



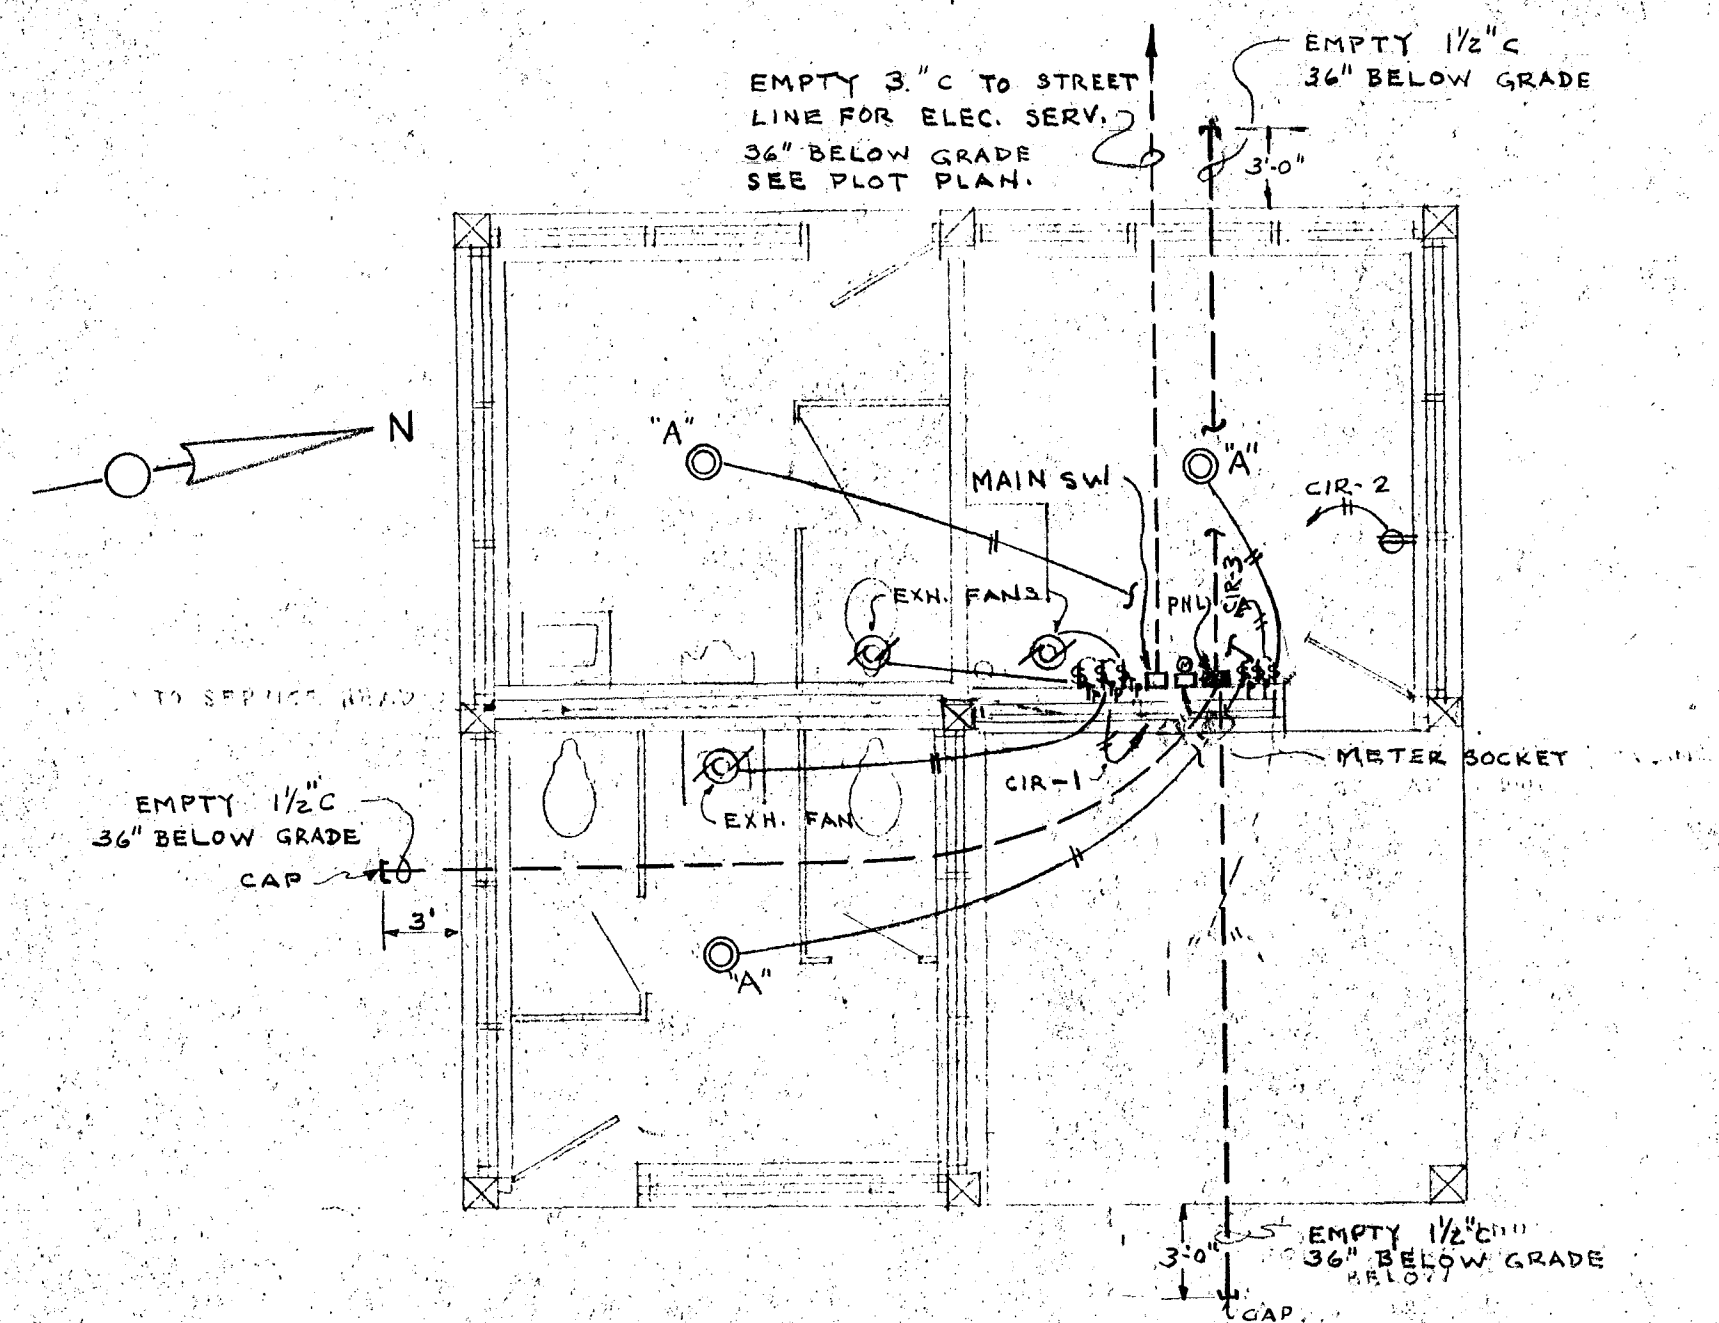

PLAN ELECTRICAL
SCALE 1/4" = 1'-0"

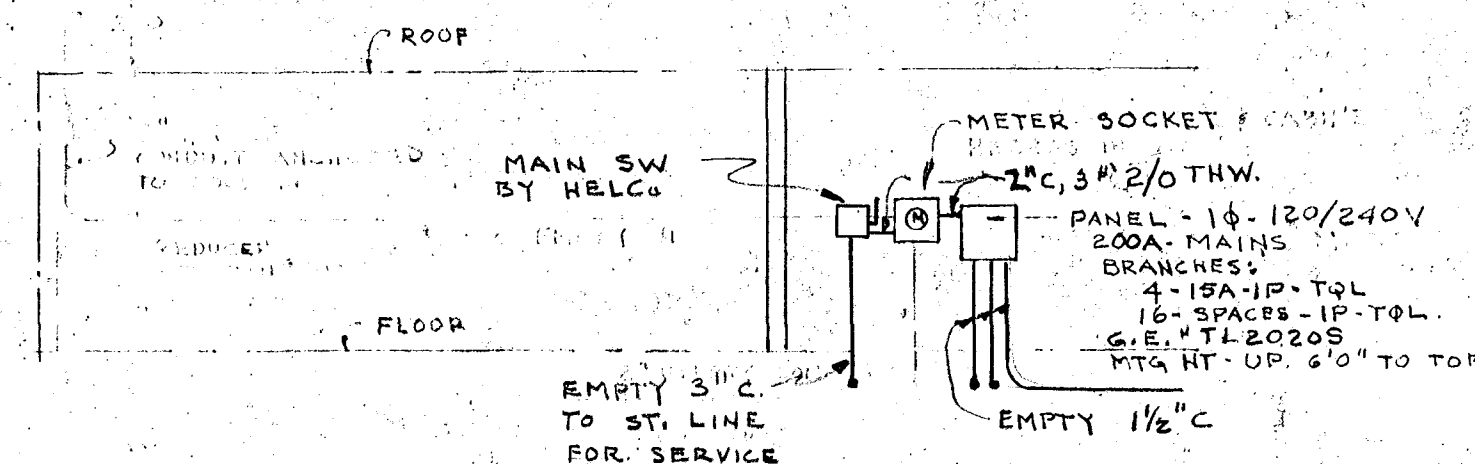



POWER RISER DIAGRAM
NO SCALE

SYMBOL LIST.


- ⊙ RECESSED LIGHTING FIXTURE
- ⊕ SINGLE POLE SW. H&H #891 UP 4'-0"
- ⊕ " " " & PILOT LT H&H #1891 & #1120 UP 4'-0"
- ⊕ MOTOR FURNISHED & INSTALL BY OTHERS; WIRED BY E.C.
- ⊕ MOTOR STARTER & PILOT LT. FURN. BY OTHER; INSTALLED & WIRED BY EC. UP 4'-6"

FIXTURE SCHEDULE

"A" - PERFECTITE CAT NO N386 CST-TP-MP-PW 150W. 1F LAMP

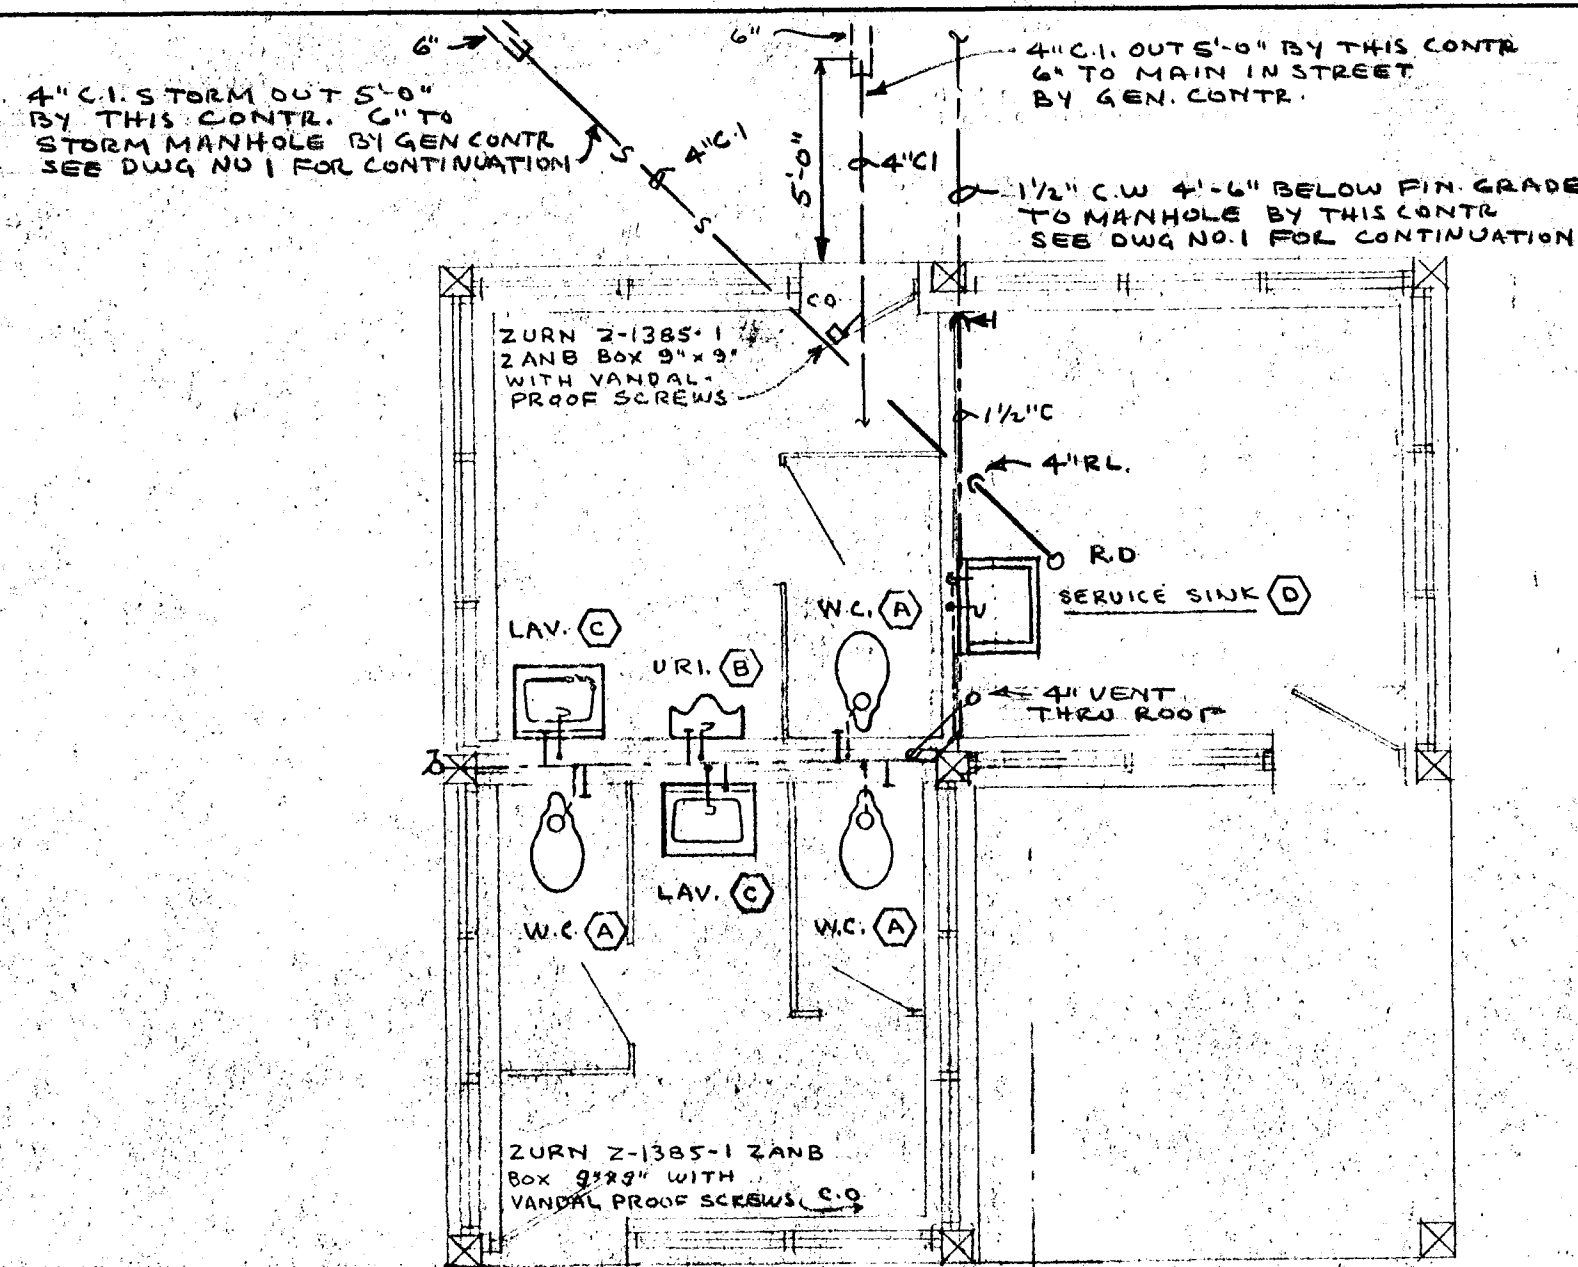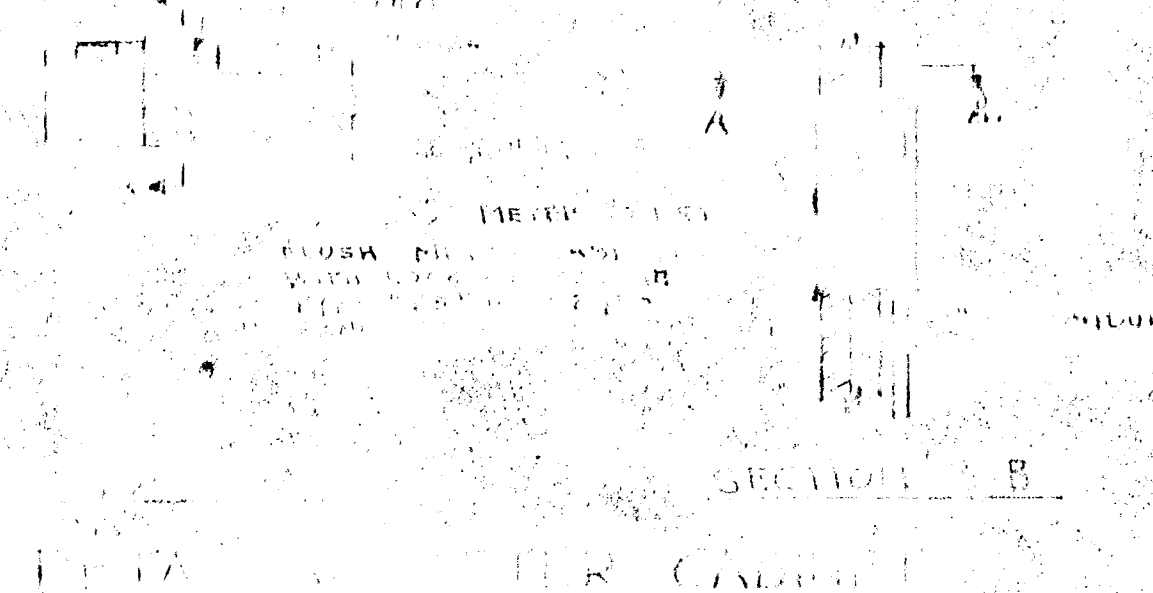


PLAN PLUMBING
SCALE 1/4" = 1'-0"

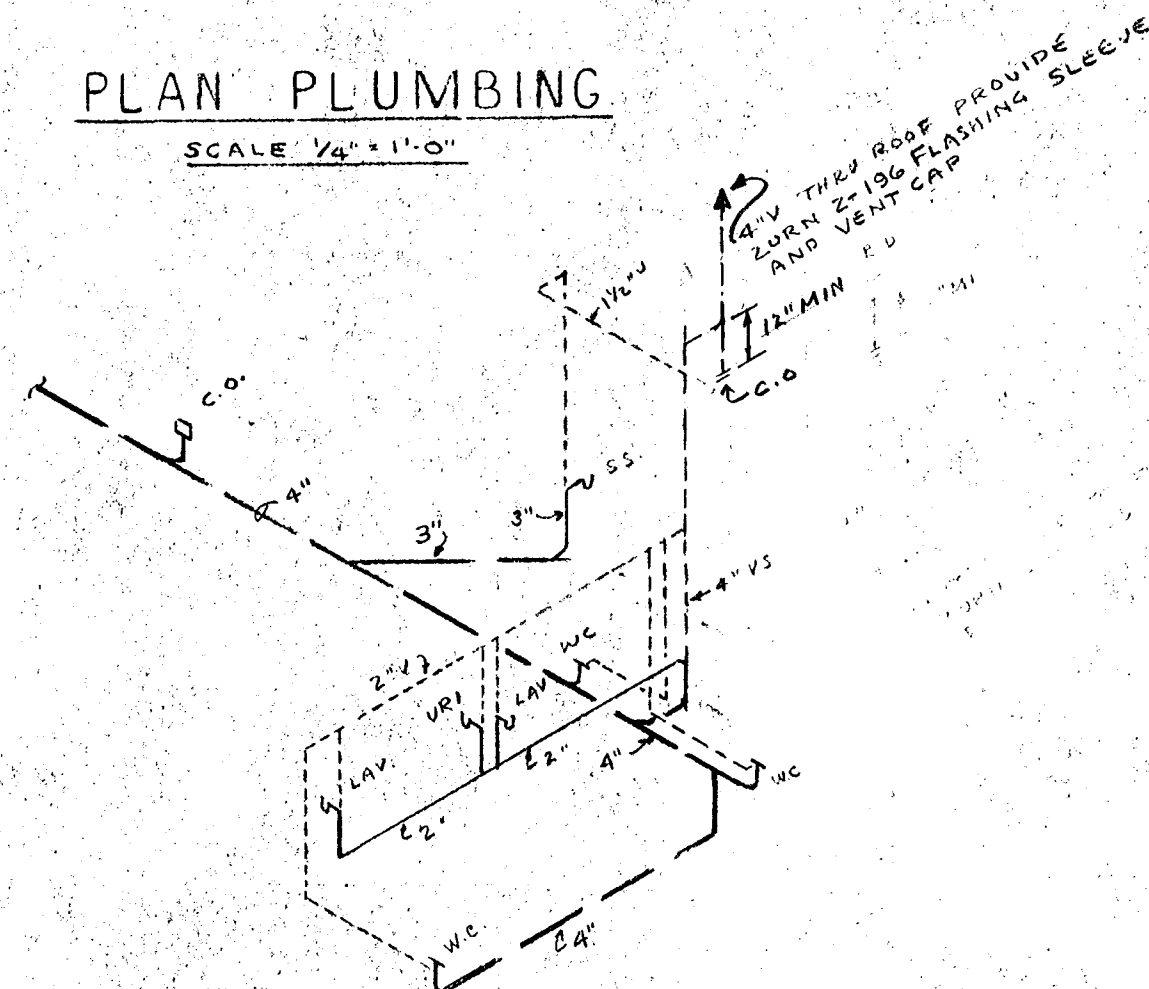


SCHEMATIC WASTE & VENT PIPING

PLUMBING FIXTURE SCHEDULE


SYM-BOL	FIXTURE	SOIL OR WASTE	VENT	C.W.	H.W.	SPECIFICATION
(A)	W.C.	4"	2"	1"	-	AM. STD. "NEW MADERA JUNIOR" F-2232 WITH NO 110-FYV SLOAN ROYAL VALVE, OLSONITE #10 BLACK OPEN FRONT SEAT.
(B)	URINAL	2"	1 1/2"	3/4"	-	AM. STD. "WASHBROOK" F-6500-1 WITH NO 186-II SLOAN ROYAL VALVE, MOUNTING HEIGHT - 15"
(C)	LAVATORY	1 1/2"	1 1/2"	1/2"	-	AM. STD. "HEXAGON" P-3869-40, 22"X19" C.I. A.R. ENAMEL WITH N-2552 DRAIN, R-2215 FAUCET, R-2607 SUPPLY STOP, R-7013-44 1 1/4"X1 1/2" P TRAP, MOUNTING HEIGHT - 27"
(D)	SERVICE SINK	3"	1 1/2"	1/2"	-	AM. STD. "ARGON" P-7706 22"X18" C.I. A.R. ENAMEL WITH STAINLESS STEEL RIM GUARD, P-7798 TRAP STD. R-5084-31 FAUCET.
	HOSE BIBB	-	-	1/2"	-	ANALCONDA 1463, ANGLE TYPE, LOOSE SET KEY, HOSE THREAD
	ROOF DRAIN	4"	-	-	-	ZURN Z-1700 RC WITH CLAMP MODIFIED FOR 5/8" PLYWOOD ROOF DECK.

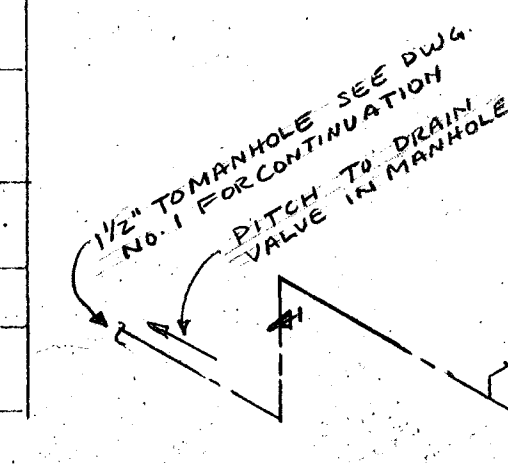

SCHEMATIC WATER PIPING
IN MANHOLE
NO SCALE

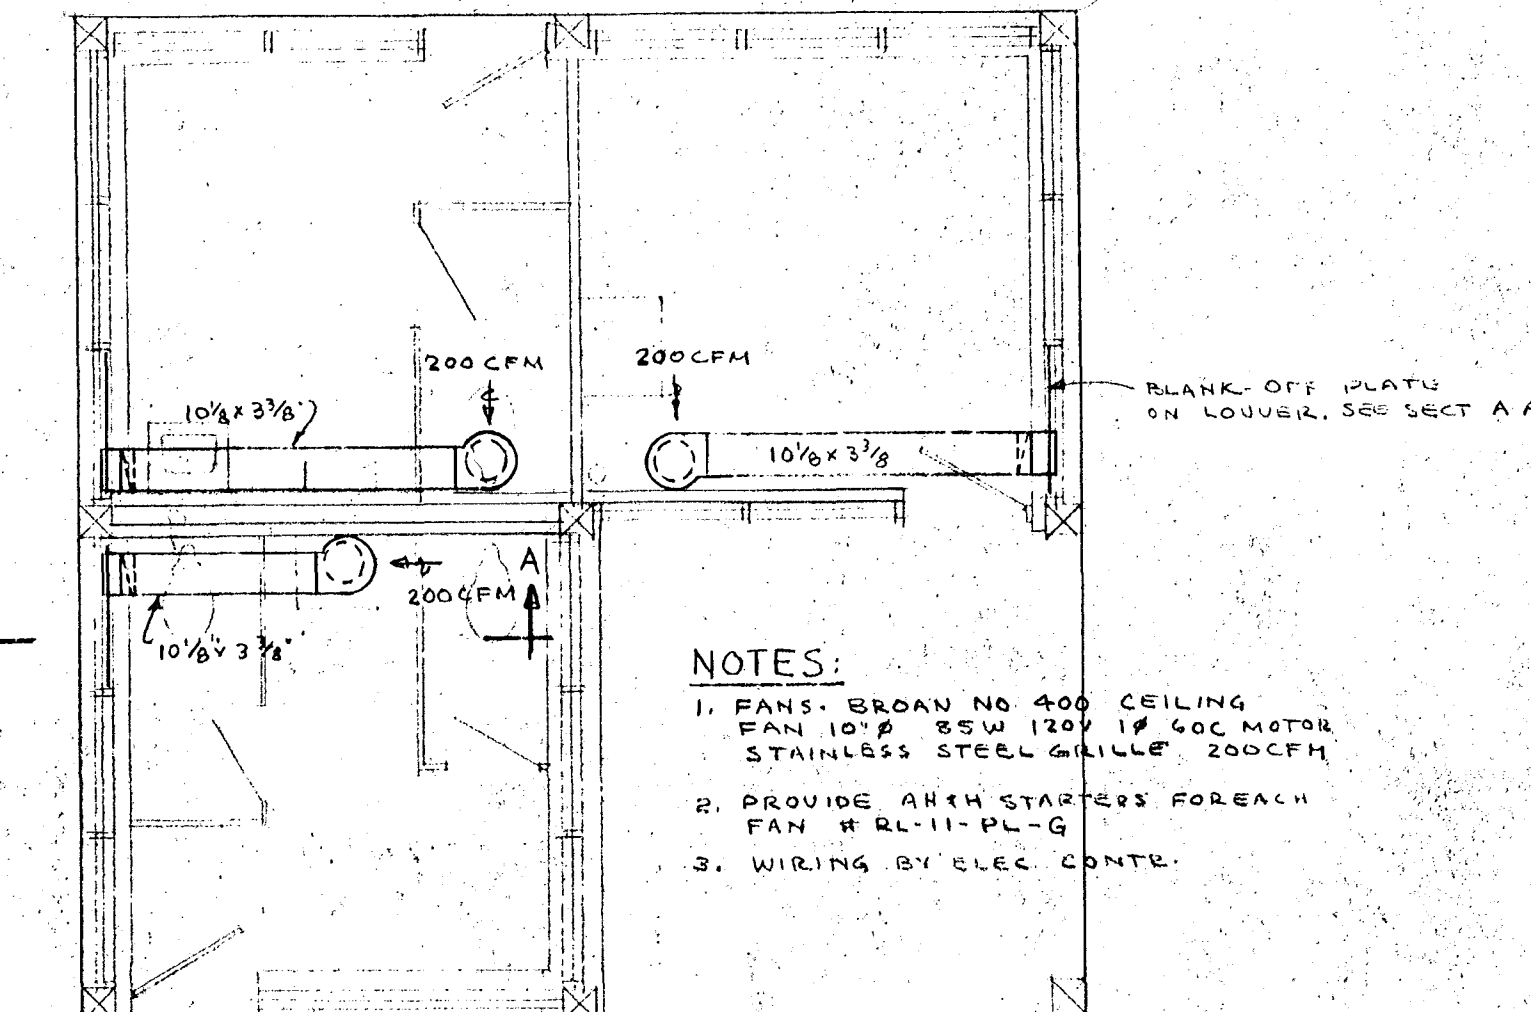

PLAN VENTILATING
SCALE 1/4" = 1'-0"

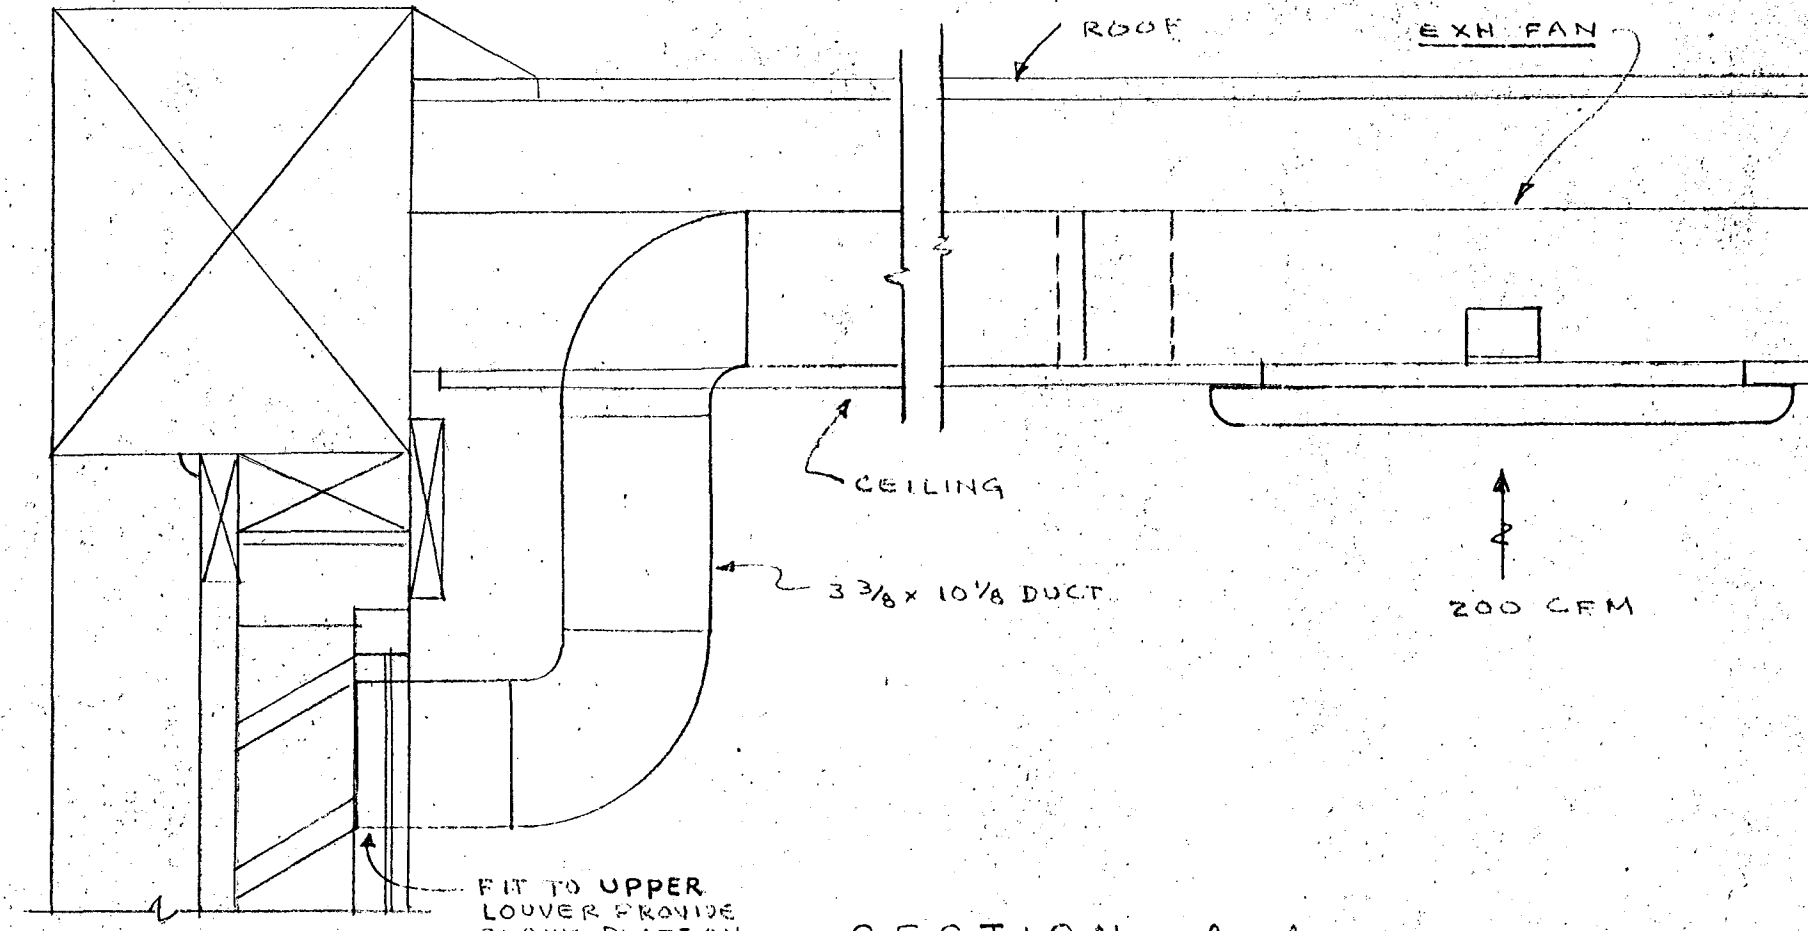

SECTION A-A
SCALE 3/4" = 1'-0"

CITY OF HARTFORD, CONNECTICUT DEPARTMENT OF ENGINEERING		
TYPICAL FIELD HOUSE MECHANICAL & ELECTRICAL ST. BENEDICT'S PLAYGROUND HARTFORD, CONN.		DWG. NO. 5
SUBMITTED R.B. - P.D.	RECOMMENDED CITY ARCHITECT	APPROVED CITY ENGINEER
DESIGN R.B. - P.D.	DRAWN R.B. - P.D.	DAYBOOK NO. 010018 E
DATE MARCH 13, 1968		