



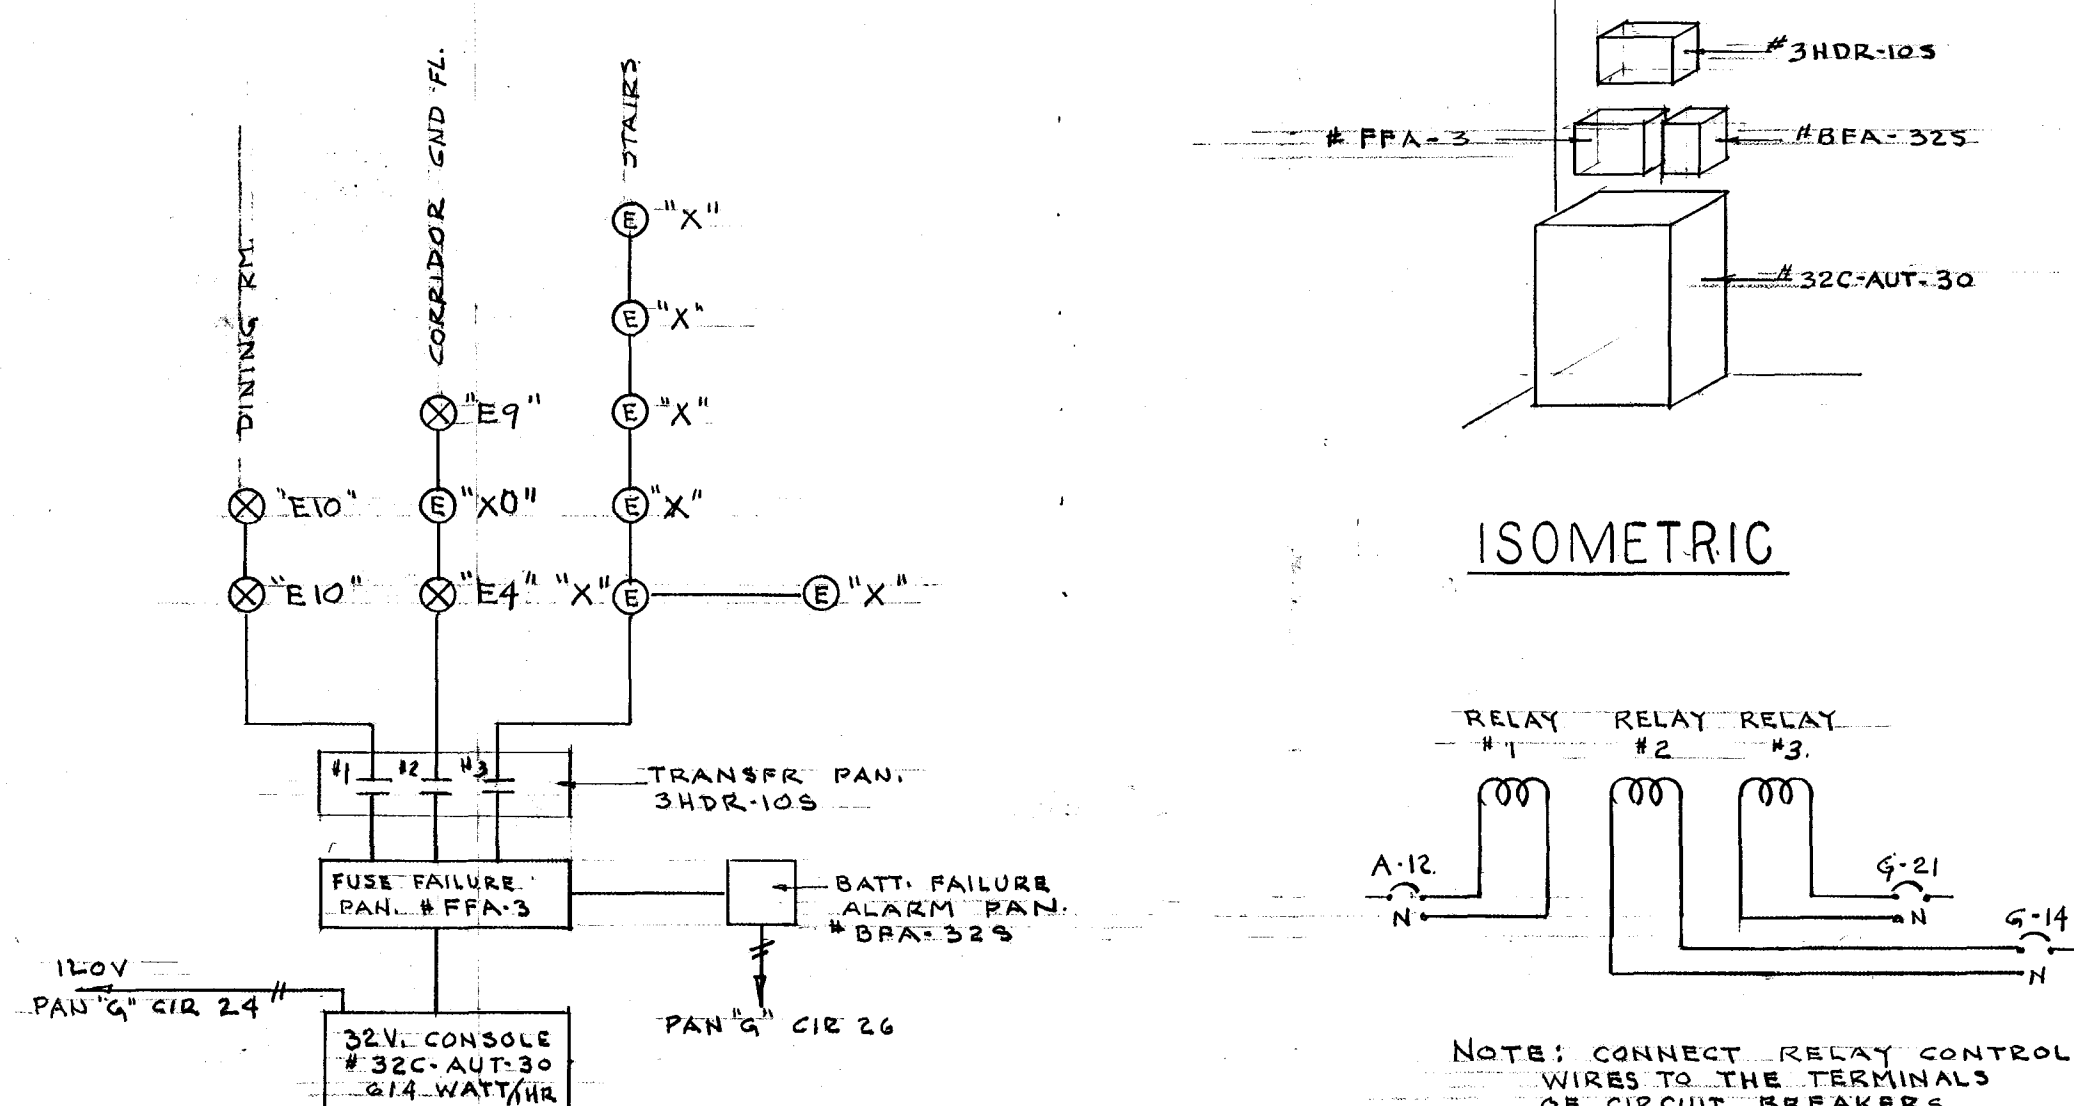


EMERG. LTG. SCHEMATIC

WIRING DIAGRAM OF A.C. CONTROL FOR RELAYS IN TRANSFER PANEL

EMERGENCY LIGHTING FOR DINING AREA 121 GND. FL. NO SCALE.

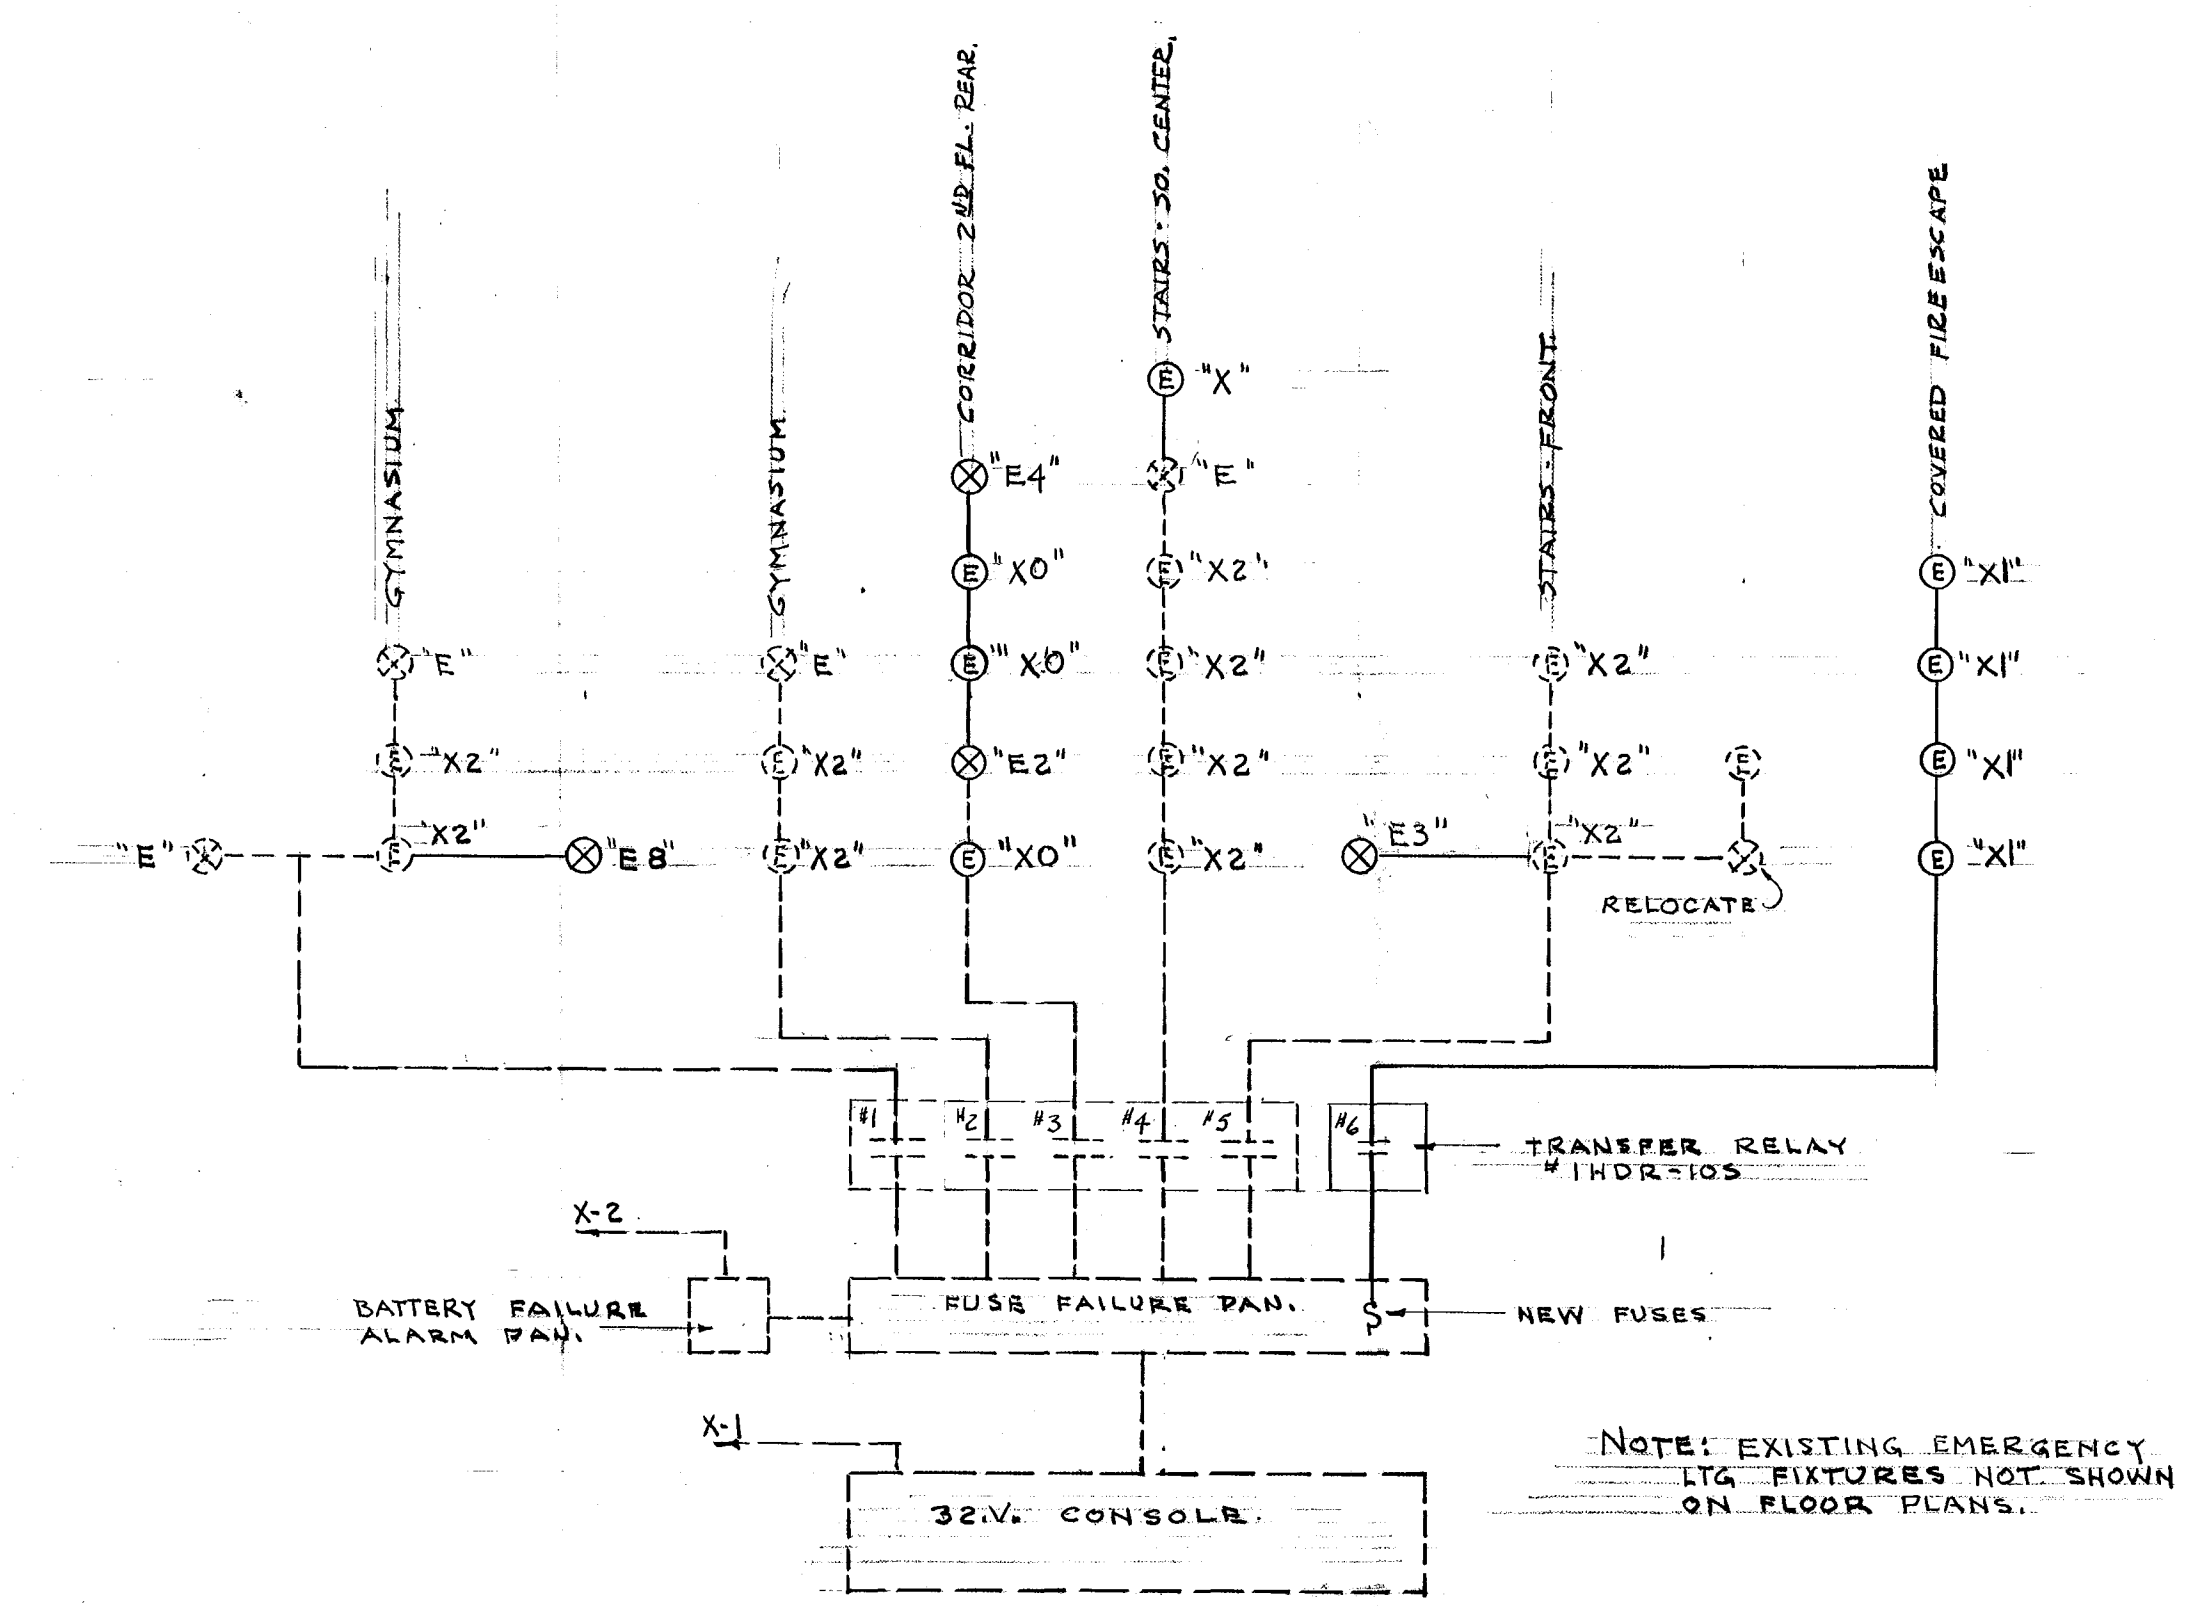


EMERGENCY LIGHTING SCHEMATIC

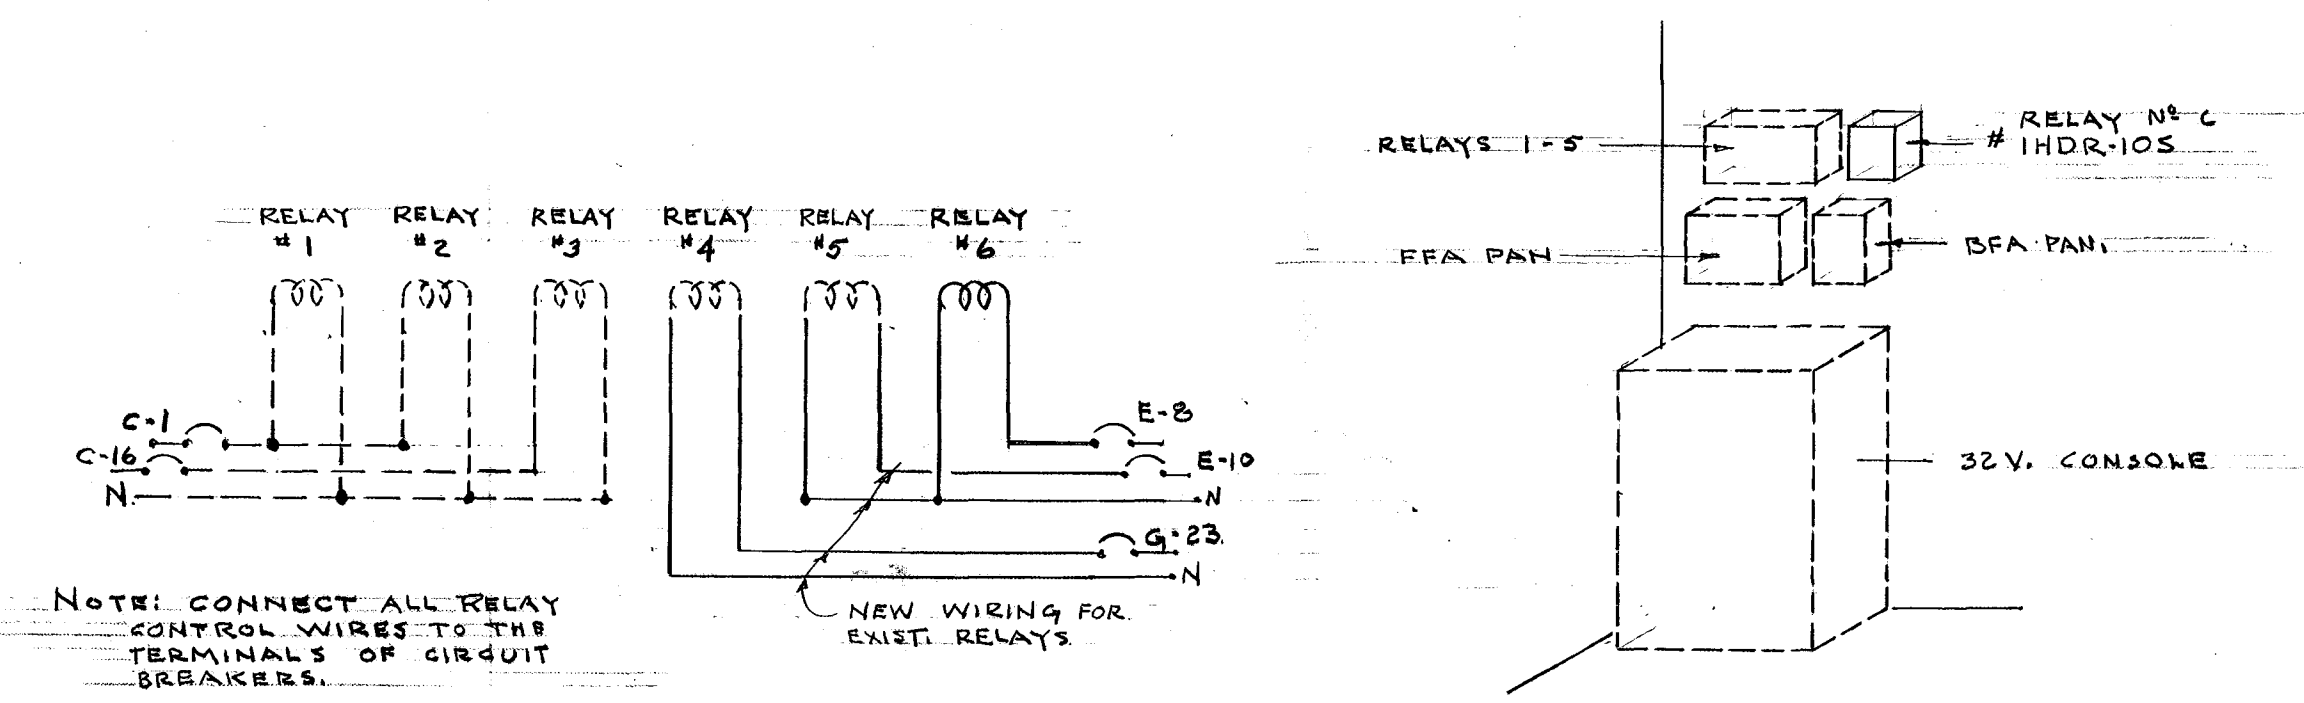


WIRING DIAGRAM OF A.C. CONTROL FOR RELAYS IN TRANSFER PANELS

ISOMETRIC


EMERGENCY LIGHTING FOR GYMNASIUM & AREA NO SCALE

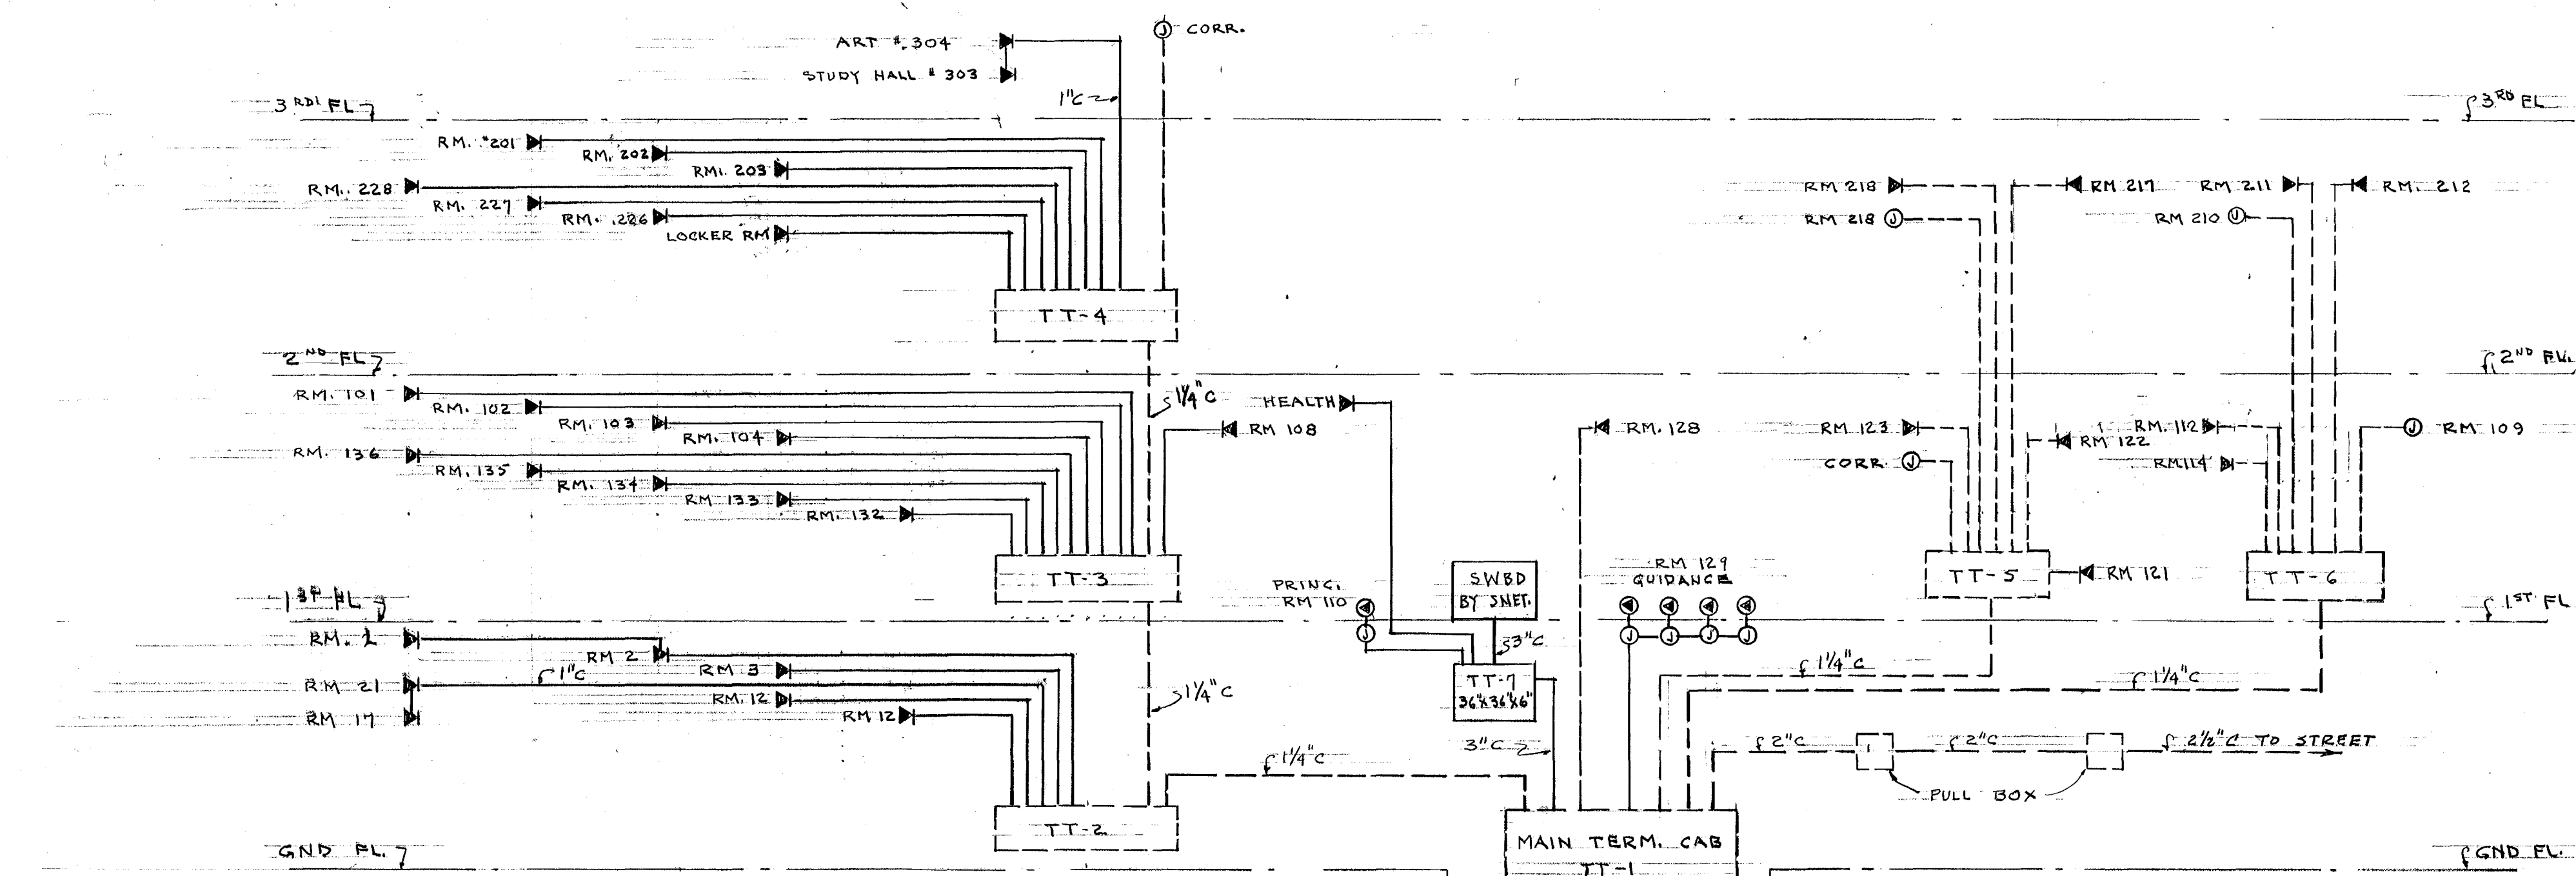

TELEPHONE RISER DIAGRAM

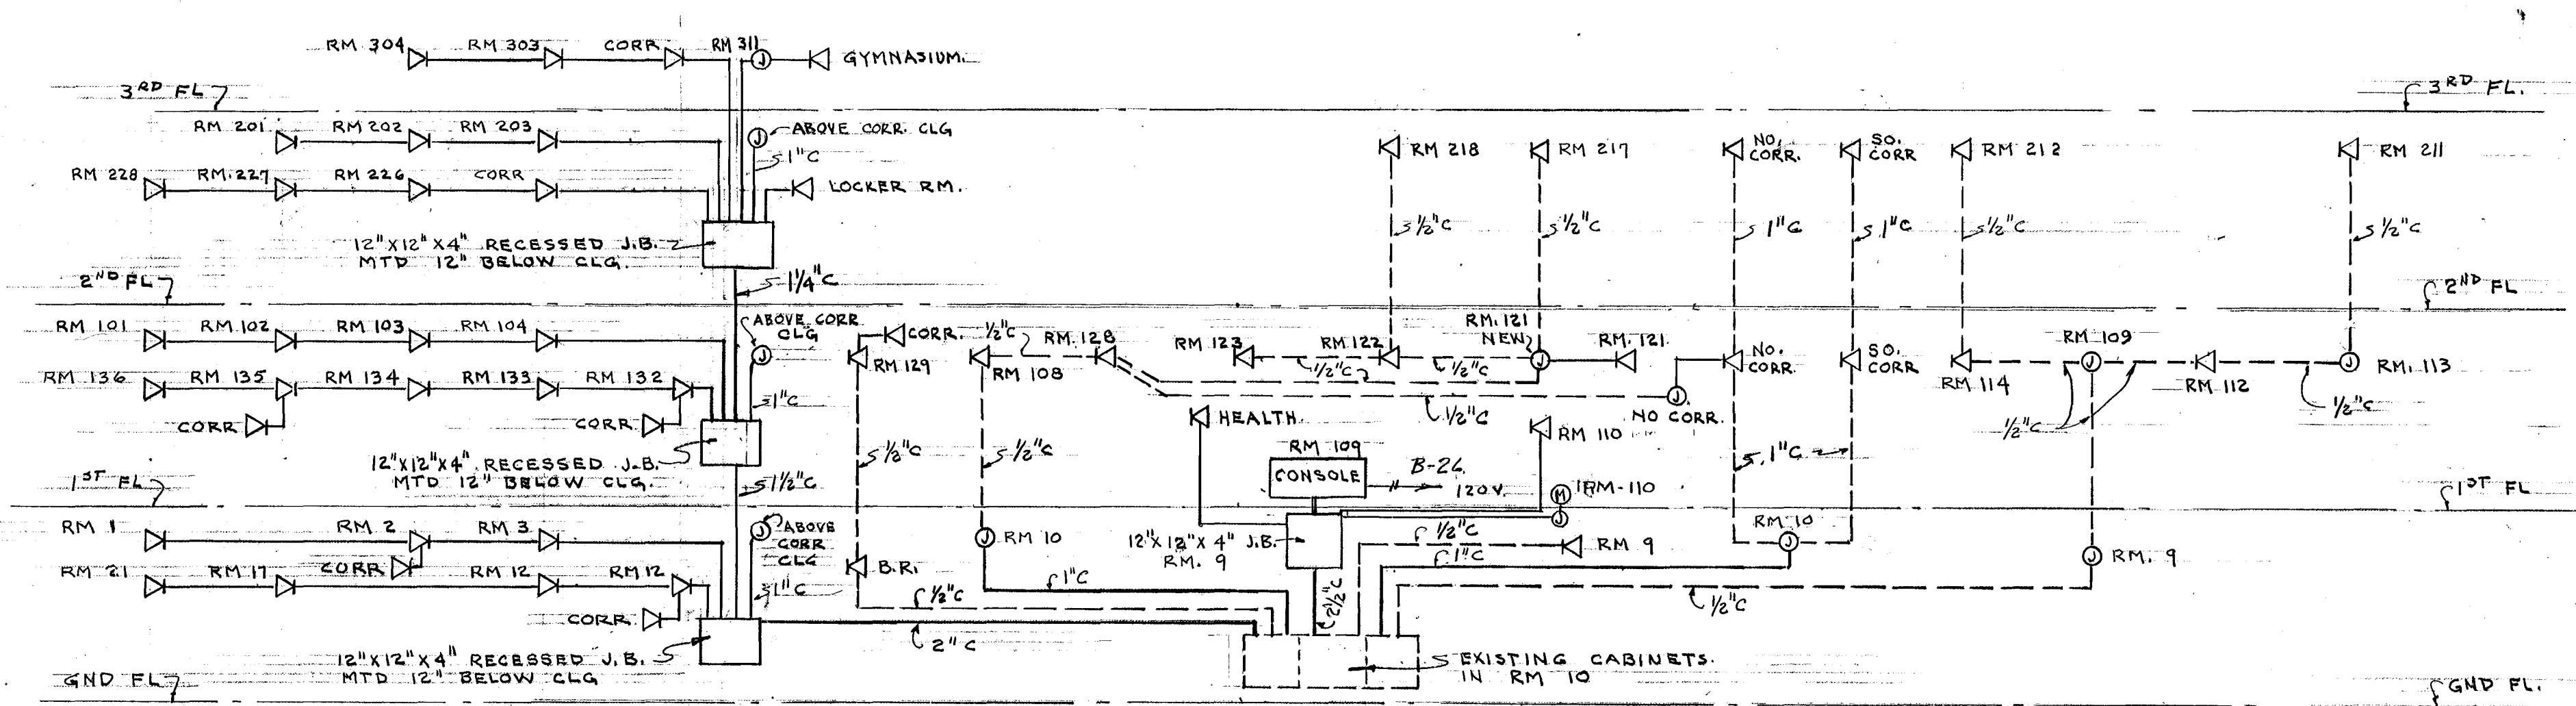

SOUND RISER DIAGRAM

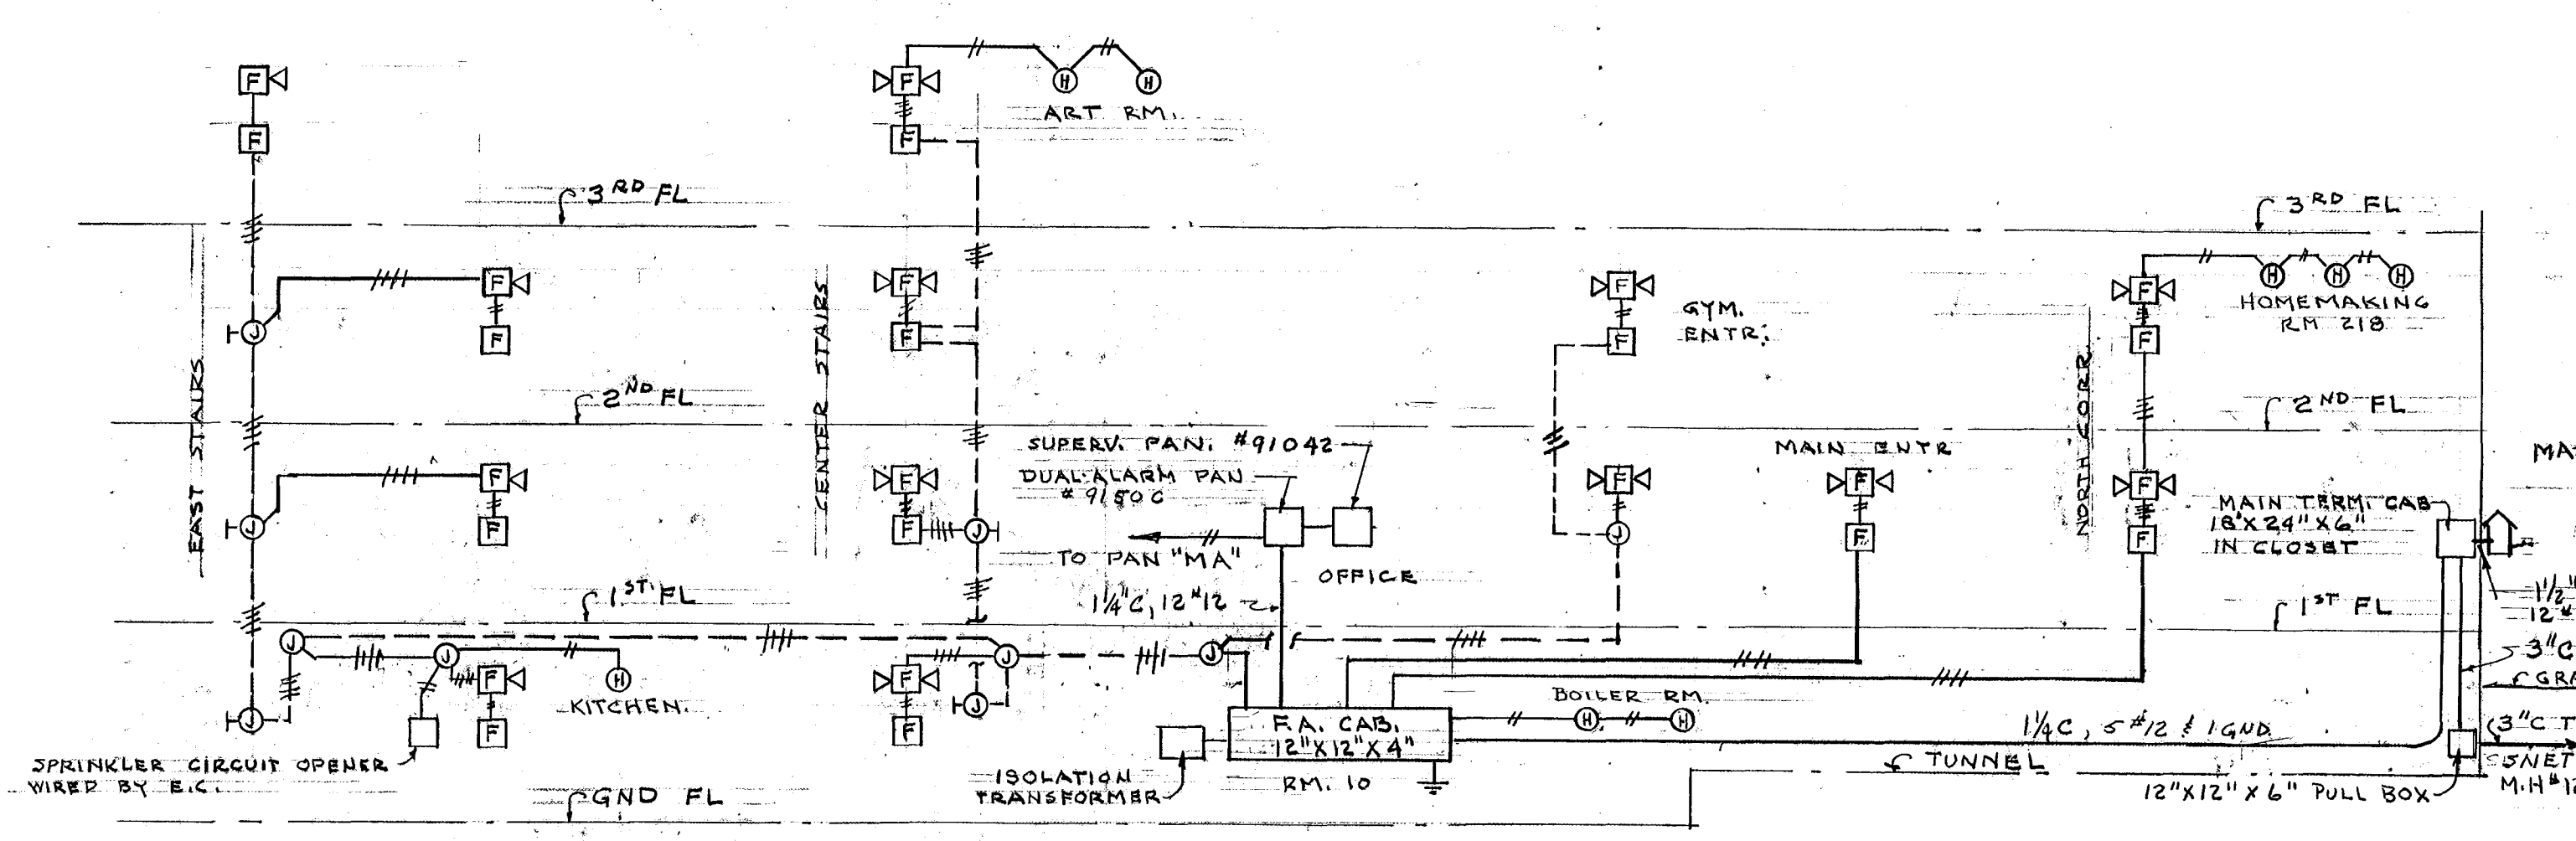

FIRE ALARM RISER DIAGRAM

CITY OF HARTFORD, CONNECTICUT DEPARTMENT OF ENGINEERING		DWG No.
WASHINGTON STREET HIGH SCHOOL ALTERNATIONS 110 WASHINGTON ST. HARTFORD, CONN.		126
SUBMITTED R.G. Bannan	RECEIVED Daniel J. Tassell	APPROVED R.G. Bannan
DESIGN R.G.B.	DRAWN R.G.B.	DAYBOOK NO. 03876-AA
TRACED	CHECK	DATE APR. 7-1965

VERIFY EXISTING
CONDITIONS AND
DIMENSIONS AT
BUILDING