



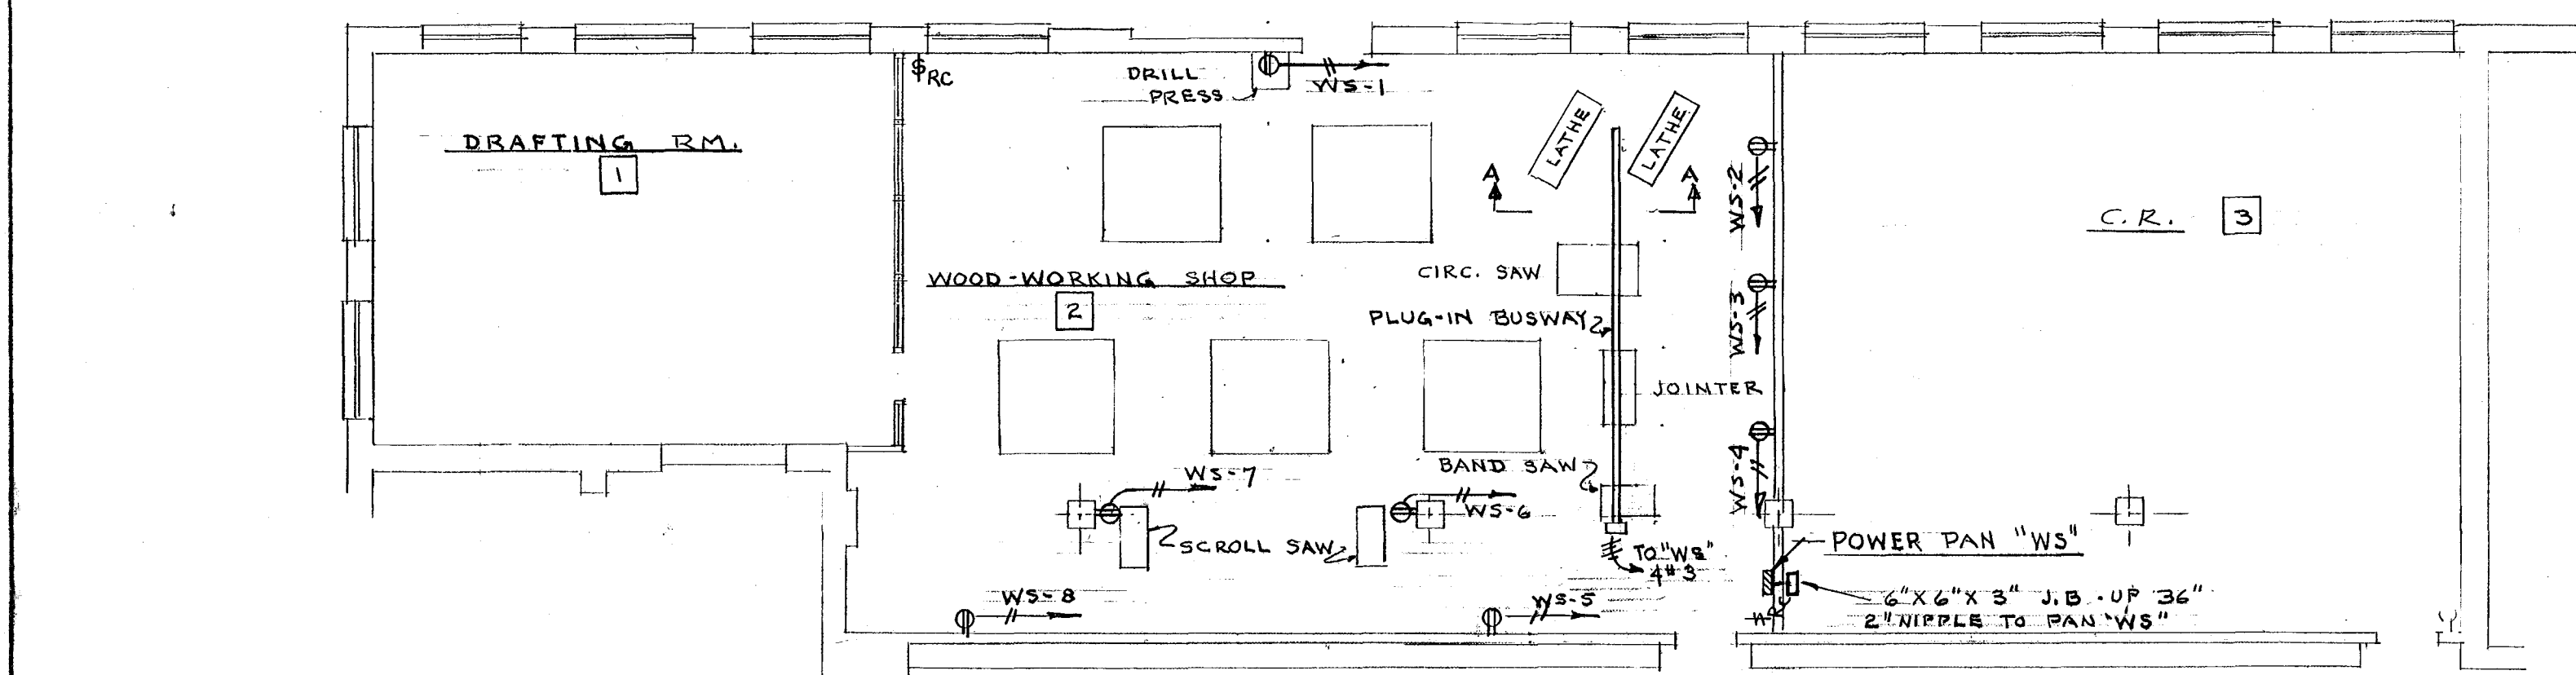


POWER LAYOUT OF SHOP AREA

SCALE 1/8" = 1'-0"

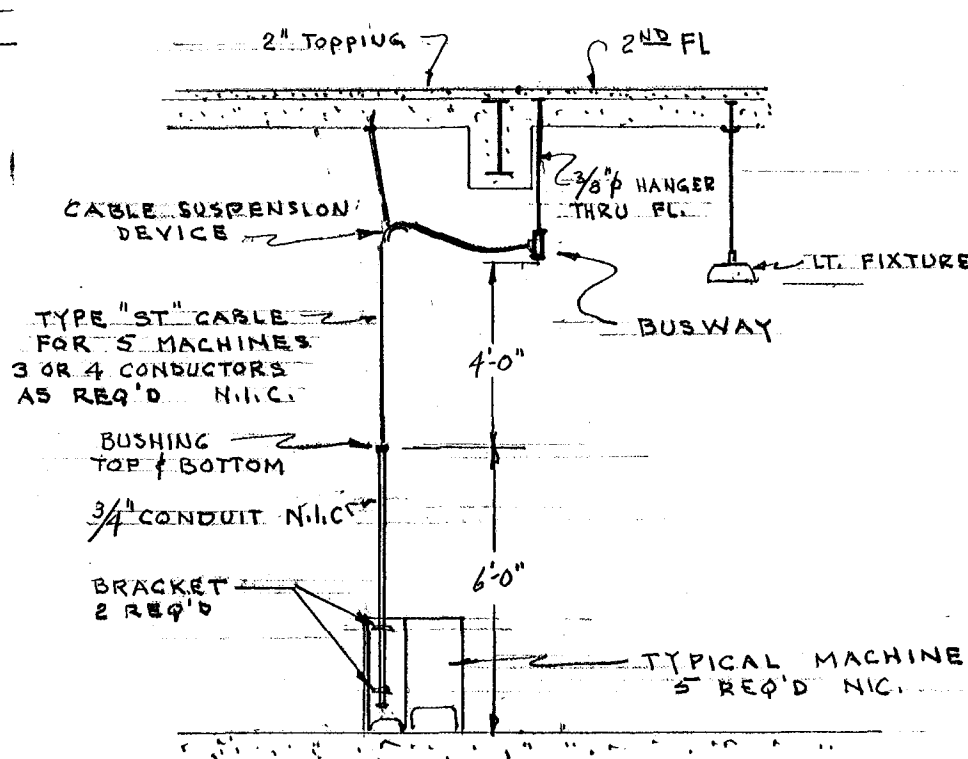


SECTION A-A

1/4" = 1'-0"

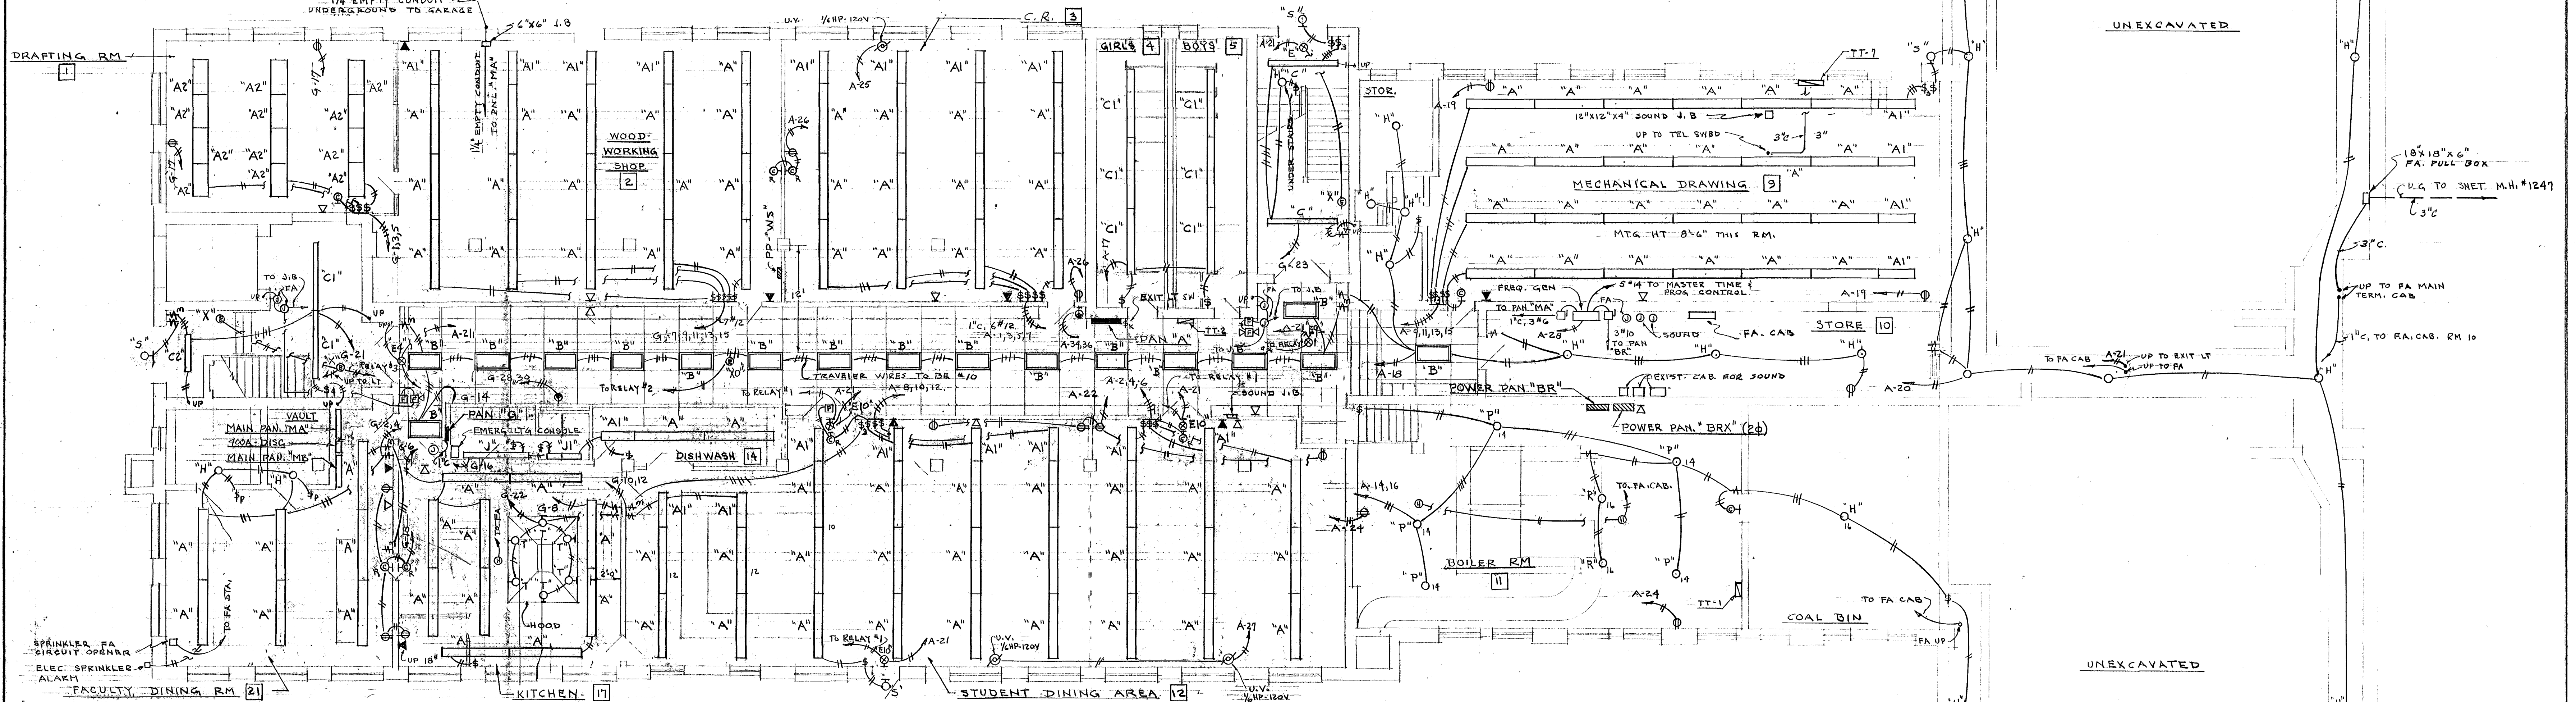


GROUND FLOOR PLAN

SCALE 1/8" = 1'-0"

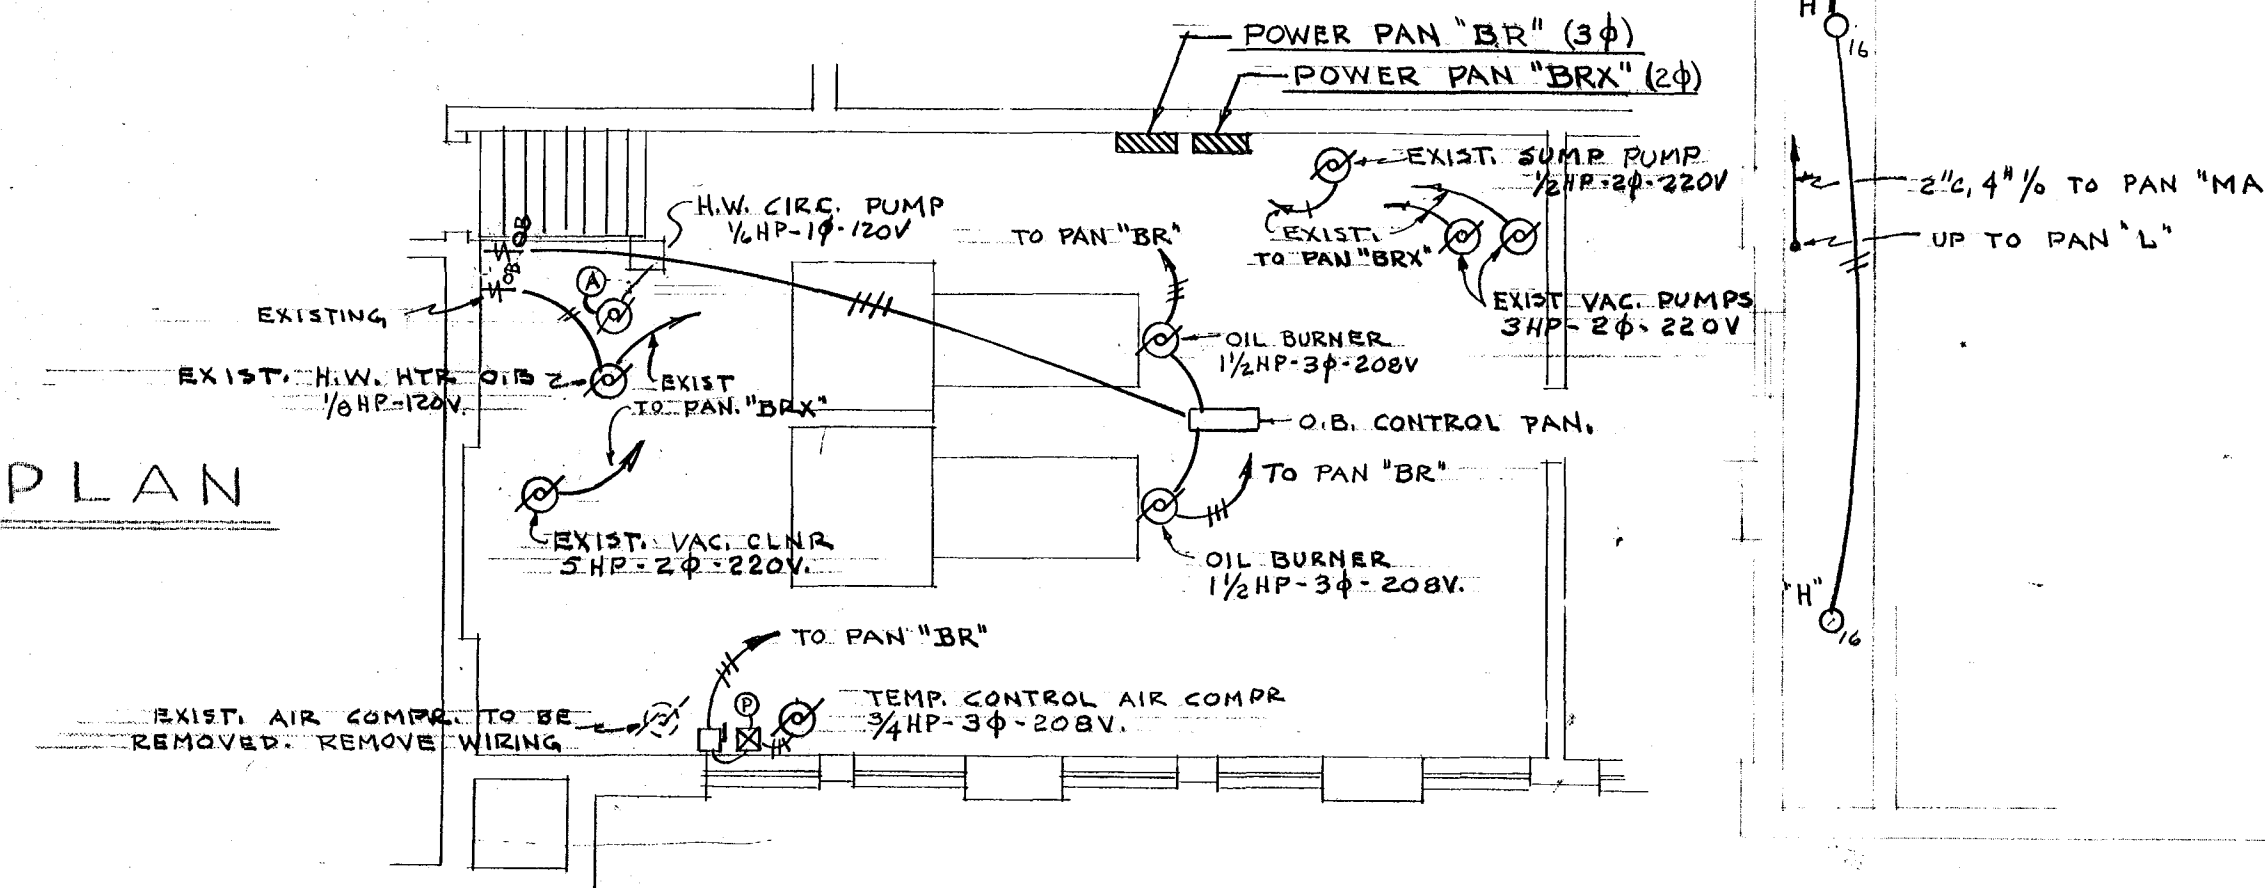

POWER PLAN - BOILER RM

1/8" = 1'-0"

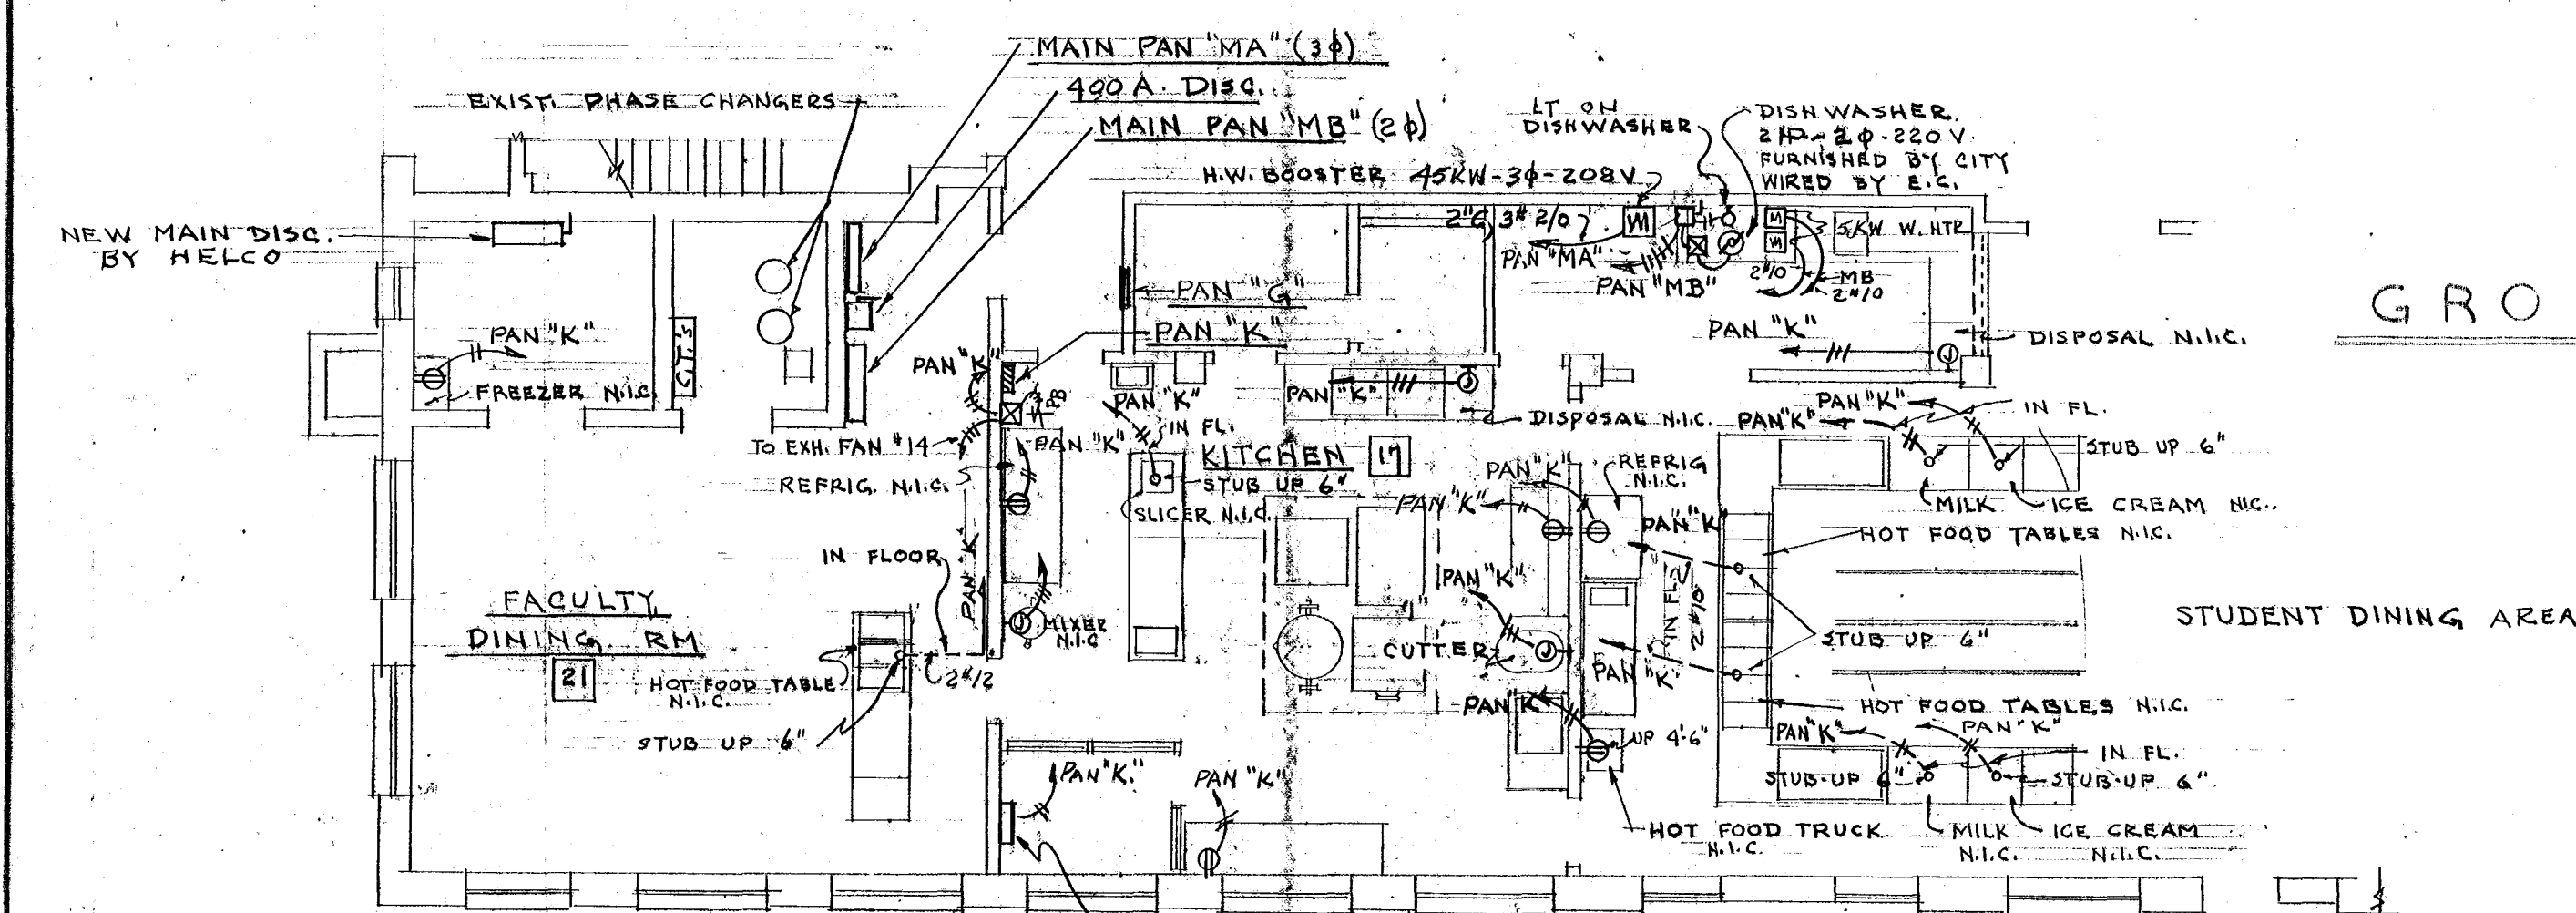

POWER LAYOUT OF KITCHEN AREA

SCALE 1/8" = 1'-0"

NOTES - KITCHEN AREA

1. ALL J.B.'S UP 1'-6"
2. FOR ALL STUB-UPS AND JUNCTION BOXES LEAVE 36" SLACK WIRE FOR FUTURE CONNECTION
3. EXACT LOCATION OF ALL STUB-UPS, J.B.'S, & OUTLET WILL BE DETERMINED IN THE FIELD BY THE ENGINEER
4. CUT-UP PATCH FLOOR FOR CONDUITS

VERIFY EXISTING
CONDITIONS AND
DIMENSIONS AT
BUILDING

CITY OF HARTFORD, CONNECTICUT DEPARTMENT OF ENGINEERING		DWG. NO.
WASHINGTON STREET HIGH SCHOOL ALTERATIONS 110 WASHINGTON ST. HARTFORD, CONN.		121
SUBMITTED R. G. B.	RECOMMENDED D. G. B.	APPROVED D. G. B.
DESIGN R. G. B.	DRAWN R. G. B.	DAYBOOK NO. 09876-V
TRACED	CHECK	DATE APR. 7 - 1965