



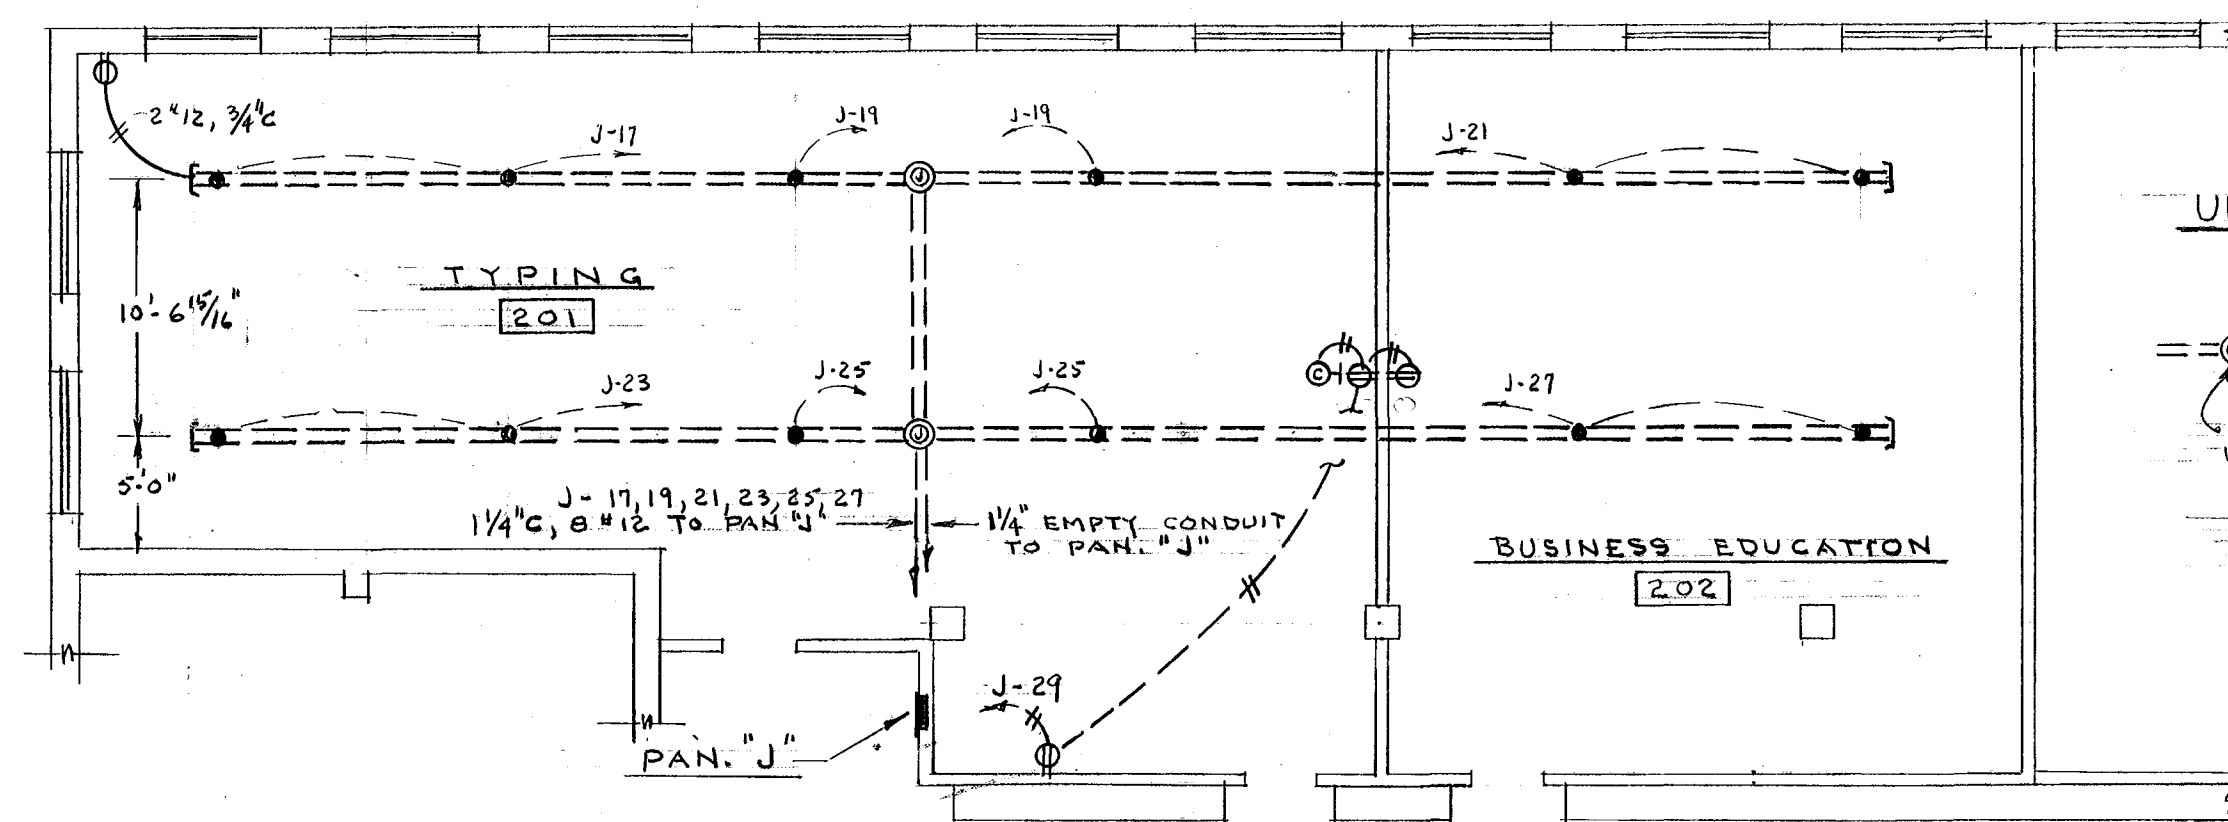


UNDERFLOOR DUCT PLAN
SCALE 1/8" = 1'-0"


UNDERFLOOR DUCT LEGEND
#2 WALKER DUCT
END CAP OR ADAPTER
REC'DT - WALKER #313ALDPS-G
JUNCTION BOX EXACT LOCATION BY ENGINEER
WALKER #125
NOTE: ALL UNDERFLOOR DUCTS TO HAVE
2" IPS INSERTS 2'-0" O.C.

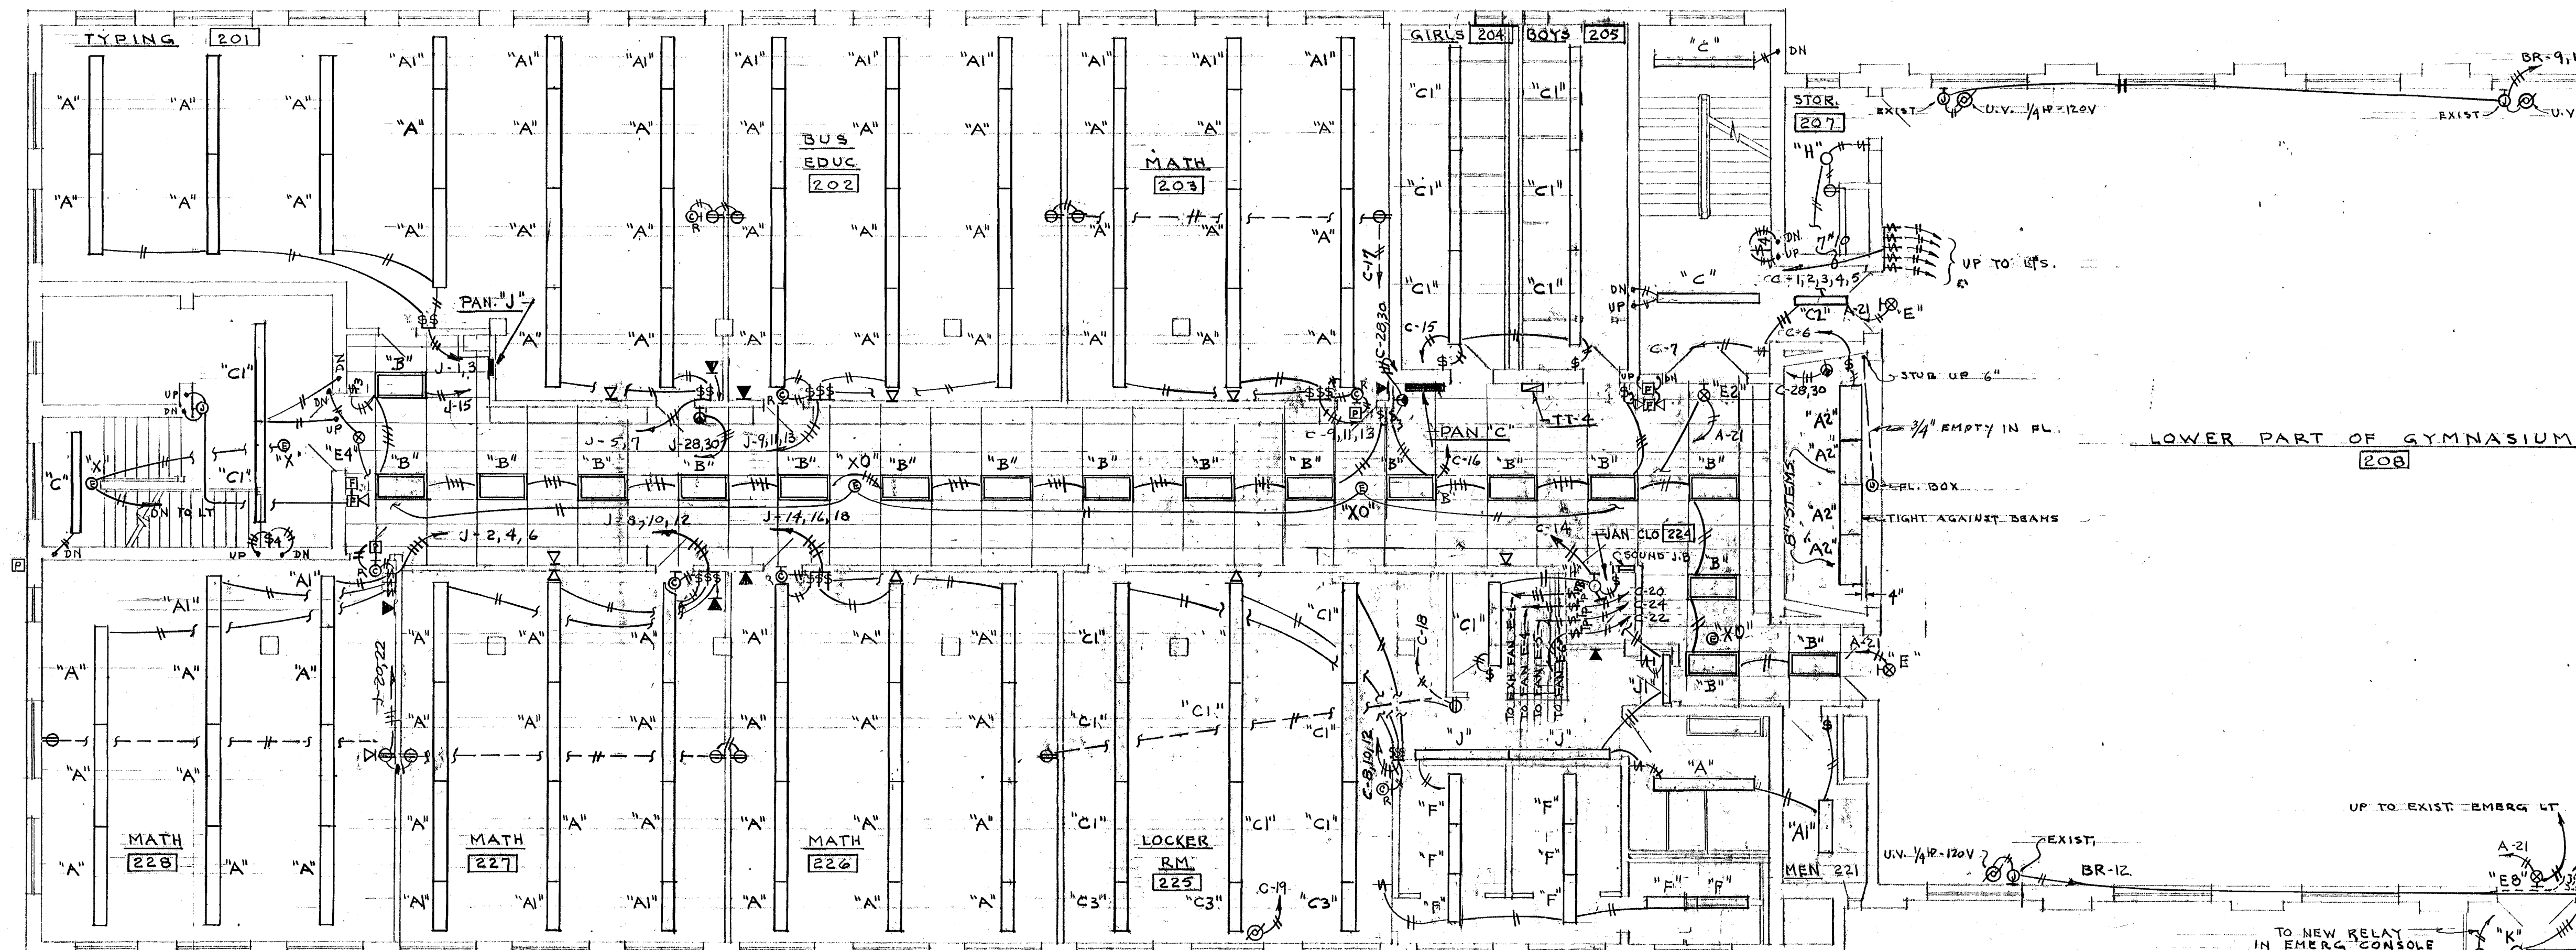

SECOND FLOOR PLAN
SCALE 1/8" = 1'-0"

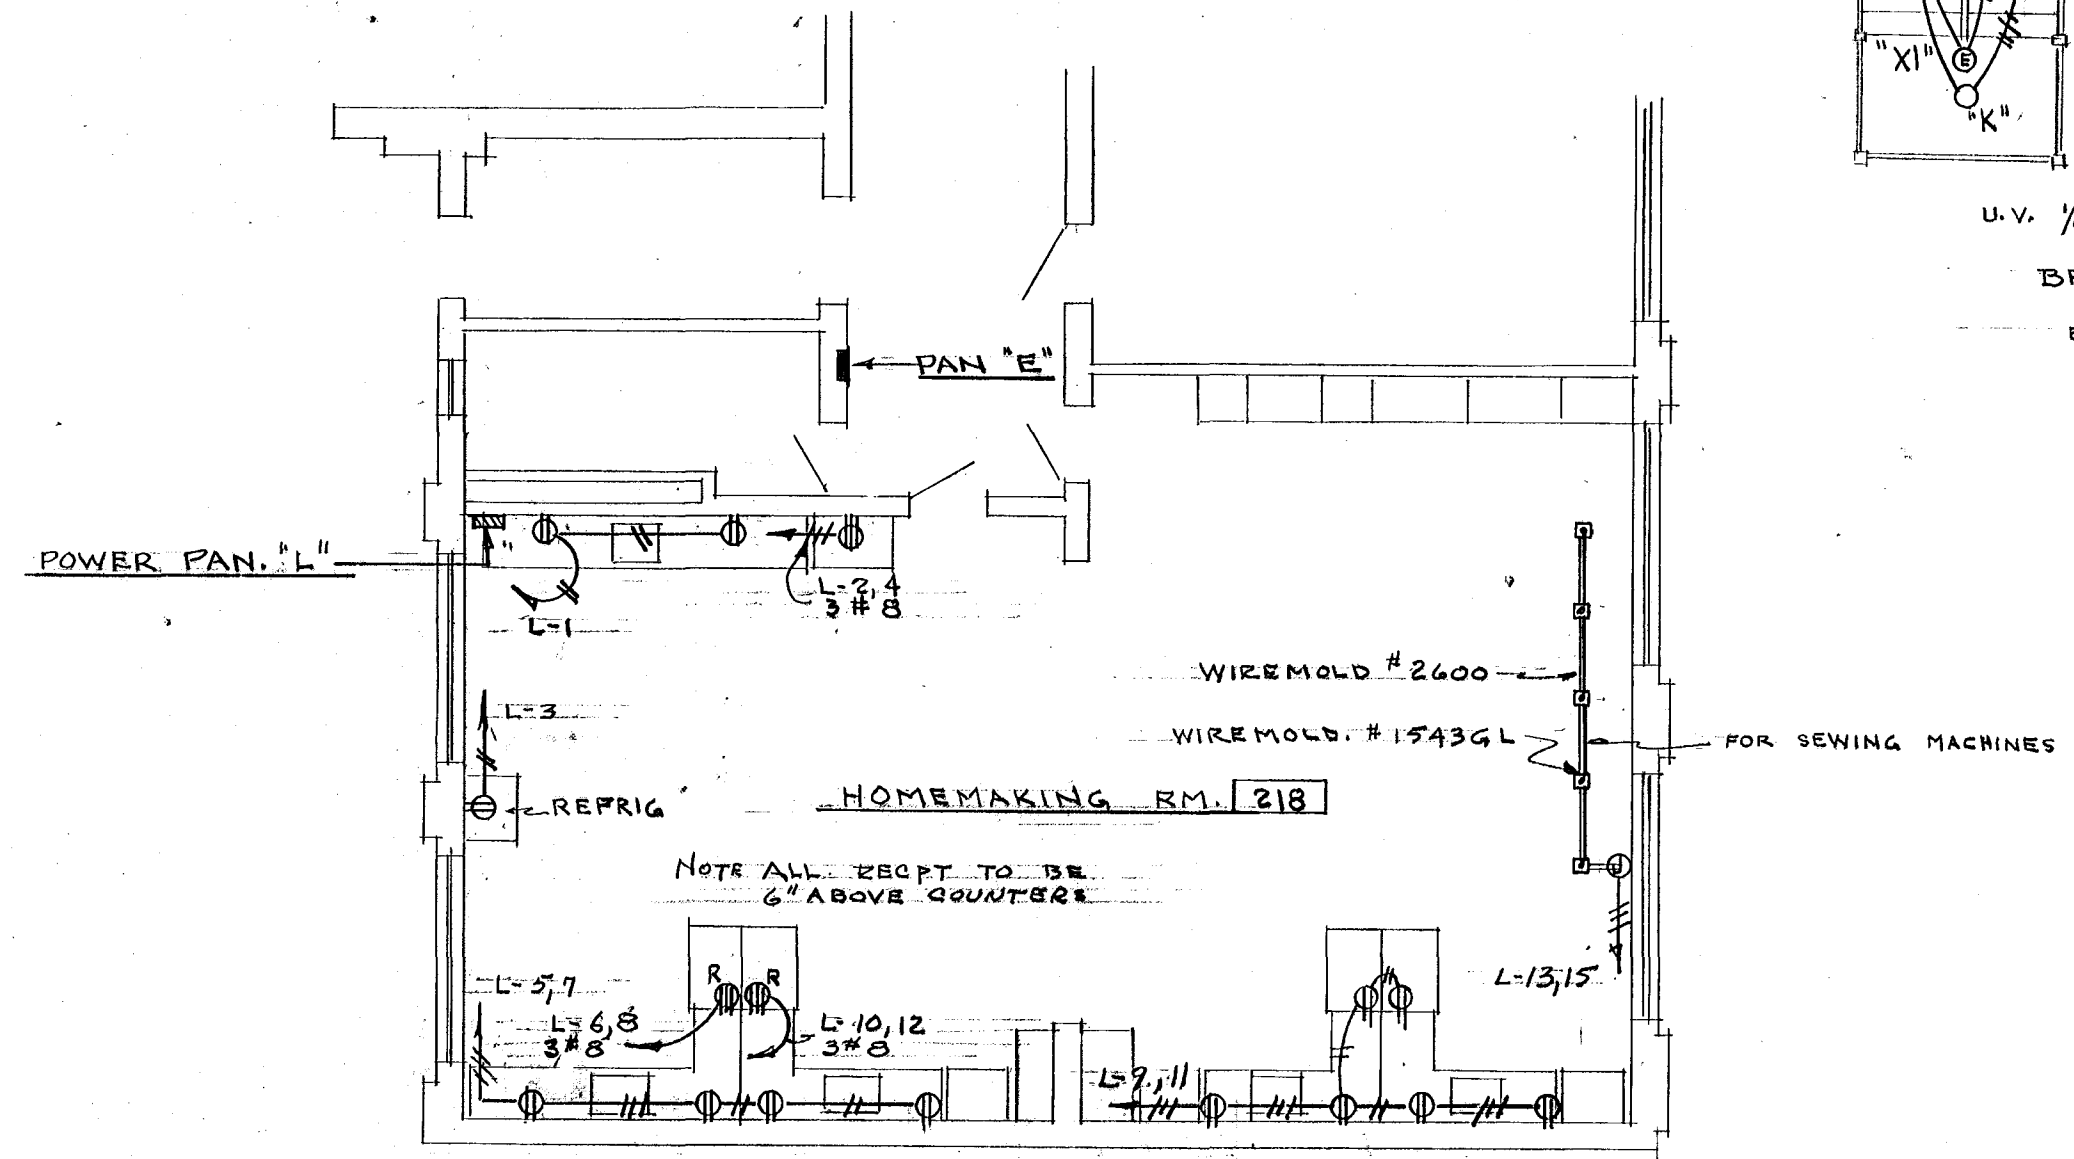

POWER PLAN - HOMEMAKING
SCALE 1/8" = 1'-0"

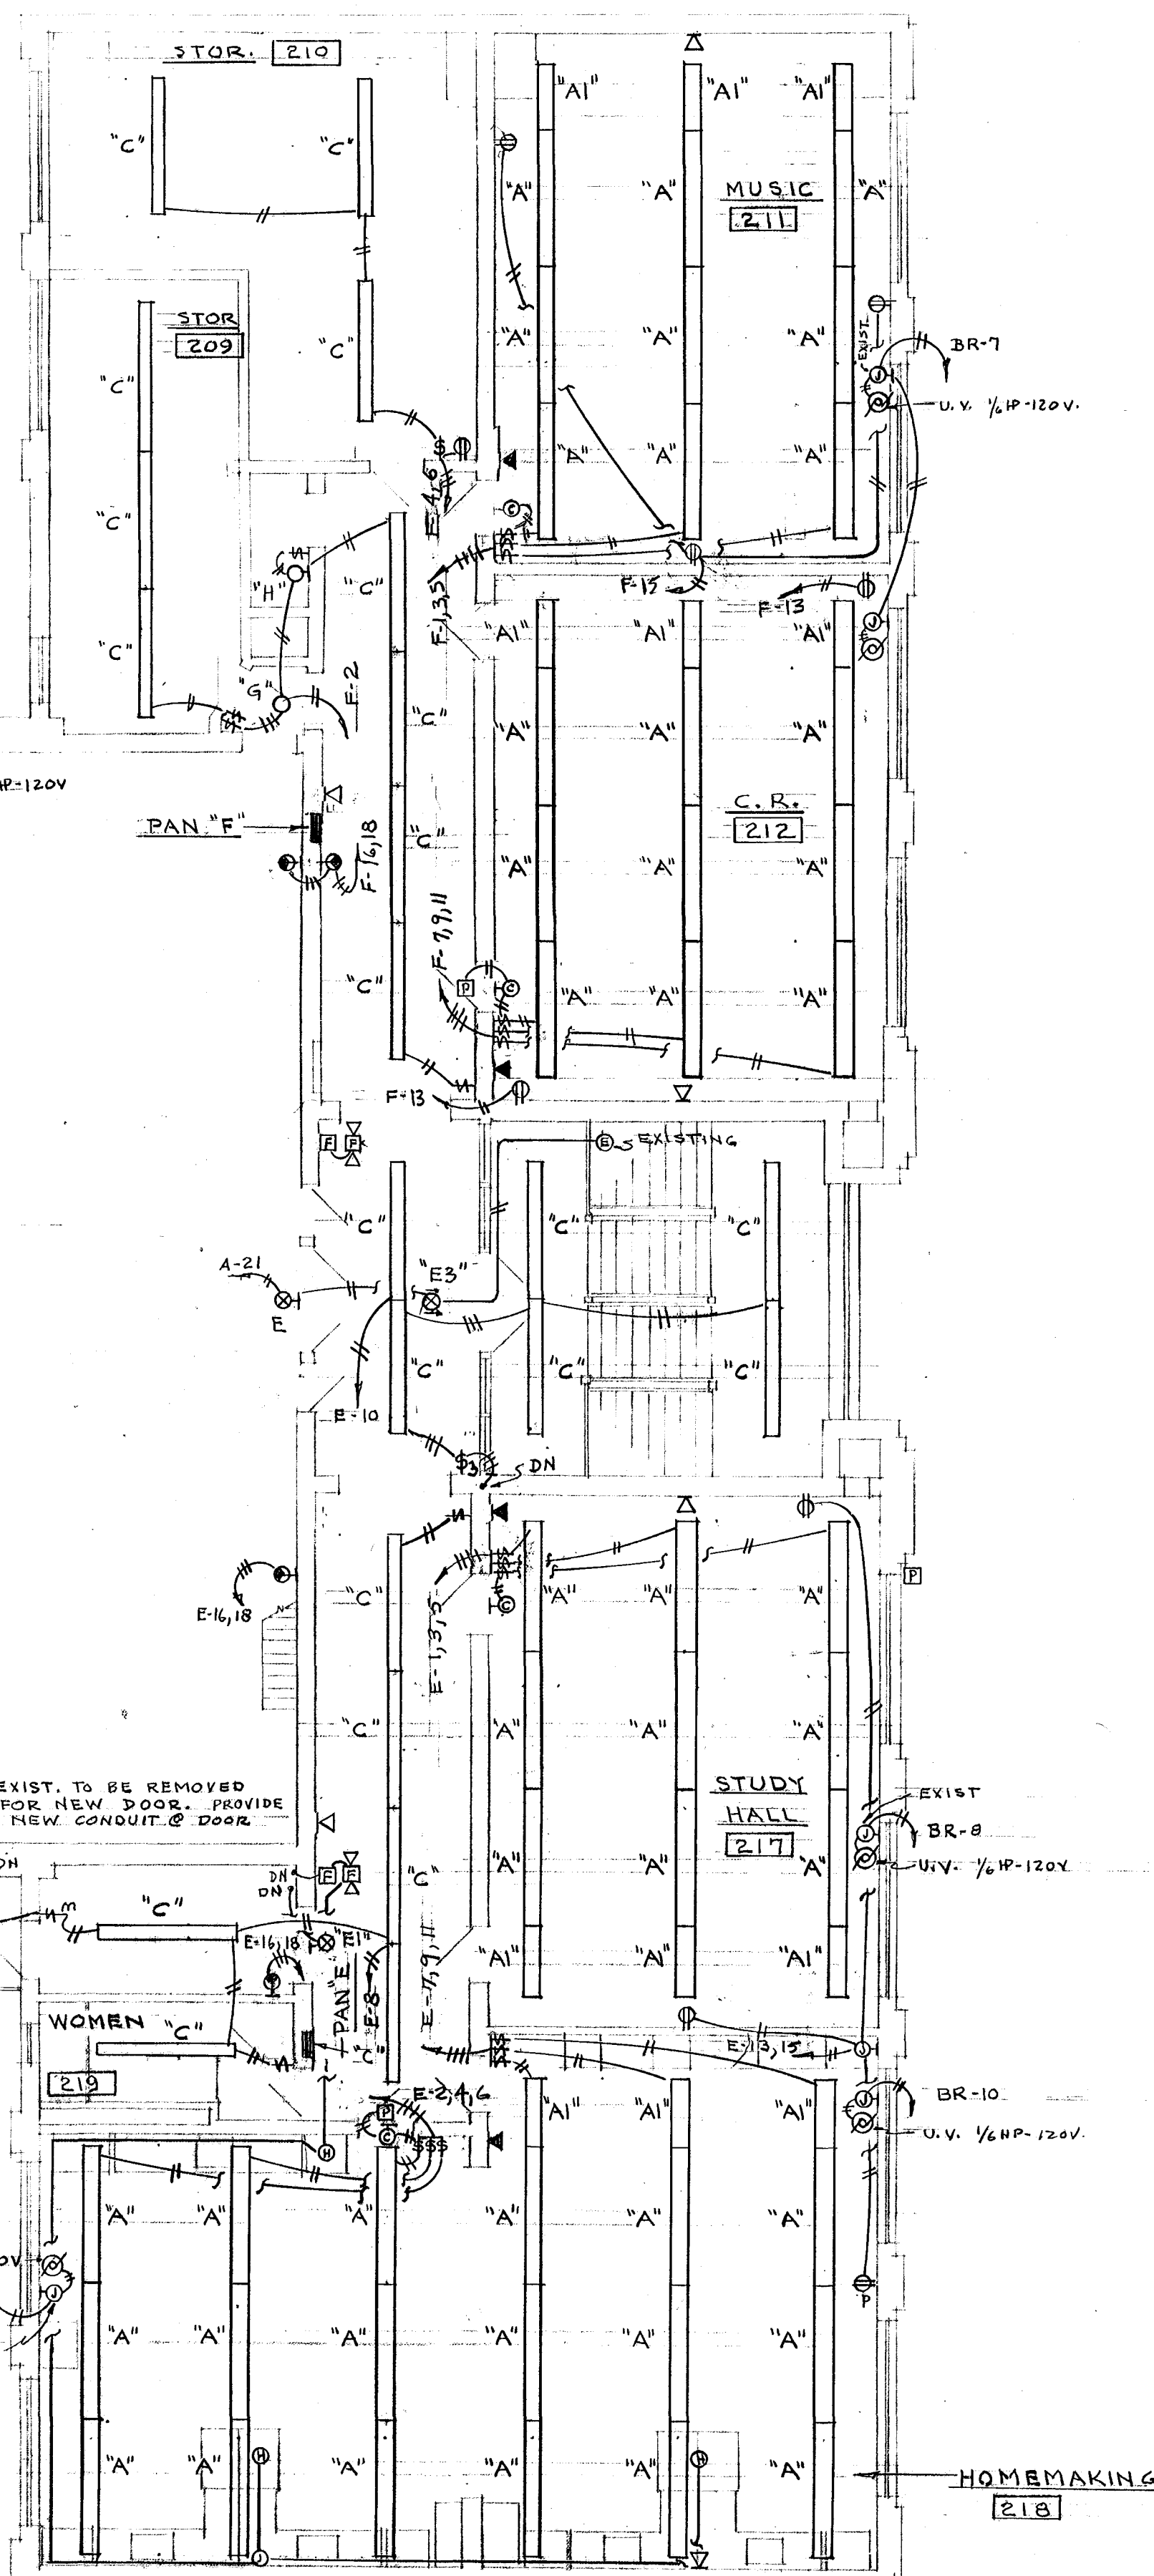

CITY OF HARTFORD, CONNECTICUT DEPARTMENT OF ENGINEERING		
WASHINGTON STREET HIGH SCHOOL ALTERATIONS 110 WASHINGTON ST. HARTFORD, CONN.		DWG. No. 123
SUBMITTED R.G.B.	RECOMMENDED Daniel H. Taitell	APPROVED R.G.B.
DESIGN R.G.B.	DRAWN R.G.B.	DAYBOOK No. 09876-X
TRACED	CHECK	DATE APR. 7-1965

VERIFY EXISTING
CONDITIONS AND
DIMENSIONS AT
BUILDING