



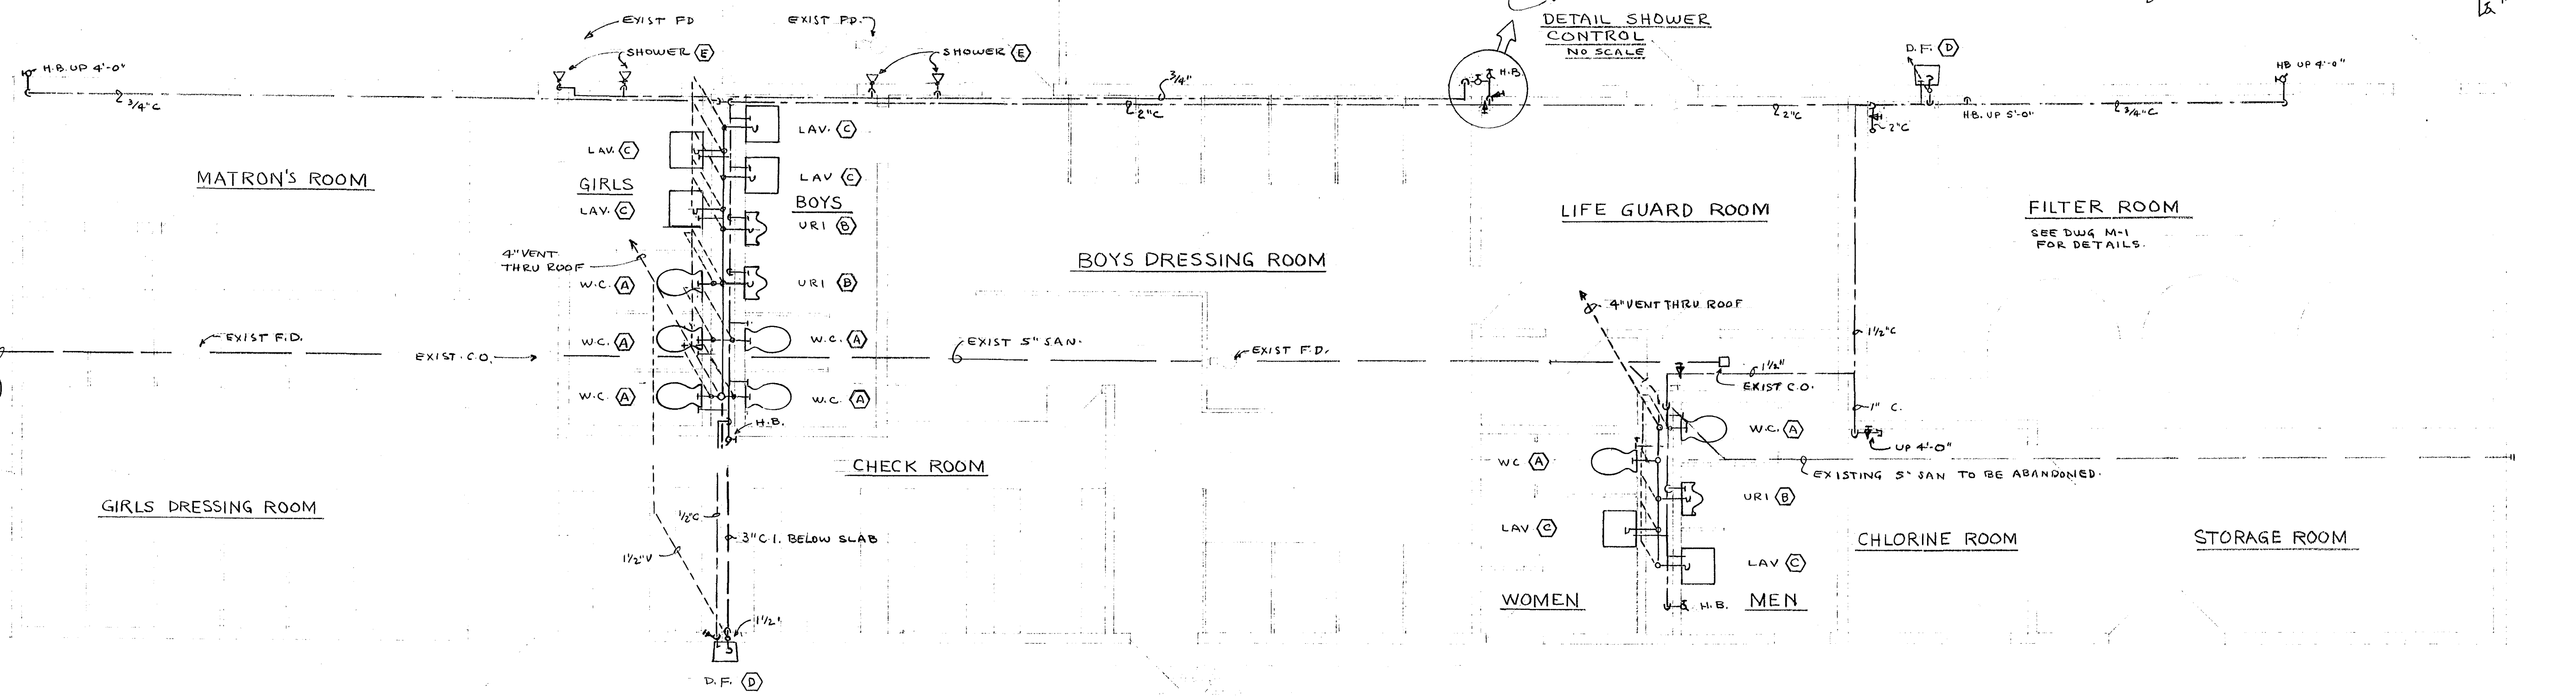


PLAN BATH HOUSE
SCALE 1/4" = 1'-0"

NOTE:
ALL C.W. PIPING TO BE INSULATED
WITH 1/2" FIBER GLASS INSULATION
WITH FACTORY APPLIED VAPOR
BARRIER.

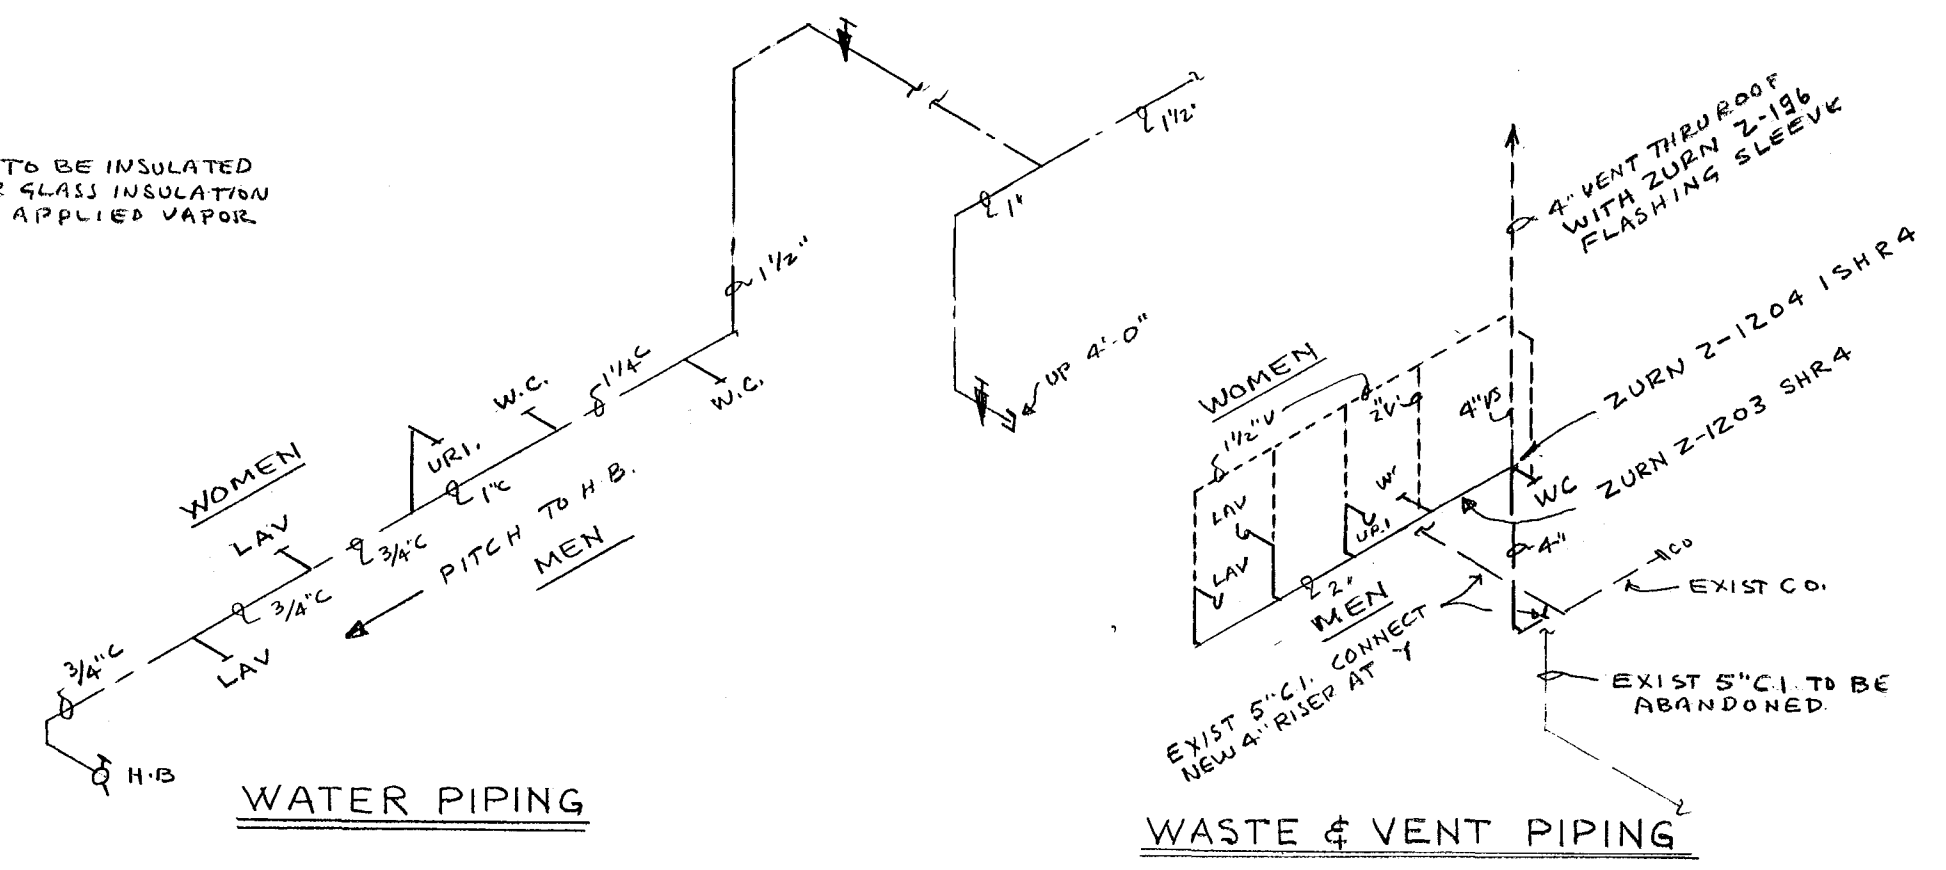

PIPING SCHEMATICS TOILETS
NO SCALE

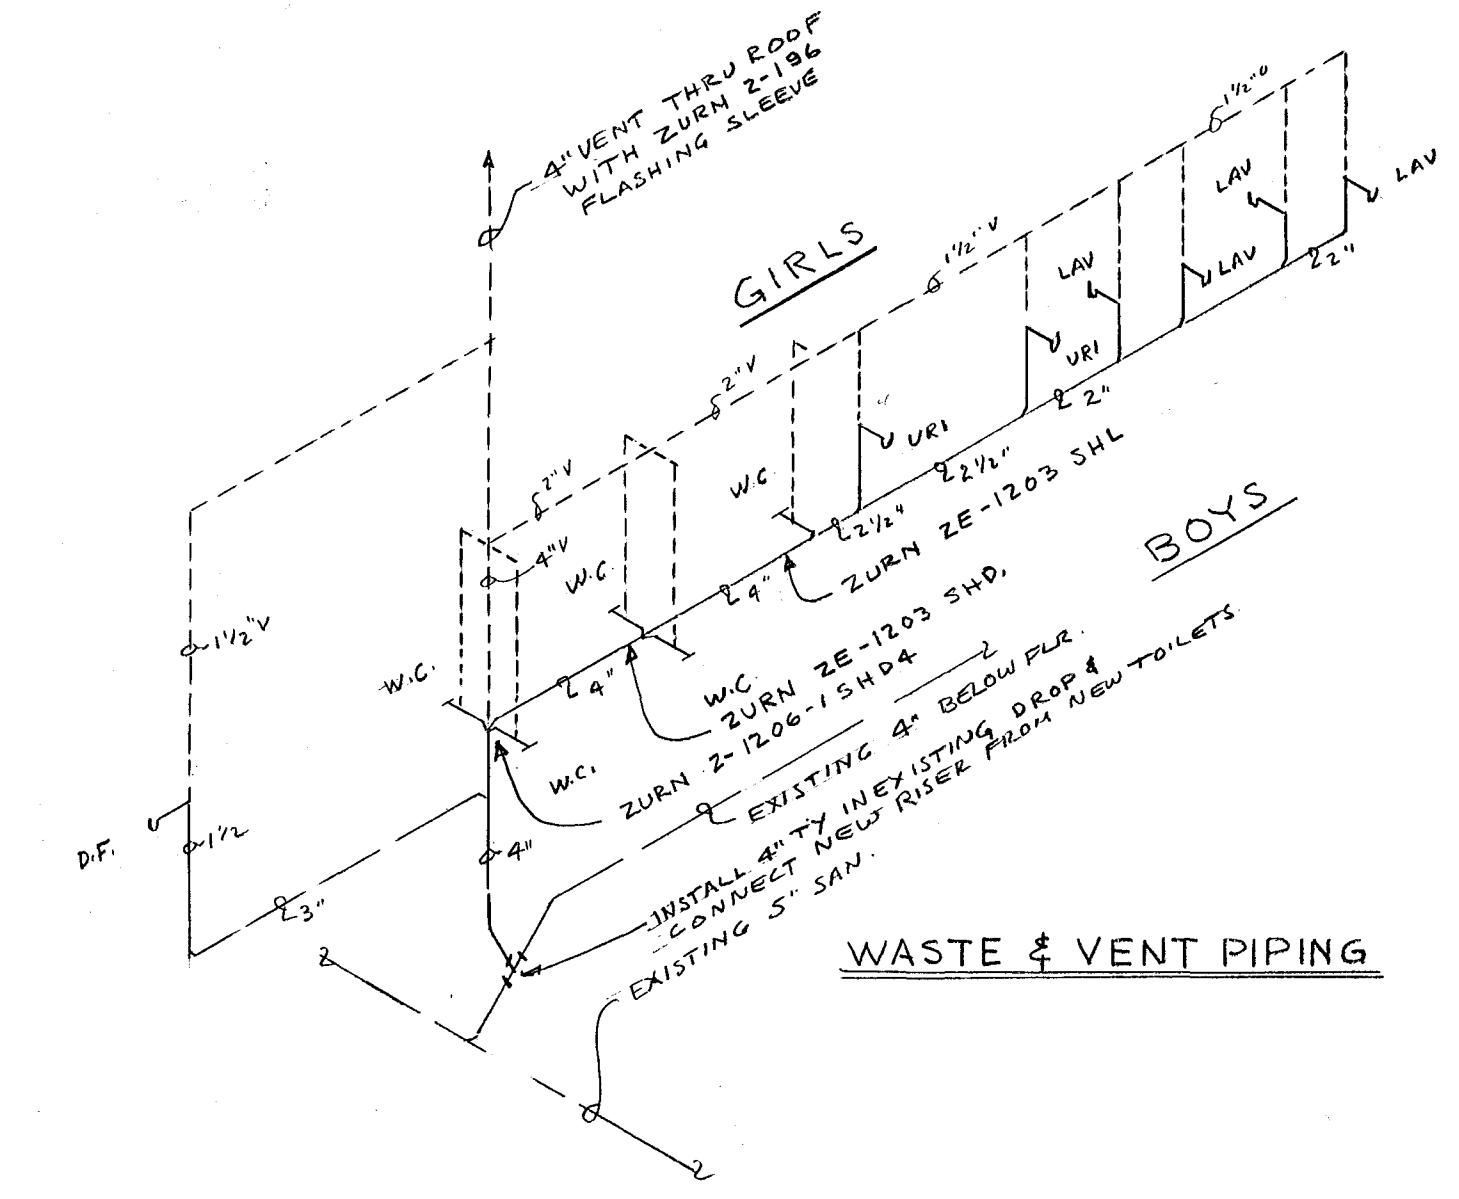

PIPING SCHEMATICS TOILETS
NO SCALE

PLUMBING FIXTURE SCHEDULE						
SYM	FIXTURE	SOIL OR WASTE	VENT	COLD WATER	HOT WATER	SPECIFICATION
(A)	W.C.	4"	2"	1"	-	AM. STD. "NEW GLENCO" F-2502 WALL HUNG WITH NO. 110 YW SLOAN ROYAL VALVE & OLSONITE #10 BLACK SEAT OPEN FRONT. ZURN INTEGRAL CARRIER FITTINGS WITH FOOT SUPPORT & VANDAL PROOF NUTS OF SIZES & TYPES AS SHOWN ON PLANS
(B)	URI	2"	1 1/2"	3/4"	-	AM. STD. "WASH BROOK" NO. F-6500-1 WITH #186-11 SLOAN ROYAL VALVE MOUNTING HEIGHT 15"
(C)	LAV	1 1/2"	1 1/2"	1/2"	-	AM. STD. "REGALYN" NO. P-4847 20"x18" C.I. A.R. ENAMEL WITH N-2542 DRAIN, R-2215 FAUCET, R-2607 SUPPLY & STOP, R-7013-44 1/4"x1 1/2" P TRAP MOUNTING HEIGHT 27"
(D)	D.F.	1 1/2"	1 1/2"	1/2"	-	HALSEY-TALOR NO. 4546 WITH MTG BRACKET TRAP & STOP MOUNTING HEIGHT 30"
(E)	SHOWER	-	-	1/2"	-	SYMMONS NO. 4-151 WITH 4 GPM RESTRICTOR MOUNT AT 5'-8" FOR GIRLS & 5'-10" FOR BOYS.
H.B.	HOSE BIBB	-	-	3/4"	-	ANACONDA 1463 ANGLE TYPE-LOOSE SET KEY-HOSE THREAD.
G	GATE VALVE	-	-	-	-	JENKINS FIG. 1242
O	GLOBE VALVE	-	-	-	-	JENKINS FIG. 1200

CITY OF HARTFORD, CONNECTICUT DEPARTMENT OF ENGINEERING			DWG. No.
NEW BUILDING FOR POPE PARK SWIMMING POOL HARTFORD, CONNECTICUT			P-1
SUBMITTED P.D.P.	RECOMMENDED R. Lasello CITY ARCHITECT	APPROVED C. H. Barron CITY ENGINEER	DESIGN P.D.P.
DRAWN P.D.P.		DAYBOOK NO. 010026-D	DATE APRIL 6 1968
TRACED CHECK			

VERIFY EXISTING
CONDITIONS AND
DIMENSIONS AT
BUILDING