




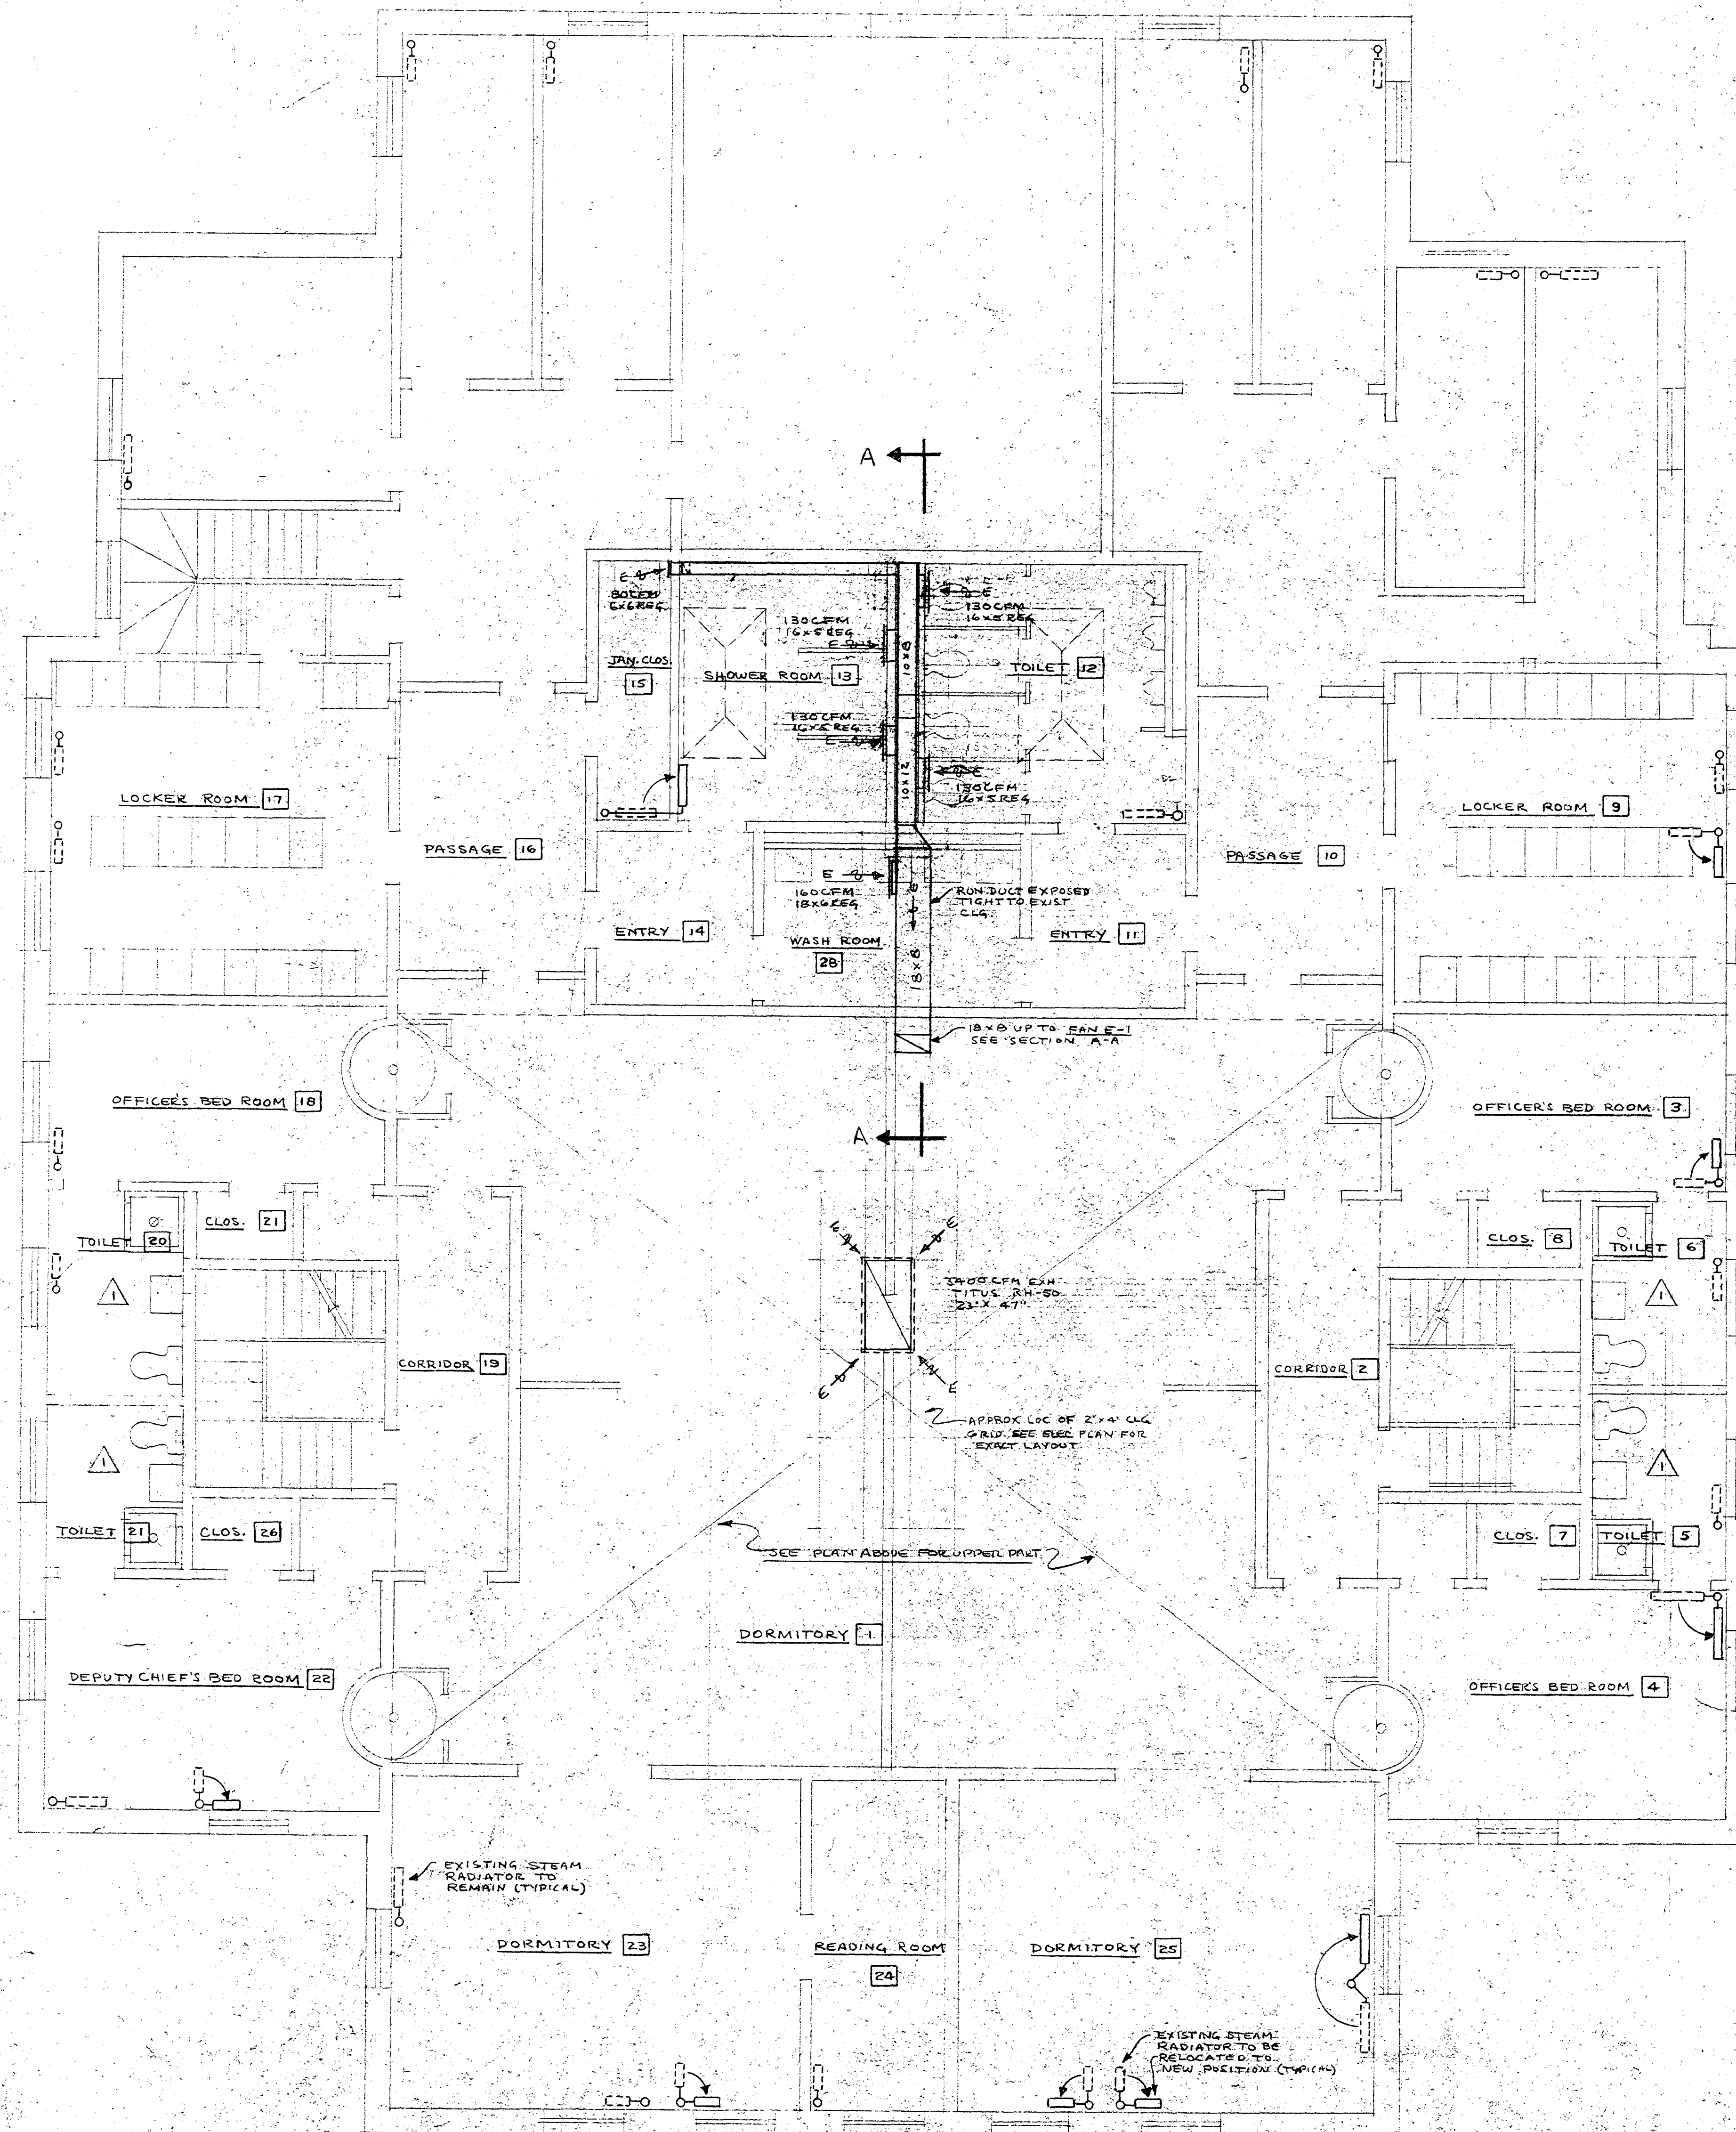

SECOND FLOOR PLAN
SCALE 1/4"=1'-0"

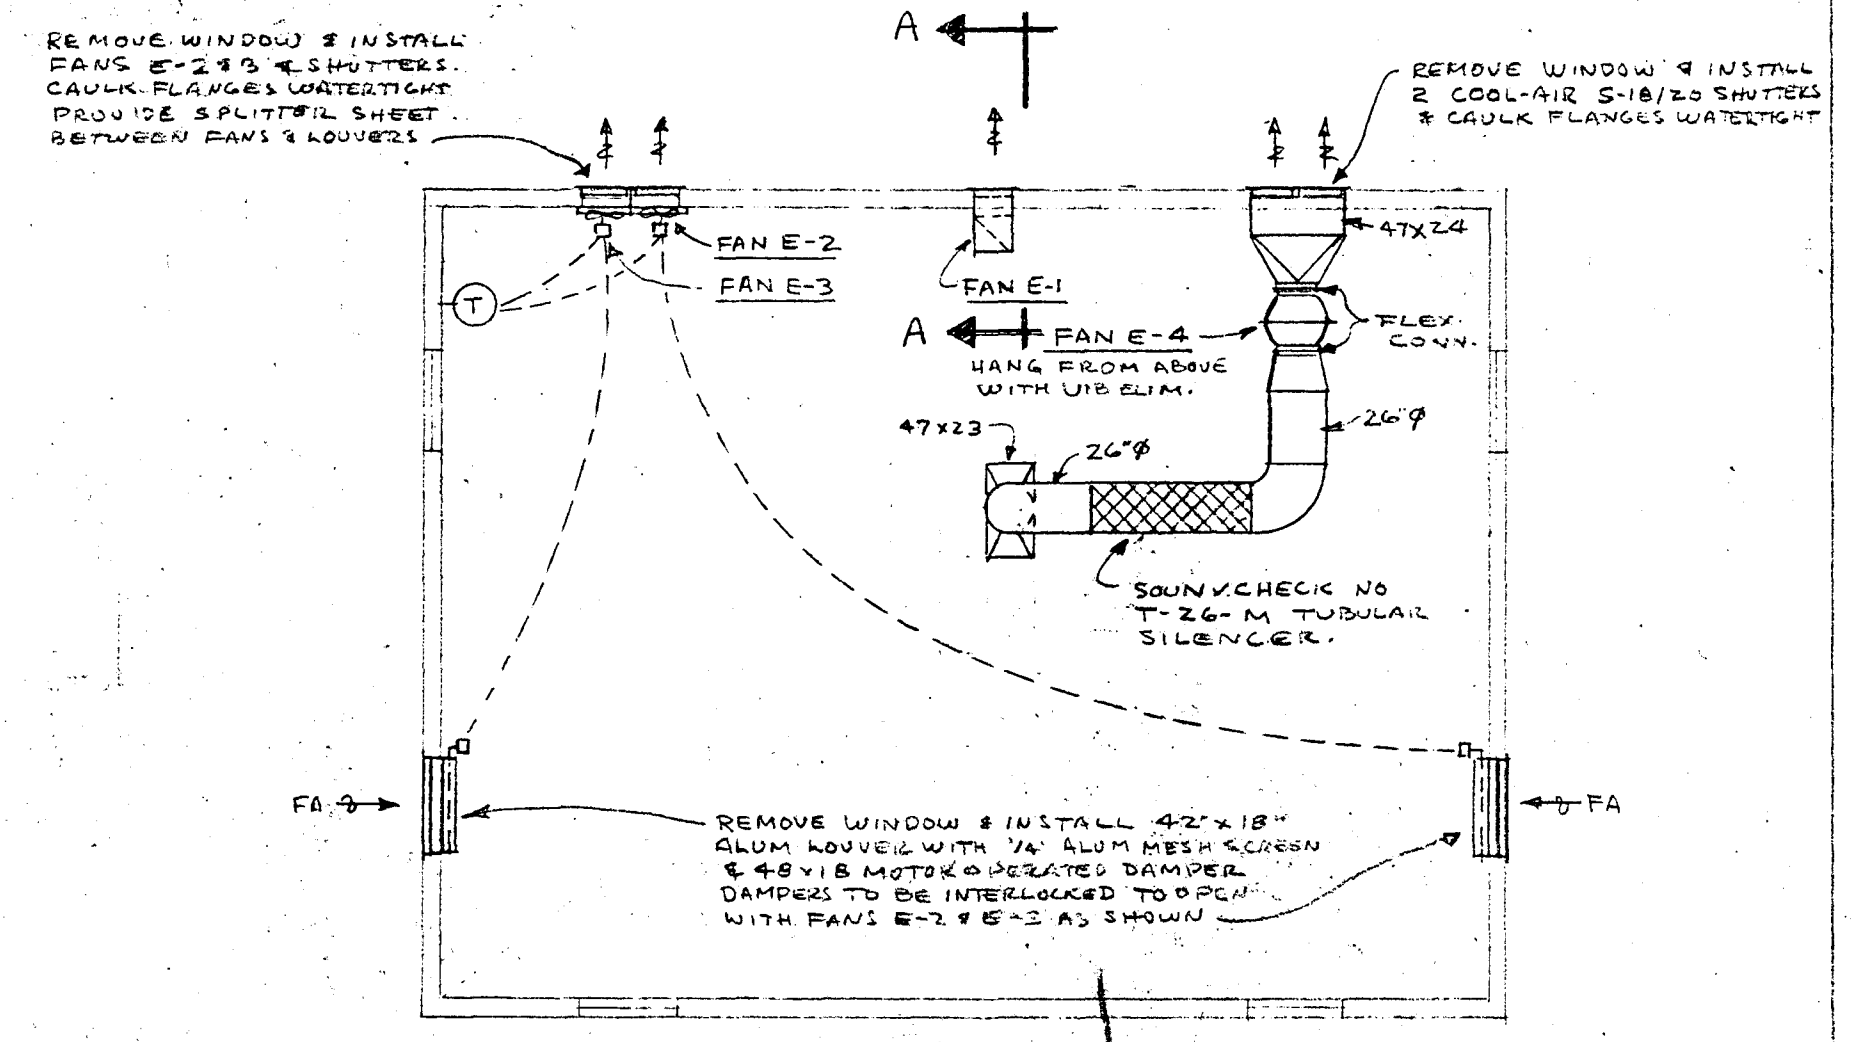

UPPER PART DORMITORY I PLAN
SCALE 1/8"=1'-0"

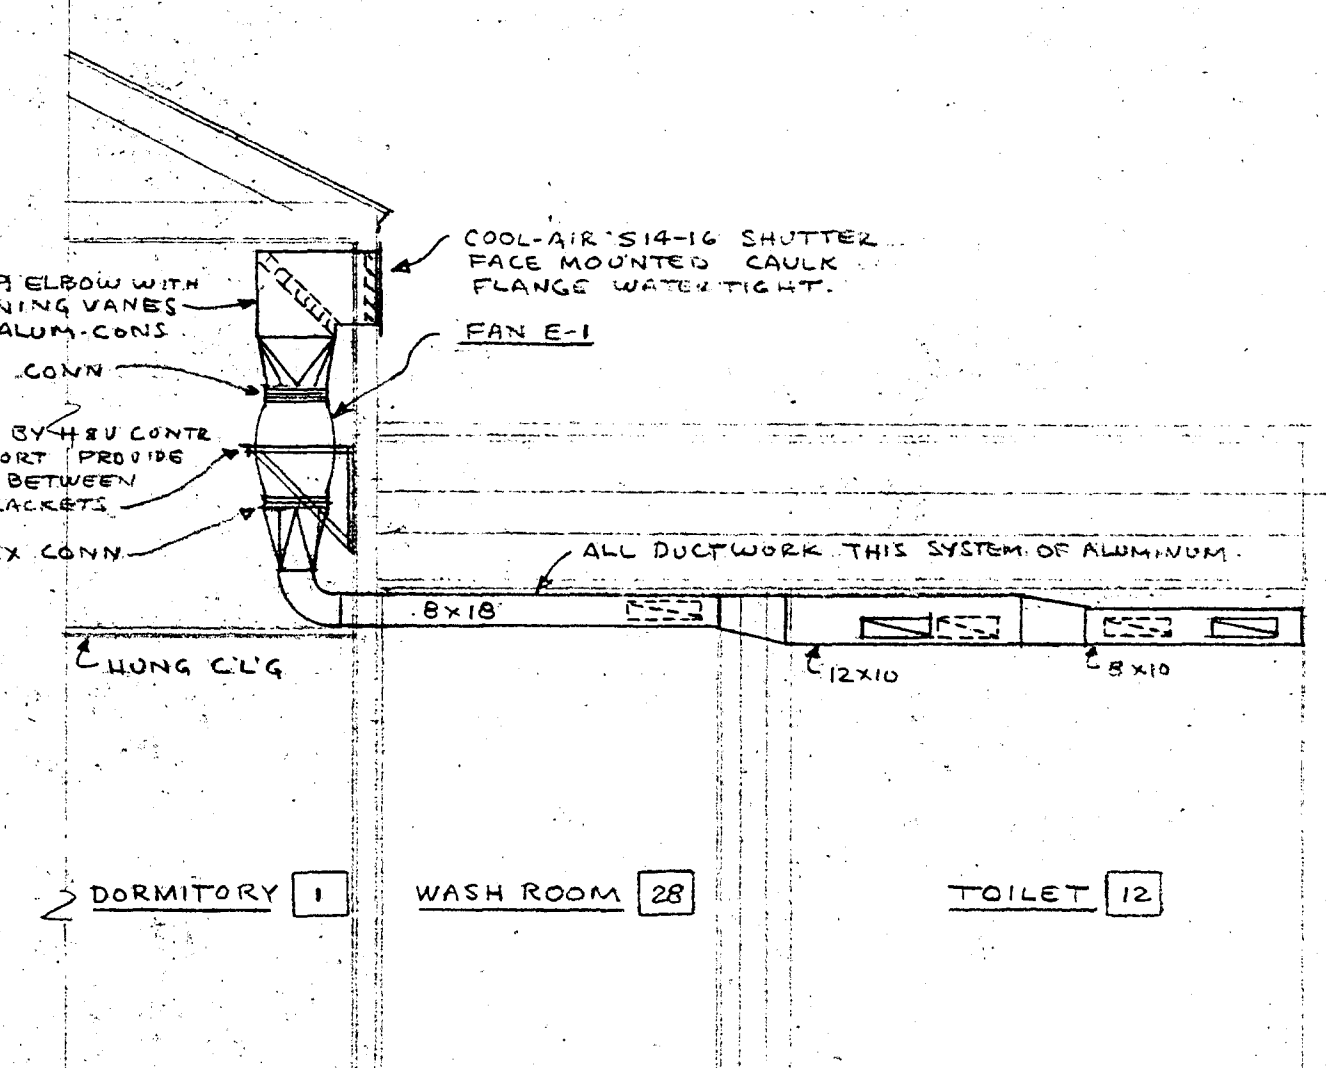

SECTION A-A
SCALE 1/4"=1'-0"

EQUIPMENT SCHEDULE:

1. FAN E-1 JENN-AIR NO. 128 1LD 1/2HP 840RPM 120V-1Ø-60C 830CFM @ 1/2" SP. PROVIDE THERMAL STARTER W/PL A17H RL-11-PL
2. FANS E-2, E-3 COOL-AIR NO. UD-204-H 3/4HP 1650RPM 230V-1Ø-60C 5000CFM @ 1/2" SP. PROVIDE COOL-AIR NO. S-18-20 SHUTTER MAGNETIC STARTER FOR EACH FAN. PROVIDE ONE MH NO. T-423 23" GAGE COOLING T-STAT. RANGE 60-100°F.
3. FAN E-4 JENN-AIR NO. 161-1LD 3/4HP 1140RPM 230V-1Ø-60C 3480CFM @ 1/2" SP. PROVIDE THERMAL STARTER W/PL A17H RL-11-PL
4. REGISTERS TITUS RL-251 - ALL ALUMINUM CONSTRUCTION WITH ALUMINUM DAMPERS.
5. SHEET METAL GAUGES PER ASHRAE GUIDE. TOILET & SHOWER SYSTEM ALL ALUMINUM. ALL OTHERS GALVANIZED STEEL.

VERIFY EXISTING
CONDITIONS AND
DIMENSIONS AT
BUILDING

REV. NO. 1	DATE 3-18-68	TOILET FIXTURES RELOCATED IN TOILETS NO. 5, 6, 20 & 21
CITY OF HARTFORD, CONNECTICUT DEPARTMENT OF ENGINEERING		
ALTERATIONS TO SECOND FLOOR OF ENGINE HOUSE NO. 2 1515 MAIN STREET HARTFORD, CONNECTICUT		DWG. NO. H E V 1
SUBMITTED Robert J. Smith	RECOMMENDED Daniel J. Tavelle	APPROVED [Signature]
DESIGN P.D.P.	DRAWN P.D.P.	DAYBOOK NO. 010007C
TRACED	CHECK	DATE MARCH 11, 1968