



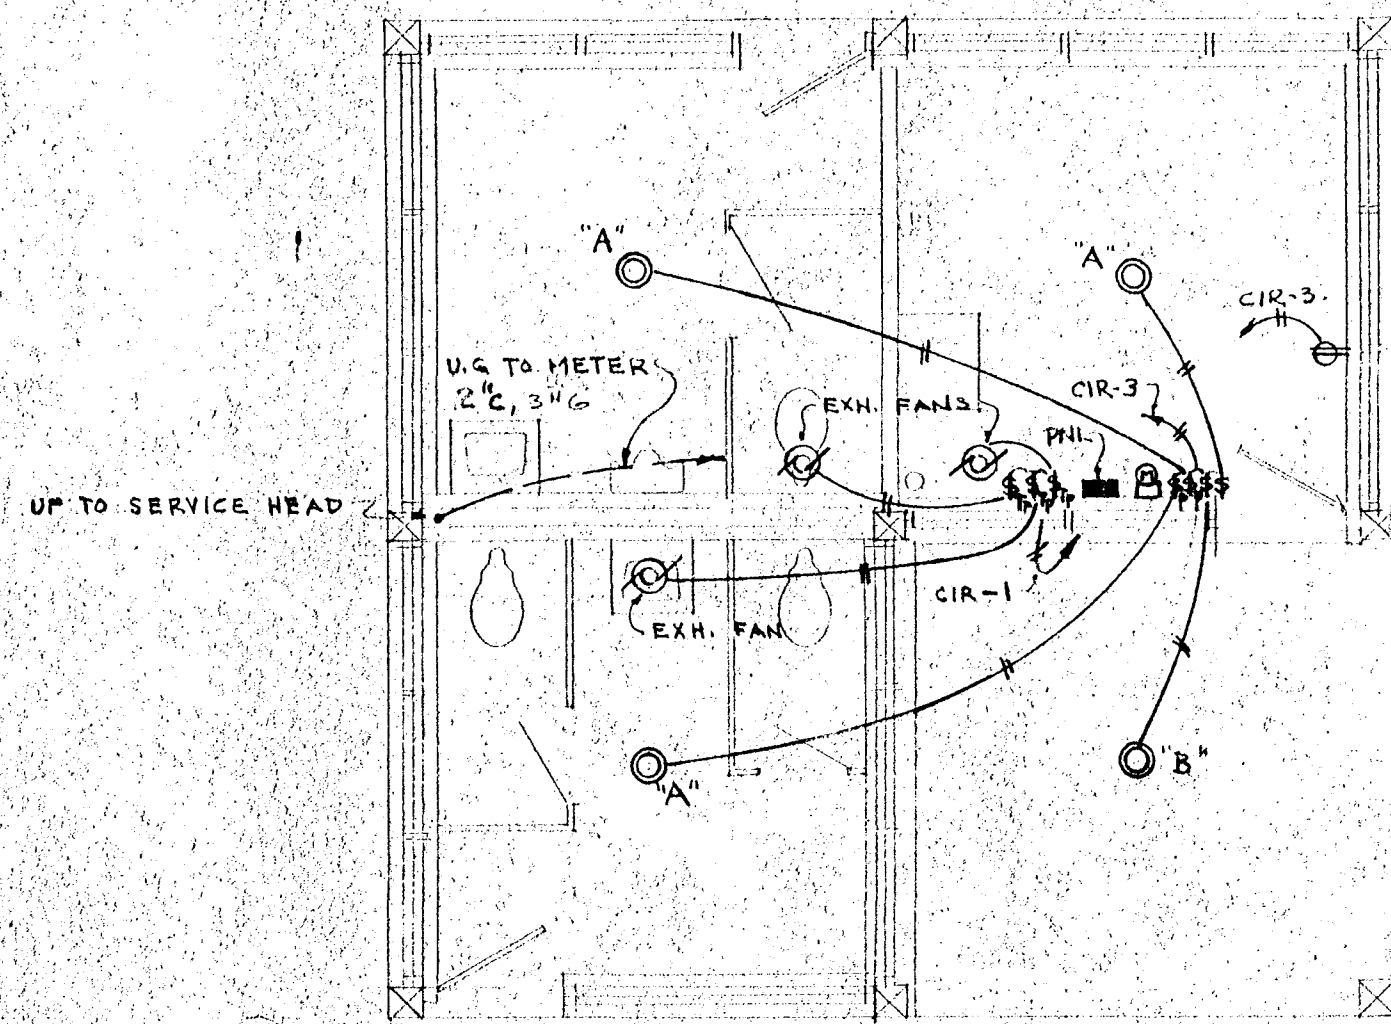

PLAN ELECTRICAL  
SCALE 1/4" = 1'-0"

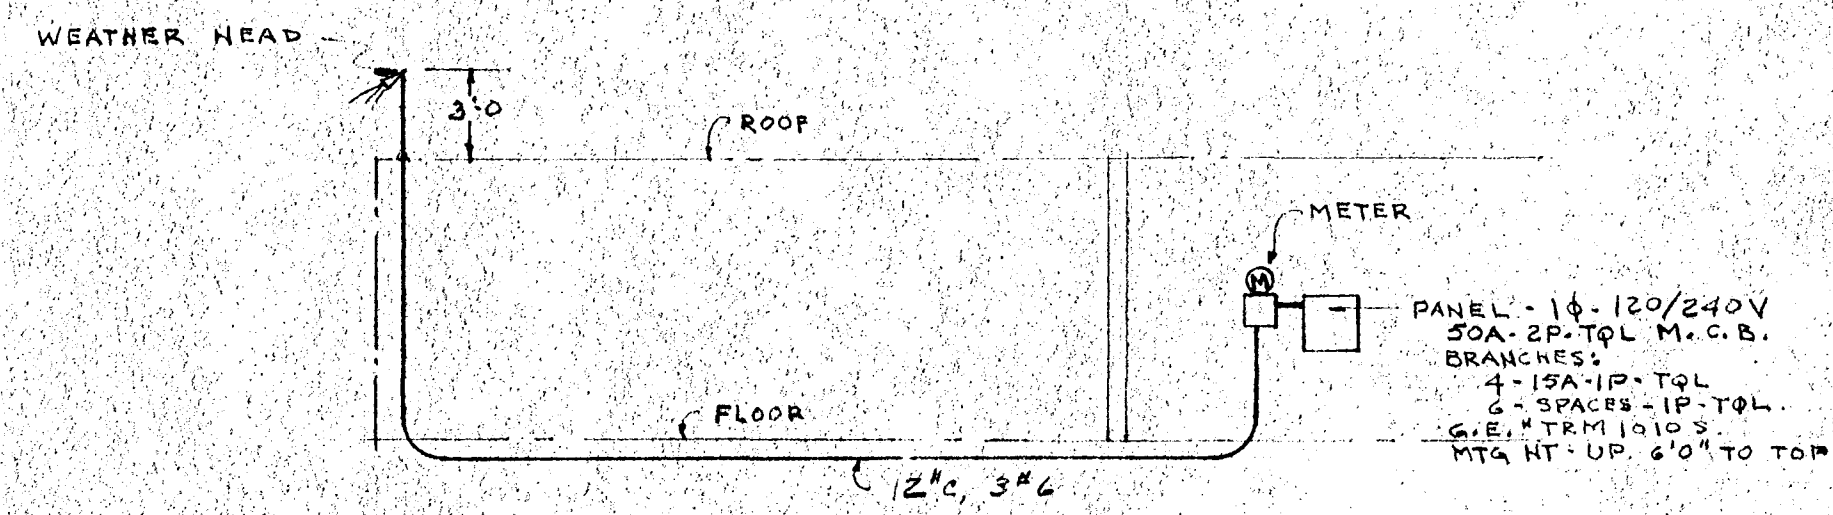


POWER RISER DIAGRAM  
NO SCALE

SYMBOL LIST.


- ⊙ RECESSED LIGHTING FIXTURE
- ⊠ SINGLE POLE SW. H#H 1891 UP 4'-0"
- ⊡ " " " & PILOT LT H#H 1891 & 1720 UP 4'-0"
- ⊗ MOTOR - FURNISHED, INSTALL BY OTHERS, WIRED BY E.C.
- ⊡ MOTOR STARTER & PILOT LT-FURN BY OTHER, INSTALLED & WIRED BY EQ. UP 4'-6"

FIXTURE SCHEDULE.

- A- PERFECTITE CAT. N° N834-BWE-PW LESS NIGHT LIGHT, 150W. I.F. LAMP
- B- PERFECTITE CAT. N° N834-MP-PW LESS NIGHT LIGHT, 150W. I.F. LAMP

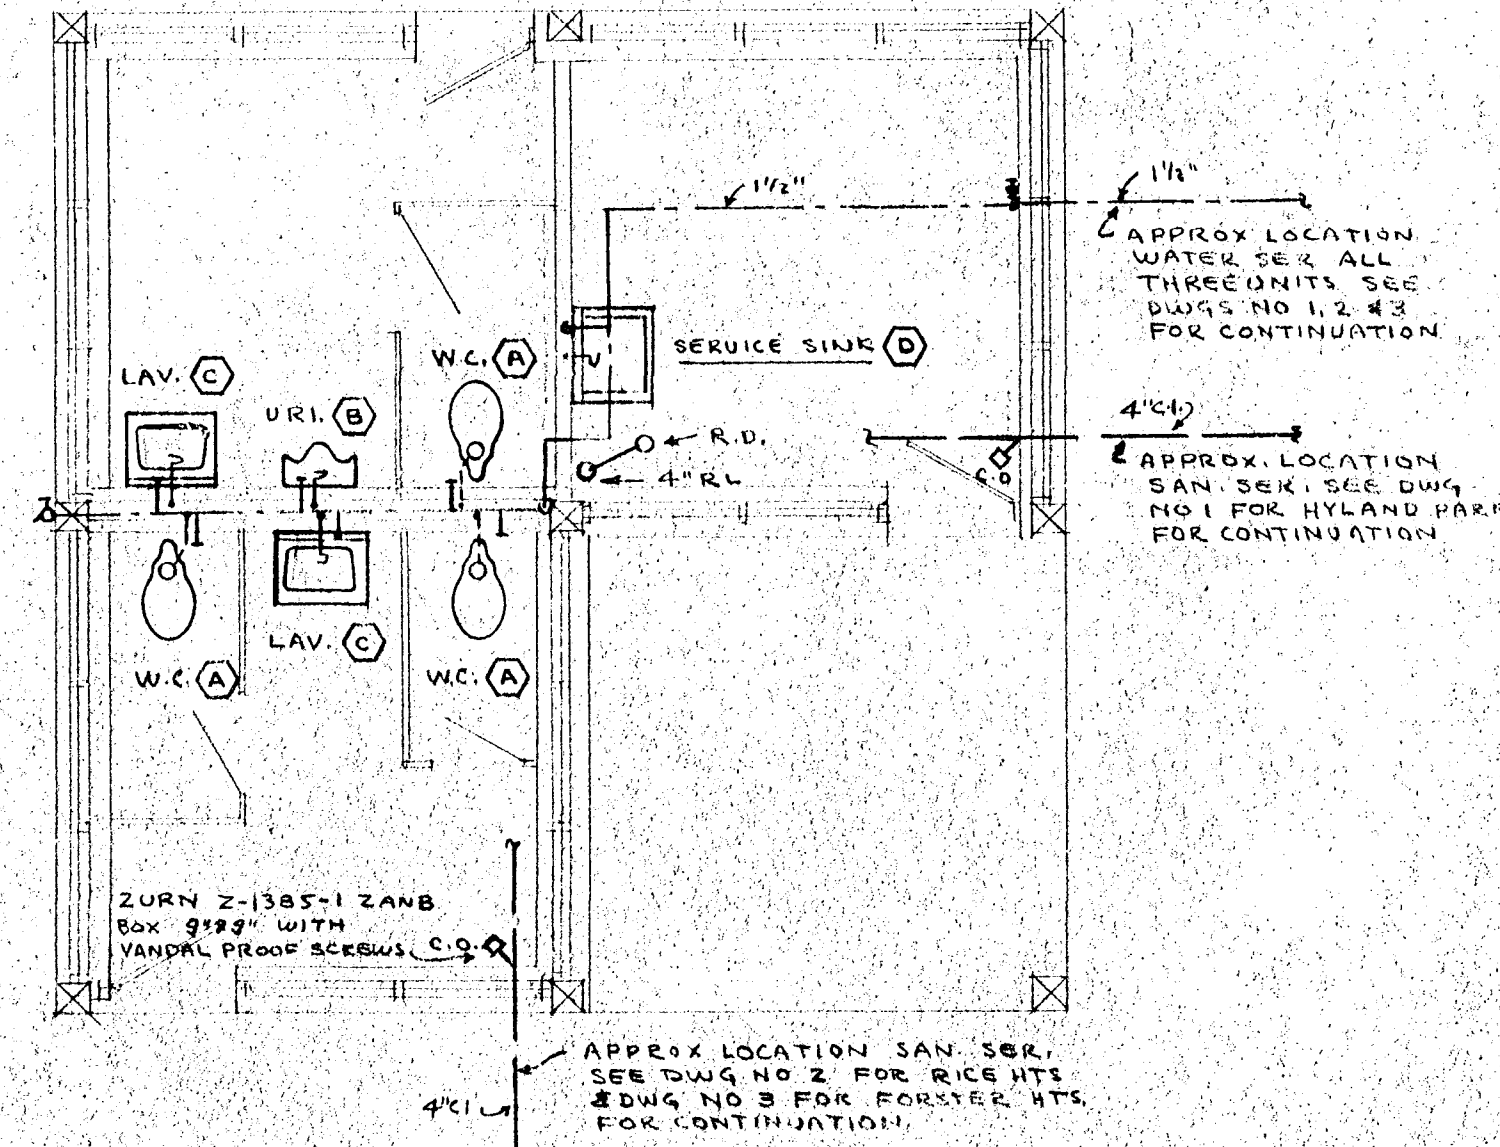


PLAN PLUMBING  
SCALE 1/4" = 1'-0"

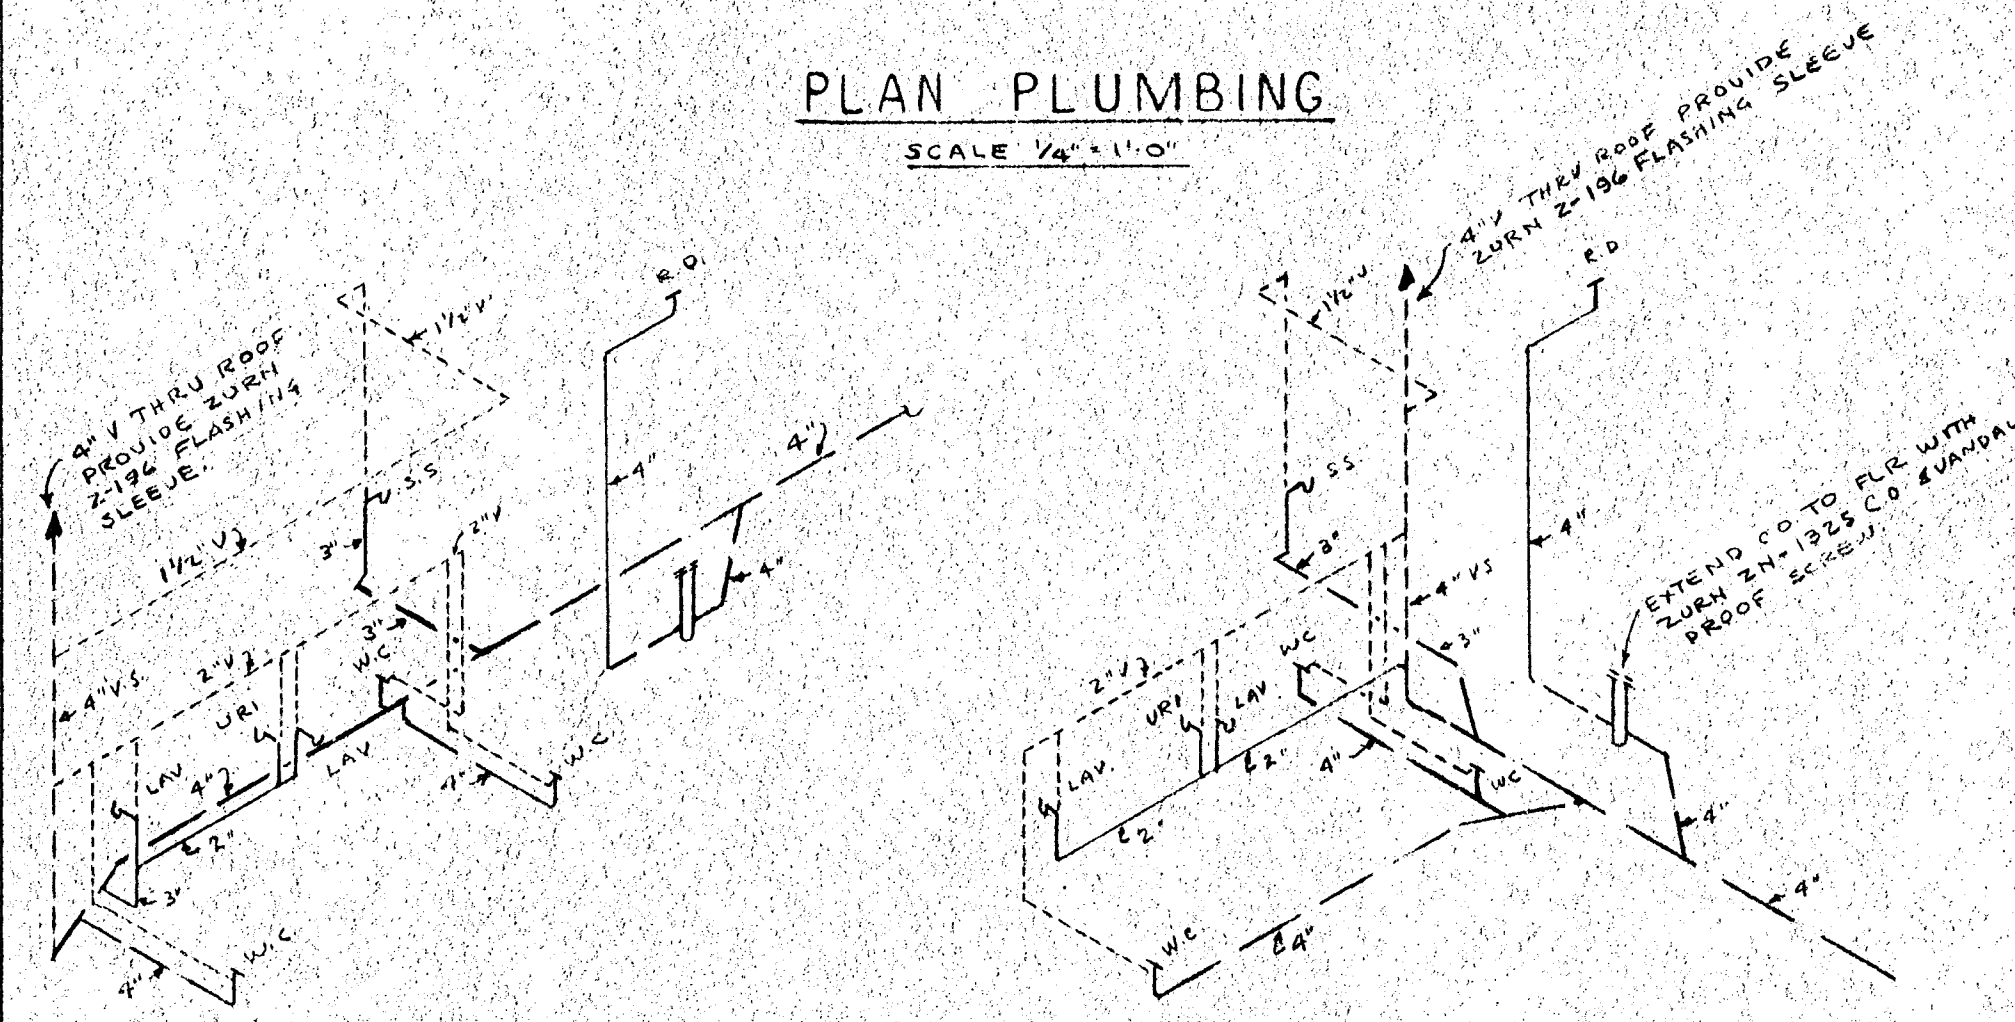


SCHEMATIC WASTE & VENT PIPING  
HYLAND PARK NO SCALE  
RICE & FORSTER HTS. NO SCALE


| SYM-BOL | FIXTURE      | SOIL OR WASTE | VENT   | C.W. | H.W. | SPECIFICATION                                                                                                                                                     |
|---------|--------------|---------------|--------|------|------|-------------------------------------------------------------------------------------------------------------------------------------------------------------------|
| (A)     | W.C.         | 4"            | 2"     | 1"   | -    | AM. STD. "NEW MADERA JUNIOR" F-2232 WITH NO. 110-FVY SLOAN ROYAL VALVE, OLSONITE #10 BLACK OPEN FRONT SEAT.                                                       |
| (B)     | URINAL       | 2"            | 1/2"   | 3/4" | -    | AM. STD. "WASHBROOK" F-6500-1 WITH NO. 186-II SLOAN ROYAL VALVE. MOUNTING HEIGHT - 15"                                                                            |
| (C)     | LAVATORY     | 1 1/2"        | 1 1/2" | 1/2" | -    | AM. STD. "HEXAGON" R-3849-40, 22" X 19" C.I.A.R. ENAMEL WITH N-2001 SUPPLY & DRAIN, R-2602 SUPPLY & STOP, R-7013-45 1 1/2" X 1 1/2" P TRAP. MOUNTING HEIGHT - 27" |
| (D)     | SERVICE SINK | 3"            | 1 1/2" | 1/2" | -    | AM. STD. "ARGON" F-7704 22" X 18" C.I.A.R. ENAMEL WITH STAINLESS STEEL RIM GUARD, P-7788 TRAP LTD. R-5084-T FAUCET.                                               |
|         | HOSE BIB     | -             | -      | 1/2" | -    | ANACONDA 1663, ANGLE TYPE, LOOSE SET KEY, HOSE THREAD                                                                                                             |
|         | ROOF DRAIN   | 4"            | -      | -    | -    | ZURN Z-100-RC WITH CLAMP MODIFIED FOR 5/8" PLYWOOD ROOF DECK                                                                                                      |

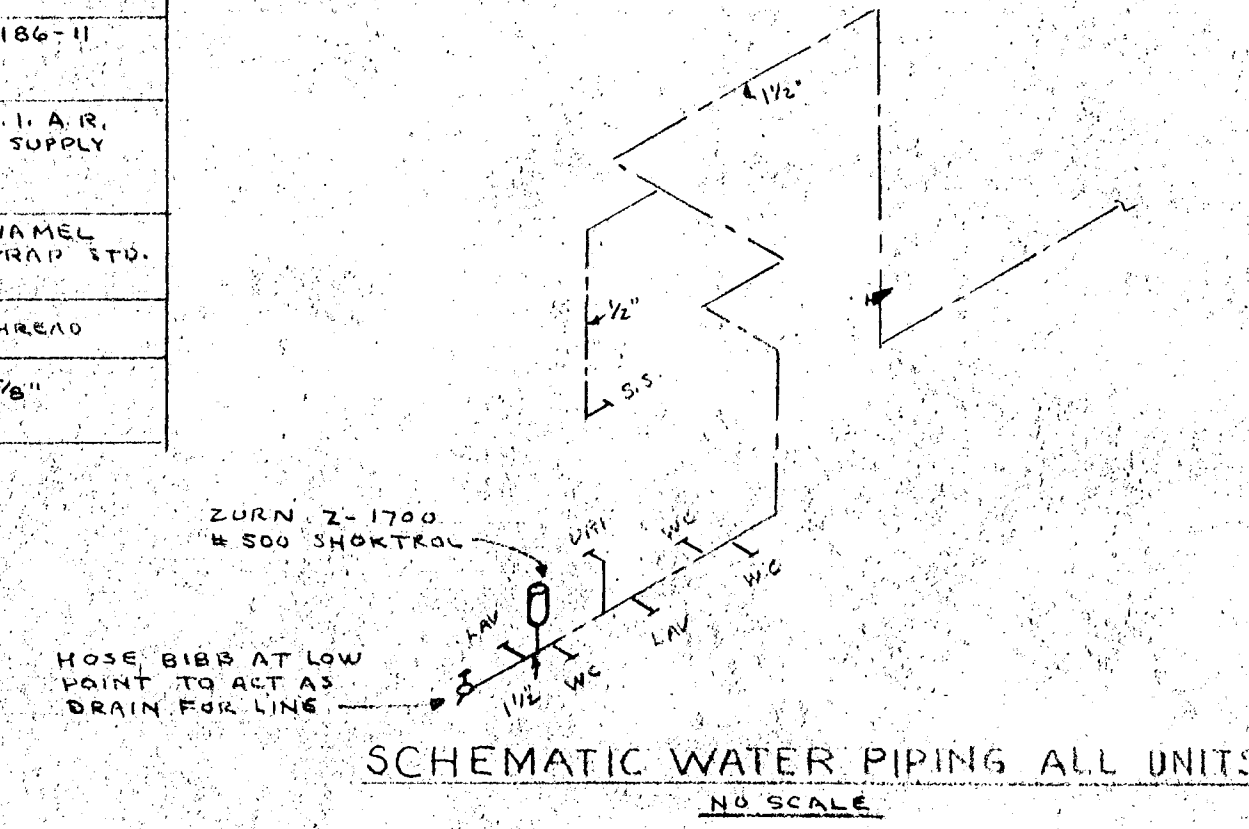

SCHEMATIC WATER PIPING ALL UNITS  
NO SCALE

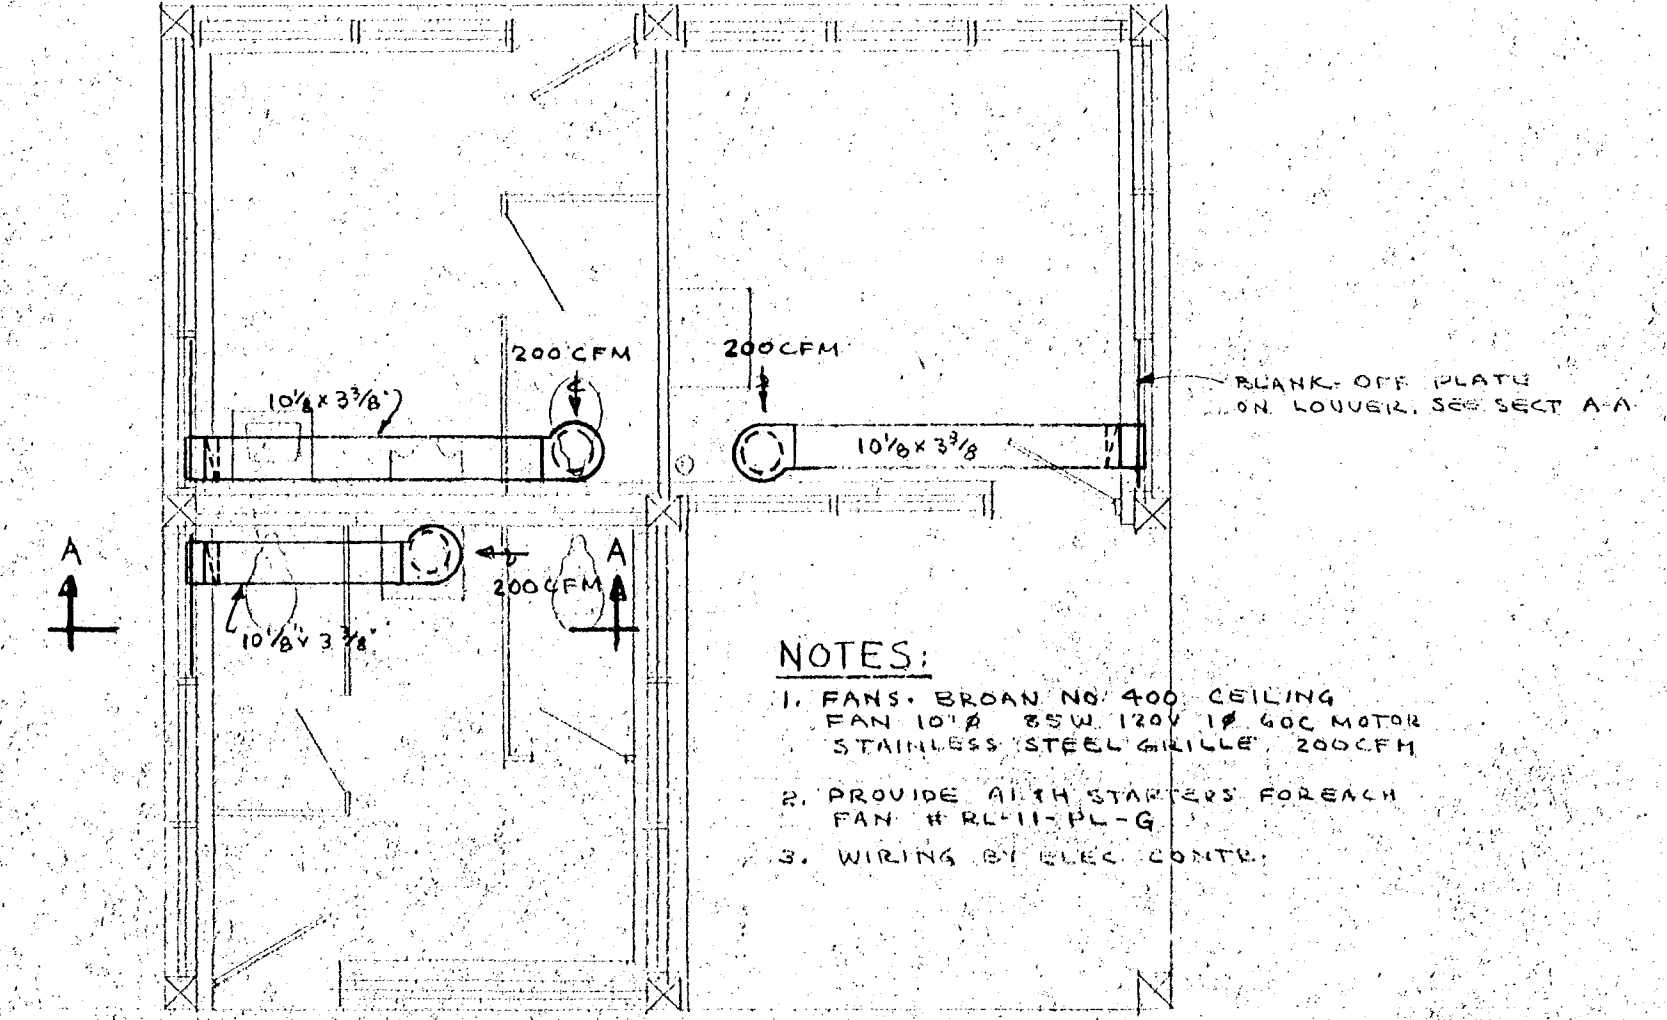

PLAN VENTILATING  
SCALE 1/4" = 1'-0"

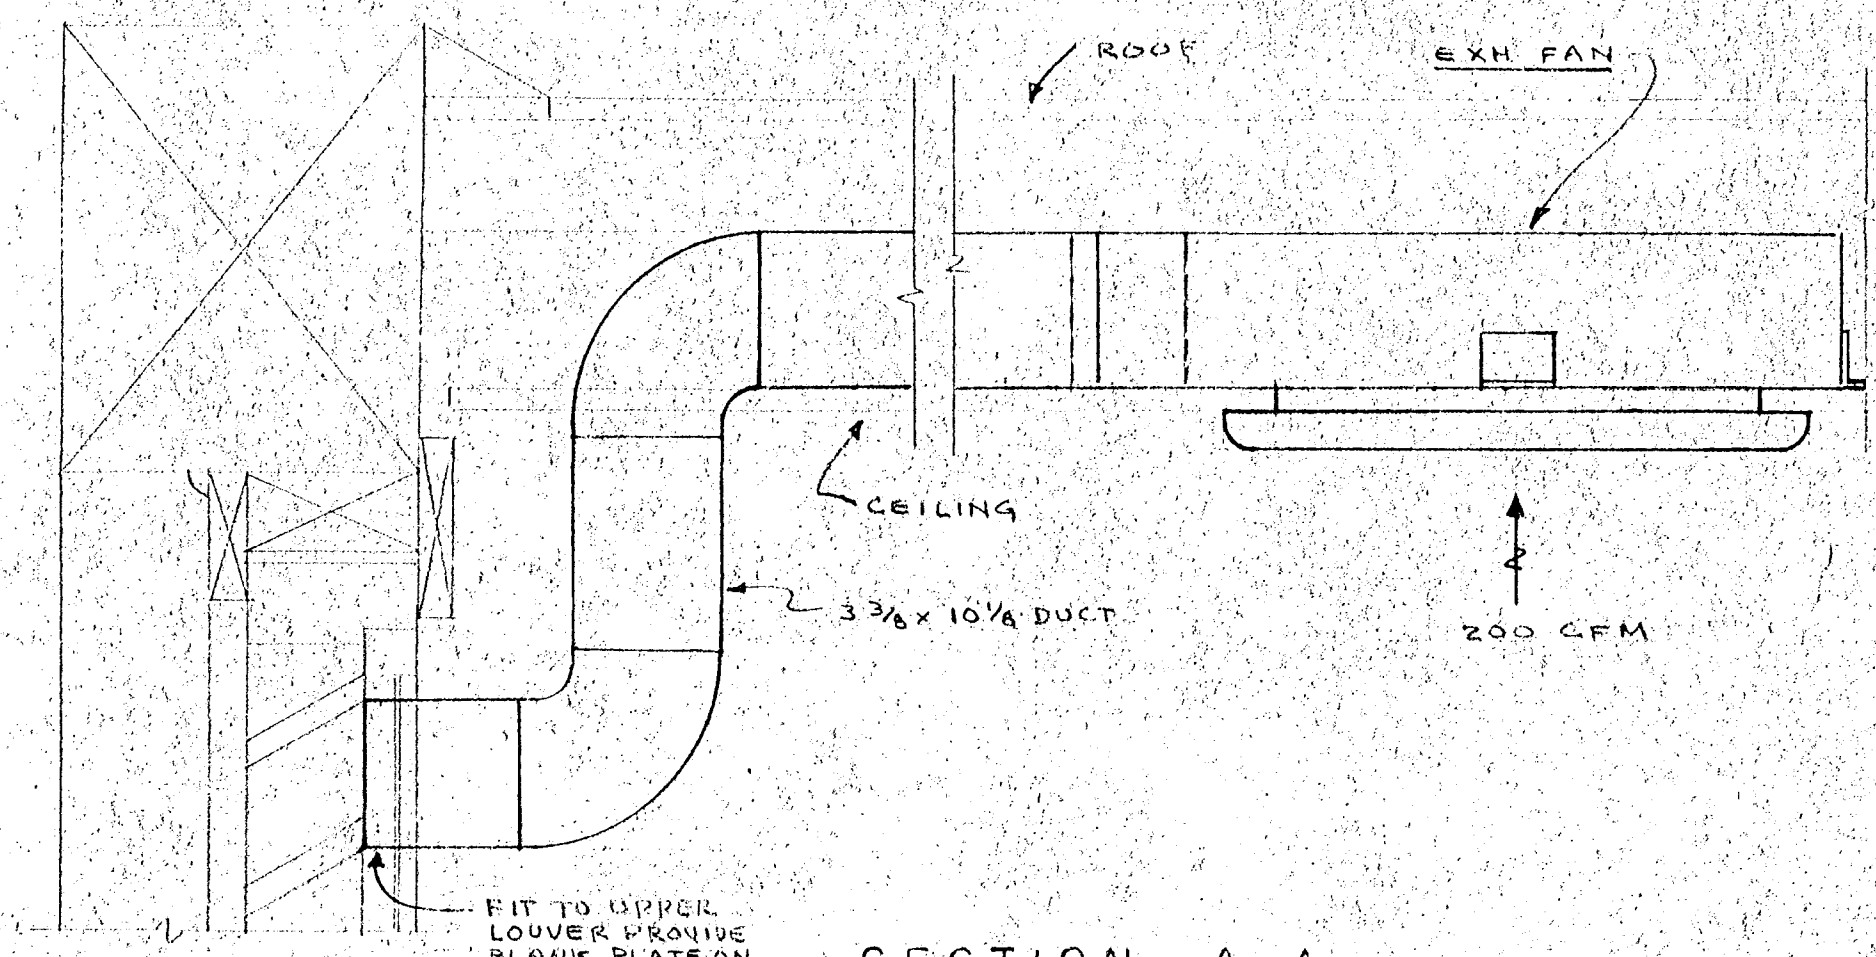

SECTION A-A  
SCALE 3/4" = 1'-0"

|                                                                                                        |                                                     |                                                 |
|--------------------------------------------------------------------------------------------------------|-----------------------------------------------------|-------------------------------------------------|
| CITY OF HARTFORD, CONNECTICUT<br>DEPARTMENT OF ENGINEERING                                             |                                                     |                                                 |
| TYPICAL FIELD HOUSE<br>MECHANICAL & ELECTRICAL<br>FOSTER HTS., RICE HTS., HYLAND PK<br>HARTFORD, CONN. |                                                     | DWG. NO.<br><b>7</b>                            |
| SUBMITTED<br><i>W.D. Stiehl</i>                                                                        | RECOMMENDED<br><i>W.D. Stiehl</i><br>CITY ARCHITECT | APPROVED<br><i>W.D. Stiehl</i><br>CITY ENGINEER |
| DESIGN<br>R.S.B. - POP                                                                                 | DRAWN<br>R.S.B. - POP                               | DAYBOOK NO. 09883-G                             |
| DATE MAY 4, 1965                                                                                       |                                                     |                                                 |