


SYMBOL LIST	
SYMBOL	DESCRIPTION
⊗	EXISTING SPRINKLER HEAD - APPROXIMATE LOCATION
⌞	GATE VALVE
⊙	GLOBE VALVE
⊕	EXISTING T' STAT
⊕	NEW T' STAT
—	DUCTWORK - NO INSULATION
—	DUCTWORK - WITH EXTERNAL INSULATION

CONVECTOR SCHEDULE				
SYMBOL	# E.D.R.	MFGR.	TYPE COVER	ELEMENT
C-1	83	TRANE	15-S WALL FIN	15 FT. - 1" COPPER-ALUM. SERIES 44 - 1ROW
C-2	83	TRANE	15-S WALL FIN	15 FT. - 1" COPPER-ALUM. SERIES 44 - 1ROW
C-3	101	TRANE	18-S WALL FIN	11 FT. - 1 1/4" COPPER-ALUM. SERIES 40 - 1ROW
C-4	74	TRANE	18-S WALL FIN	8 FT. - 1 1/4" COPPER-ALUM. SERIES 40 - 1ROW
C-5	55	TRANE	18-S WALL FIN	6 FT. - 1 1/4" COPPER-ALUM. SERIES 40 - 1ROW

REGISTER & DIFFUSER SCHEDULE				
SYMBOL	DUTY	MFGR.	TYPE	FINISH
A	SUPPLY	TITUS	S-277 & 115 FRAME	PRIME COAT
B	RETURN	TITUS	RL-251 & 115 FRAME	WALL MTD - PRIME COAT CLG MTD - BAKED WHITE ENAMEL
C	SUPPLY	TITUS	TNDC-S 4 & A9 95 DMPR	BAKED WHITE ENAMEL
D	RETURN	TITUS	RS-251 & 115 FRAME	PRIME COAT

* AT 1PSIG & 65°F AIR.

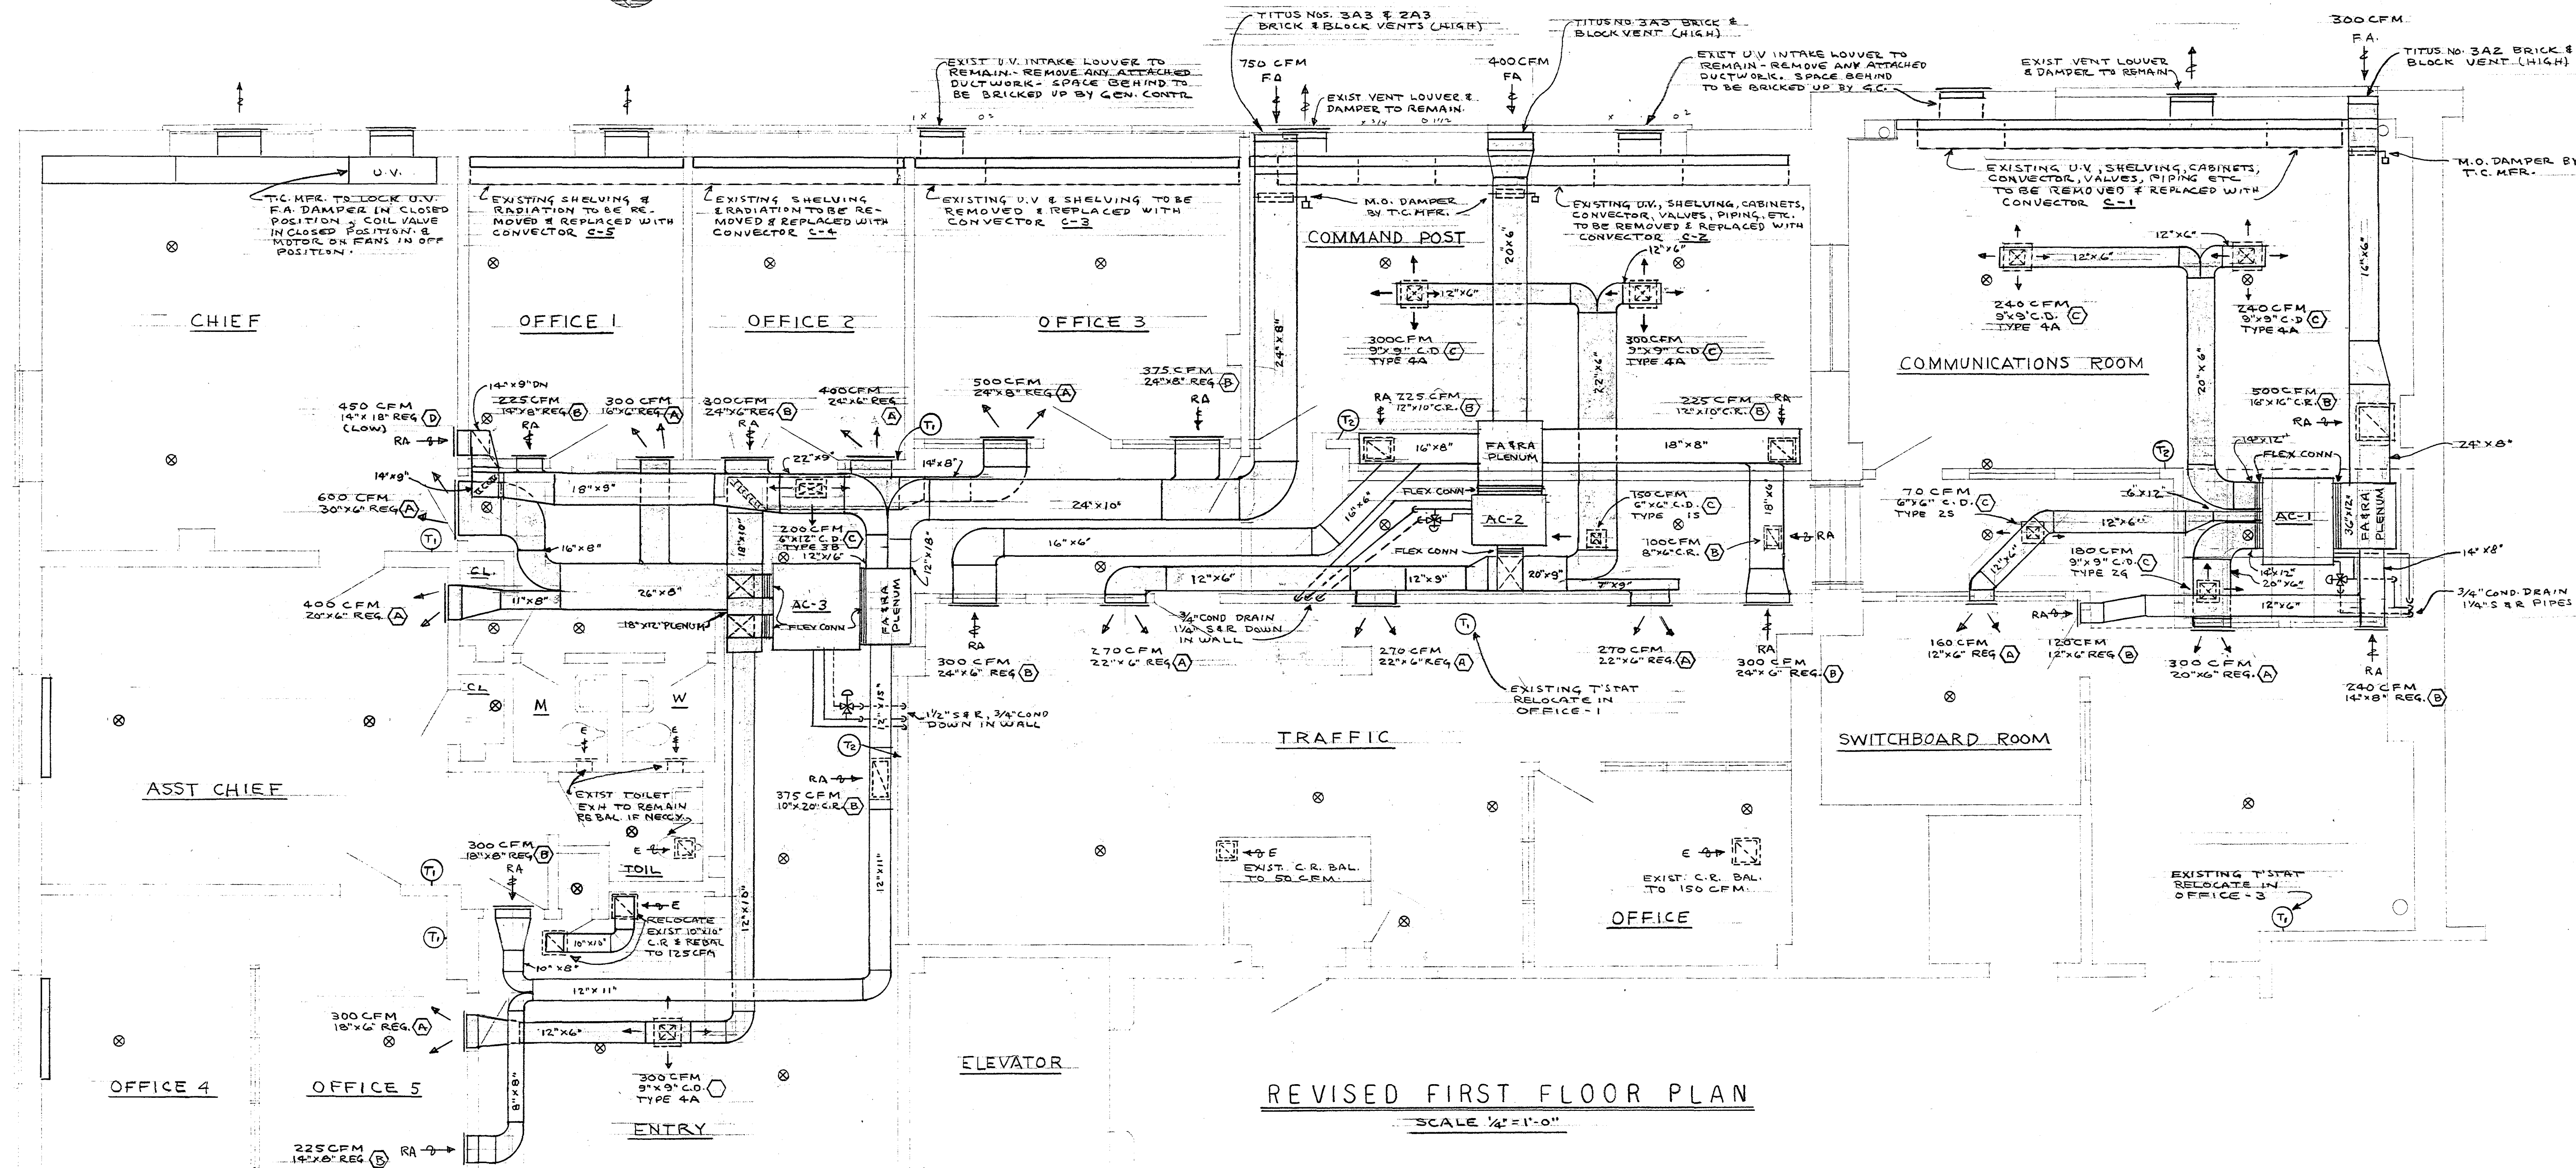

REVISED FIRST FLOOR PLAN
SCALE 1/4" = 1'-0"

CITY OF HARTFORD, CONNECTICUT DEPARTMENT OF ENGINEERING			
ALTERATIONS TO POLICE HEADQUARTERS 155 MORGAN STREET HARTFORD, CONN.			DWG. No. M 1
SUBMITTED <i>Booffenstich</i>	RECOMMENDED <i>David L. Smith</i>	APPROVED <i>George C. Nipper</i>	
DESIGN P.D.P.	DRAWN P.D.P.	DAYBOOK No. 10062 C	
TRACED	CHECK	DATE FEB. 28, 1969	

VERIFY EXISTING
CONDITIONS AND
DIMENSIONS AT
BUILDING