 
 


FIXTURE SCHEDULE			
TYPE	MANUFACTURER & CATALOG NO.	LAMPS	REMARKS
A	LITHONIA # 2G-440-RH	FOUR F40CW	RECESSED
A1	LITHONIA # 2G-240-RH	TWO F40CW	"
B	LITHONIA # 8TWA-240-RH	FOUR F40CW	SURFACE MTD.
B1	LITHONIA # 8TWA-440-RH	EIGHT F40CW	"
B2	LITHONIA # WA-240-RH	TWO F40CW	"
C	LIGHTOLIER # 7766	ONE 150W PAR FLD	RECESSED
D	LIGHTOLIER # 1778	ONE 75W R30 SPOT	"
E	RELOCATED EXISTING FIXTURE	TWO #96T4CW	EXISTING 1ST FL. FIXTURES TO BE USED IN COMM. TEL. RM.
E1	EXISTING TO REMAIN	ONE 100W IF	"
F	LITHONIA # 8TCC140RH	TWO F40CW	CEILING MTD.
G	DAYBRITE # 5220-W	TWO 2FT TRIGGER ST	WALL MTD ABOVE MIRROR
H	DAYBRITE # 45242-4	TWO F40CW	WALL MTD 1" BELOW CLG
H1	DAYBRITE # 45242-8	FOUR F40CW	"


ELECTRIC BASEBOARD SCHEDULE	
SYMBOL	DESCRIPTION
HTR-1	MARKEL # H854LC W/ BUILT-IN THERMOSTAT ~ 48" LONG ~ 750W, 208V.
HTR-2	MARKEL # H854LC W/ BUILT-IN THERMOSTAT ~ 72" LONG ~ 1150W, 208V.

SYMBOL LIST	
SYMBOL	DESCRIPTION
	FLUORESCENT FIXTURE
	RECESS FLUORESCENT FIXTURE
	CEILING OUTLET OR FIXTURE.
	DUPLEX CONV. OUTLET ~ H/H #5262 ~ UP 1'-6"
	EXISTING DUPLEX CONV. OUTLET ~ TO REMAIN.
	SINGLE POLE SW. ~ H/H #1911 ~ UP 4'-0"
	3-WAY SW. ~ H/H #1913 ~ UP 4'-0"
	DIMMER ~ SUPERIOR #WBD800 WITH #P853 PLATE ~ UP 4'-6"
	LIGHTING PANEL
	POWER PANEL
	MOTOR ~ SEE NOTE #1
	MAGNETIC MOTOR STARTER ~ SEE NOTE #2
	DISCONNECT ~ UP 5'-0"
	PUSH BUTTON STATION WITH PILOT LT ~ UP 5'-0" ~ SEE NOTE #2
	TELEPHONE CABINET ~ EXISTING ~ TO REMAIN.
	EXISTING TELEPHONE OUTLET.
	CLOCK - SURFACED MTD ~ 9" DIAL ~ SIMPLEX #58-35
	EXISTING CLOCK ~ TO REMAIN.
	EXISTING CLOCK RELOCATED AS SHOWN ~ UP 8'-6" ~ RECESSED
	EXISTING BELL TO REMAIN OR BE RELOCATED AS SHOWN.
	EXISTING ANNUNCIATOR TO REMAIN OR BE RELOCATED AS SHOWN
	EXISTING SPEAKER TO REMAIN OR BE RELOCATED AS SHOWN.
	EXISTING FLOOR OUTLET TO REMAIN
	EXISTING TELEPHONE FLOOR OUTLET TO REMAIN.
	DOOR OPENER - SEE NOTE #1
	ELECTRIC BASEBOARD HEATER ~ SEE SCHEDULE.

NOTES:
 1. FURNISHED & INSTALLED BY OTHERS; WIRED BY THIS ELEC. CONTR.
 2. FURNISHED BY OTHERS; INSTALLED & WIRED BY THIS ELEC. CONTR.

- NOTES
- HOME RUNS TO PAN. I-1 FOR LIGHTING CIRCUITS SHALL BE IN EXISTING CONDUITS AND CONNECTED TO EXISTING CIRCUIT BREAKERS.
 - EXISTING WIRING FOR EXISTING RECEPTACLES TO REMAIN. PROVIDE NEW WIRING FOR NEW RECEPTACLES AS SHOWN.
 - WHERE EXISTING WIRING DEVICES ARE LOCATED IN EXISTING PARTITIONS WHICH ARE TO BE REMOVED, WIRING TO THESE DEVICES SHALL BE RELOCATED AND RECONNECTED WHERE NECESSARY IN ORDER TO FEED OTHER EXISTING DEVICES NOW BEING FED FROM THESE POINTS.
 - UNIT VENTILATORS IN "COMMAND POST", "COMMUNICATIONS RM", "OFFICE #3" WILL BE REMOVED BY OTHERS. THIS ELEC. CONTRACTOR SHALL REMOVE ALL WIRING FOR THESE UNITS.
 - EXISTING WIRING & CONTROL DEVICES FOR UNIT VENTILATORS WHICH ARE TO BE REMAIN SHALL NOT BE REMOVED BY THIS ELEC. CONTRACTOR

- NOTES REV.
- CLG. DIFFUSER
 - CLG. RET. REG. OR EXH. REG.
 - WALL SUPPLY OR RET. OR EXH. REG.
 - SPRINKLER HEAD APPROX. EXISTING LOCATION
 - SEE DWG. M-1 FOR EXACT REG. & DISC. LOCATIONS & DUCT RUNS.

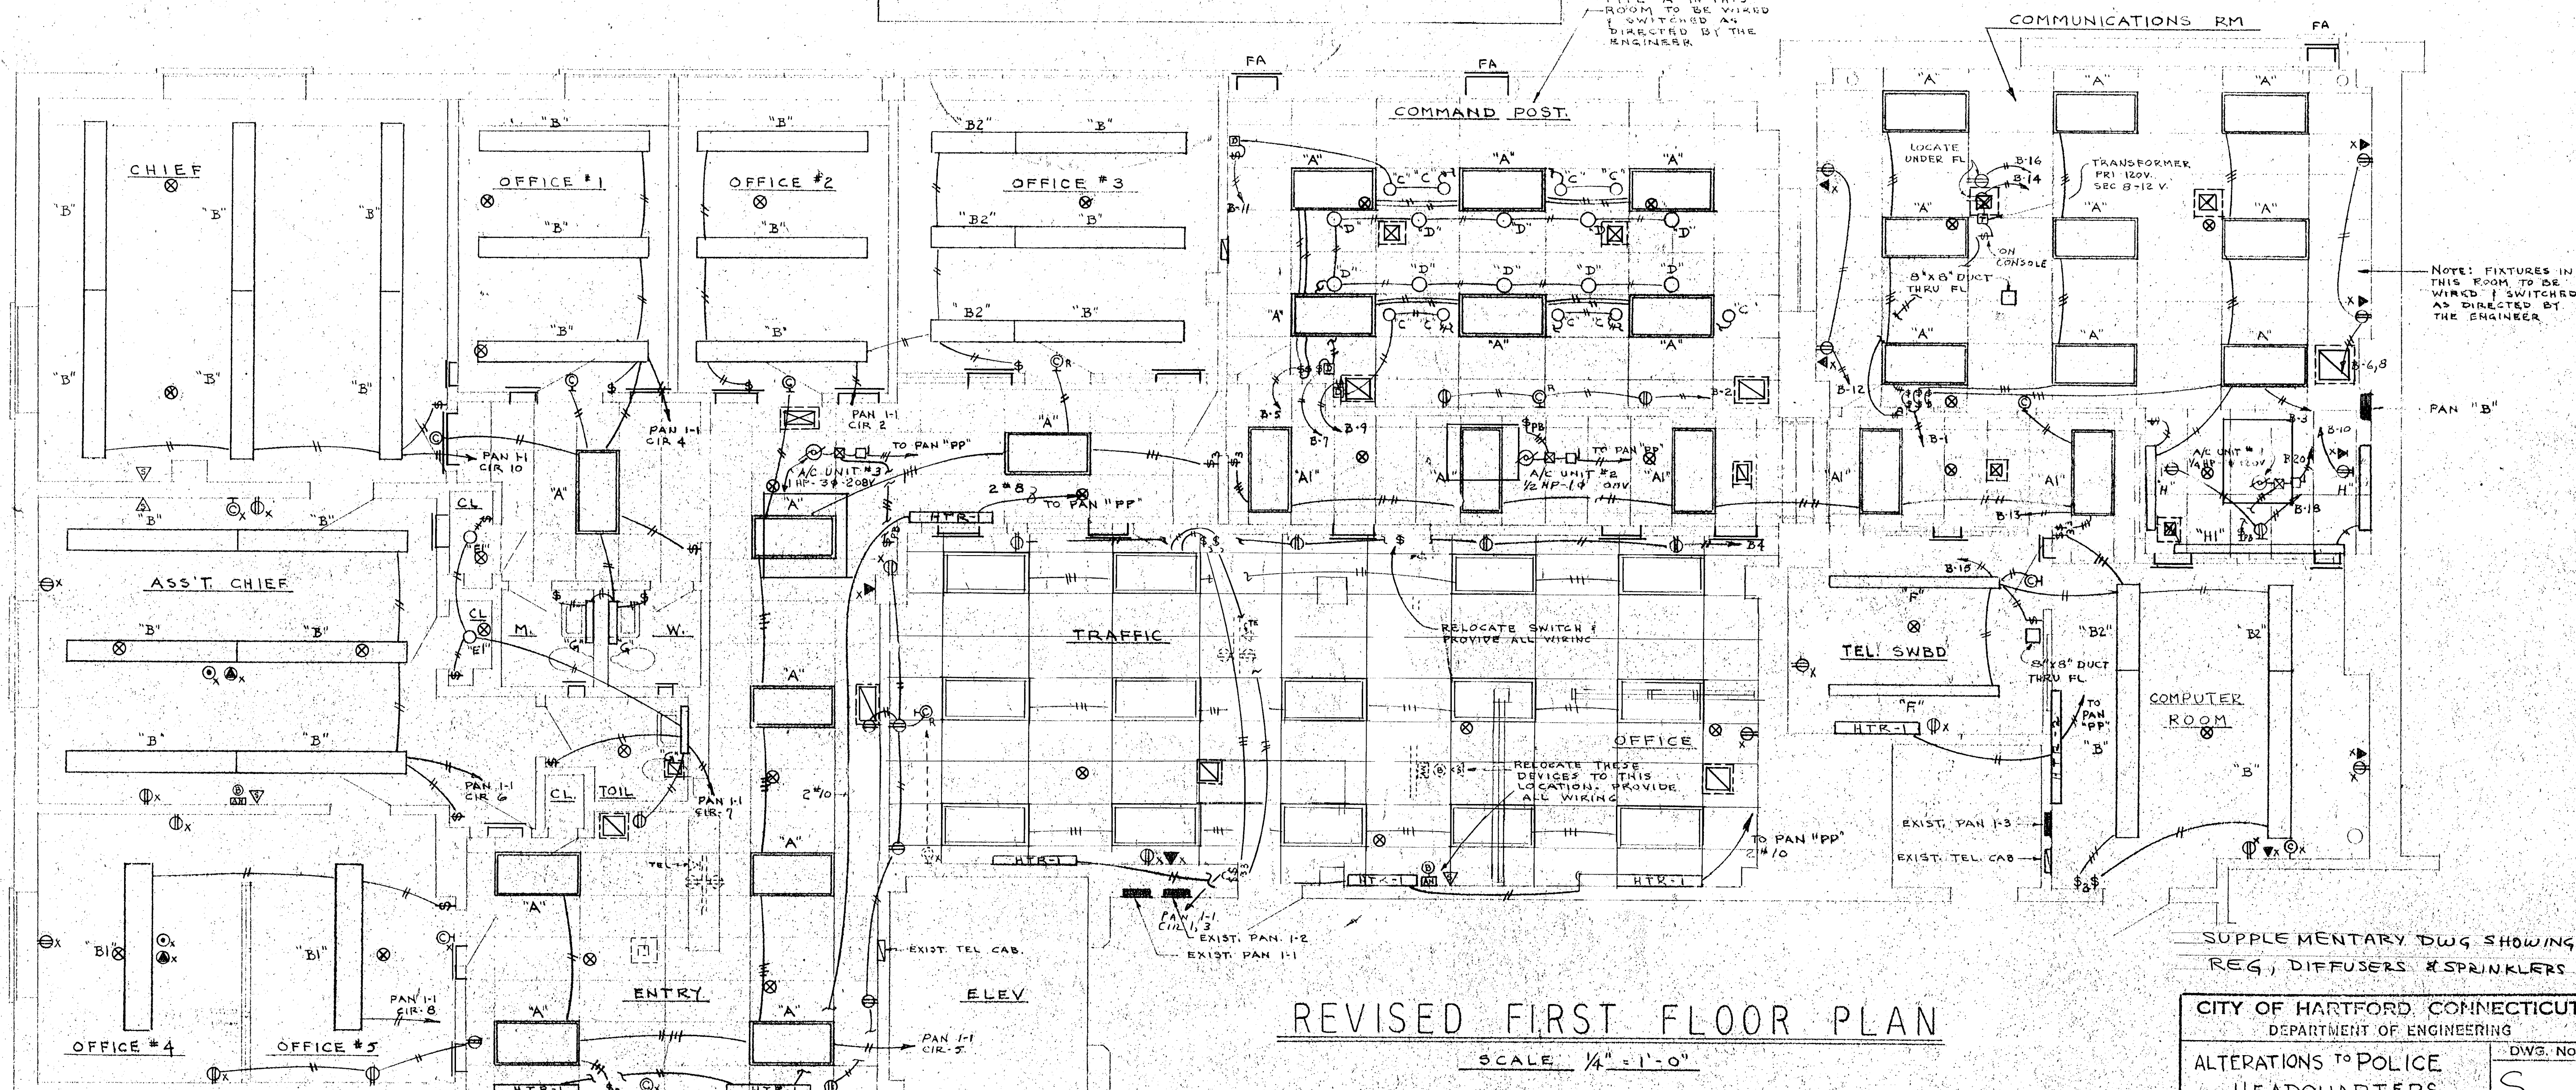

REVISED FIRST FLOOR PLAN
 SCALE 1/4" = 1'-0"

SUPPLEMENTARY DWG. SHOWING REG., DIFFUSERS & SPRINKLERS

CITY OF HARTFORD, CONNECTICUT
 DEPARTMENT OF ENGINEERING

ALTERATIONS TO POLICE HEADQUARTERS
 155 MORGAN STREET
 HARTFORD, CONN.

DESIGNED: [] DRAWN: PDP DAYBOOK NO. 1006287
 CHECKED: [] DATE 6-24-69

APPROVED: [] CITY ARCHITECT [] CITY ENGINEER []

Sup. #1

VERIFY EXISTING CONDITIONS AND DIMENSIONS AT BUILDING

Contract DWG