


FIXTURE SCHEDULE

A - RECESSED - 1 TUBE - LITHONIA #26440A12 -
 A1 - RECESSED - 2 TUBE - LITHONIA #26240A12 -
 X - EXISTING FIXTURES TO REMAIN.
 X1 - EXISTING FIXTURES TO BE RELOCATED.

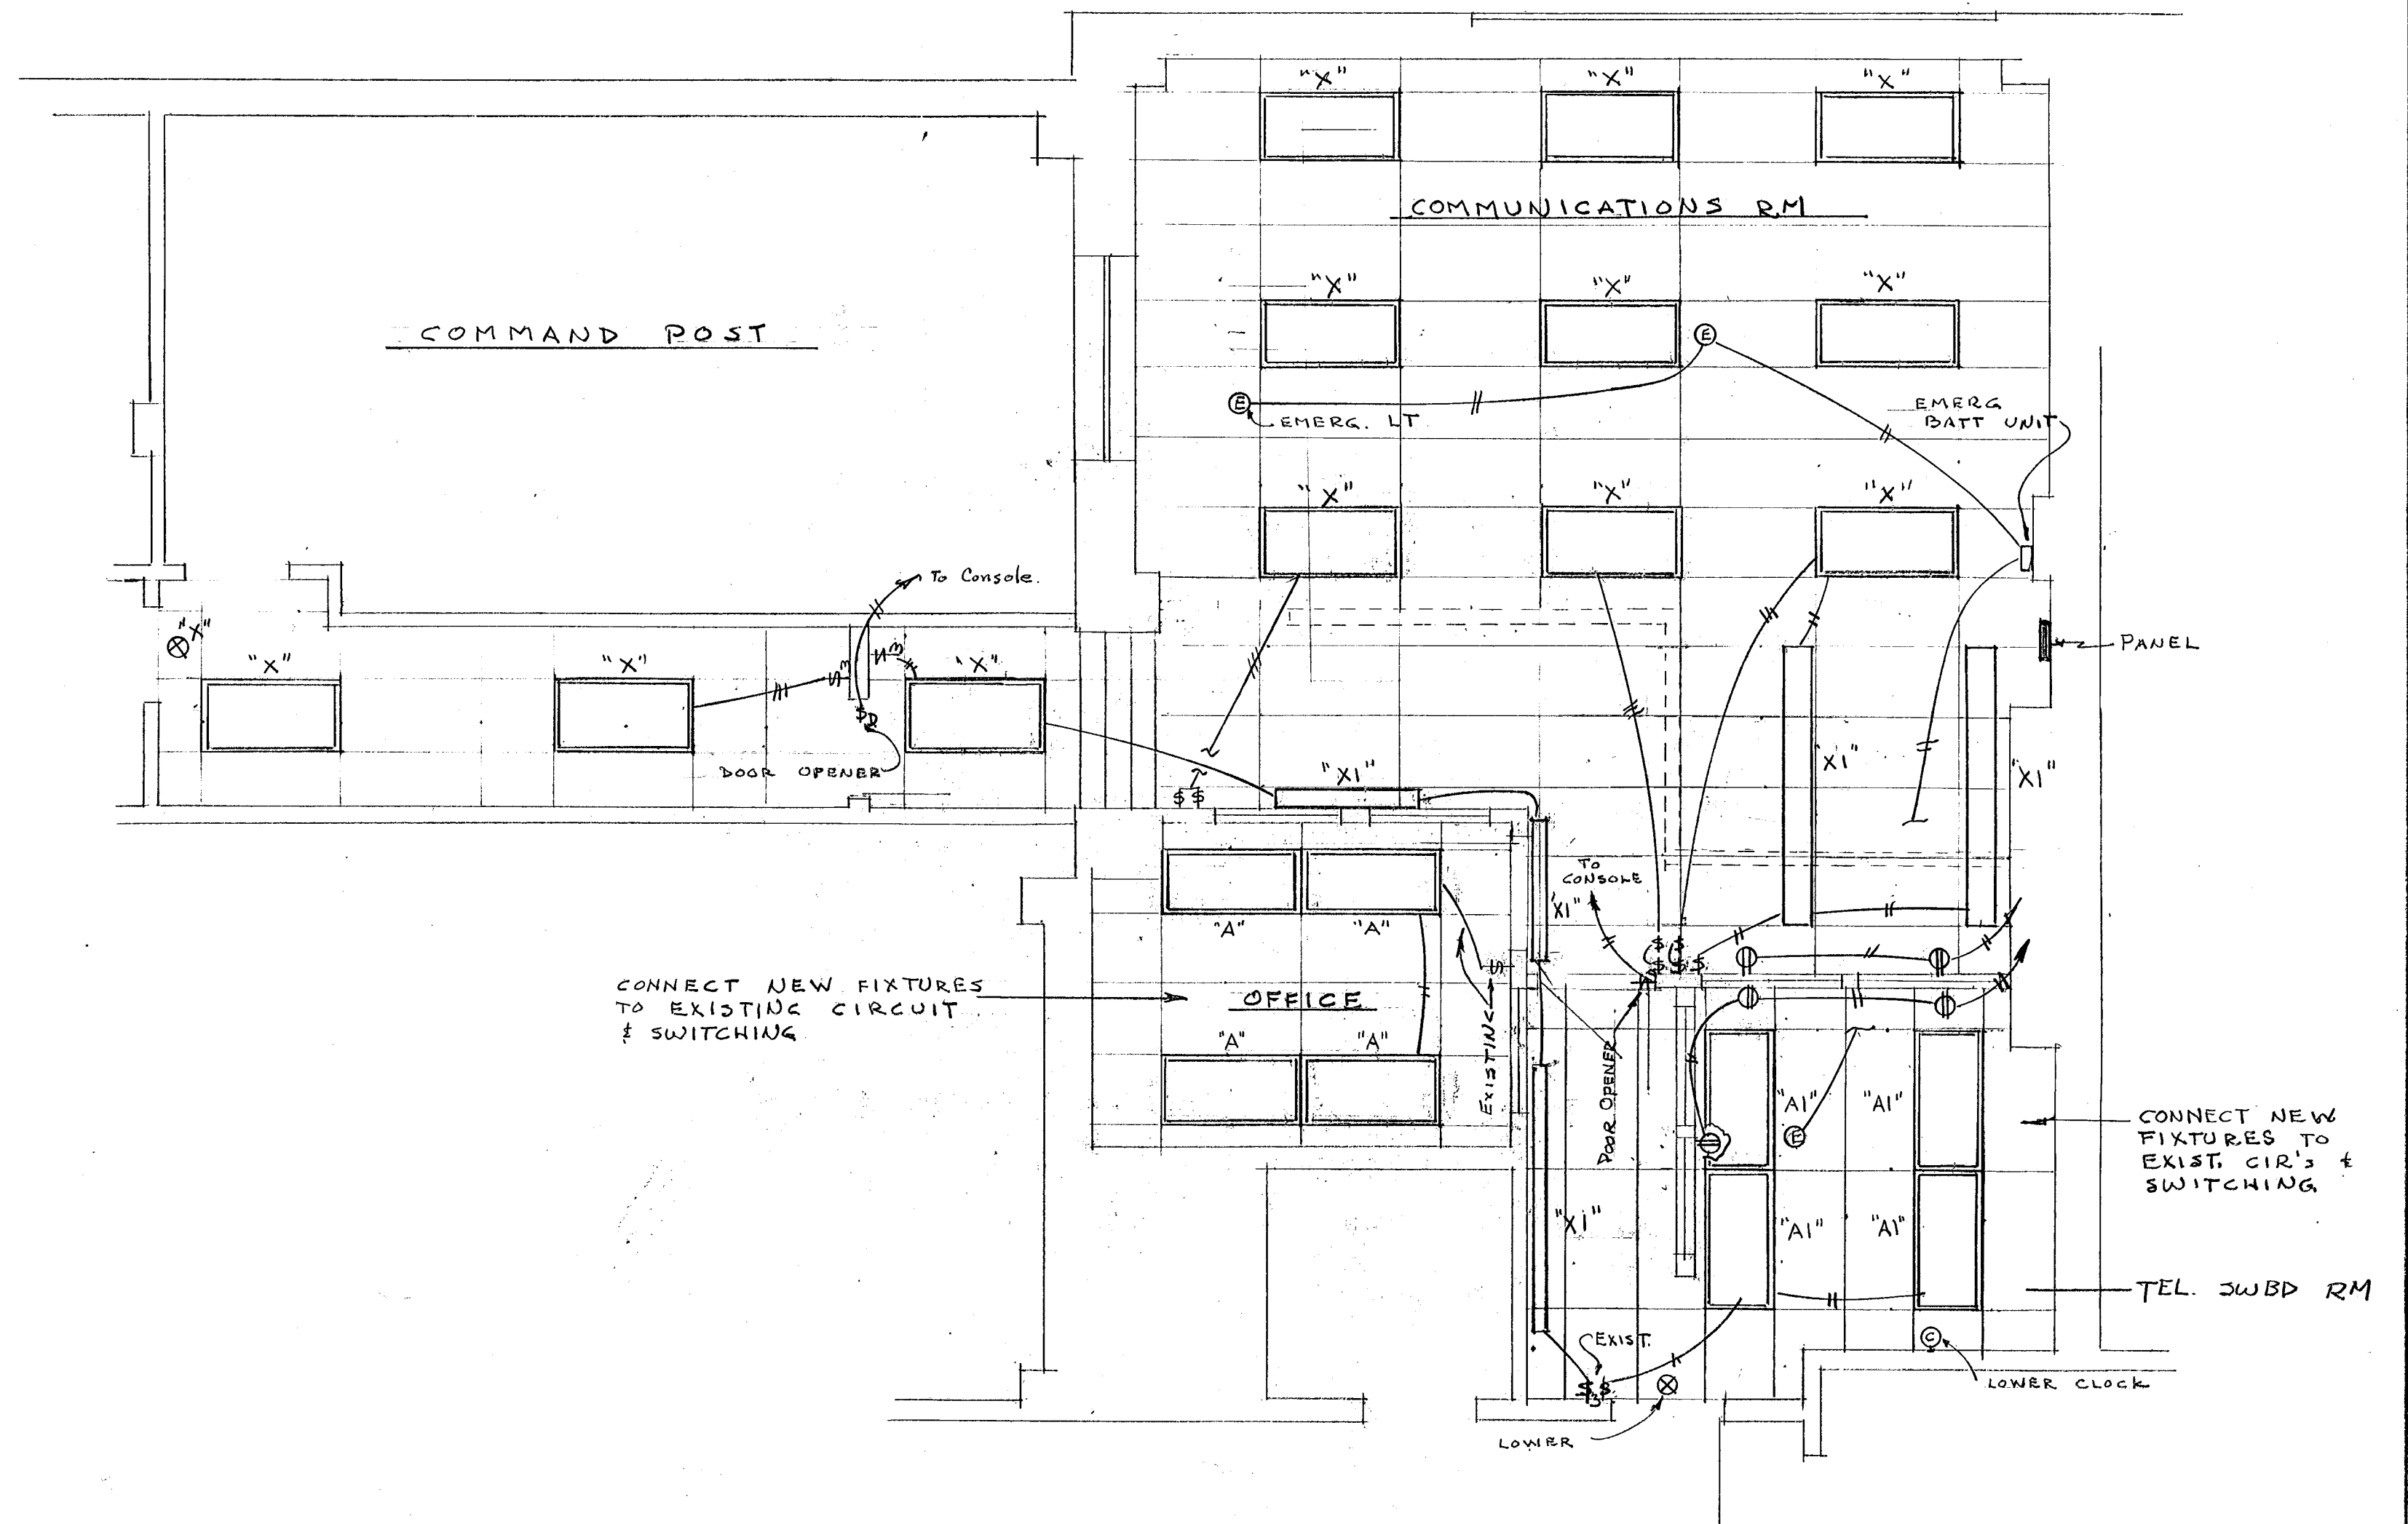

NOTES:

1. REUSE EXISTING SWITCHES IN NEW LOCATIONS
2. IF DOOR OPENERS \$p ARE NOT INSTALLED AT THIS TIME, PROVIDE ALL WIRING FOR FUTURE OPENERS.

FLOOR PLAN

SCALE 1/8" = 1'-0"

ELECTRICAL			
CITY OF HARTFORD, CONNECTICUT			
DEPARTMENT OF PUBLIC WORKS			
BUREAU OF PUBLIC BUILDINGS			
ALTERATION TO POLICE HEADQUARTERS HARTFORD CONN.			DWG NO. E-1
SUBMITTED <i>R.G. Bannon</i>	DESIGNED [Signature]	APPROVED [Signature]	ASST. DIR. CITY ENG.
DRAWN <i>R.G.B.</i>	SCALE	DAYBOOK NO. 10062-J	
CHECKED		DATE	JUNE 24, 1973