



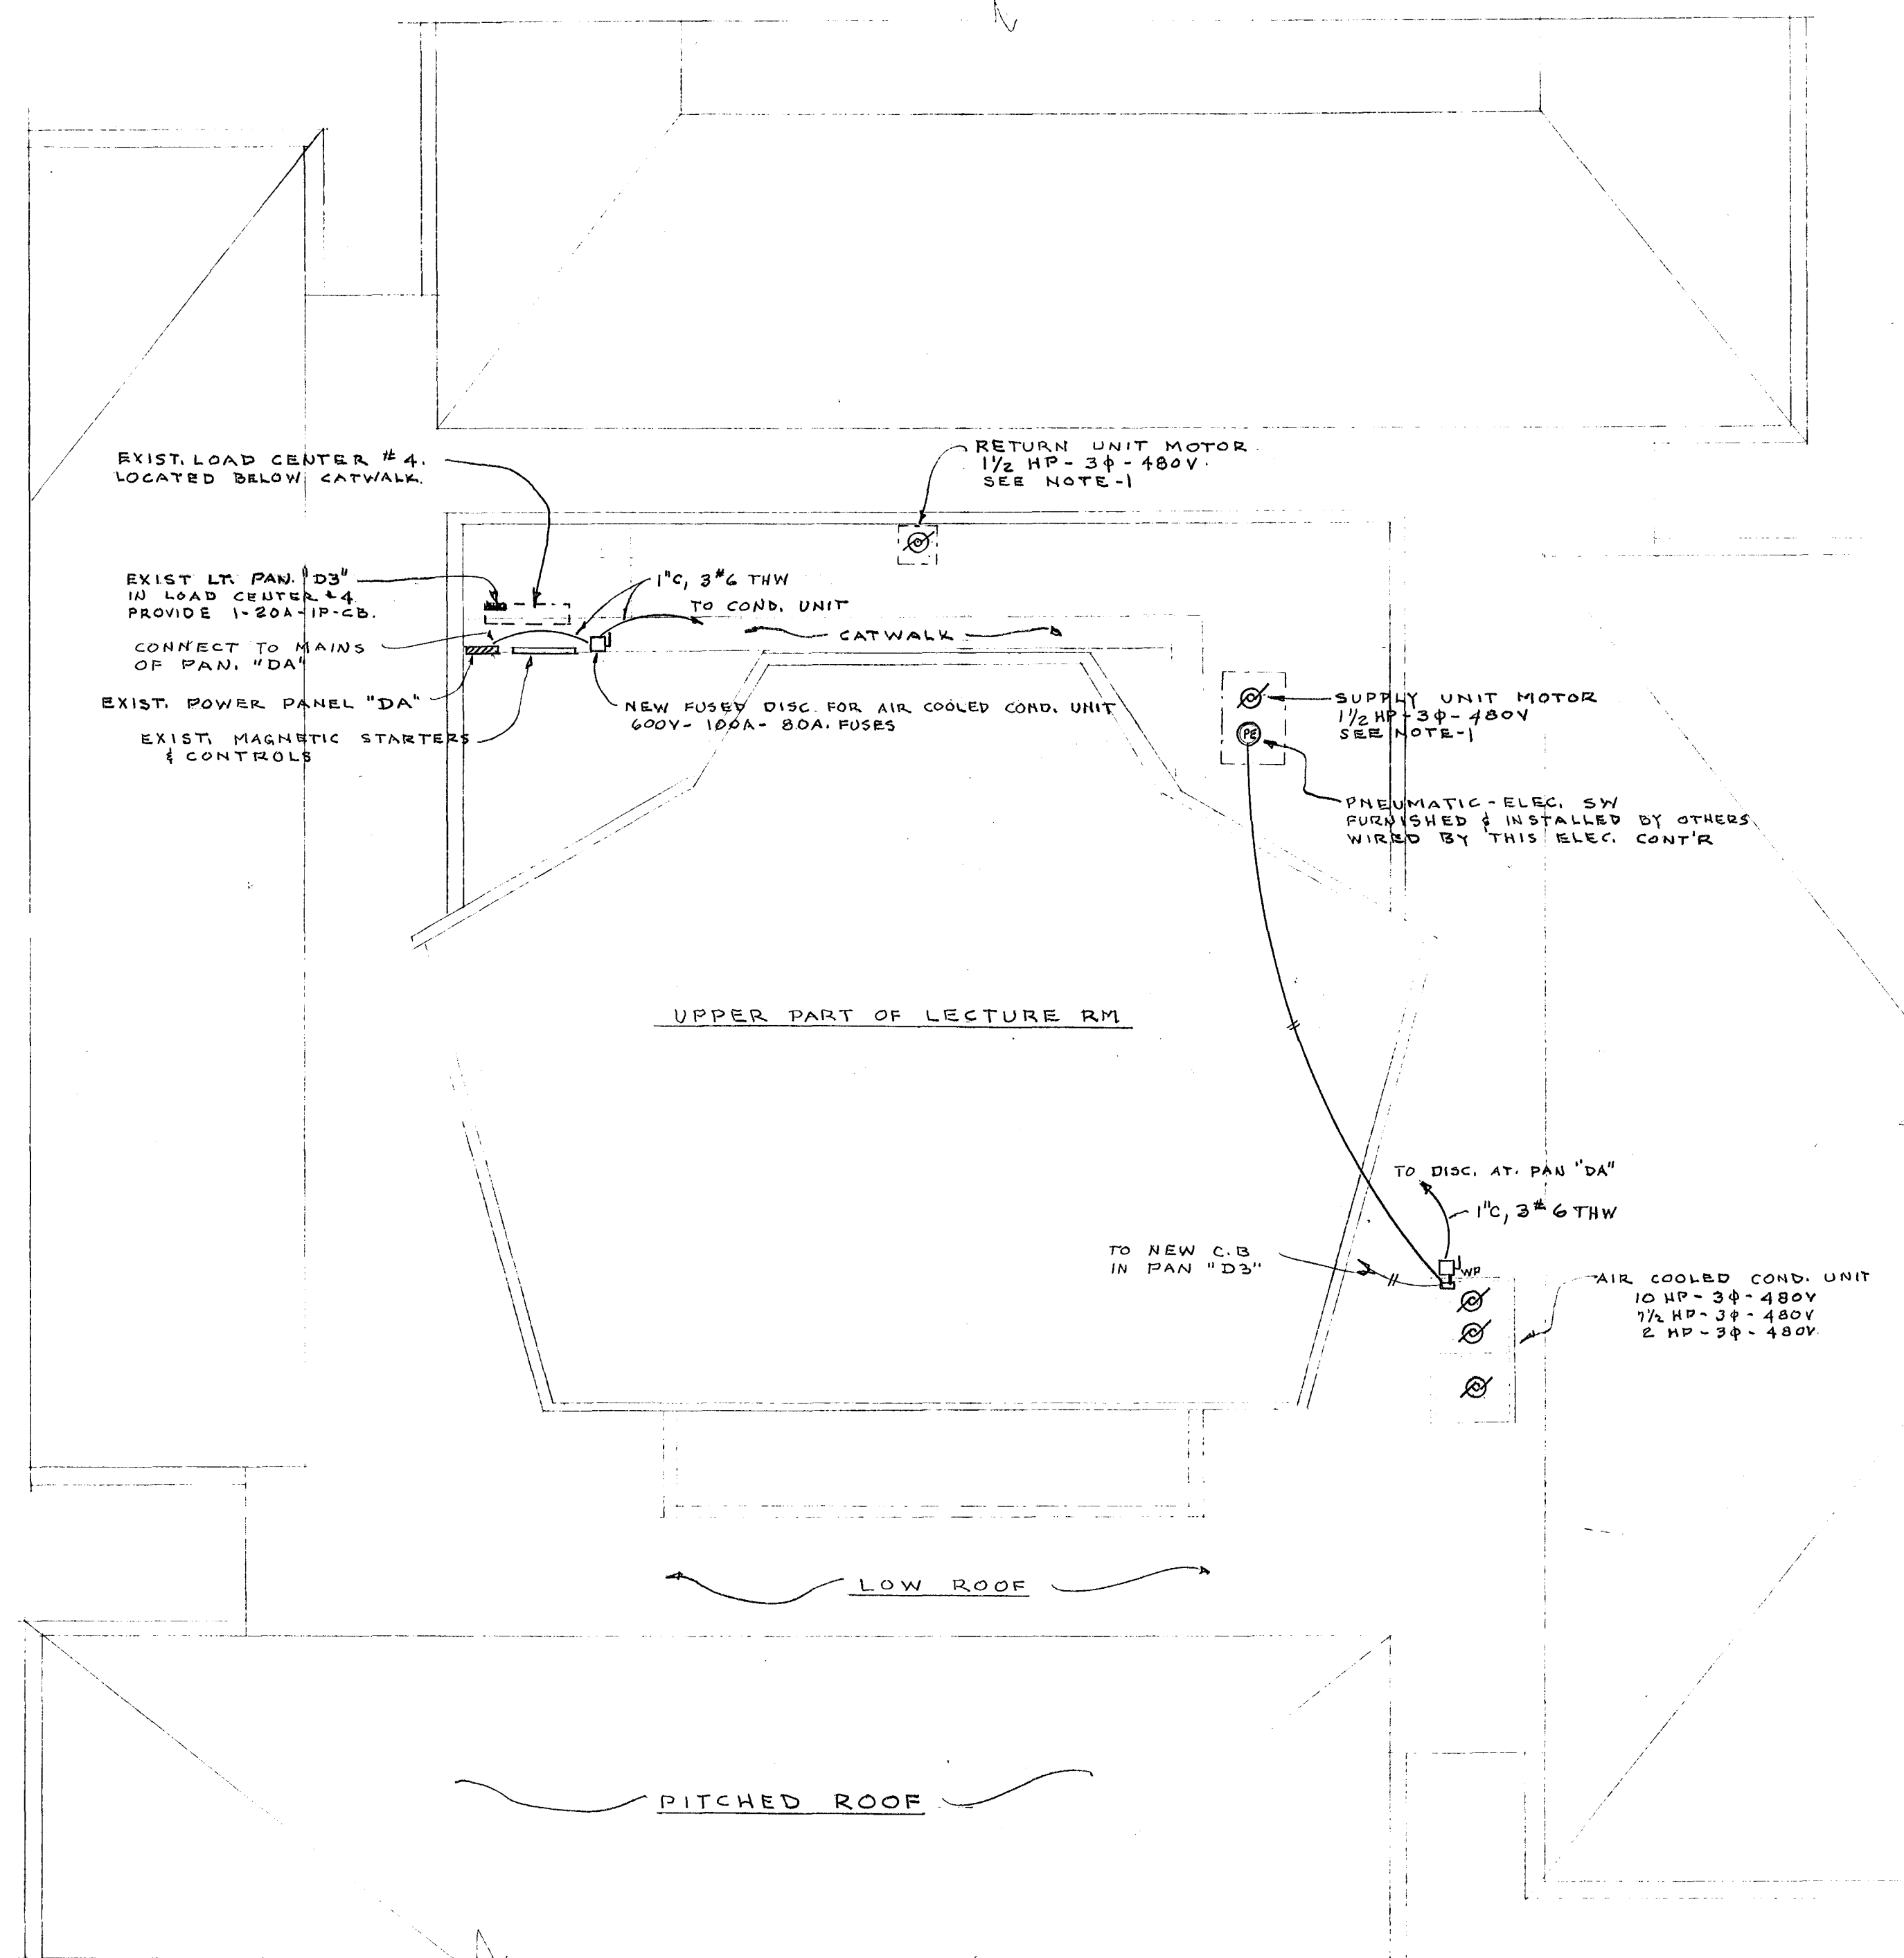

- NOTE-1: THIS MOTOR REPLACES A SMALLER MOTOR. THIS ELEC. CONTR. SHALL DISCONNECT WIRING FROM EXISTING MOTOR, SHALL CONNECT UP NEW MOTOR USING EXISTING WIRING WHERE POSSIBLE, AND SHALL PROVIDE IN EXISTING MAGNET STARTER NEW HEATERS OF PROPER RATING FOR THE NEW MOTOR.
2. WHERE CONDUITS PASS THROUGH OUTSIDE WALLS PROVIDE SLEEVES AND CAULKING FOR A RAIN-TIGHT INSTALLATION.

ELECTRICAL PLAN - UNIT "D" ROOF & LECTURE ROOM.
SCALE 1/8" = 1'-0"

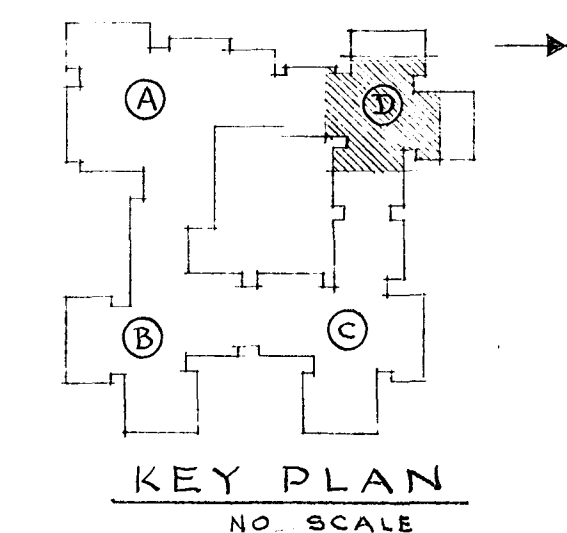

VERIFY EXISTING
CONDITIONS AND
DIMENSIONS AT
BUILDING

CITY OF HARTFORD, CONNECTICUT DEPARTMENT OF ENGINEERING		
AIR CONDITIONING FOR LECTURE ROOM BUILDING "D" ANNIE FISHER ELEM. SCHOOL PLAINFIELD ST. HARTFORD, CONN.		DWG. No. 121
SUBMITTED CITY ARCHITECT <i>R. G. B.</i>	RECOMMENDED CITY ARCHITECT <i>George E. Heppner</i>	APPROVED CITY ENGINEER <i>George E. Heppner</i>
DESIGN R.G.B.	DRAWN R.G.B.	DAYBOOK No. 010099B
TRACED	CHECK	DATE MAY 23, 1969