

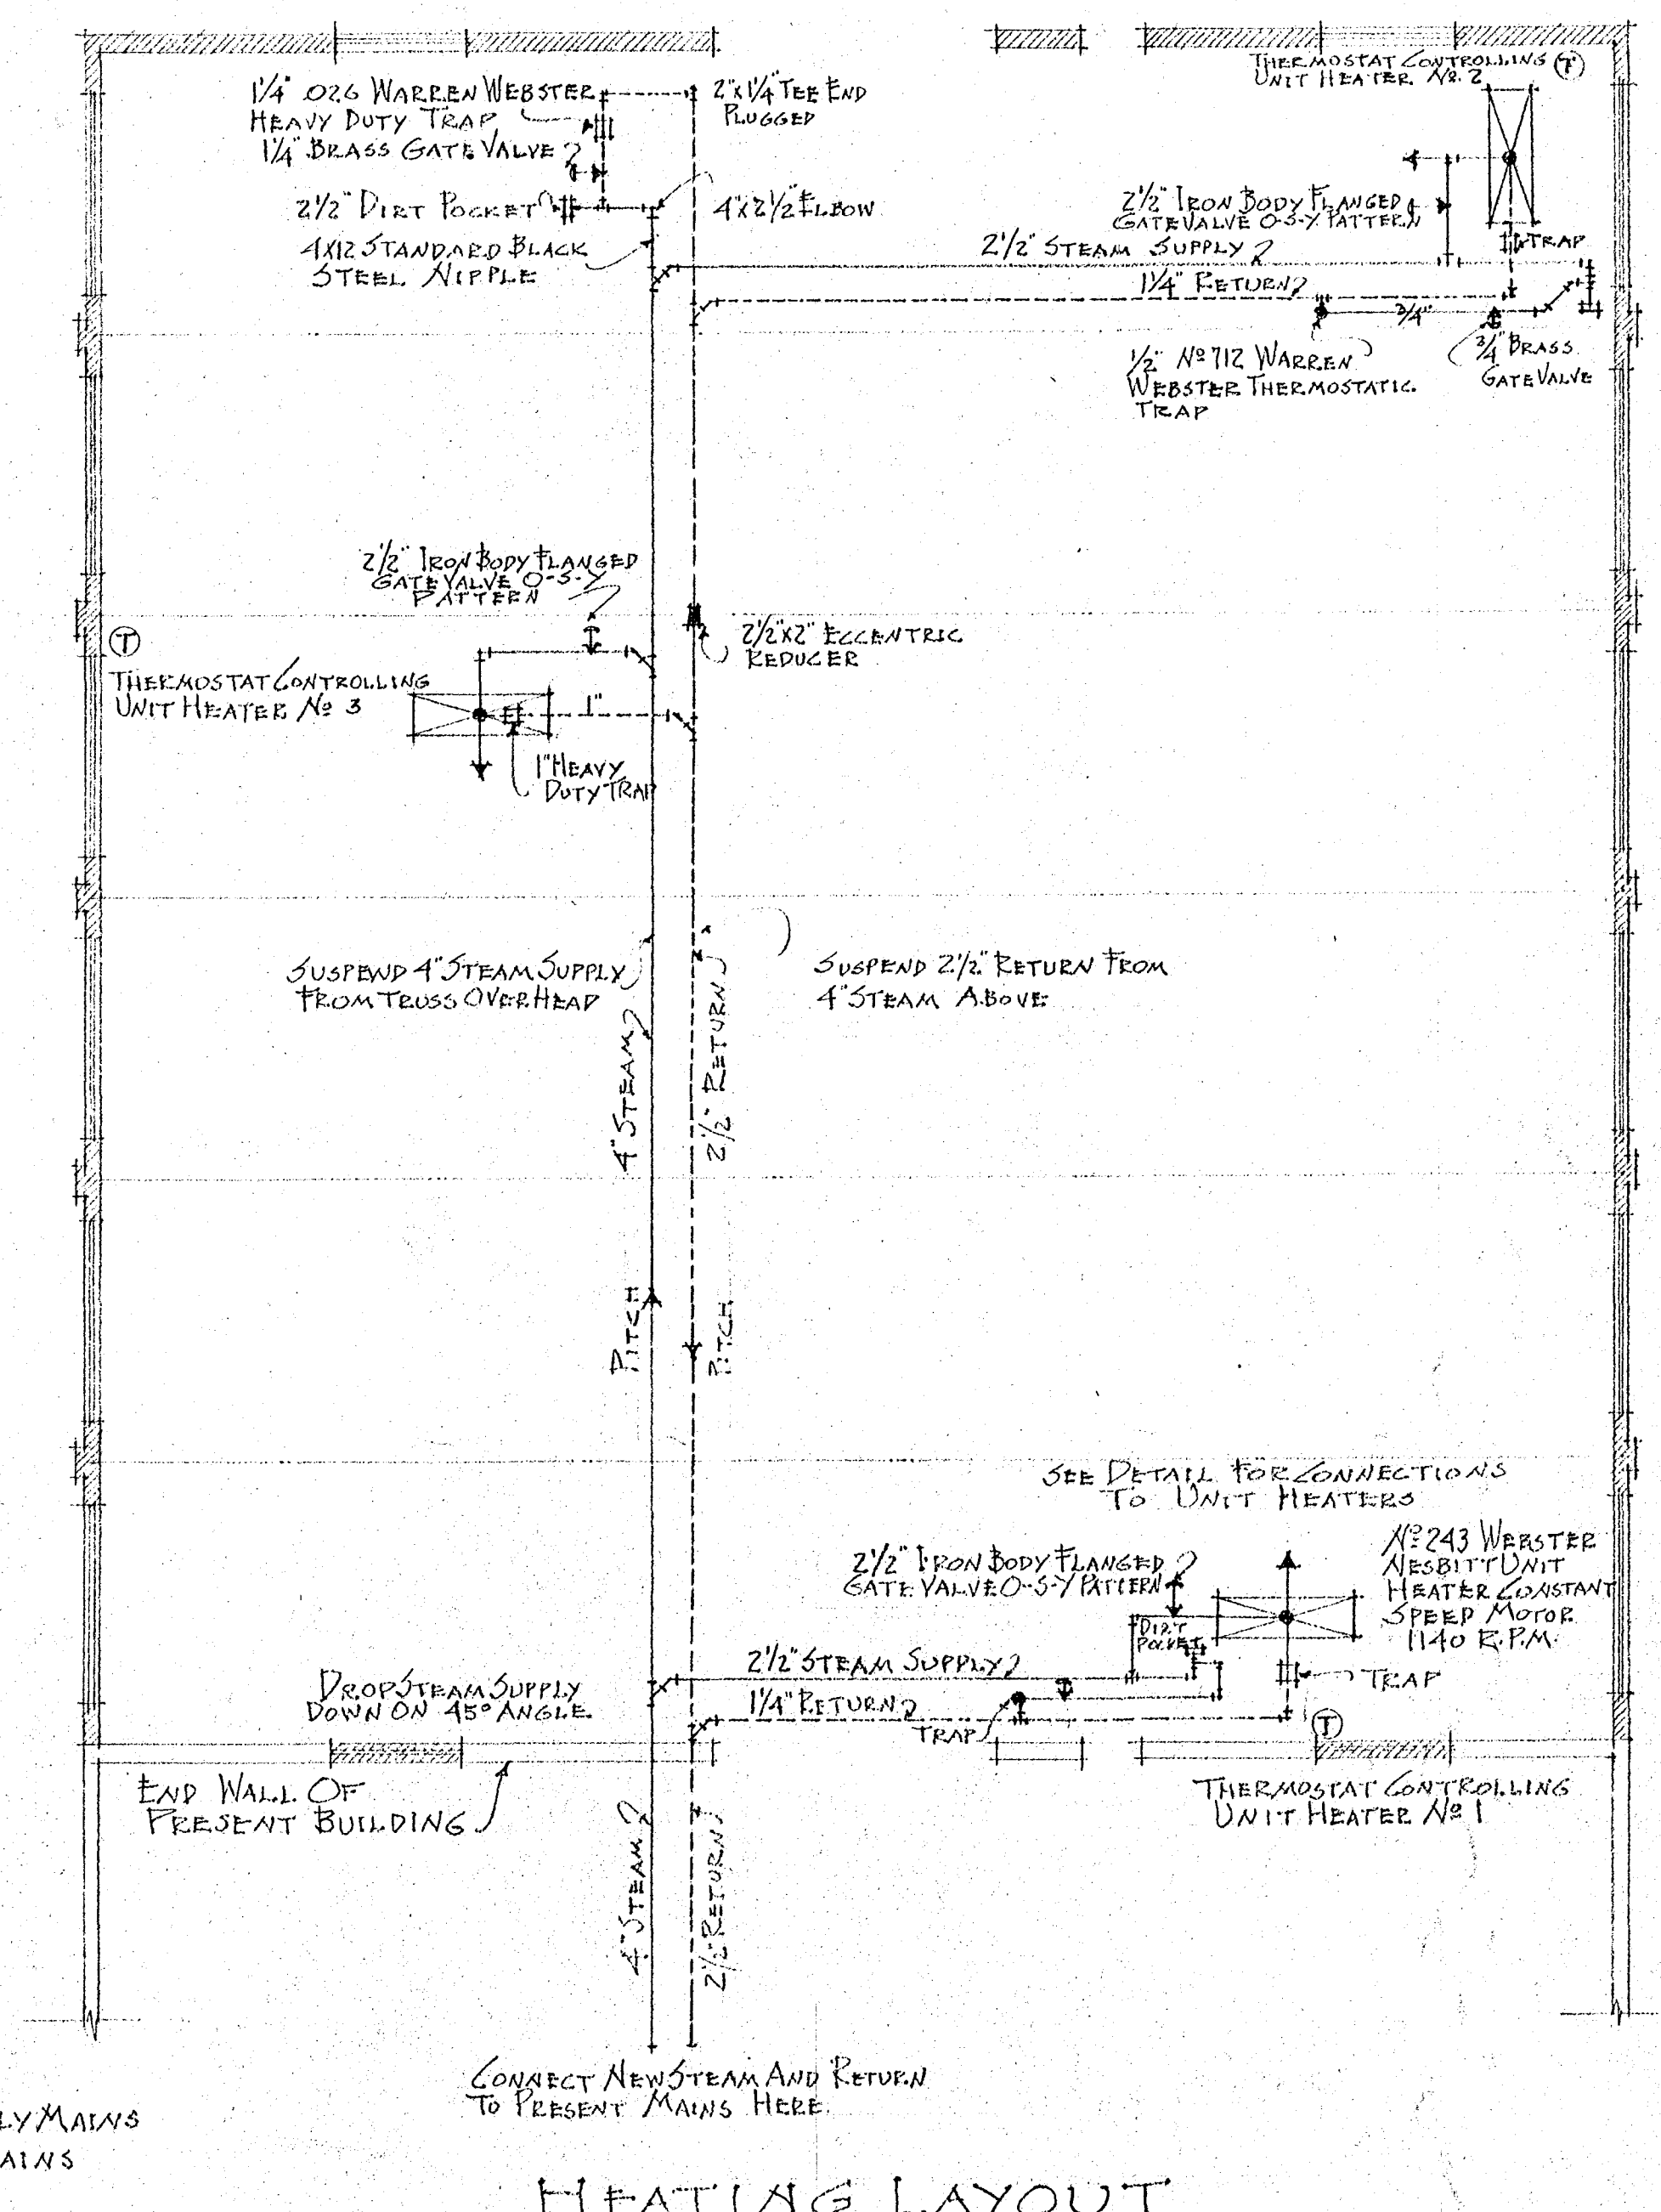


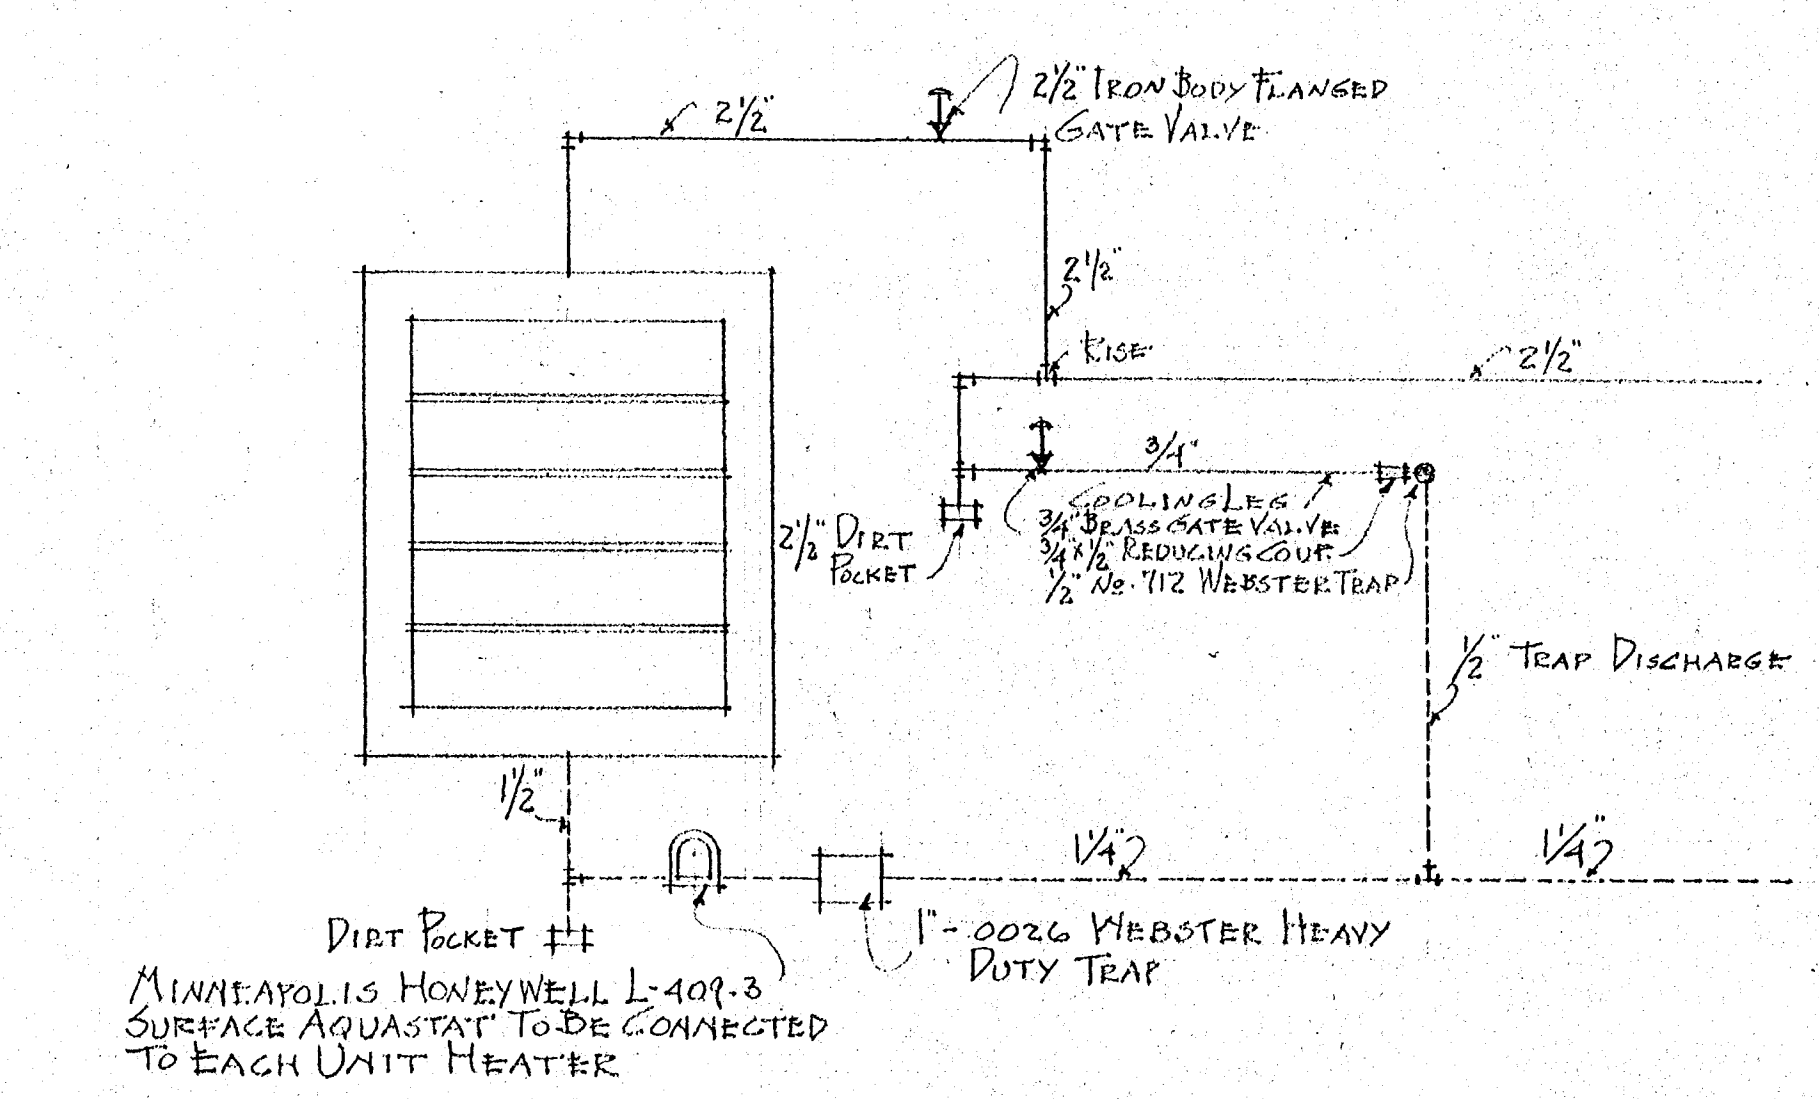

HEATING LAYOUT

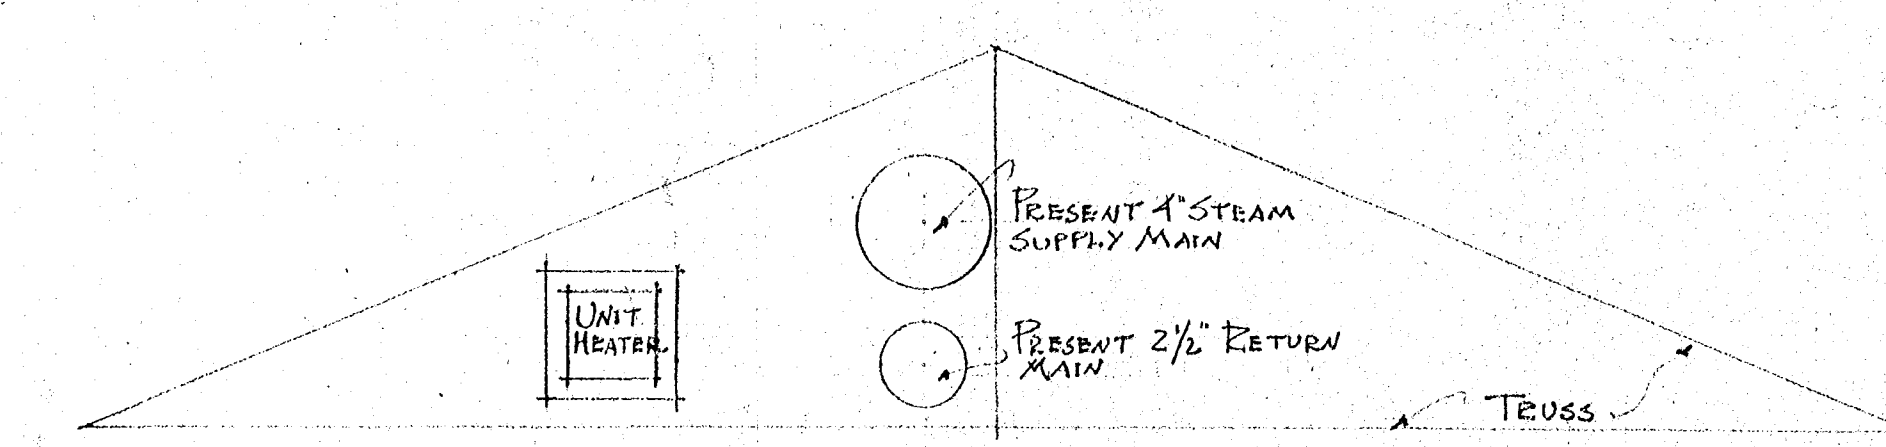

DETAIL OF PIPING CONNECTIONS
TO UNIT HEATERS NUMBER ONE AND TWO

CITY OF HARTFORD ARCHITECTURAL BUREAU THOMAS F. FOLEY - DIRECTOR		
DRAWN BY D.A.G.	TITLE: FIREPROOF ADDITION TO PRESENT GARAGE STREET DEPARTMENT CITY OF HARTFORD 1899 VAN BURE AVENUE	JOB No. M-325
CHECKED BY E.A.P.		SHEET No. 3
APPROVED BY F.W.W.		SCALE 1/4" = 1'-0"
DATE MAR. 7-1930	FRANK W. WHITON SUPERVISING ARCHITECT	