


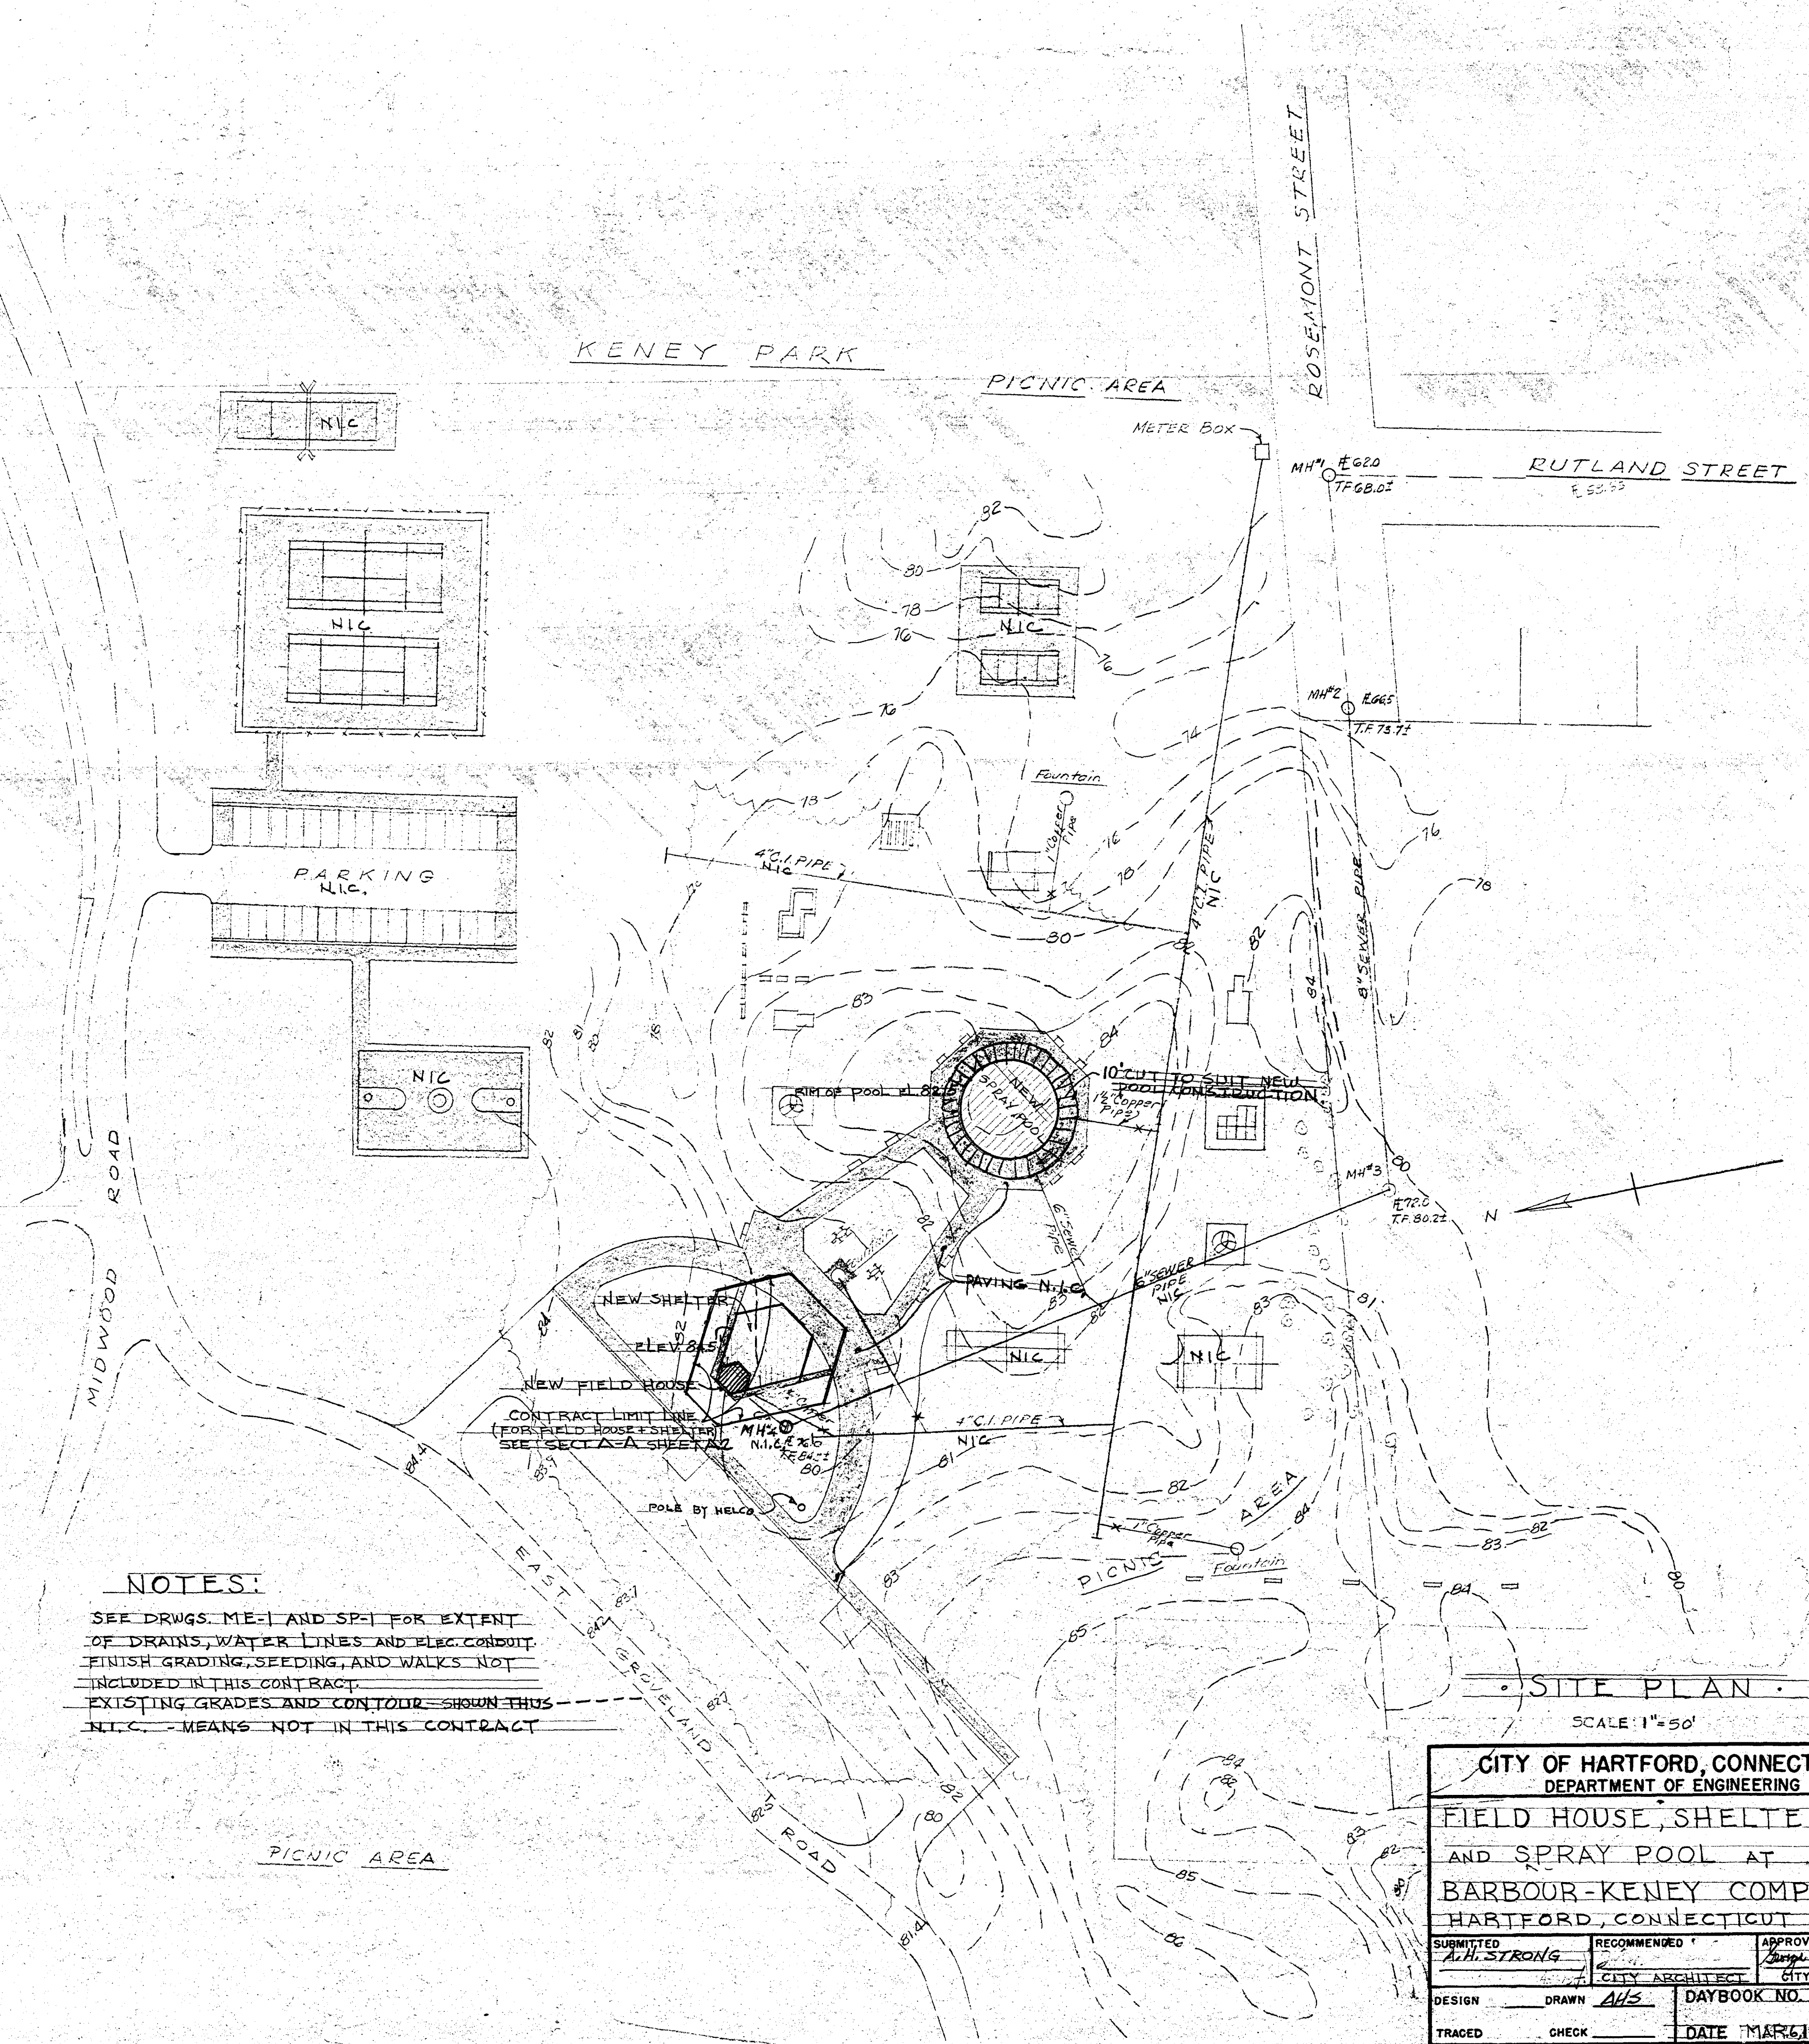

NOTES:
SEE DRGS. ME-1 AND SP-1 FOR EXTENT
OF DRAINS, WATER LINES AND ELEC. CONDUIT.
FINISH GRADING, SEEDING, AND WALKS NOT
INCLUDED IN THIS CONTRACT.
EXISTING GRADES AND CONTOUR SHOWN THUS
N.I.C. MEANS NOT IN THIS CONTRACT

SITE PLAN
SCALE: 1" = 50'

CITY OF HARTFORD, CONNECTICUT DEPARTMENT OF ENGINEERING		
FIELD HOUSE, SHELTER, AND SPRAY POOL AT BARBOUR-KENEY COMPLEX HARTFORD, CONNECTICUT		
SUBMITTED A.H. STRONG	RECOMMENDED CITY ARCHITECT	APPROVED CITY ENGINEER
DESIGN AHS	DRAWN AHS	DAYBOOK NO. 610153-A
TRACED	CHECK	DATE MAR 6 1970

CLARENCE A. BARBOUR SCHOOL GROUNDS