



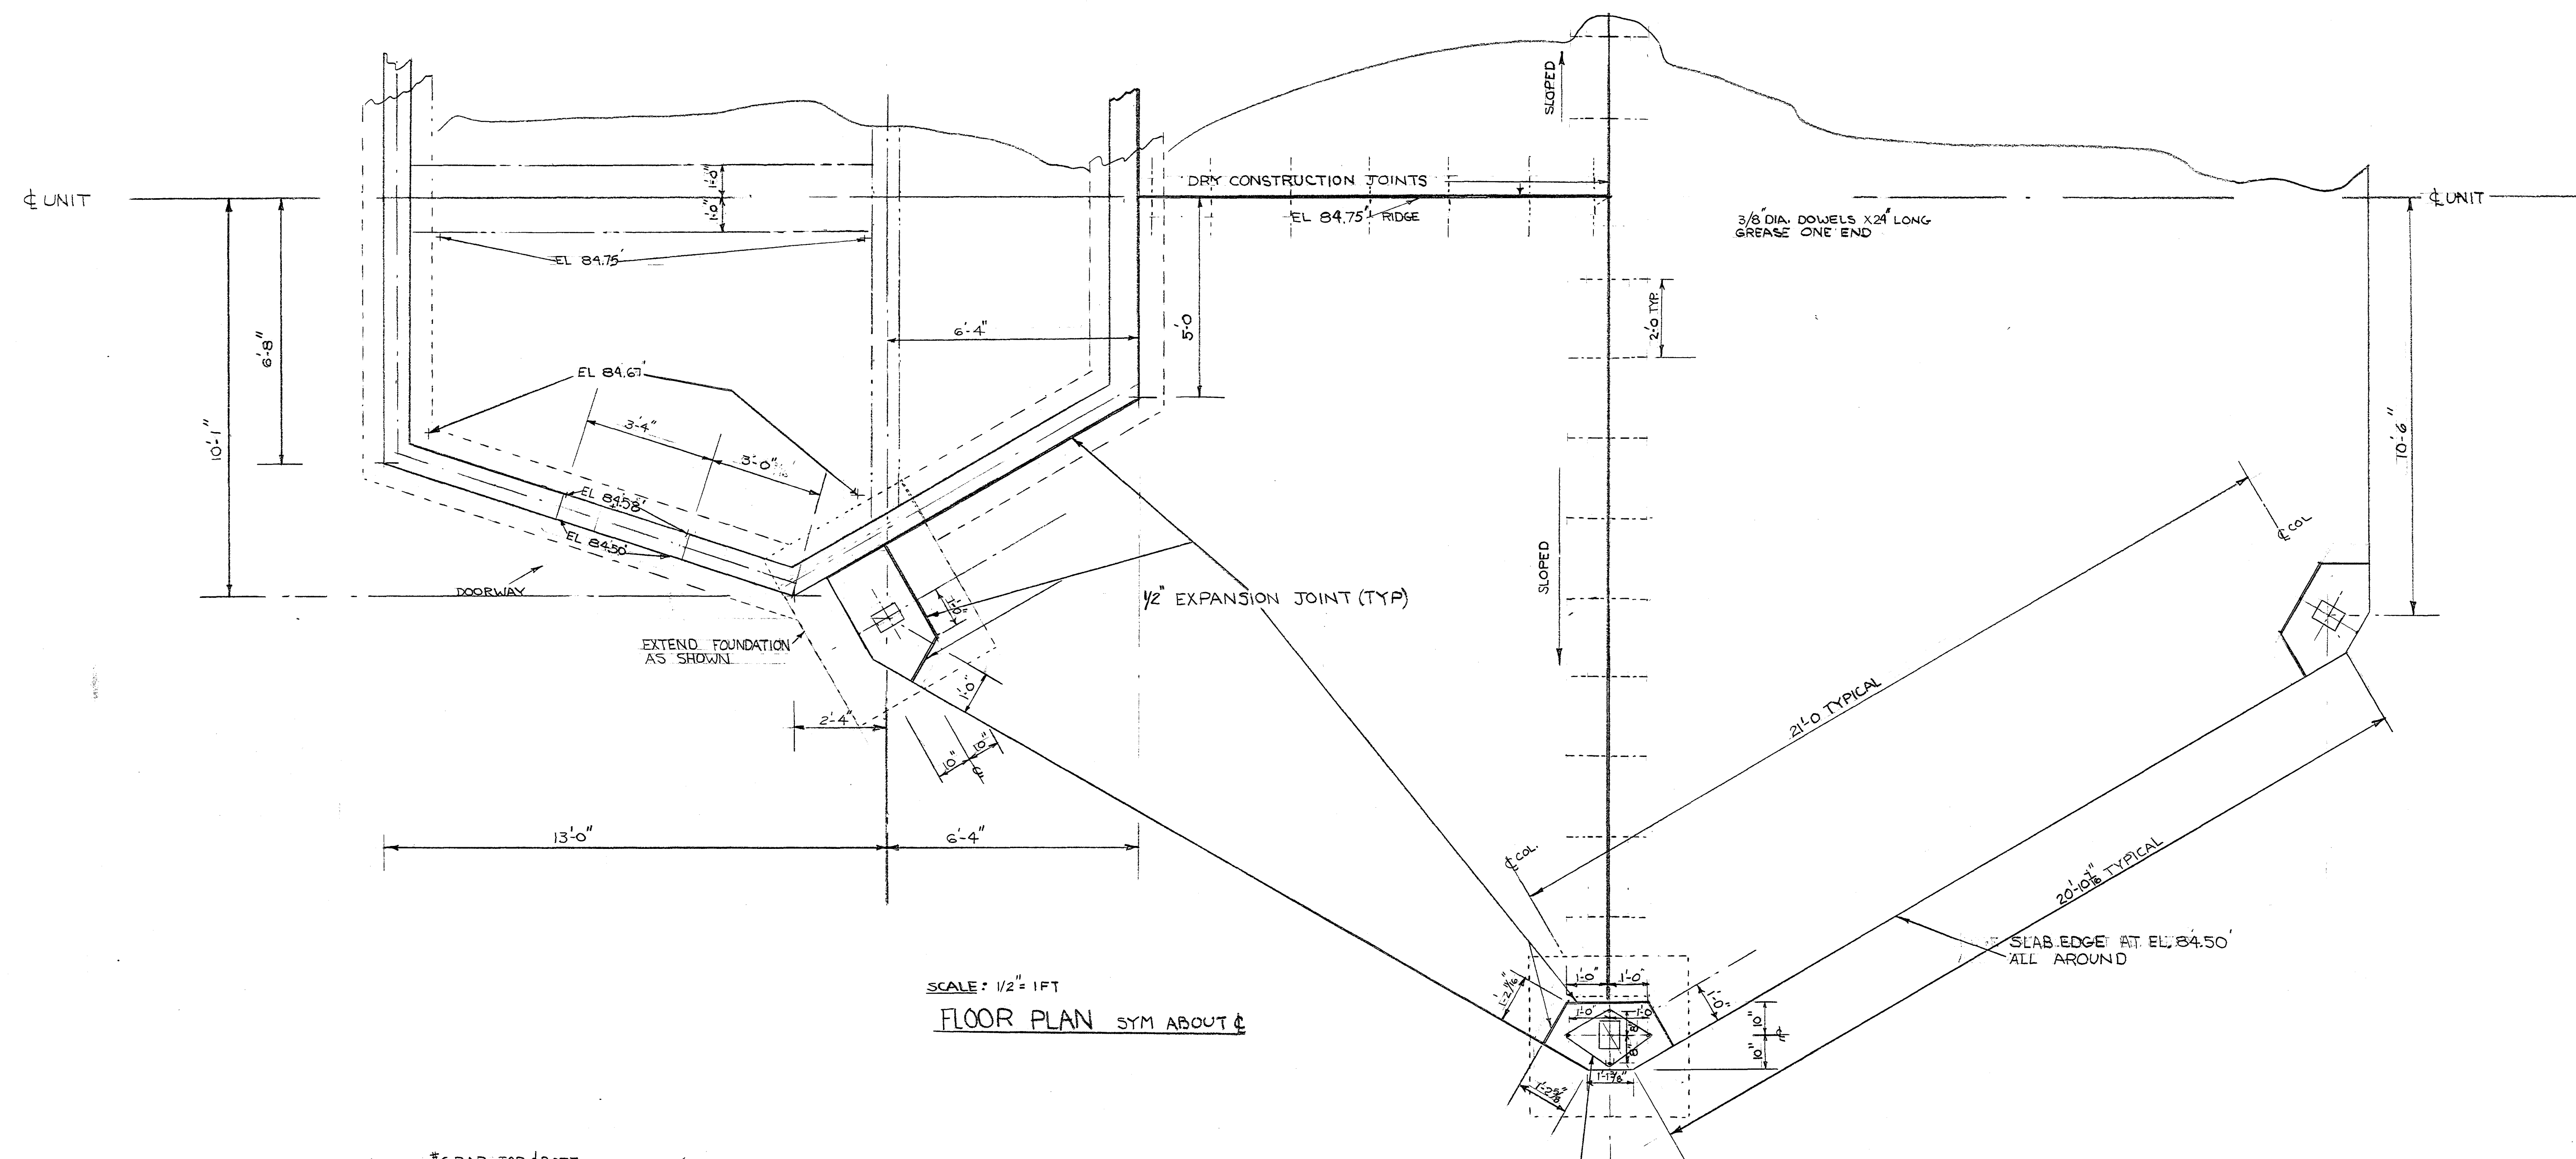

SCALE: 1/2" = 1 FT
FLOOR PLAN SYM ABOUT C

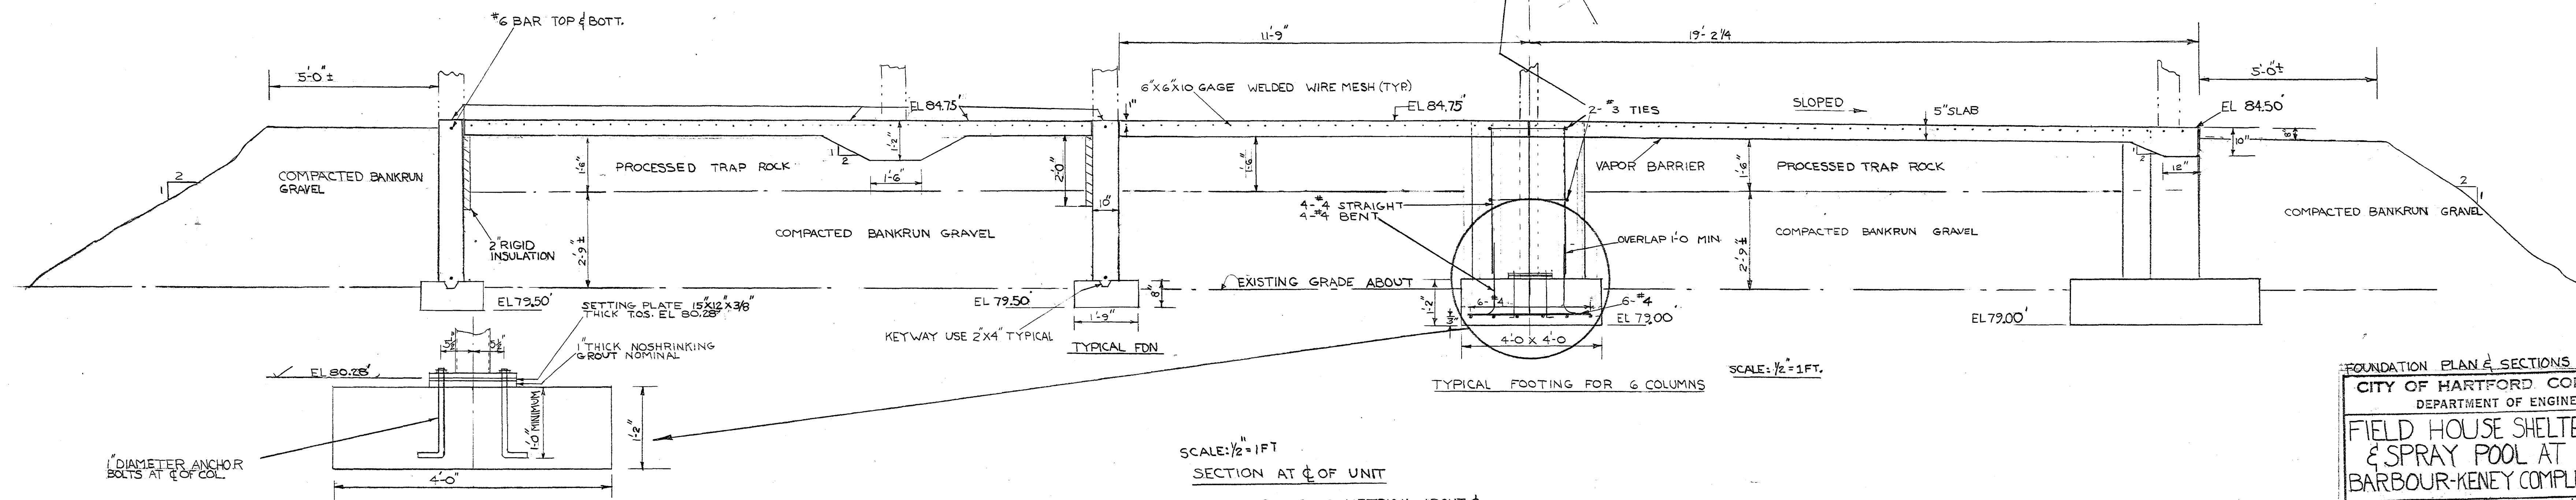

SCALE: 1/2" = 1 FT
SECTION AT C OF UNIT
STRUCTURE IS SYMMETRICAL ABOUT C

FOUNDATION PLAN & SECTIONS		
CITY OF HARTFORD, CONNECTICUT DEPARTMENT OF ENGINEERING		
FIELD HOUSE SHELTER & SPRAY POOL AT BARBOUR-KENEY COMPLEX		DWG. No. S-2
SUBMITTED <i>Paul B. Anthony</i>	RECOMMENDED <i>George C. Hopper</i>	APPROVED <i>George C. Hopper</i>
DESIGN PDA	DRAWN PDA	DAYBOOK No. 010153E
TRACED	CHECK	DATE MARCH 6, 1970