

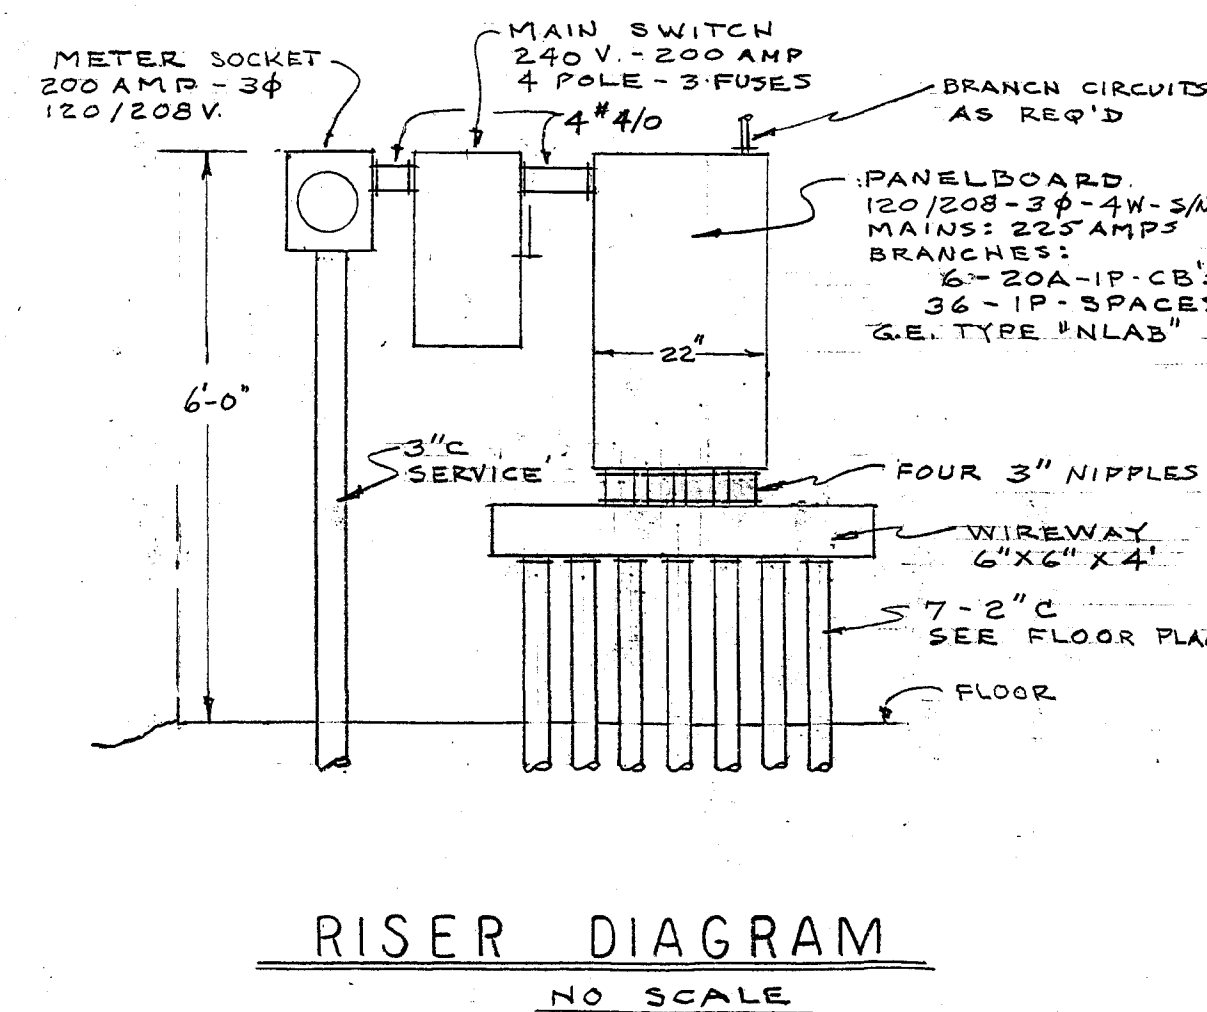
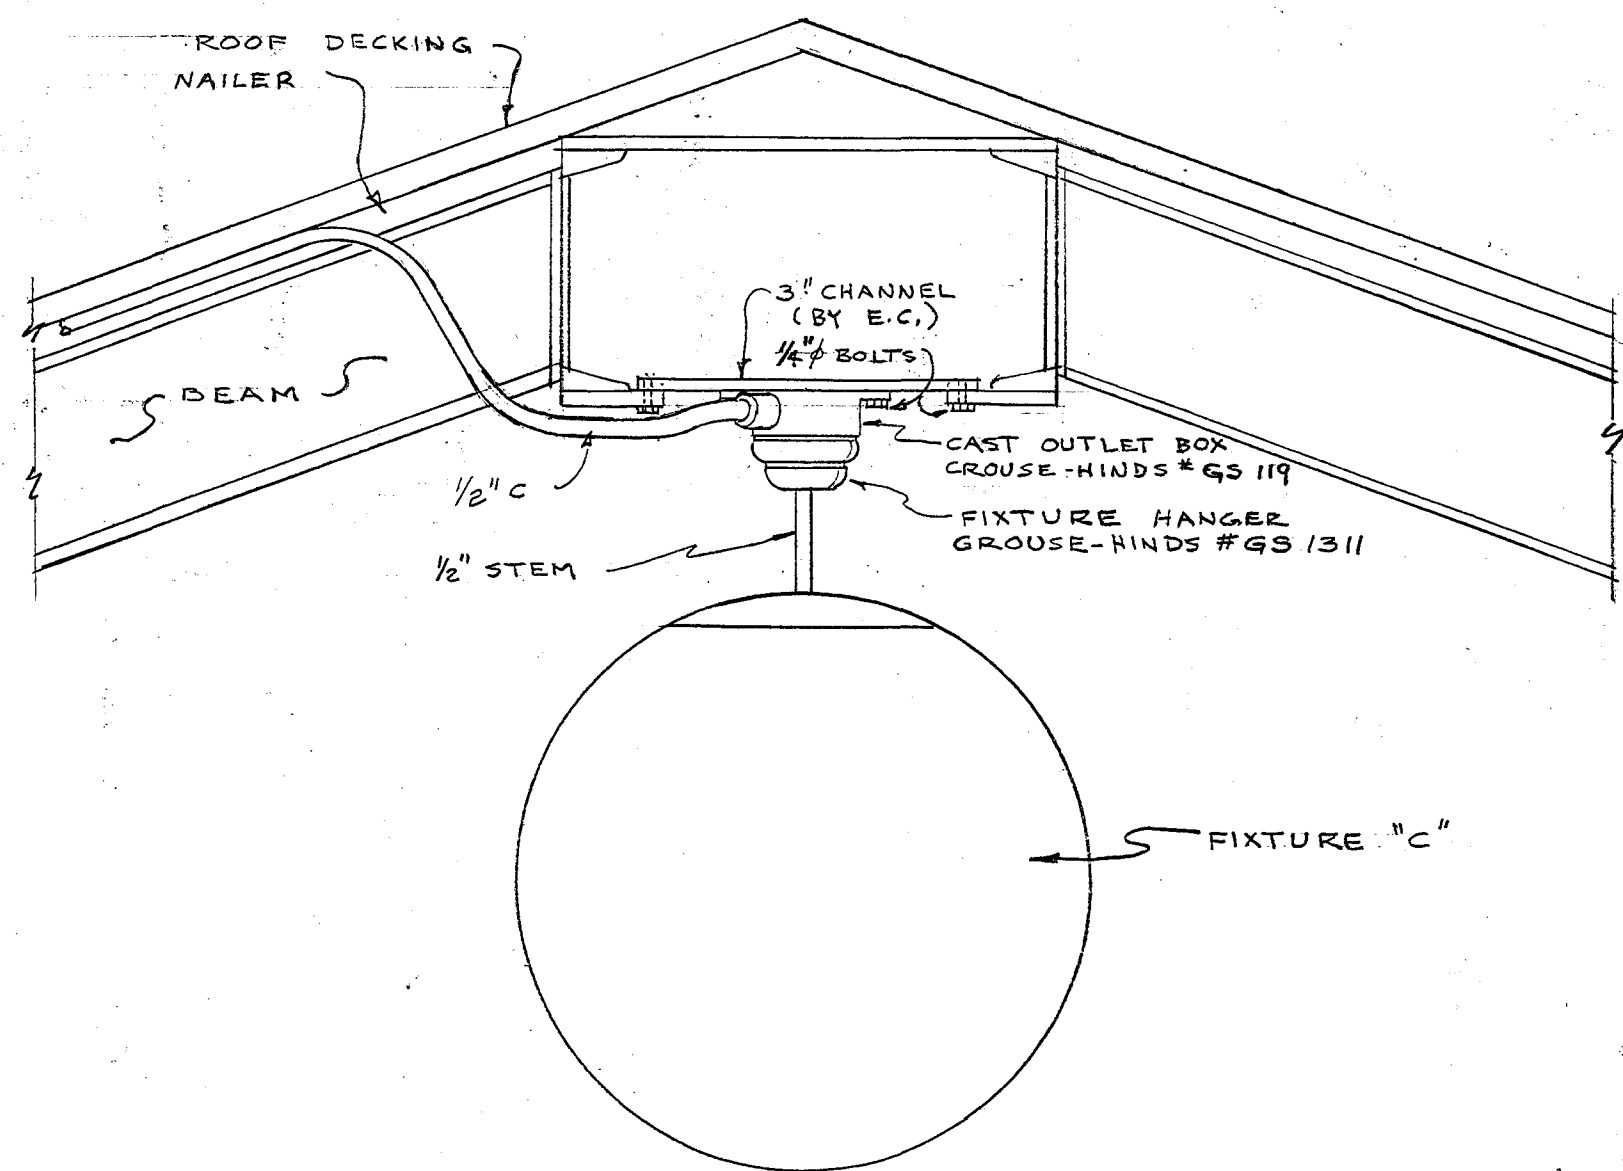
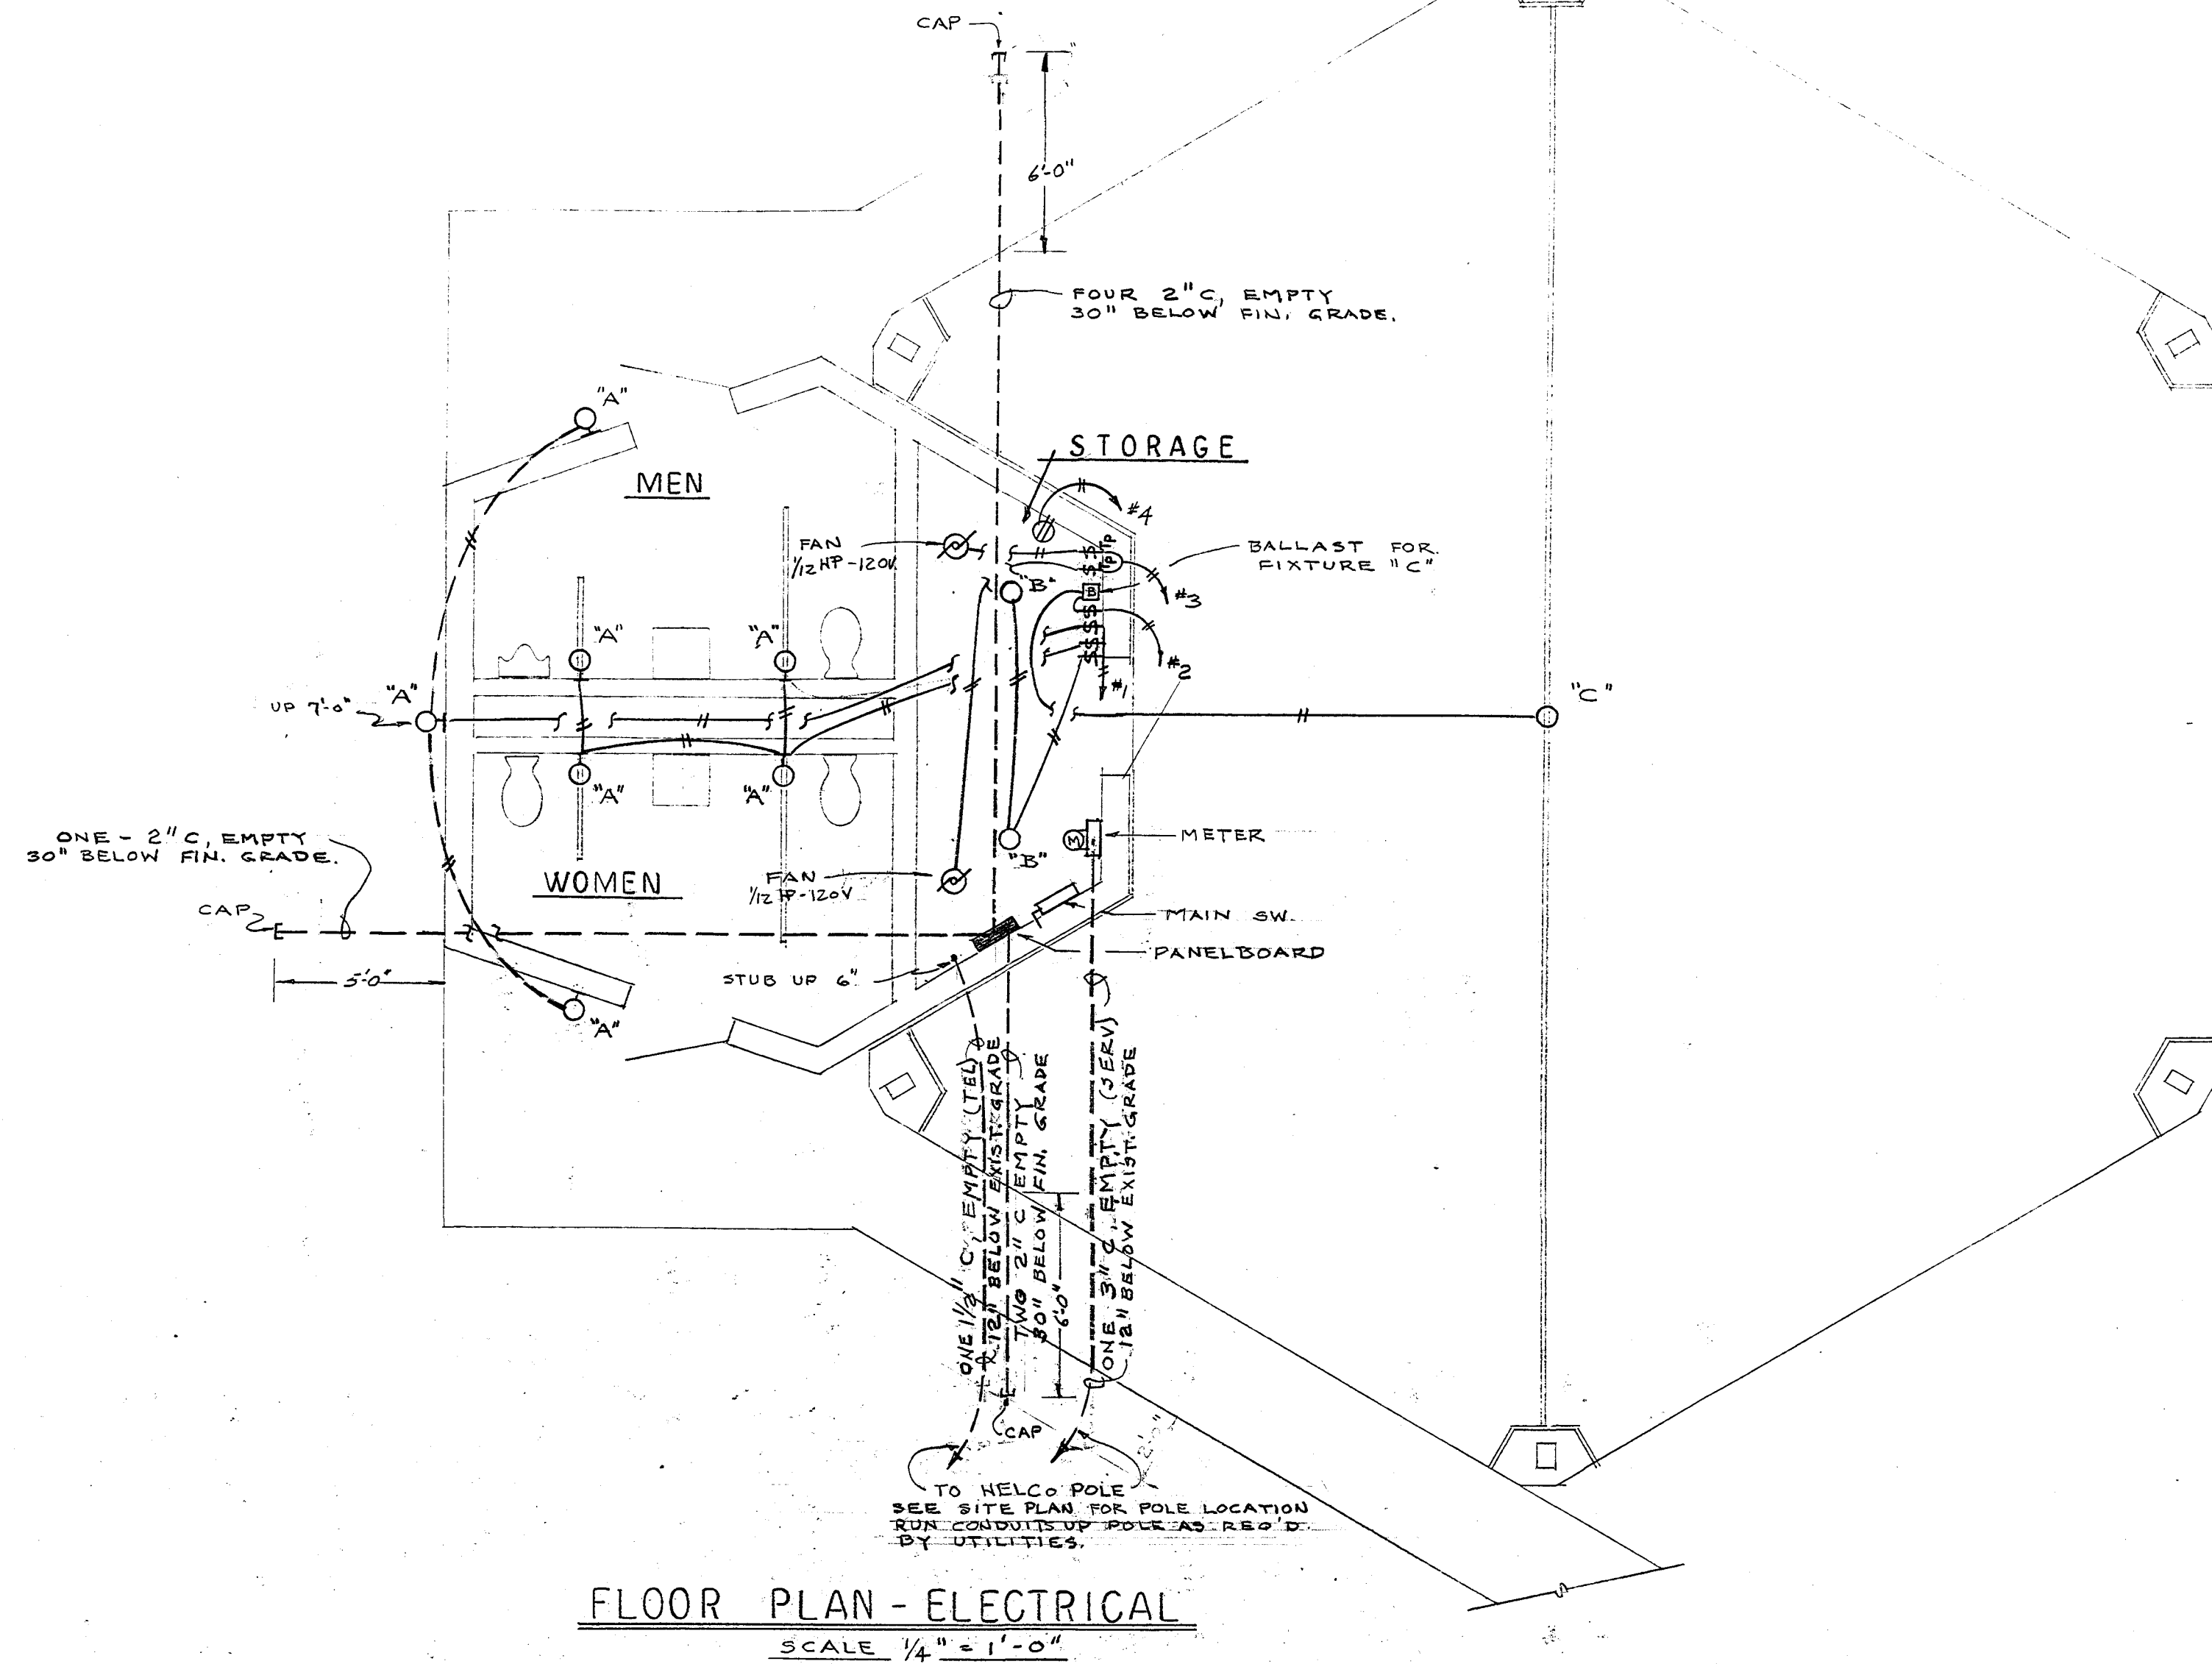



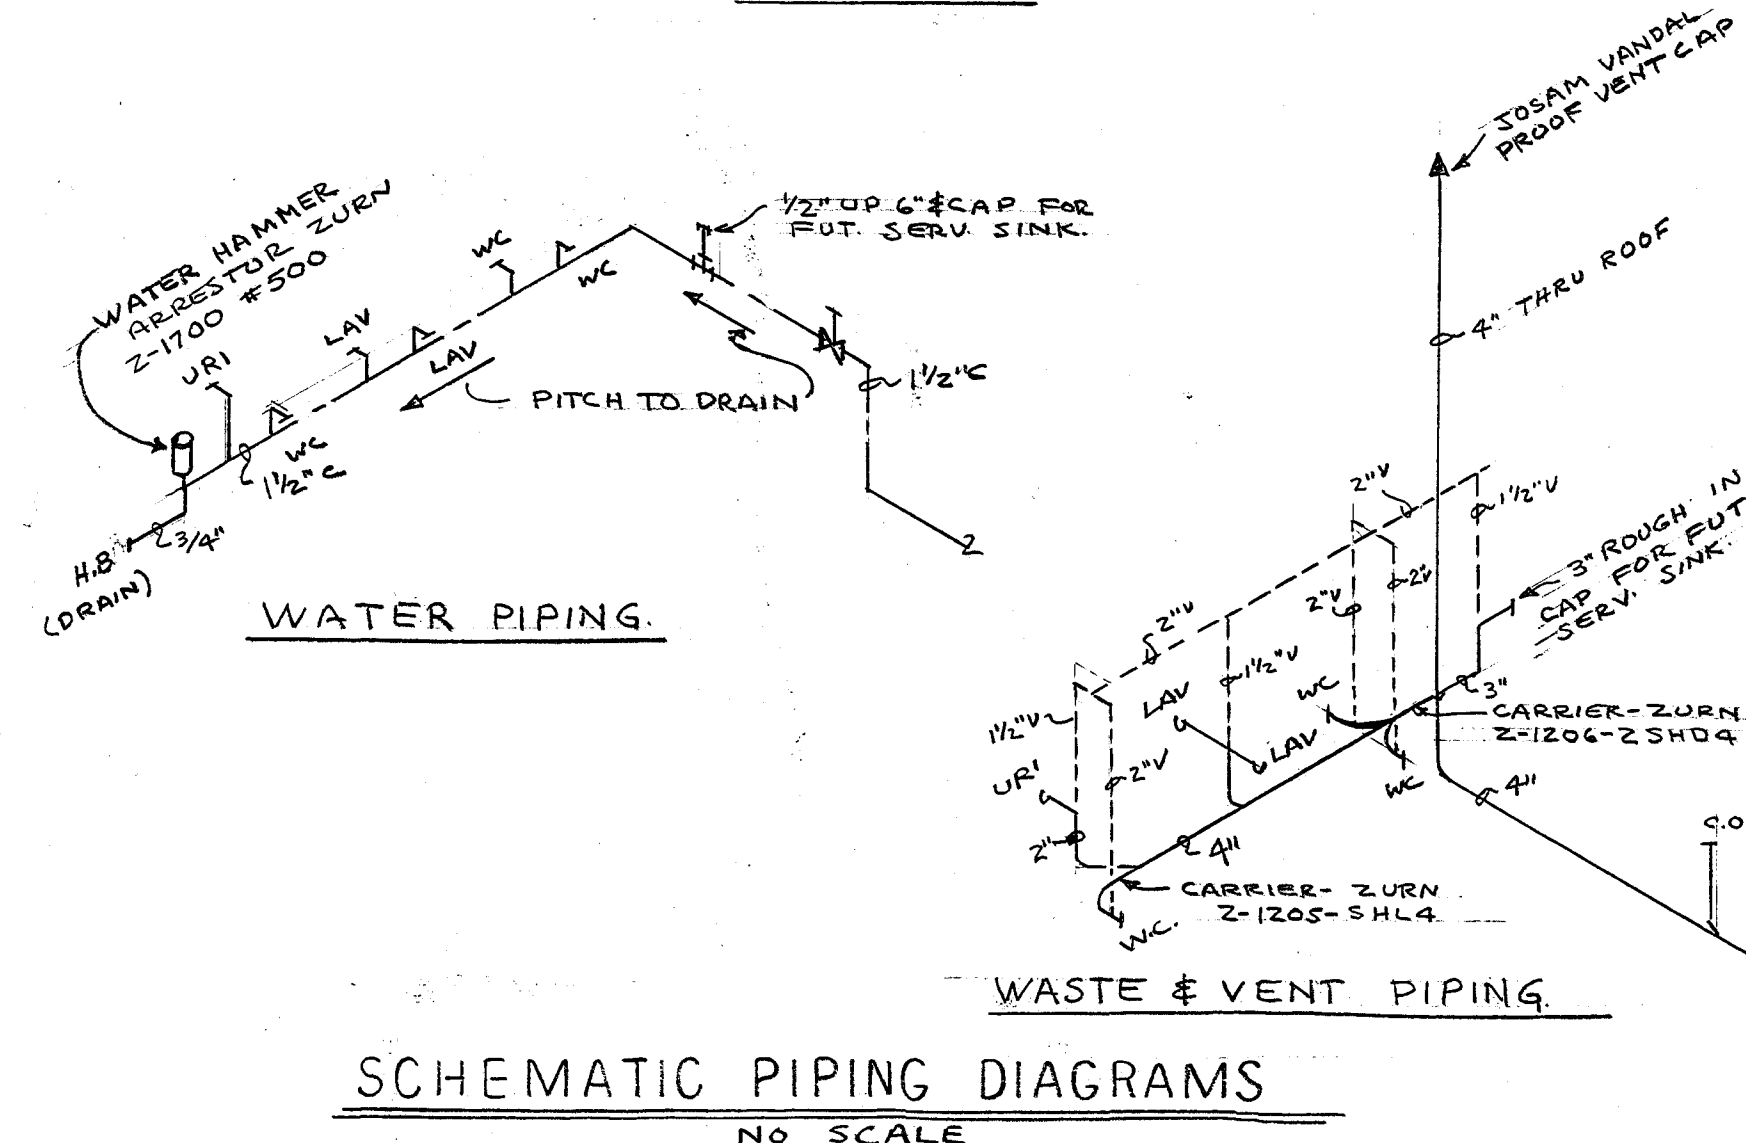


FIXTURE SCHEDULE			
TYPE	MANUFACTURER & CATALOG NO.	LAMPS	REMARKS
A	STONCO # P63701-LK	100W. I.F.	UP 8'-0" EXCEPT AS NOTED
B	STONCO # P63704-LK	100W. I.F.	
C	STONCO # 02P-24-500-LK	GE # MV-400 BU	REMOTE W.P. BALLAST

SYMBOL LIST	
SYMBOL	DESCRIPTION
---	CONCEALED OR OVERHEAD WIRING
---	UNDERGROUND WIRING OR RACEWAYS
○	CEILING OUTLET - SEE FIXTURE SCHEDULE
□	WALL BRACKET - " " " "
⊕	SINGLE POLE SW ~ H & H #1991 ~ UP 4'-0"
⊕	DUPLEX RECEPTACLE ~ H & H #5262
⊕	BALLAST ~ WEATHER-PROOF
⊕	MOTOR ~ FURNISHED & INSTALLED BY OTHERS ~ WIRED BY THIS E.C.
⊕	MANUAL MOTOR STARTER ~ FURNISHED BY OTHERS ~ INSTALLED & WIRED BY THIS E.C.

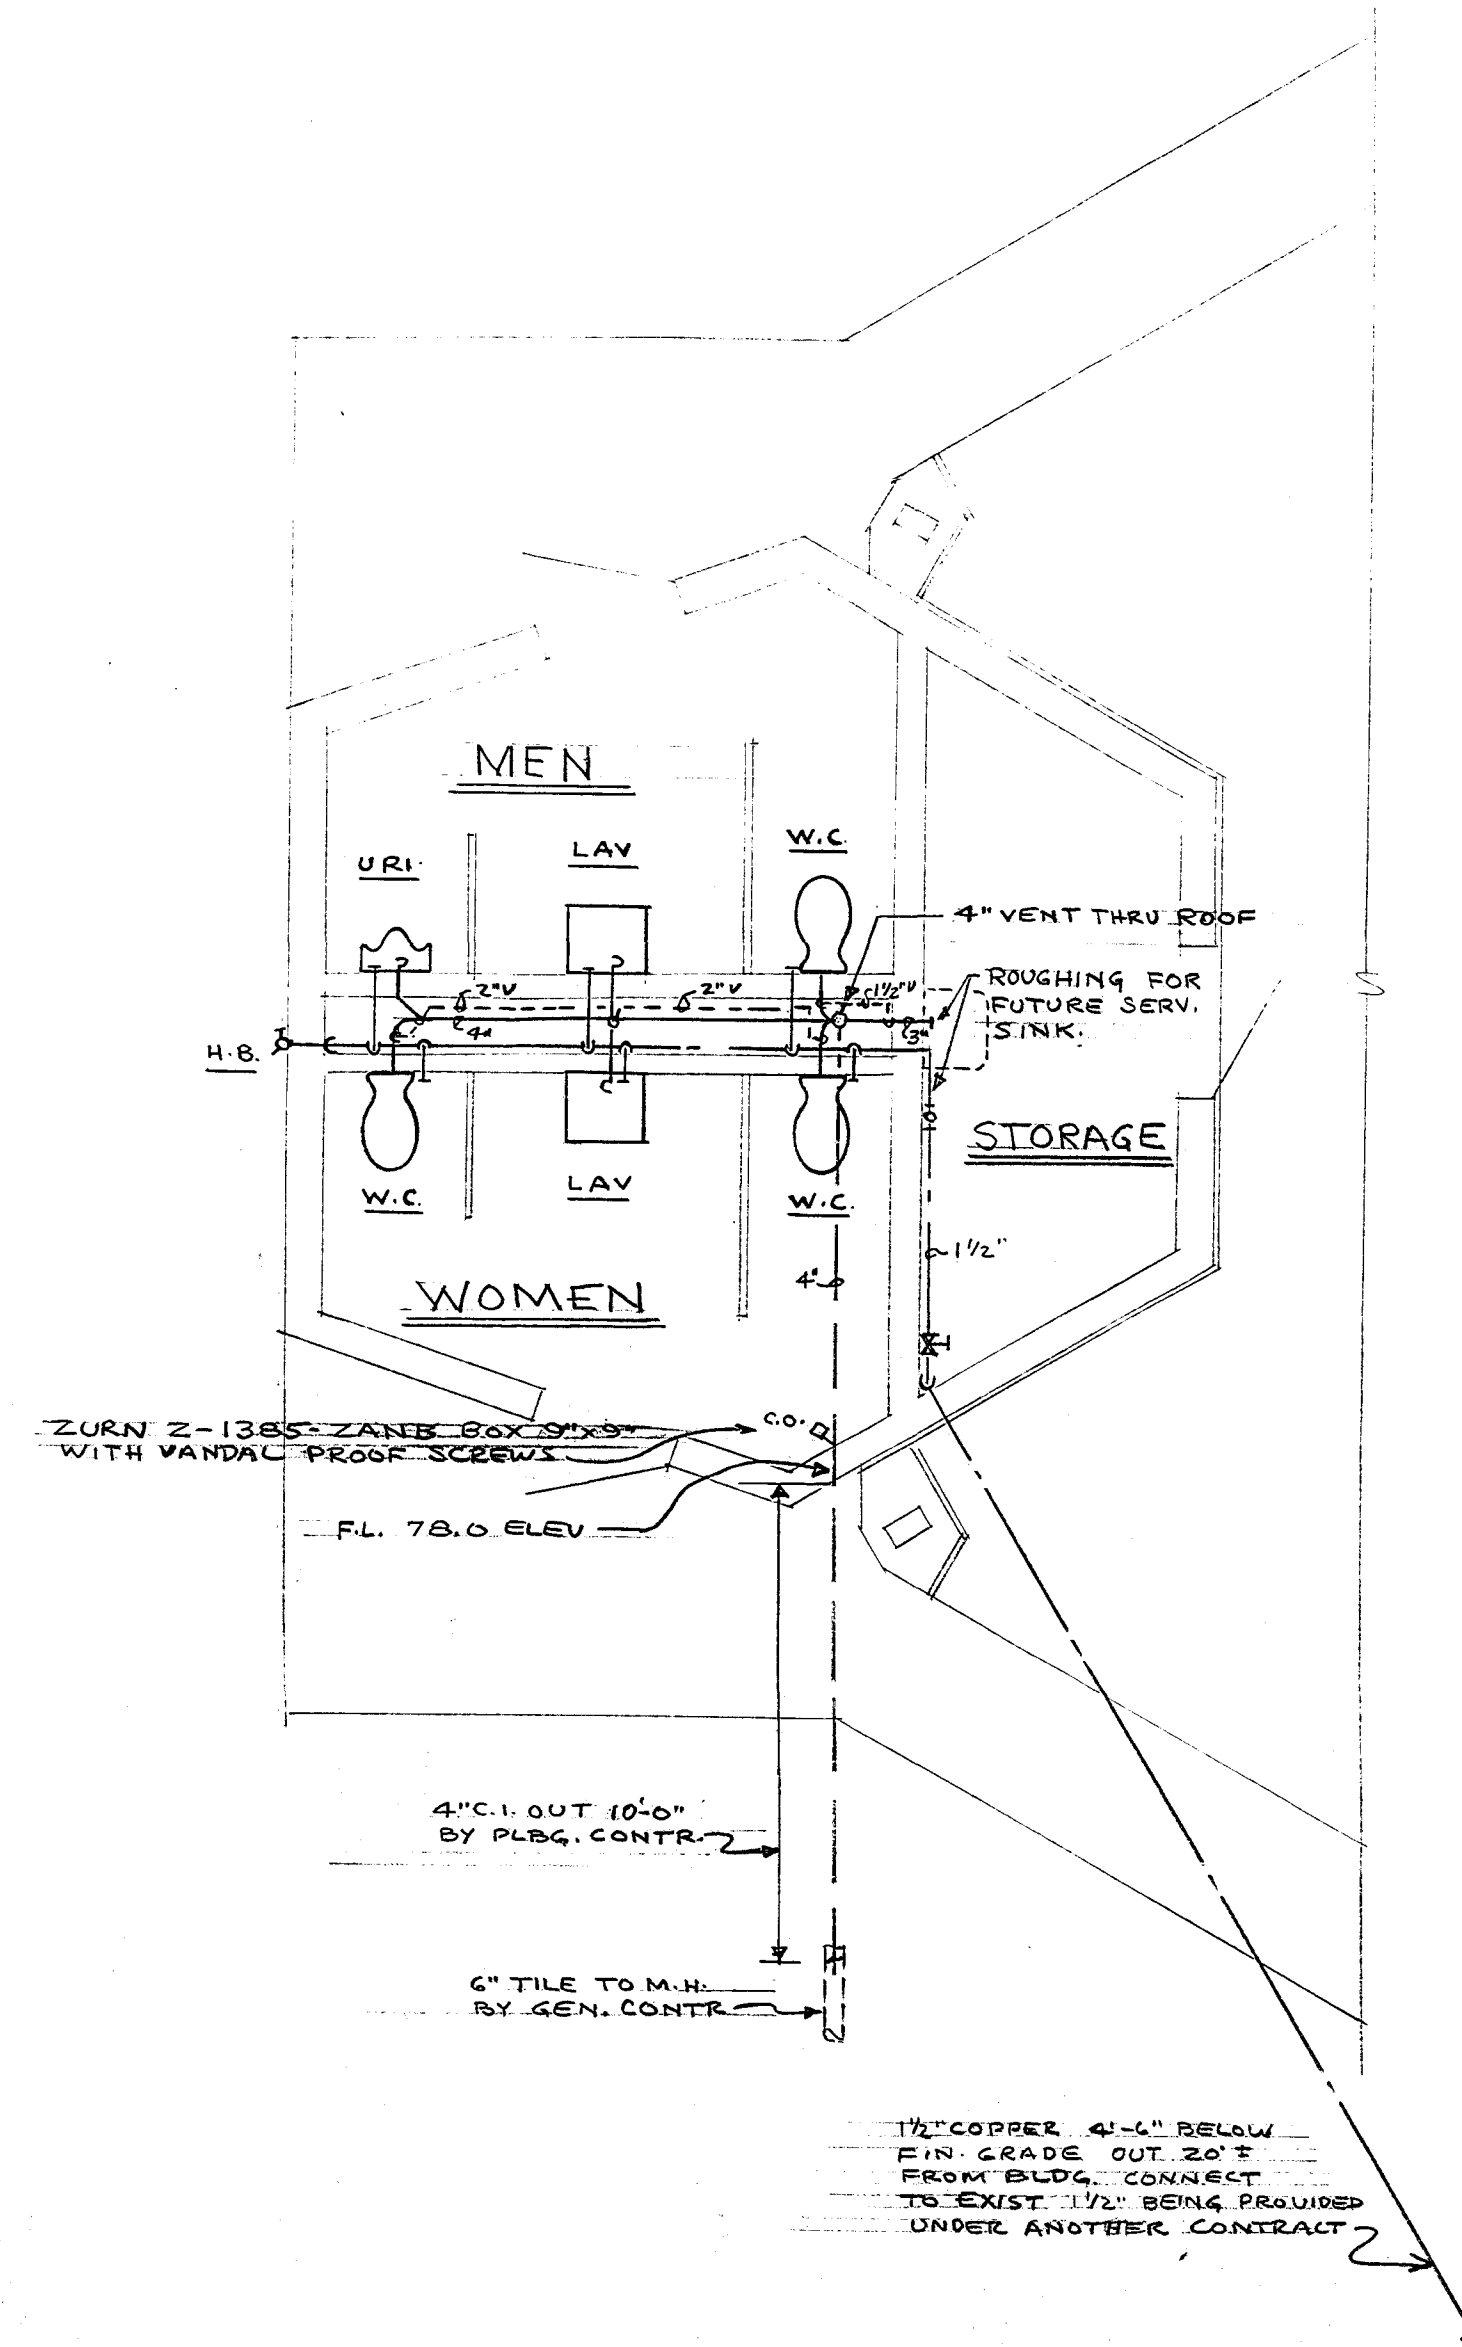

PLUMBING FIXTURE SCHEDULE					
FIXTURE	SOIL OR WASTE	VENT	C.W.	H.W.	SPECIFICATION
W.C. WATER CLOSET	4"	2"	1"	-	AM. STD. "GLENCO" NO. 2502, 011 WITH NO. 110 F.V. SLOAN ROYAL VALVE & SLOANITE W.I.O. BLACK OPEN FRONT SEAT
U.R.I. URINAL	2"	1 1/2"	3/4"	-	AM. STD. "WASHBROOK" NO. 6500, 011 NO. 182-H SLOAN ROYAL VALVE MOUNTING HEIGHT 15"
LAV. LAVATORY	1 1/2"	1 1/2"	1/2"	-	AM. STD. "REGALYN" 20" X 18" C.L.A.R. ENAMEL NO. 2534, 022 SLOAN ROYAL VALVE NO. 2175, 016 FAUCET NO. 2502, 031 SUPPLY STOP MOUNTING HEIGHT 21"
H.B. HOSE BIBB	-	-	1/2"	-	ANACONDA NO. 1663, ANGLE TYPE, LOOSE SET KEY, HOSE THREAD.

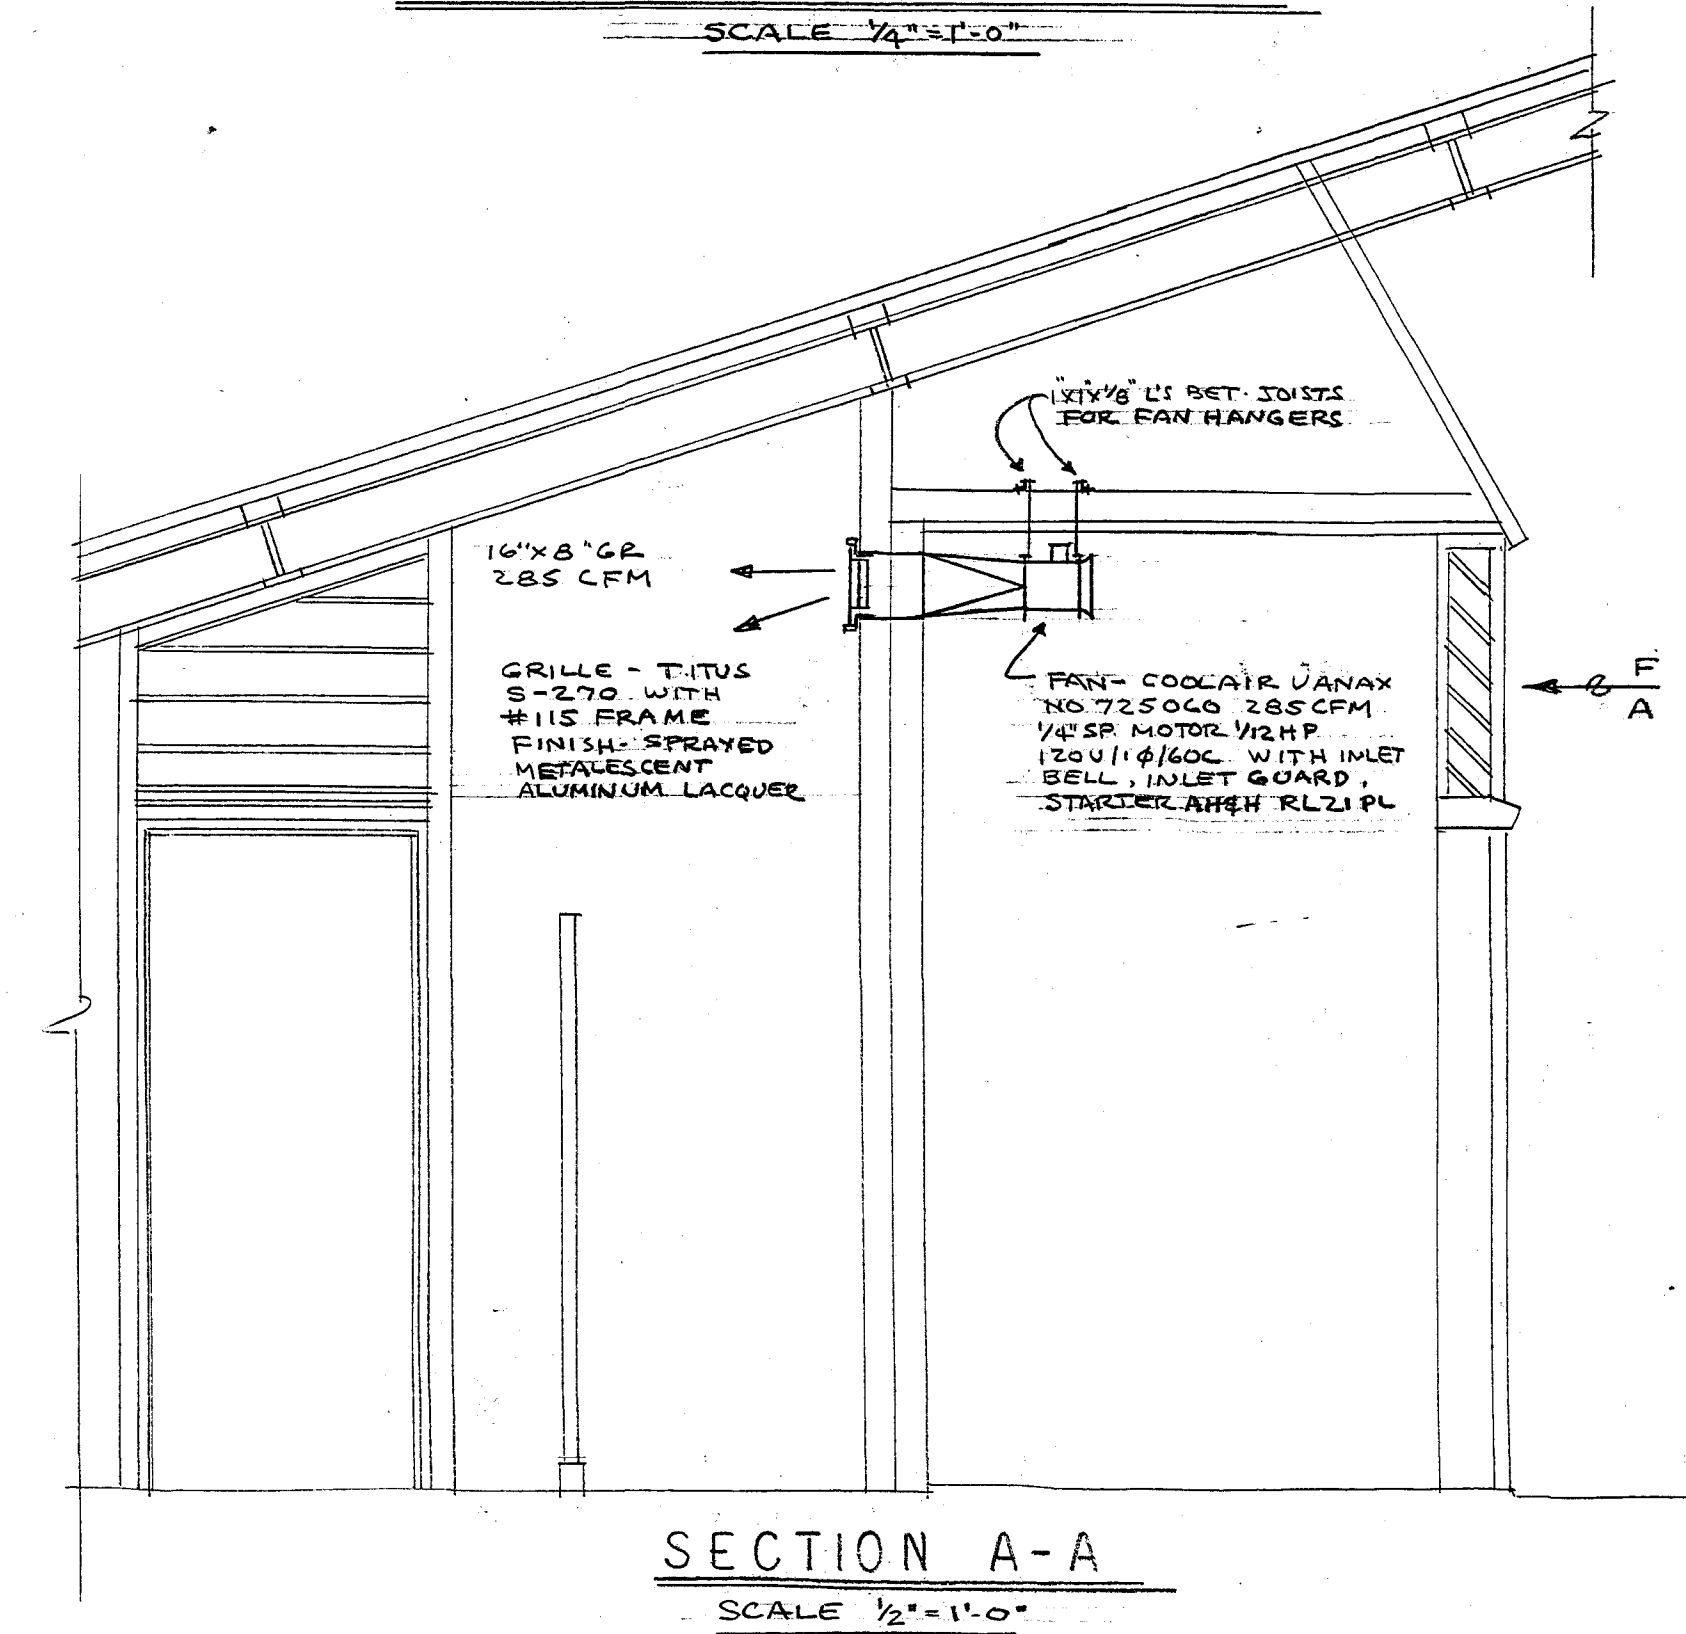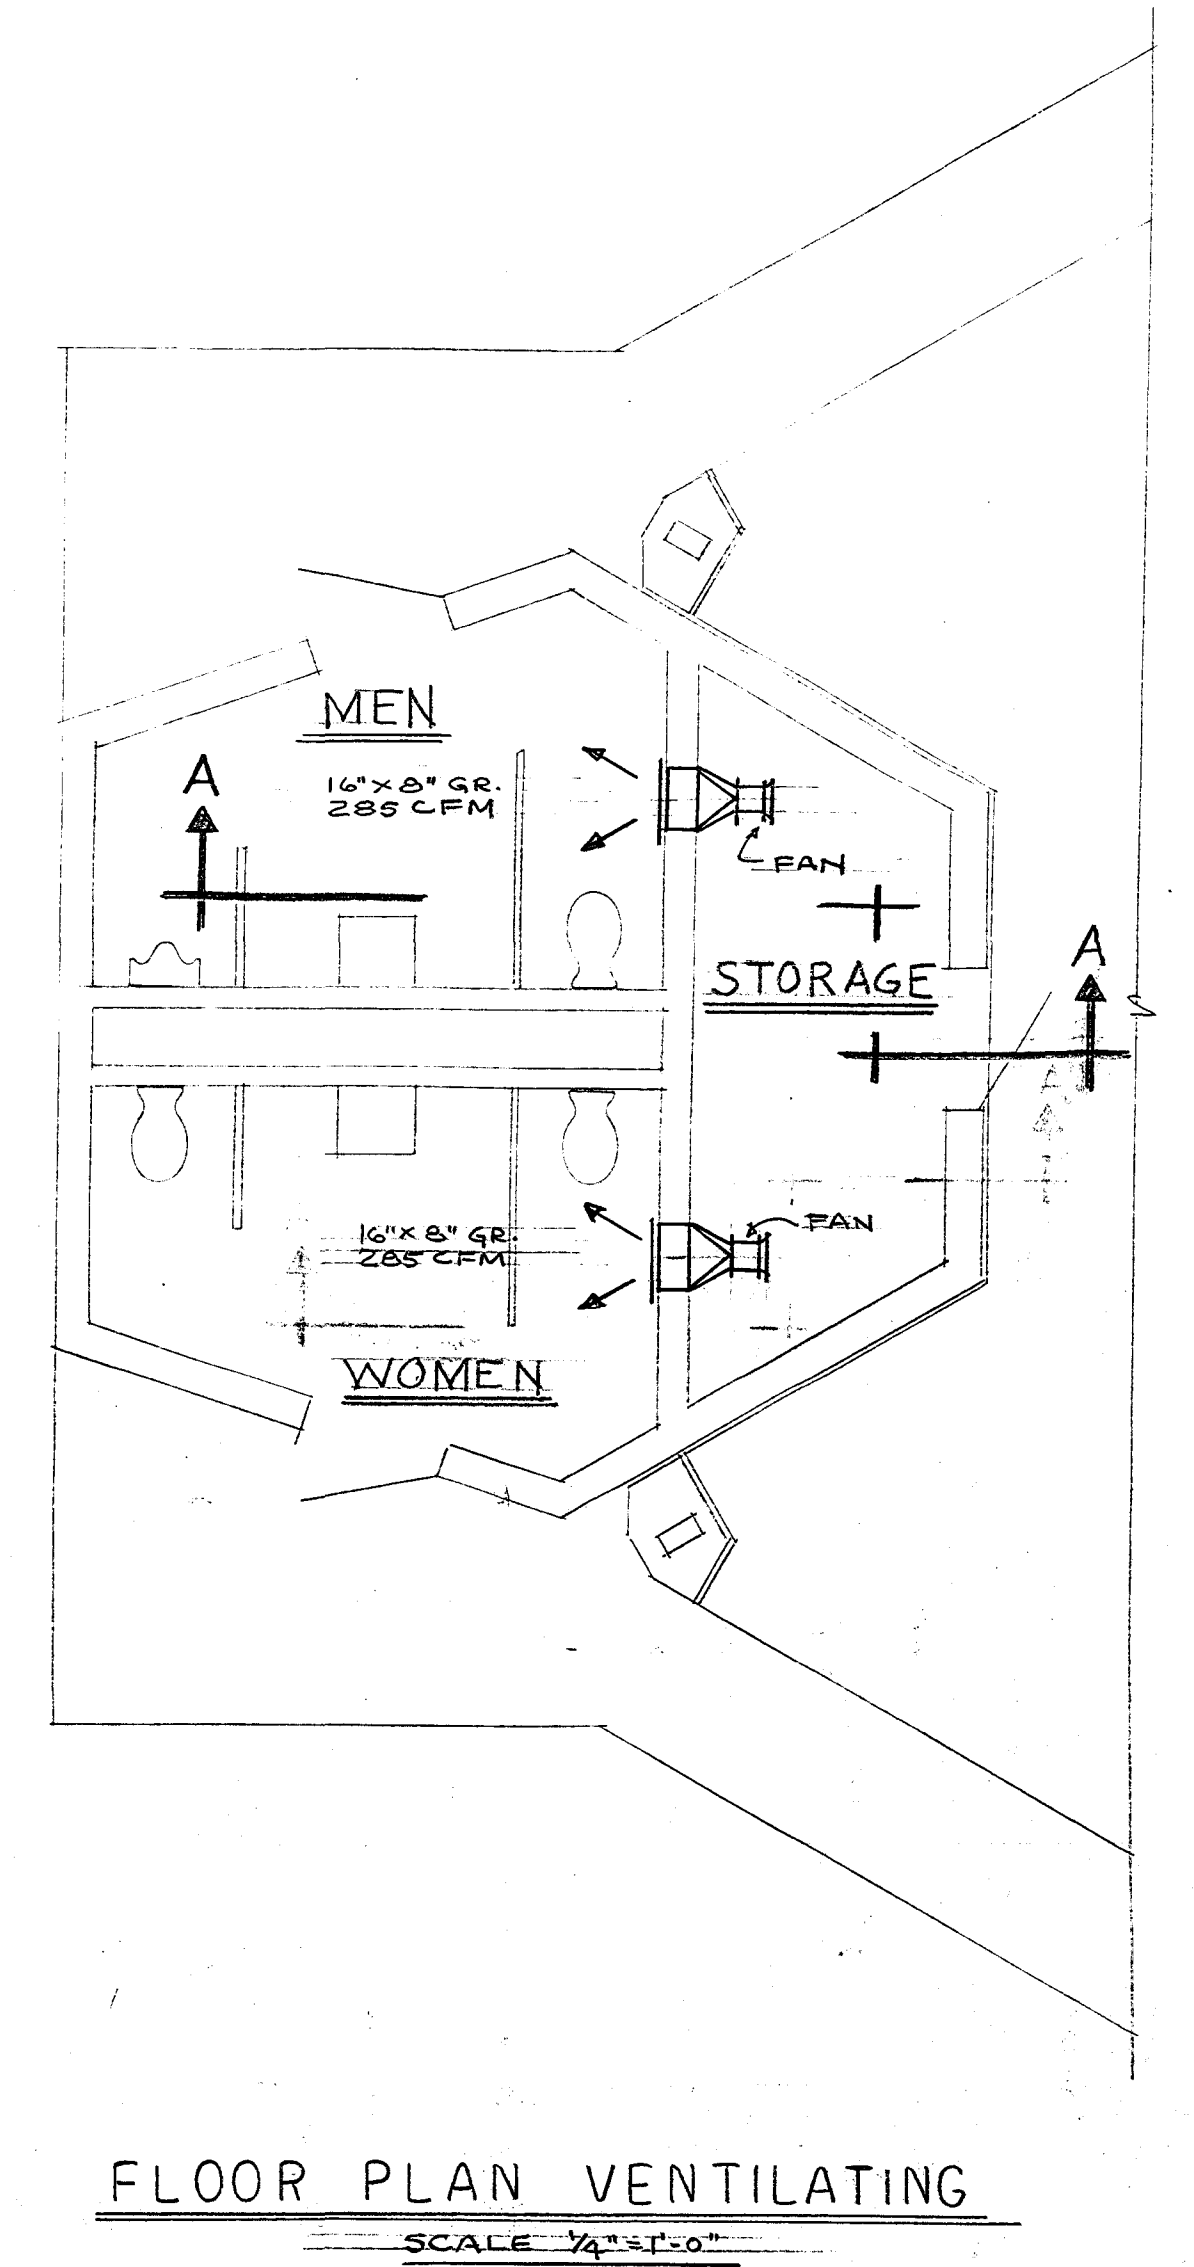

CITY OF HARTFORD, CONNECTICUT DEPARTMENT OF ENGINEERING		DWG. NO.
FIELD HOUSE - SHELTER AND SPRAY POOL AT BARBOUR-KENEY COMPLEX HARTFORD, CONN.		ME-1
SUBMITTED <i>Raymond Pannoy</i>	RECOMMENDED CITY ARCHITECT	APPROVED <i>George E. Johnson</i> CITY ENGINEER
DESIGN PDP-RB, DRAWN PDP-RB	DAYBOOK NO. 010153-F	DATE MARCH 6, 1970
TRACED	CHECK	