


SYMBOL	DESCRIPTION
	FLUORESCENT FIXTURE
	RECESSED FLUORESCENT FIXTURE
	CEILING OUTLET OR FIXTURE
	WALL BRACKET
	EXIT LIGHT
	CLOCK OUTLET ~ H#H#5262 ~ UP 8'-6"
	DUPLEX CONV. OUTLET ~ H#H#5262 ~ UP 1'-6"
	DUPLEX CONV. OUTLET ~ H#H#5262 ~ (EXIST. LOCATION)
	RANGE OUTLET ~ H#H#5738
	SINGLE POLE SW. ~ H#H#1991
	THREE-WAY SW. ~ H#H#1993
	FOUR-WAY SW. ~ H#H#1994
	CLEANING RECEPTACLE ~ H#H#5292
	JUNCTION BOX
	LIGHTING PANEL

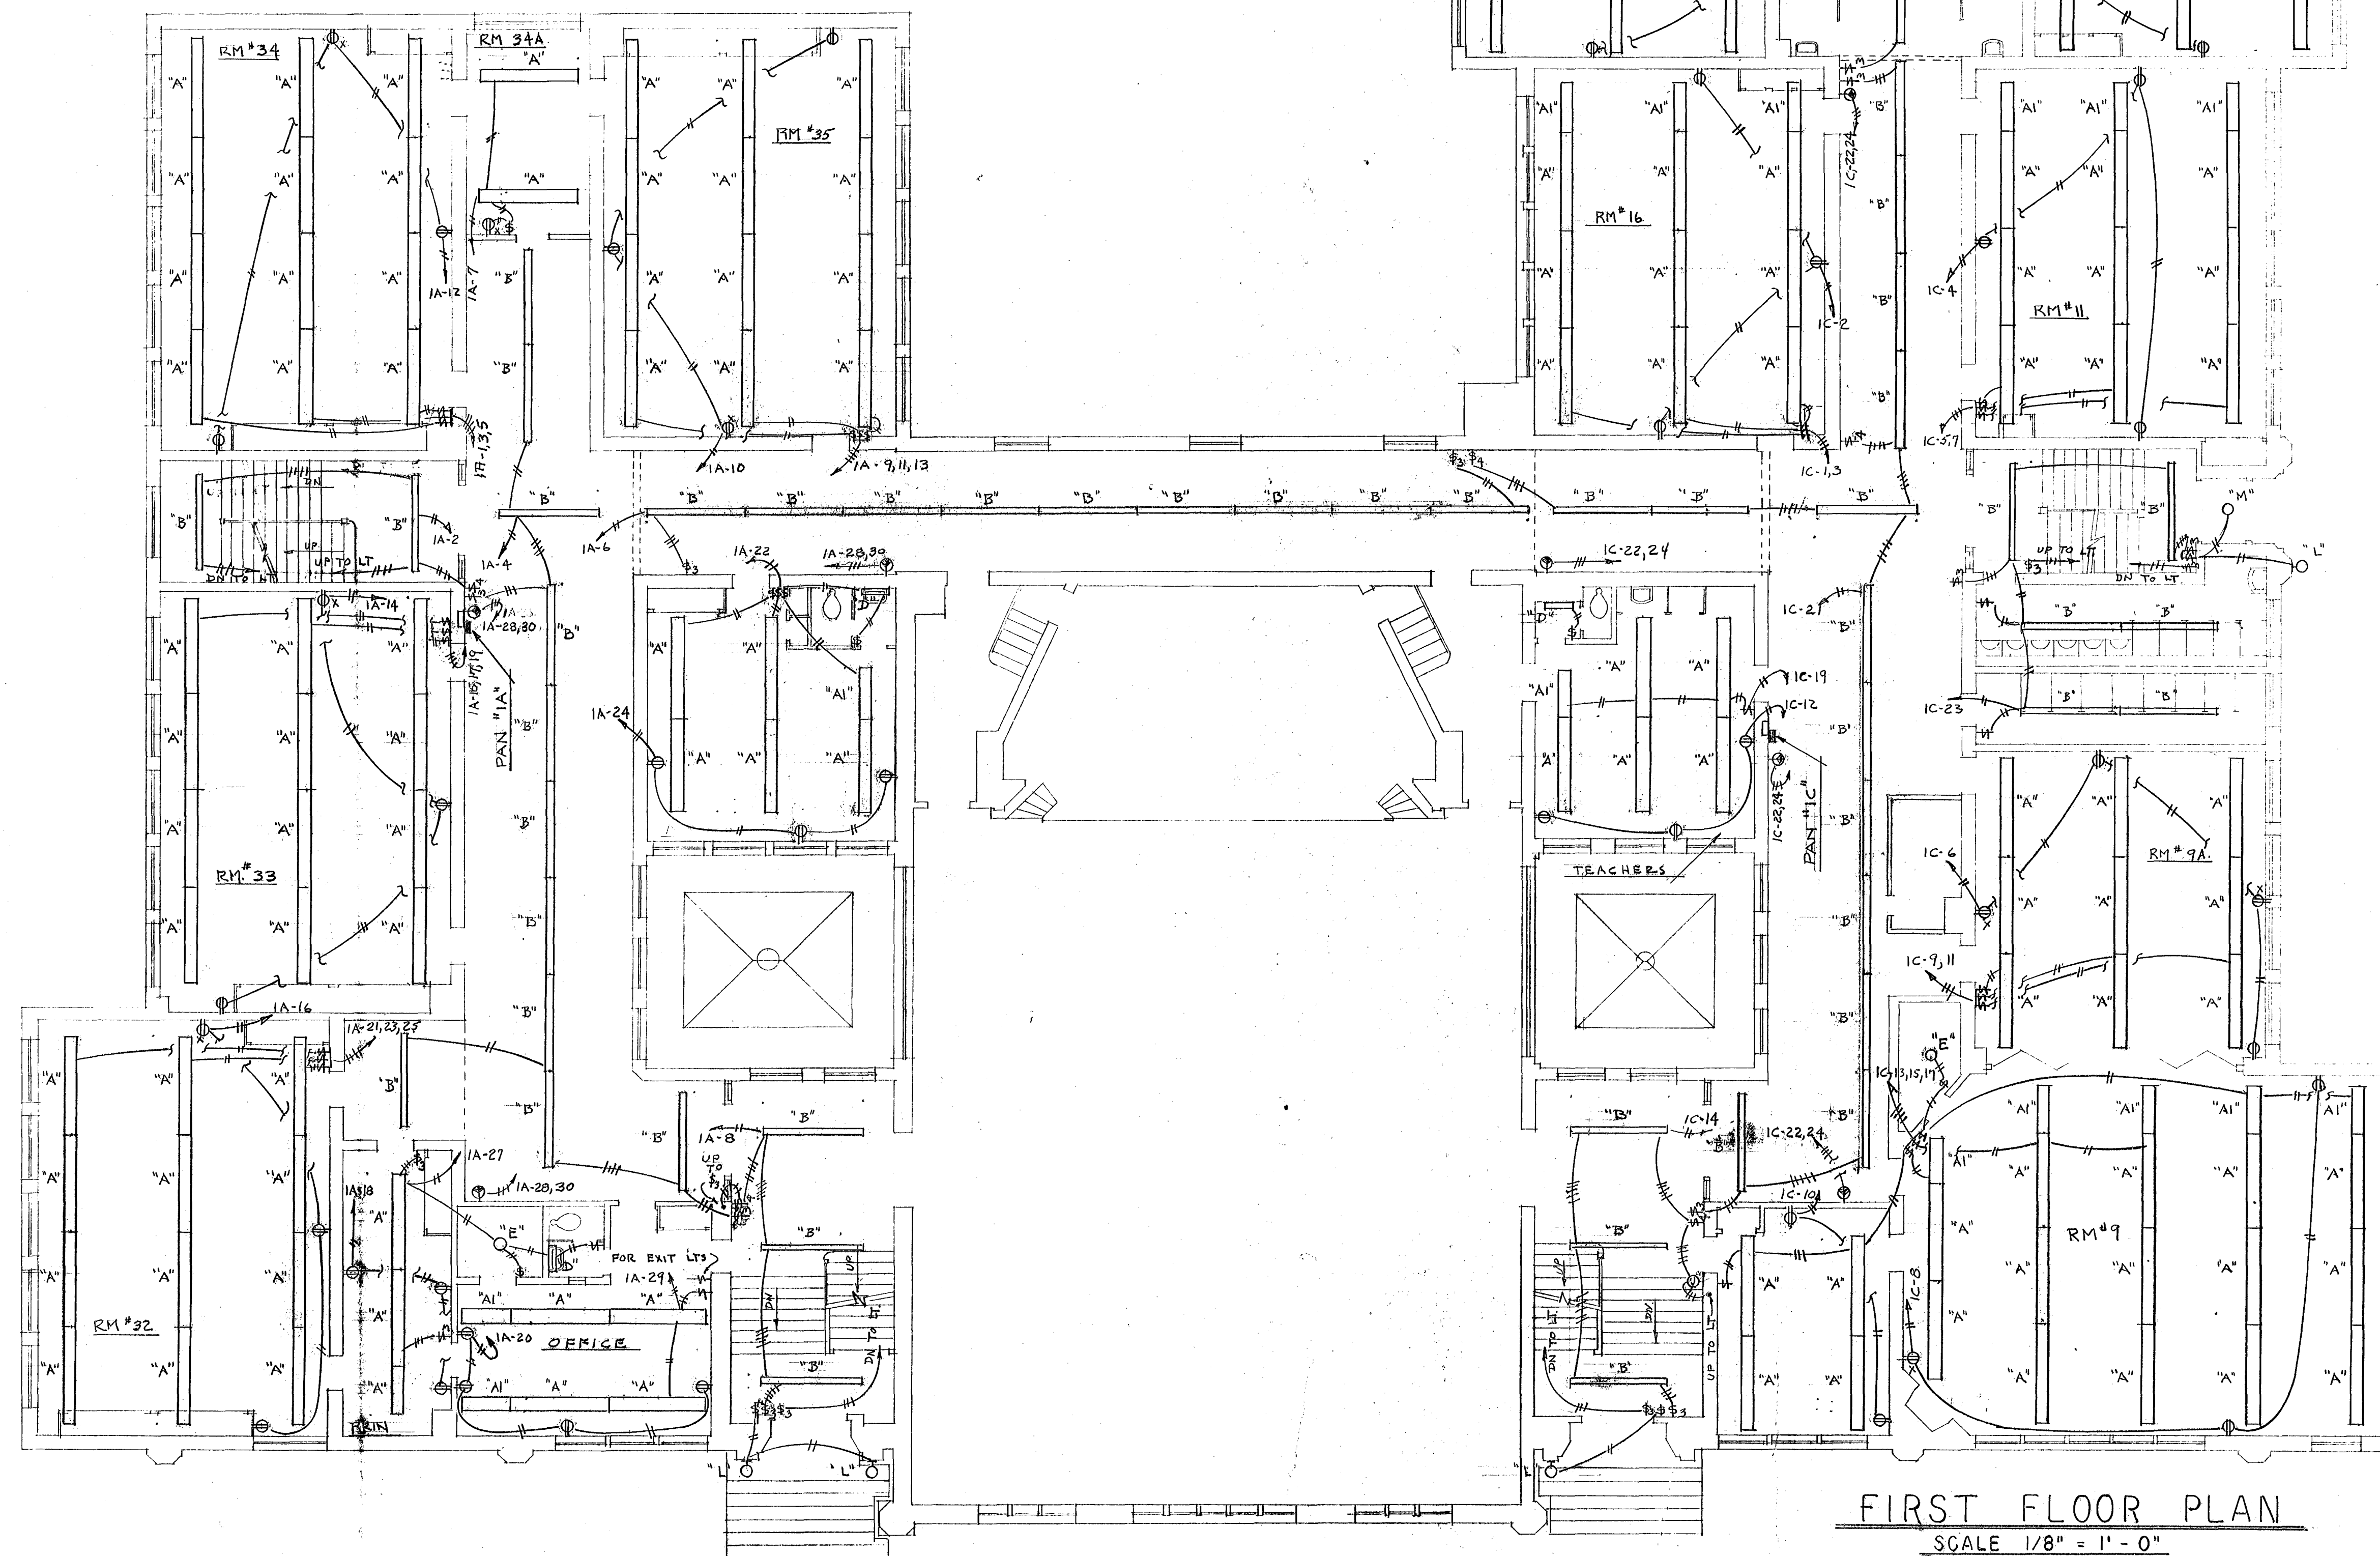

FIRST FLOOR PLAN
SCALE 1/8" = 1' - 0"

VERIFY EXISTING
CONDITIONS AND
DIMENSIONS AT
BUILDING

CITY OF HARTFORD, CONNECTICUT DEPARTMENT OF ENGINEERING		
ELECTRICAL ALTERATIONS FOR SARAH J. RAWSON SCHOOL 260 HOLCOMB ST. HARTFORD CONN.		
SUBMITTED <i>Raymond J. Bennett</i>	RECOMMENDED <i>James E. Donz</i> - CIVIL ARCHITECT	APPROVED <i>James E. Donz</i> - CIVIL ENGINEER
DESIGN: R.G.B.	DRAWN: R.G.B.	DAYBOOK NO. 0101598
TRACED: _____	CHECK: _____	DATE: APRIL 1, 1970