



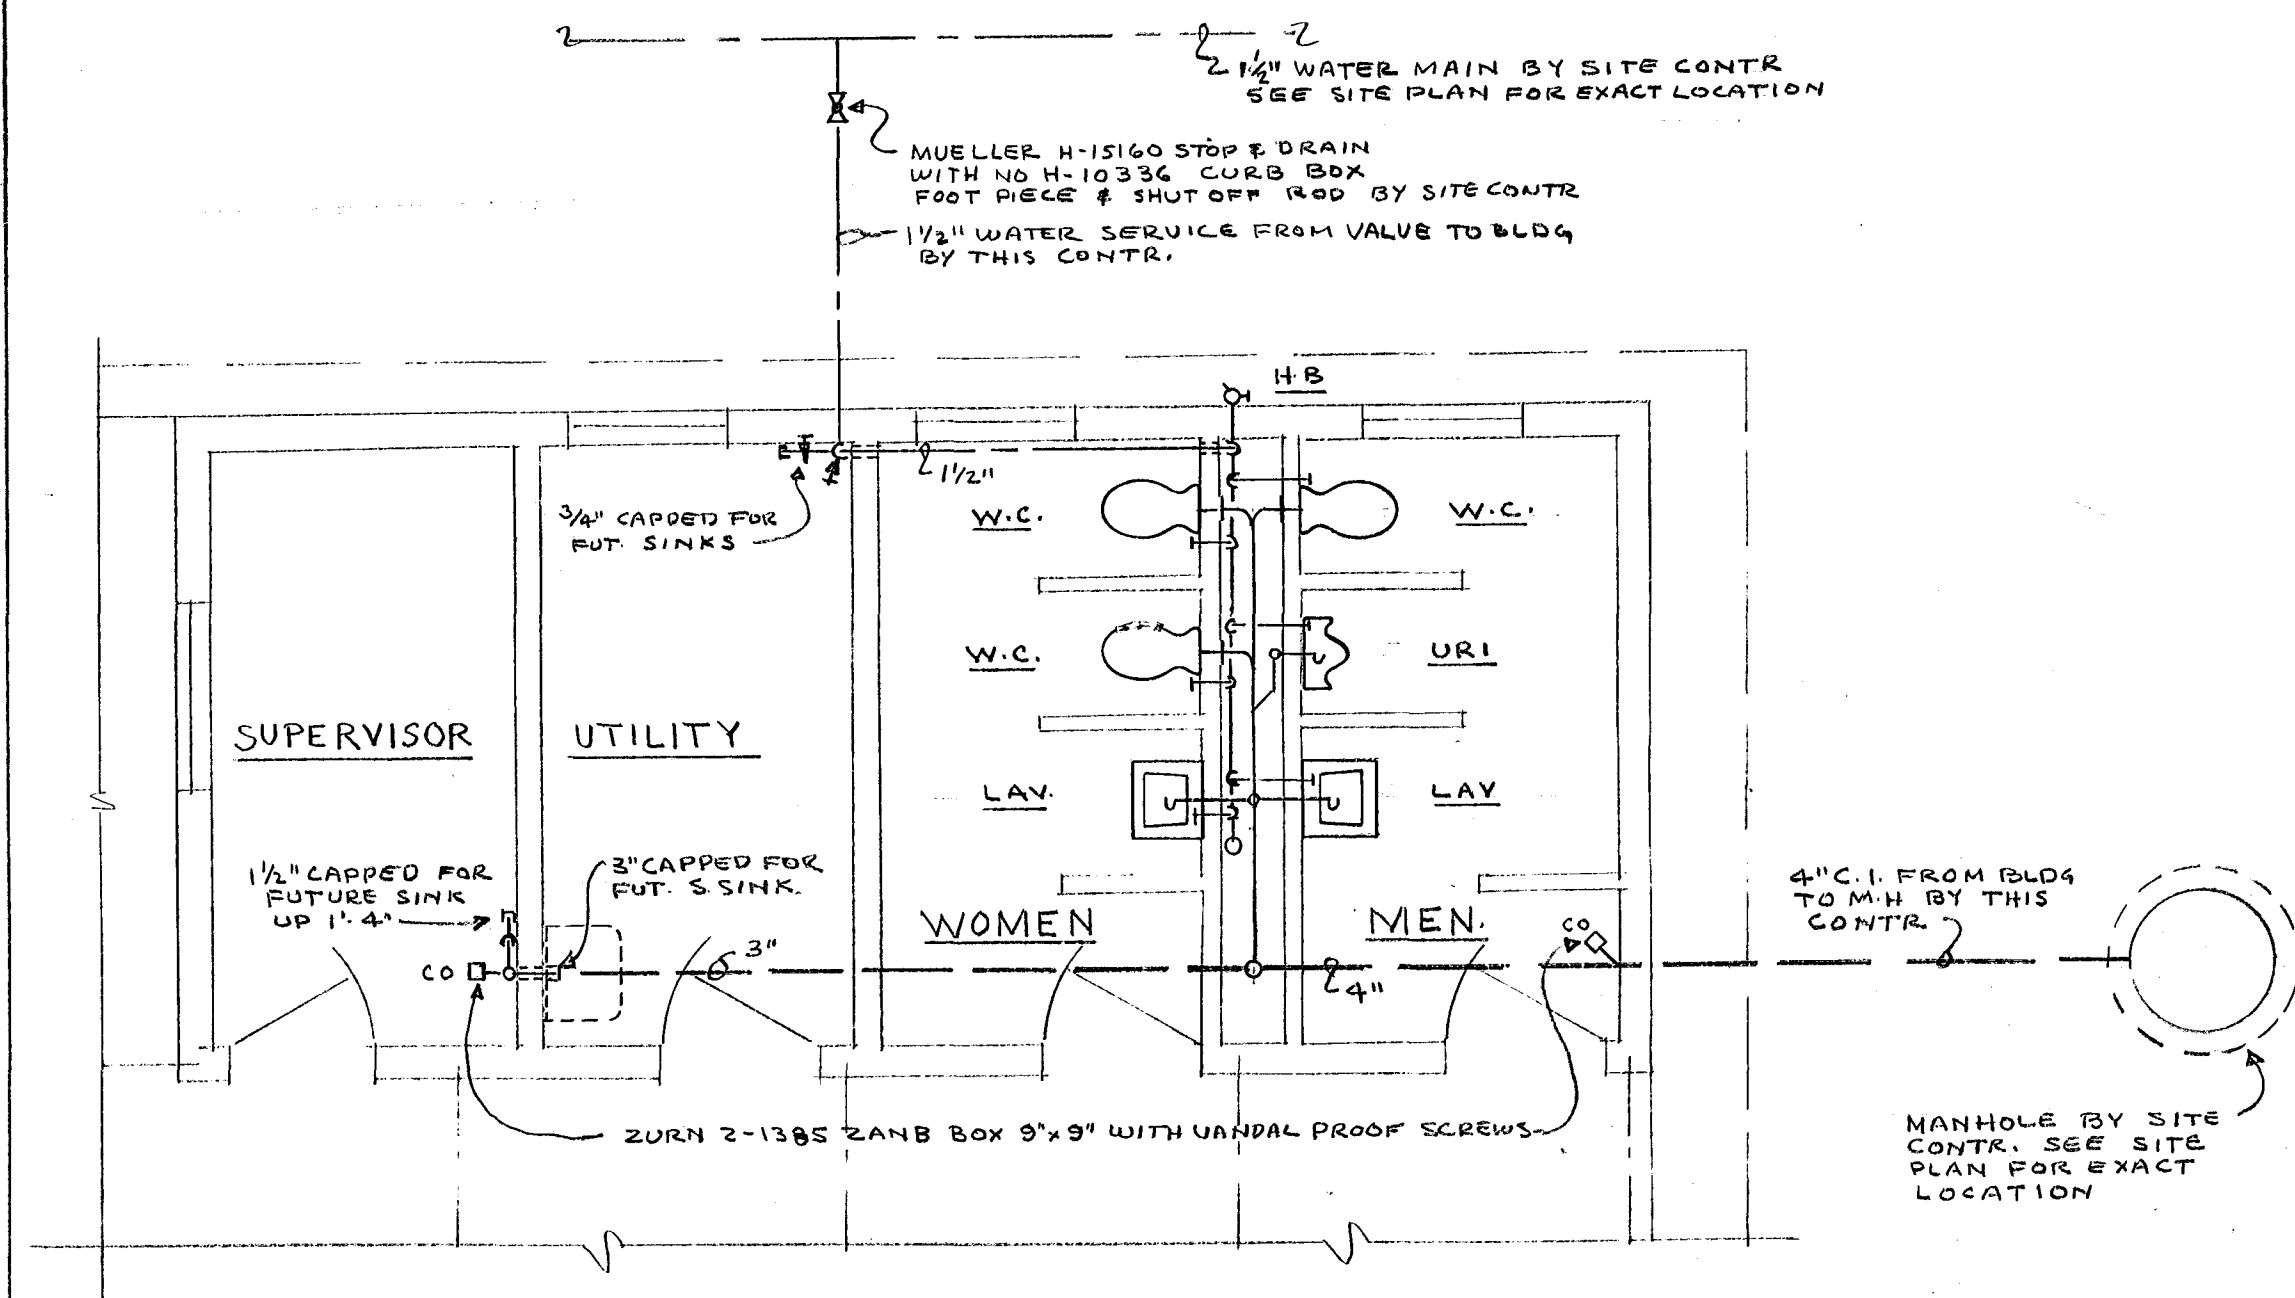

FLOOR PLAN PLUMBING

SCALE 1/4" = 1'-0"

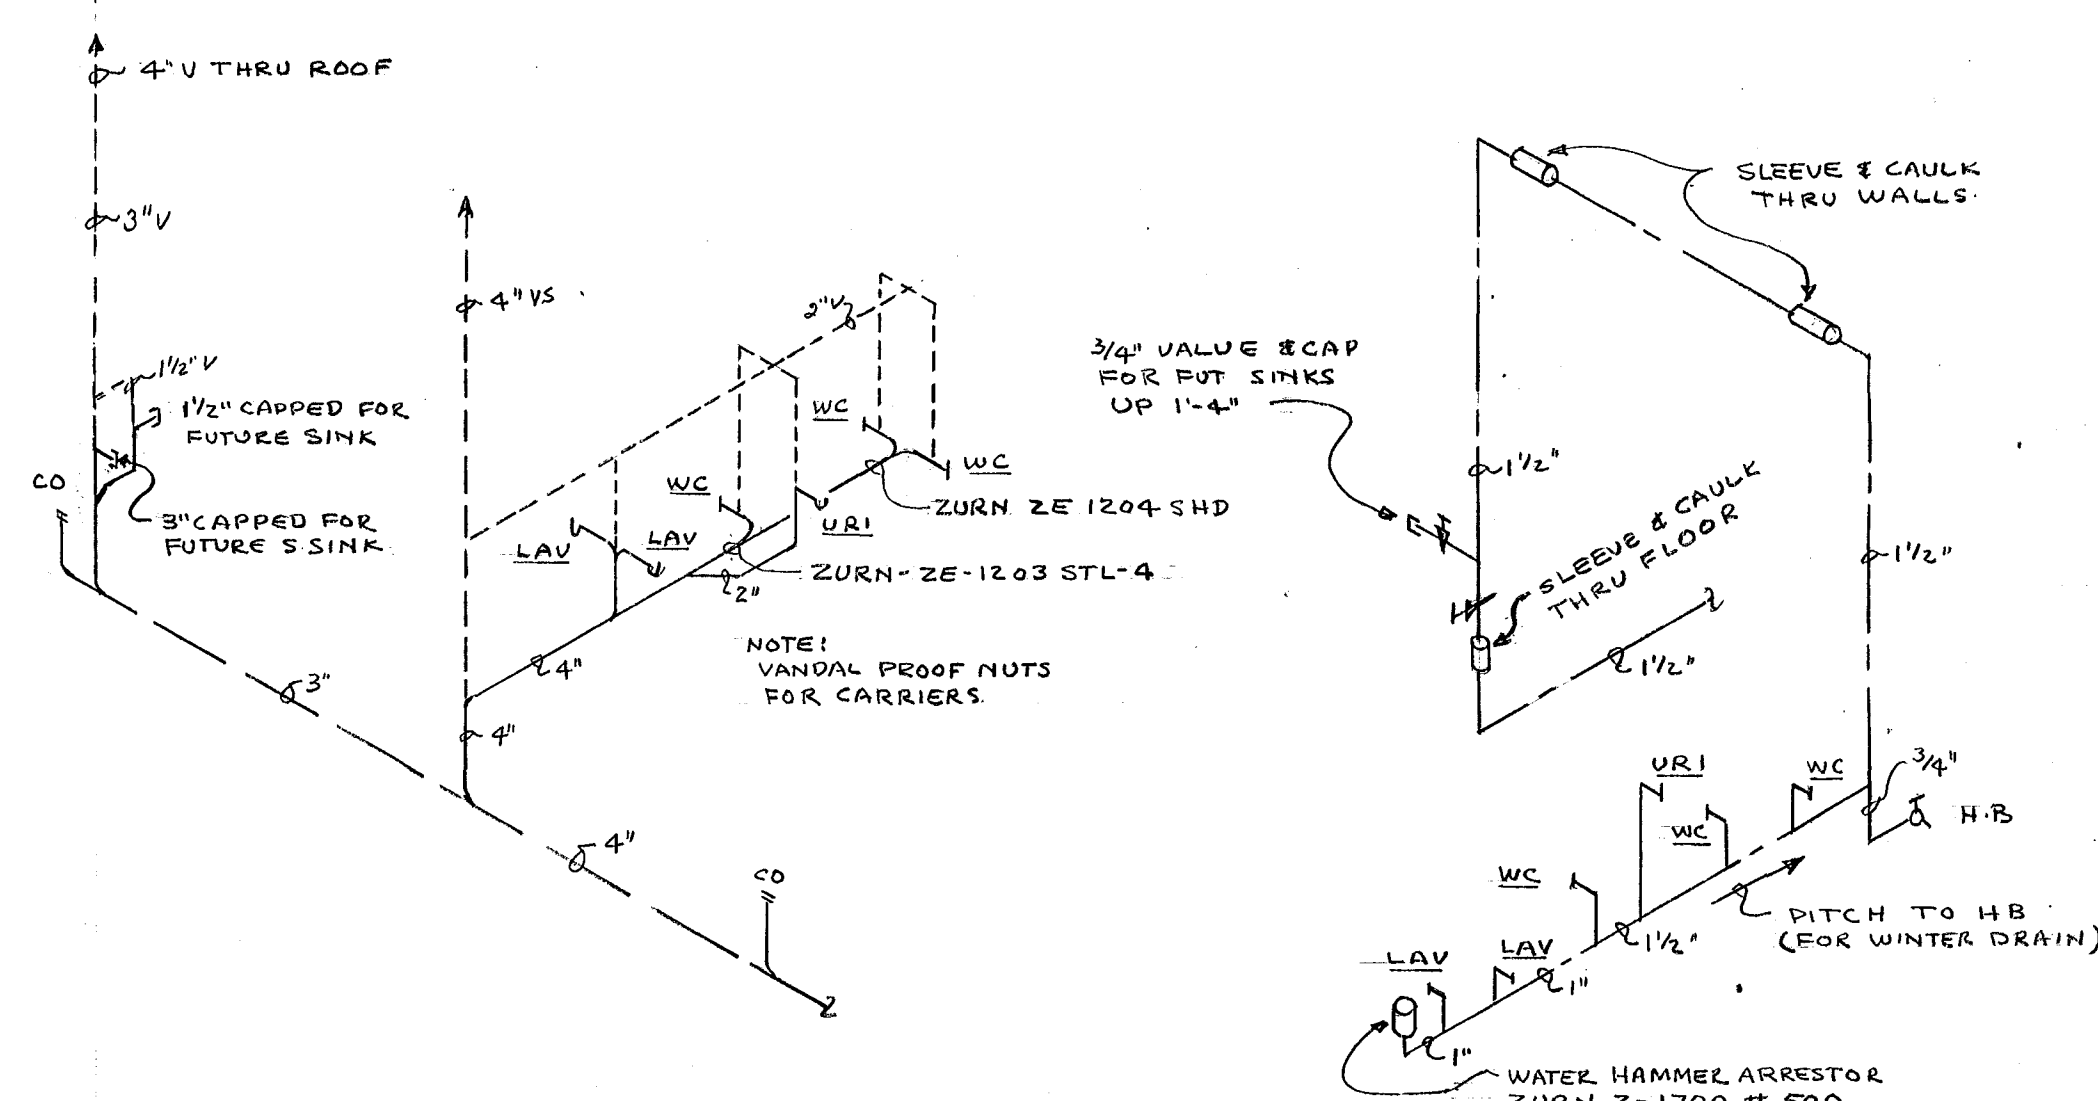

WASTE & VENT PIPING


WATER PIPING

SCHEMATIC PIPING DIAGRAMS

NO SCALE


PLUMBING FIXTURE SCHEDULE

FIXTURE	SOIL OR WASTE	VENT	C.W.	H.W.	SPECIFICATION
W.C. WATER CLOSET	4"	2"	1"	-	AM. STD. "GLENCO" NO. 2502.011 WITH NO. 110 F.V. SLOAN ROYAL VALVE OLSONITE #10 BLACK OPEN FRONT SEAT
U.R.I. URINAL	2"	1 1/2"	3/4"	-	AM. STD. "WASHBROOK" NO. 6500.011 NO. 186-II SLOAN ROYAL VALVE MOUNTING HEIGHT 15"
L.A.V. LAVATORY	1 1/2"	1 1/2"	1/2"	-	AM. STD. "REGALYN" 20x18" C.I. L.A.R. ENAMEL NO. 4869.020 NO. 2420-016 POP UP DRAIN NO. 2279-016 FAUCET NO. 2302.081 SUPPLY & STOP
H.B. HOSE BIBB	-	-	3/4"	-	ANACONDA NO. 1663 ANGLE TYPE, LOOSE SET KEY, HOSE THREAD.

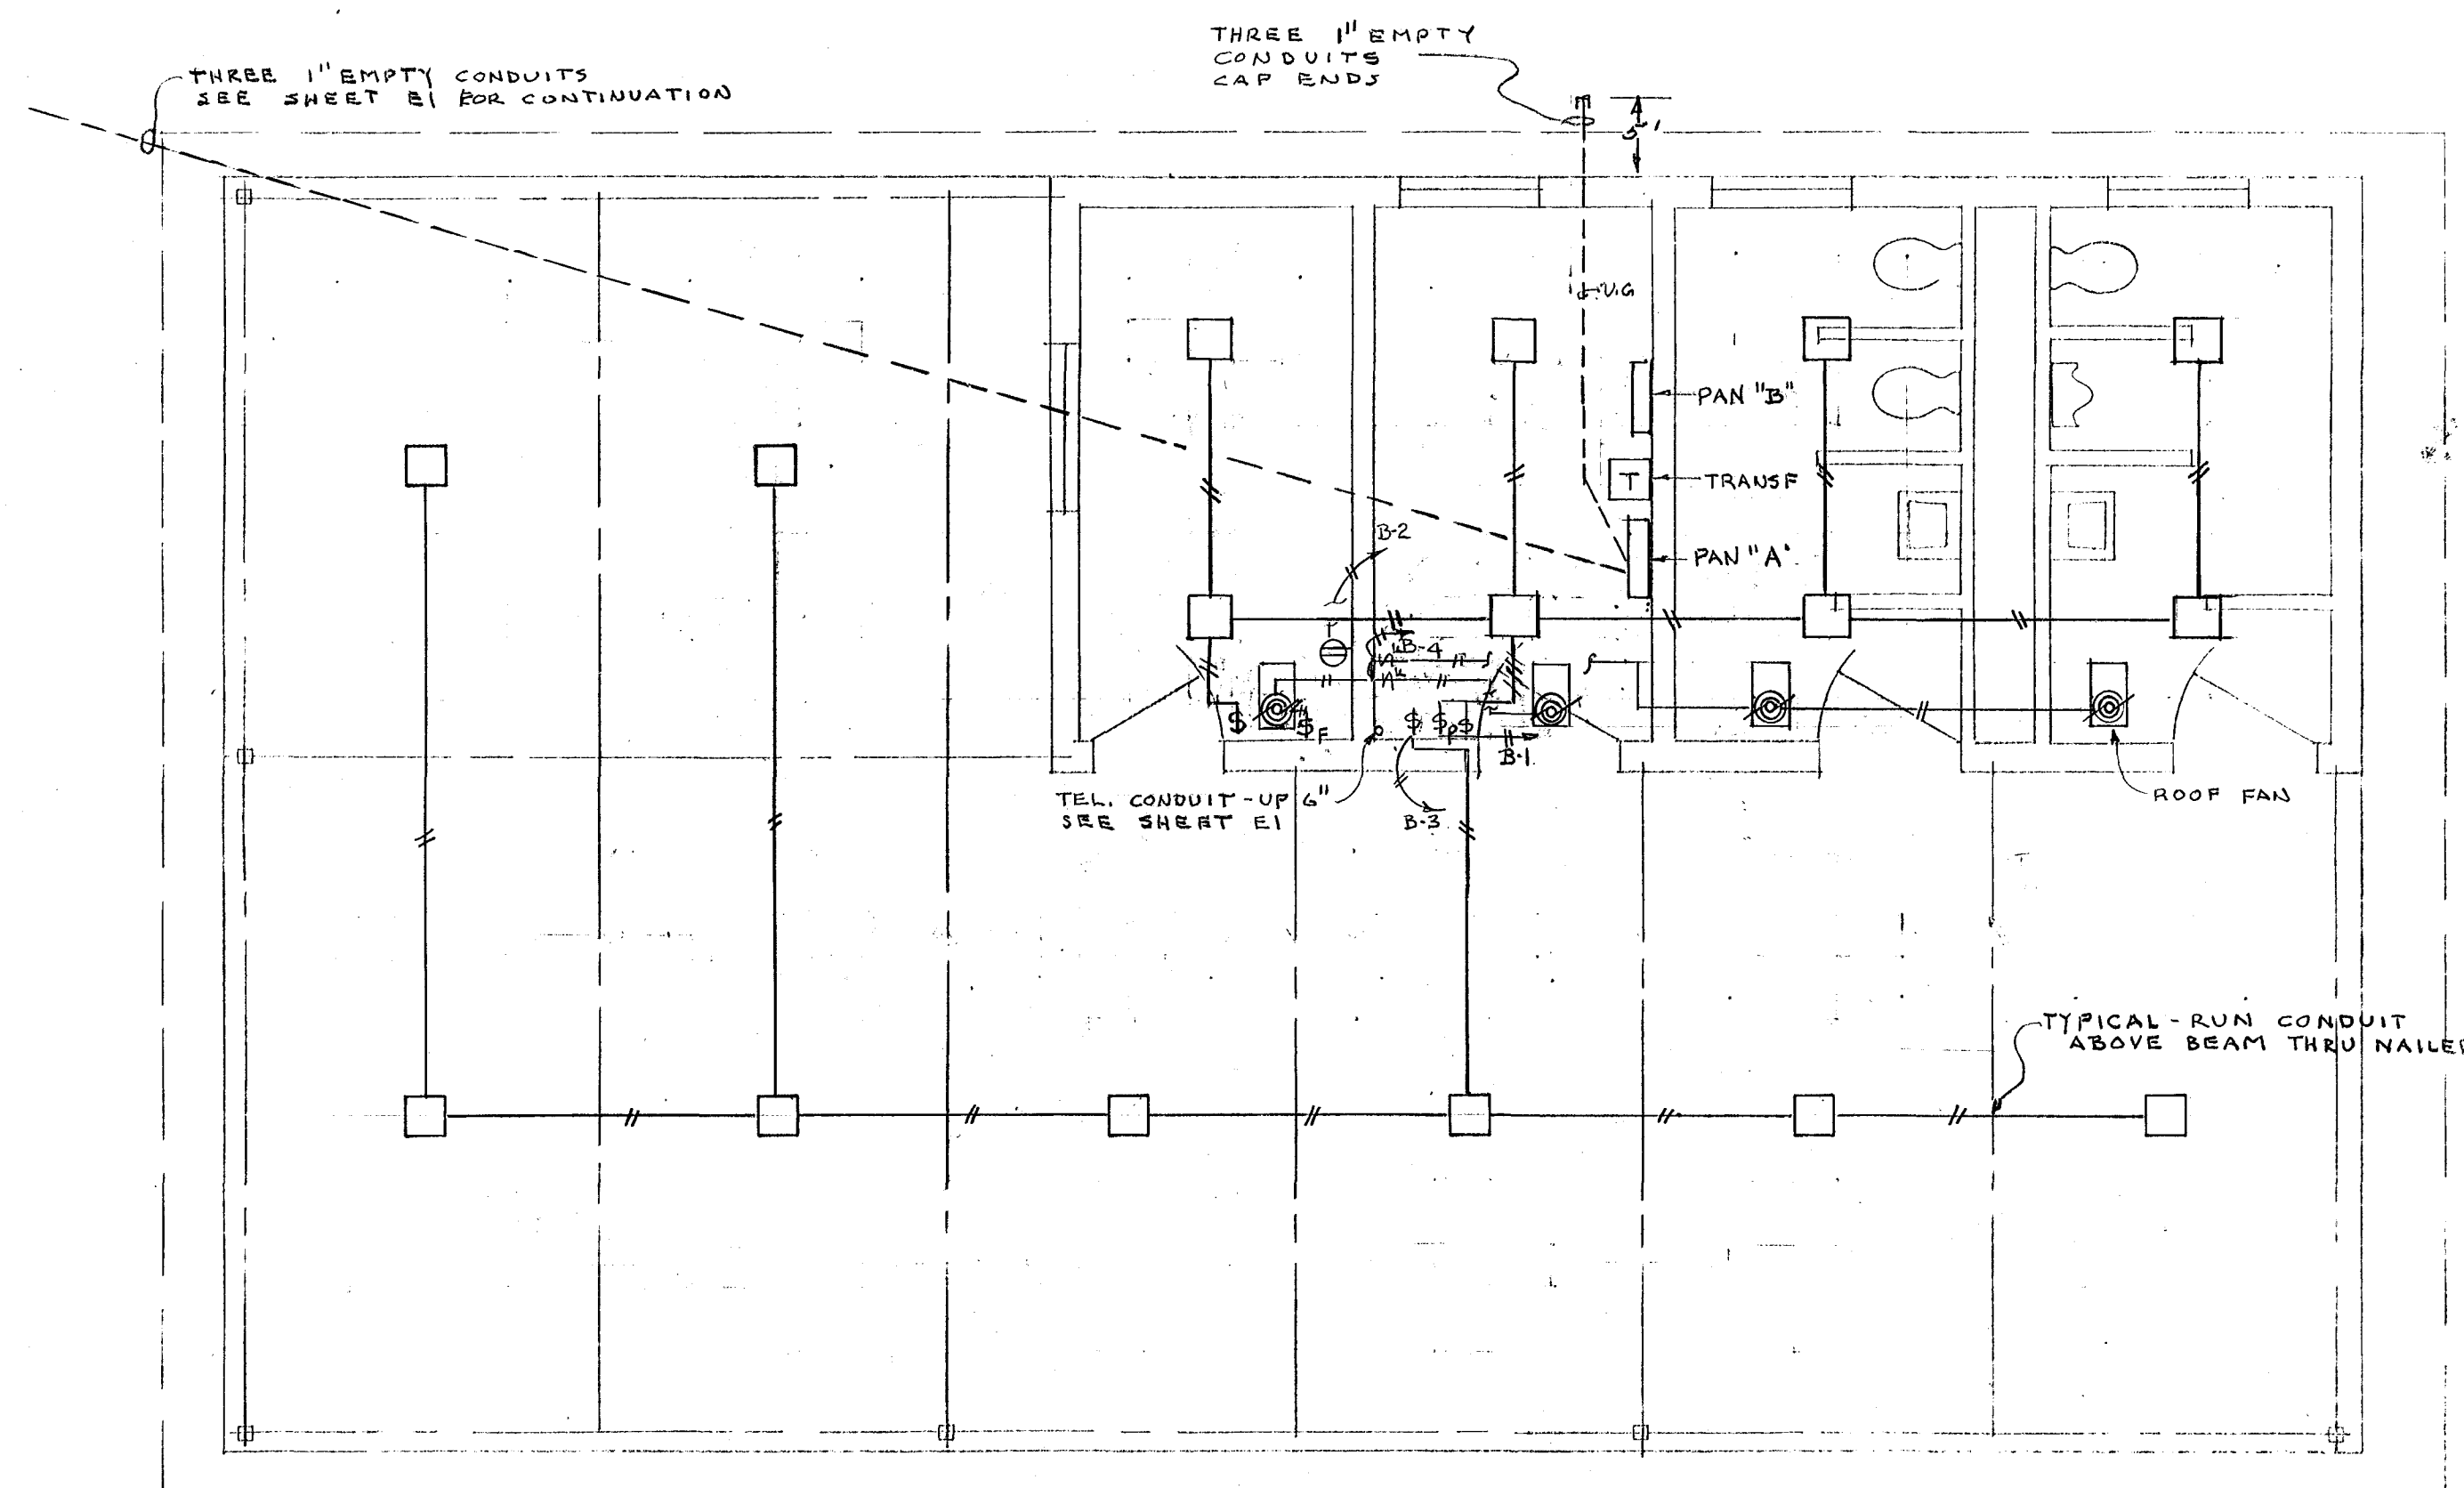

FLOOR PLAN ELECTRICAL

SCALE 1/4" = 1'-0"

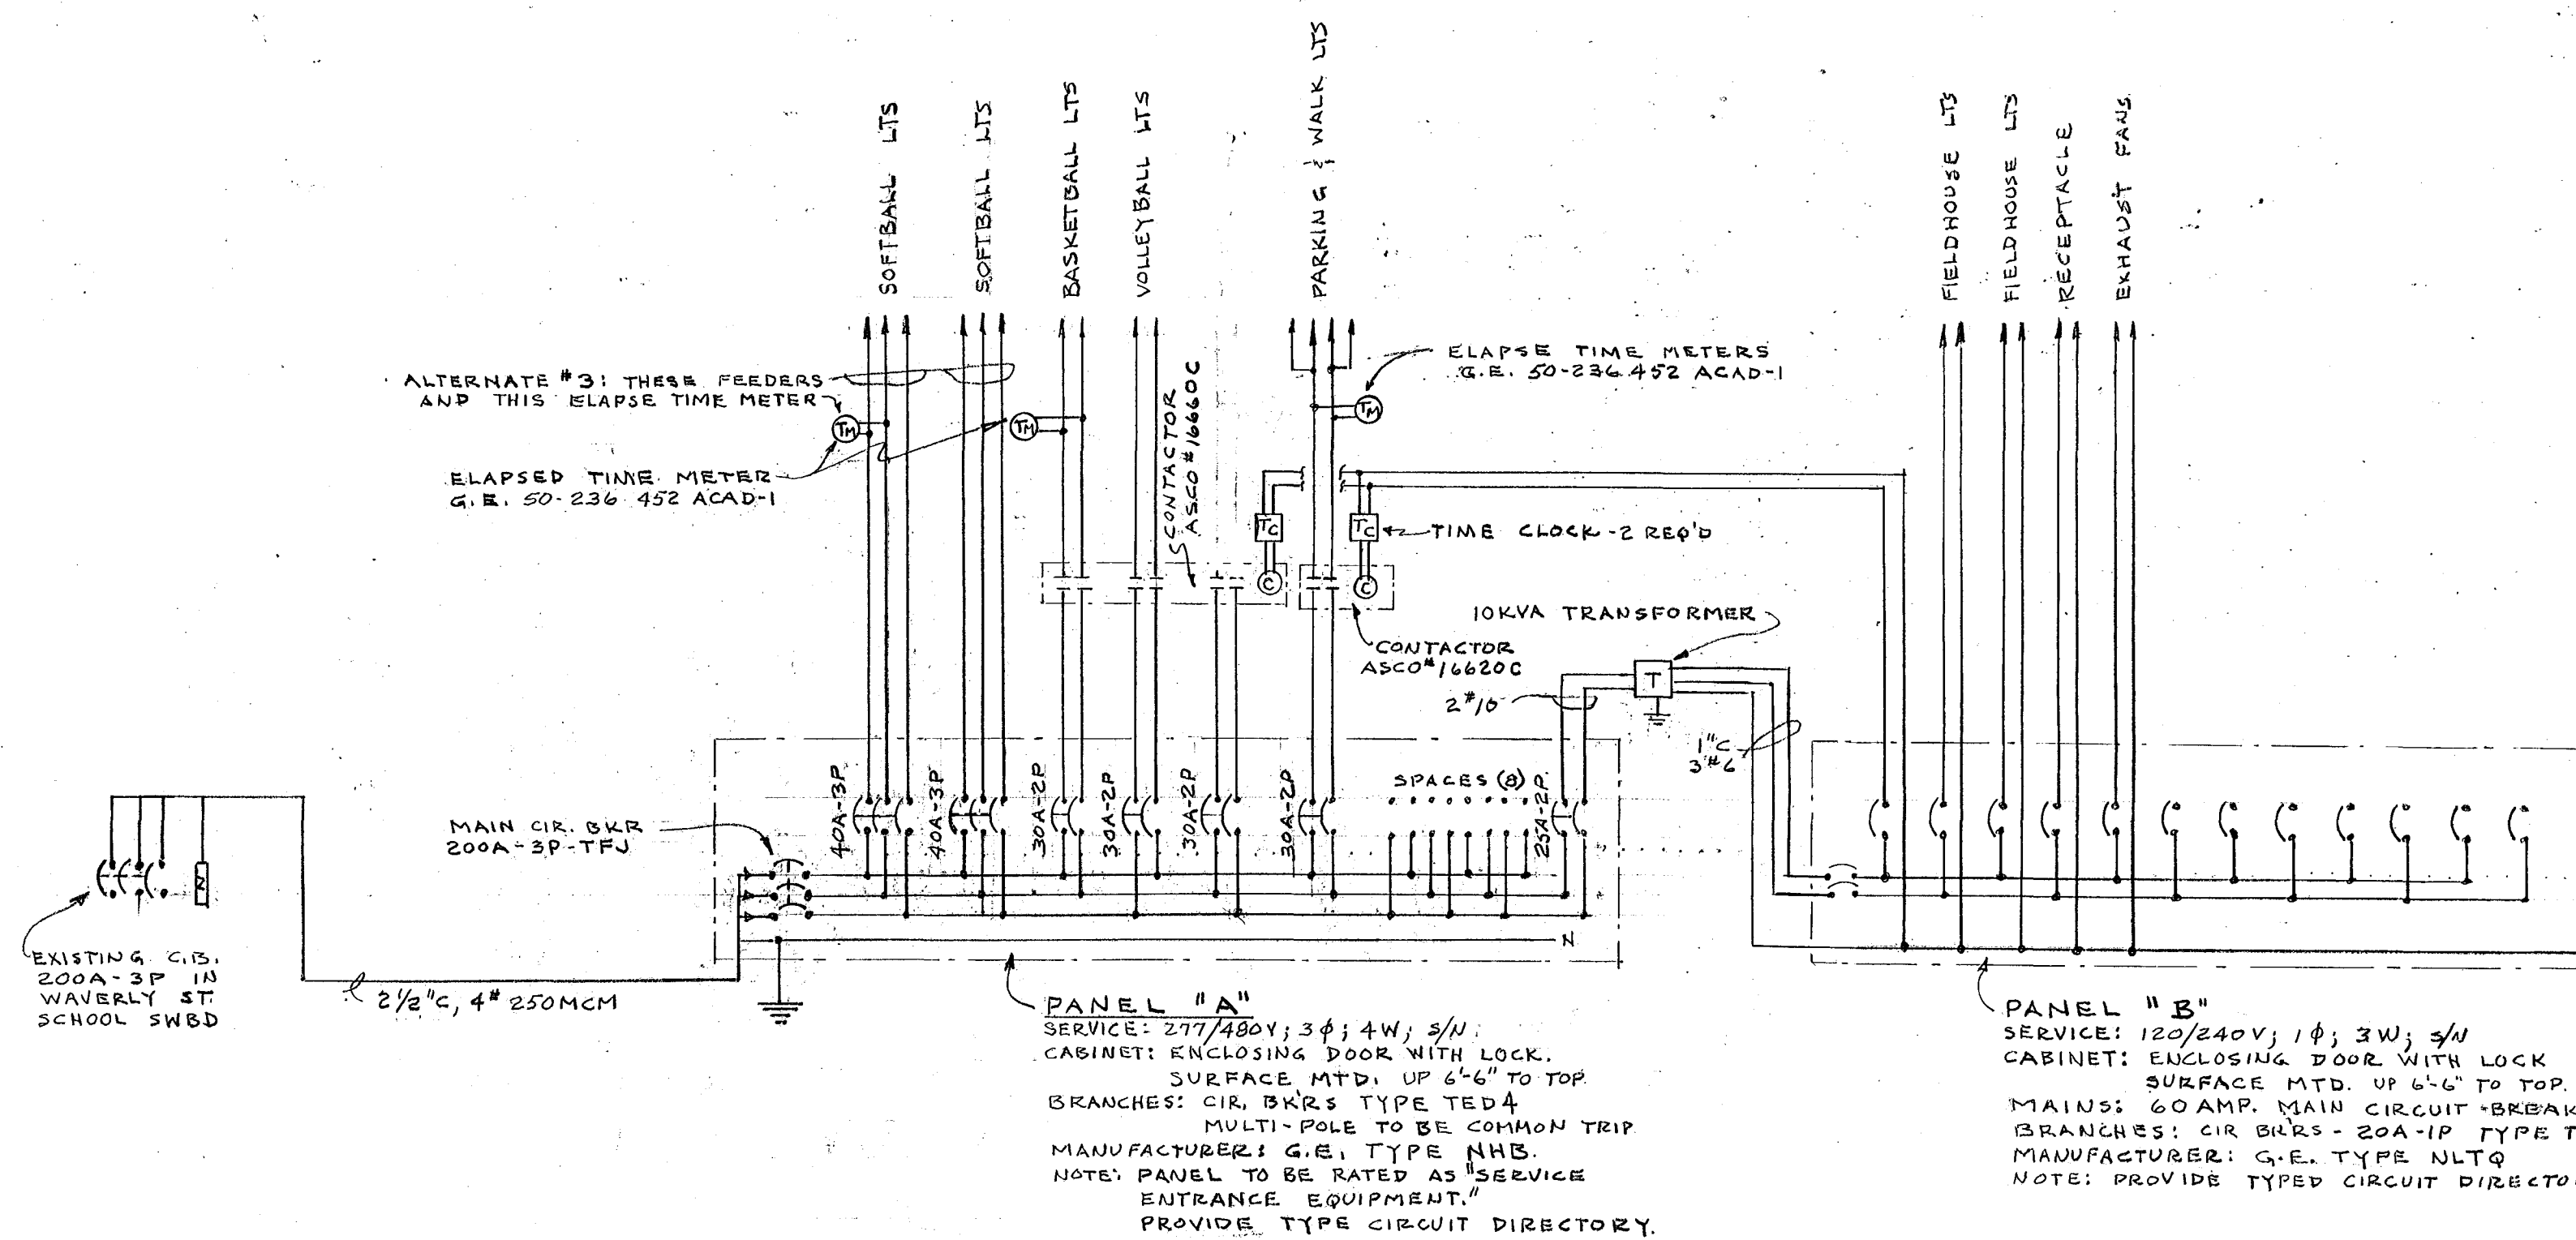

POWER RISER DIAGRAM

NO SCALE

SYMBOL	DESCRIPTION
□	INCANDESCENT FIXTURE - SURFACE MTD. - LAMPS 2-100 W/ KENALL #3808 WITH #3808A SURFACE ADAPTER. FIXTURE TO HAVE ONE YEAR GUARANTEE AGAINST VANDALISM
⊕	SINGLE POLE SWITCH - H.H.#1991 - UP 48"
⊕	SINGLE POLE SW. WITH PILOT LT. - H.H.#1991 #1720 - UP 48"
⊕	SINGLE POLE SW. WITH PILOT LT. FOR FAN - H.H.#1991 #1720 - UP 5'-6"
⊕	DUPLEX RECEPT - H.H.#5262 - UP 18"
⊕	ROOF EXHAUST FAN - NUTONE #RF-35 1/2" V.G. 58 GRILLE. ROOF MOUNTED - 310 CFM - 120 V. (NOTE: PROVIDED BY E.C.)
⊕	FLOODLIGHT POLE & FIXTURE - SEE POLE SCHEDULE.

CITY OF HARTFORD, CONNECTICUT DEPARTMENT OF PUBLIC WORKS BUREAU OF PUBLIC BUILDINGS		
FIELD HOUSE & LIGHTING AT WAVERLY FIELD IN KENY PARK HARTFORD, CONN.		DWG. NO. P-E 1
SUBMITTED <i>[Signature]</i> CITY ARCHITECT	RECOMMENDED <i>[Signature]</i> CITY ARCHITECT	APPROVED <i>[Signature]</i> CITY ARCHITECT
DRAWN <i>[Signature]</i> P.D.P.	CHECKED <i>[Signature]</i> R.S.B.	SCALE DAYBOOK NO. 010373-C DATE FEB. 14, 1973