


FIXTURE SCHEDULE

"A" - LITHONIA #8TAF240 - LAMPS (4) F40CW - STEM MTD
B - CROUSE-HIND #VXHF22G - LAMP 200W LF - CEILING MTD

SYMBOL LIST

- FLUORESCENT FIXTURE
- CEILING OUTLET OR FIXTURE
- SINGLE POLE SW - H#H*1991 ~ UP 4'-0"
- THREE WAY SW - H#H*1993 ~ UP 4'-0"
- OIL BURNERS EMERG. SW - H#H*1992 - UP 5'-6"
- MANUAL MOTOR STARTER W/PILOT - AH#H*RL-11-PL ~ UP 5'-0" (BY THIS E2)
- PRESSURE SW'S -
- DUPLEX RECEPT - H#H*5262 ~ UP 4'-0"
- MOTOR.

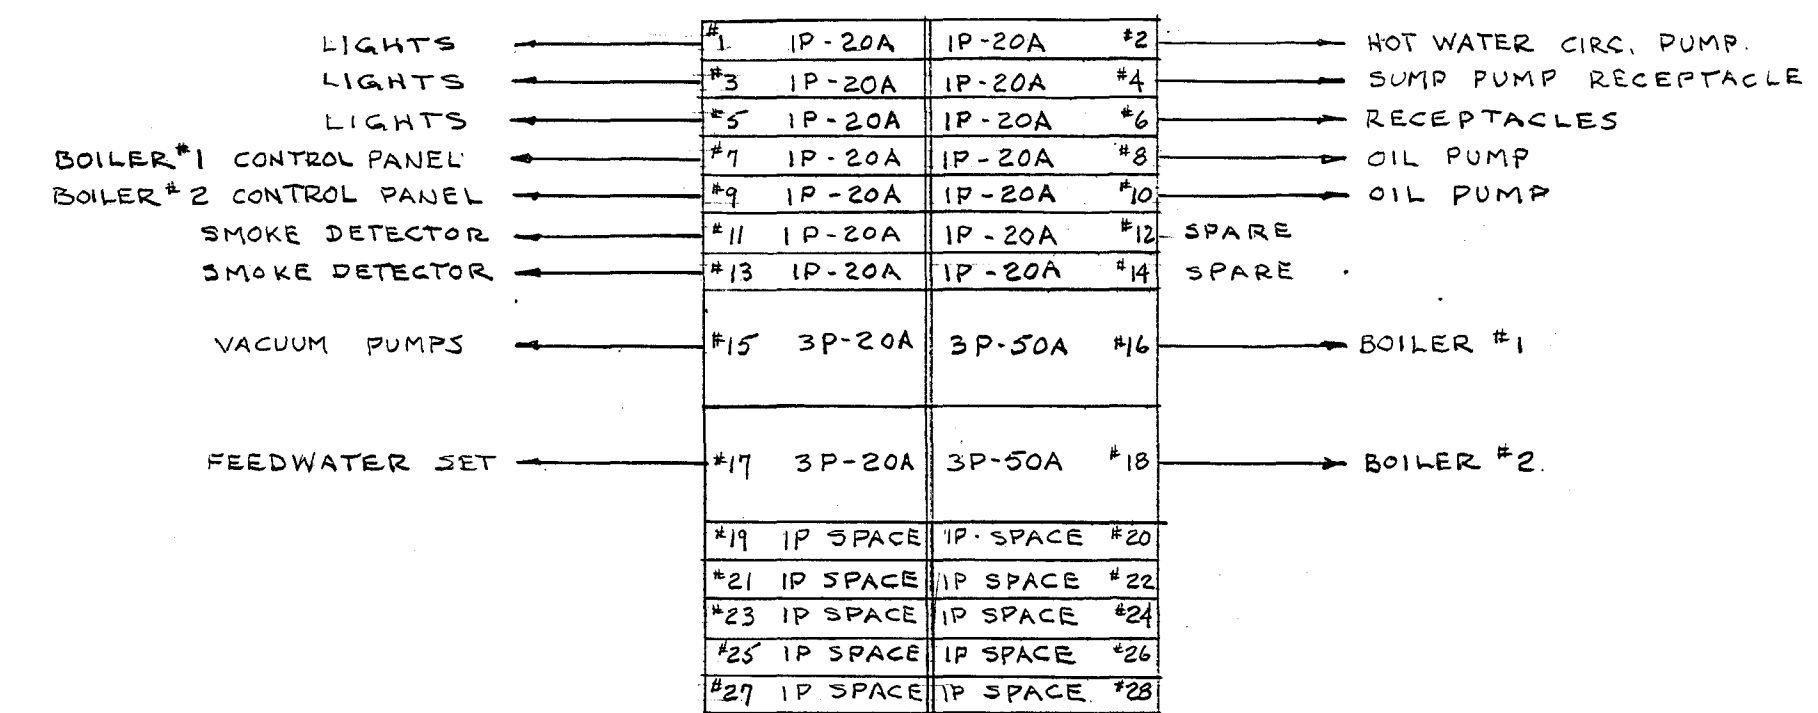


SPEC.

SERVICE: 120/208V - 3Ø-4W
MAINS: 200 AMP LUGS.
CABINET: USE EXIST. PANEL BOX. PROVIDE NEW INTERIOR & COVER WITH DOOR AND TYPED CIRCUIT DIRECTORY
BRANCHES: AS SHOWN ABOVE. MULTIPLE-POLE BRANCHES TO BE COMMON-TRIP.
MANUFACTURER: G.E. TYPE NLAB

NOTE: THE EXISTING FEEDER FOR THE GYM PASSES THRU THIS PANELBOARD CABINET. THIS FEEDER FOR GYM IS TO REMAIN.


PANEL "BR" DETAILS

NO SCALE

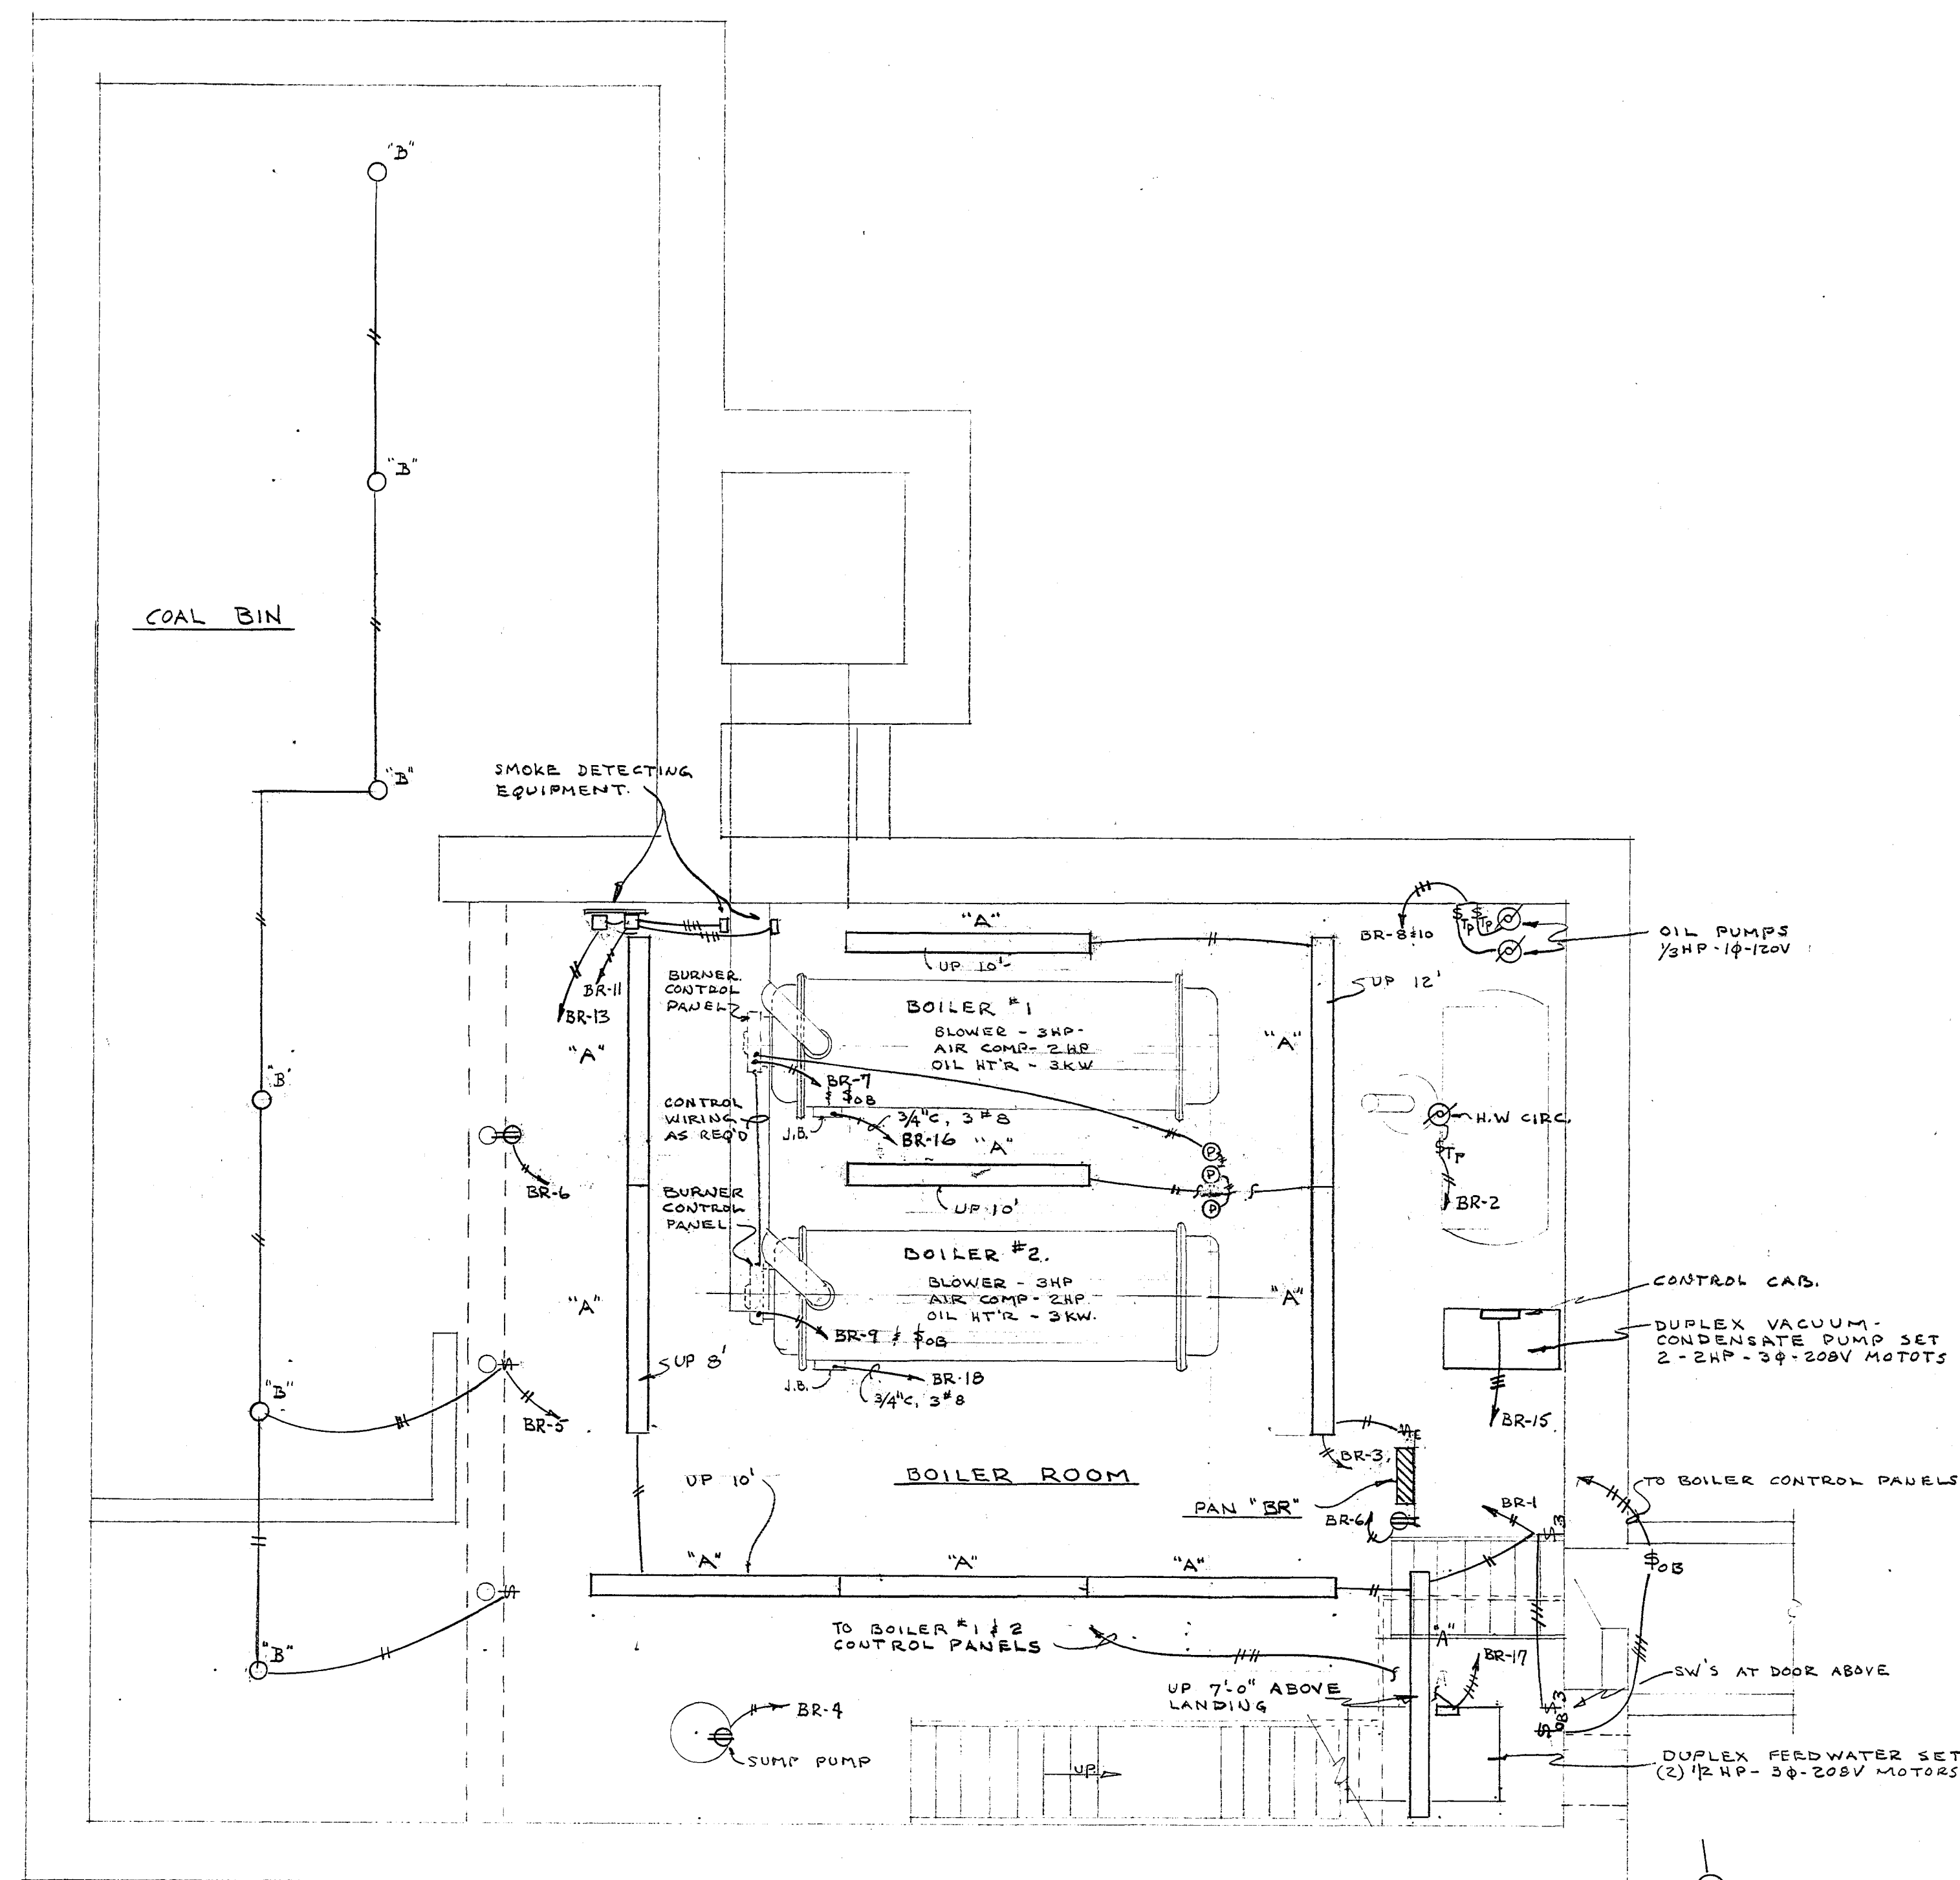

FLOOR PLAN

1/4" = 1'-0"

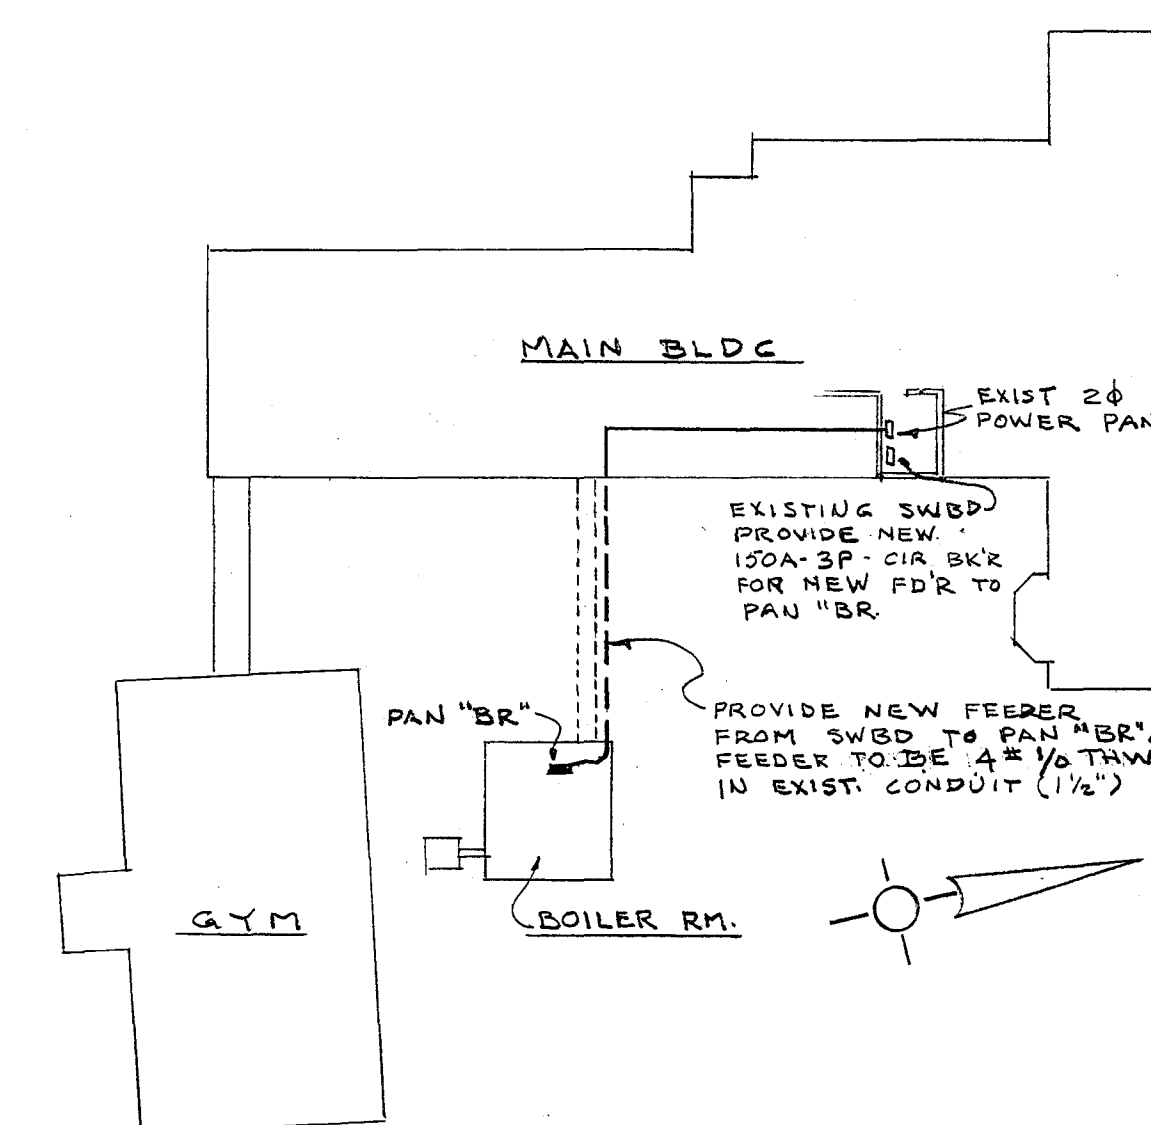

PLOT PLAN

1" = 50'

ELECTRICAL

VERIFY EXISTING CONDITIONS AND DIMENSIONS AT BUILDING

CITY OF HARTFORD, CONNECTICUT
DEPARTMENT OF PUBLIC WORKS
BUREAU OF PUBLIC BUILDINGS

BOILER REPLACEMENT
WEST MIDDLE SCHOOL
927 ASYLUM AVE.
HARTFORD, CONN.

SUBMITTED: R.H. BROWN
RECOMMENDED: WALTER H. BROWN
APPROVED: GEORGE C. HAYES
CITY ARCHITECT: ASSIST. CITY ENG.

SCALE: DAYBOOK NO. 010389-C
DRAWN: R.G.B.
CHECKED: R.G.B.
AS NOTED
DATE: MAY 3, 1973