



FIXTURE SCHEDULE

TYPE	MANUFACTURER & CATALOG NO	LAMP	REMARKS
A	WIDE-LITE #FS-400-C-AL-4-F	400W-HPS	MTG-SEE DETAIL BELOW
B	WIDE-LITE #FS-400-D-AL-4-F-SK40	400W-HPS	" " " "
C	WIDE-LITE #FS-400-C-AL-4-F-SK40	400 W-HPS	" " " "

NOTES:
1. ALL BALLASTS TO 120V. REGULATING TYPE, -20°F OPERATION.
2. AIMING SHALL BE AS DIRECTED BY THE CITY.

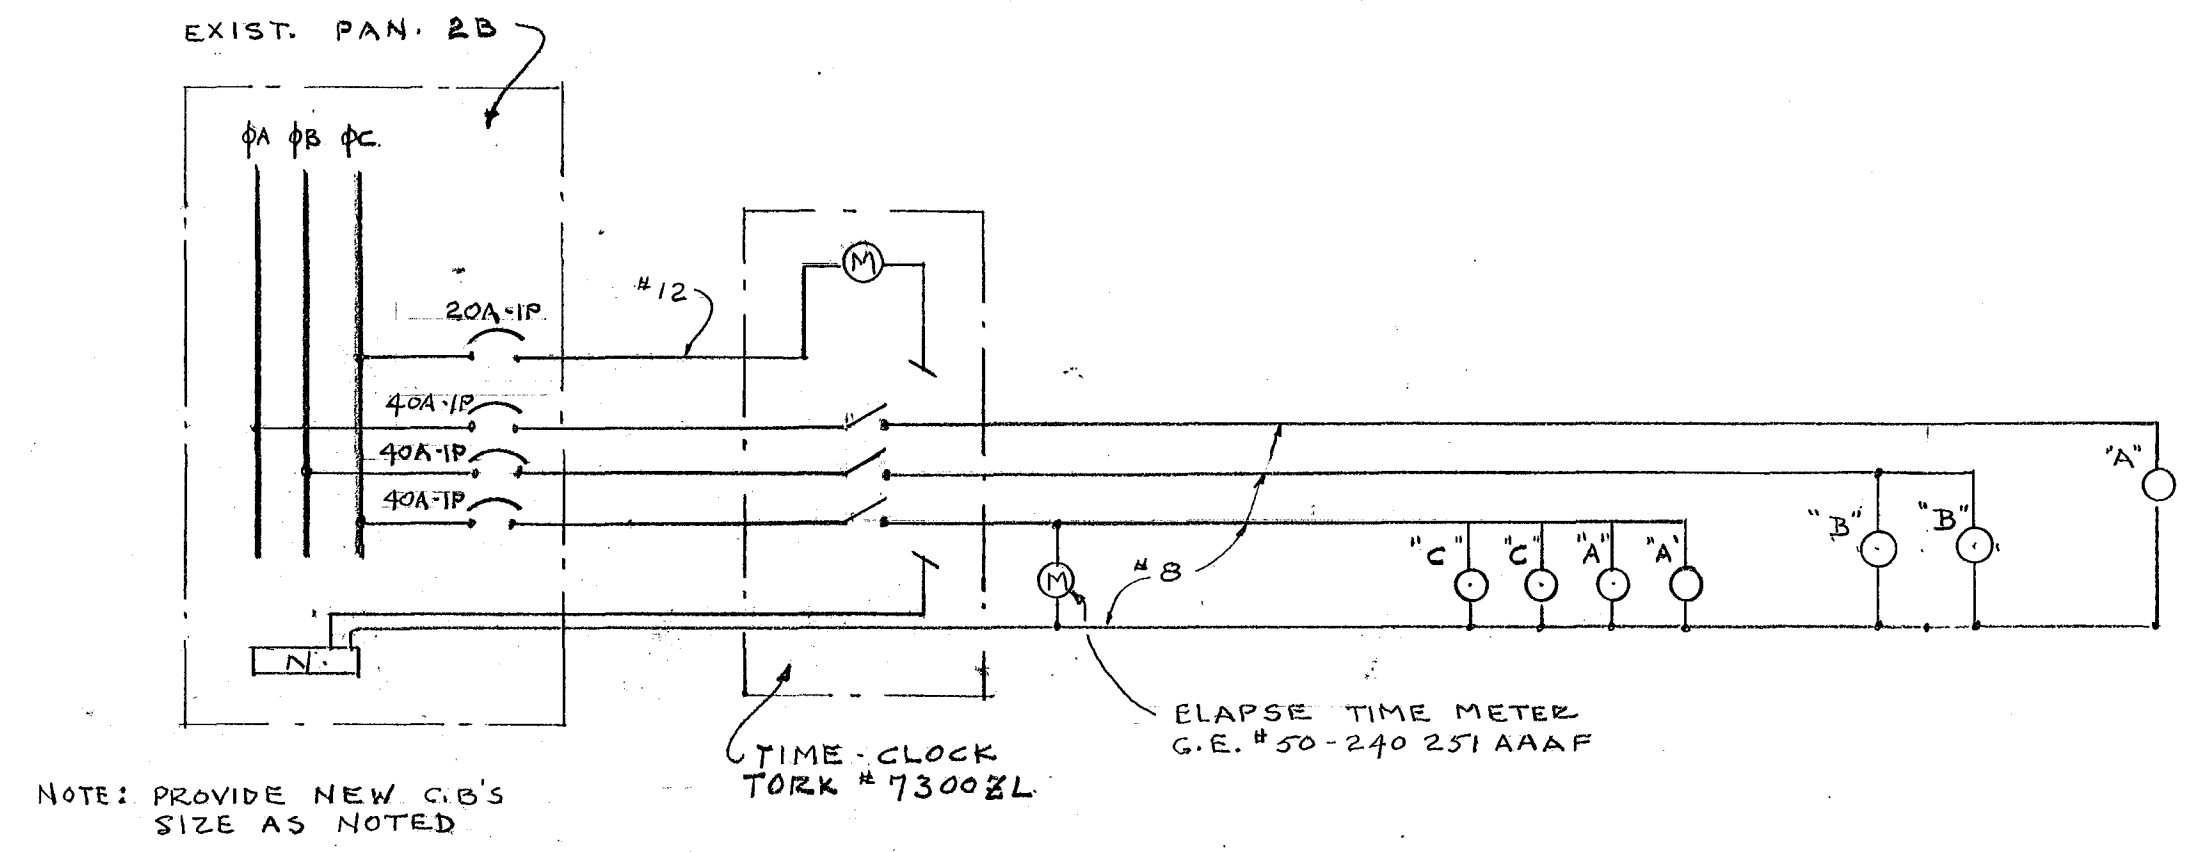

POWER RISER DIAGRAM
N.T.S.

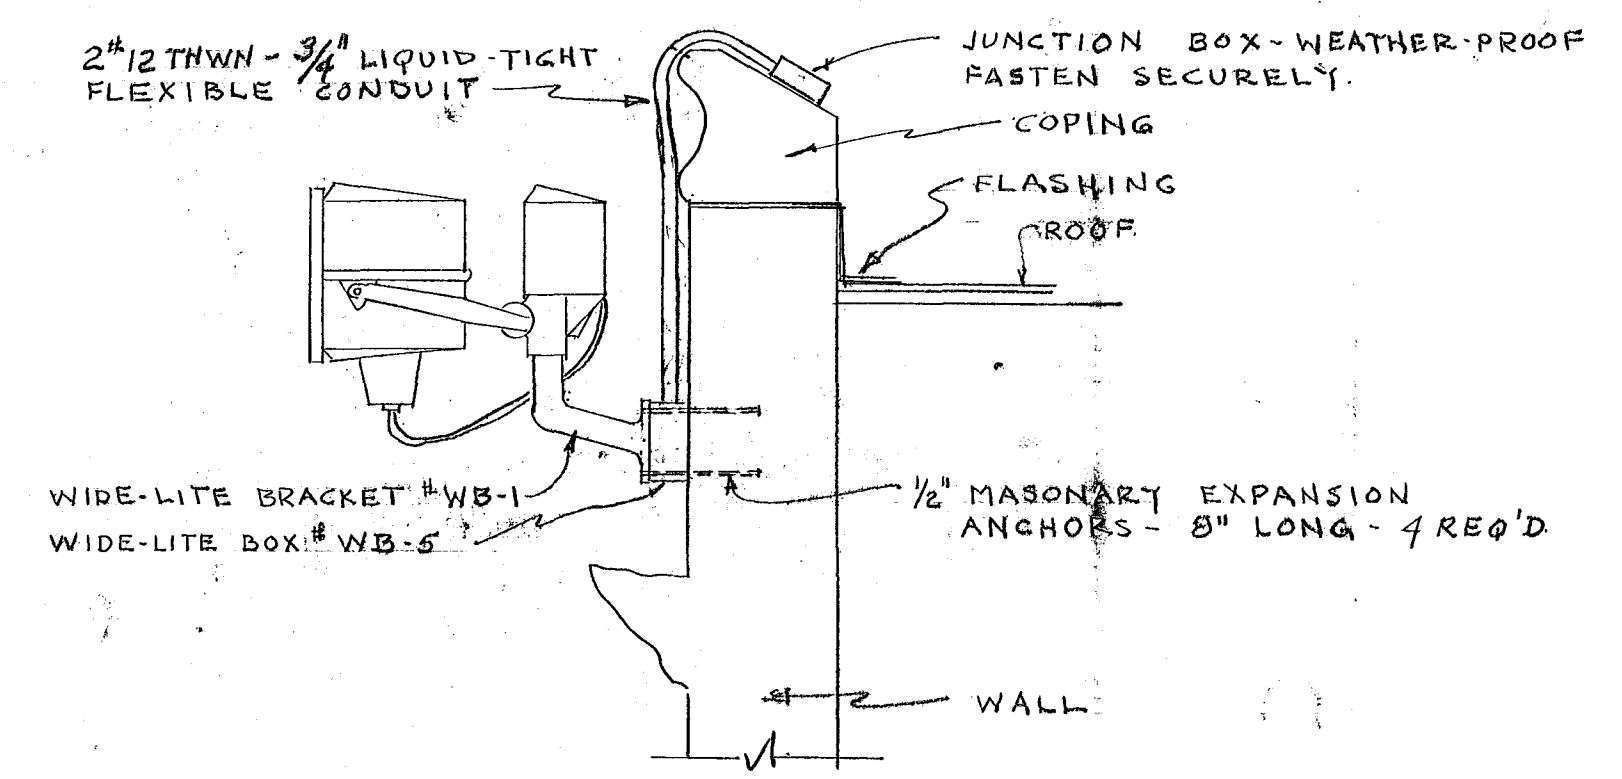

NOTE: DO NOT PUNCTURE ROOF OR FLASHING

FIXTURE MOUNTING DETAIL
NO SCALE

CITY OF HARTFORD, CONNECTICUT DEPARTMENT OF PUBLIC WORKS BUREAU OF PUBLIC BUILDINGS		
SITE LIGHTING SARAH J. RAWSON SCHOOL 260 HOLCOMB STREET HARTFORD CONNECTICUT		
SUBMITTED R. G. B.	RECOMMENDED W. H. Reed	APPROVED J. H. Hopper
DRAWN R.G.B.	CITY ARCHITECT	ASSISTANT CITY ENG.
CHECKED	SCALE	DAYBOOK NO. 010587B
DATE FEB. 4, 1977		

SHEET NO
2
OF 2 SHTS

88
RES