



NOTE 1.
 DUPLEX RECEPT. H&H # 5262 IN CAST BOX.
 6 REQ'D. EACH ON A SEPARATE CIRCUIT
 FED FROM PANEL "CD1". RECEPT 18" FROM
 PANEL & 18" O.C. UP 4'-0" ABOVE FLOOR

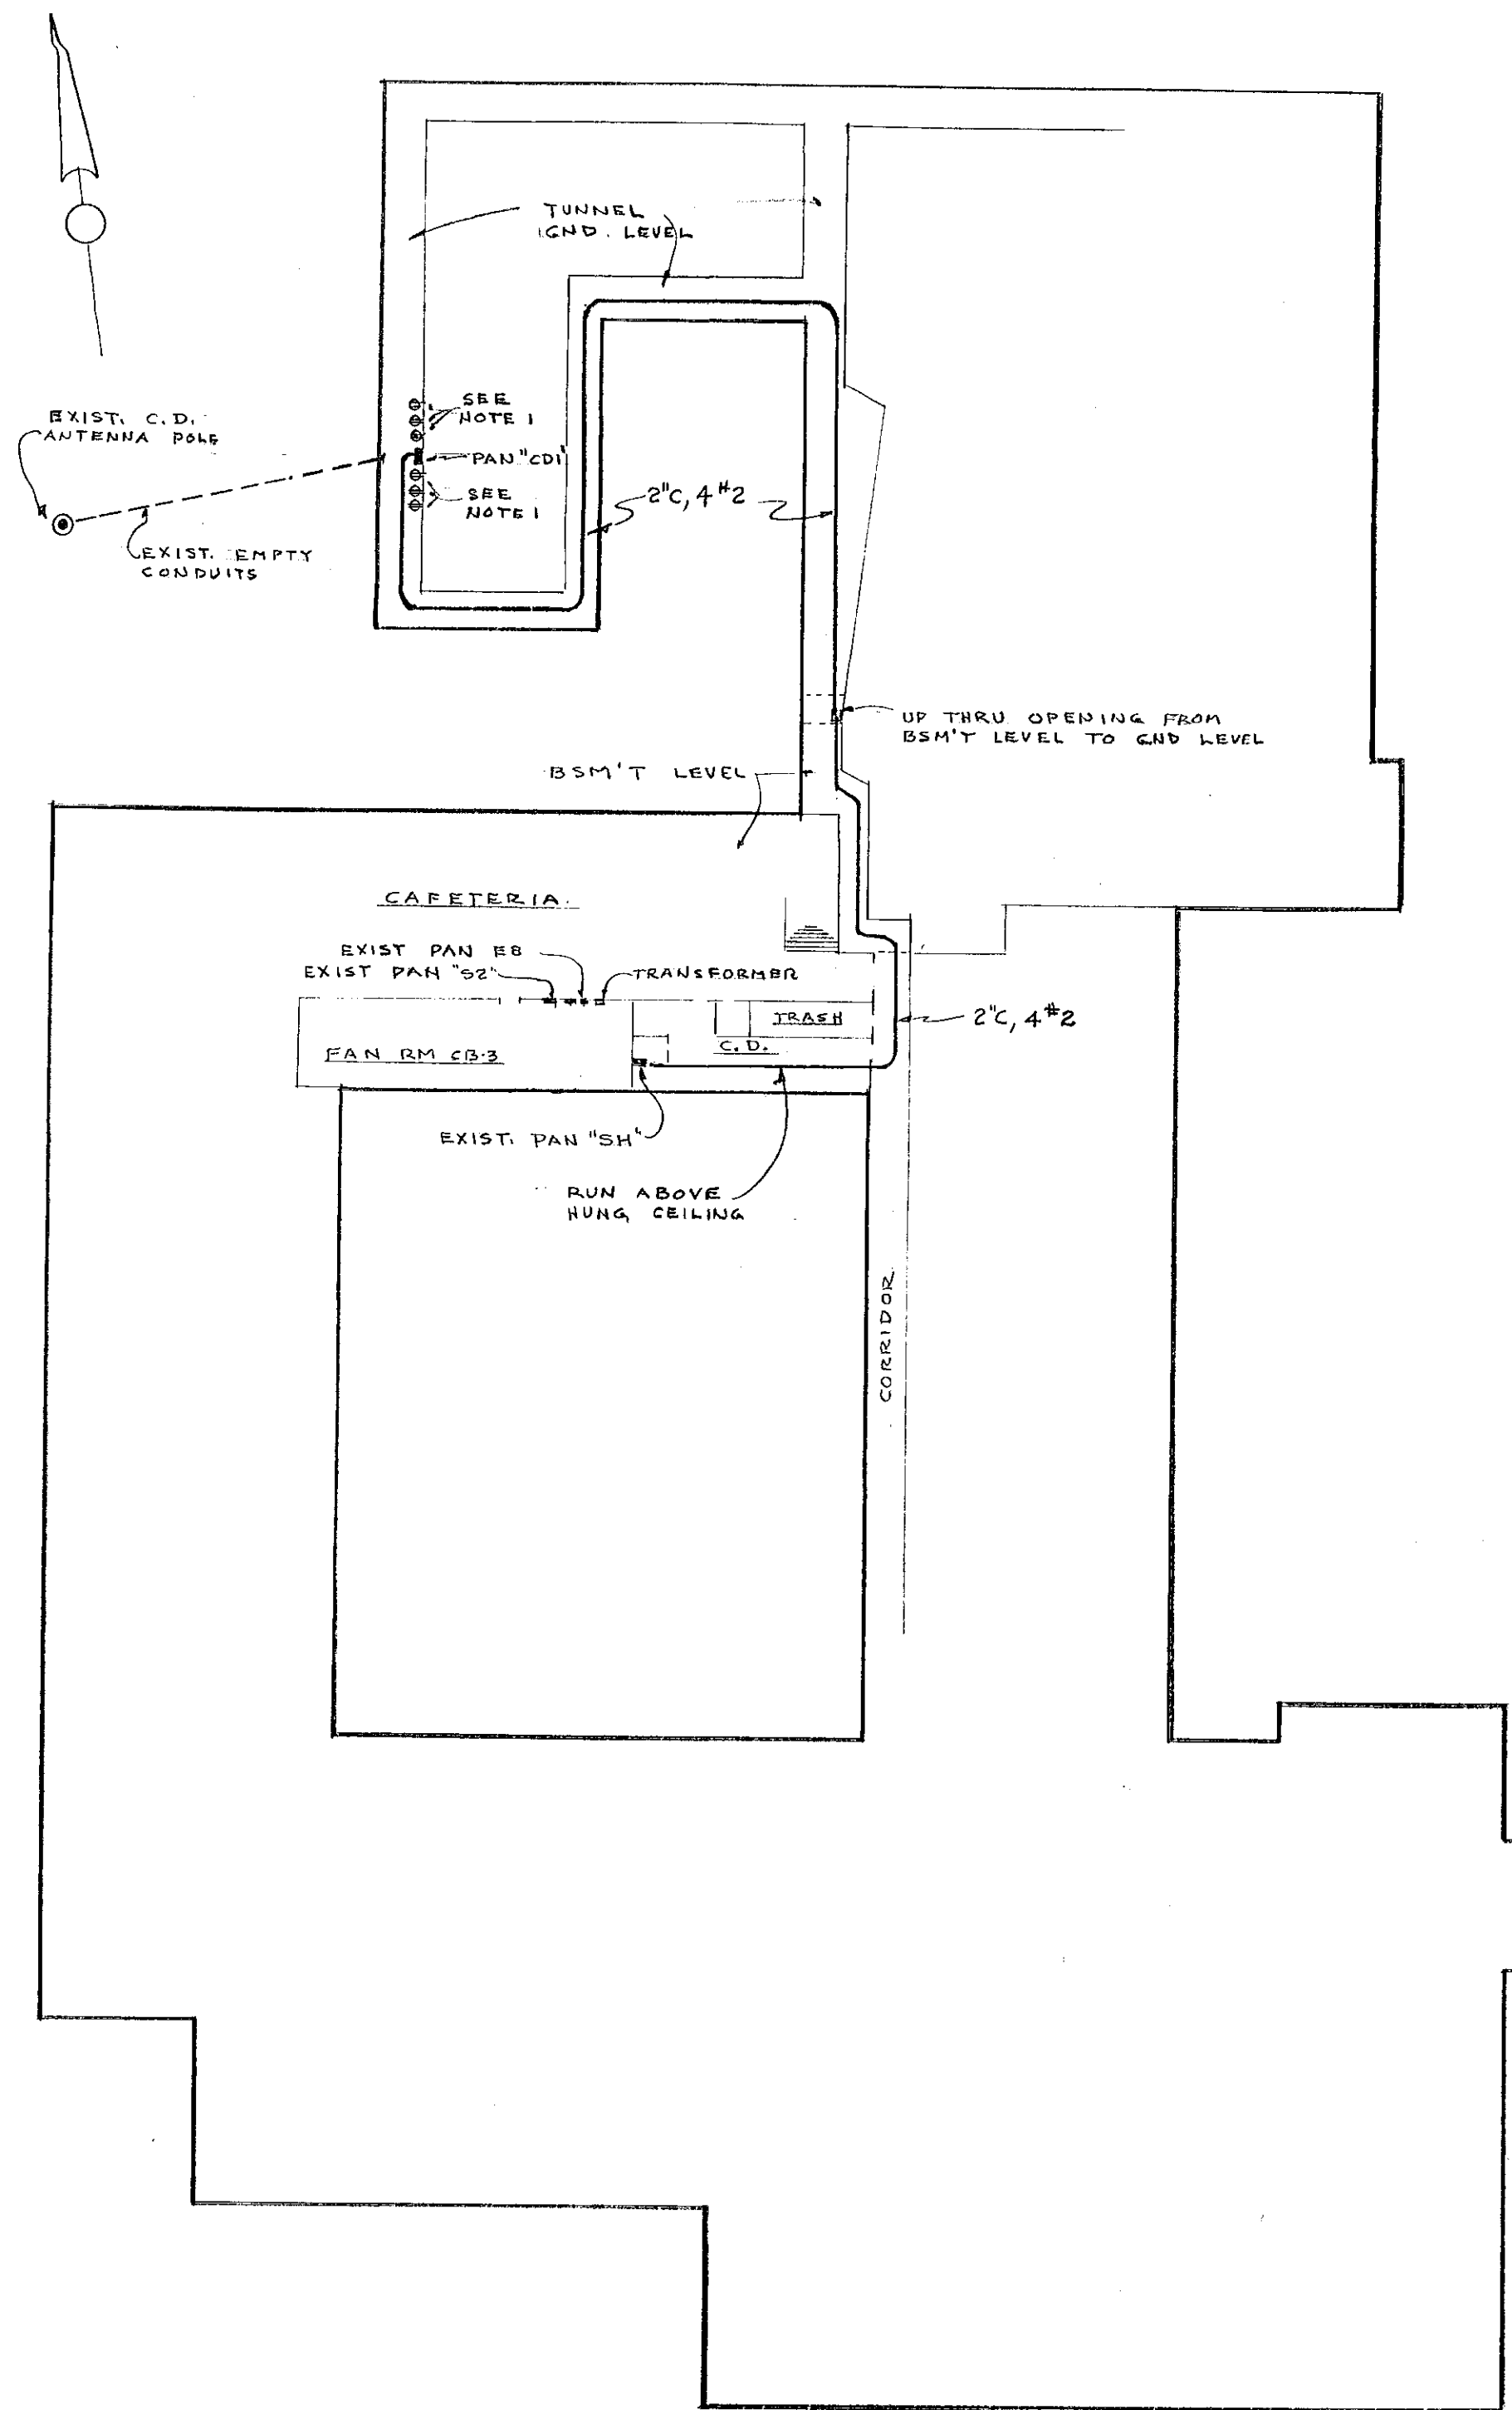


KEY PLAN

SCALE 1" = 40'

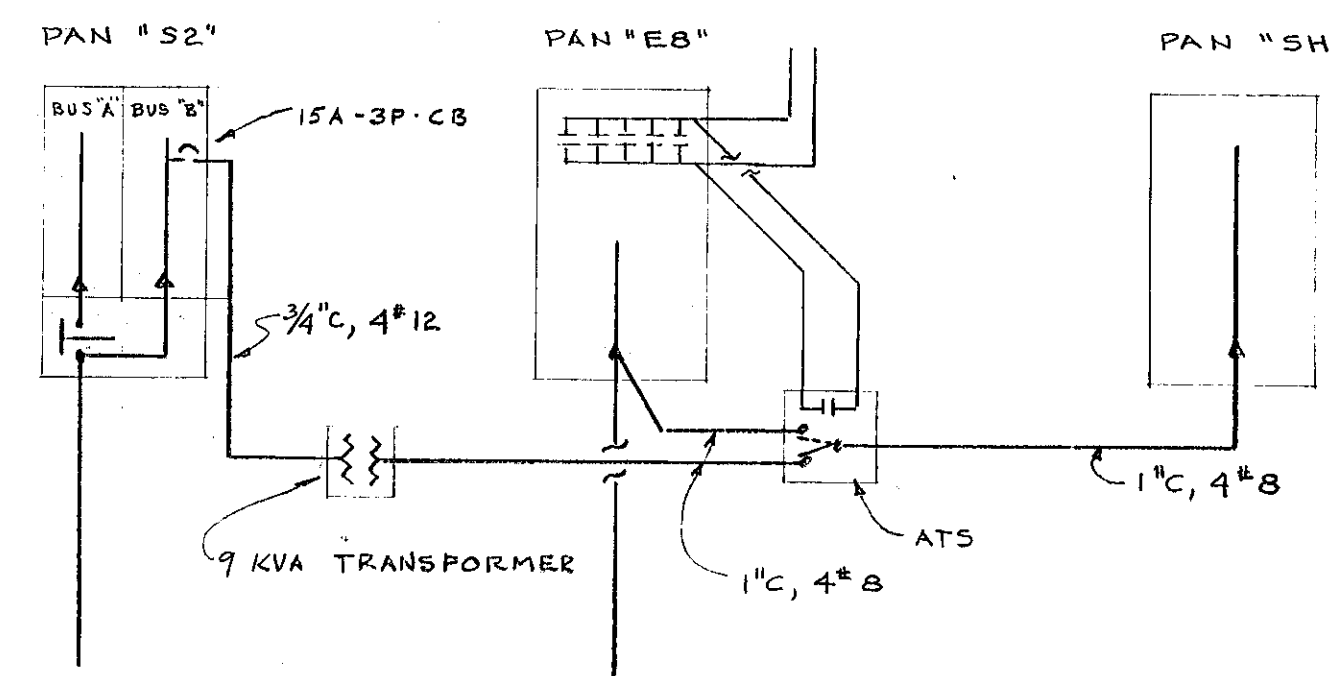


EXISTING POWER RISER DIAGRAM

NO SCALE

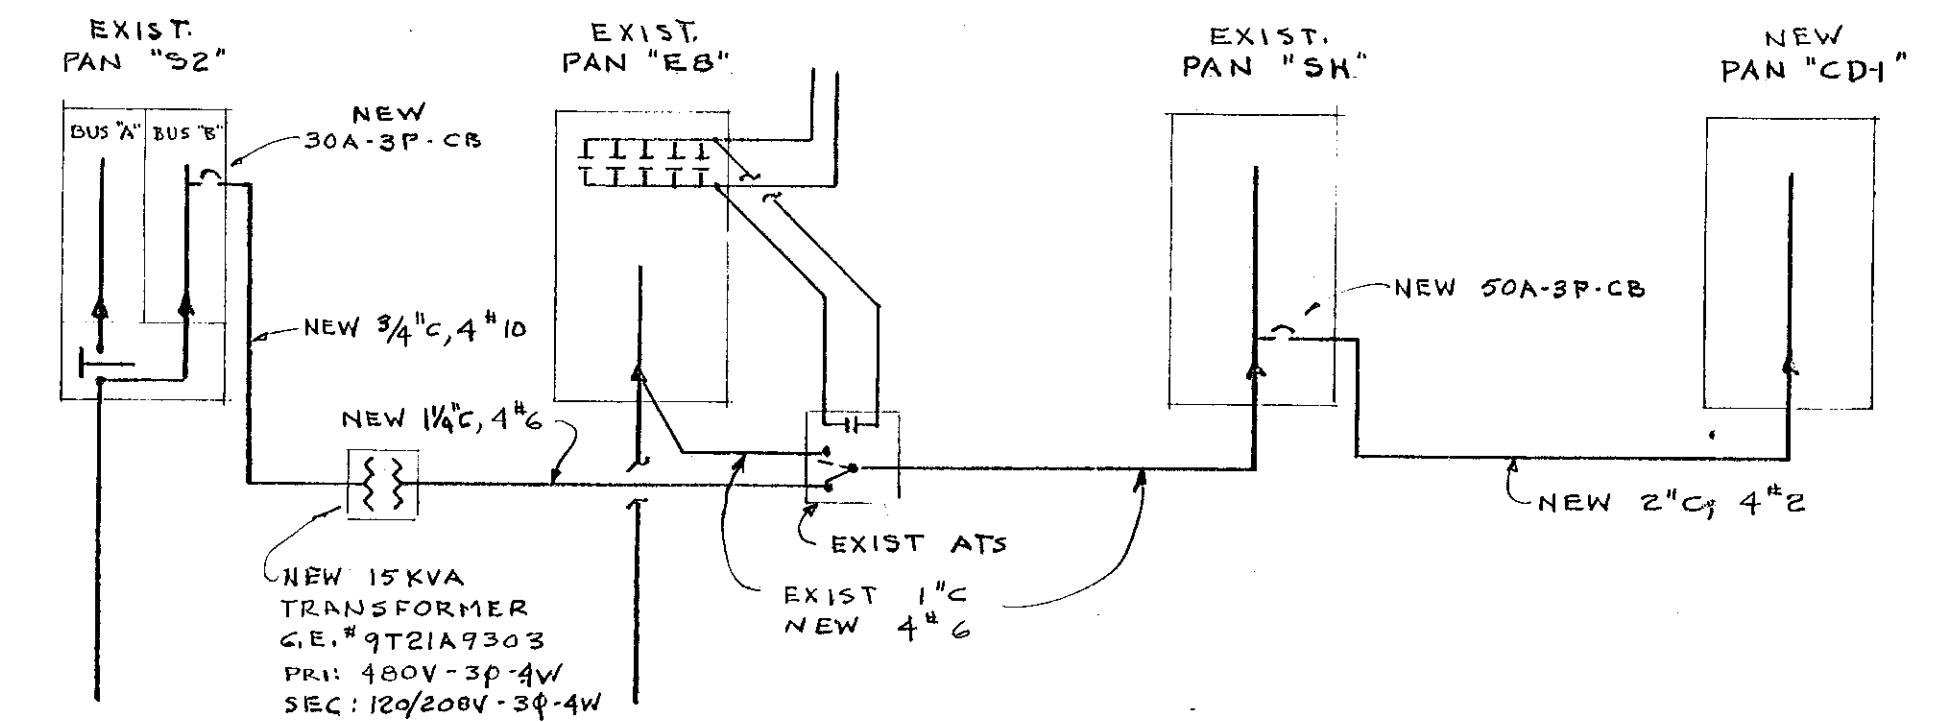

REVISED POWER RISER DIAGRAM

NO SCALE

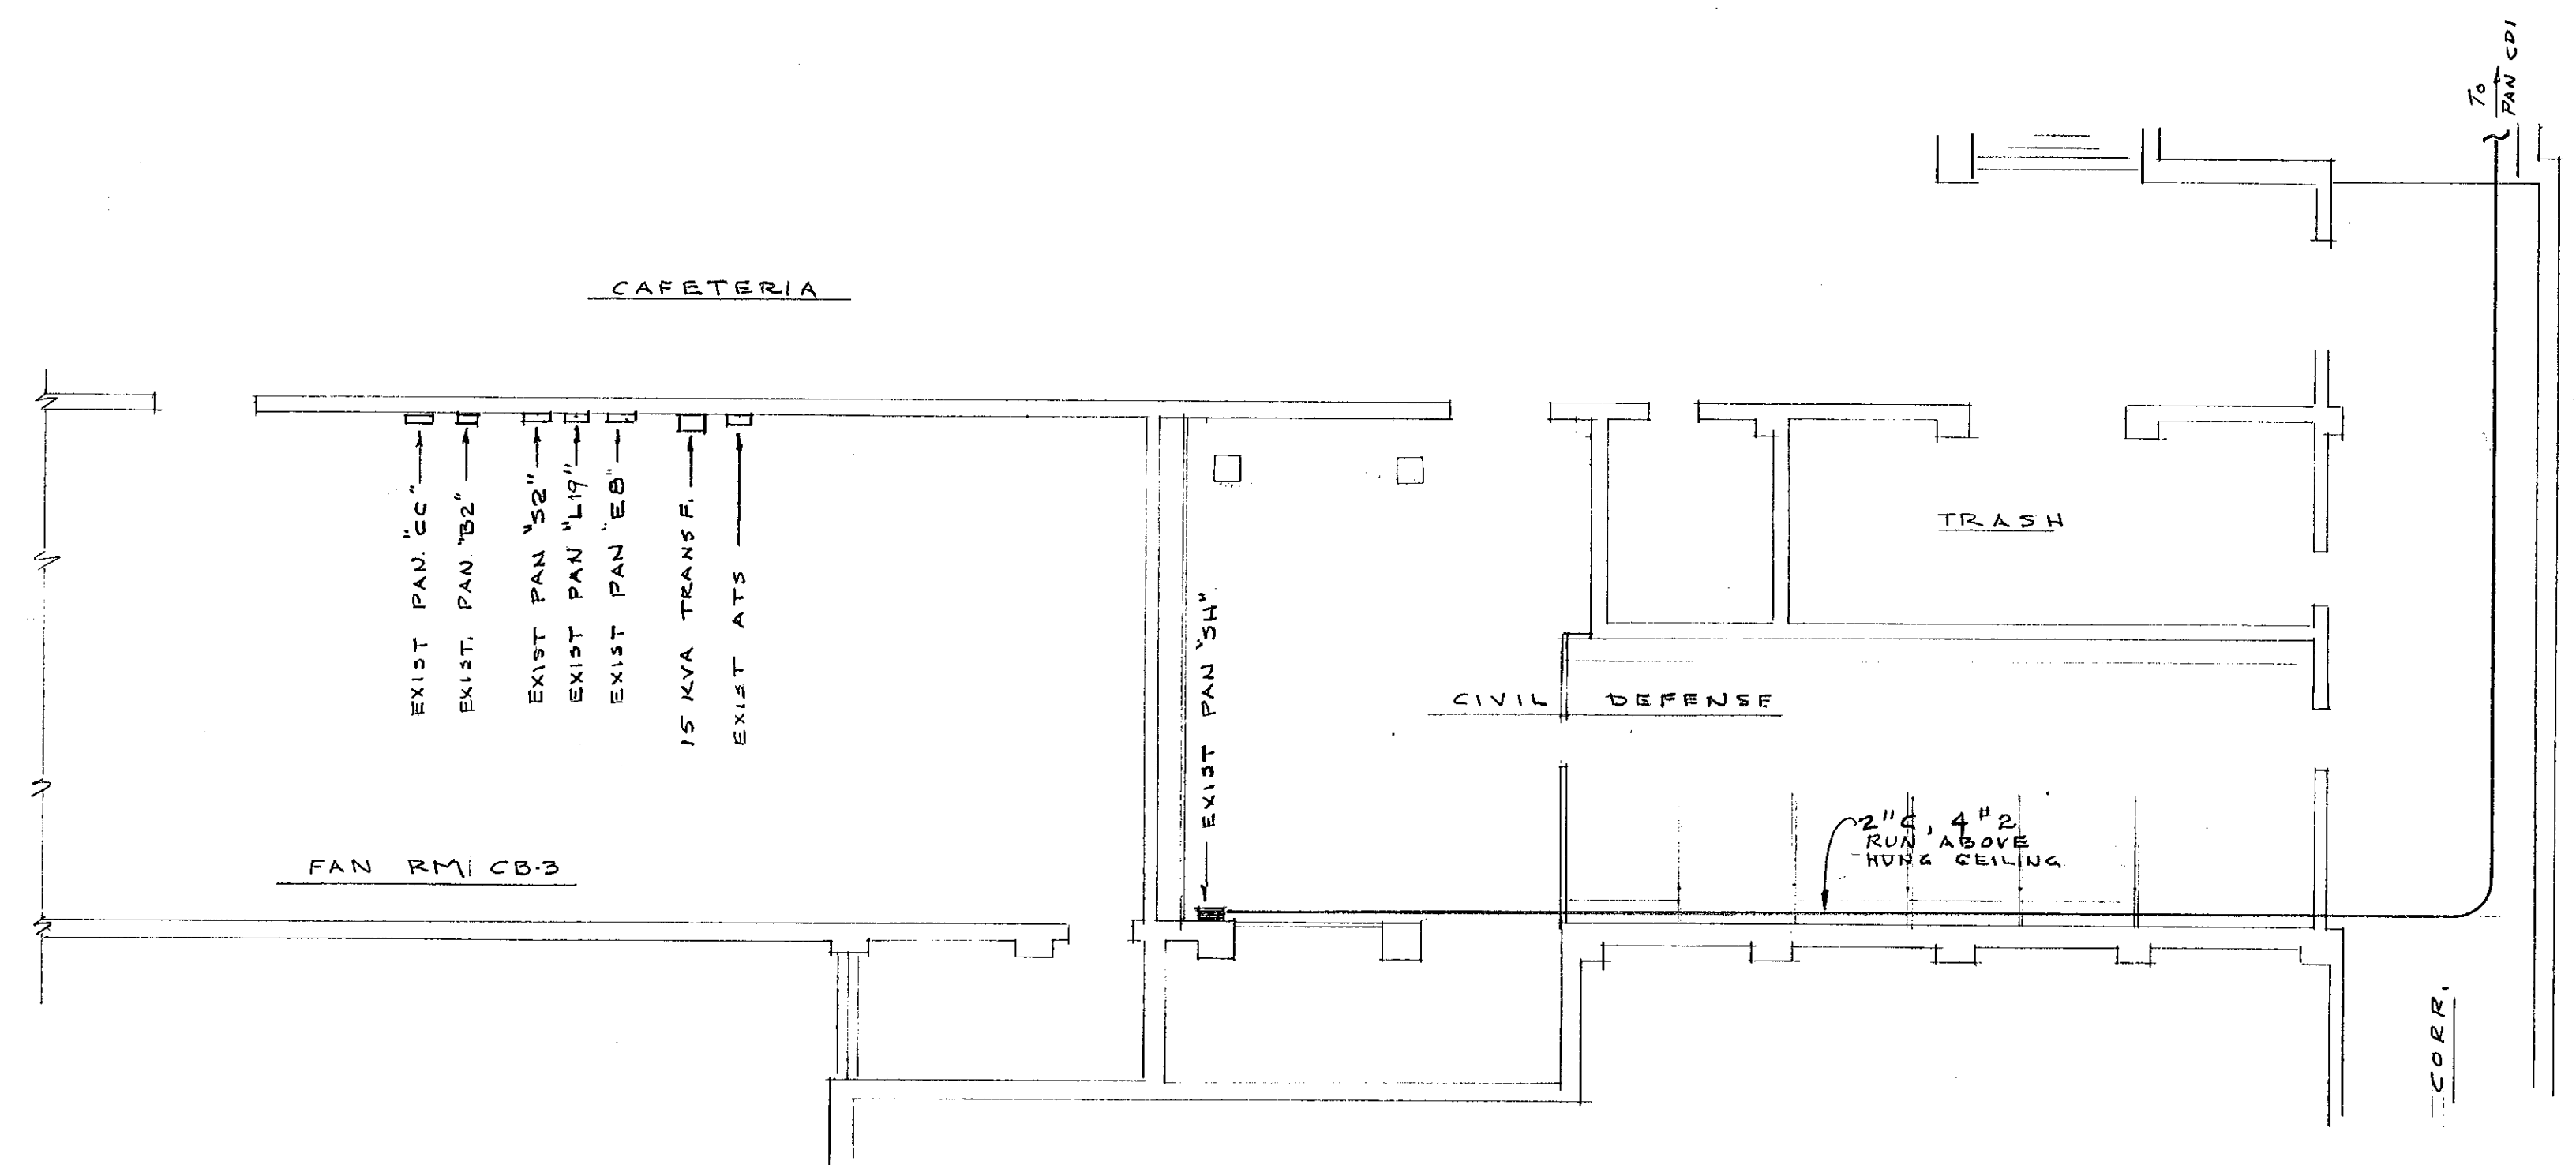

PART PLAN - CIVIL DEFENSE AREA

SCALE 1/8" = 1' - 0"

VERIFY EXISTING
 CONDITIONS AND
 DIMENSIONS AT
 BUILDING

CITY OF HARTFORD, CONNECTICUT DEPARTMENT OF ENGINEERING			DWG. No.
ELECTRICAL POWER FOR C.D. TRANSMITTERS			E1
HARTFORD PUBLIC HIGH SCH. FOREST ST., HARTFORD CONN.			
SUBMITTED	RECOMMENDED	APPROVED	
<i>R.B. Cannon</i> CITY ARCHITECT	<i>David A. Tassillo</i> CITY ARCHITECT	<i>George E. Hoffman</i> CITY ENGINEER	
DESIGN <i>R.G.B.</i>	DRAWN <i>R.G.B.</i>	DAYBOOK No. 10148	
TRACED	CHECK	DATE JAN. 23, 1970	