




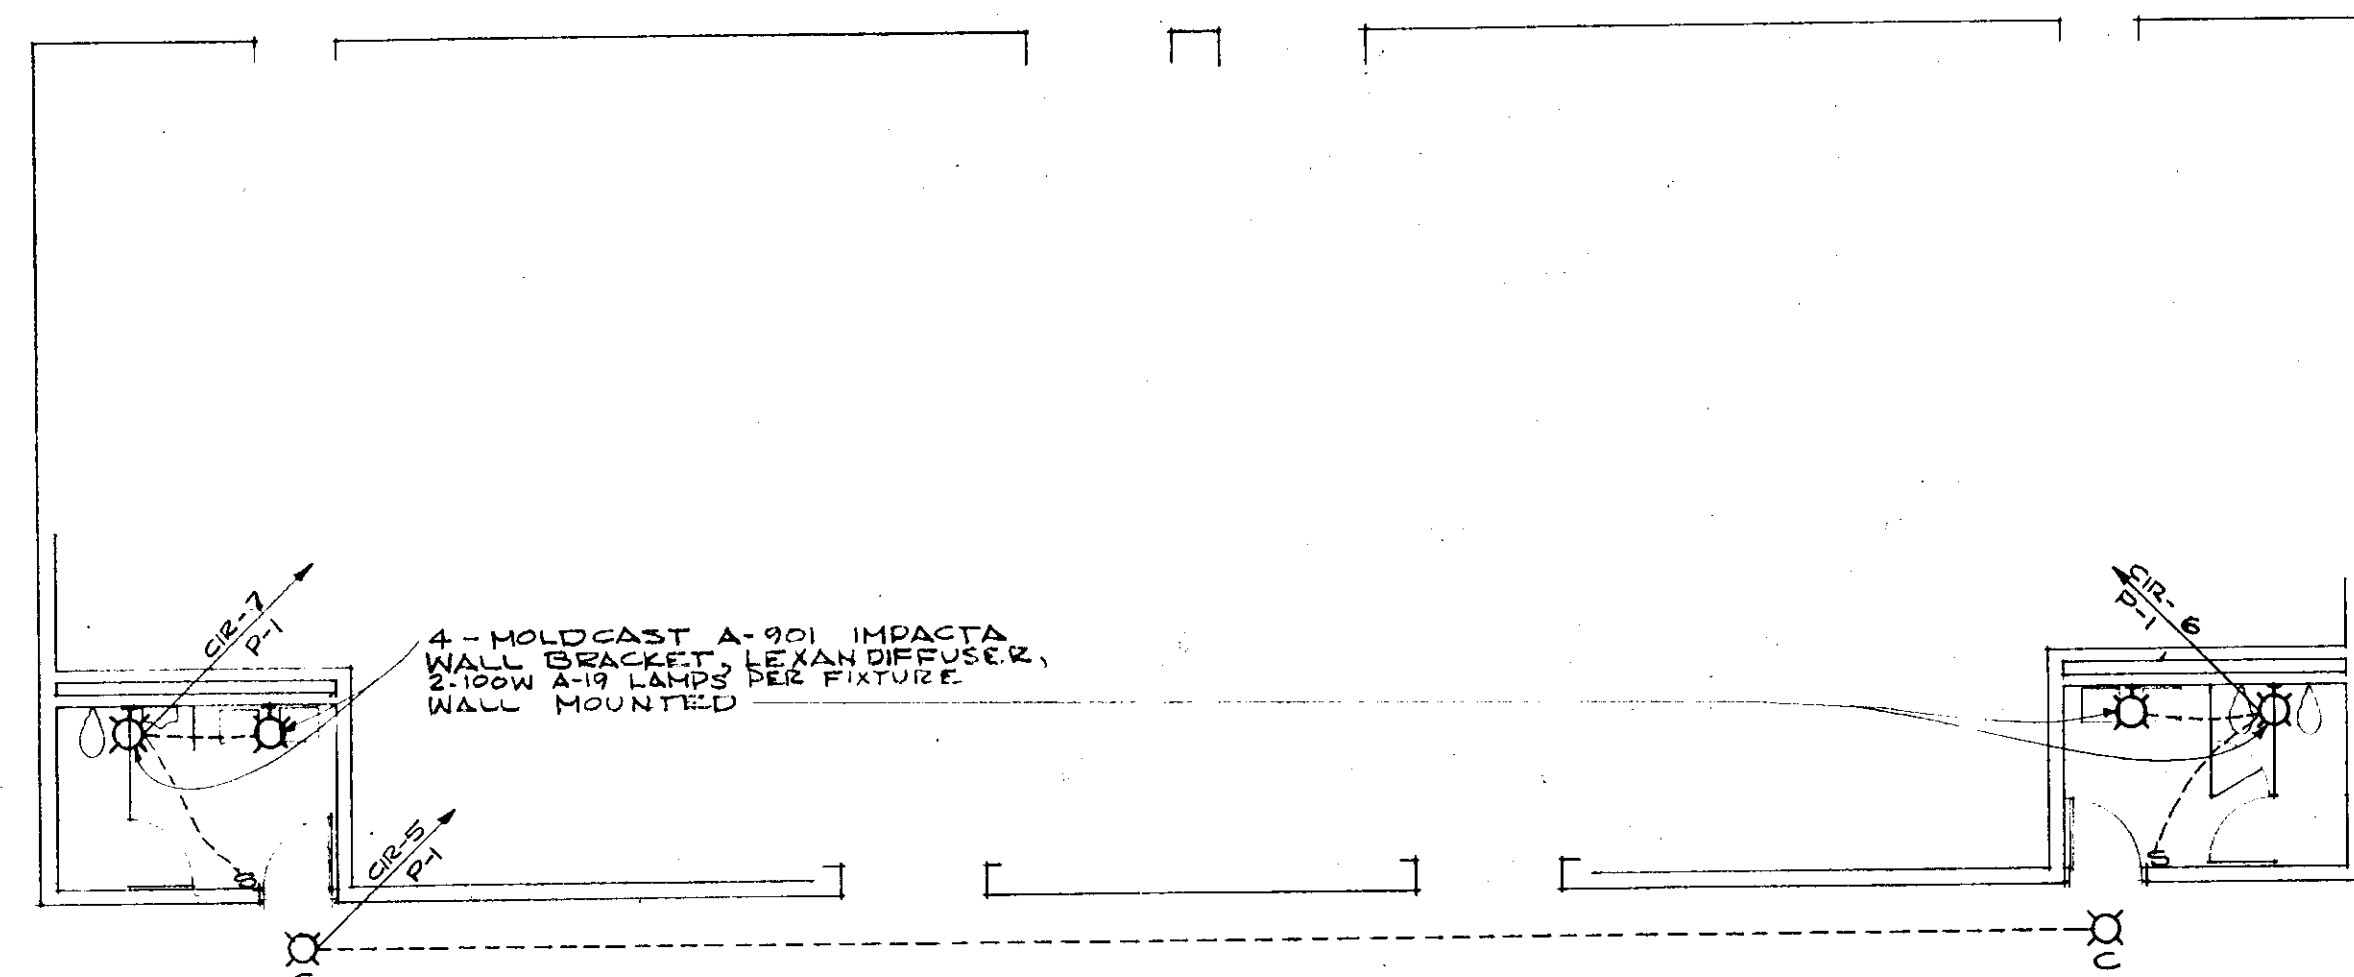


PARTIAL ELECTRICAL PLAN
SCALE: 1/8" = 1'-0"

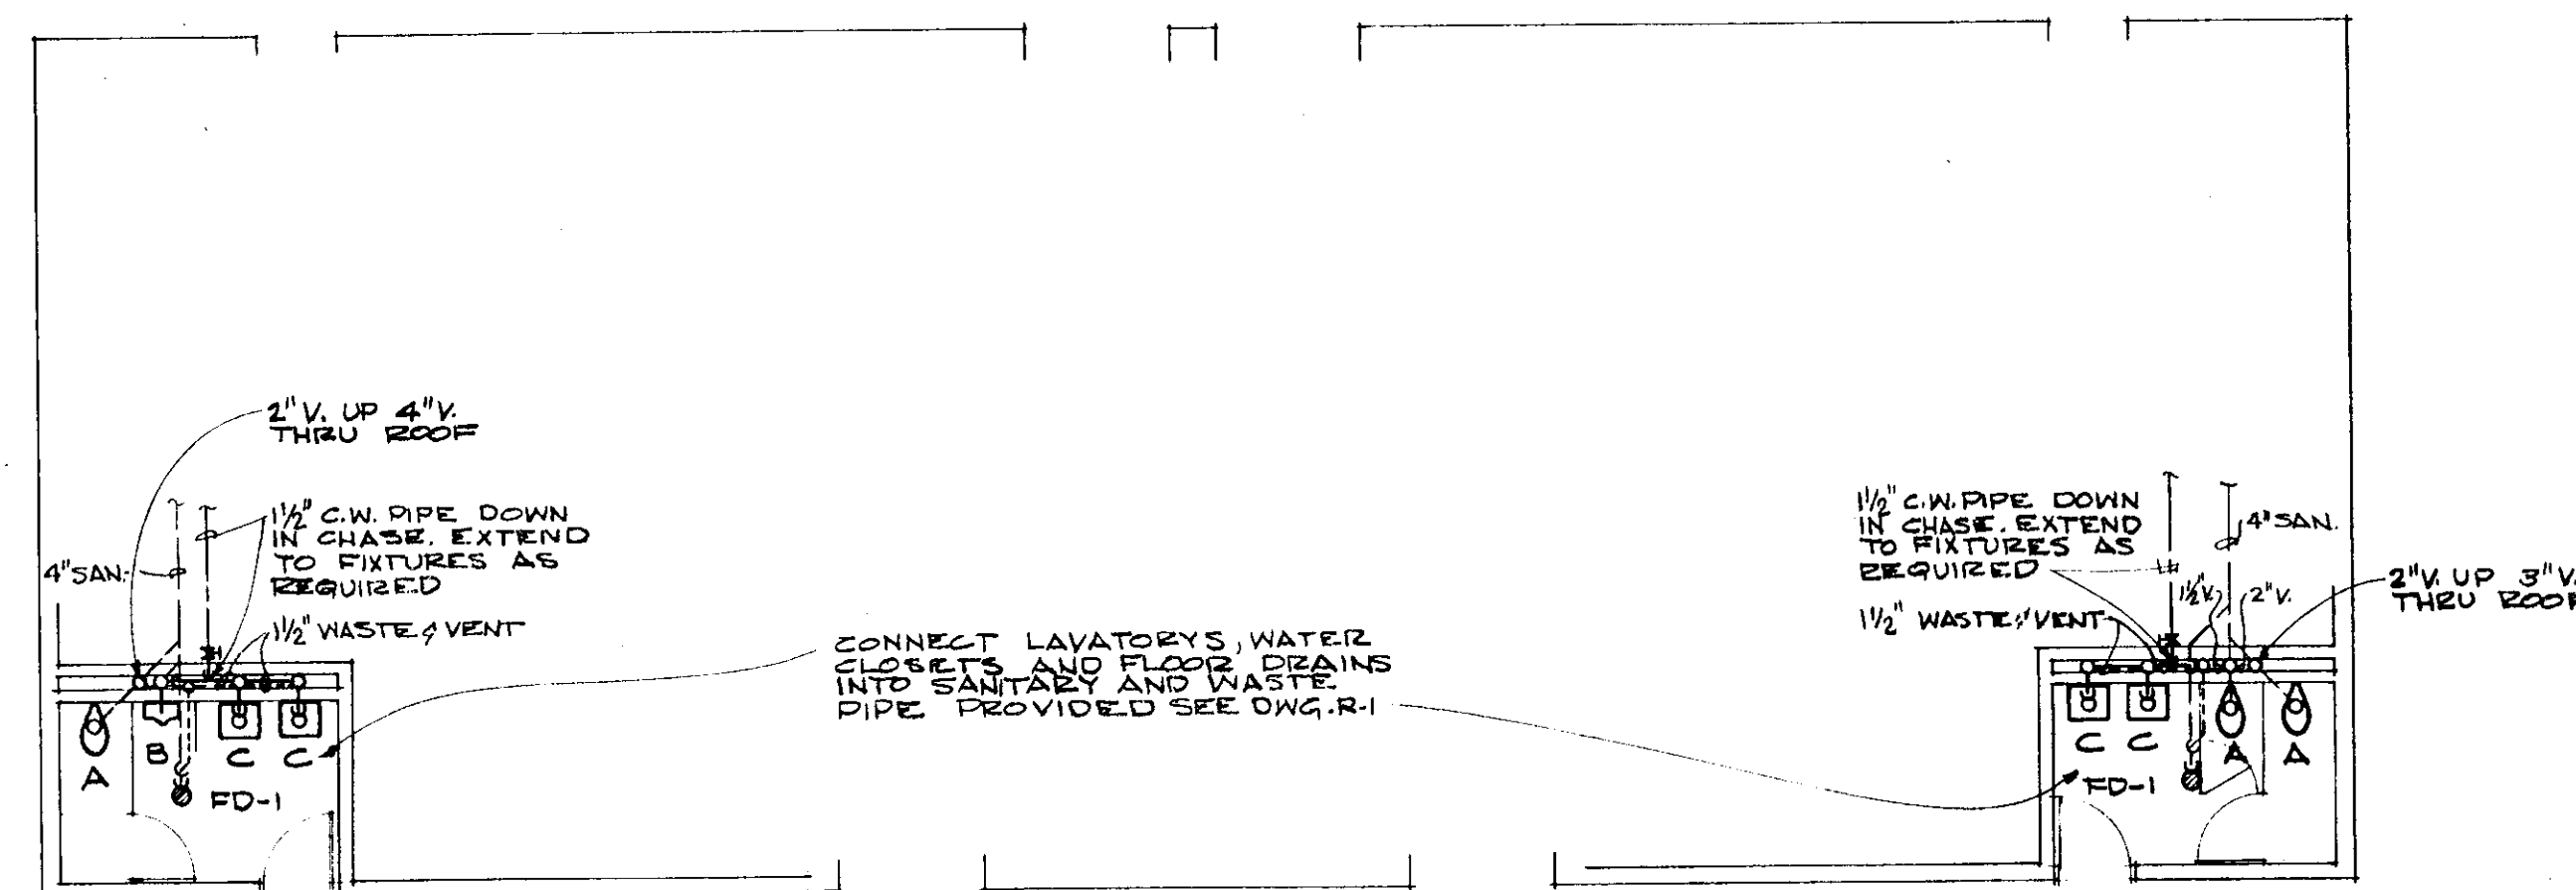

PARTIAL PLUMBING PLAN
SCALE: 1/8" = 1'-0"

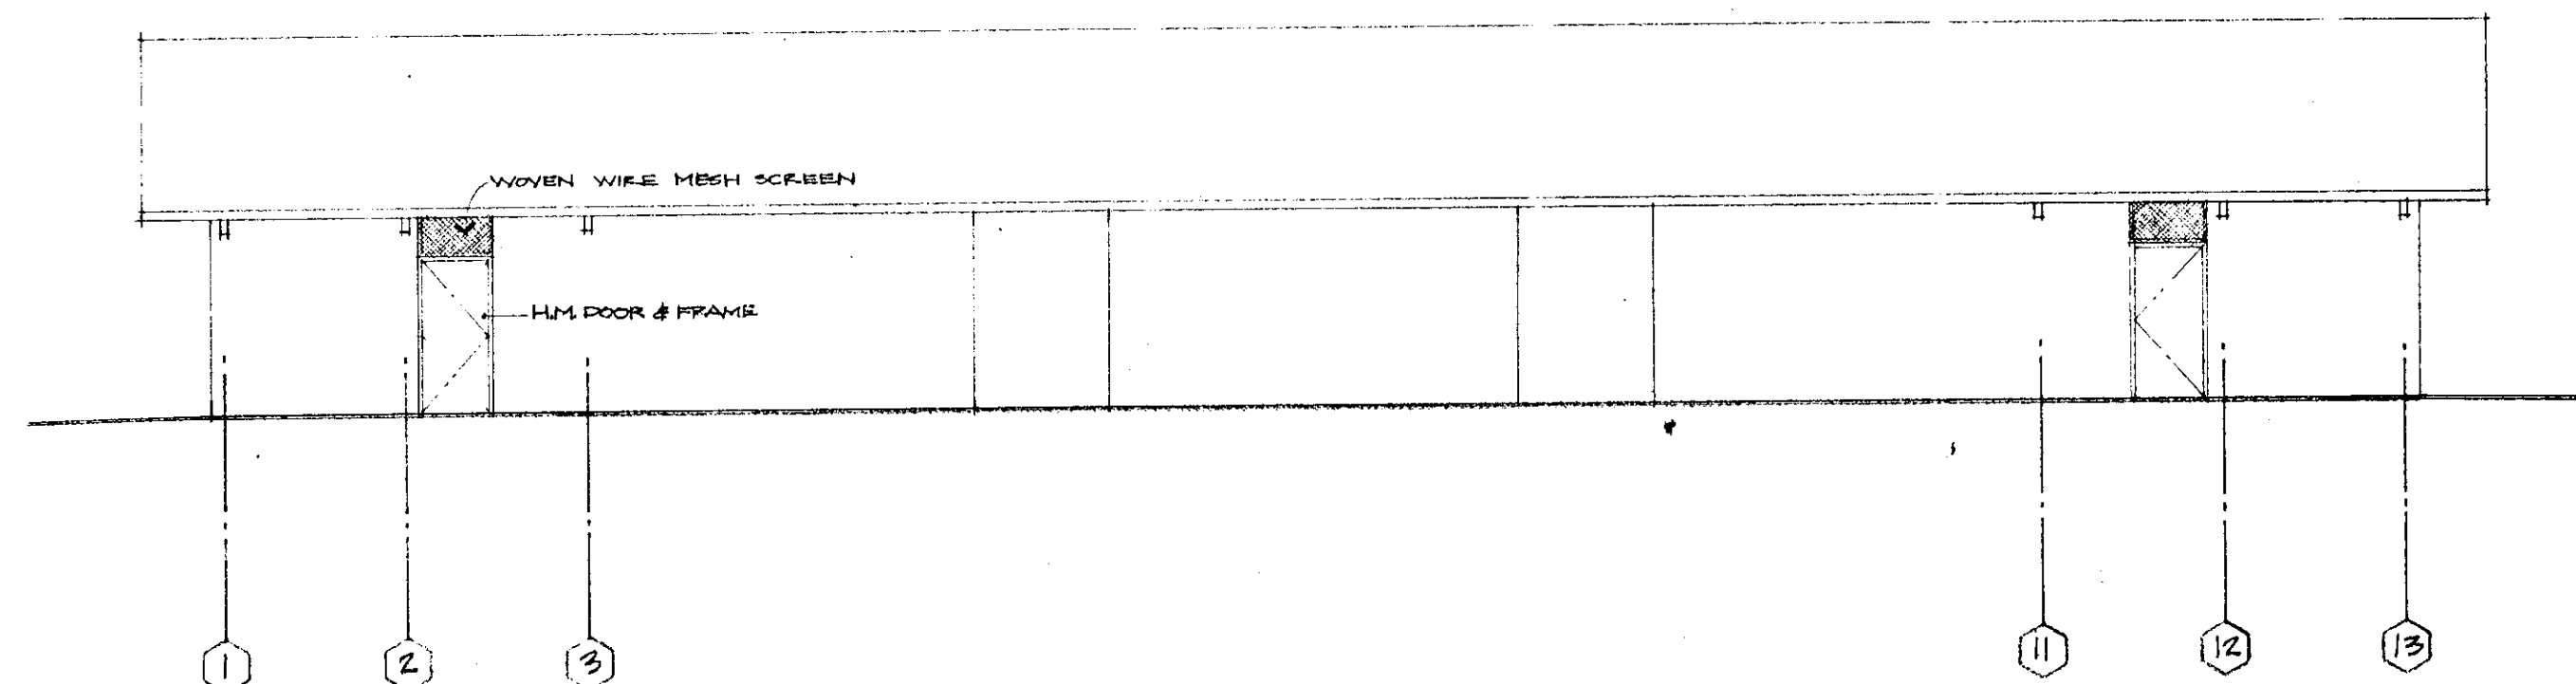

SOUTH ELEVATION

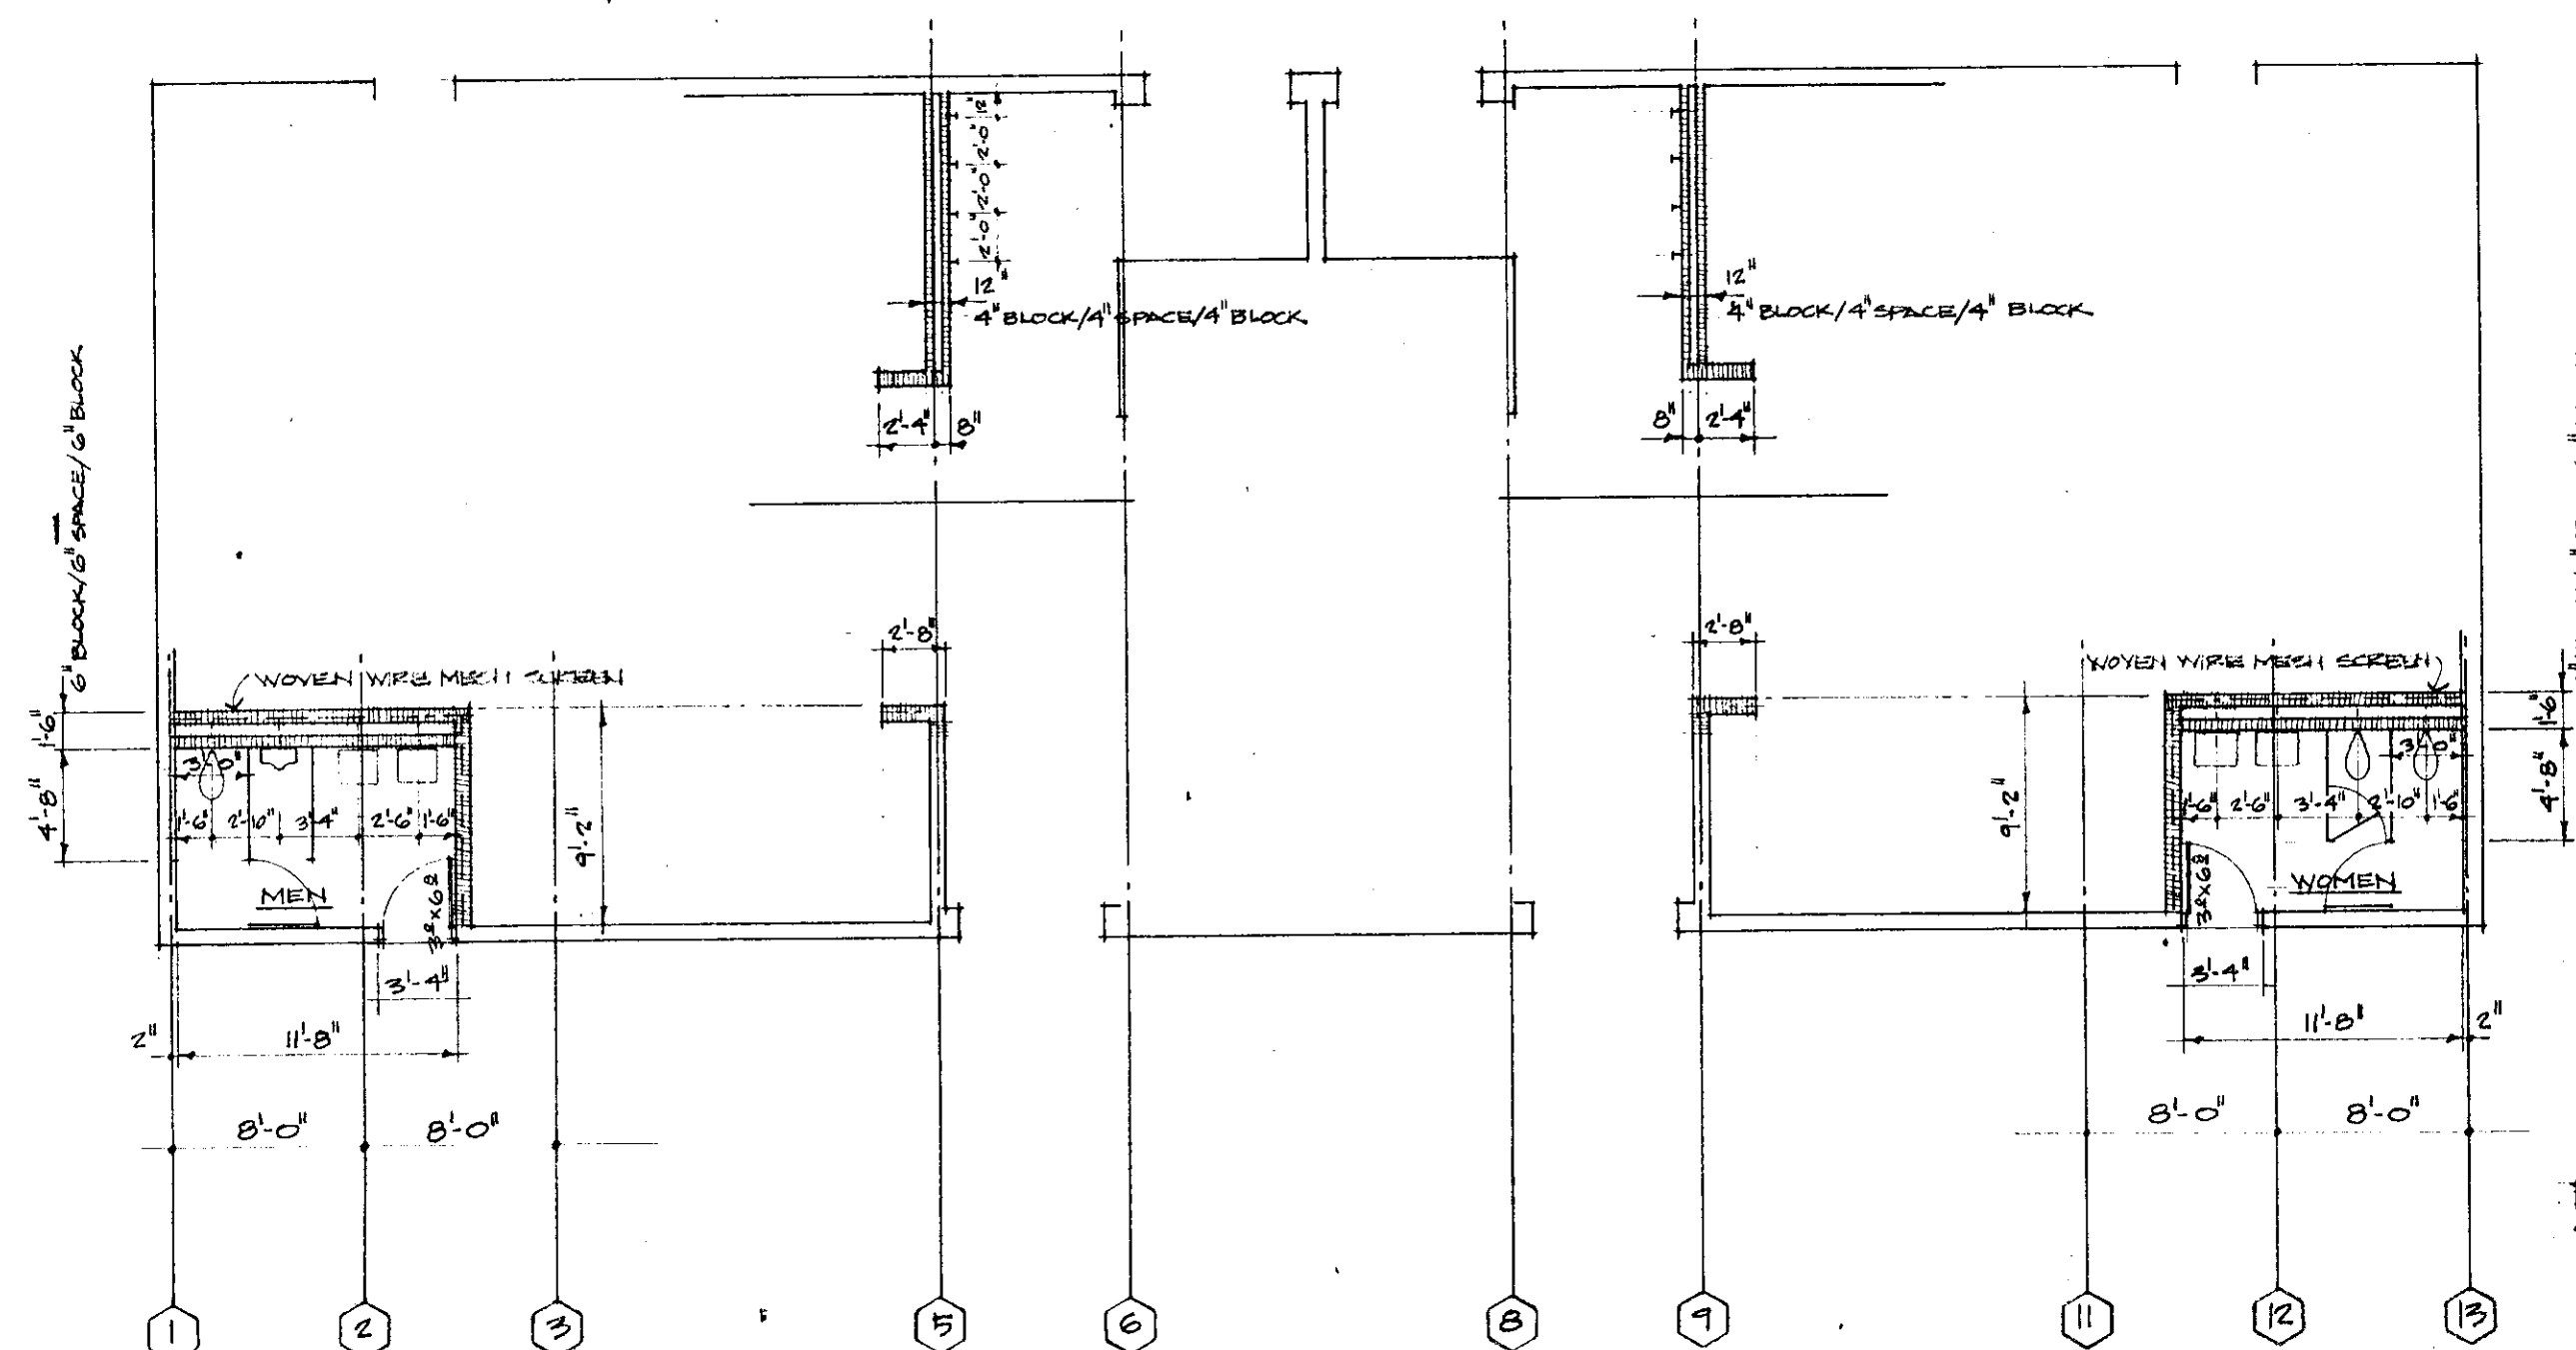

BATHHOUSE FLOOR PLAN
SCALE: 1/8" = 1'-0"

REVISIONS

NO.	DATE	REMARKS

PROJECT TITLE

POPE PARK POOL
&
BATHHOUSE

ASSOCIATED
ARCHITECTS

FARMINGTON • CONNECTICUT • 06032

LAND PLANNER

MAINE & TILLAPPAUGH
WEST HARTFORD CONNECTICUT


MECHANICAL ENGINEER

BURTON & VAN HOUTEN
WEST HARTFORD CONNECTICUT

STRUCTURAL ENGINEER

BURTON & VAN HOUTEN
WEST HARTFORD CONNECTICUT

CORRECT AS BUILT DEL. 10-72

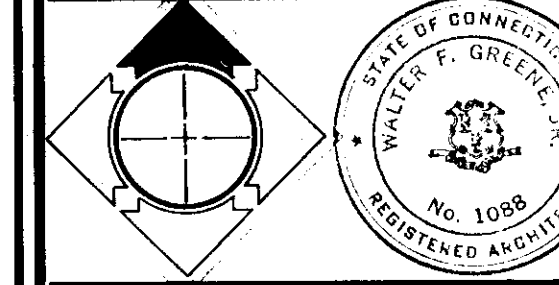

SHEET TITLE
PROPOSED
REVISIONS

PROJECT NO. 80410	SHEET NO.
DRAWN BY CEN	R2
CHECKED BY WFG	
APPROVED BY	
DATE 17 MARCH 72	SHEET 1 OF 1

