
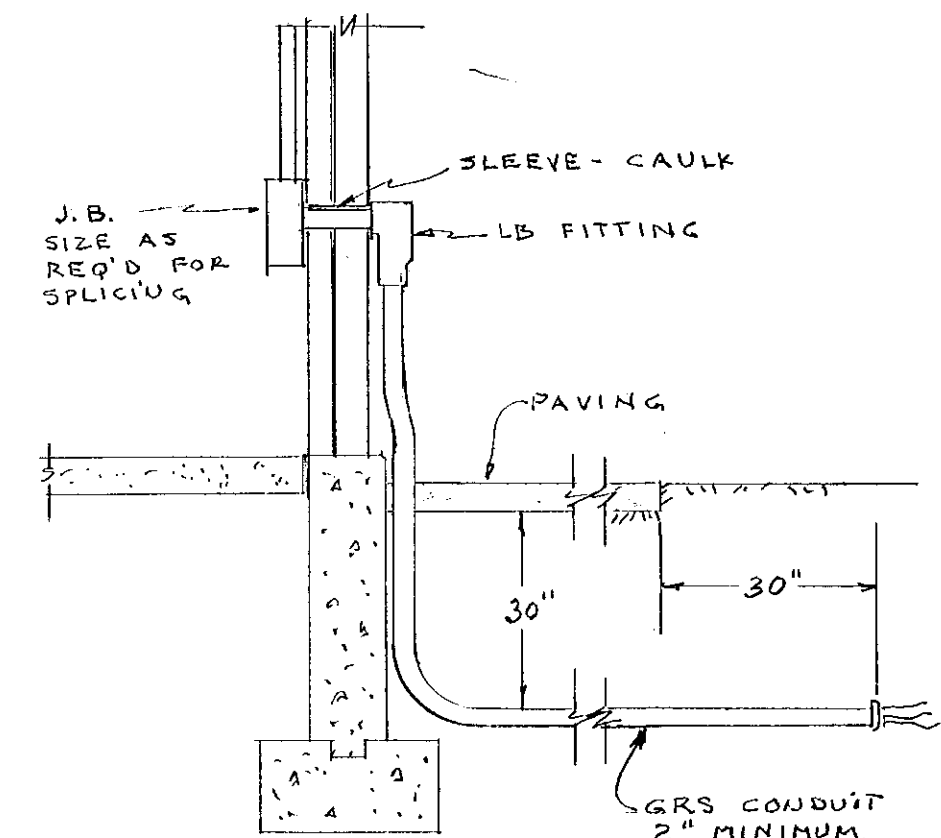


POLE & FIXTURE SCHEDULE

TYPE	POLE		FIXTURES			REMARKS
	HT.	MILLERBERND CAT. NO.	NUMBER PER POLE	WIDE-LITE CAT. NO.	LAMP	
1	37'	WLH-373-3 (120°)	1	FL-401-BWRB-LX-AL-4-F	400 W-HPS	STAIRS
2	37'	WLH-373-2	2	FL-1001-CWRB-LX-AL-10-F	1000 W-HPS	BASKET BALL
3	37'	WLH-373-3 (120°)	3	FL-401-CWRB-LX-AL-4-F	400 W-HPS	VOLLEYBALL & TENNIS
4	37'	WLH-373-2	2	FL-401-BWRB-LX-AL-4-F	400 W-HPS	AREA LT'G.

NOTES:

1. ALL POLES TO BE BARE COR-TEN
2. BALLASTS SHALL BE NOMINAL 120 VOLTS, REGULATING TYPE, HFF, AND RATED FOR -20°F OPERATION OF LAMPS
3. COLOR OF ALL FIXTURES SHALL BE DARK BRONZ-ANODIZED.
4. THIS CONTRACTOR SHALL AIM ALL FIXTURES AS DIRECTED BY CITY AND TO THE SATISFACTION OF THE CITY.
5. ALL FIXTURES SHALL STAND-OFF POLYCARBONATE SHIELDS TO PREVENT VANDALISM.

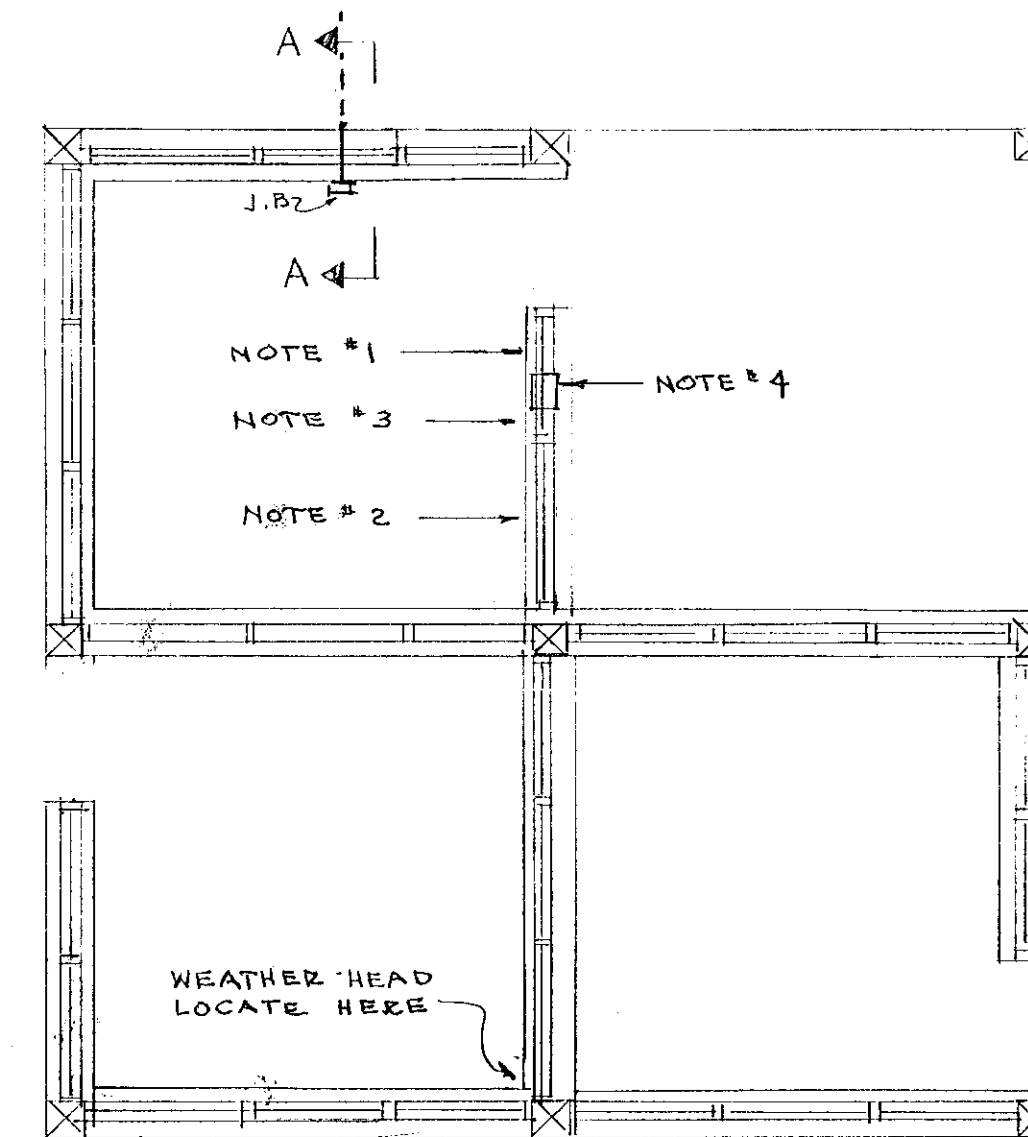


SECTION A-A
N.T.S.


- NOTES:
1. LOCATION OF EXISTING LT. SW'S - TO REMAIN.
 2. LOCATION OF EXISTING MAN. MTR ST'RS - TO REMAIN.
 3. LOCATION OF EXISTING METER & PANEL - TO BE REMOVED. NEW METER, PANEL & TIME CLOCKS TO BE LOCATED HERE.
 4. EXISTING J.B. IN WALL FOR SERVICE. WELD 1/16" PLATE TO EXTERIOR SIDE. ADAPT INTERIOR SIDE TO BRING IN SERVICE CONDUCTORS TO METER.

FIELD HOUSE PLAN

SCALE 1/4" = 1'-0"

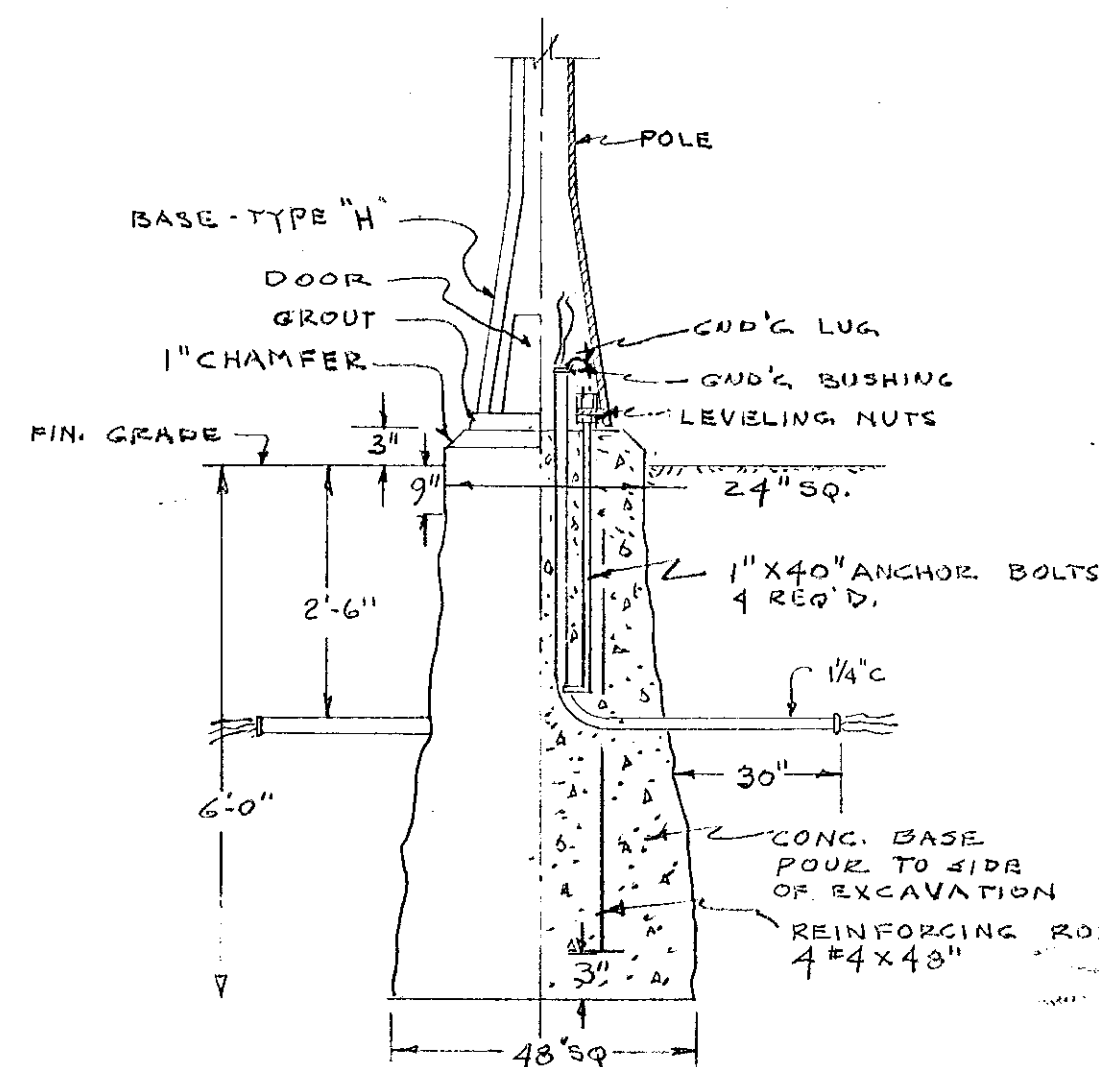


POLE BASE DETAIL
NO SCALE.

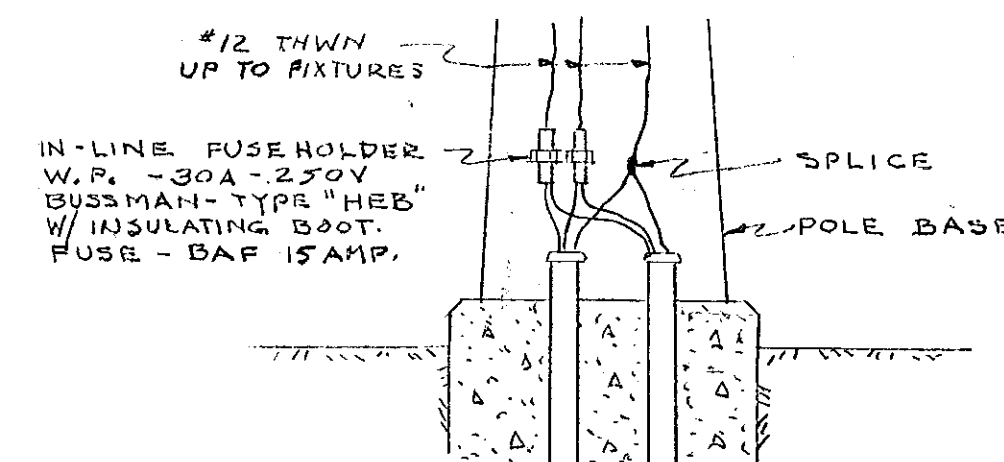

- NOTES:
1. DETAIL IS TYPICAL FOR ALL POLES AND FIXTURES. EACH FIXTURE SHALL BE INDIVIDUALLY FUSED.
 2. SPLICES IN POLES TO BE WATERPROOF

FIXTURE FUSING DETAIL
NO SCALE

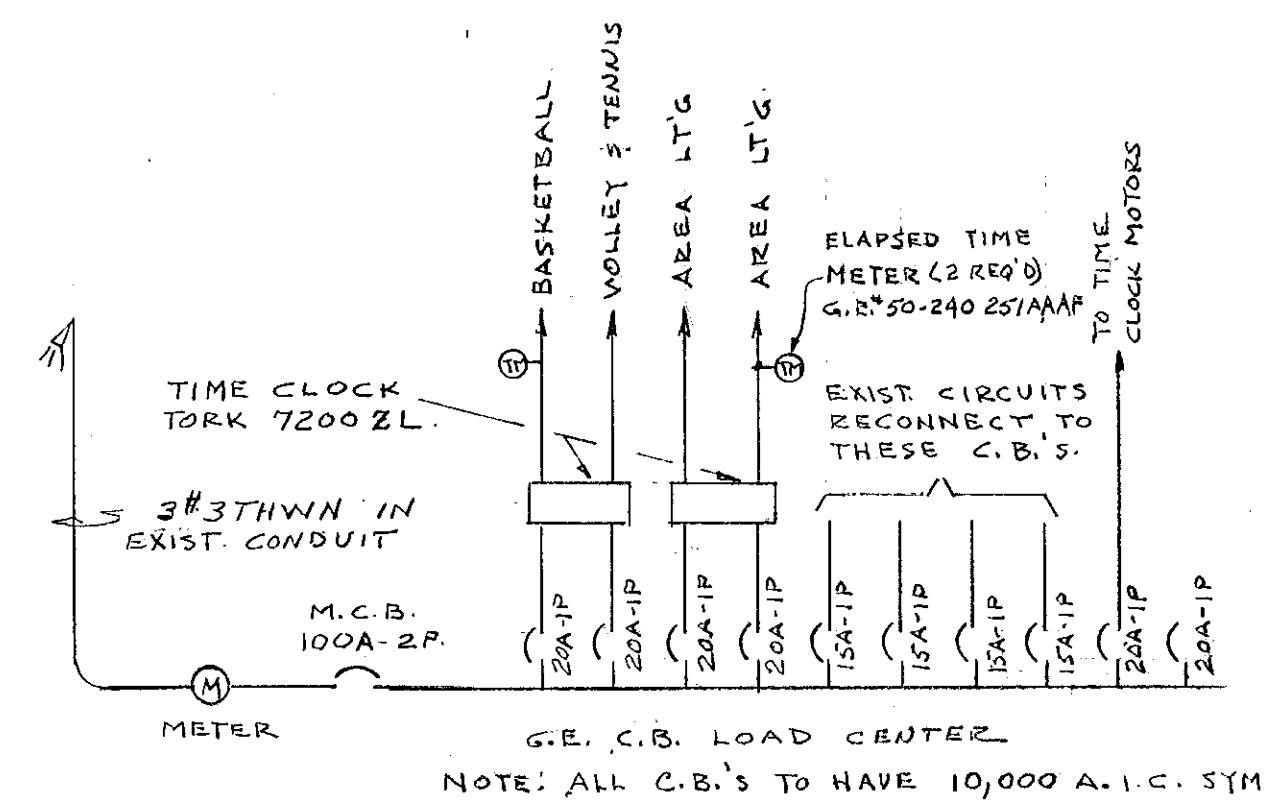

POWER RISER DIAGRAM.
NO SCALE

THIS SHEET - RICE HEIGHTS

VERIFY EXISTING
CONDITIONS AND
DIMENSIONS

SHEET NO.
2
OF 3 SHEETS

CITY OF HARTFORD, CONNECTICUT
DEPARTMENT OF PUBLIC WORKS
BUREAU OF PUBLIC BUILDINGS

PLAYGROUND LIGHTING
RICE HEIGHTS PLAYGROUND.
HARBISON PLAYGROUND.

SUBMITTED: *Ed. Cannon* RECOMMENDED: *Walter H. Reed* APPROVED: *George C. Heppner*
CITY ARCHITECT ASST. & CHIEF ENG.
DRAWN: R.G.B. SCALE: DAYBOOK NO. 010585B
CHECKED: DATE JAN. 29, 1977