


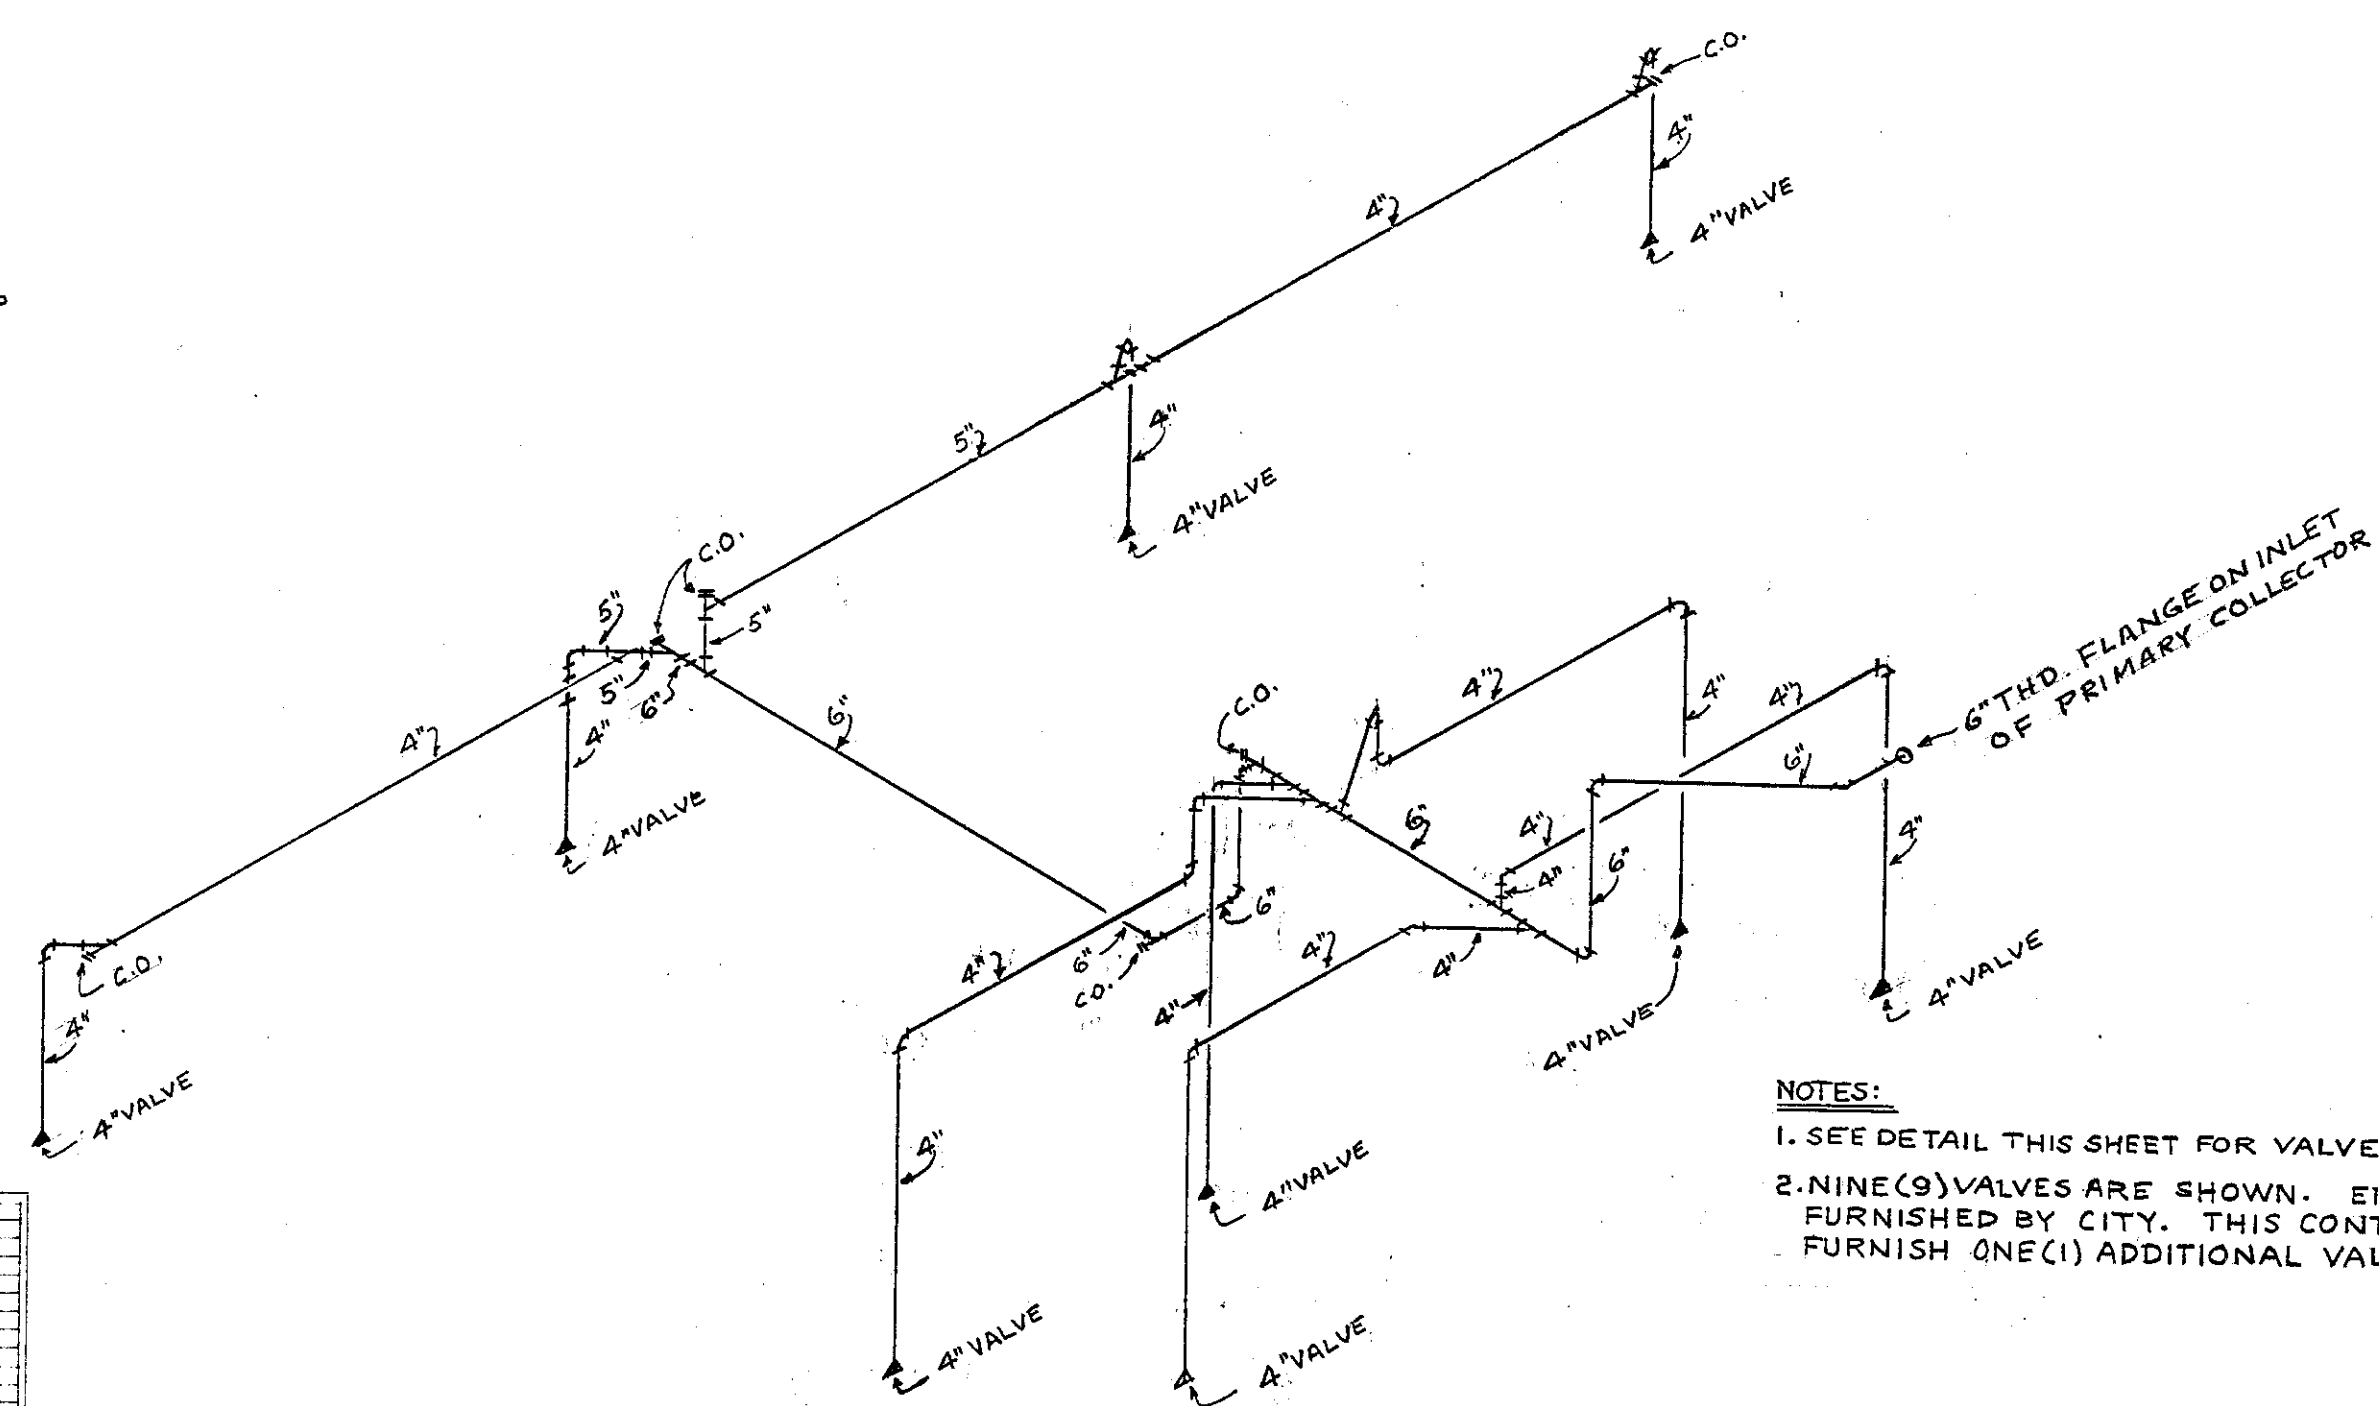


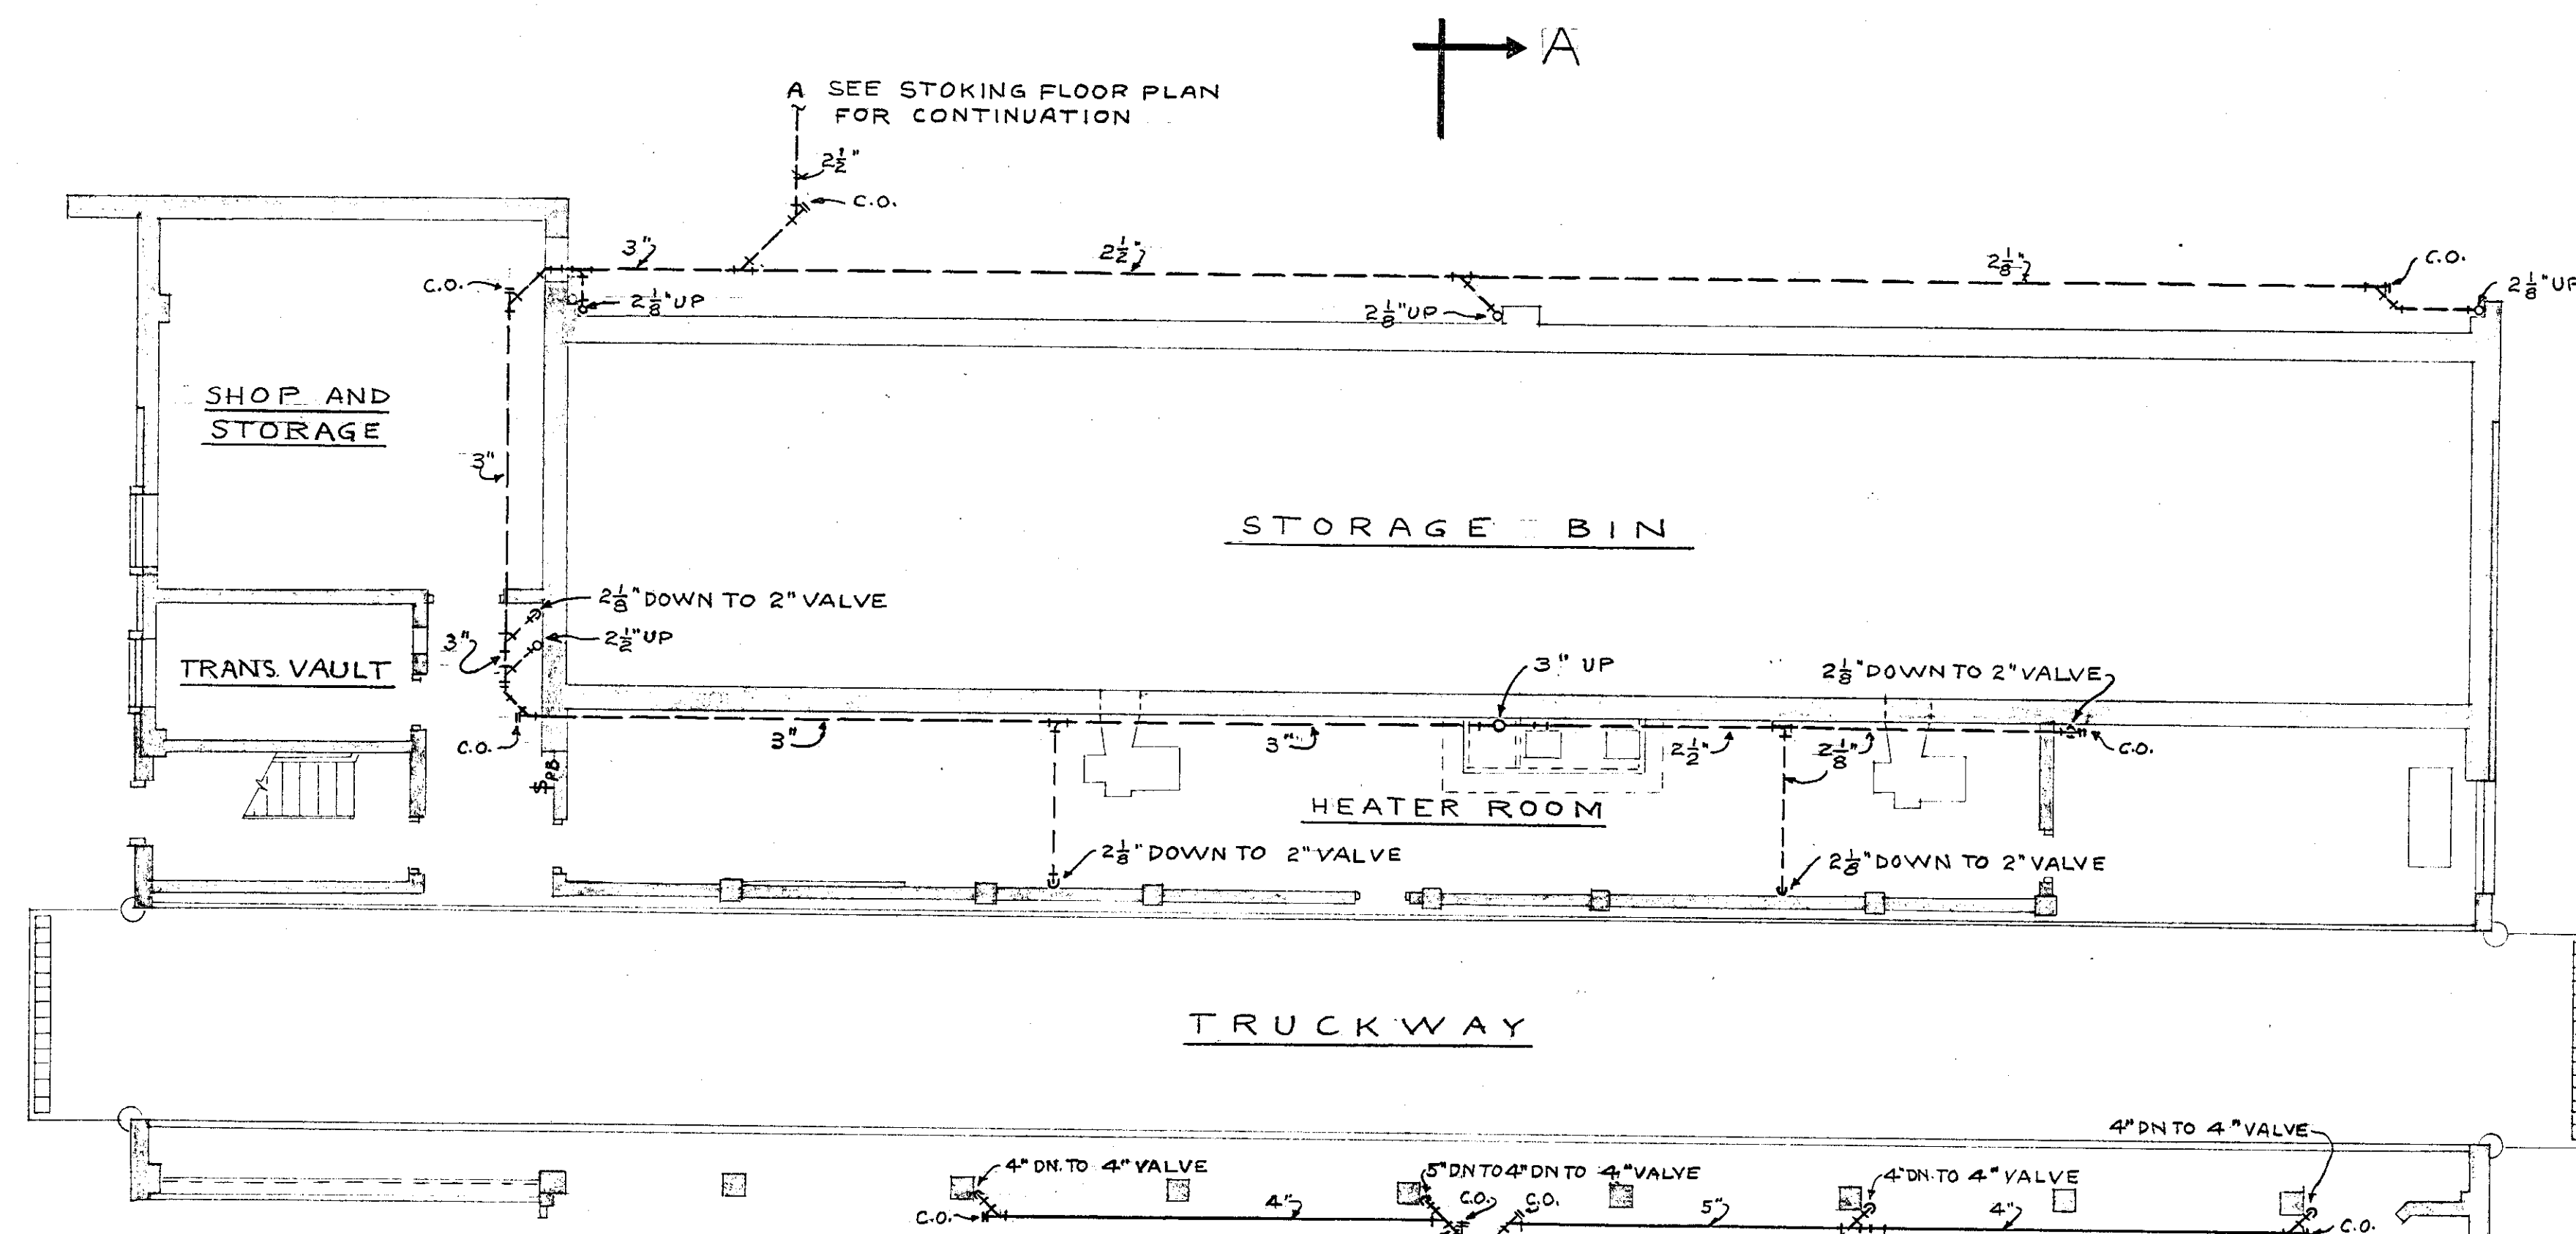


SCHEMATIC PIPING DIAGRAM-HEAVY DUTY VACUUM CLEANING SYSTEM
NO SCALE

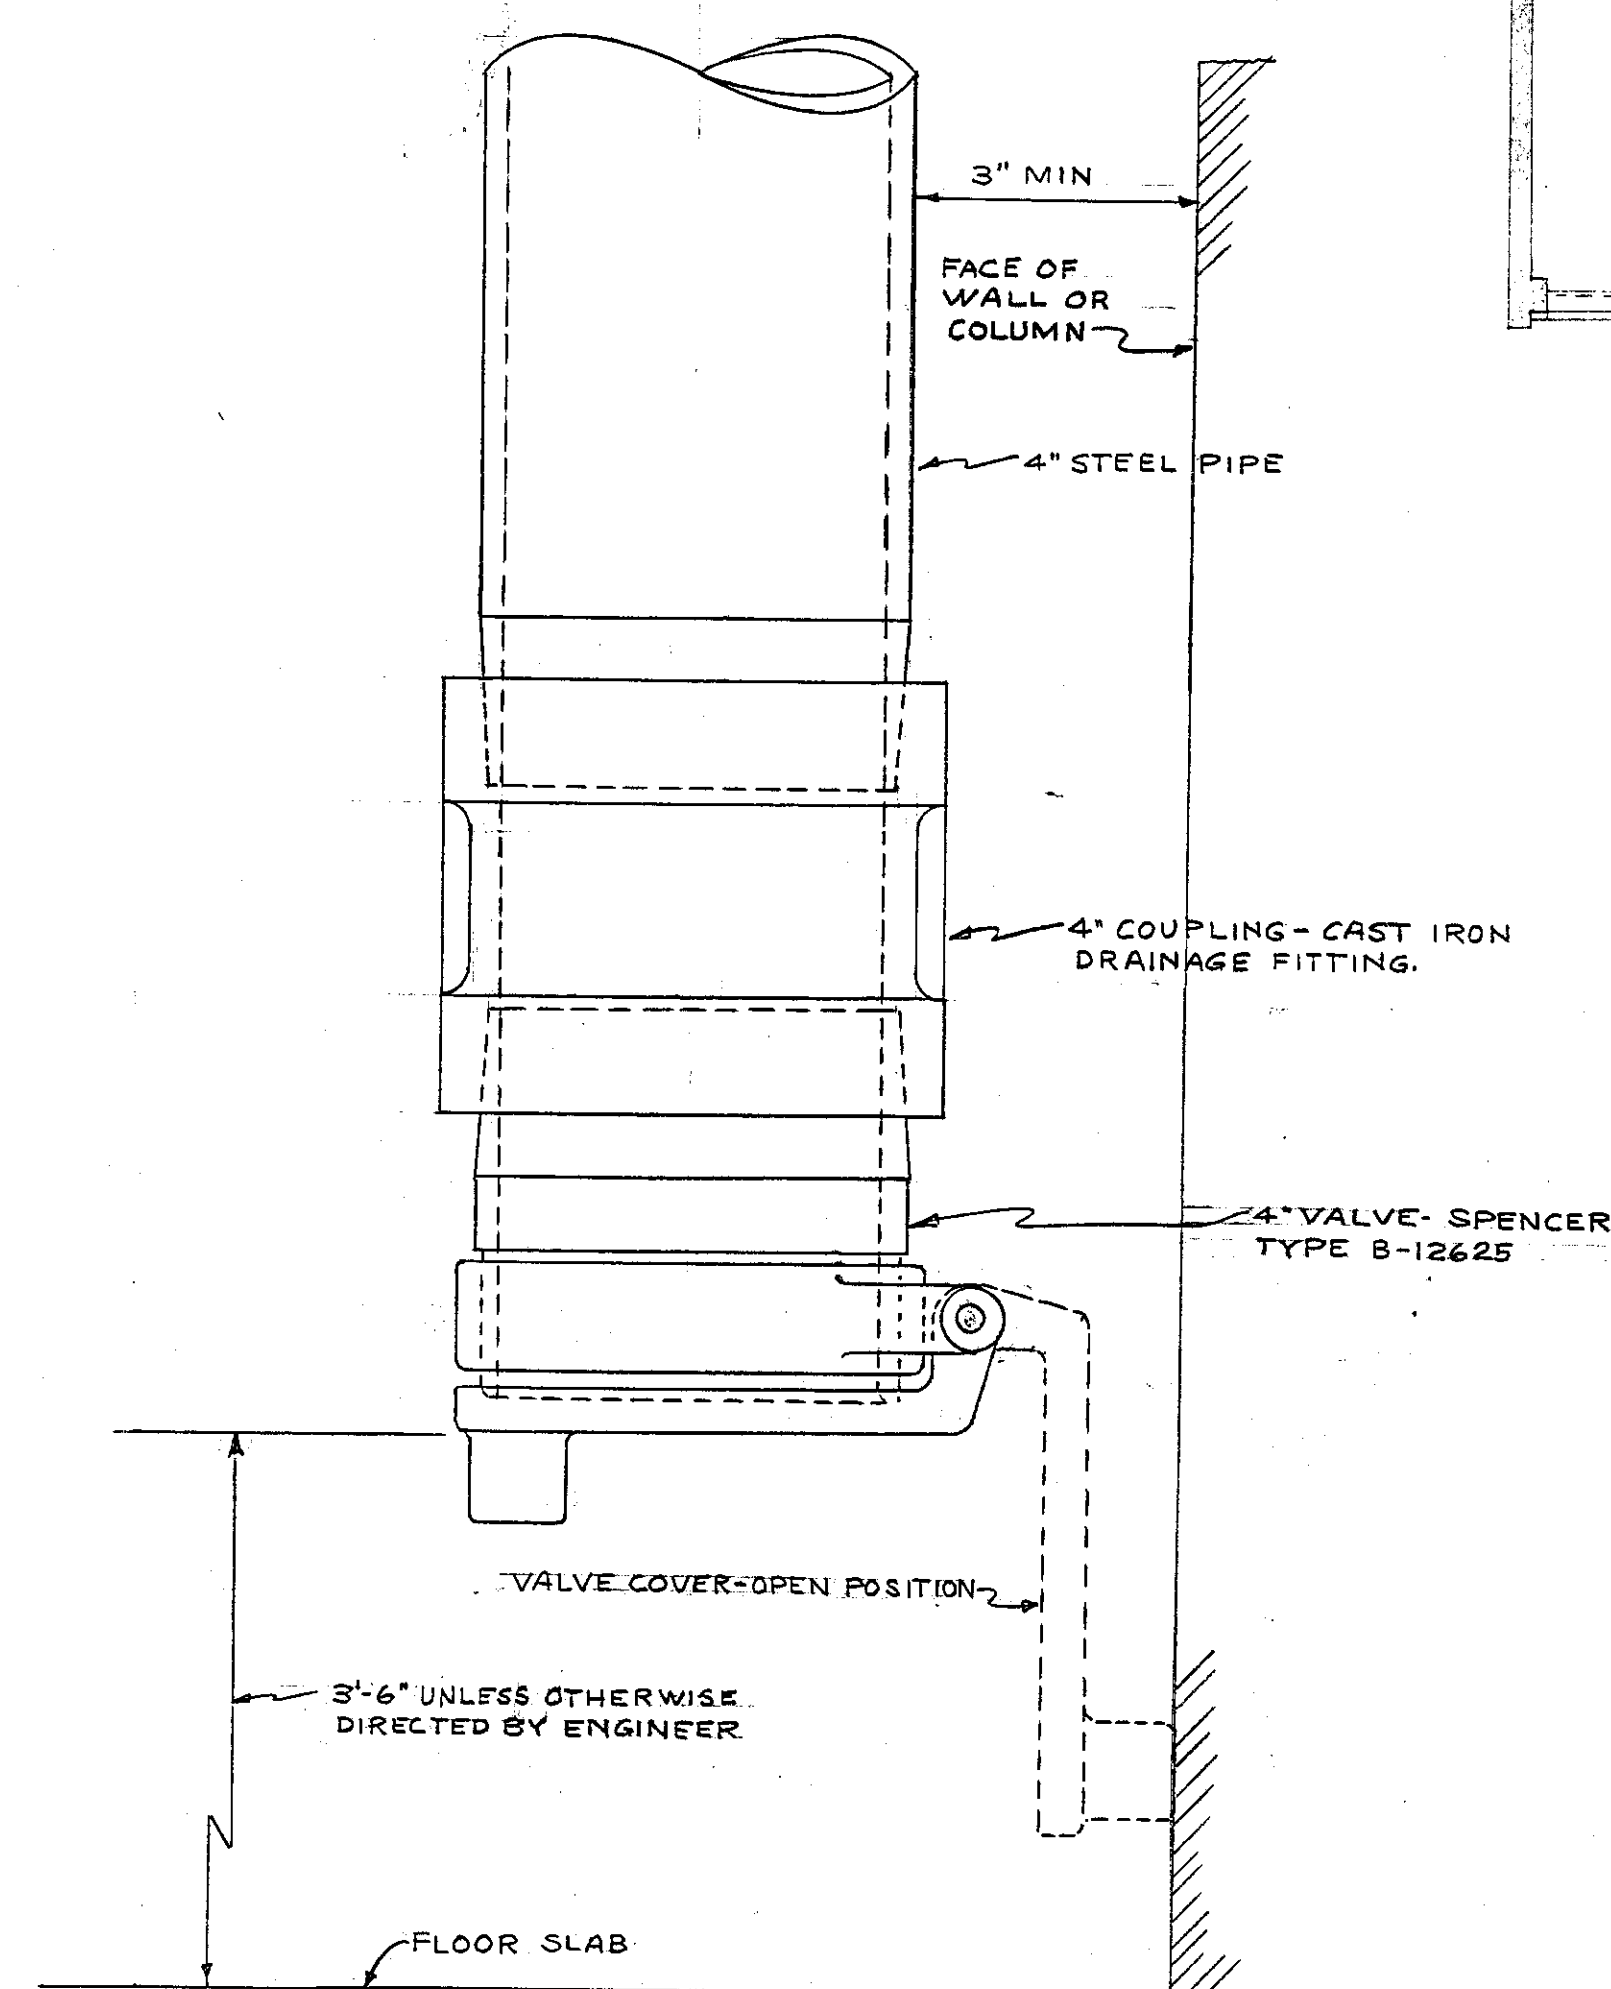

DETAIL- VALVE-HEAVY DUTY SYSTEM
SCALE - 1/2" = 1"

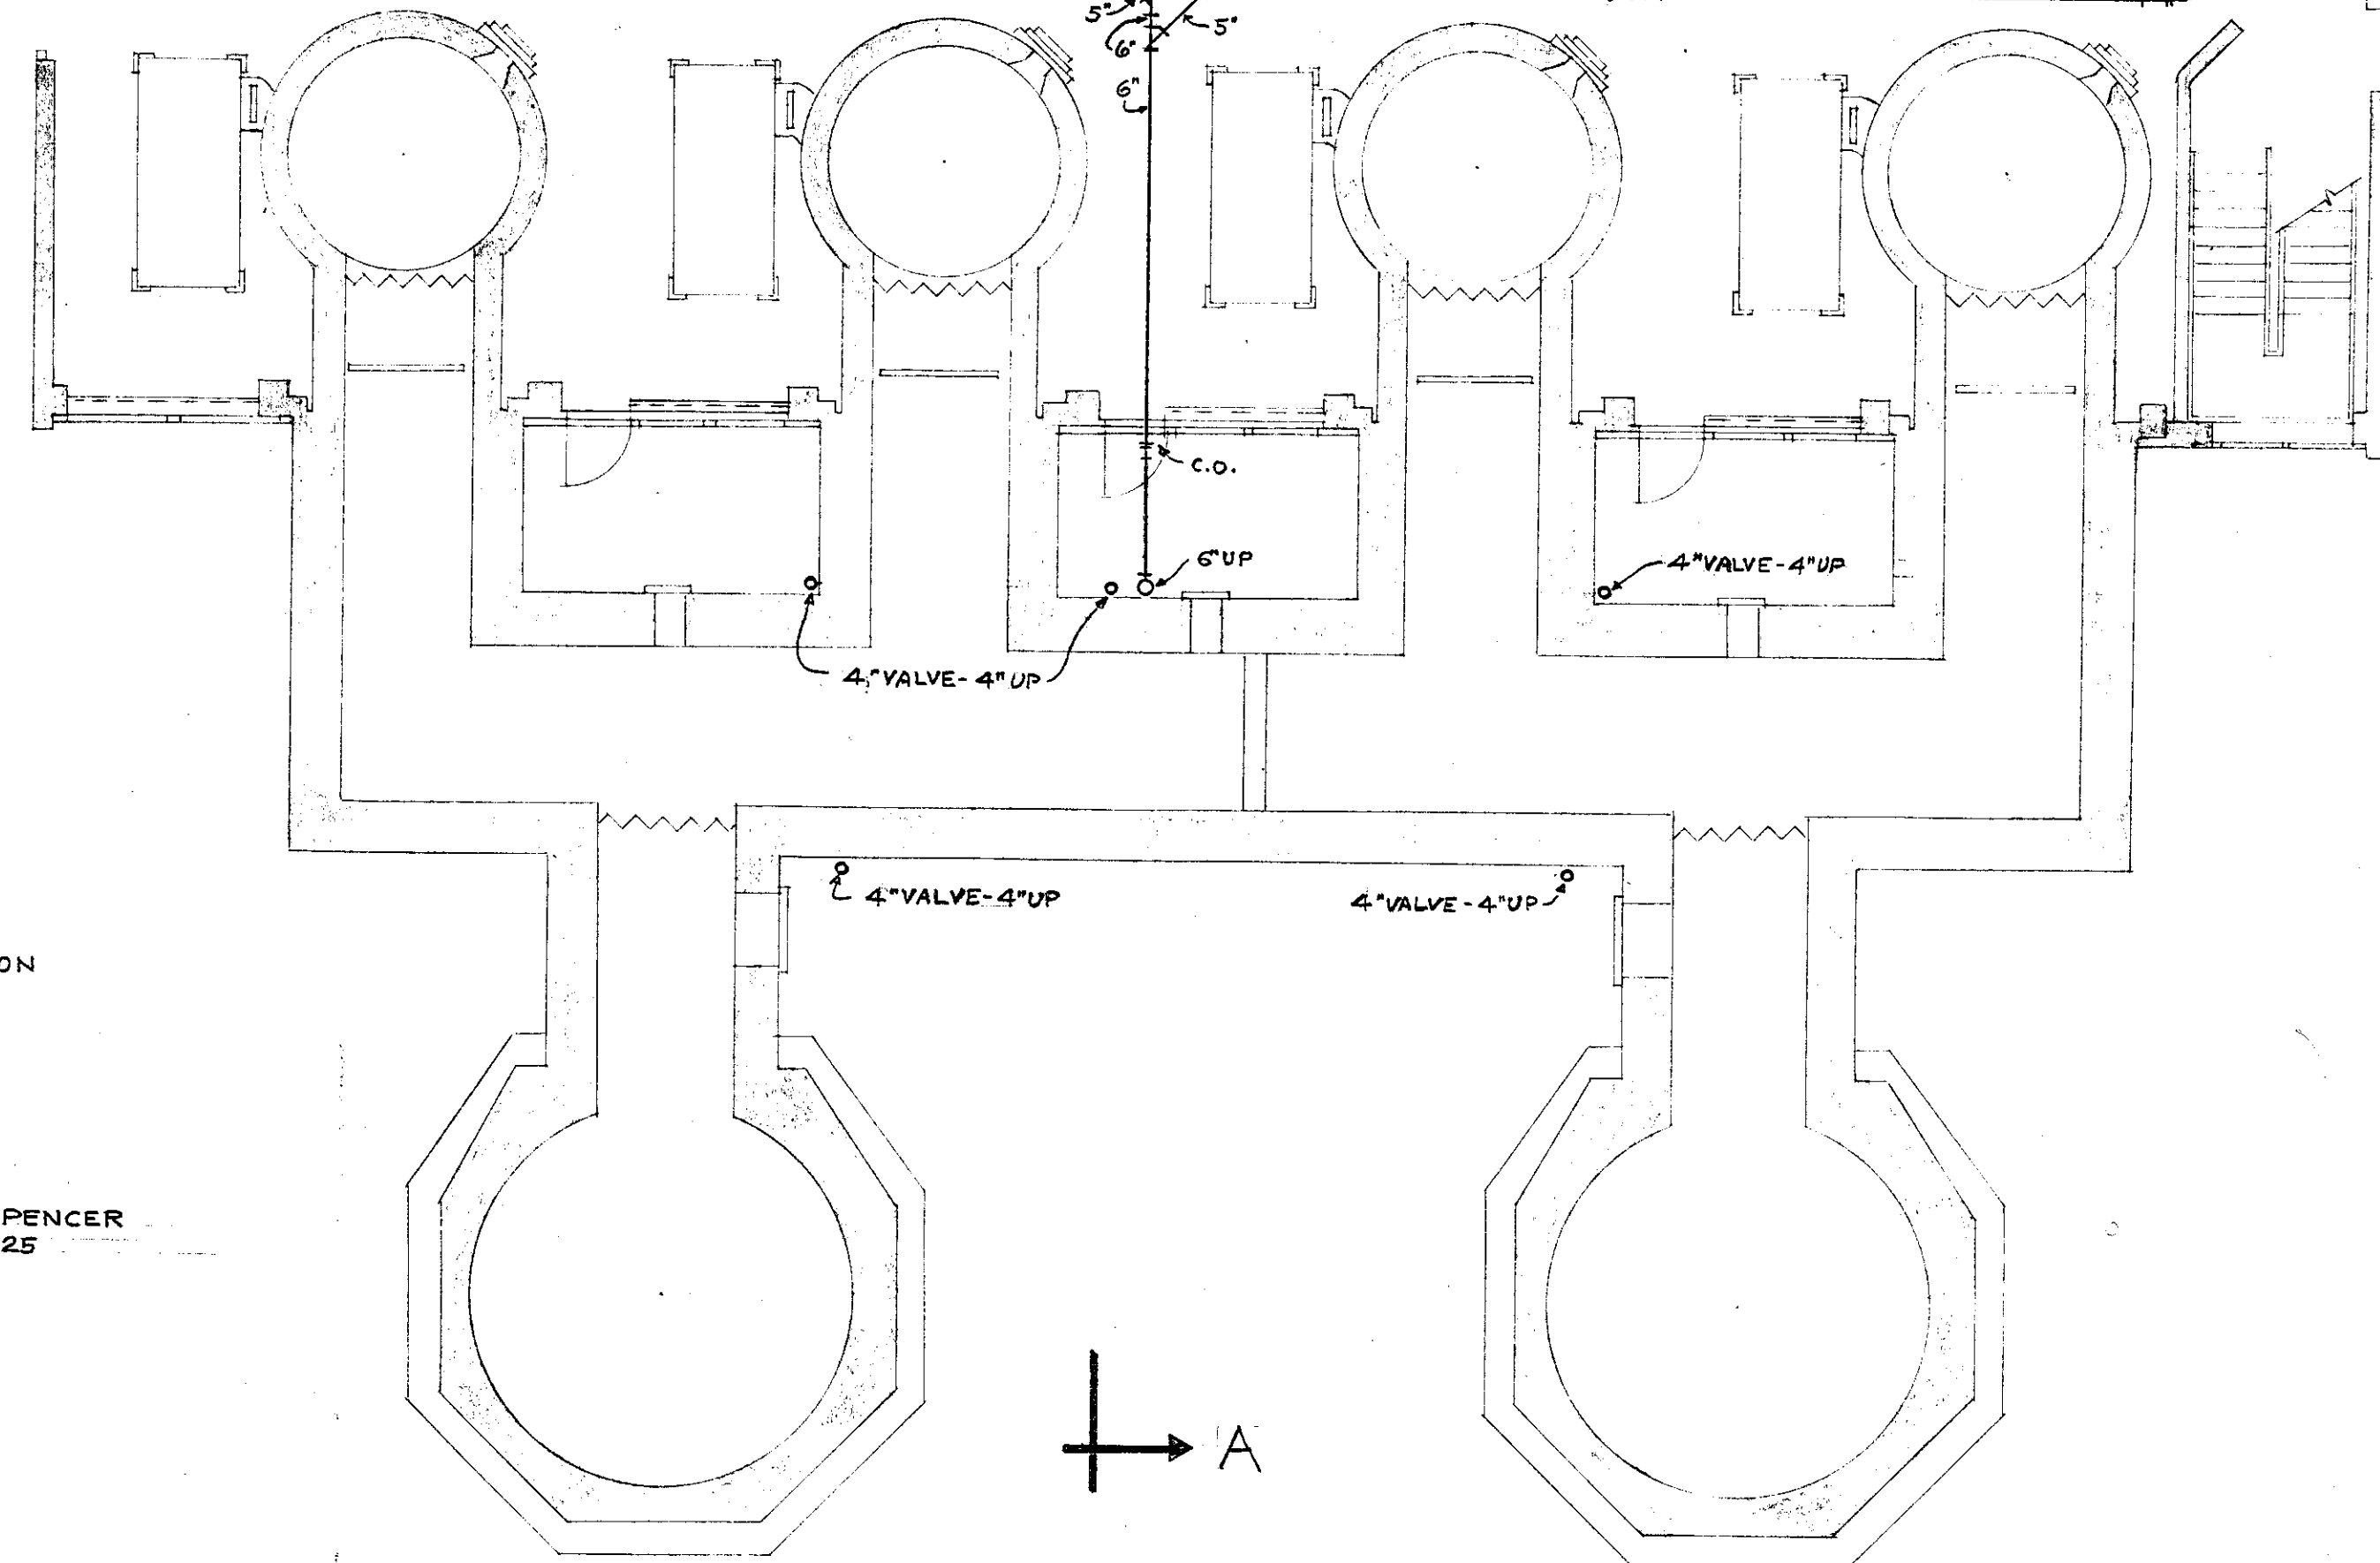

ASH TUNNEL FLOOR PLAN
SCALE 1/8" = 1'-0"

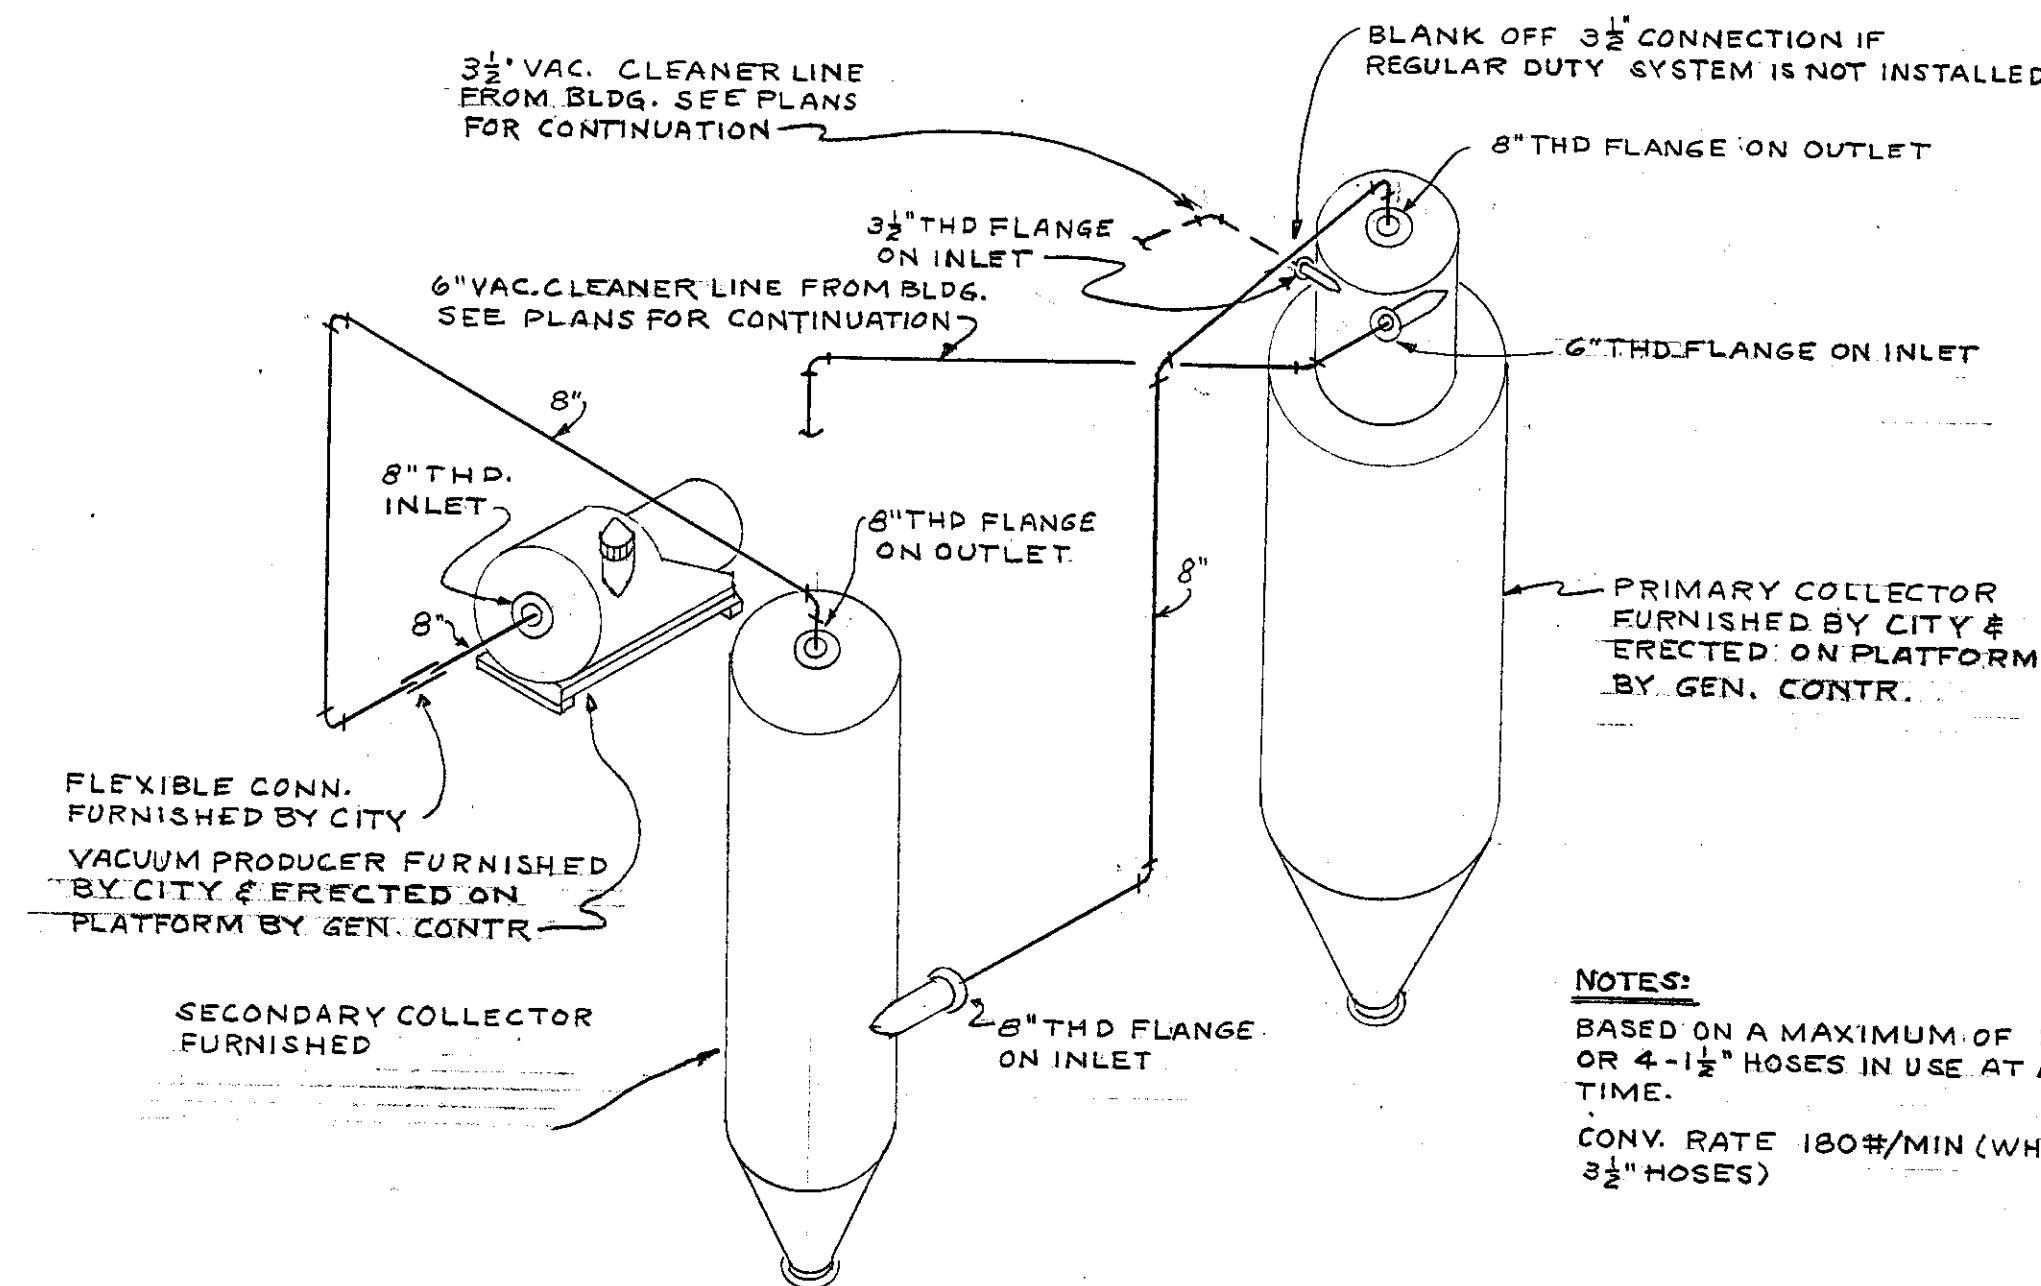

SCHEMATIC PIPING DIAGRAM-COLLECTORS
NO SCALE

CITY OF HARTFORD, CONNECTICUT DEPARTMENT OF ENGINEERING			
VACUUM CLEANER SYSTEM INCINERATOR INCINERATOR ROAD, NORTH MEADOWS HARTFORD, CONNECTICUT			
SUBMITTED	RECOMMENDED	APPROVED	
DIVISION ARCHITECT	CITY ARCHITECT	CITY ENGINEER	
DESIGN P.D.P.	DRAWN P.D.P.	DAYBOOK NO. 09649-A	
TRACED	CHECK	DATE DEC 22 1960	