



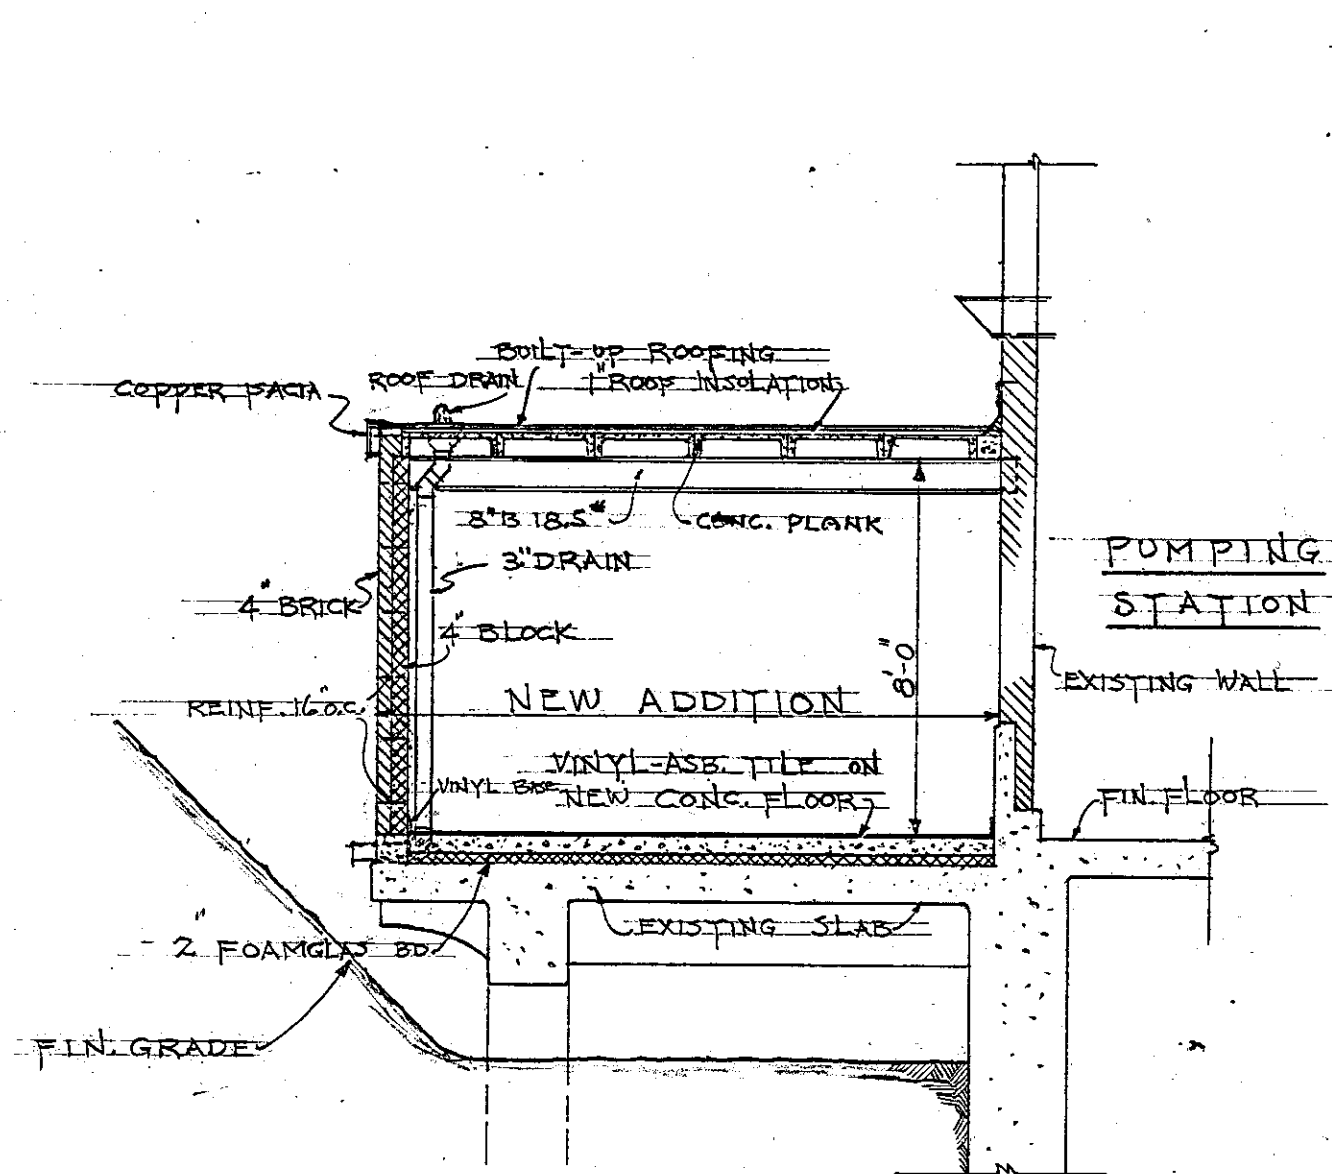


CROSS-SECTION
SCALE 1/4"=1'-0"

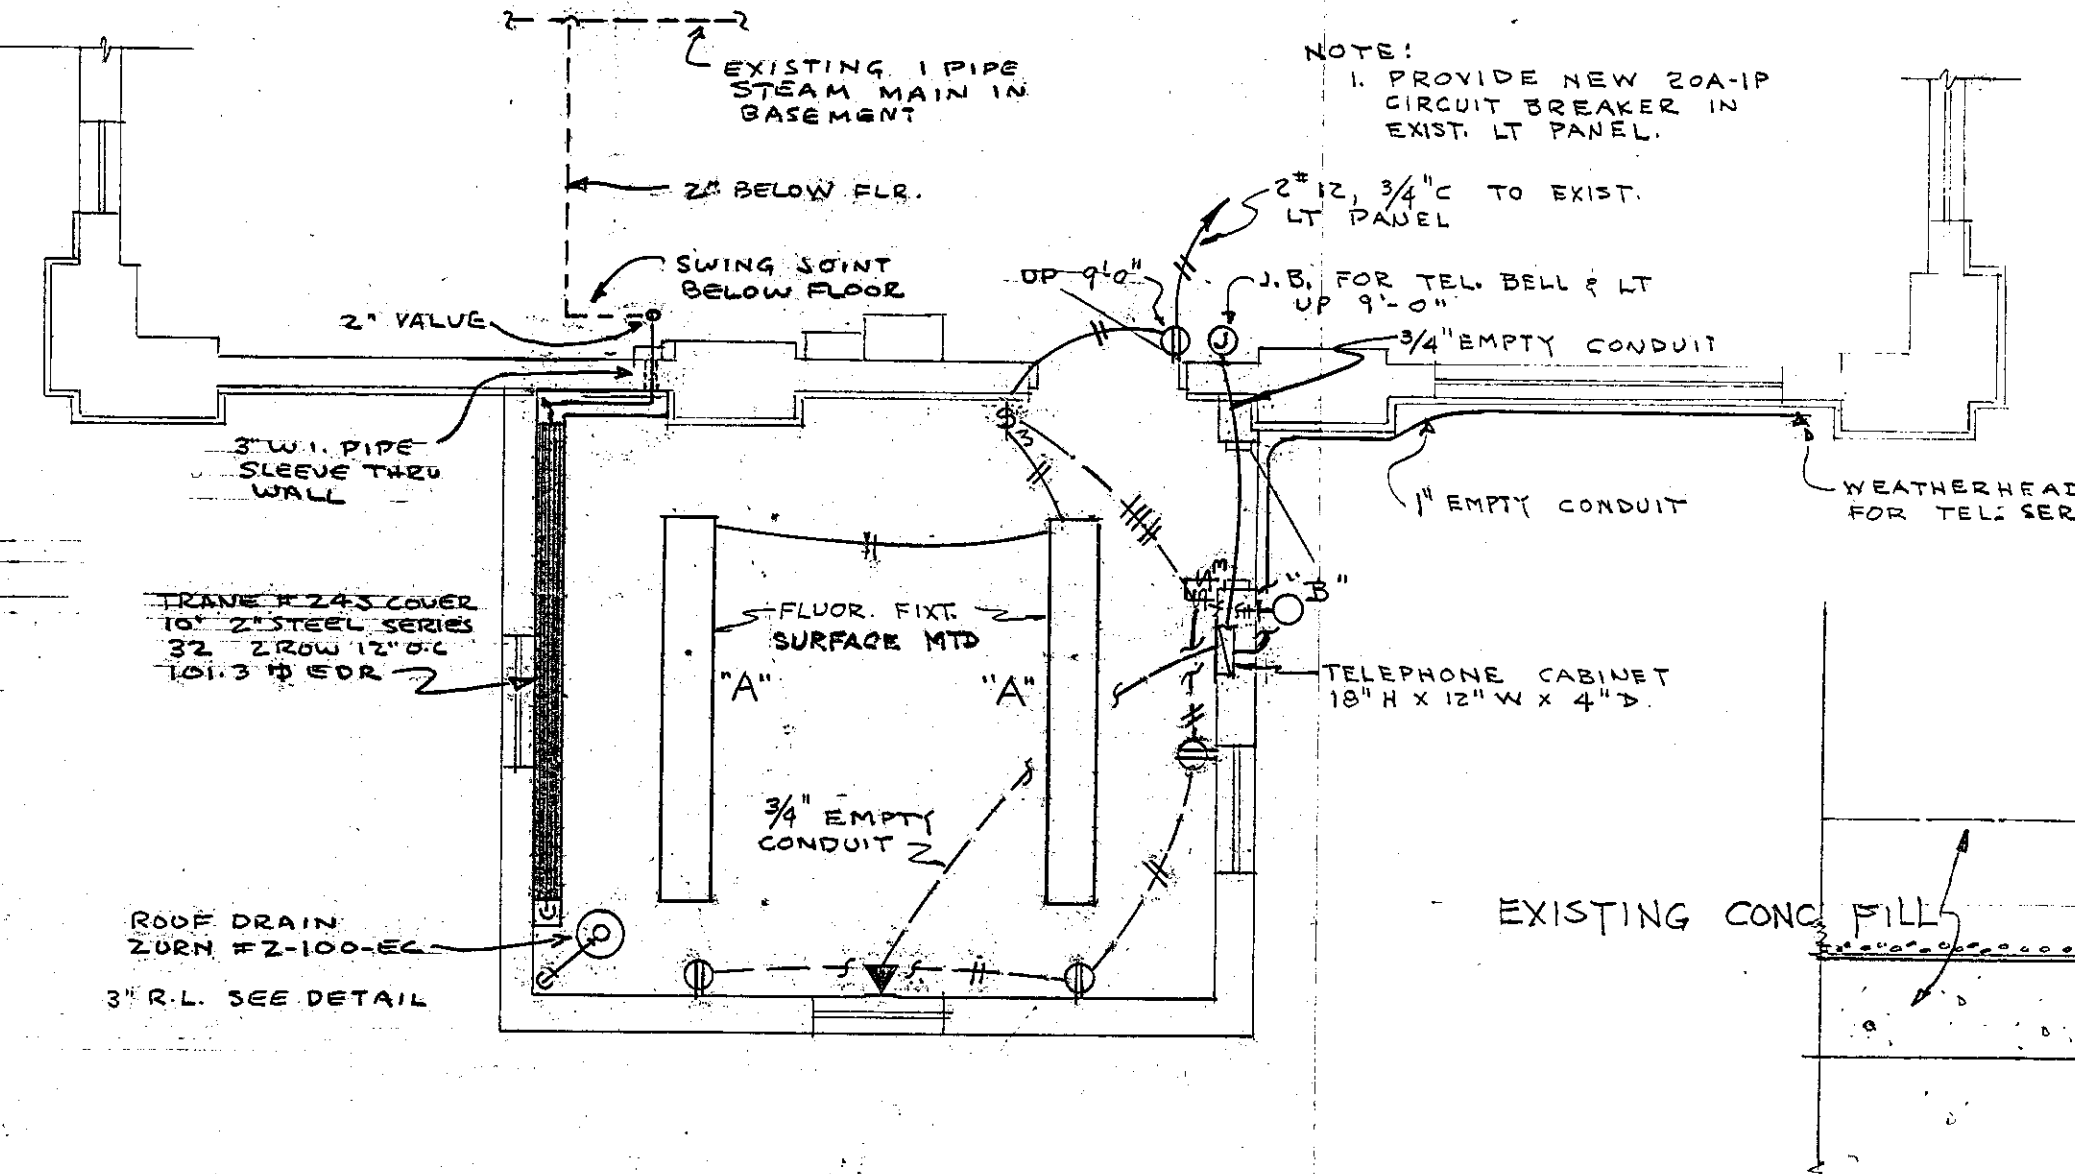


MECHANICAL PLAN
SCALE 1/4"=1'-0"

ELECTRICAL SYMBOLS


⊕	SINGLE POLE SW-UP 4'-6" - H&H 1971
⊕	THREE WAY SW-UP 4'-6" - H&H 1973
⊕	CONV. OUTLET - UP 18" H&H 3262
⊕	TELEPHONE OUTLET-FLUSH MTD-UP 18"
⊕	WALL BRACKET - UP 7'-0" TO TOP

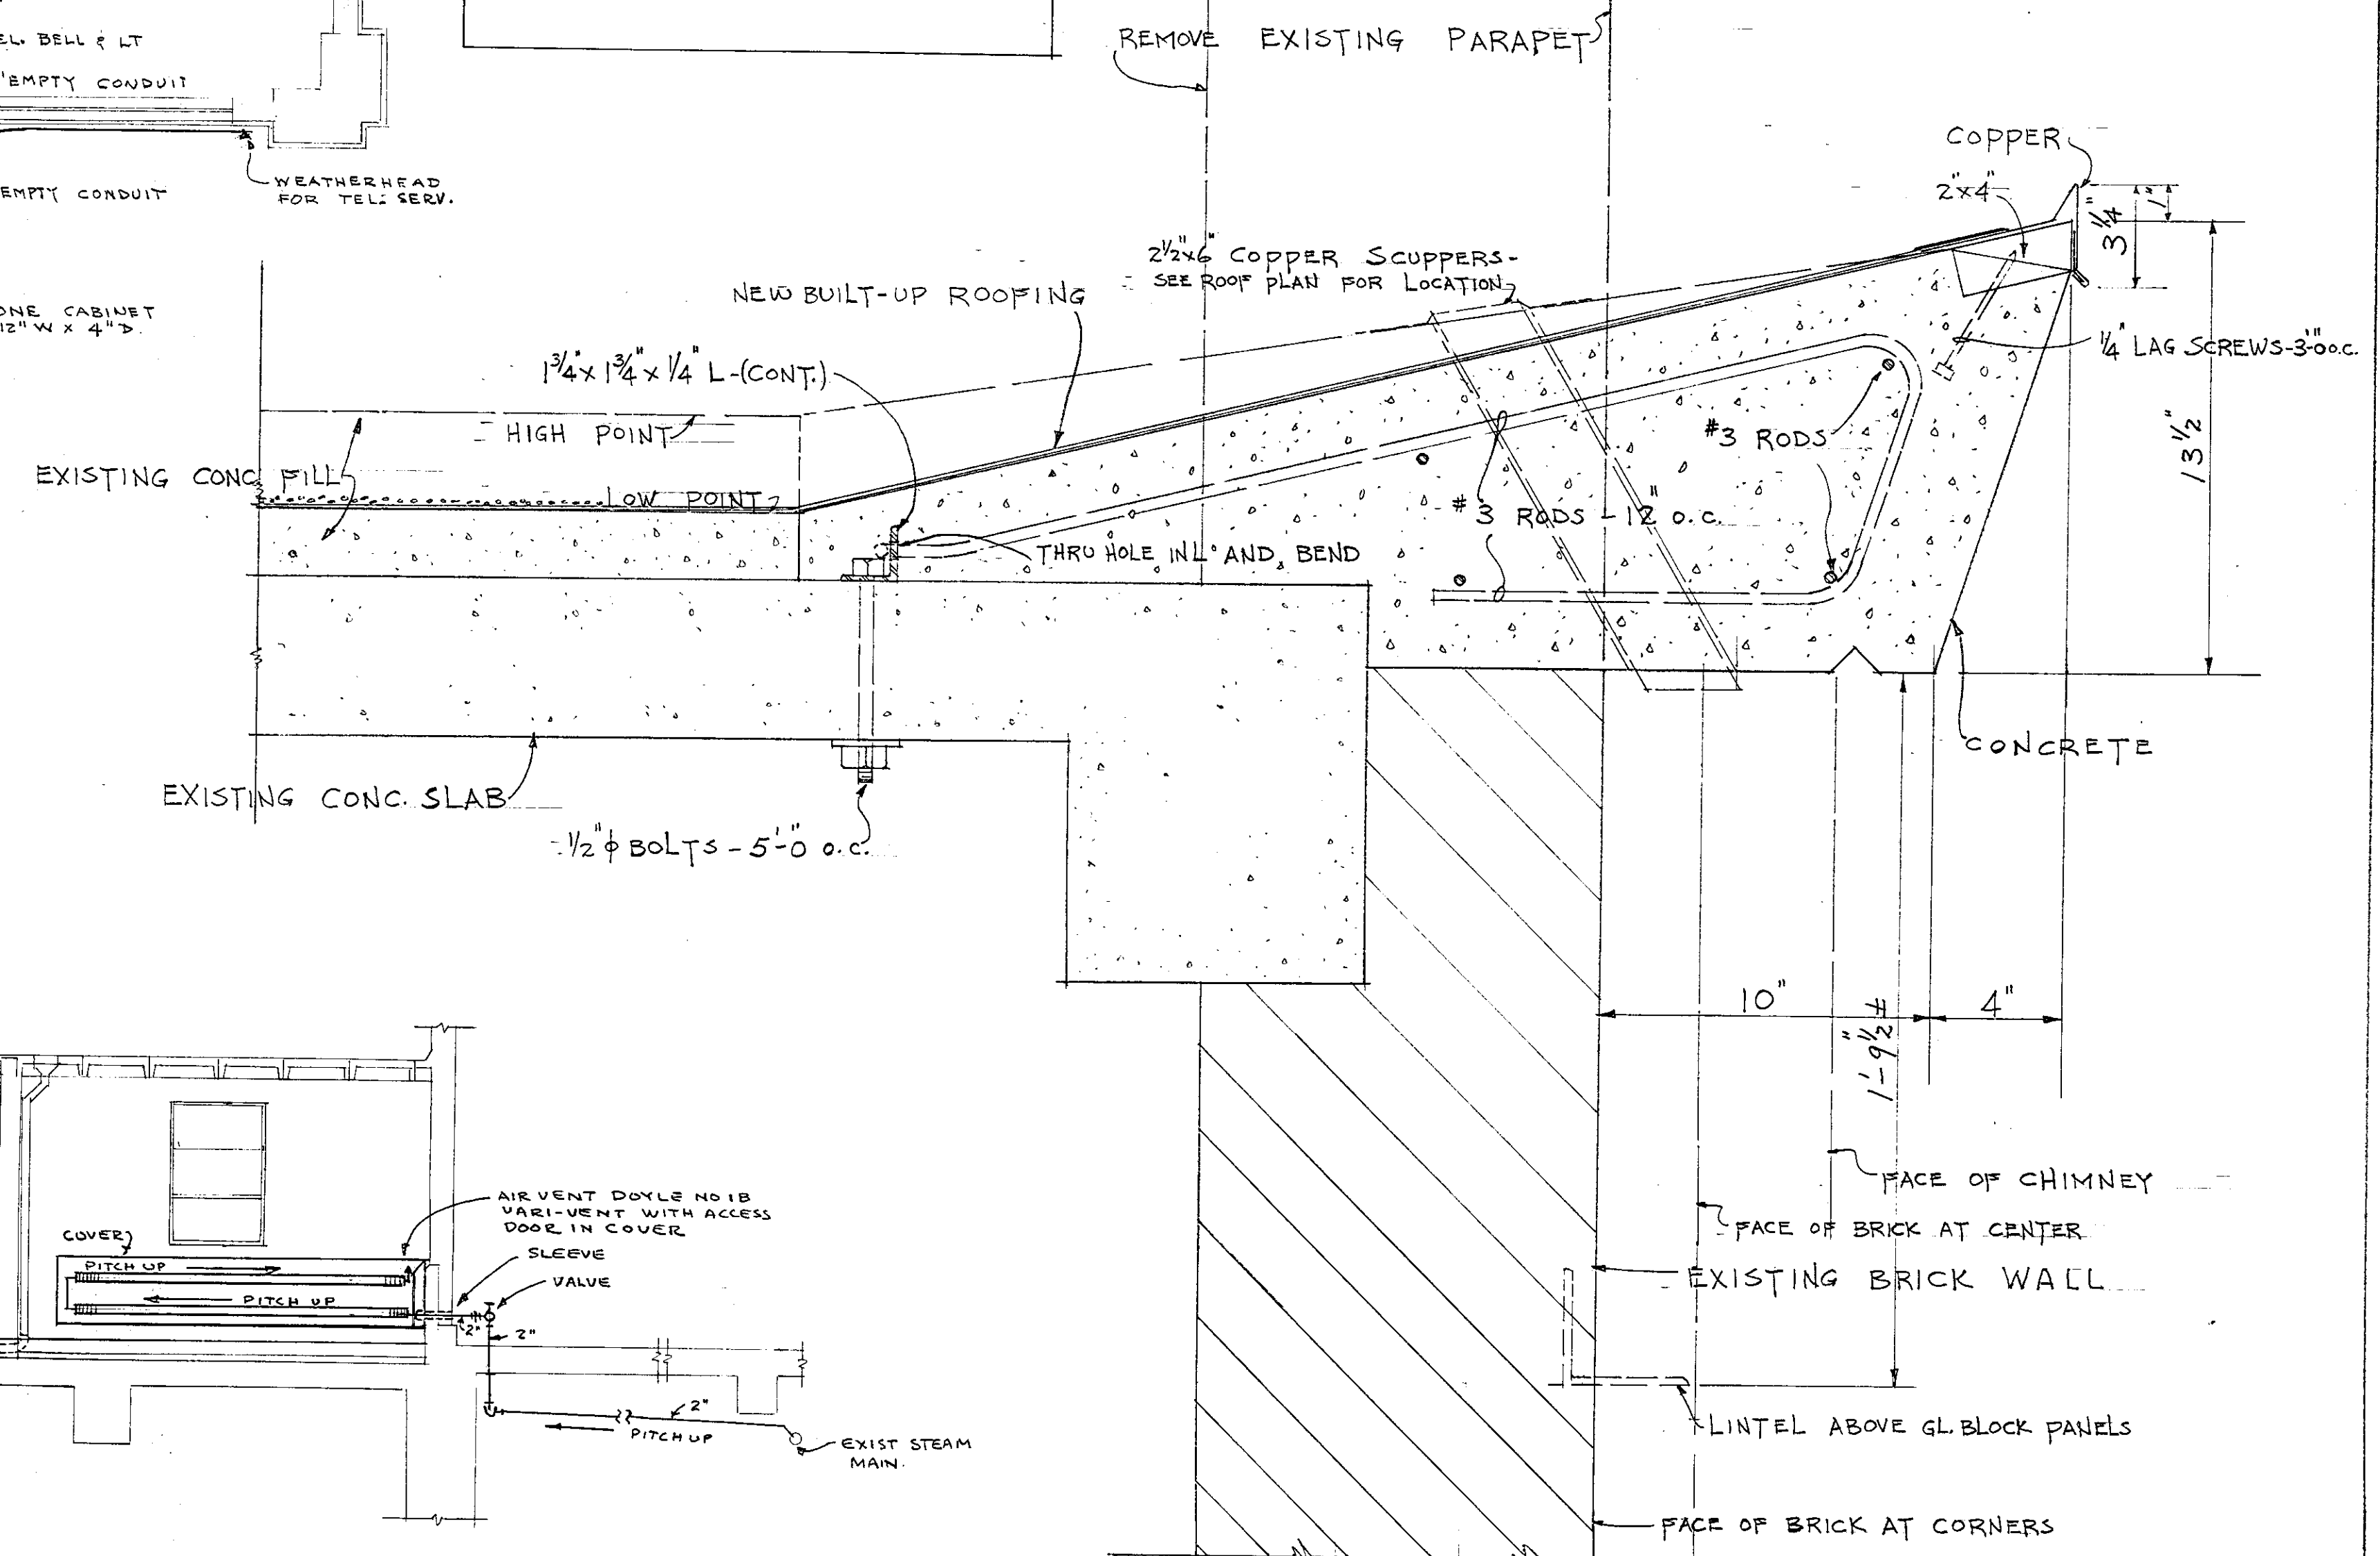


DETAIL OF CONCRETE CORNICE
(NORTH MEADOWS ONLY)
SCALE 3"=1'-0"

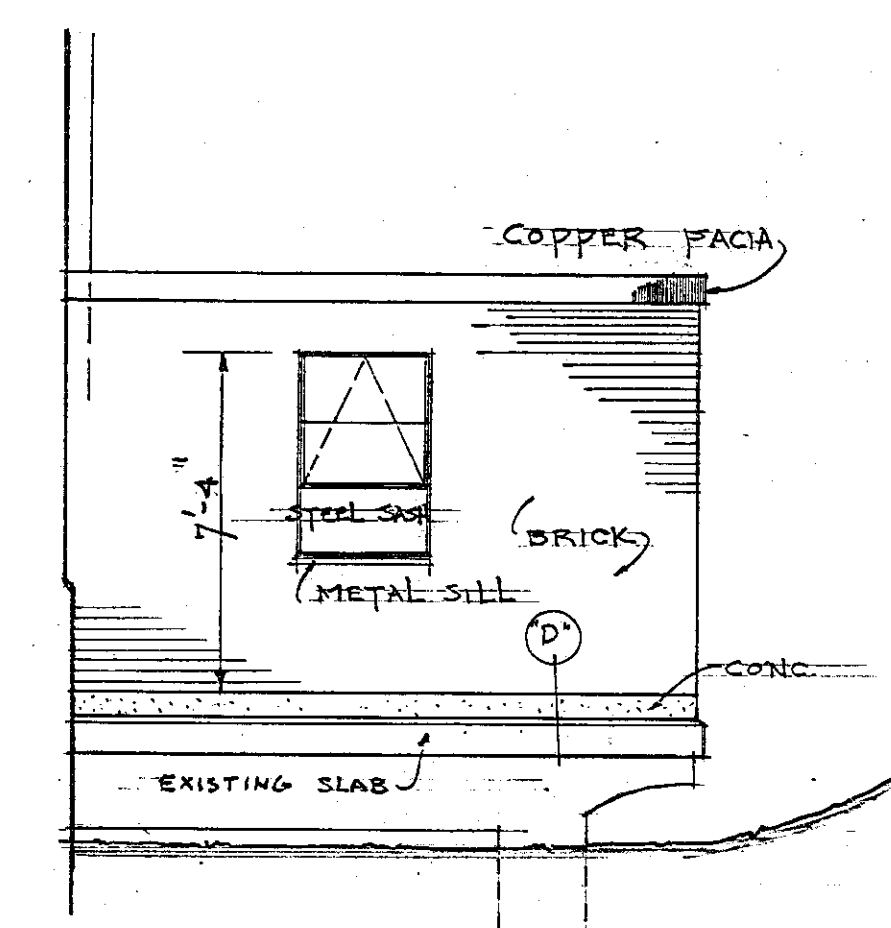


NORTH ELEVATION
SCALE 1/4"=1'-0"

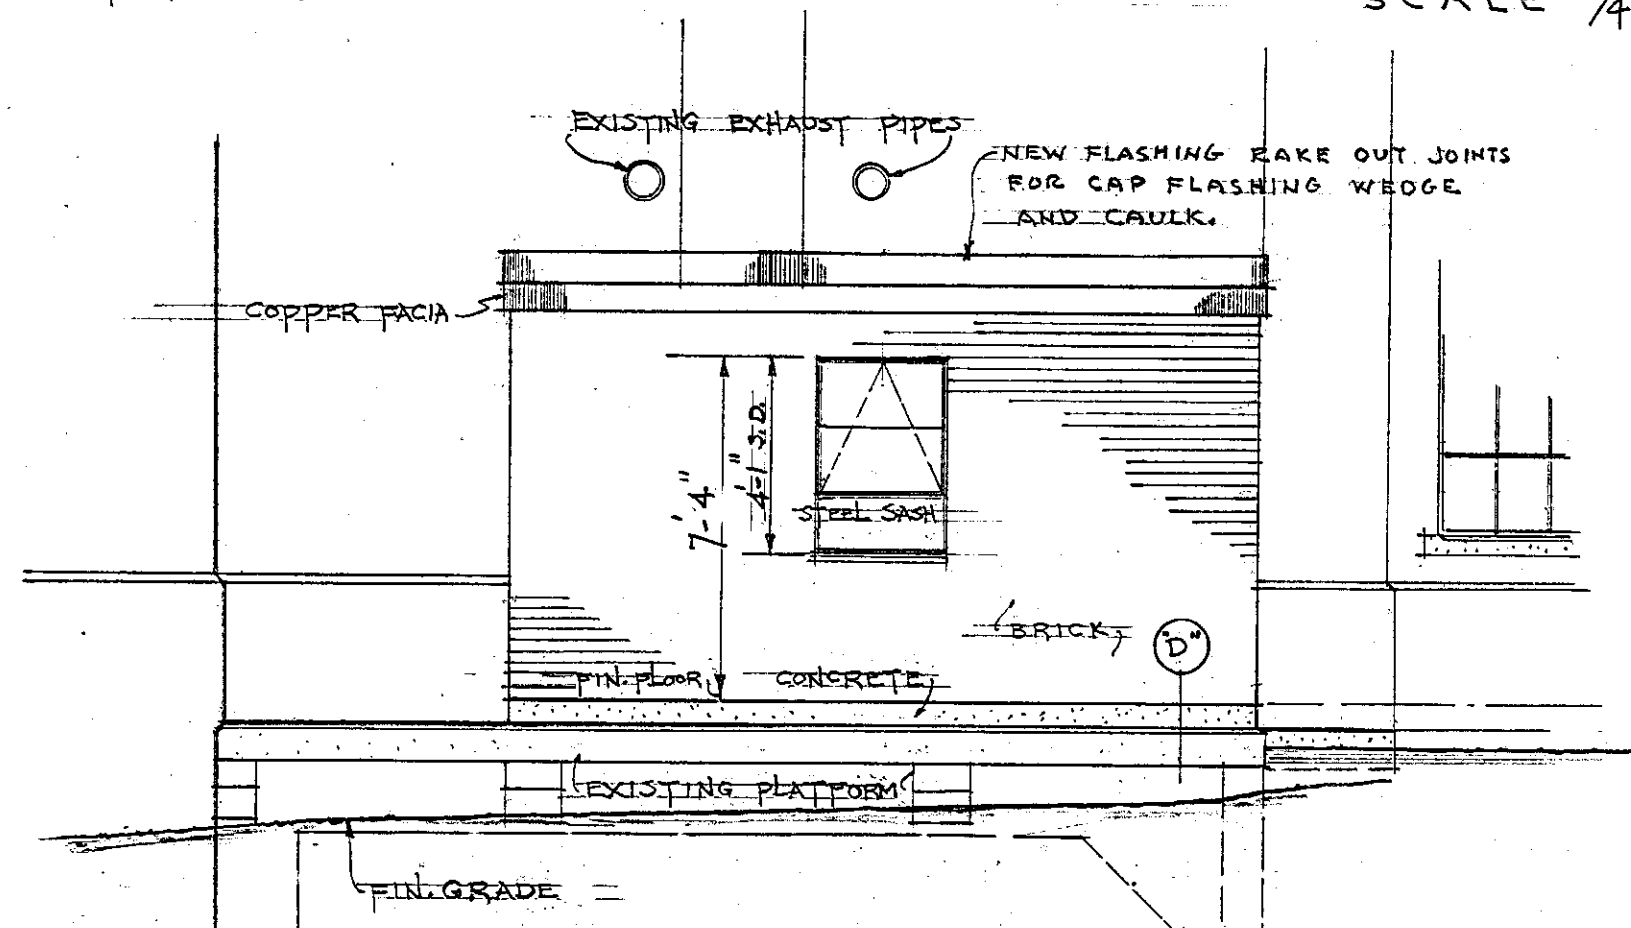


WEST ELEVATION
SCALE 1/4"=1'-0"

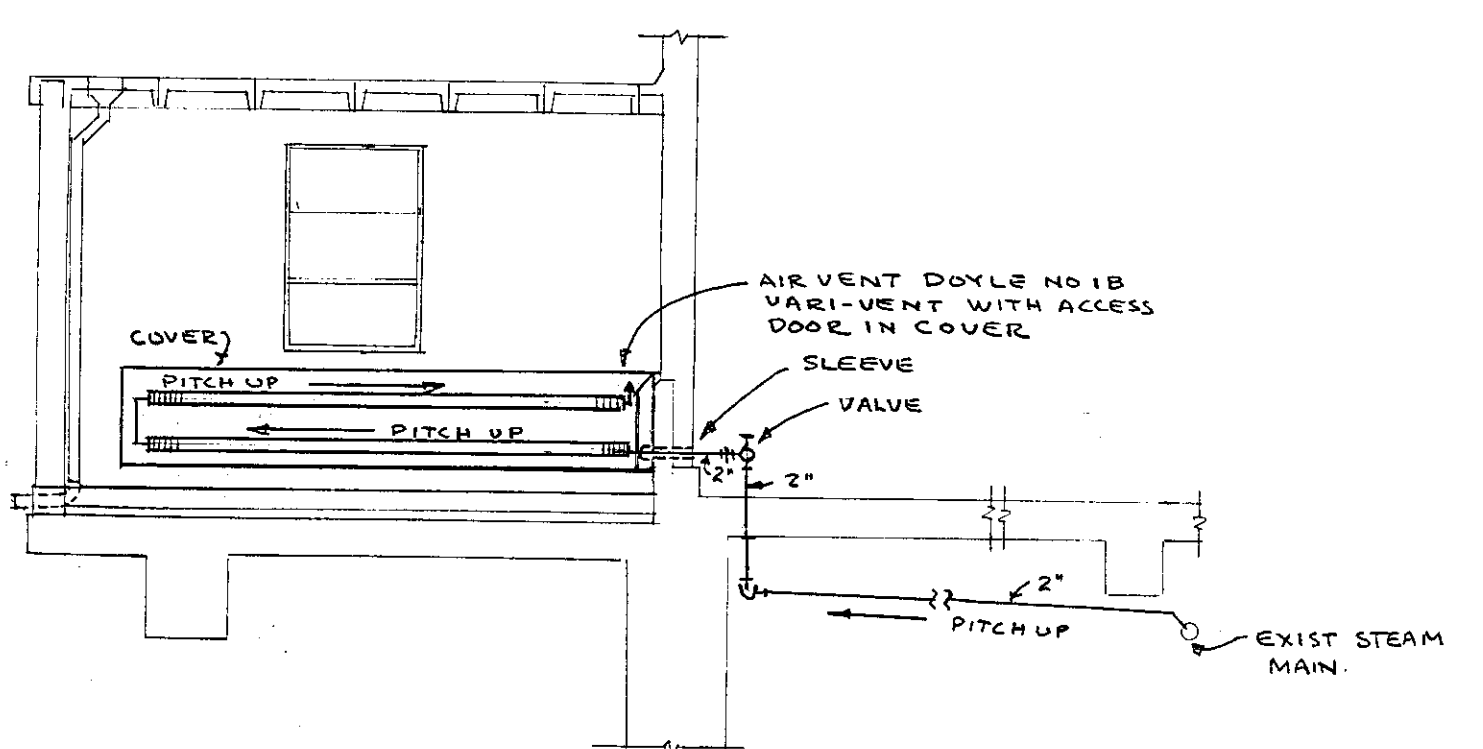


MECHANICAL ELEVATION

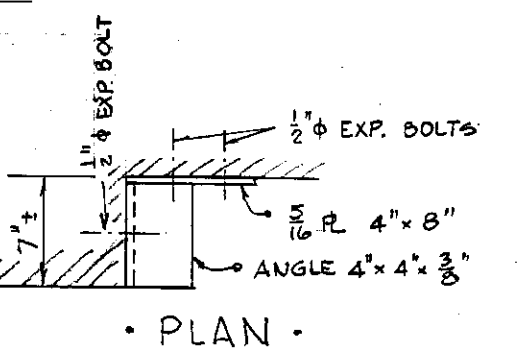


PLAN

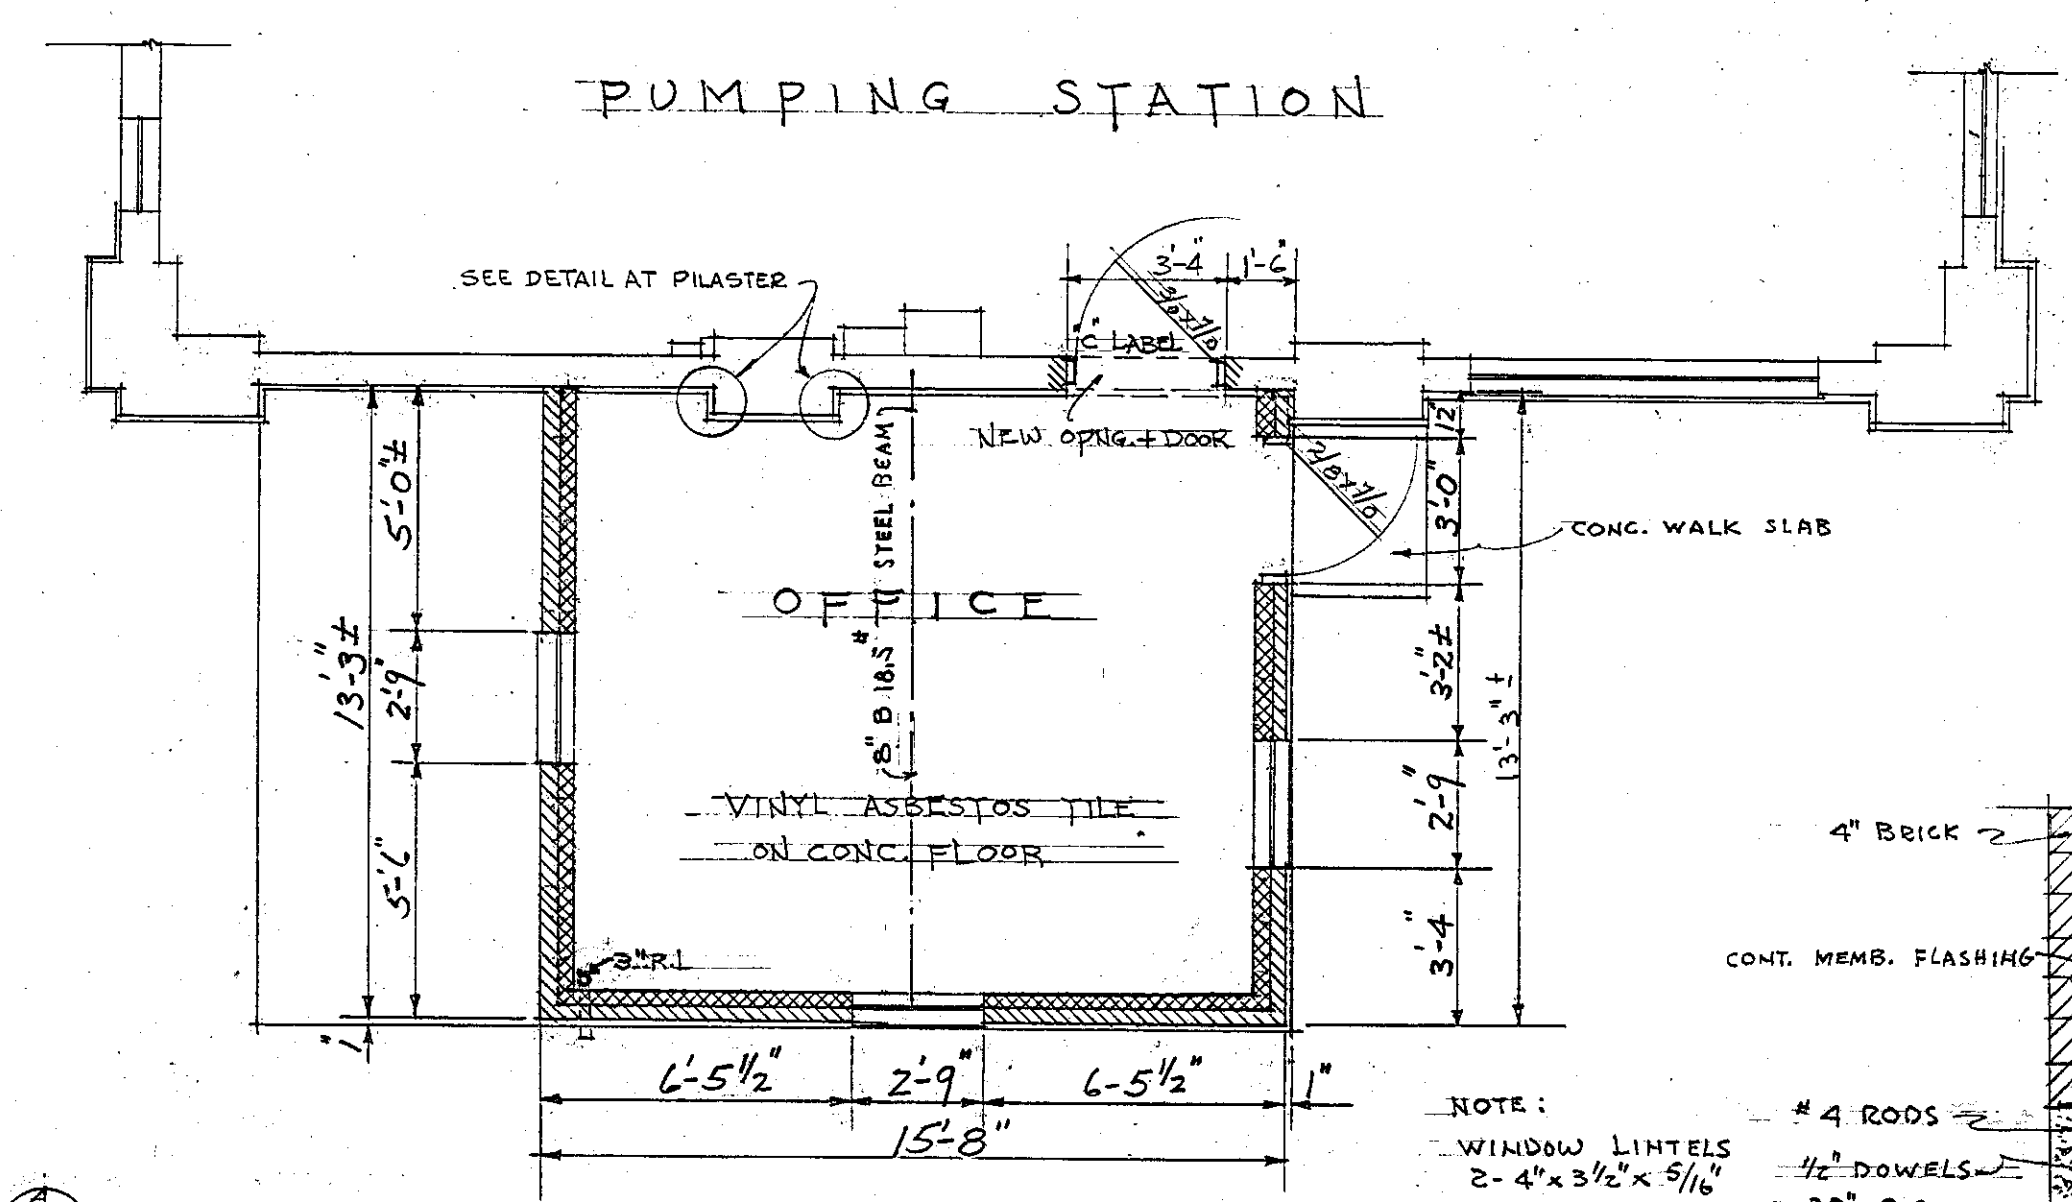


FLOOR PLAN - SOUTH MEADOWS
SCALE 1/4"=1'-0"

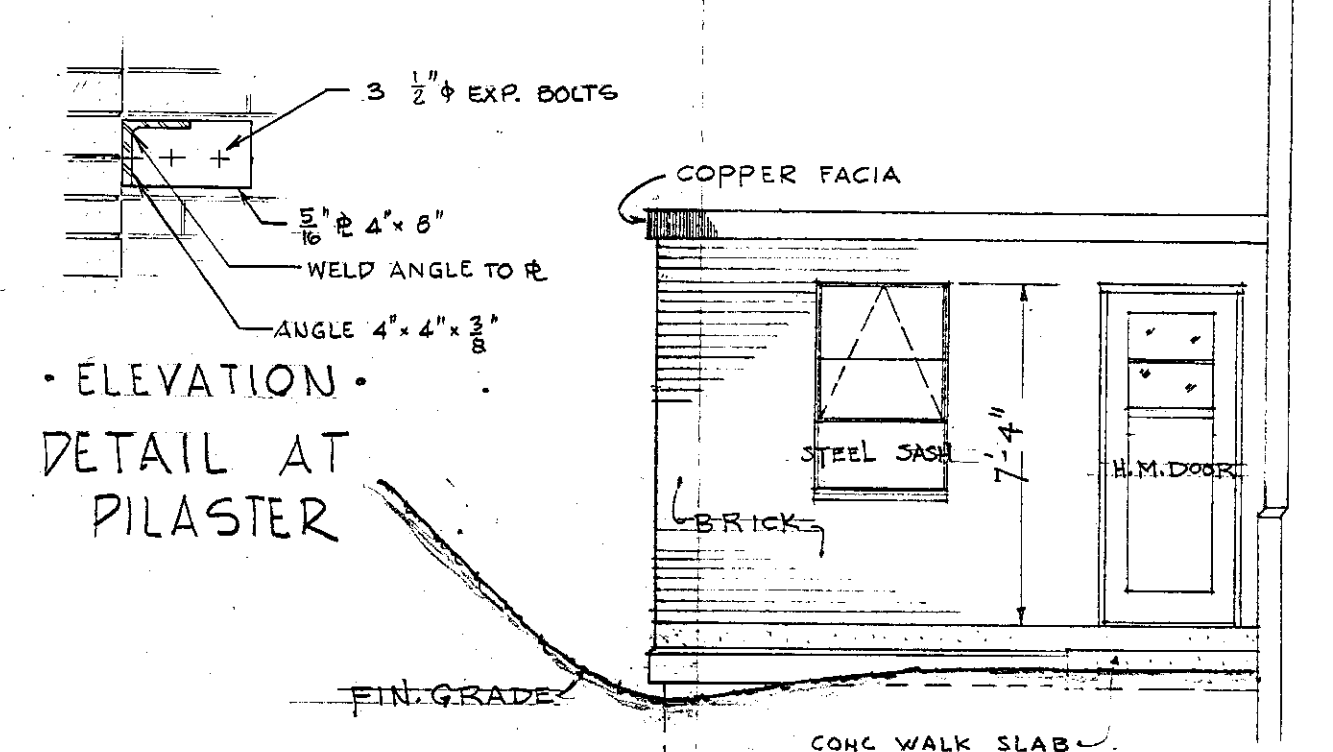


ELEVATION
DETAIL AT PILASTER

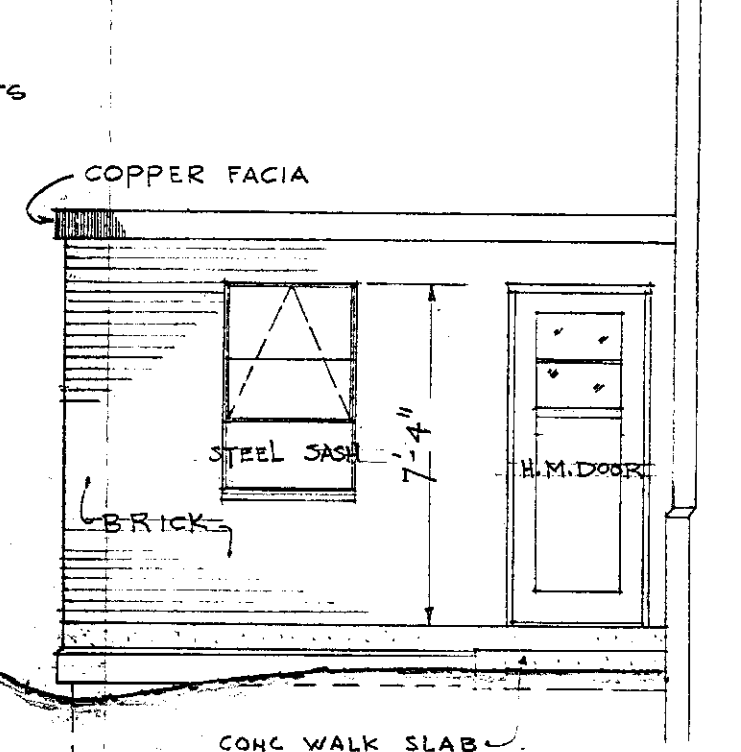

SOUTH ELEVATION
SCALE 1/4"=1'-0"

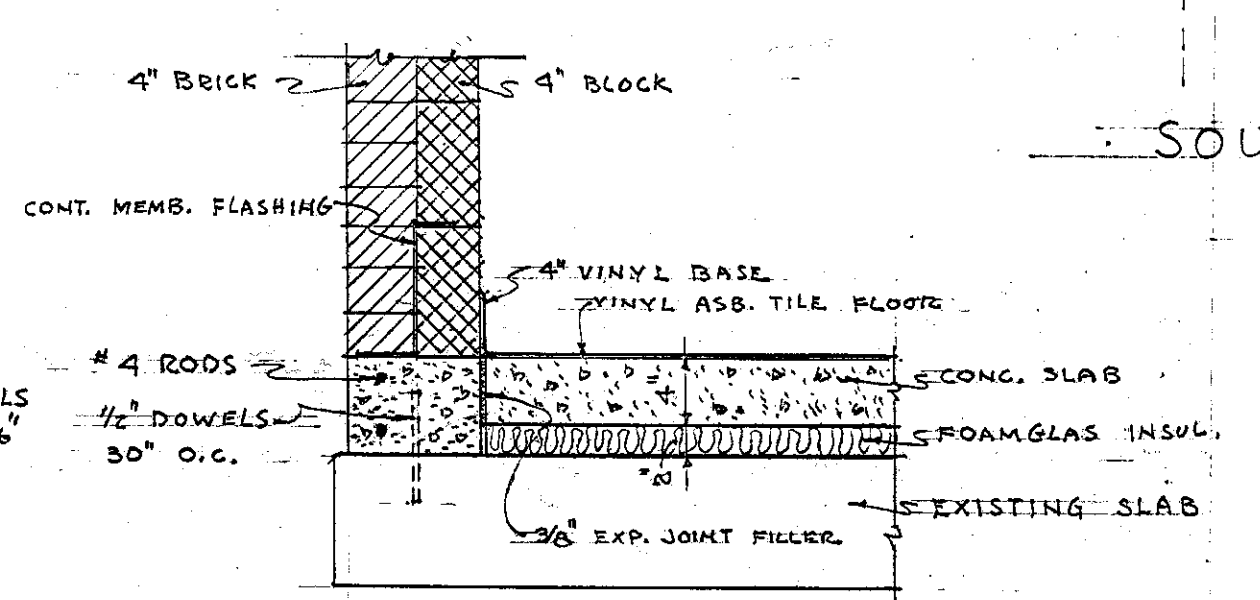

SECTION AT "D" SCALE 1"=1'-0"

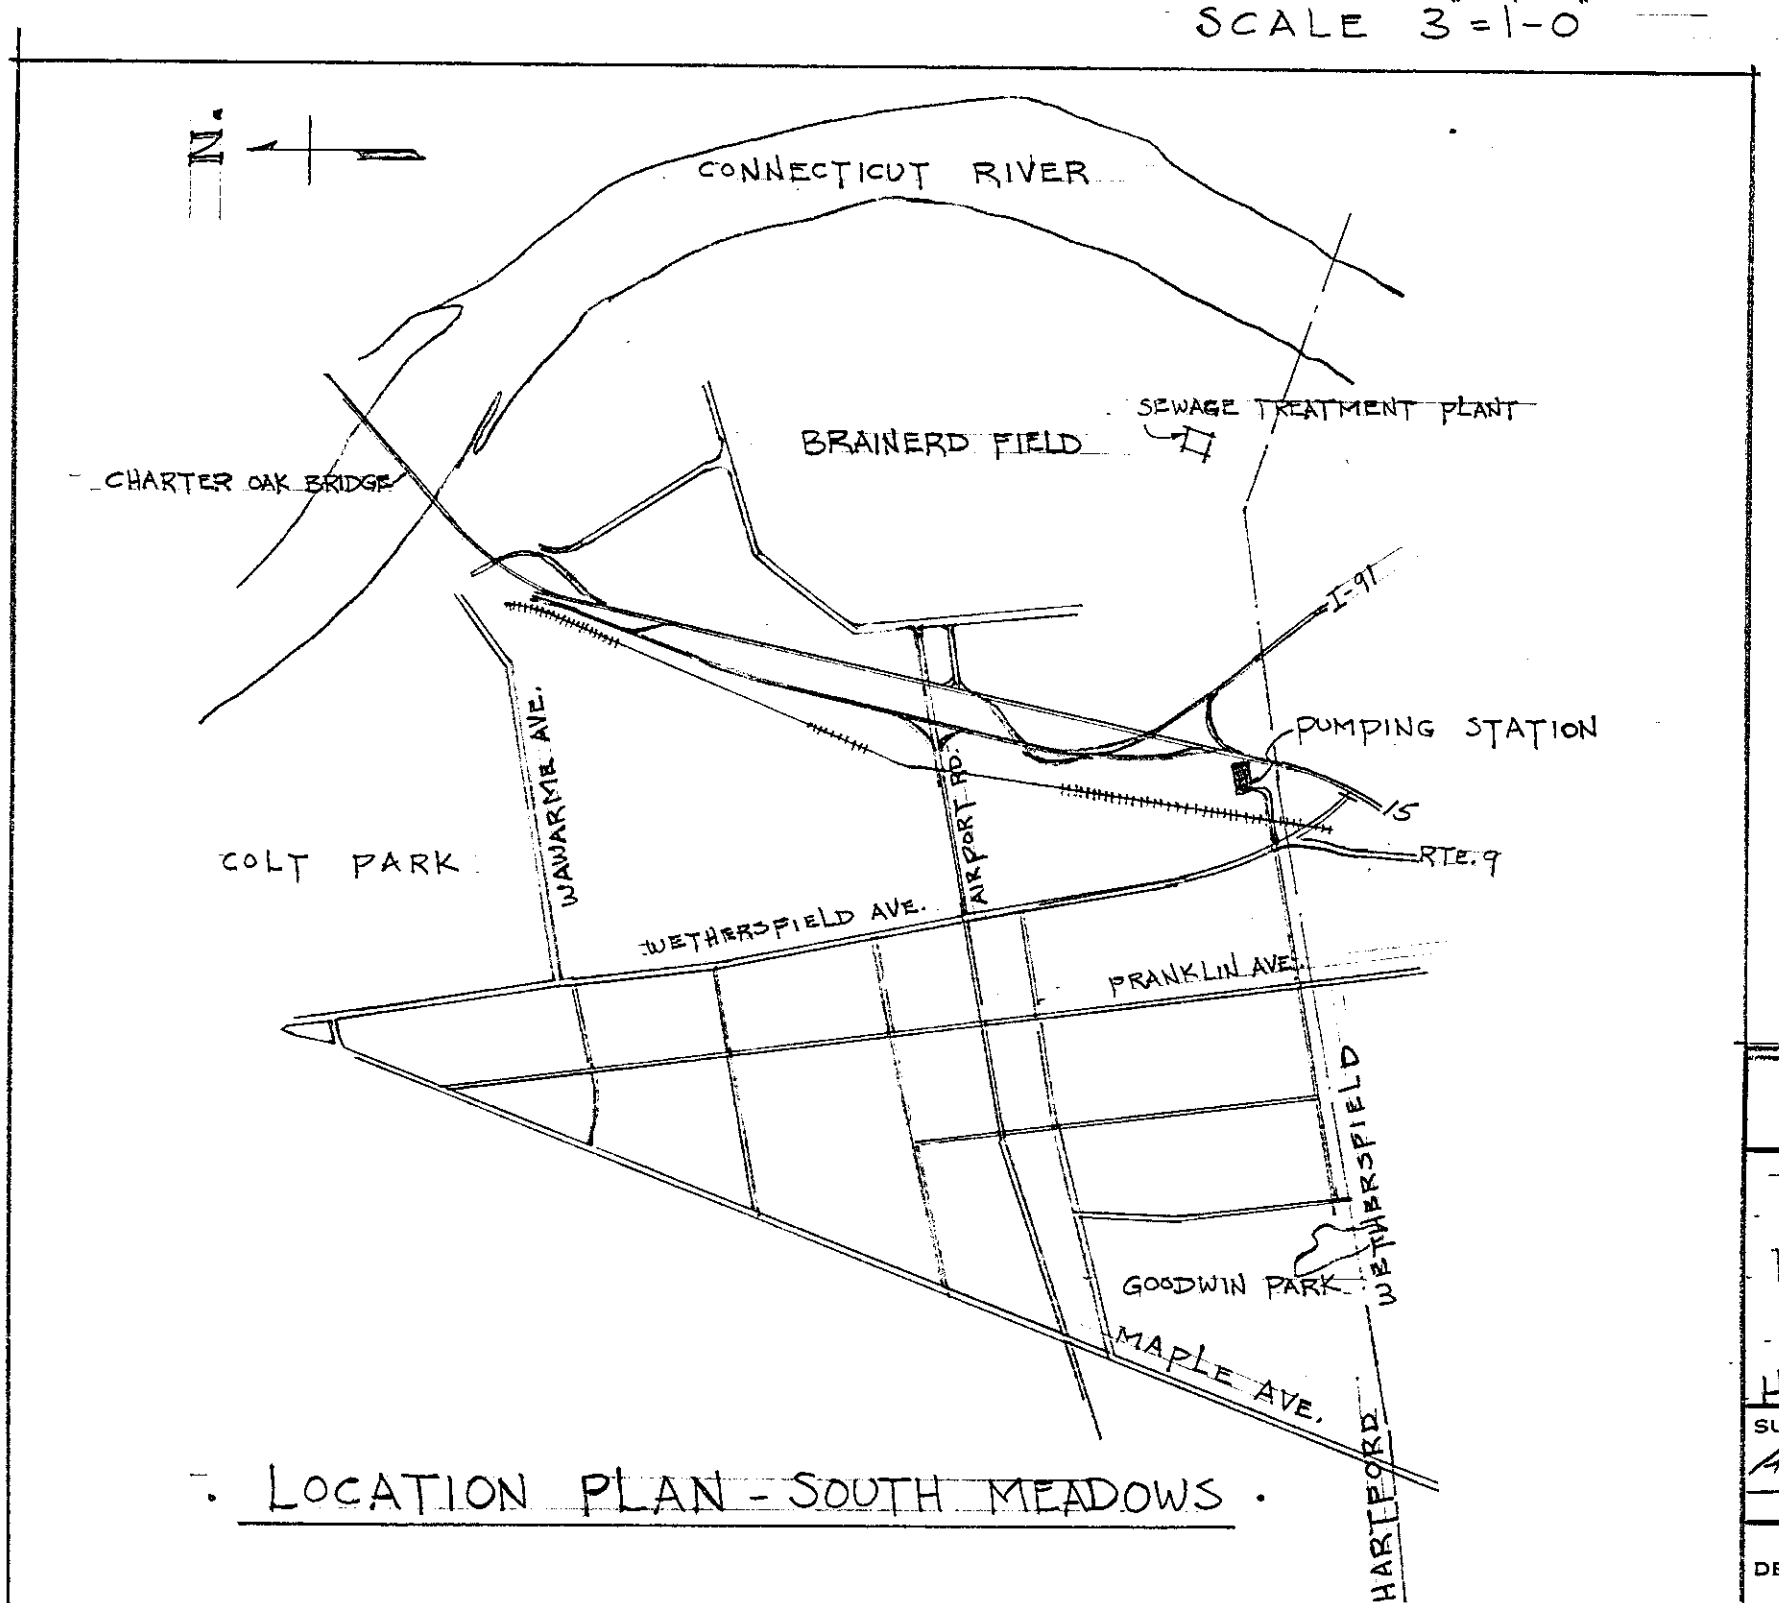

LOCATION PLAN - SOUTH MEADOWS

CITY OF HARTFORD, CONNECTICUT DEPARTMENT OF ENGINEERING		2
OFFICE ADDITIONS AND NEW ROOFING AT NORTH AND SOUTH MEADOWS PUMPING STATIONS HARTFORD, CONNECTICUT		
SUBMITTED A.H. King	RECOMMENDED Daniel J. Willis	APPROVED [Signature]
CITY ARCHITECT	CITY ENGINEER	
DESIGN D.J.L. DRAWN A.H.s	DAYBOOK NO. 09007-B	
TRACED	CHECK	DATE AUGUST 18, 1965