

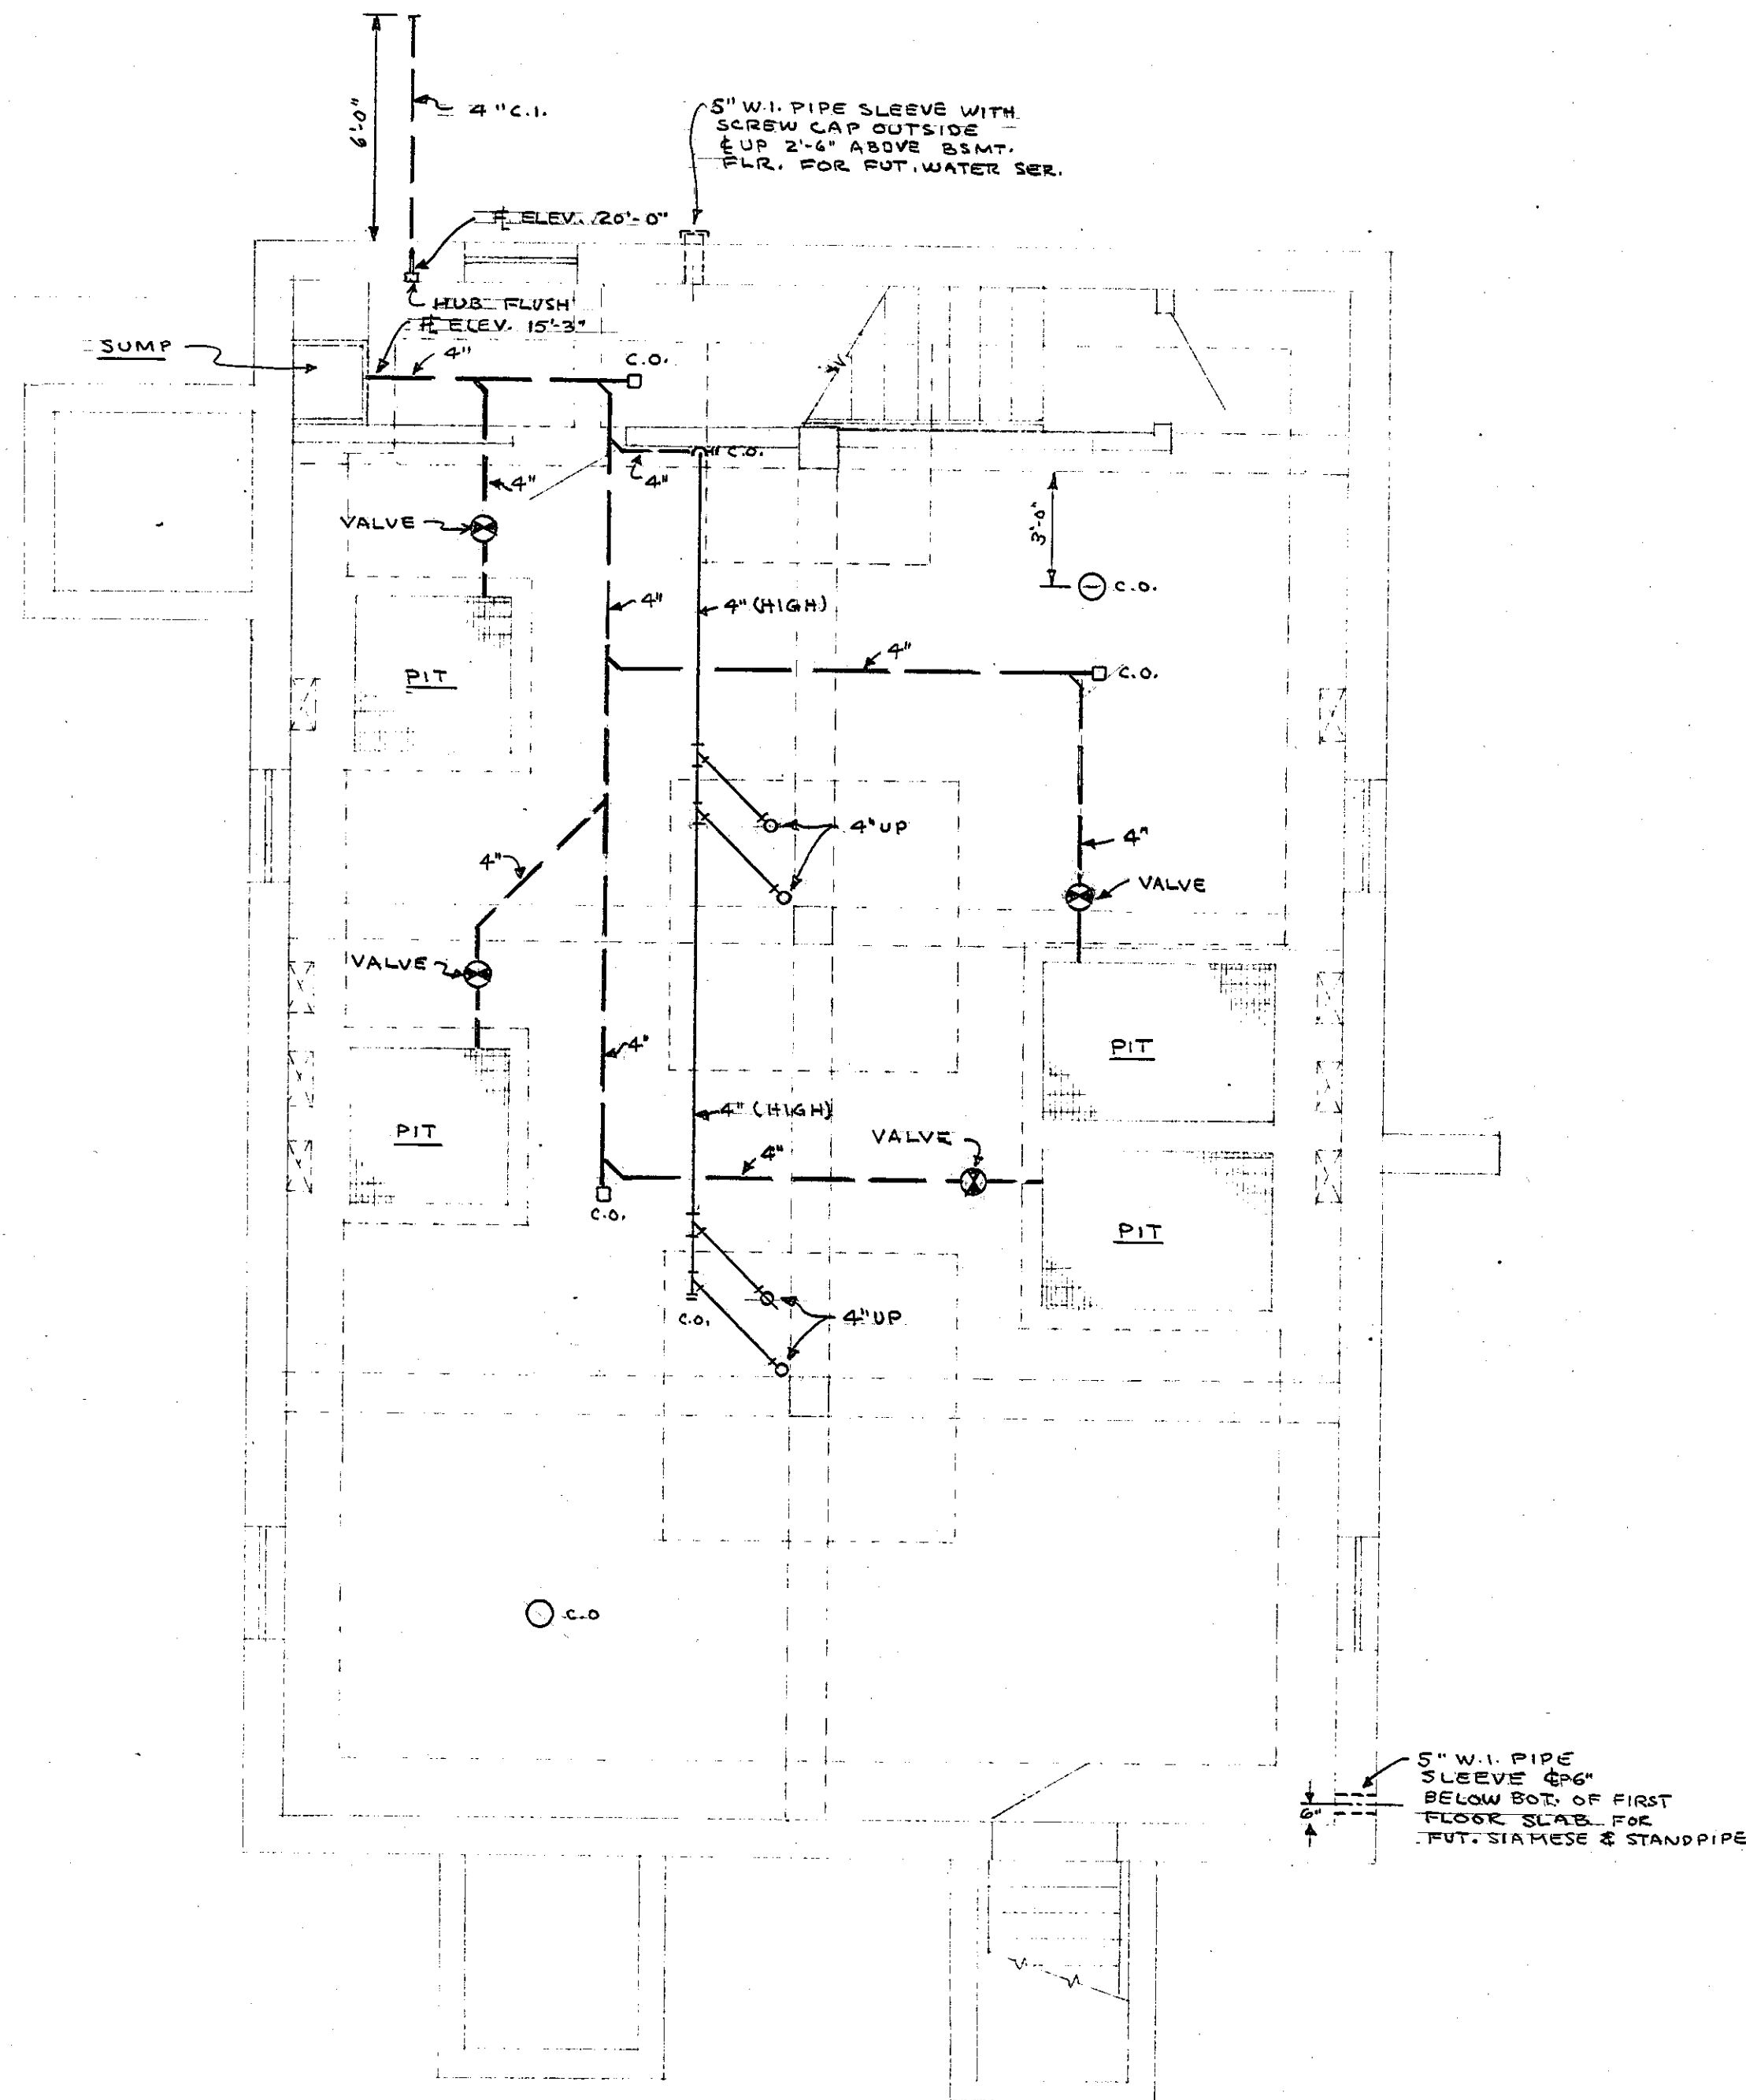


PLUMBING SYMBOLS & SCHEDULES


---	BURIED WASTE - C.I. PIPE
---	EXPOSED WASTE - GALVANIZED PIPE
C.O.	CLEANOUT WITH FLOOR COVER JOSAM Y-304-F WITH BRASS COVER & TOP
C.O.	CLEANOUT JOSAM Y-34 C.I. BODY & BRASS PLUS
F.D.	FLOOR DRAIN JOSAM G14 C.I. LACQUER
⊙	HOSE ACCESS COVER BOOSEY 6220-NP SIZE 10" WITH BRASS COVER, STEEL SLEEVE, ROD & CEILING BRASS PLATE COVER FOR 4" CONC. FLOOR SLAB
⊙	VALVE JOSAM 1154-YY C.I. BACKWATER GATE VALVE
C.O.	CLEANOUT JOSAM Y-584-F BRASS TOP (SEE DETAIL)

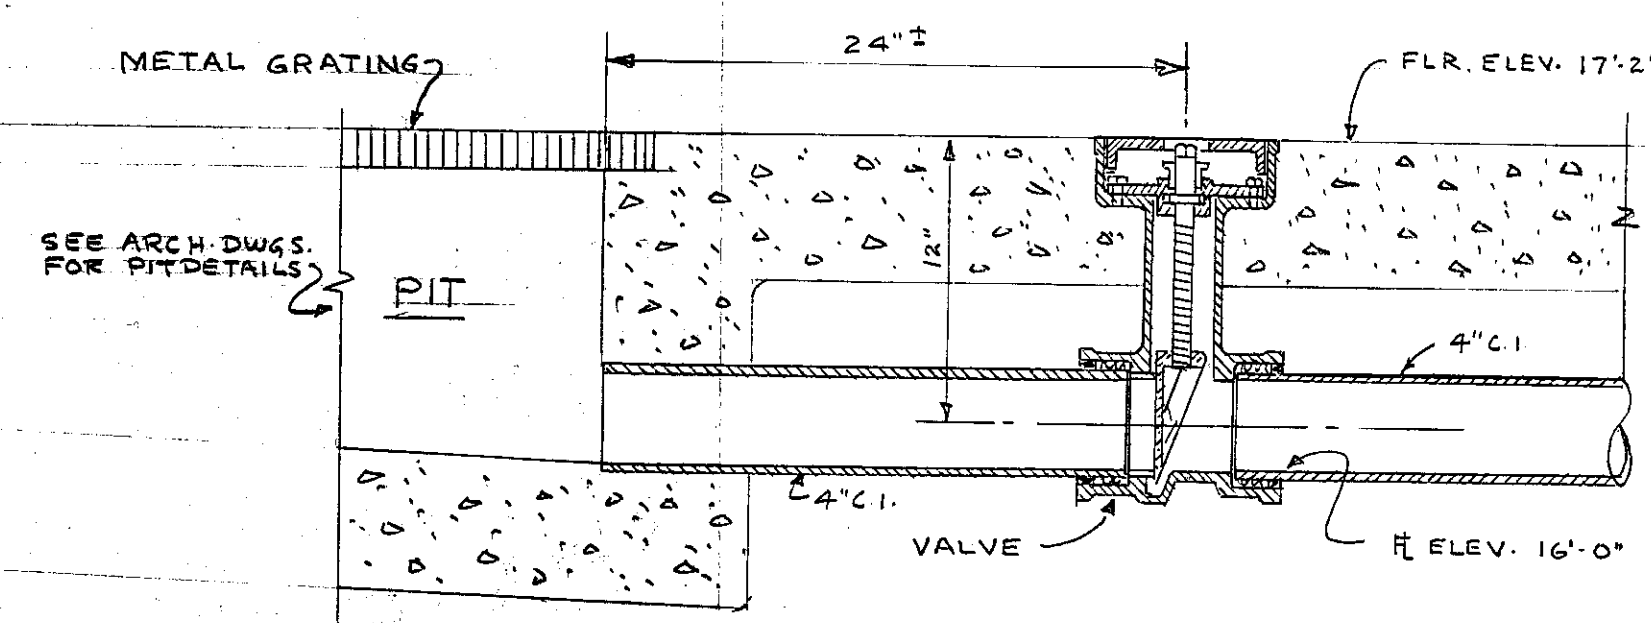



BASEMENT FLOOR PLAN
SCALE 1/2"=1'-0"

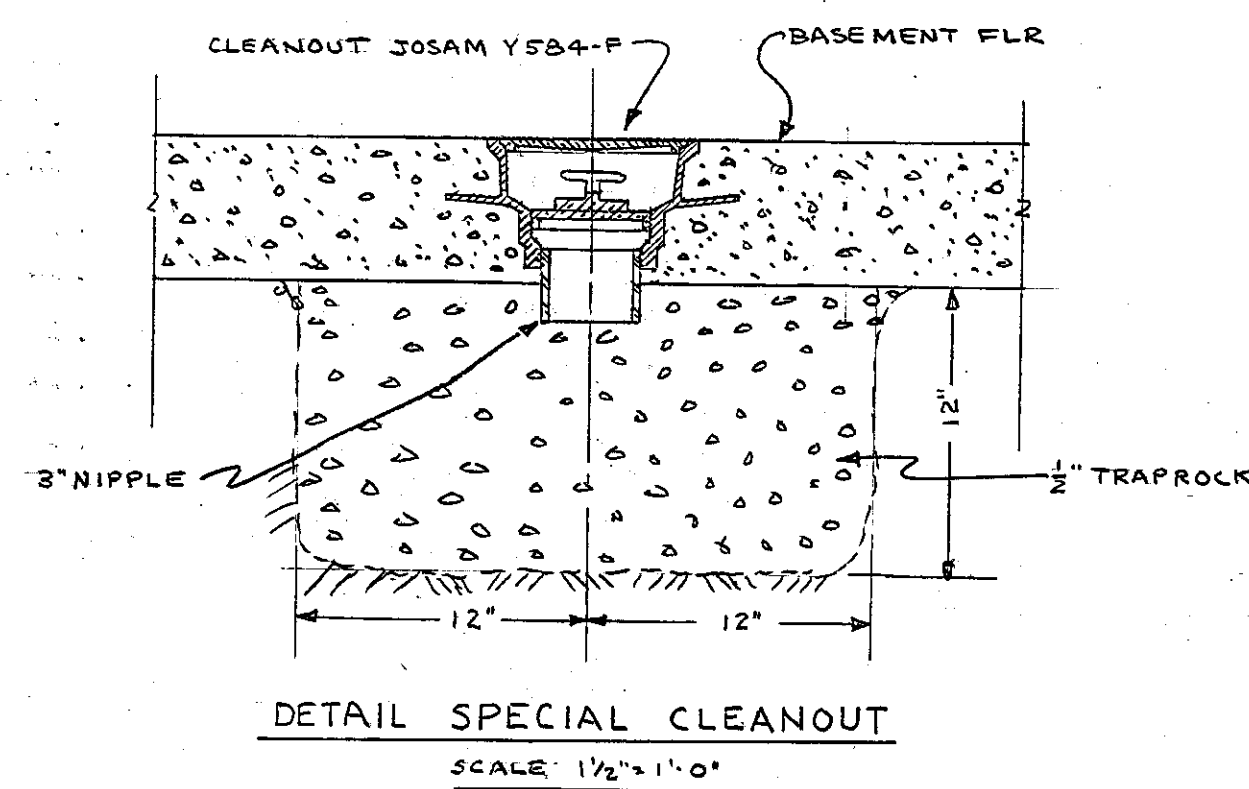

DETAIL VALVE AND PIT
SCALE 1/2"=1'-0"

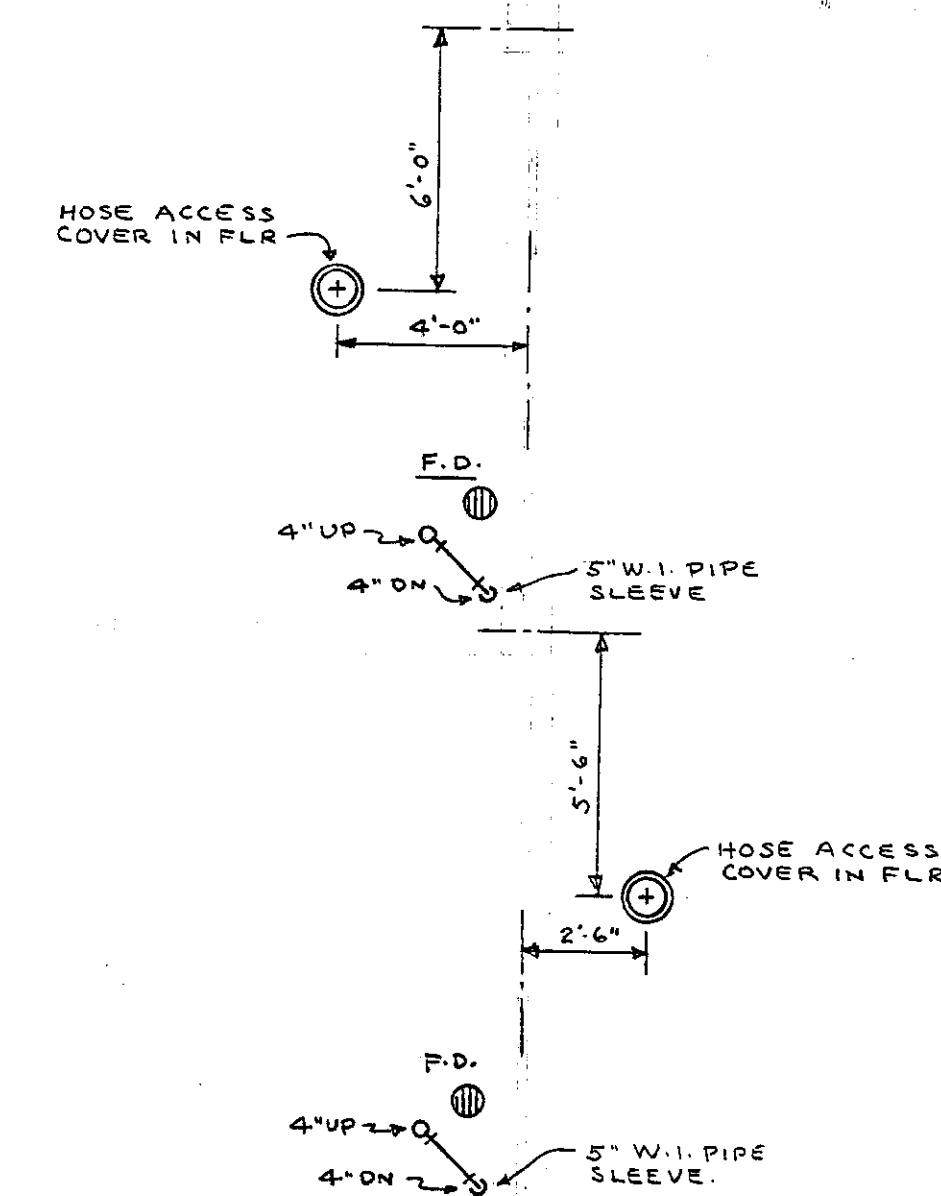

FIRST FLOOR PLAN
SCALE 1/2"=1'-0"

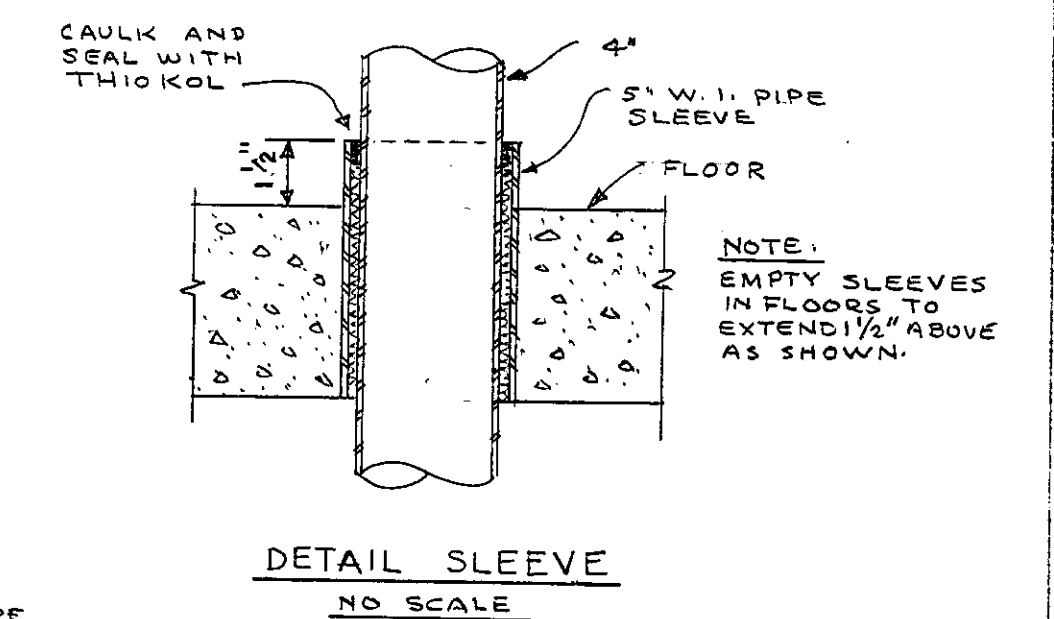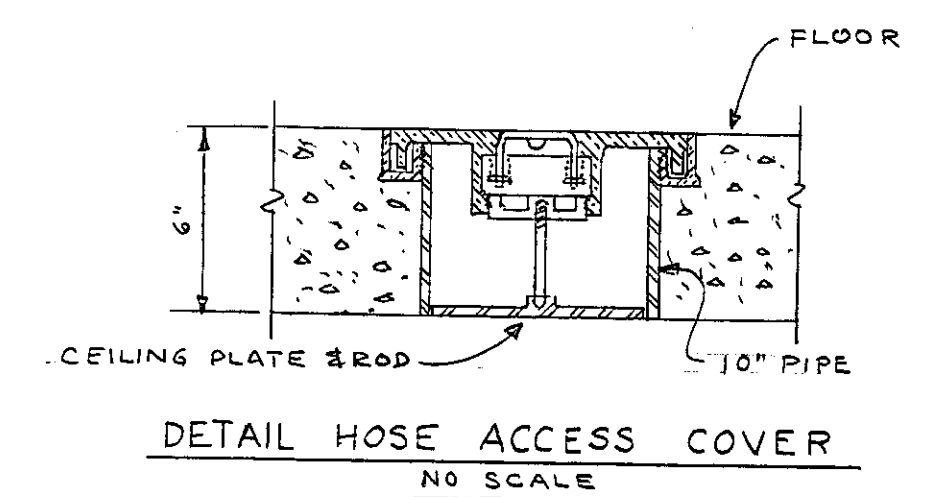

MECHANICAL.

CITY OF HARTFORD, CONNECTICUT DEPARTMENT OF ENGINEERING		
SMOKE TRAINING BLDG. FIRE DEPT. NORTH MEADOWS HARTFORD, CONN.		DWG. NO.
SUBMITTED <i>[Signature]</i>	RECOMMENDED <i>[Signature]</i>	APPROVED <i>[Signature]</i>
DESIGN <i>P.D.P.</i>	DRAWN <i>P.D.P.</i>	DAYBOOK NO. 09902-J
TRACED	CHECK	DATE