



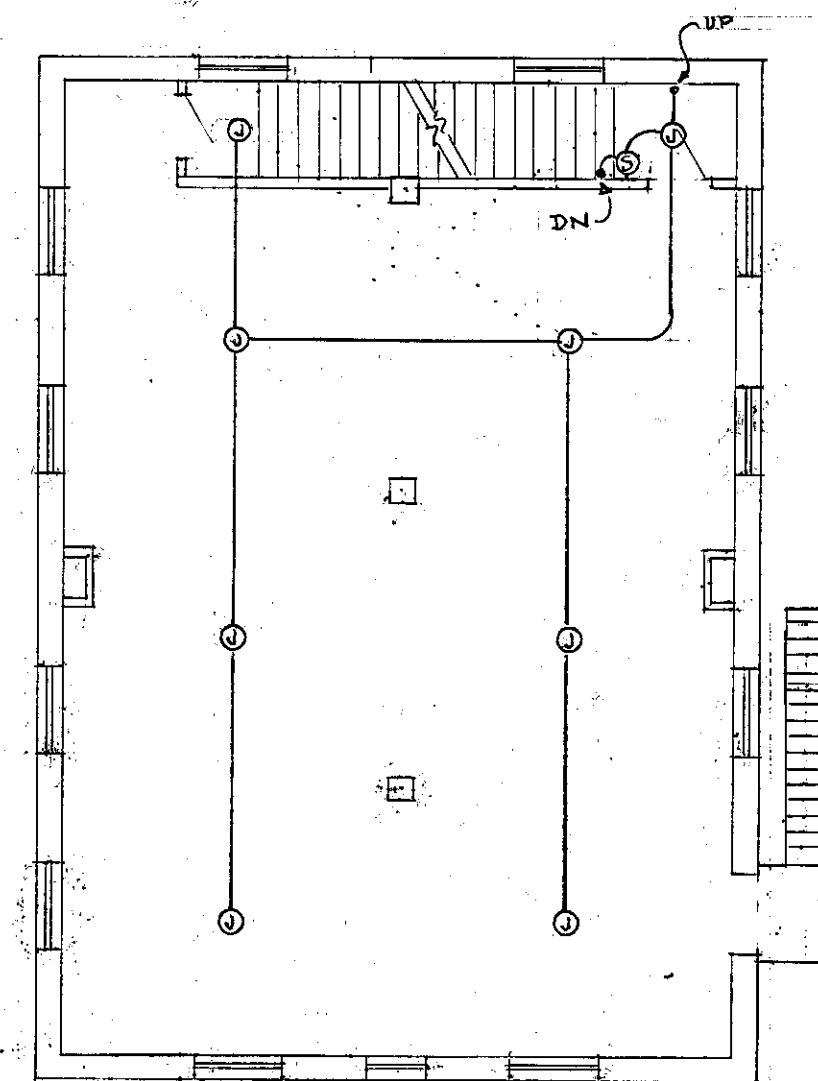

SECOND FLOOR PLAN


SCALE 1/8" = 1'-0"

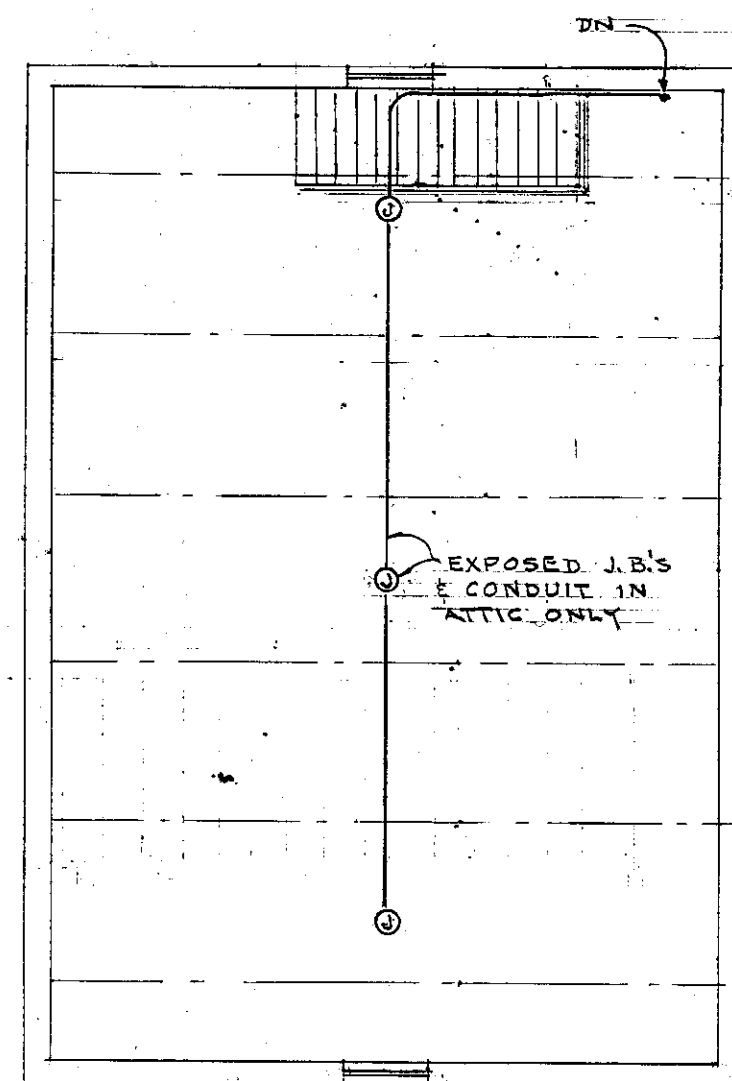

THIRD FLOOR ATTIC PLAN


SCALE 1/8" = 1'-0"

1/2" CONDUIT
2'-6" BELOW FIN. GRADE.
OUT 5'-0" FROM BLDG.
CAY END.

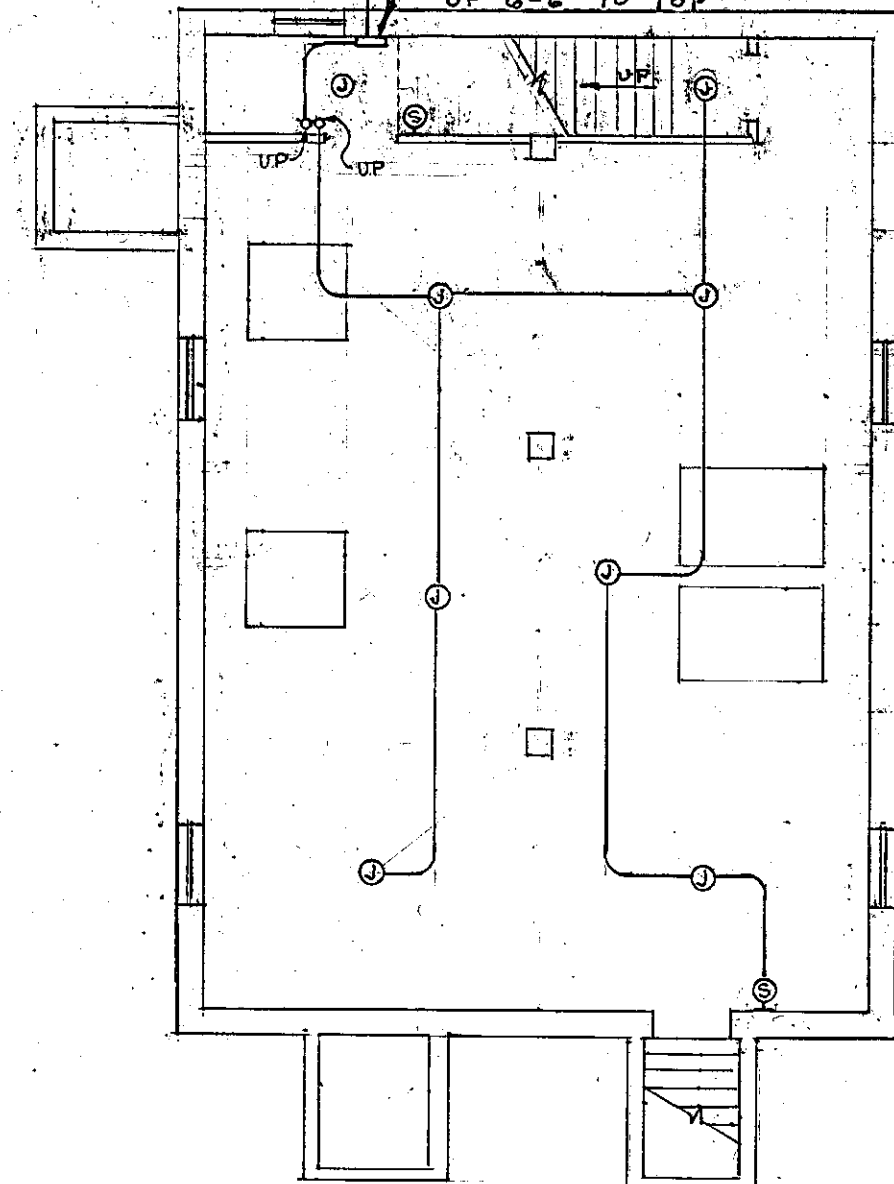

BASEMENT FLOOR PLAN

SCALE 1/8" = 1'-0"

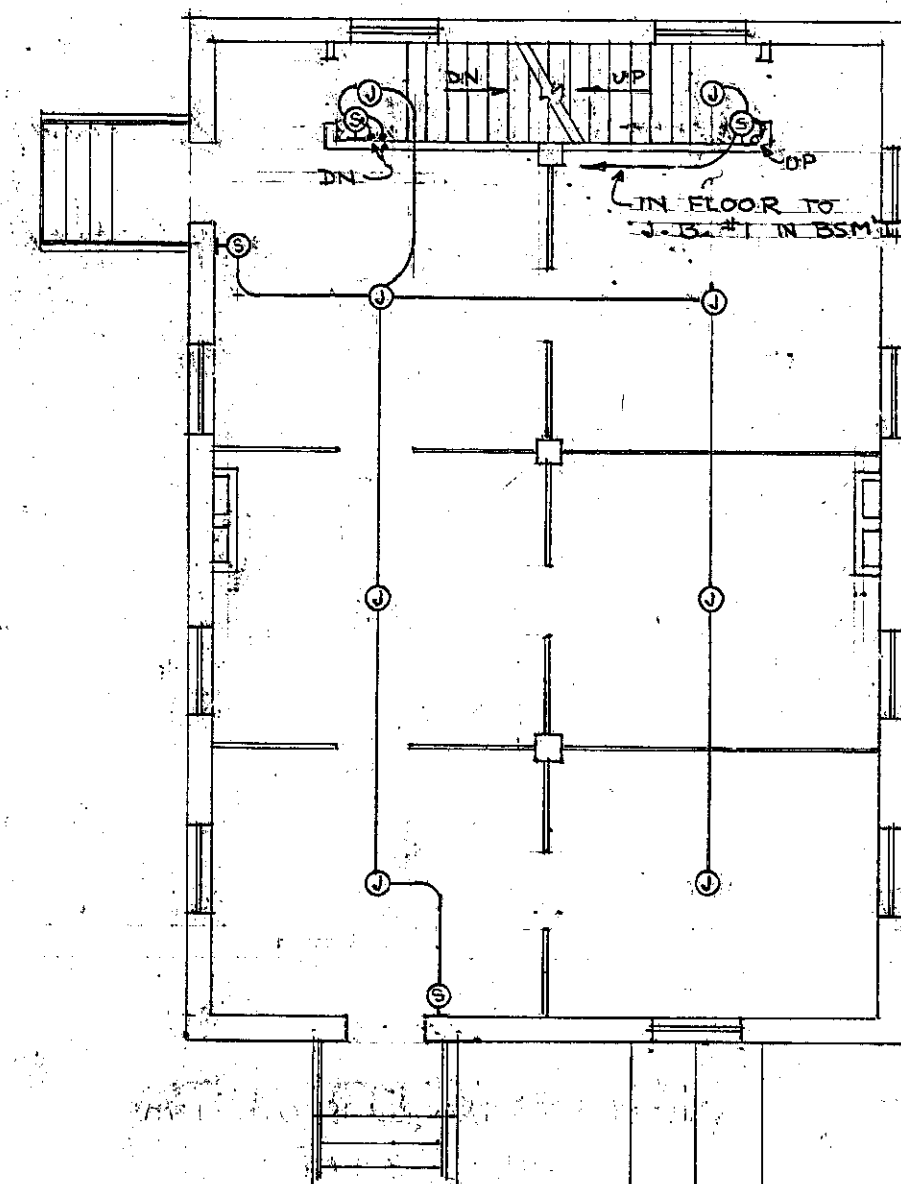

FIRST FLOOR PLAN

SCALE 1/8" = 1'-0"

LEGEND (ELEC)

- ① CEILING JUNCTION BOX - ROUND CAST BOX WITH 3/4" THREADED HUBS - FLUSH MOUNTED - NEOPRENE GASKET & BLANK COVER - TO BE M'PHILBEN # P4301A 3/4"
- ② SURFACE MOUNTED WALL JUNCTION BOX (FOR FUT. SW.) - CAST BOX WITH 3/4" THREADED HUBS, NEOPRENE GASKET AND BLANK COVER TO BE TYPE "FD" BY CROUSE-HINDS - MTG. HT 4'-6" TO BE MOUNTED INDEPENDENT OF CONDUIT SYSTEM.

F.D. ①

F.D. ②

4'-6" 5" W.I. PIPE SLEEVE

SECOND FLOOR PLAN

SCALE 1/4" = 1'-0"

ELECTRICAL

MECHANICAL

CITY OF HARTFORD, CONNECTICUT		
DEPARTMENT OF ENGINEERING		
SMOKE TRAINING BLDG.		DWG. NO.
FIRE DEPT. NORTH MEADOWS		
HARTFORD, CONN.		
SUBMITTED R. L. BARNON	RECOMMENDED D. M. L. TUCKER	APPROVED CITY ENGINEER
DESIGN R. L. B.	DRAWN R. L. B.	DAYBOOK NO. 09902-K
TRACED	CHECK	DATE