



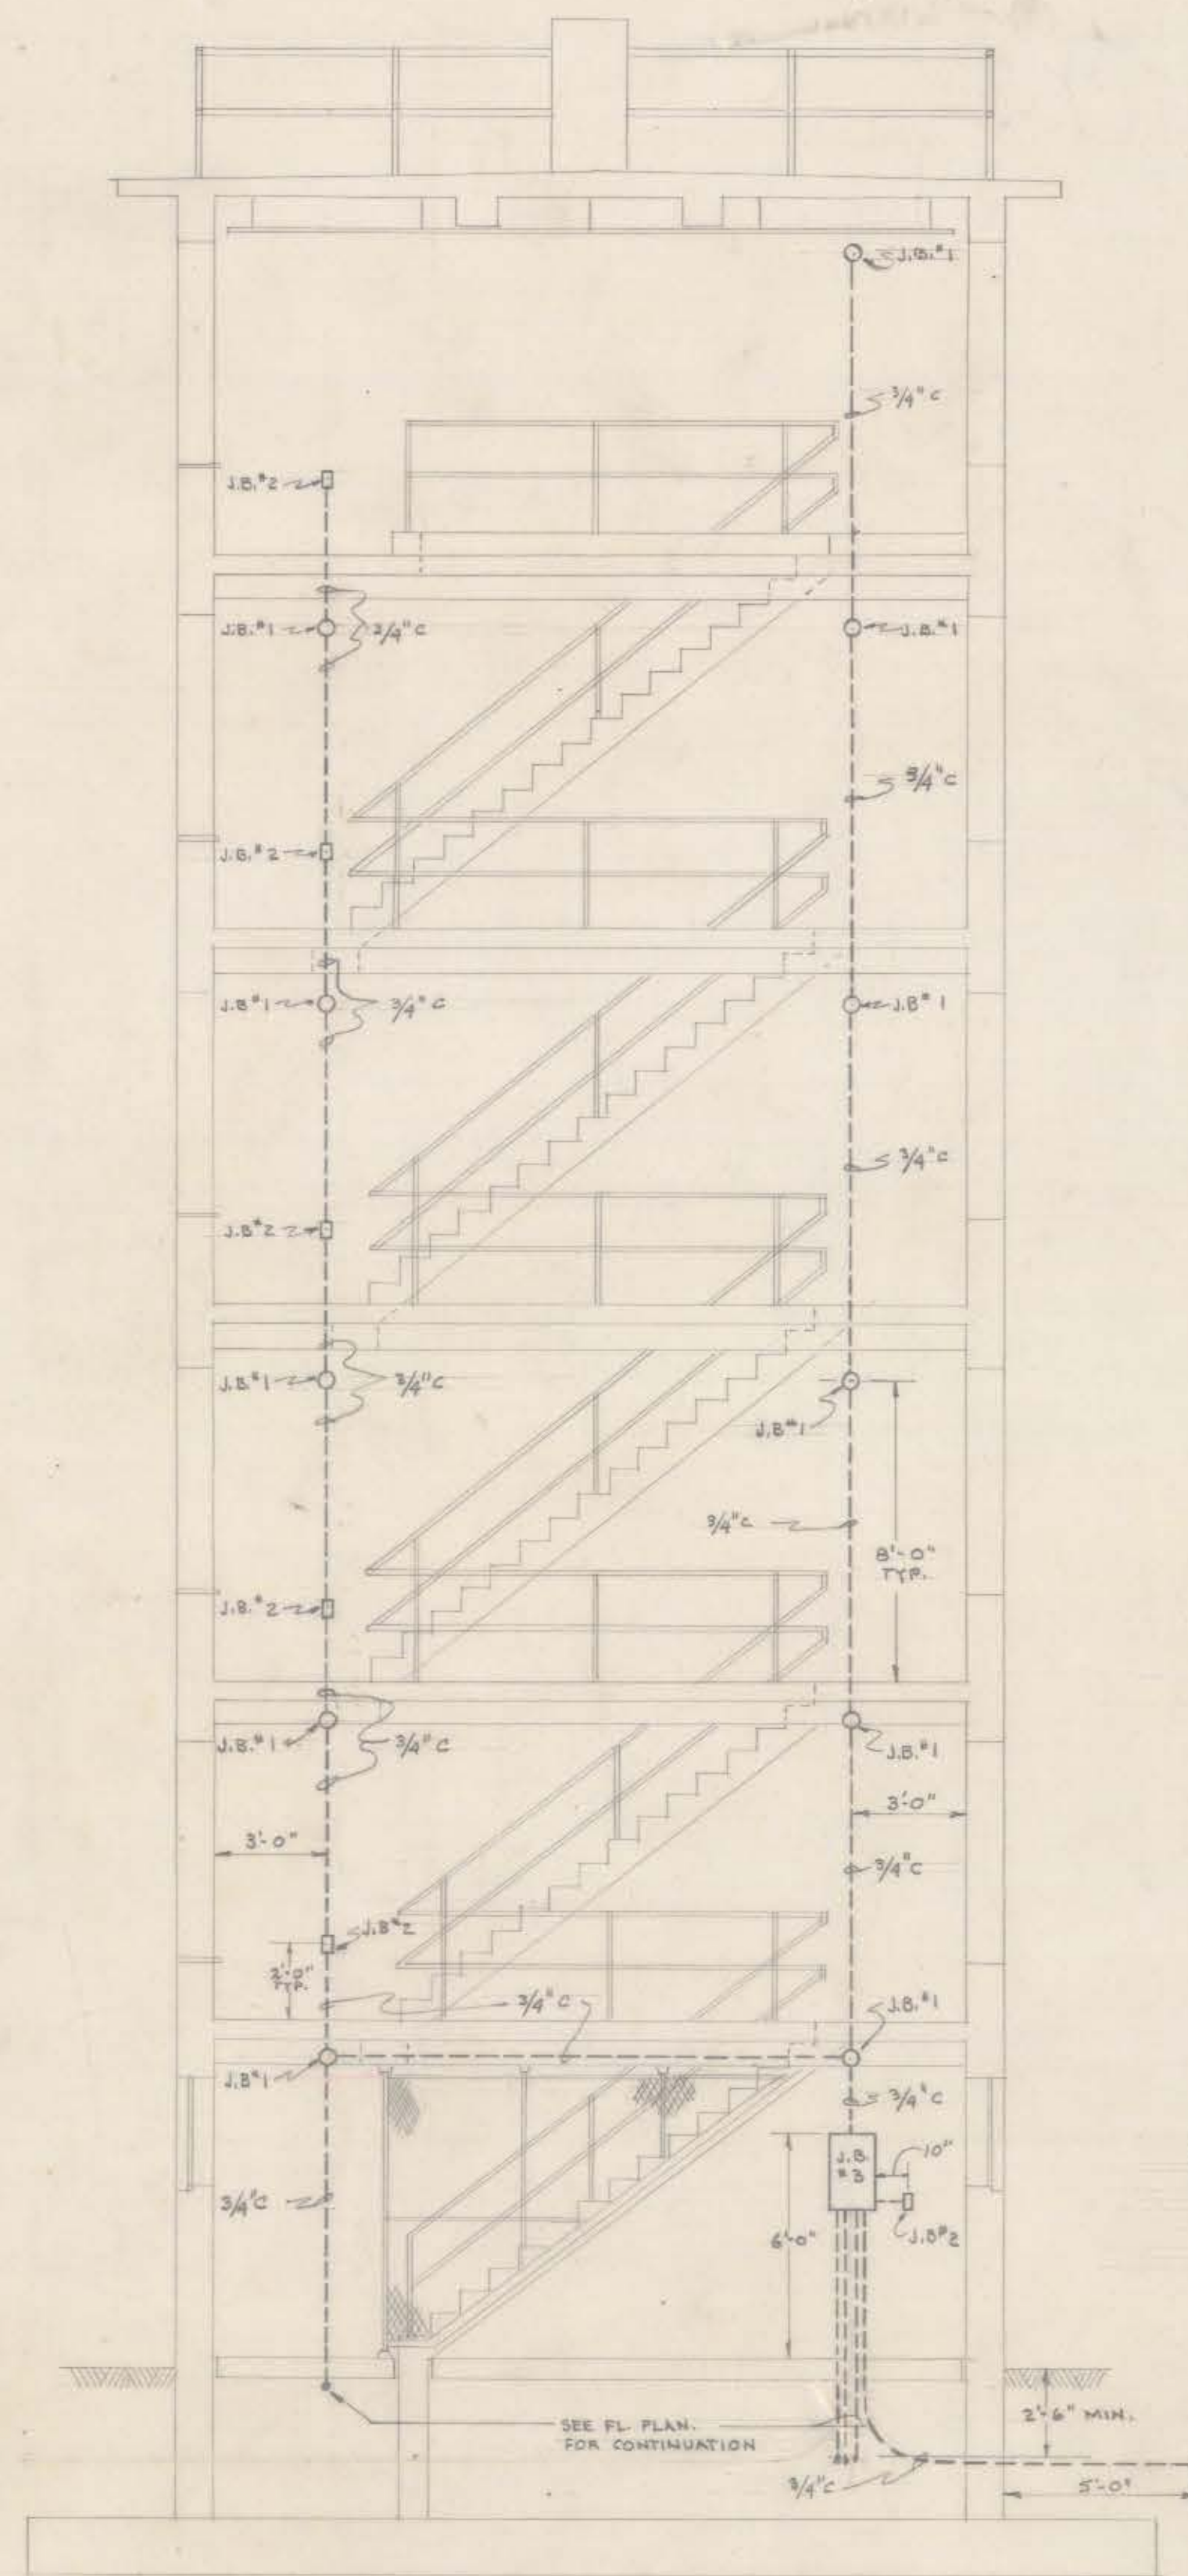


SECTION A-A ELECTRICAL

SCALE 1/4" = 1'-0"

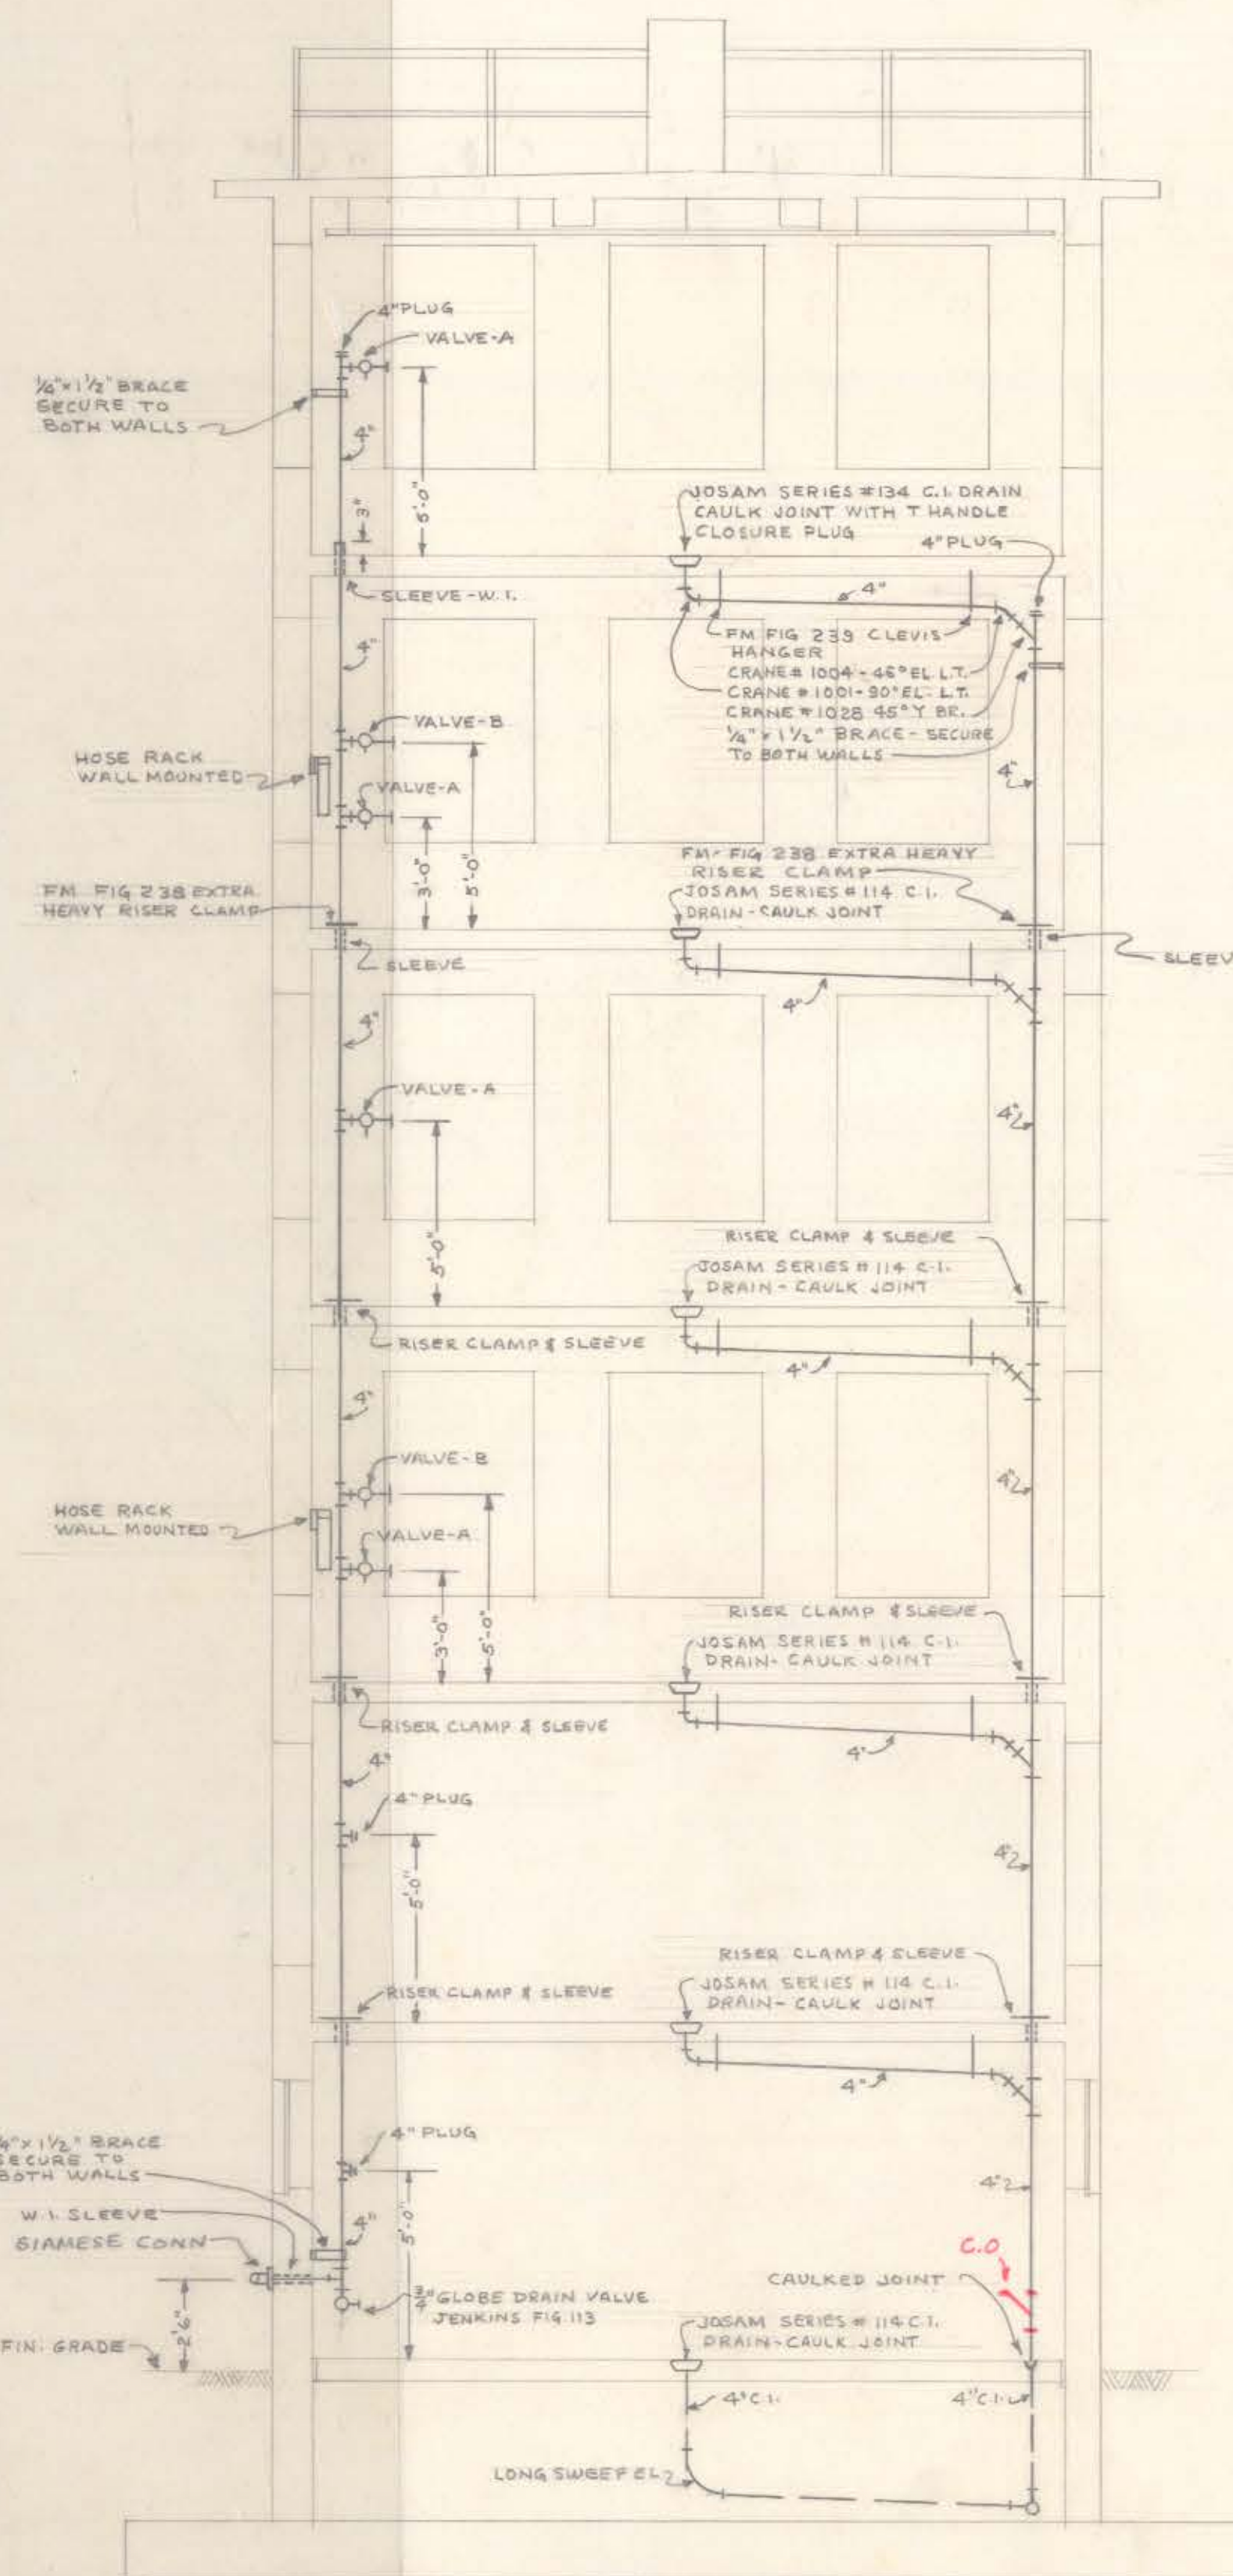


SECTION B-B PLUMBING

SCALE 1/4" = 1'-0"

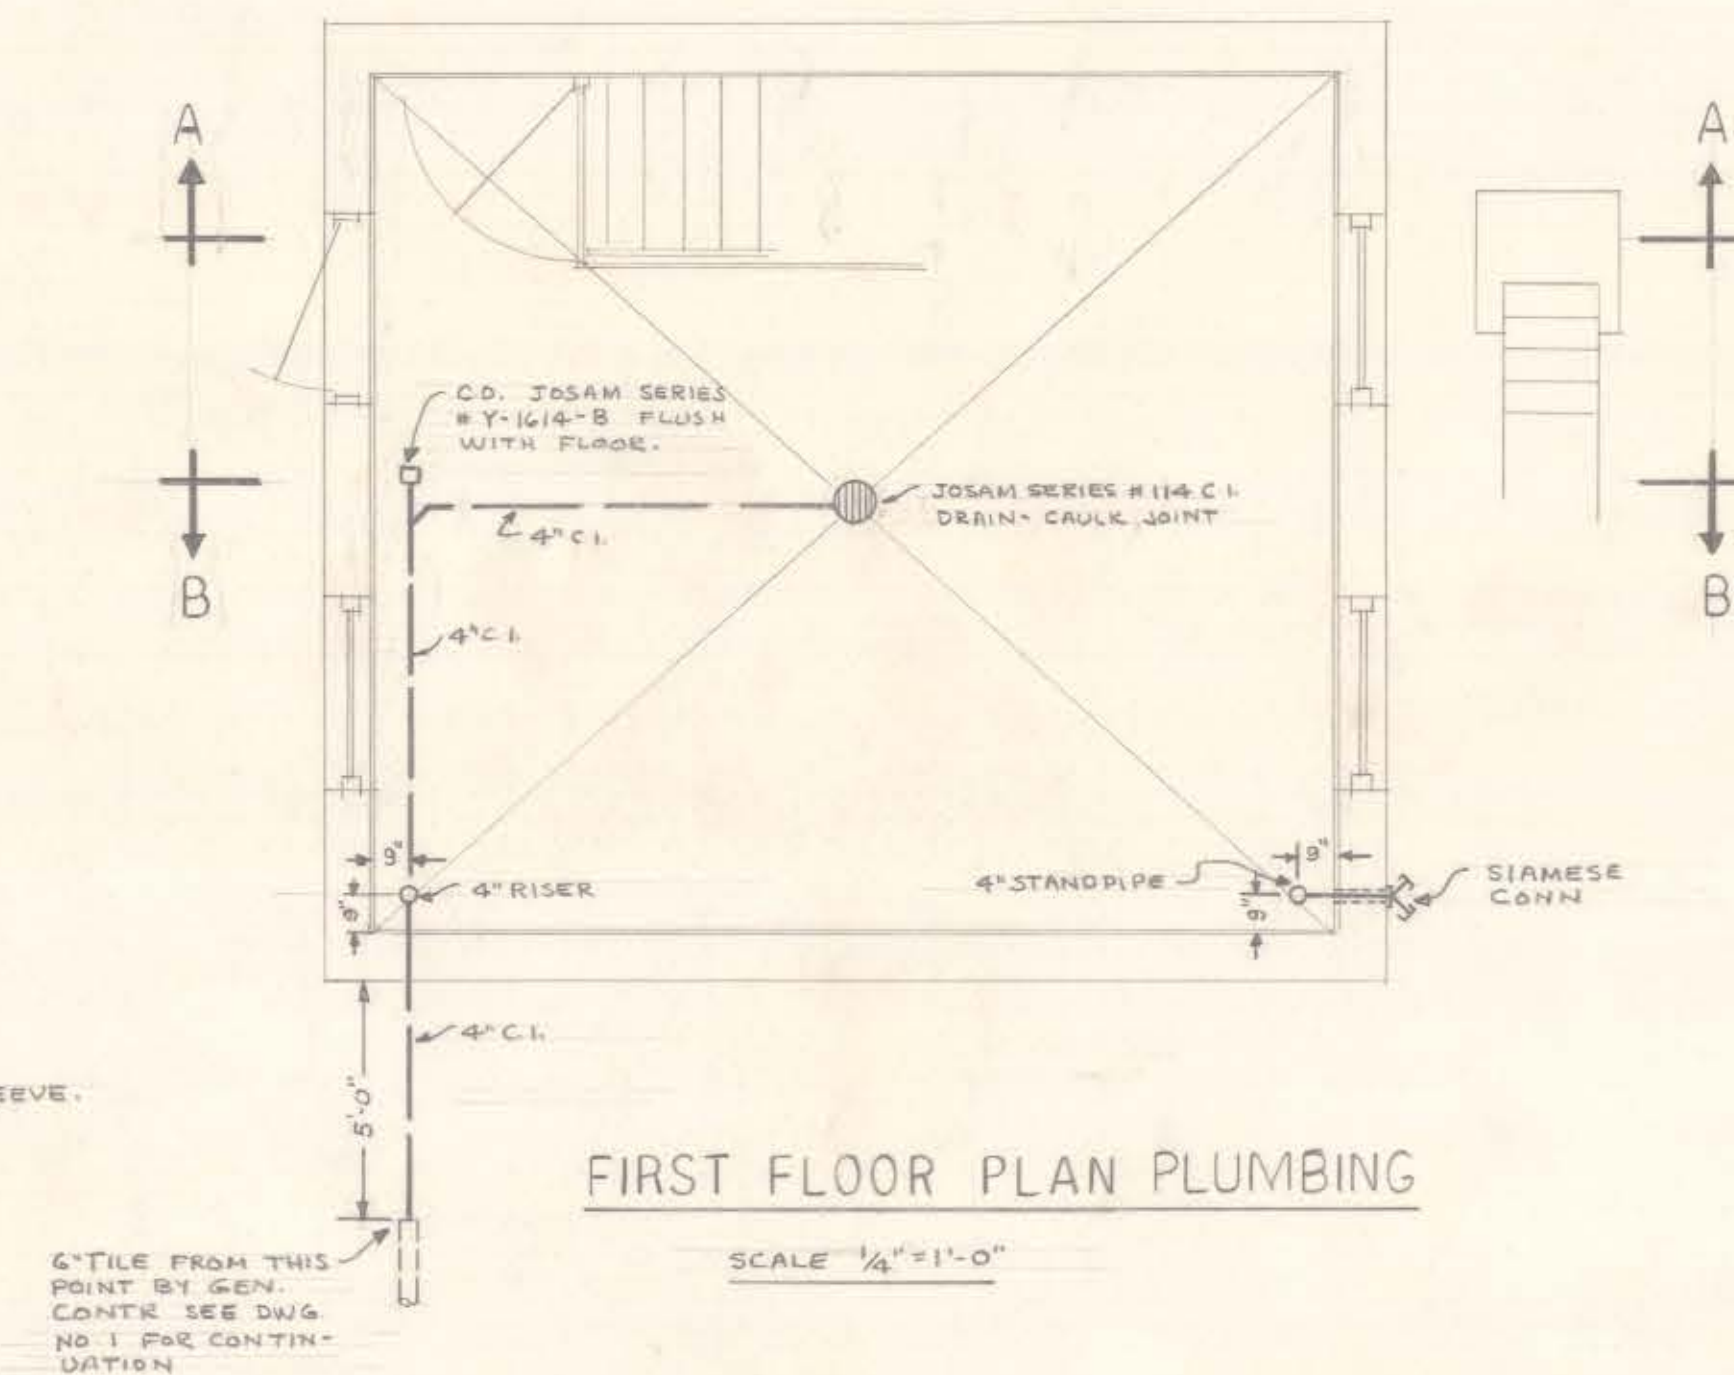


FIRST FLOOR PLAN PLUMBING

SCALE 1/4" = 1'-0"

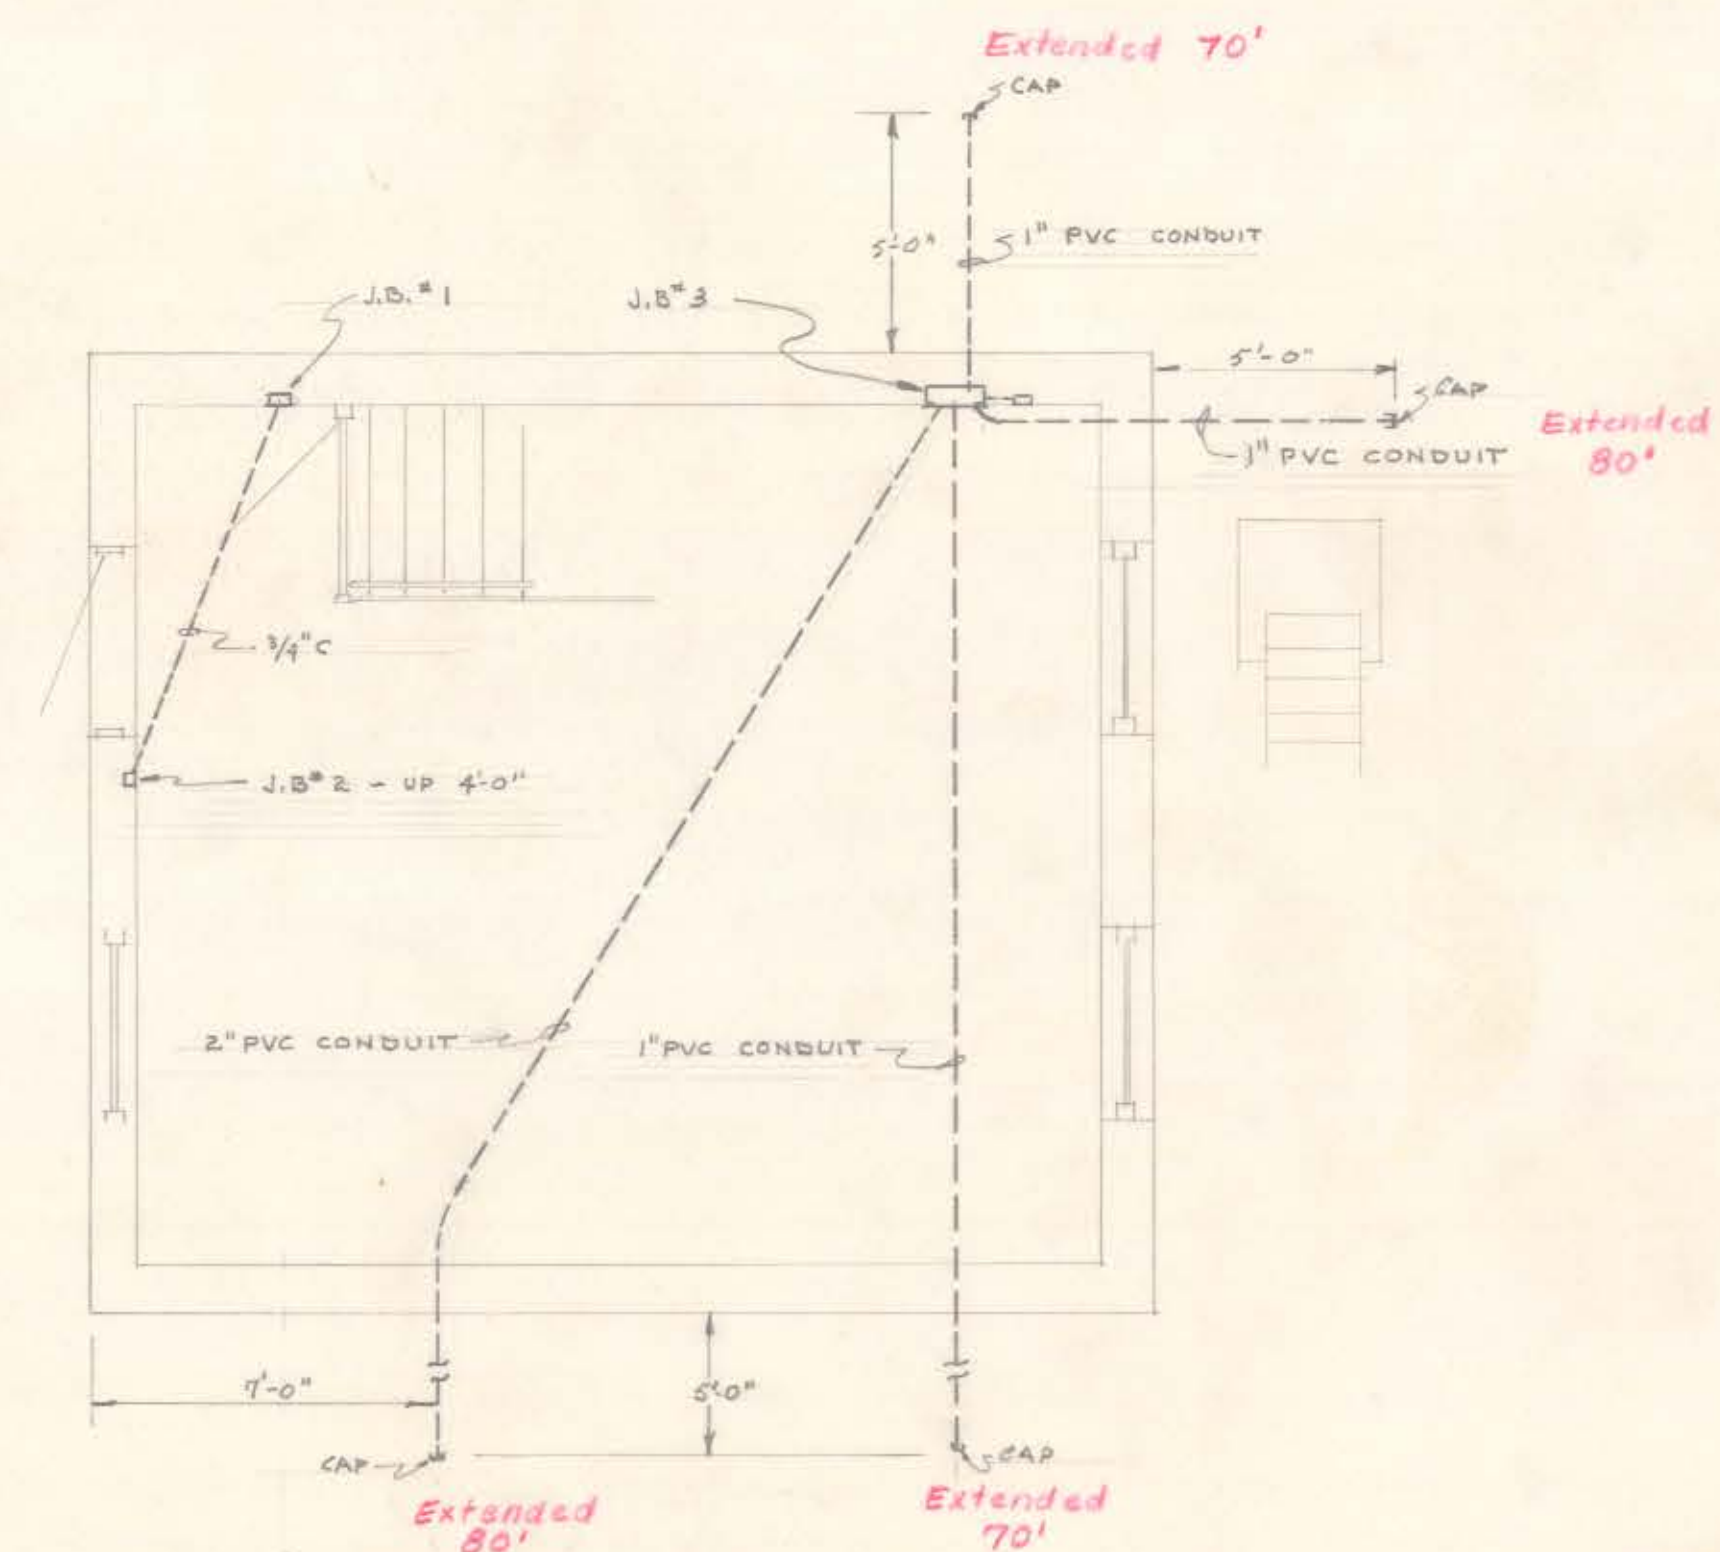

FIRST FLOOR PLAN ELECTRICAL

SCALE 1/4" = 1'-0"

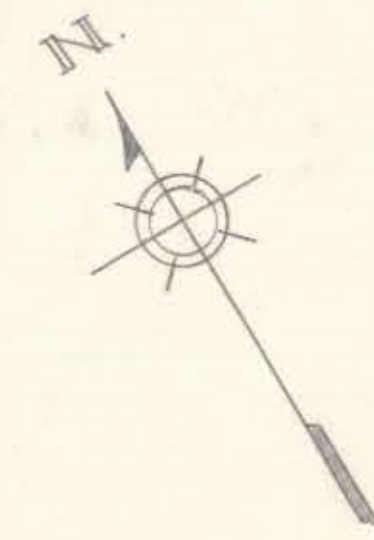

CITY OF HARTFORD, CONNECTICUT DEPARTMENT OF ENGINEERING			
TRAINING TOWER FOR THE HARTFORD FIRE DEPARTMENT CITY OF HARTFORD, CONN.			
SUBMITTED <i>Russell E. Boeg</i>	RECOMMENDED <i>Daniel F. Tavelle</i>	APPROVED <i>John H. Canmore</i>	
DESIGN R&B P&P	DRAWN R&B P&P	DAYBOOK NO. 09769 I	
TRACES	CHECK	DATE MAR. 27, 1963	