




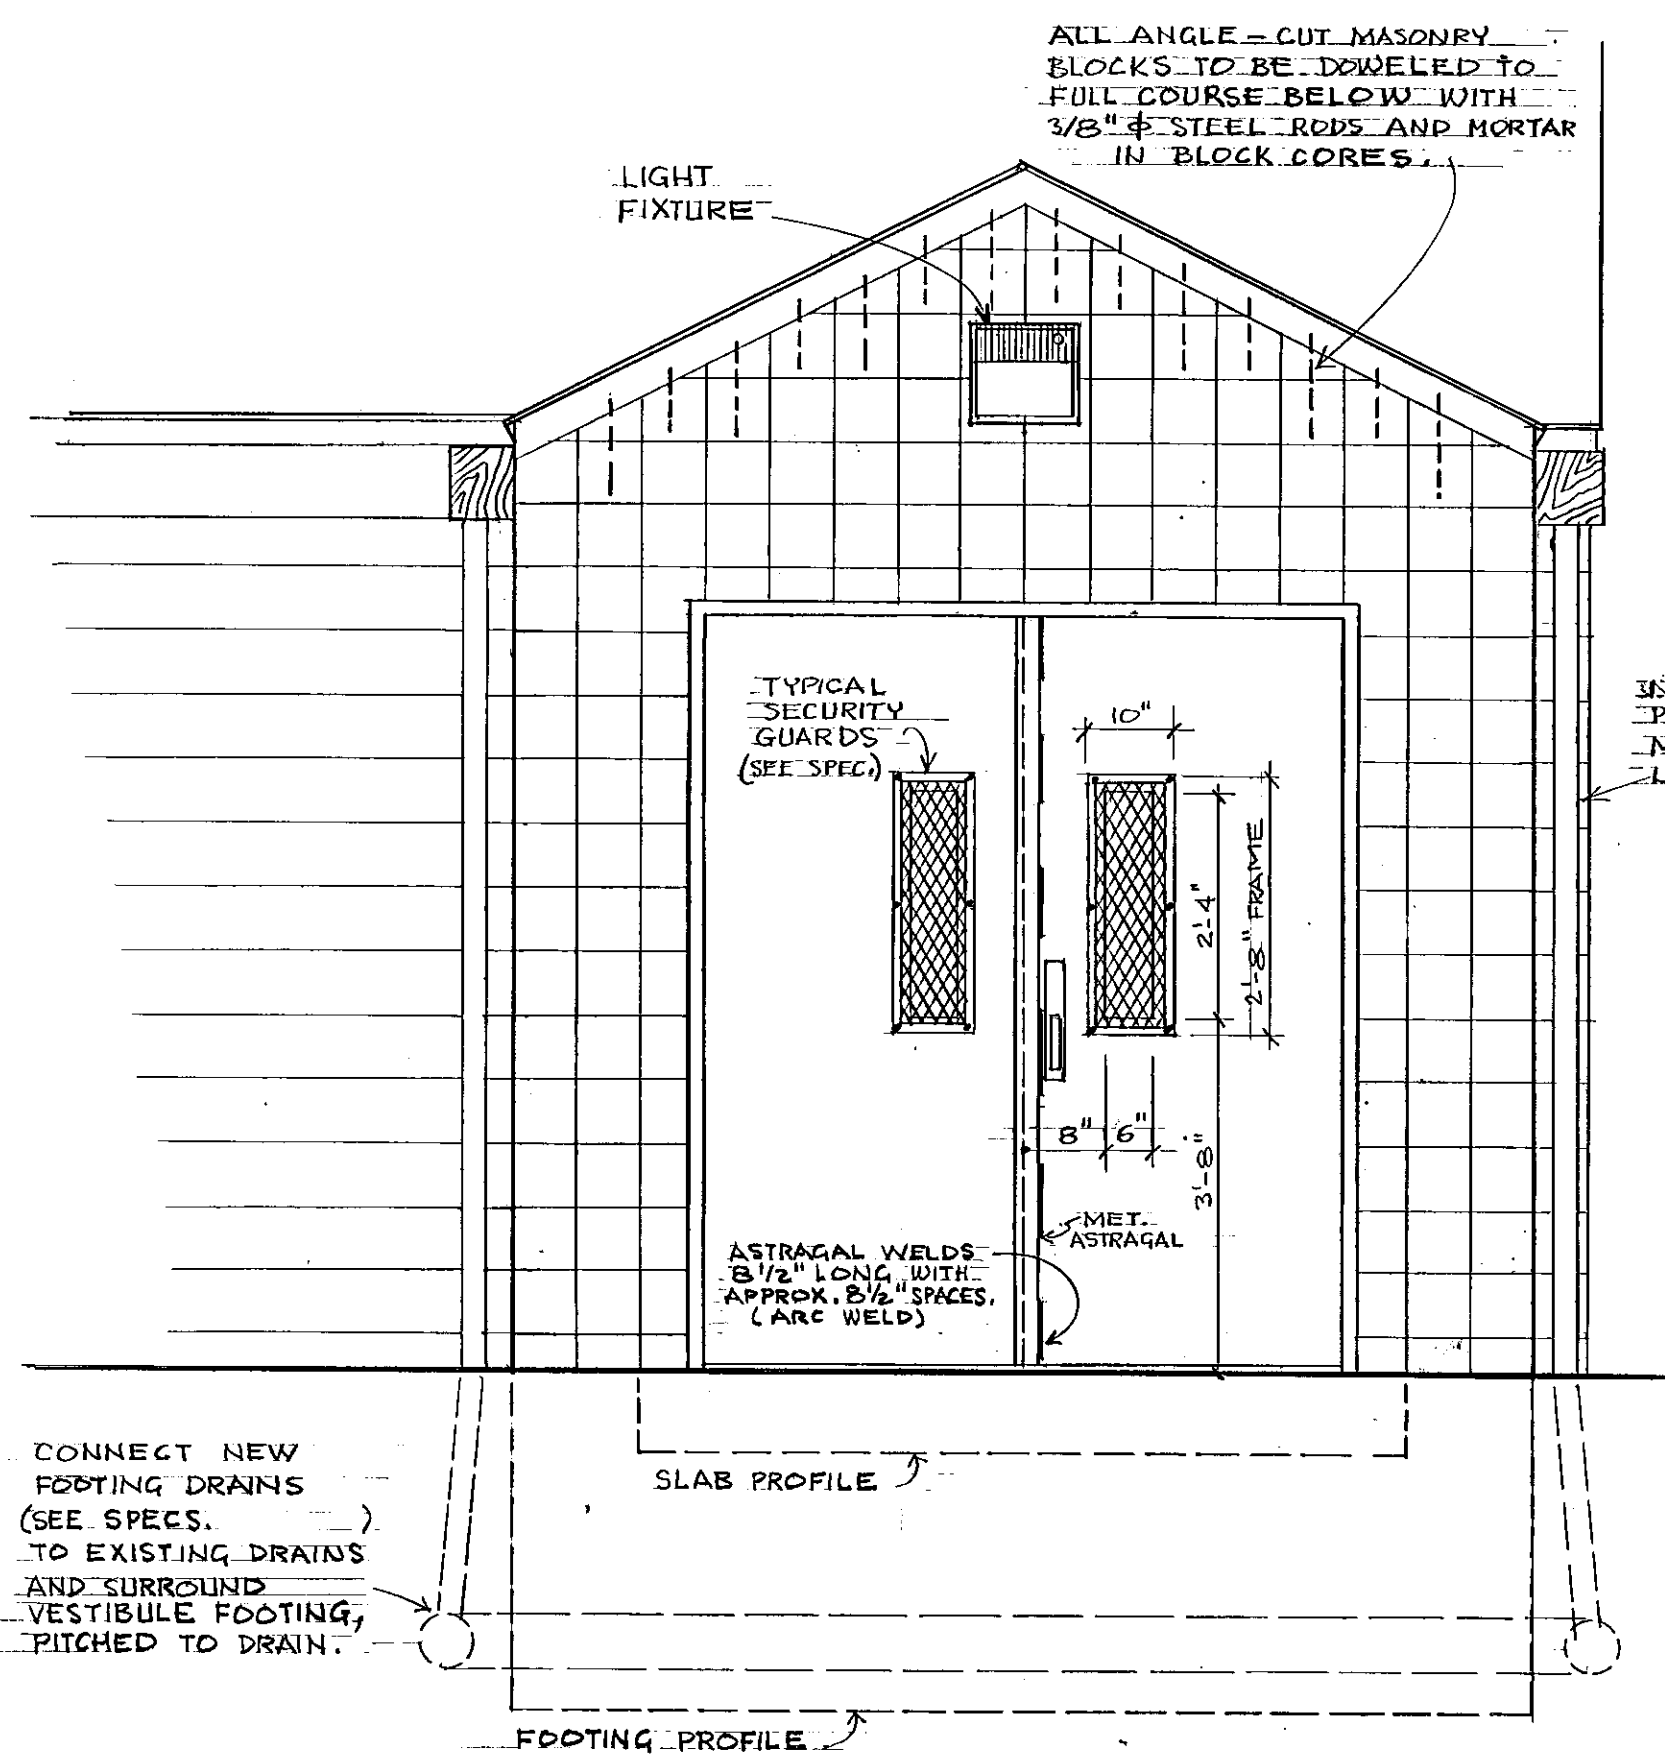


EAST ELEVATION SCALE: 1/2" = 1'-0"

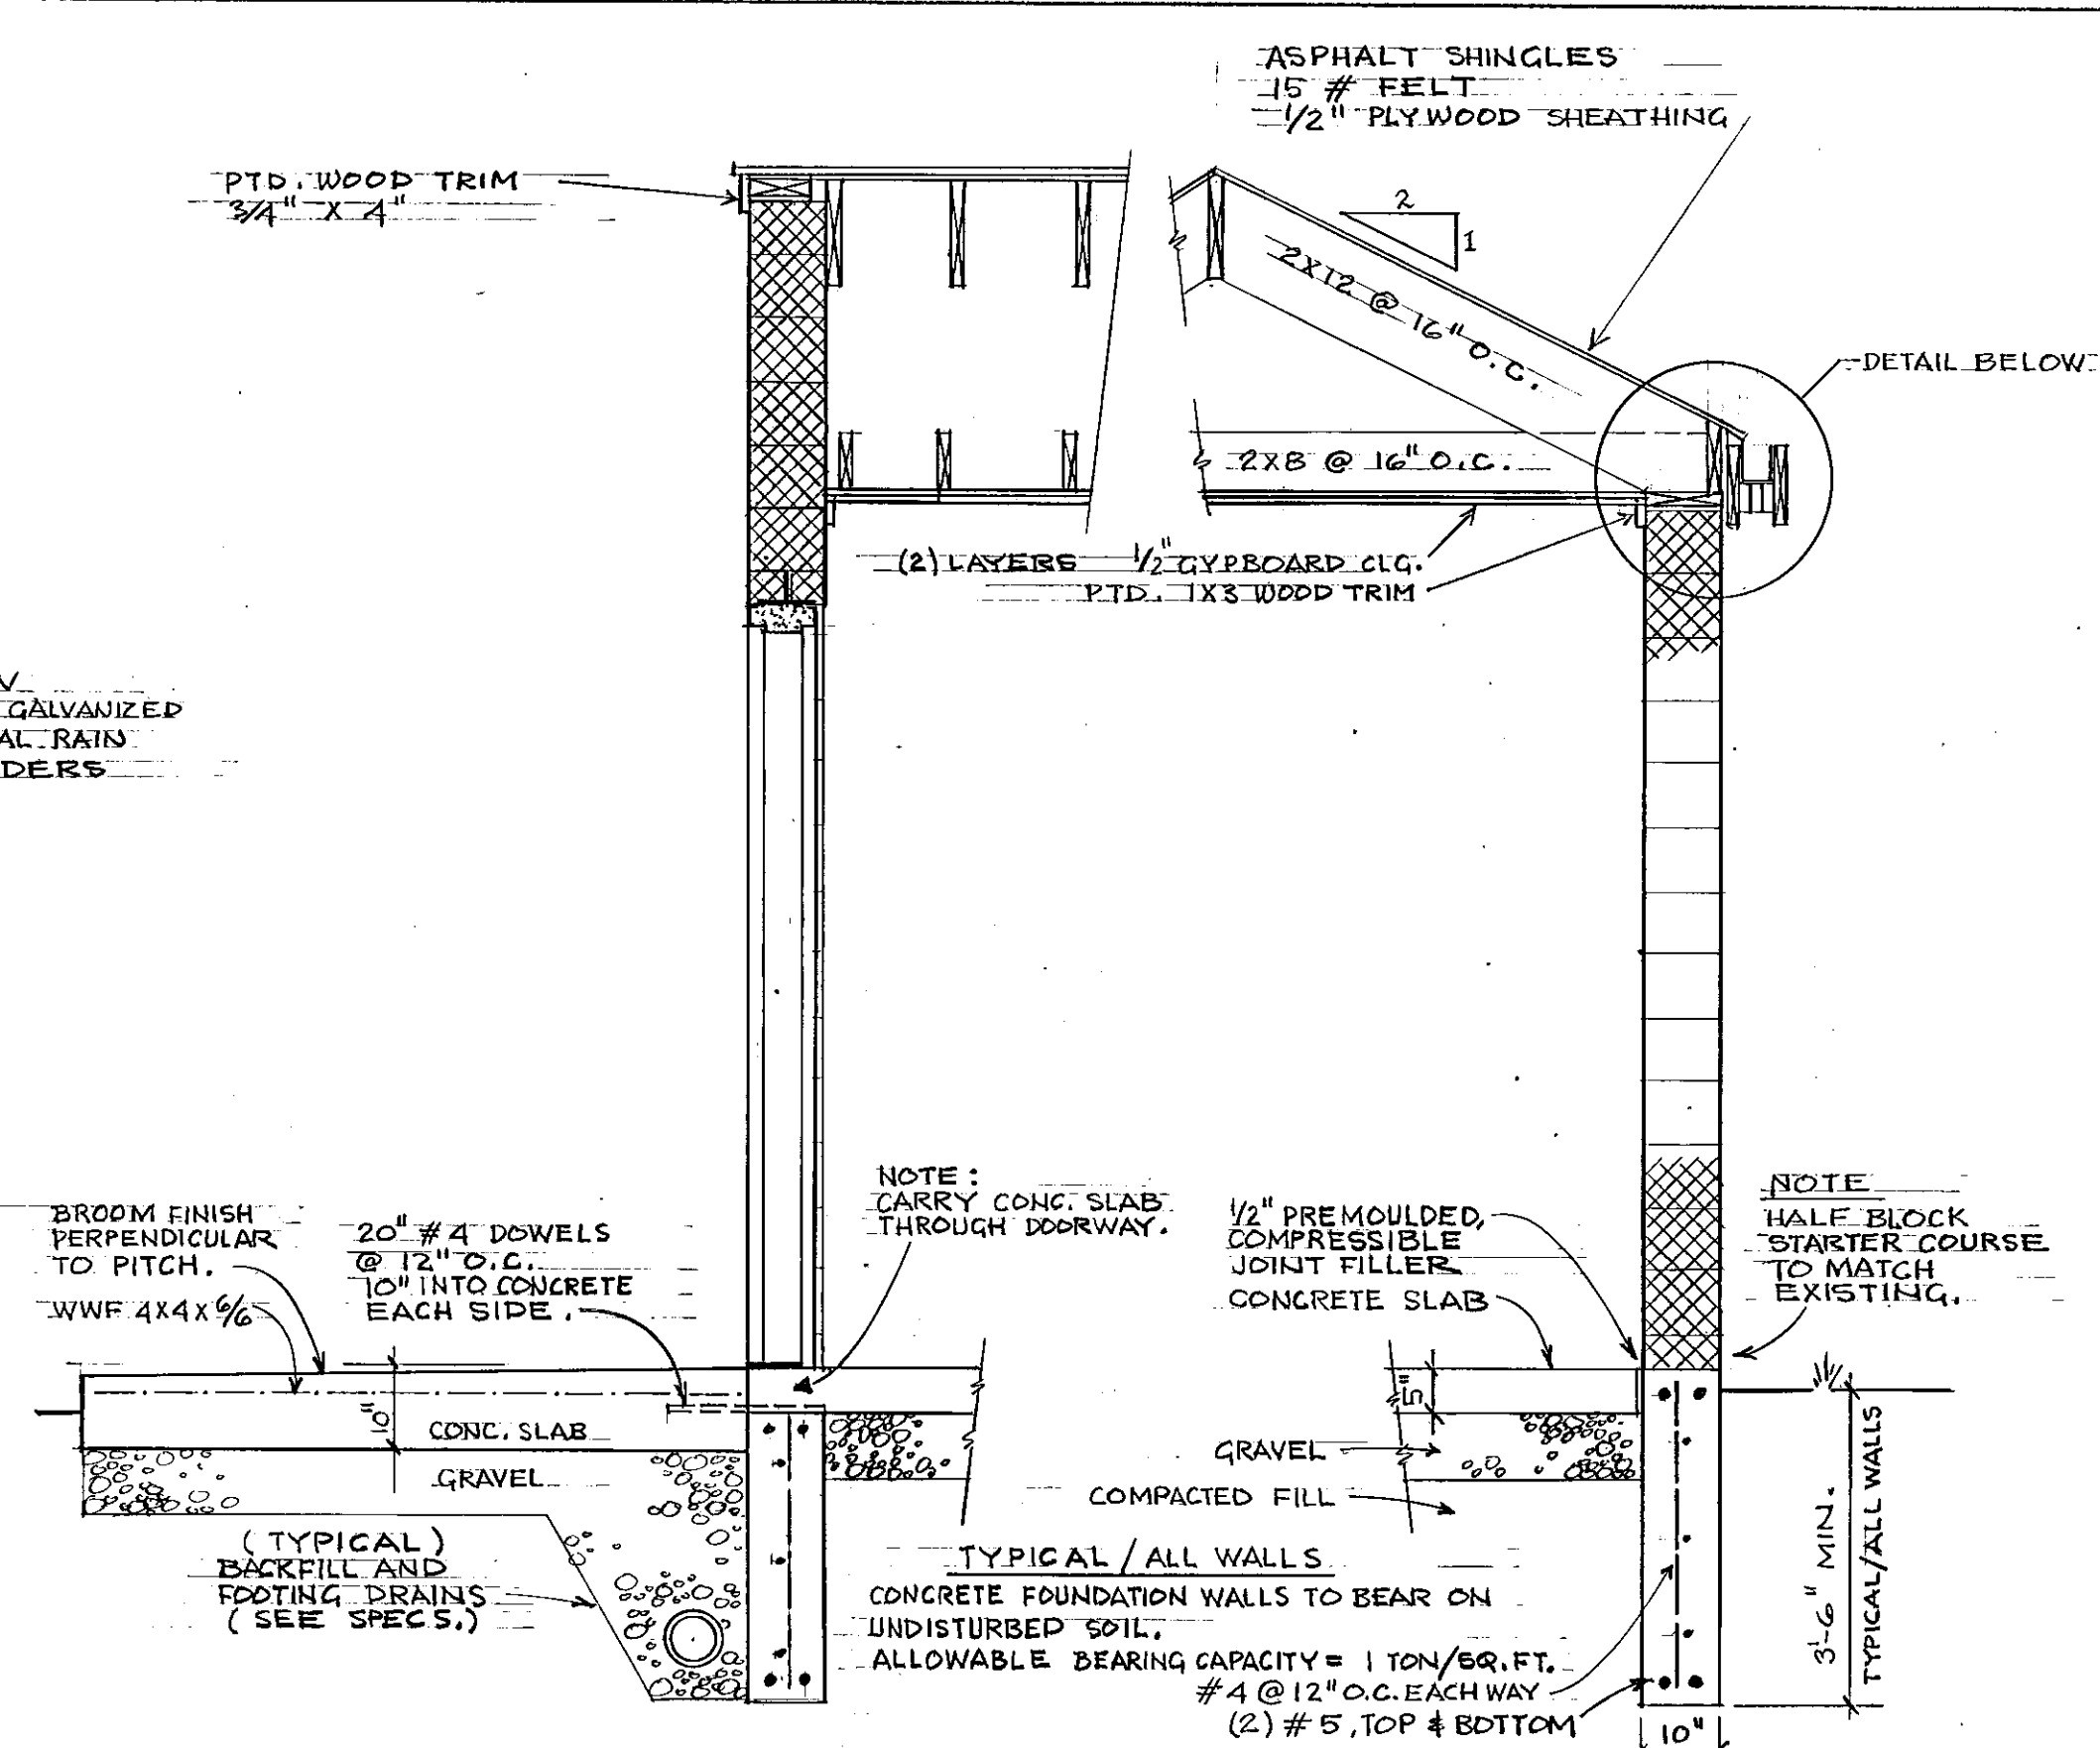


EAST WALL NORTH & SOUTH WALLS WALL SECTIONS SCALE: 1/2" = 1'-0"

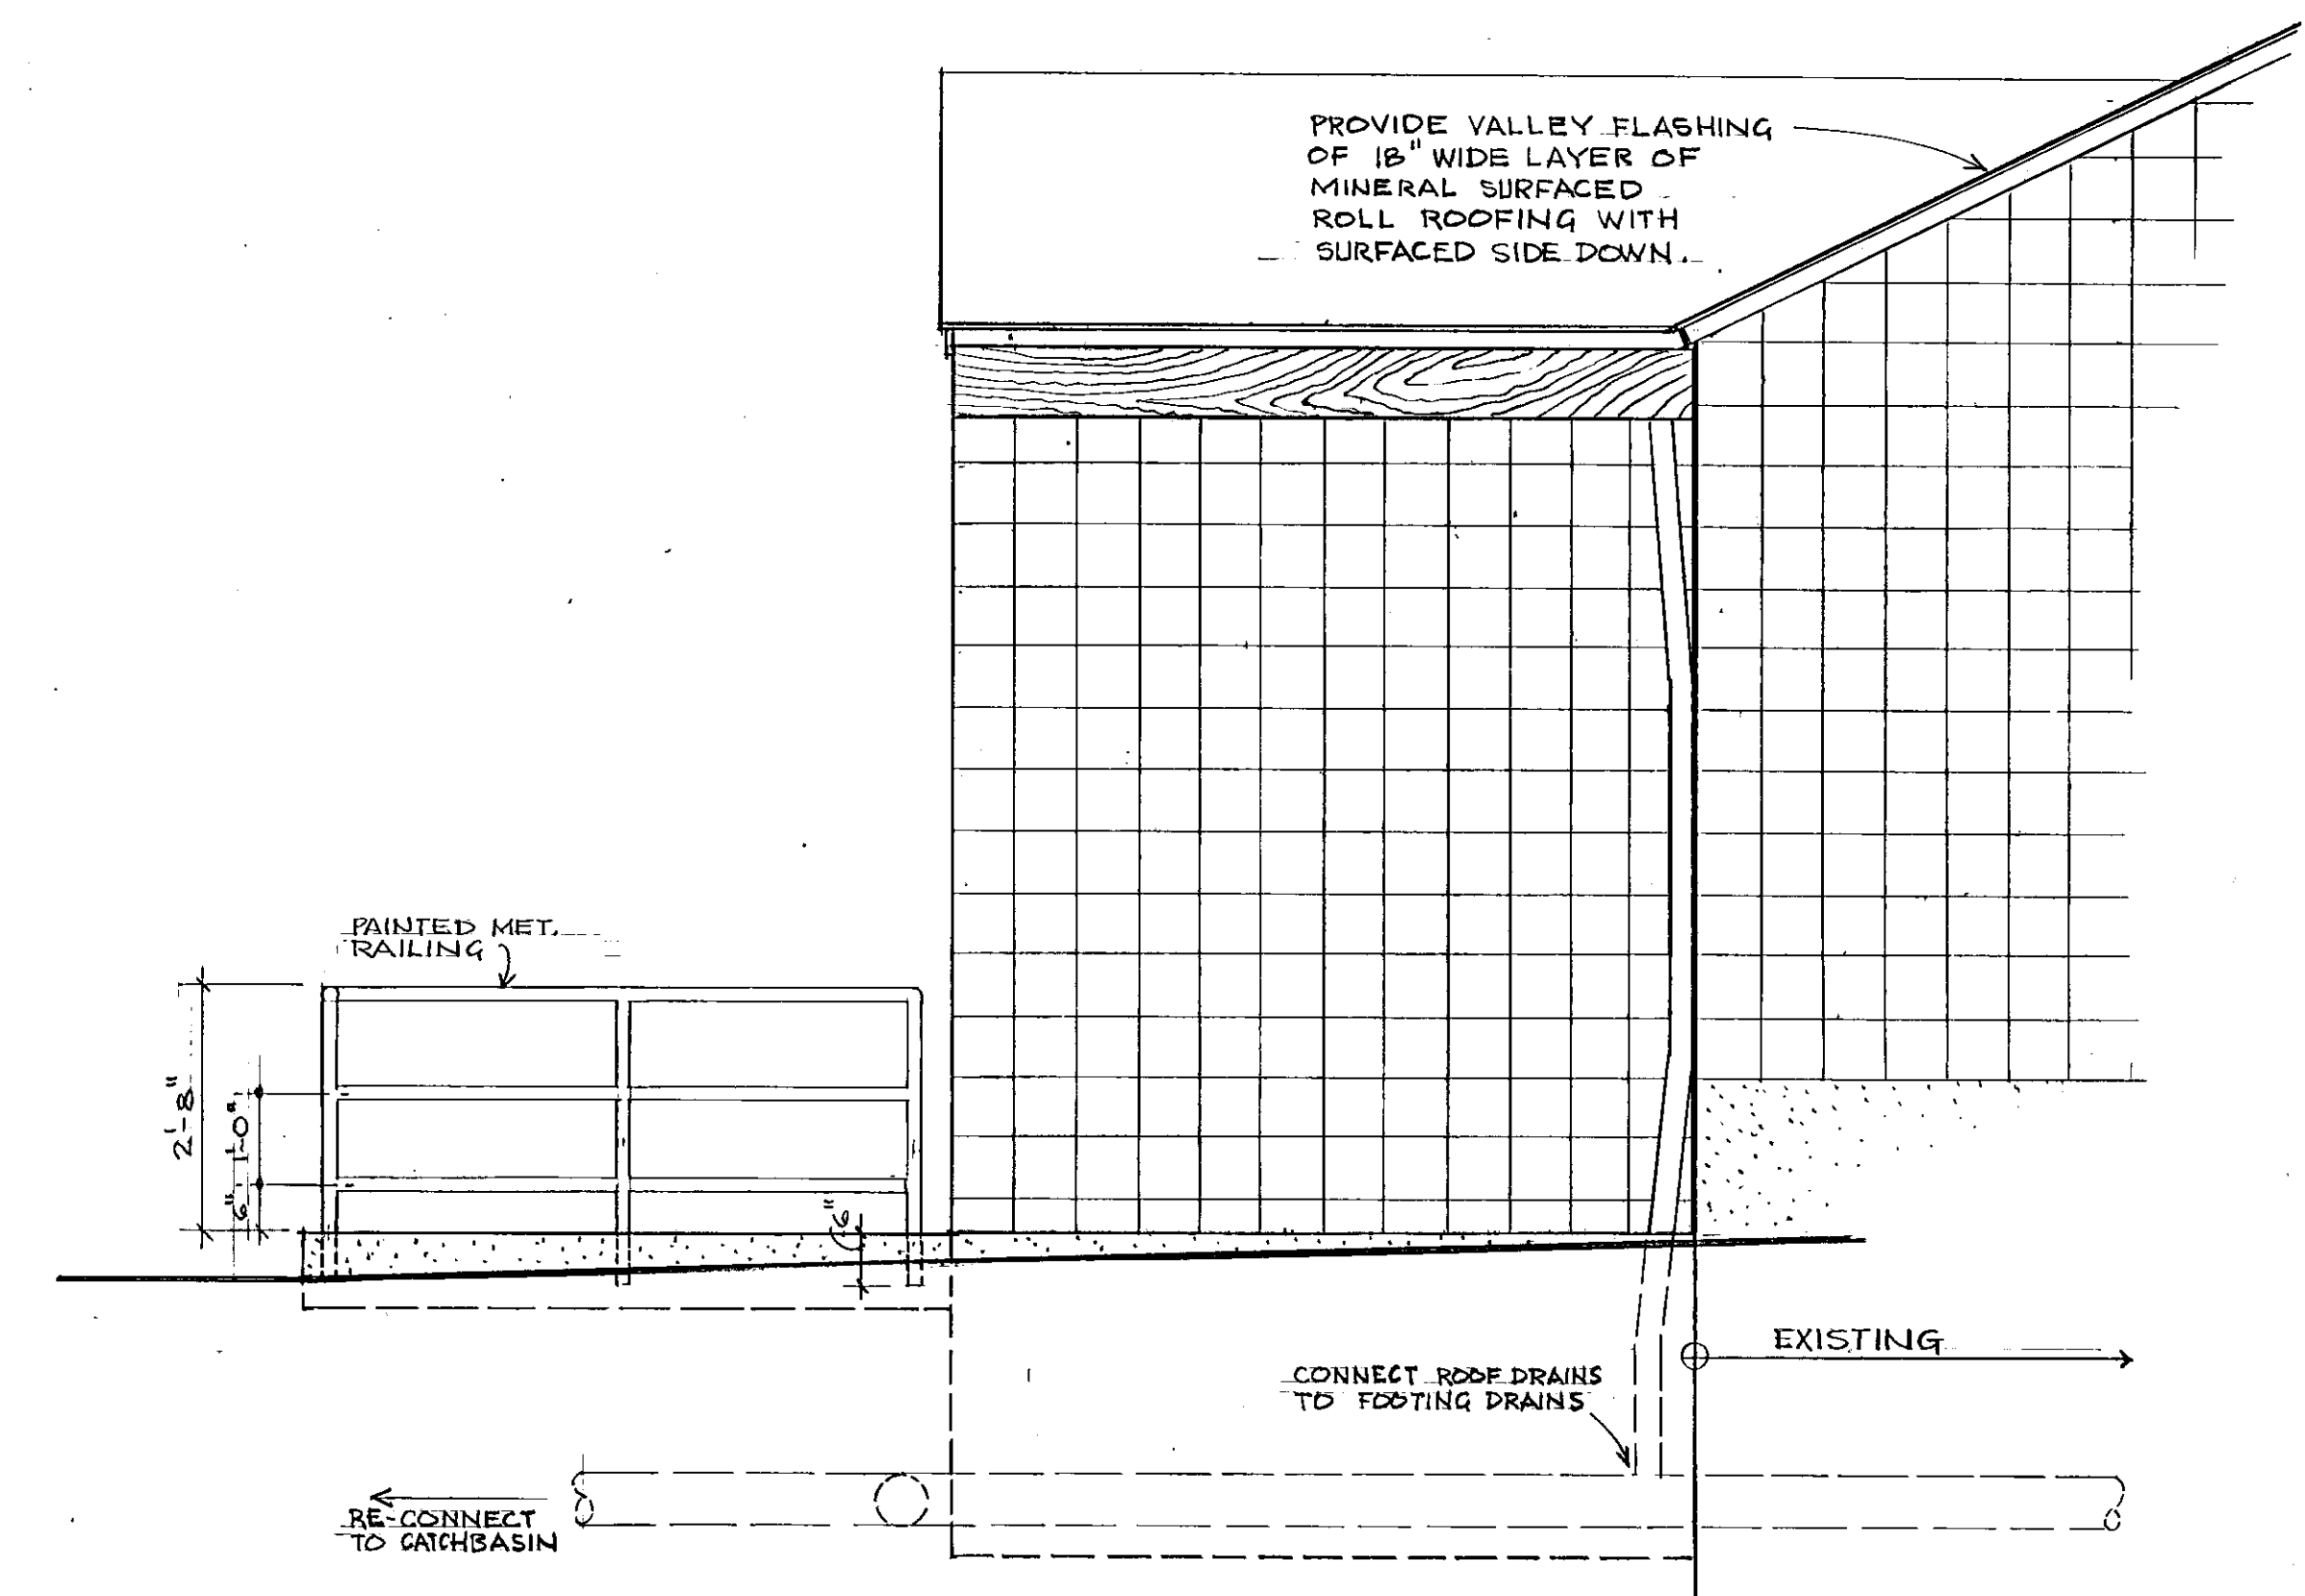


SOUTH ELEVATION SCALE: 1/2" = 1'-0" (NORTH ELEVATION SIMILAR)

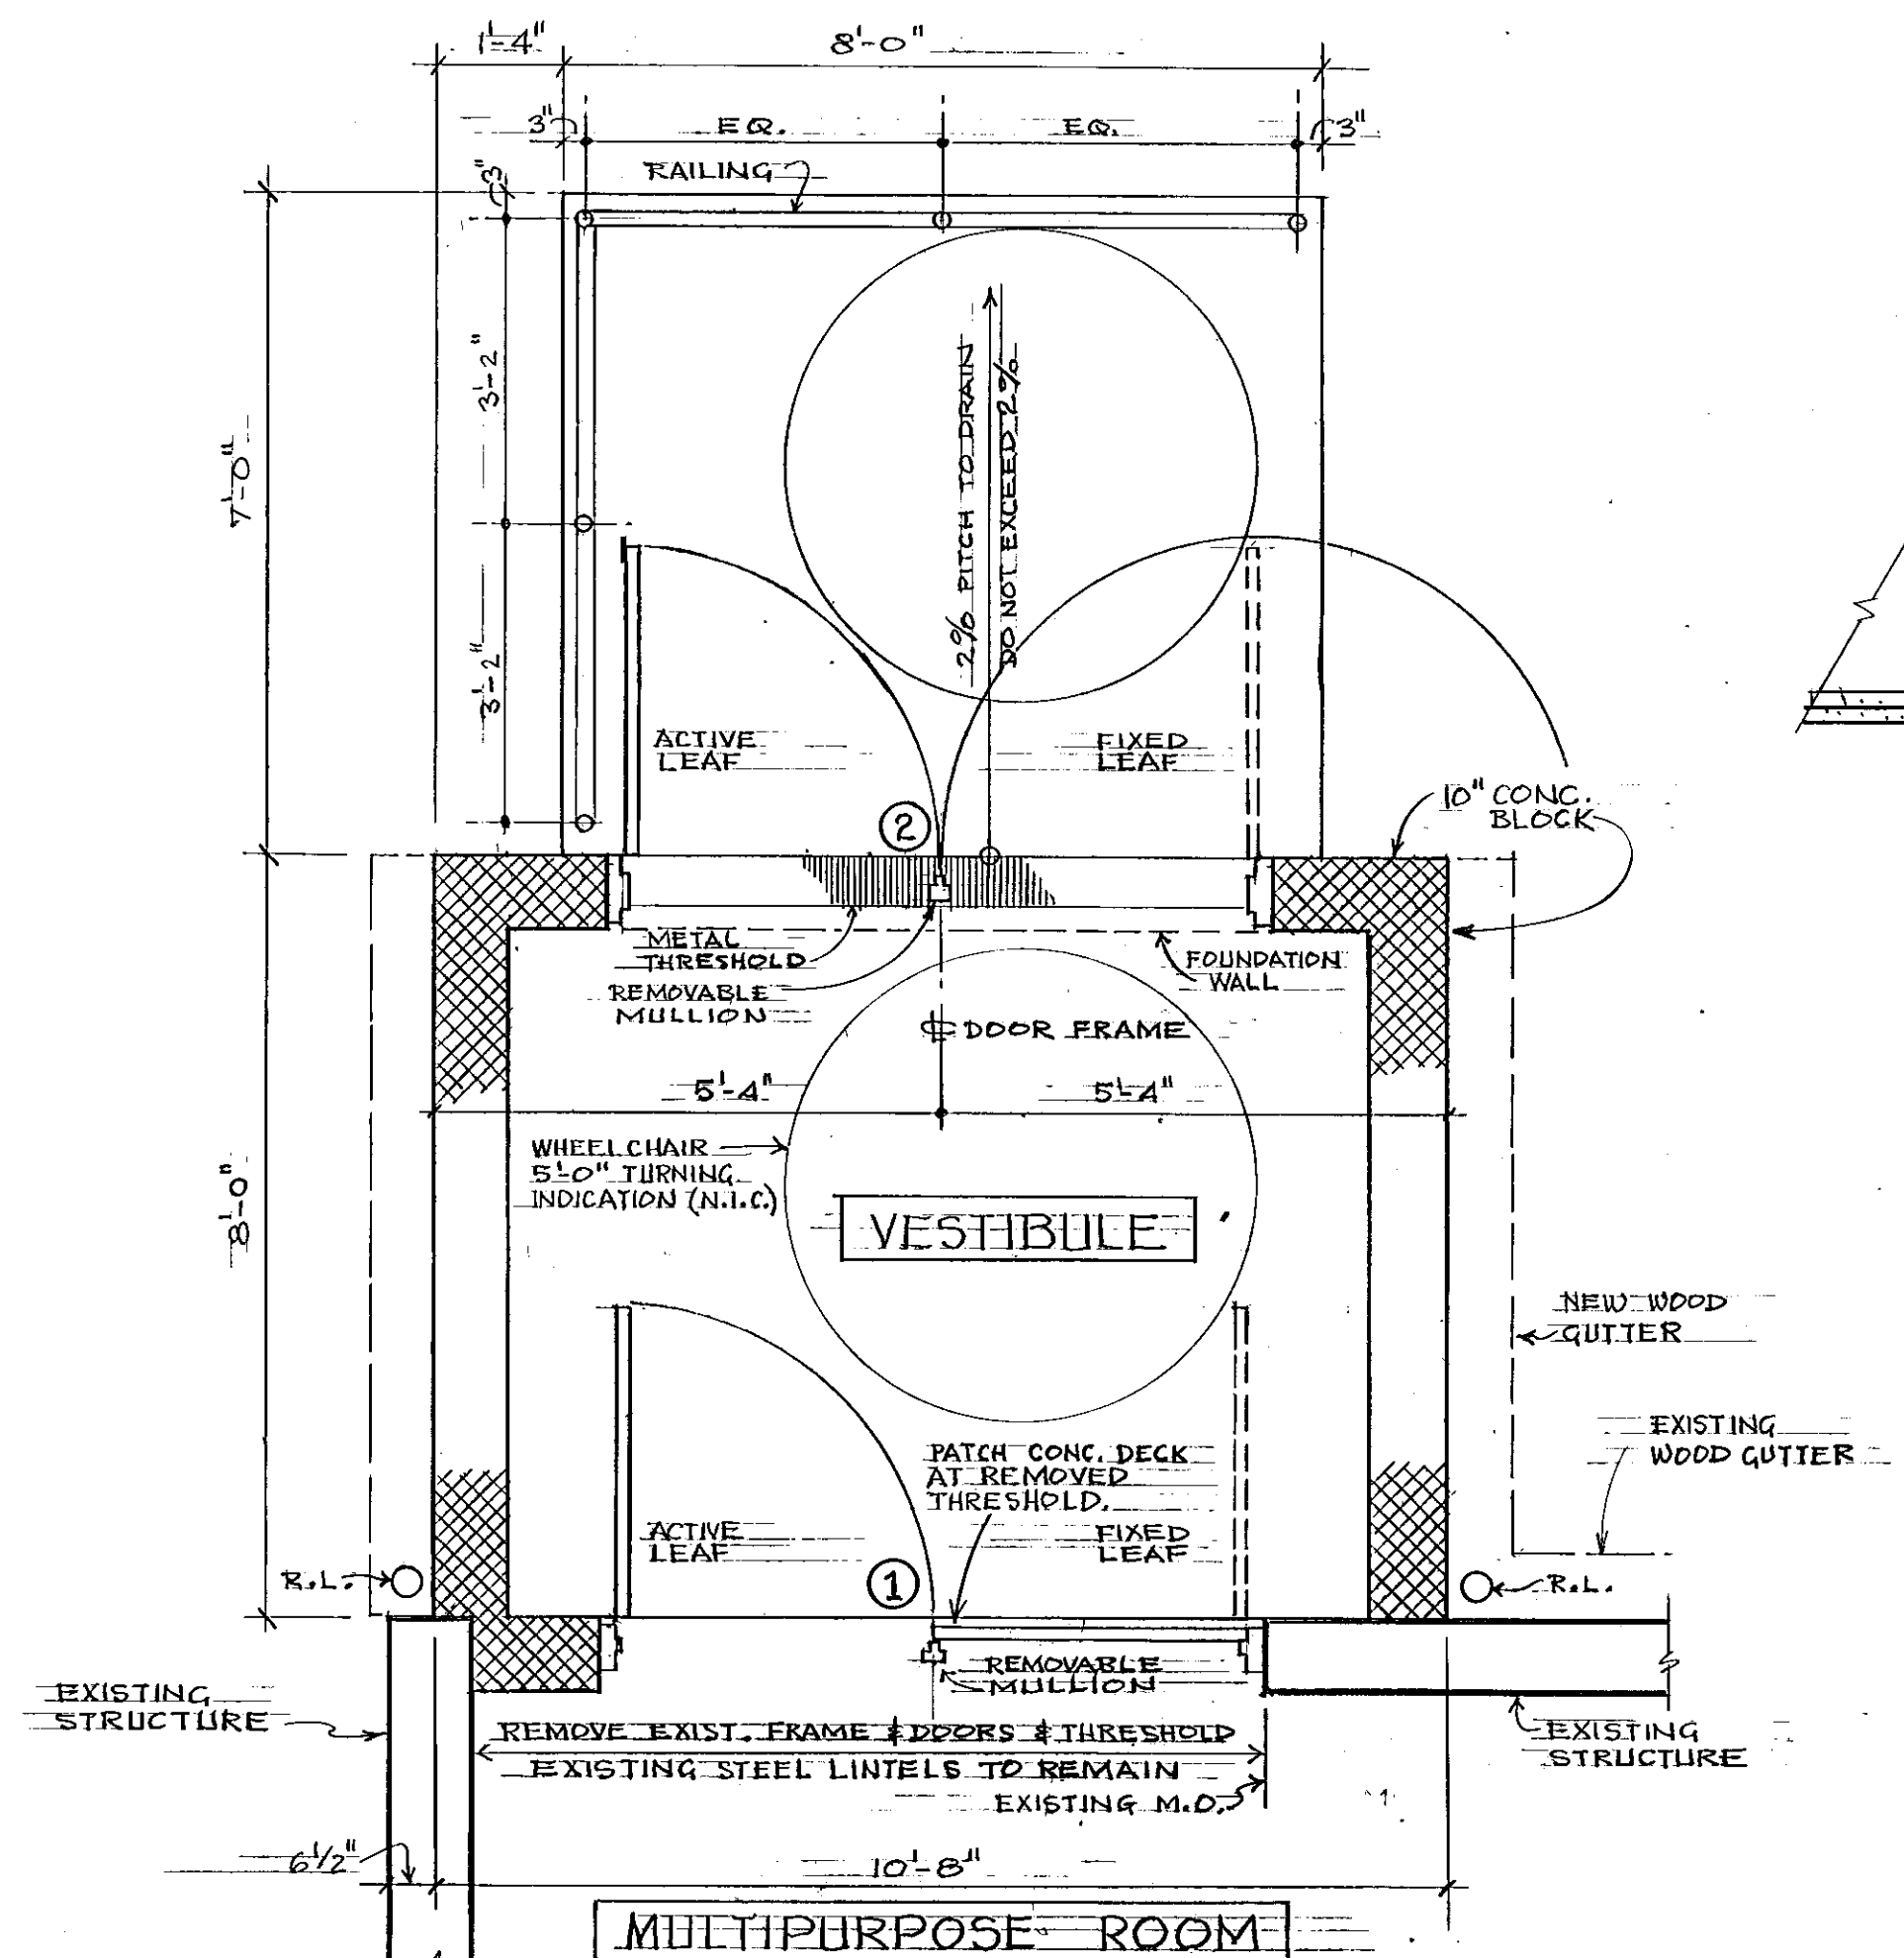


SEE DRAWING E-1 FOR ELECTRICAL PLAN SCALE: 1/2" = 1'-0"

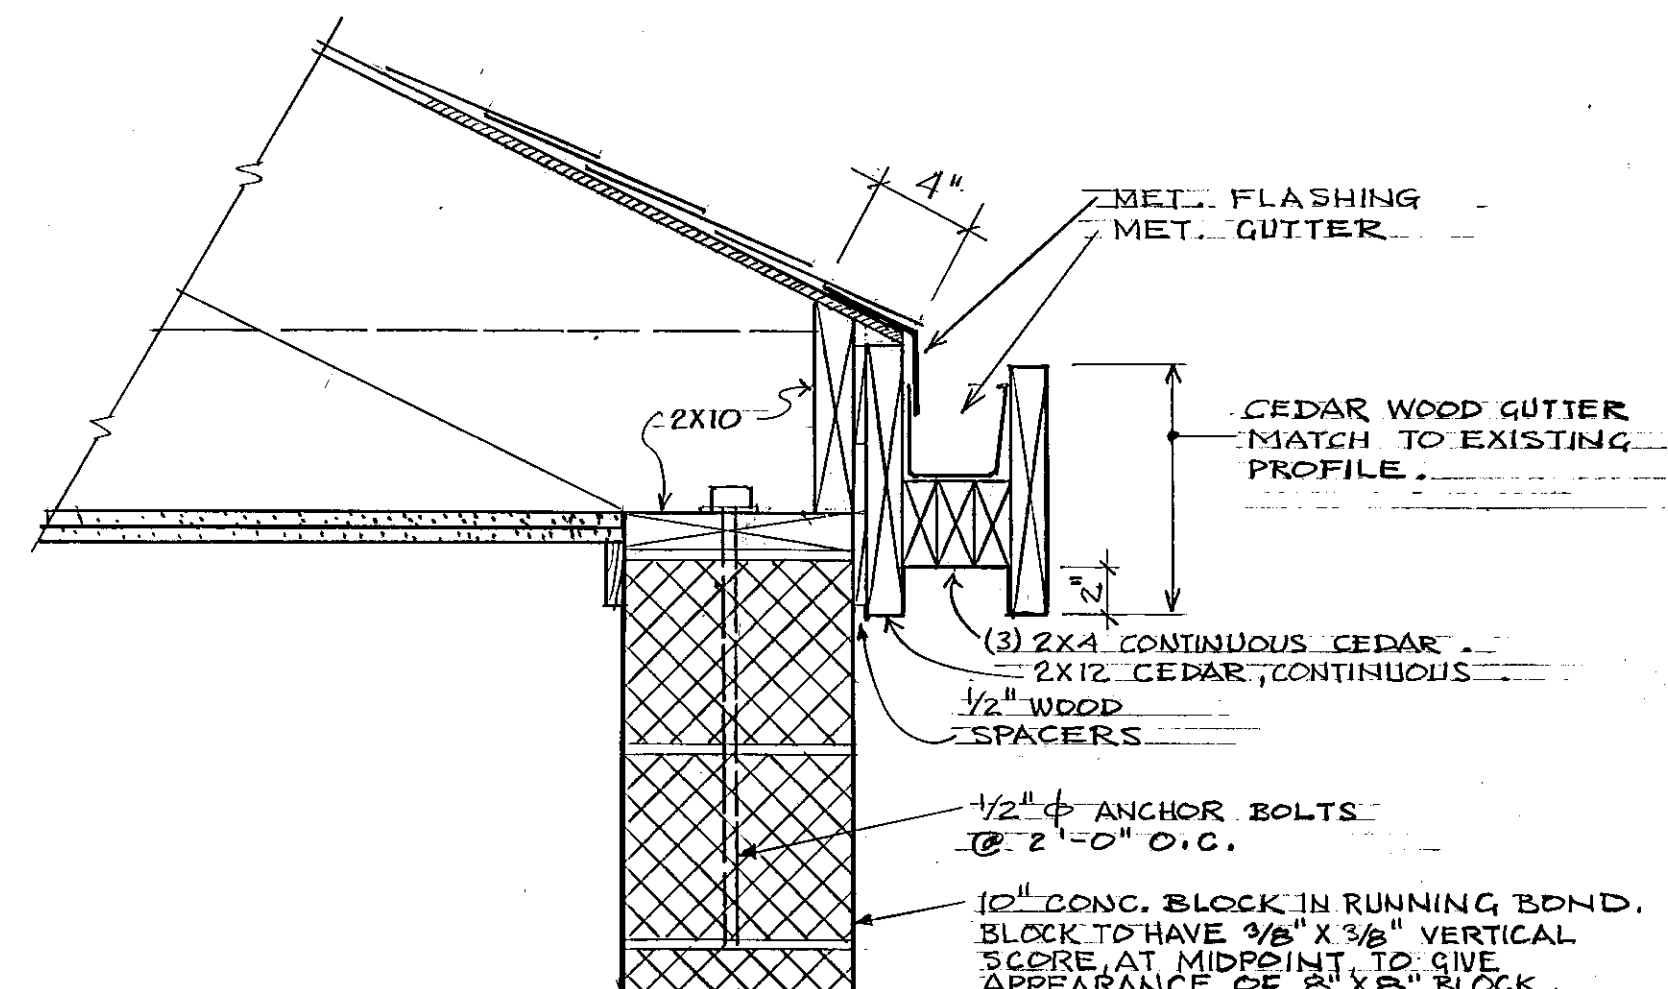

EAVE & GUTTER DETAIL SCALE: 1/2" = 1'-0"

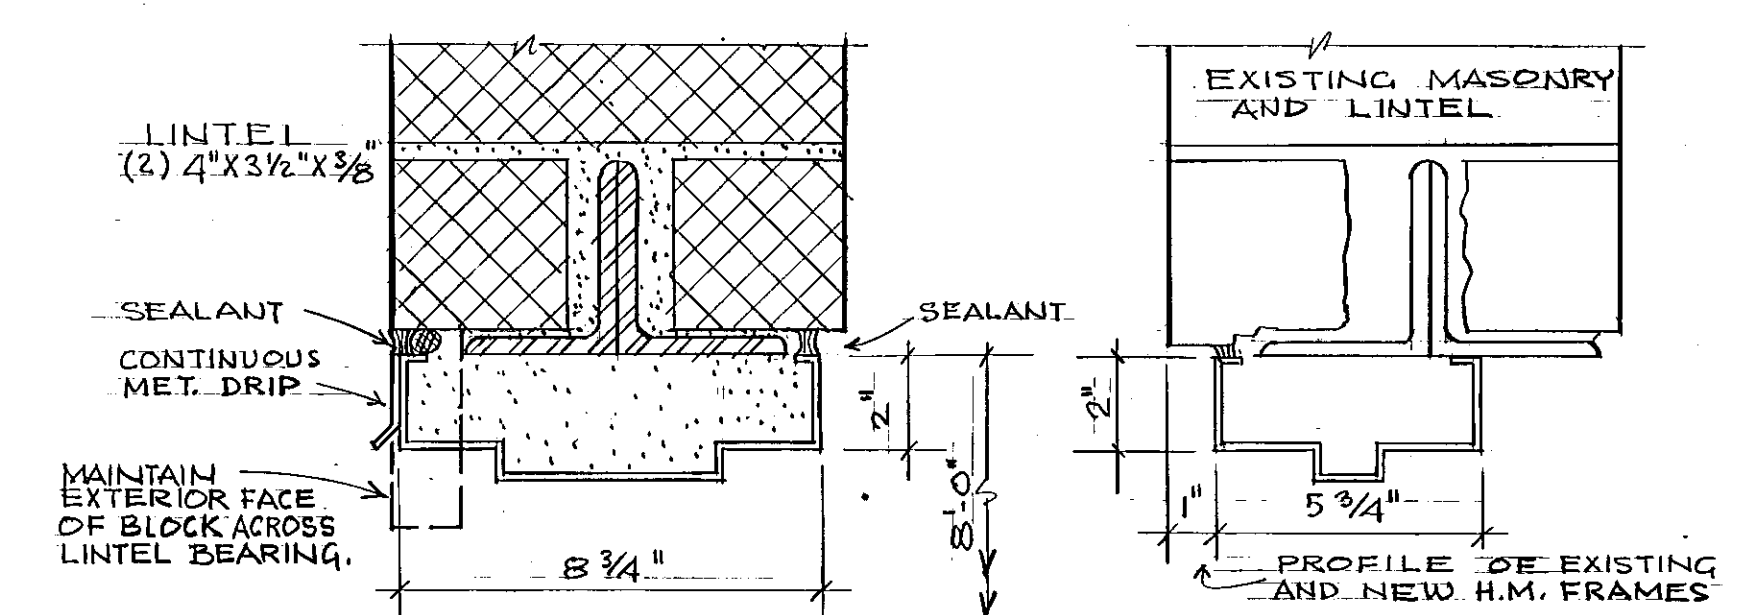


HEAD 2 HEAD 1

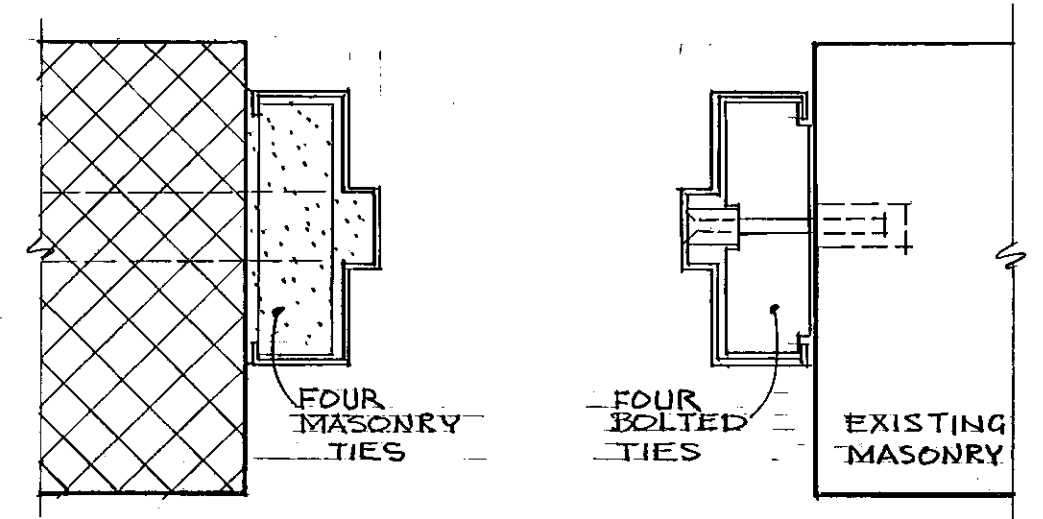


JAMB A JAMB B

DOOR SCHEDULE						
DOOR NO.	DOOR SIZE	DOOR THICKNESS	DOOR ELEVATION	HEAD	JAMB	NOTES
1	PAIR 40" X 7'-10"	1 3/4"	A	1	A & B	1, 3, 5, 6, 8
2	PAIR 40" X 7'-10"	1 3/4"	B	2	C	1, 2, 4, 5, 7, 8

DOOR SCHEDULE NOTES
 1. LITES: 1/4" LEXAN (OR APPR'D. EQUAL)
 2. ASTRAGAL TACK WELDED @ 8" O.C.
 3. SECURITY GUARD AT MULTIPURP. RM. SIDE
 4. SECURITY GUARD AT EXTERIOR SIDE
 5. COORDINATE LITE & SECURITY GUARD LOCATIONS TO CLEAR DOOR HARDWARE.
 6. NO THRESHOLD (CLEAN & PATCH FLOOR).
 7. METAL THRESHOLD
 8. HARDWARE (SEE SPECS.)

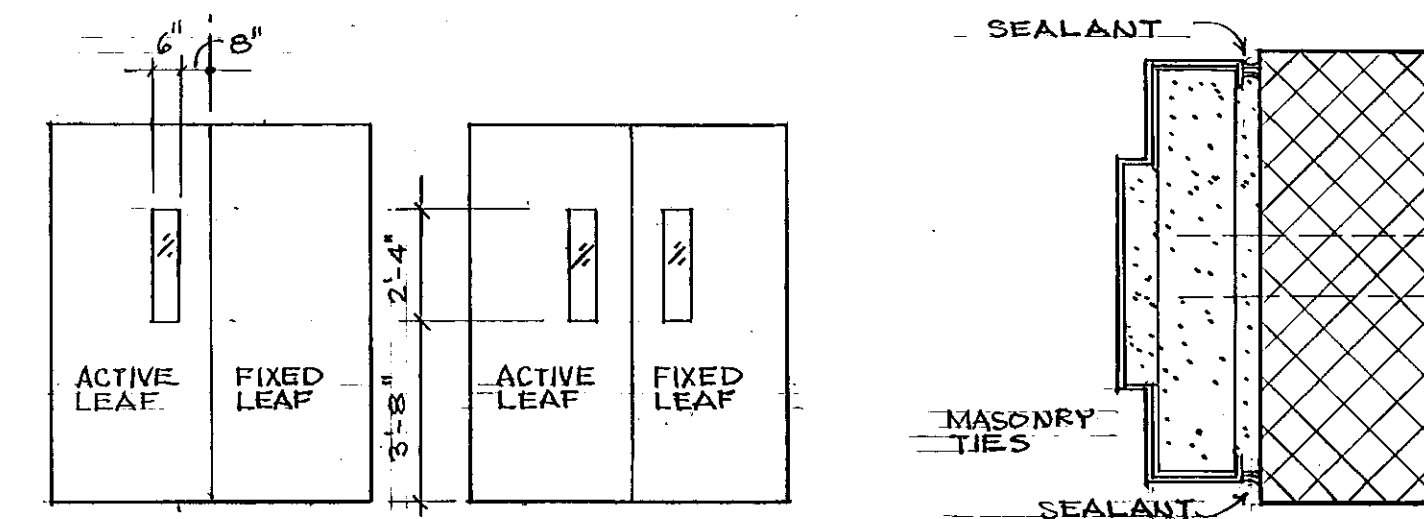

DOOR ELEVATIONS (FROM INTERIOR)

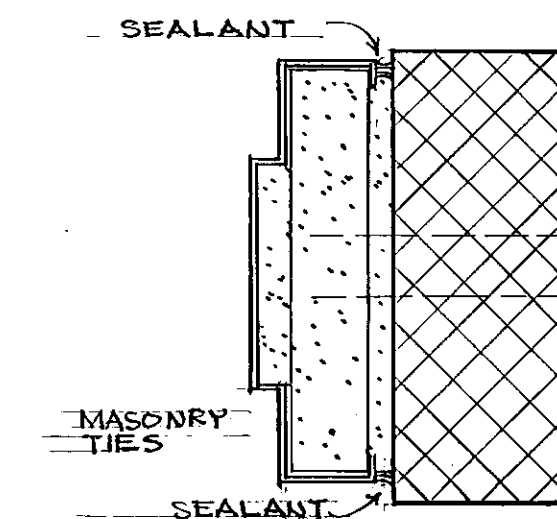

JAMB C

SEE DRAWING SD-7 FOR PROJECT LOCATION

CITY OF HARTFORD, CONNECTICUT DEPARTMENT OF PUBLIC WORKS FACILITIES SERVICES BUREAU		
HARTFORD PARKS REHABILITATION II E 83-31 (UPARR PROJECT)		
HYLAND PARK CENTER VESTIBULE		
SUBMITTED <i>[Signature]</i> DRAWN <i>[Signature]</i> CHECKED <i>[Signature]</i> SCALE AS SHOWN	APPROVED <i>[Signature]</i> CITY ARCHITECT DATE AUG. 19, 1983	APPROVED <i>[Signature]</i> CITY ENGR. OIOB 58-M DRAWING NO. A-2