


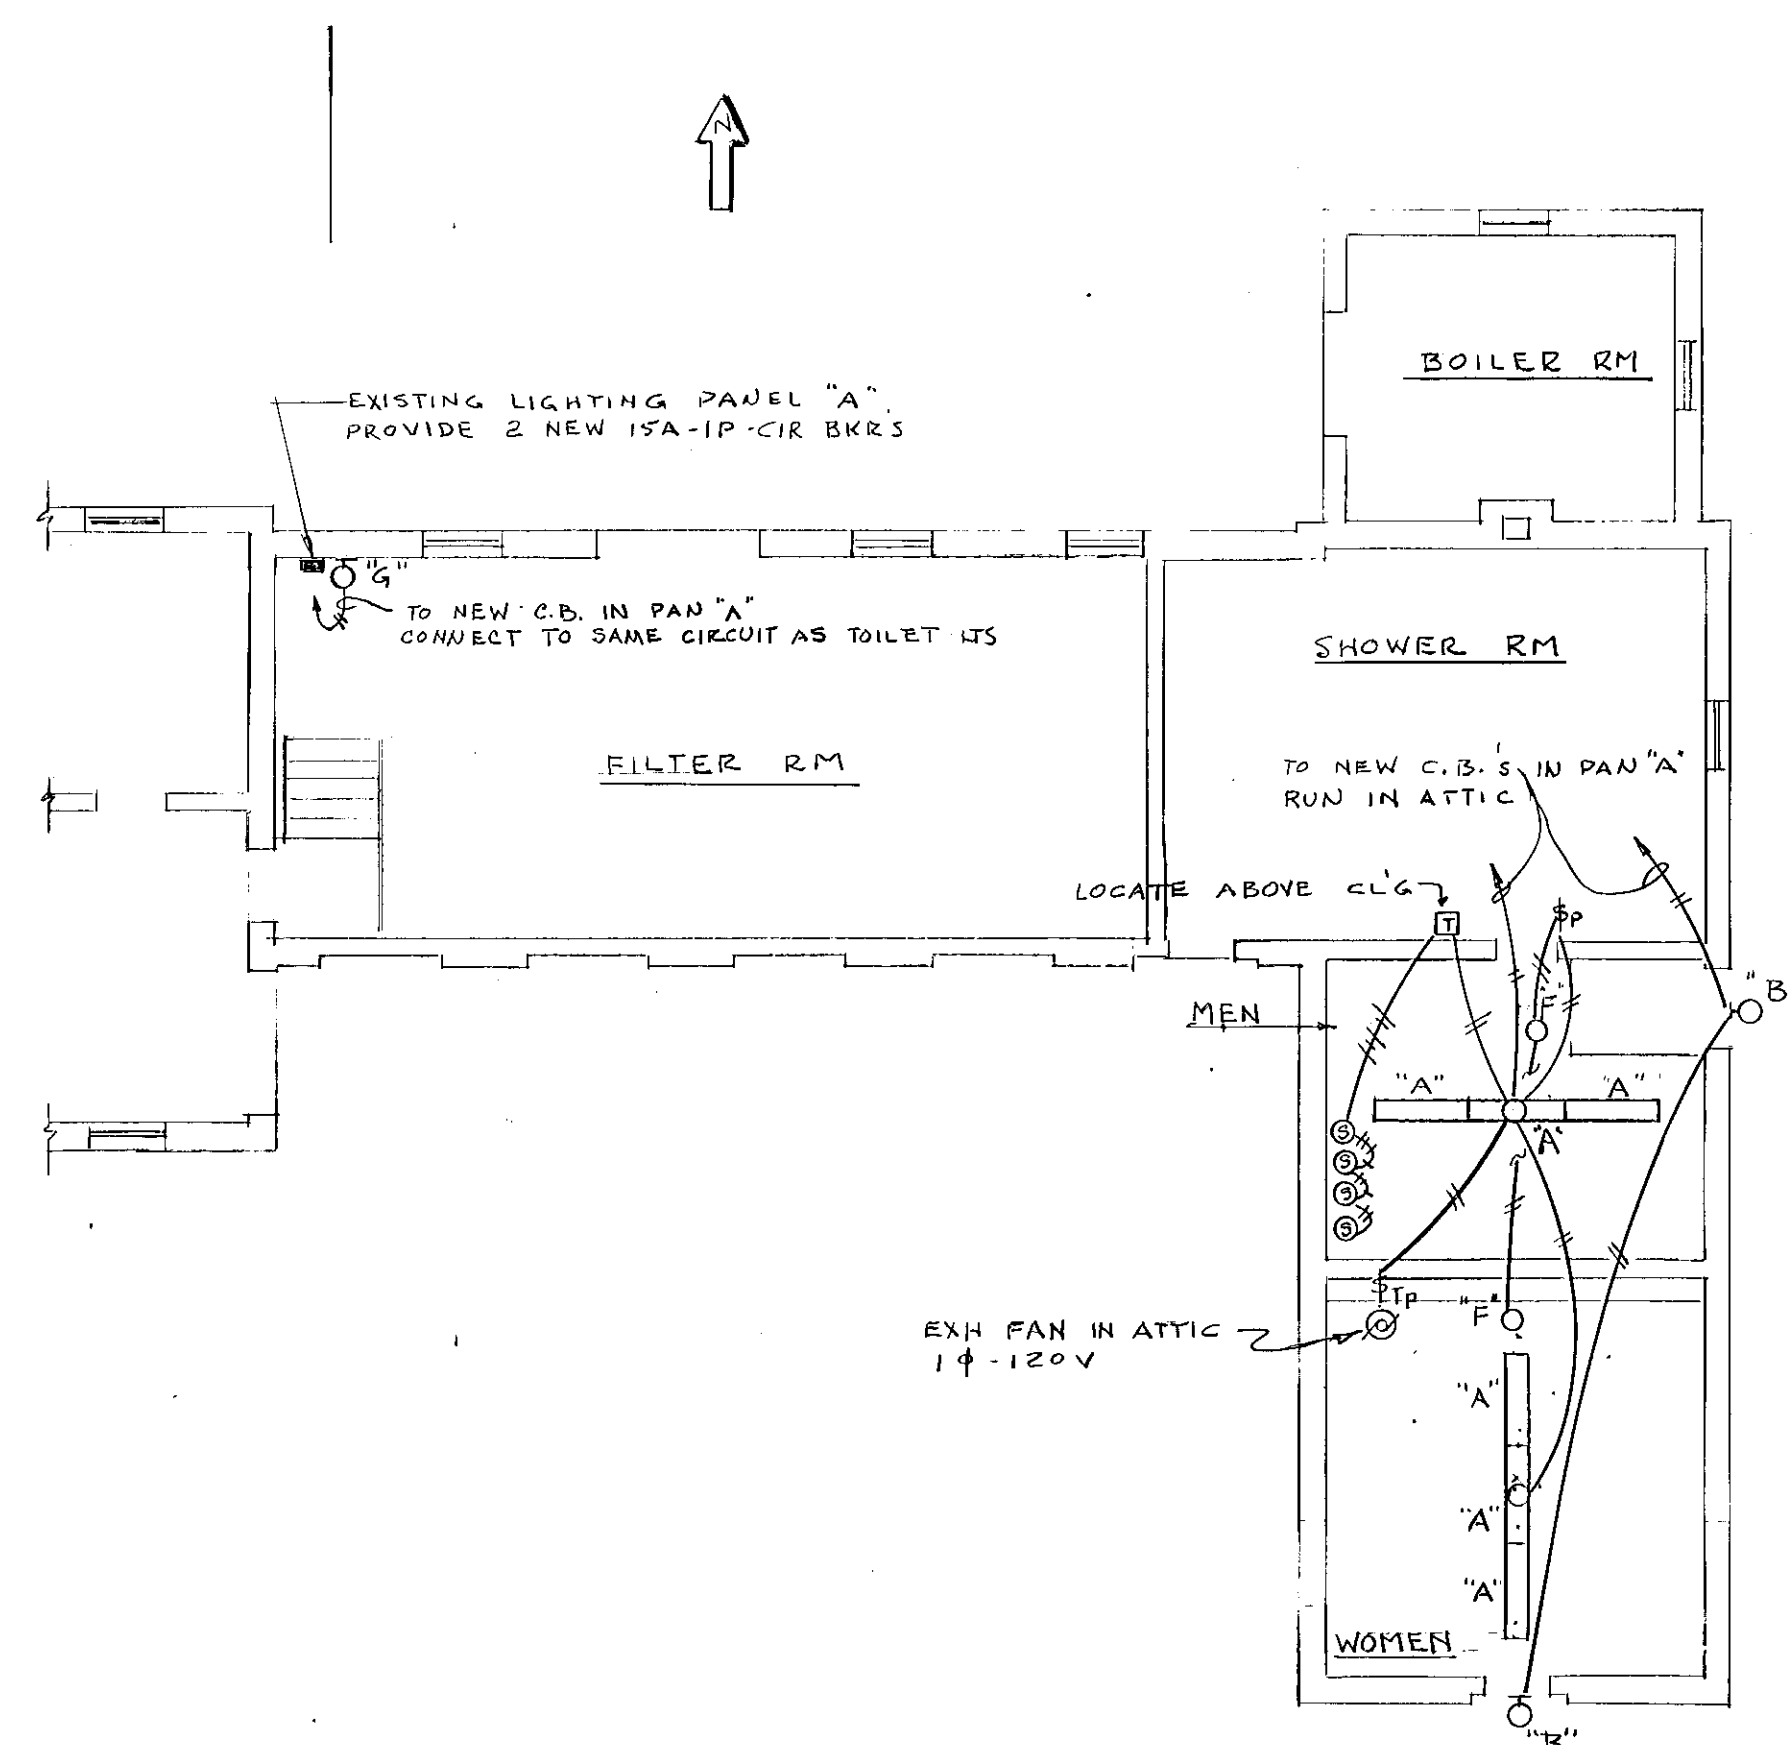


PARTIAL FLOOR PLAN
SCALE 1/8" = 1'-0"

NOTES:

- SEE ARCHITECTURAL SHEET N2.A-1 & SITE PLAN FOR LOCATION OF WORK
- PROVIDE NEW CONDUCTORS FOR ALL WIRING SHOWN.
- RUN NEW CONDUCTORS IN EXISTING RACEWAYS WHERE POSSIBLE. PROVIDE NEW RACEWAYS WHERE EXISTING CANNOT BE REUSED OR WHERE NONE EXIST. NEW RACEWAYS SHALL BE EMT, 1/2" MIN.
- RESET EXISTING BOXES FOR FIXTURE "B"
- PROVIDE PLASTIC COVER PLATES FOR ALL NEW JUNCTION BOXES AND FOR ALL EXISTING BOXES THAT WILL NOT BE REUSED DUE TO THESE ALTERATIONS

COLT PARK

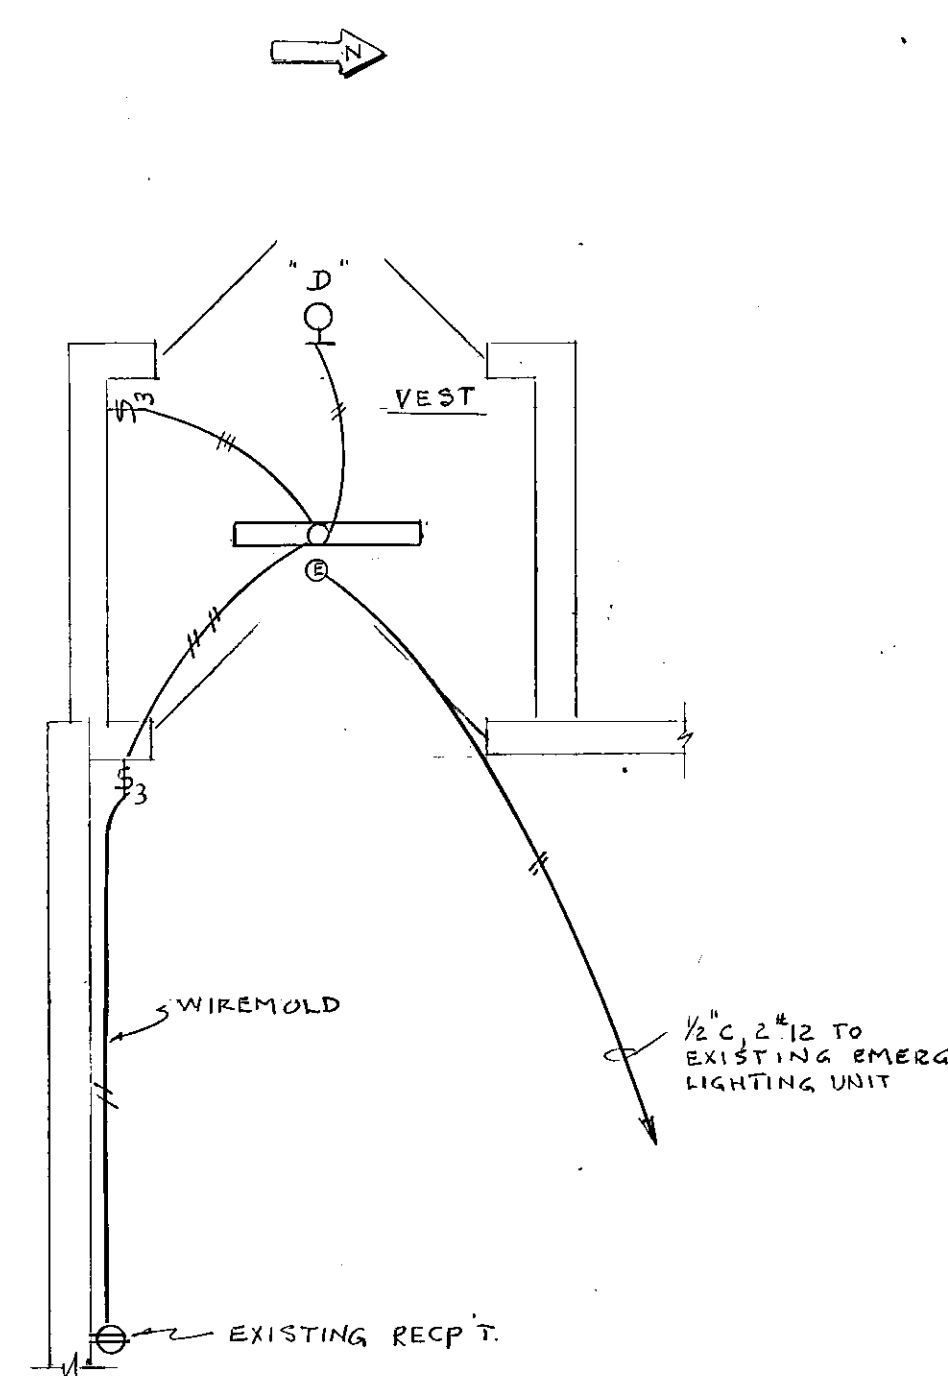


PARTIAL FLOOR PLAN
SCALE 1/4" = 1'-0"

NOTES:

- WIRING SHALL BE IN ACCORDANCE WITH ARTICLE #518-NEC
- RUN ALL WIRING CONCEALED WHERE POSSIBLE - IN WALLS, ABOVE CEILING, ETC
- SEE ARCHITECTURAL SHEET A-2 & SITE PLAN SHEET SD-7 FOR LOCATION OF WORK.
- PROVIDE ALL WIRING SHOWN.

HYLAND PARK

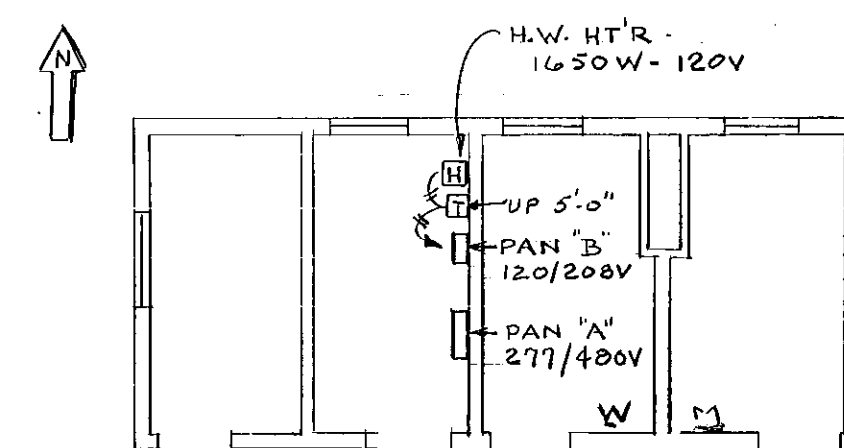

FLOOR PLAN
SCALE 1/8" = 1'-0"

NOTES:

- SEE ARCHITECTURAL SHEET A-3 & SITE PLAN SD2 FOR LOCATION OF WORK
- PROVIDE NEW COVER FOR PANEL "B"
- PROVIDE NEW ONE 20A-1P CIR. BK'R IN PANEL "B" FOR H.W. HT'R.
- PROVIDE WIRING FOR NEW WATER HEATER. WIRING TO BE 2"12, 1/2" EMT.

WAVERLY FIELD

NOTES:

- SEE SITE PLAN SD-3 FOR LOCATIONS & ALTERATIONS.
- REMOVE THE SERVICE INCLUDING RACEWAYS, CONDUCTORS, METERING EQUIPMENT, GROUNDING, ETC.
- REMOVE PANELBOARD.
- REMOVE ALL CONDUCTORS.
- REMOVE ALL LIGHTING FIXTURES, WIRING DEVICES, EXPOSED RACEWAYS AND ALL OTHER EXPOSED OR SURFACE MOUNTED ELECTRICAL EQUIPMENT.
- PLUG ALL CONDUITS LEVEL WITH FLOOR.
- PROVIDE PLASTIC COVERS WITH TAMPER-PROOF SCREW FOR ALL RECESSED BOXES THAT REMAIN.

POPE PARK

SYMBOL LIST	
SYMBOL	DESCRIPTION
O	CEILING OUTLET OR FIXTURE
—	FLUORESCENT FIXTURE
HO	WALL BRACKET
⊙	EMERGENCY LIGHT
3	THREE WAY SWITCH ~ H&H #1893 ~ UP 4'-0"
⊙	SOLENOID VALVE ~ NOTE #1
⊙	TIMER ~ NOTE #2
⊙	MOTOR ~ NOTE #1
⊙	MANUAL MOTOR STARTER ~ NOTE #2
⊙	SINGLE POLE SWITCH & PILO. LT ~ H&H #1891 & 1720RED ~ MOUNT ON CEILING
⊙	HOT WATER HEATER ~ NOTE #1
NOTES: 1. FURNISHED & INSTALLED BY OTHERS; WIRED BY THIS ELEC. CONT'R	
2. FURNISHED BY OTHERS; INSTALLED & WIRED BY THIS ELEC. CONT'R	

FIXTURE SCHEDULE	
TYPE	DESCRIPTION
A	KENALL #7140 ~ CEILING MTD ~ LAMP 1-F40CW
B	KENALL #3737 ~ OVER DOOR ~ LAMP 100W IF INCAND.
C	KENALL #7140-0' WITH 0'F BALLAST ~ CEILING MTD ~ LAMP 1-F40CW
D	HUBBELL #PVL-0100S-118-PBT WITH PHOTOELECTRIC CONTROL #PBT-1 & PVL-PK UP 10'-0" ~ LAMP 100HPS
E	DUAL-LITE #EXT-124R W/ PLEXIGLASS LENS ~ RECESSED ~ LAMP 13W-6V
F	ARROW HART #4350 ~ MOUNT ON ATTIC CEILING ~ 100 W IF INCAND
G	ARROW HART #4350 ~ UP 7'-0" ~ LAMP 11W-130V-TRANSPARENT RED-GE#HS14/TR.

ELECTRICAL

CITY OF HARTFORD, CONNECTICUT
DEPARTMENT OF PUBLIC WORKS
FACILITIES SERVICES BUREAU

HARTFORD PARKS REHABILITATION II E 83-31
(UPARR PROJECT)

COLT, HYLAND, & POPE PARKS
& WAVERLY FIELD

SUBMITTED <i>Raymond H. Bennett</i>	APPROVED <i>Paul Anthony</i> CHIEF FAC. SER. BUREAU	APPROVED <i>James C. Nelson</i> CITY ENGR.
DRAWN <i>R.G.B.</i>	DAYBOOK NO. 010258-0	DRAWING E-1
CHECKED <i>R.G.B.</i>	DATE AUG. 19, 1983	
SCALE AS NOTED		

VERIFY EXISTING CONDITIONS