

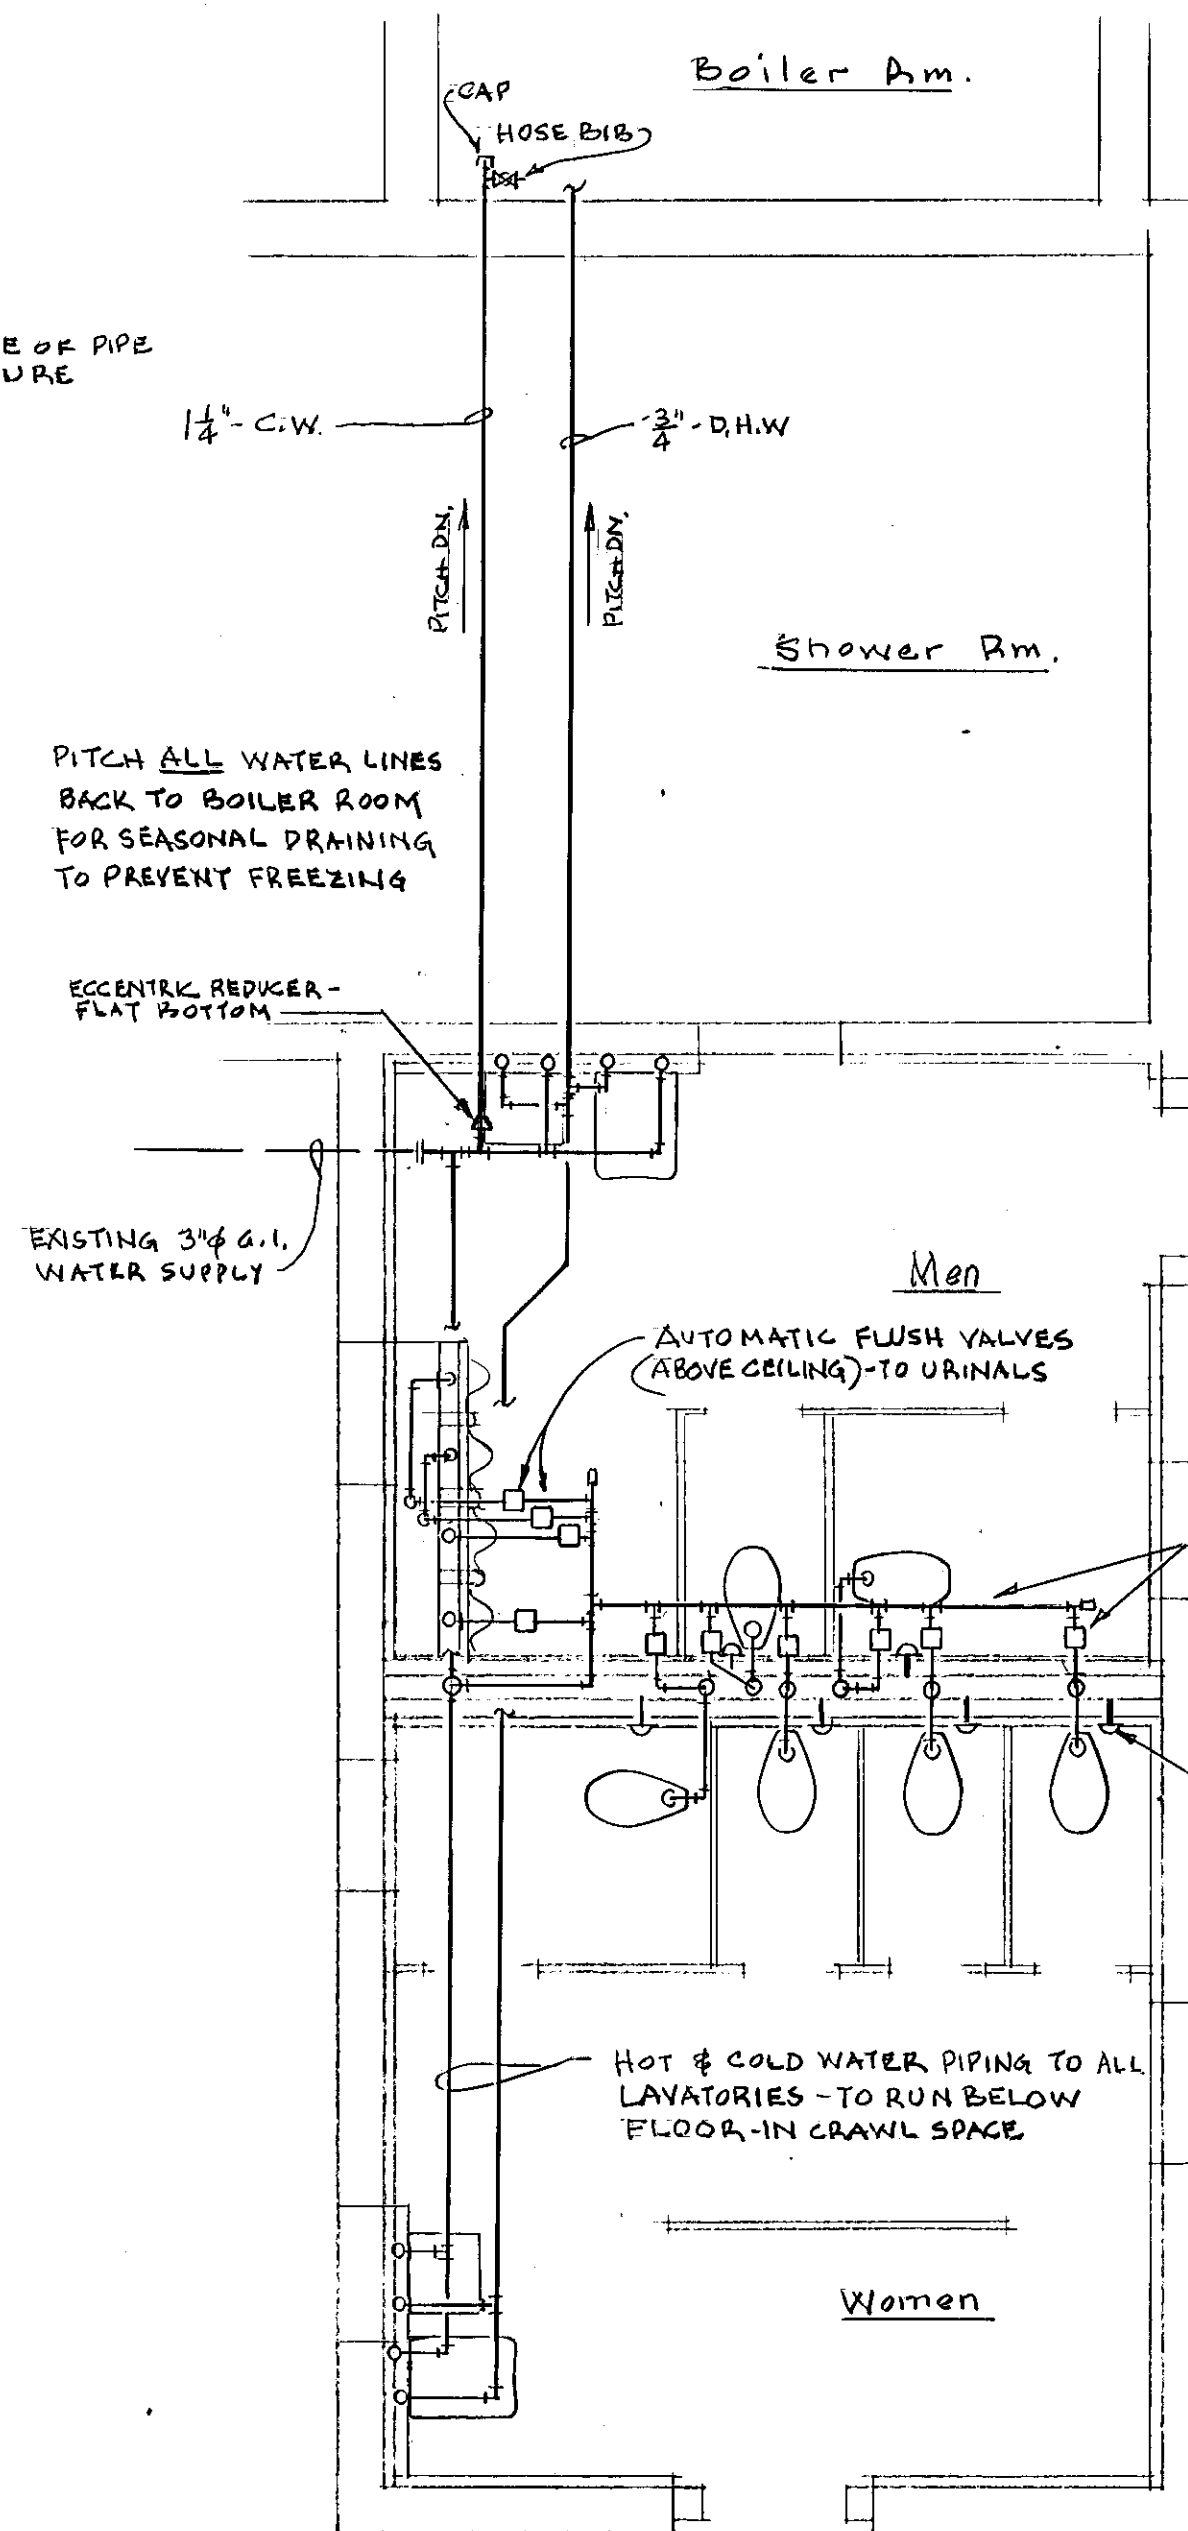
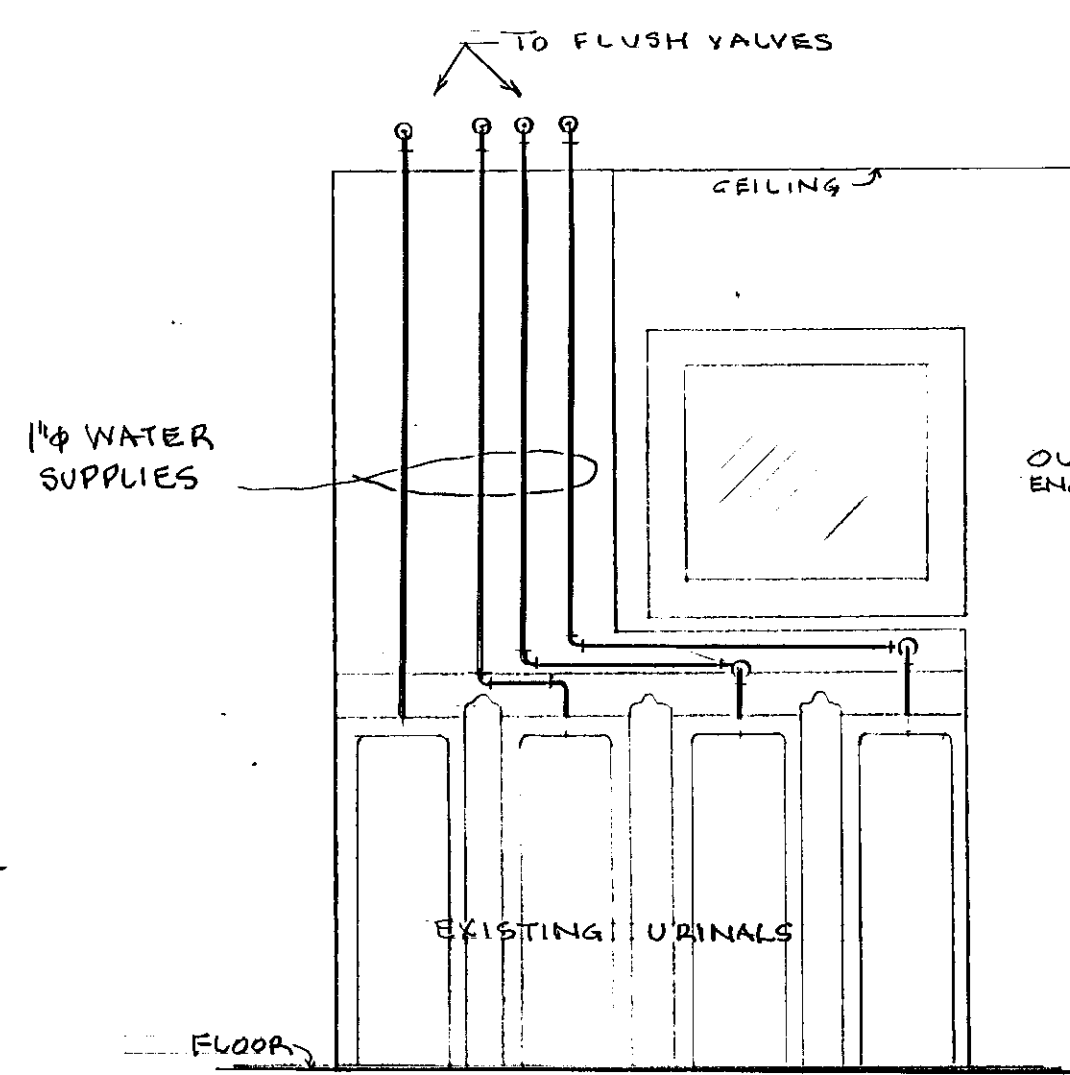



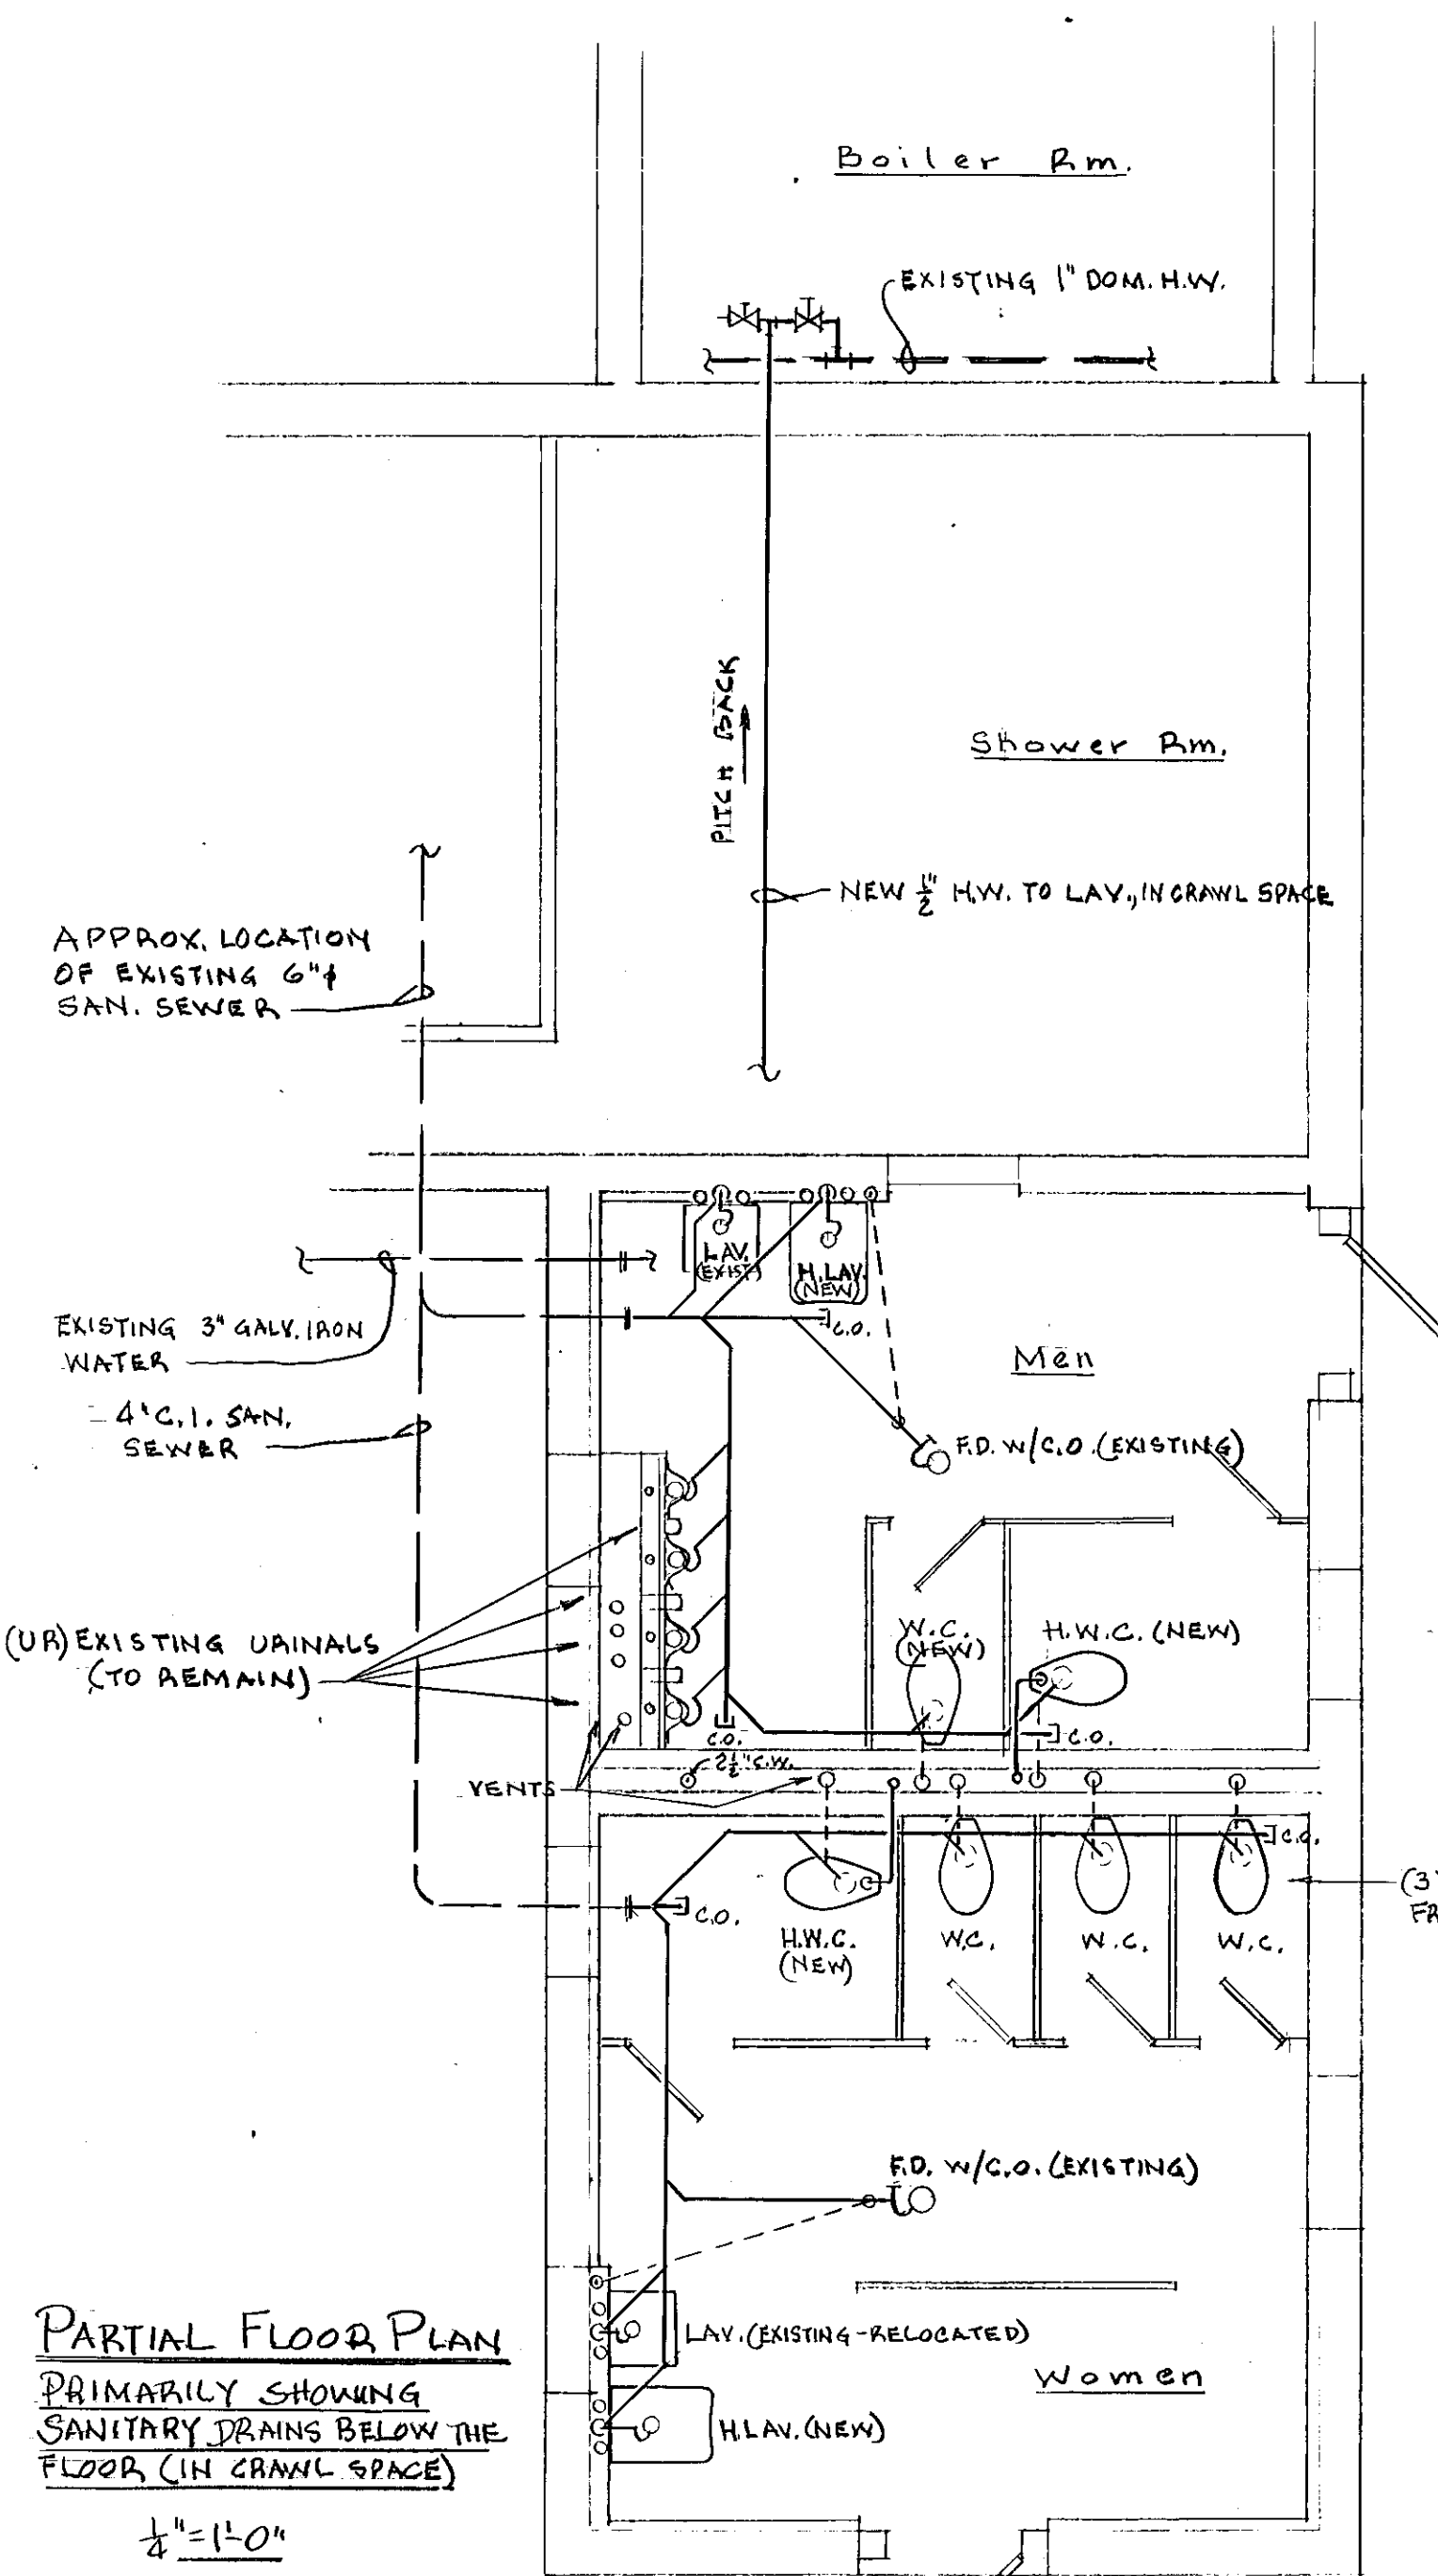


Drawing Designation	Description	For Use by Handicapped	Manufacturer	Model No.	Waste	Vent	C.W.	H. W.	Applicable Notes
W.C. (New)	Water Closet		American Standard	2342.012 Taibor	4"	2"	1"	----	A, C
H.W.C. (New)	Water Closet	Yes	American Standard	2342.012 Tribor	4"	2"	1"	----	A, C, I
W.C. (Existing)	Water Closet		?	?	4"	2"	1"	---	A, D
UR. (Existing)	Urinal		?	?	2"	1 1/2"	1"	----	B
Lav. (Existing)	Lavatory		?	?	1 1/4"	1 1/4"	3/8"	3/8"	E, H
H. Lav. (New)	Lavatory	Yes	American Standard	9141.011 Wheelchair	1 1/4"	1 1/4"	3/8"	3/8"	F, G, I

* SEE NOTES - ELSEWHERE THIS SHEET

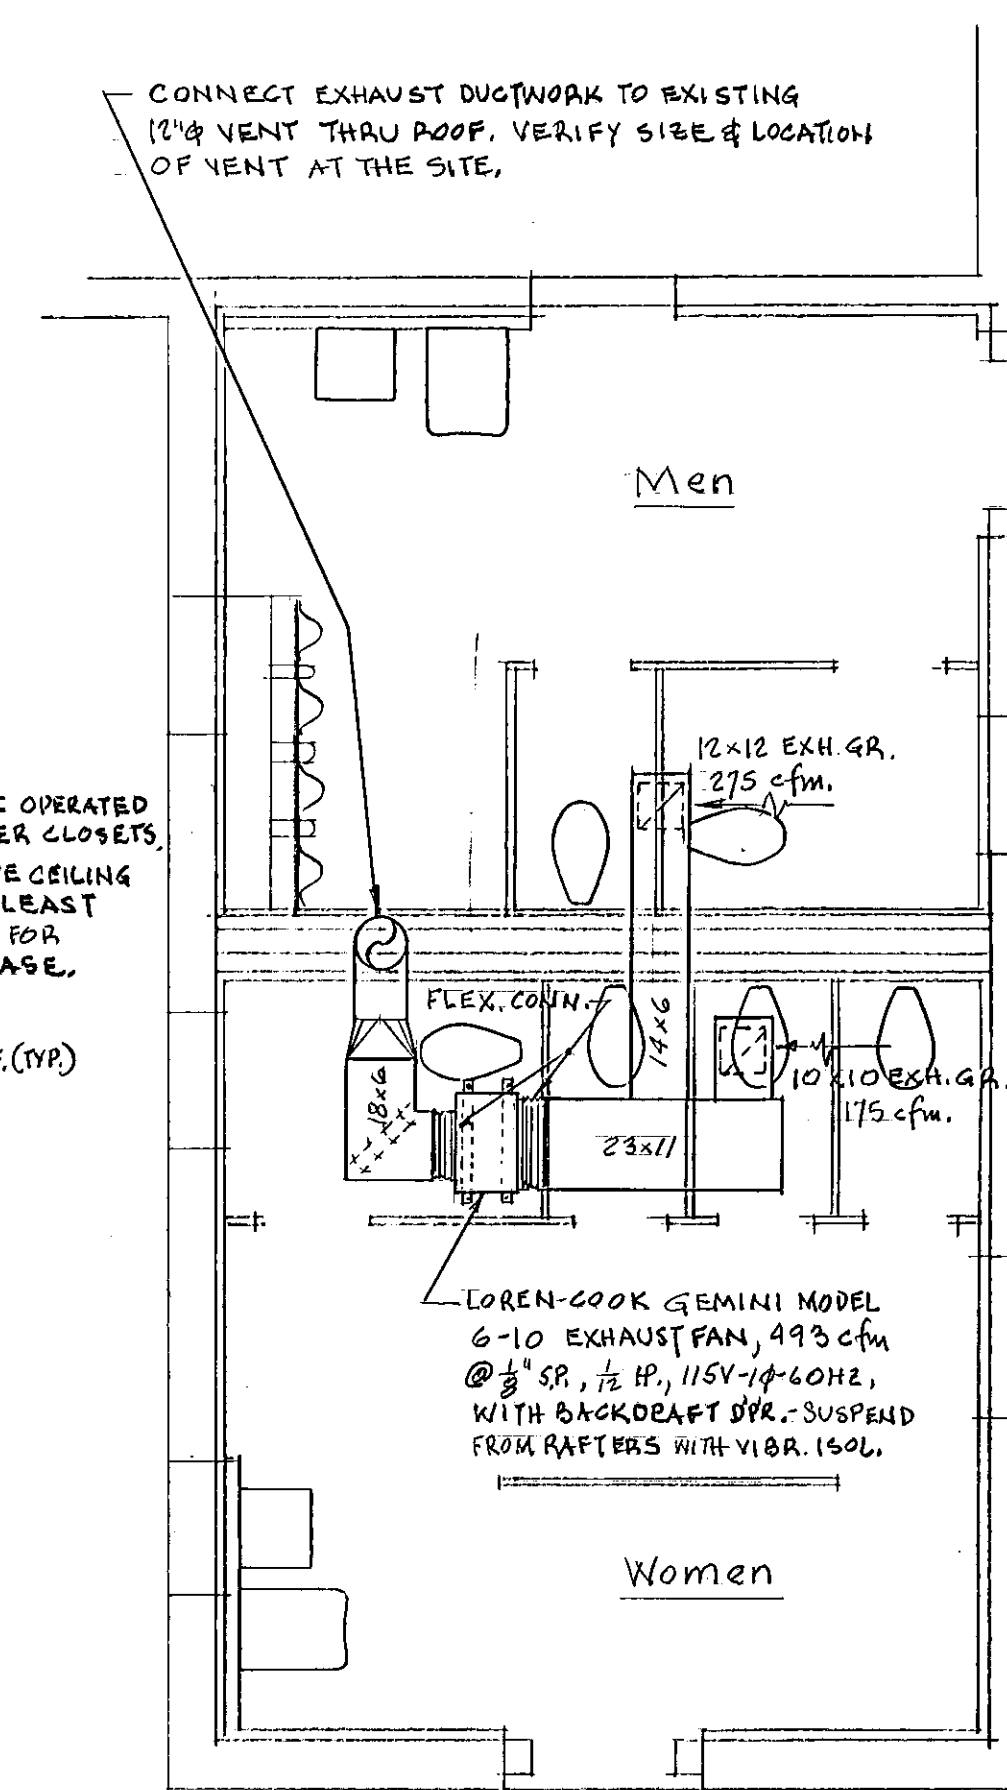

NOTES:
1. ELECTRICIAN TO WIRE FAN TO LIGHT SWITCH
2. MOUNT FAN HIGH ENOUGH TO BE ACCESSIBLE FOR SERVICING.

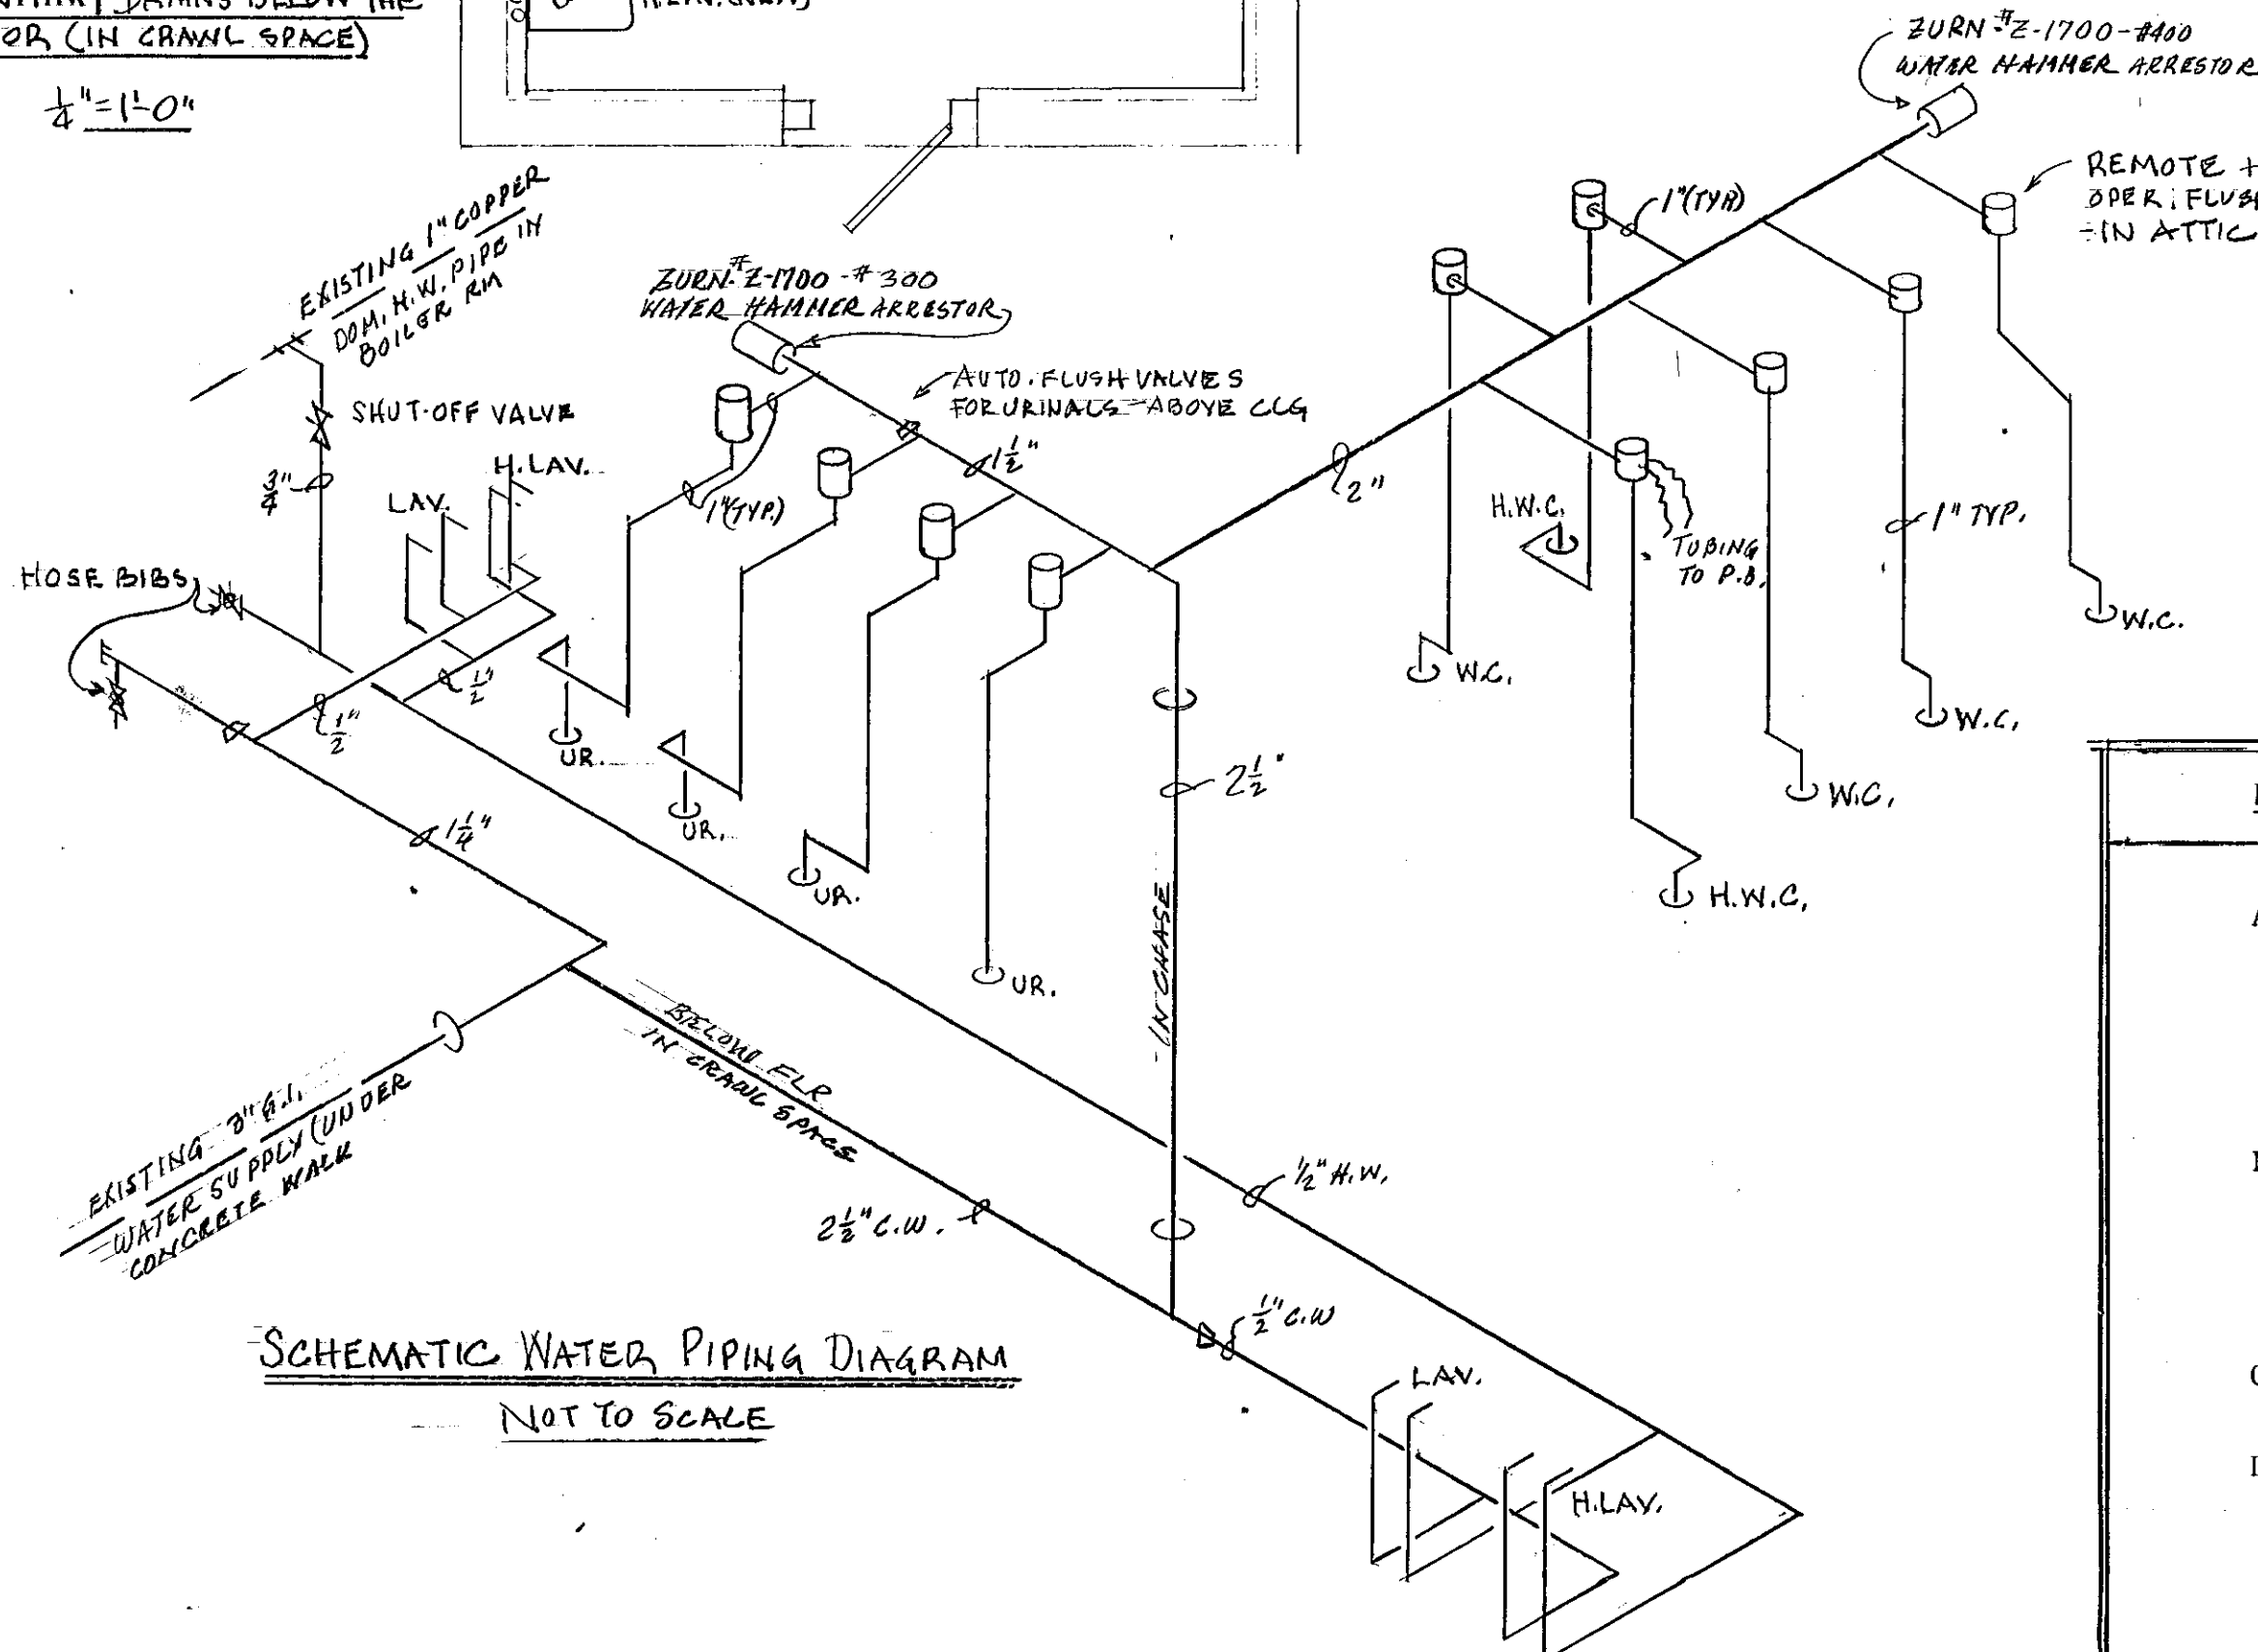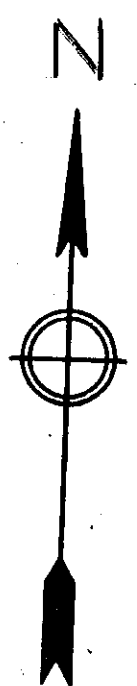

NOTES: (Plumbing Fixture Schedule) - Colt Park

- Sloan Royal 942 concealed flush valve with HY-33-A Hydraulic push button assembly complete with wall clamp and threaded rod suitable for the wall in which it is to be installed, plus adequate nylon tubing to reach from push buttons to flush valves mounted in attic space. Provide suitable copper tubing from flush valve to water closet. Mount push button 42" above the floor.
- Sloan Royal No. 821 for automatic flushing, one for each urinal with Model EL-30 - Three Circuit Timer. Valves and Timer to be suitable for 115 Volt - 60 cycle power. Provide copper tubing to existing urinals from flush valves mounted in the attic space. Timer to be activated with lights and exhaust fan to flush in sequence every 5 minutes.
- Church Model 5320.536 open front white seat.
- New Open front white seats to fit existing water closets.
- Delta Faucet Co., Model 701 Push handle, vandal resistant, self closing faucet (one for hot water, one for cold water), with new drain, "P" trap, and supply with loose key set.
- American Standard No. 7723.018 "P" trap, Delta Model 523 Vandal resistant, single lever faucet with grid strainer, loose key supplies.
- Jay R. Smith, Fig. No. 700-27-M31-U, with 1 x 3 rectangular uprights, support for wheelchair lavatory, vandal resistant.
- Provide suitable vandal resistant heavy-duty mounting supports, for relocated existing lavatories.
- Fixtures indicated for use by the handicapped shall be installed in accordance with the latest Connecticut Building Code requirements for that service, including insulation of the exposed hot water piping and drains.

GENERAL NOTES:
1. SEE ARCHITECTURAL DRAWING NO A-1 FOR LOCATION OF WORK.
2. VERIFY EXISTING CONDITIONS AT JOB SITE.

CITY OF HARTFORD, CONNECTICUT
DEPARTMENT OF PUBLIC WORKS
FACILITIES SERVICES BUREAU

HARTFORD PARKS REHABILITATION II E 83-31
(UPARR PROJECT)

PLUMBING & VENTILATING
COLT PARK

SUBMITTED <i>[Signature]</i>	APPROVED <i>[Signature]</i> CHIEF FAC. SER. BUREAU	APPROVED <i>[Signature]</i> CITY ENGINEER
DRAWN BY E. J. MILLER	DATE AUG. 19, 1983	DRAWING NO. M-1
CHECKED SCALE AS NOTED	DAYBOOK NO. 010858-R	