


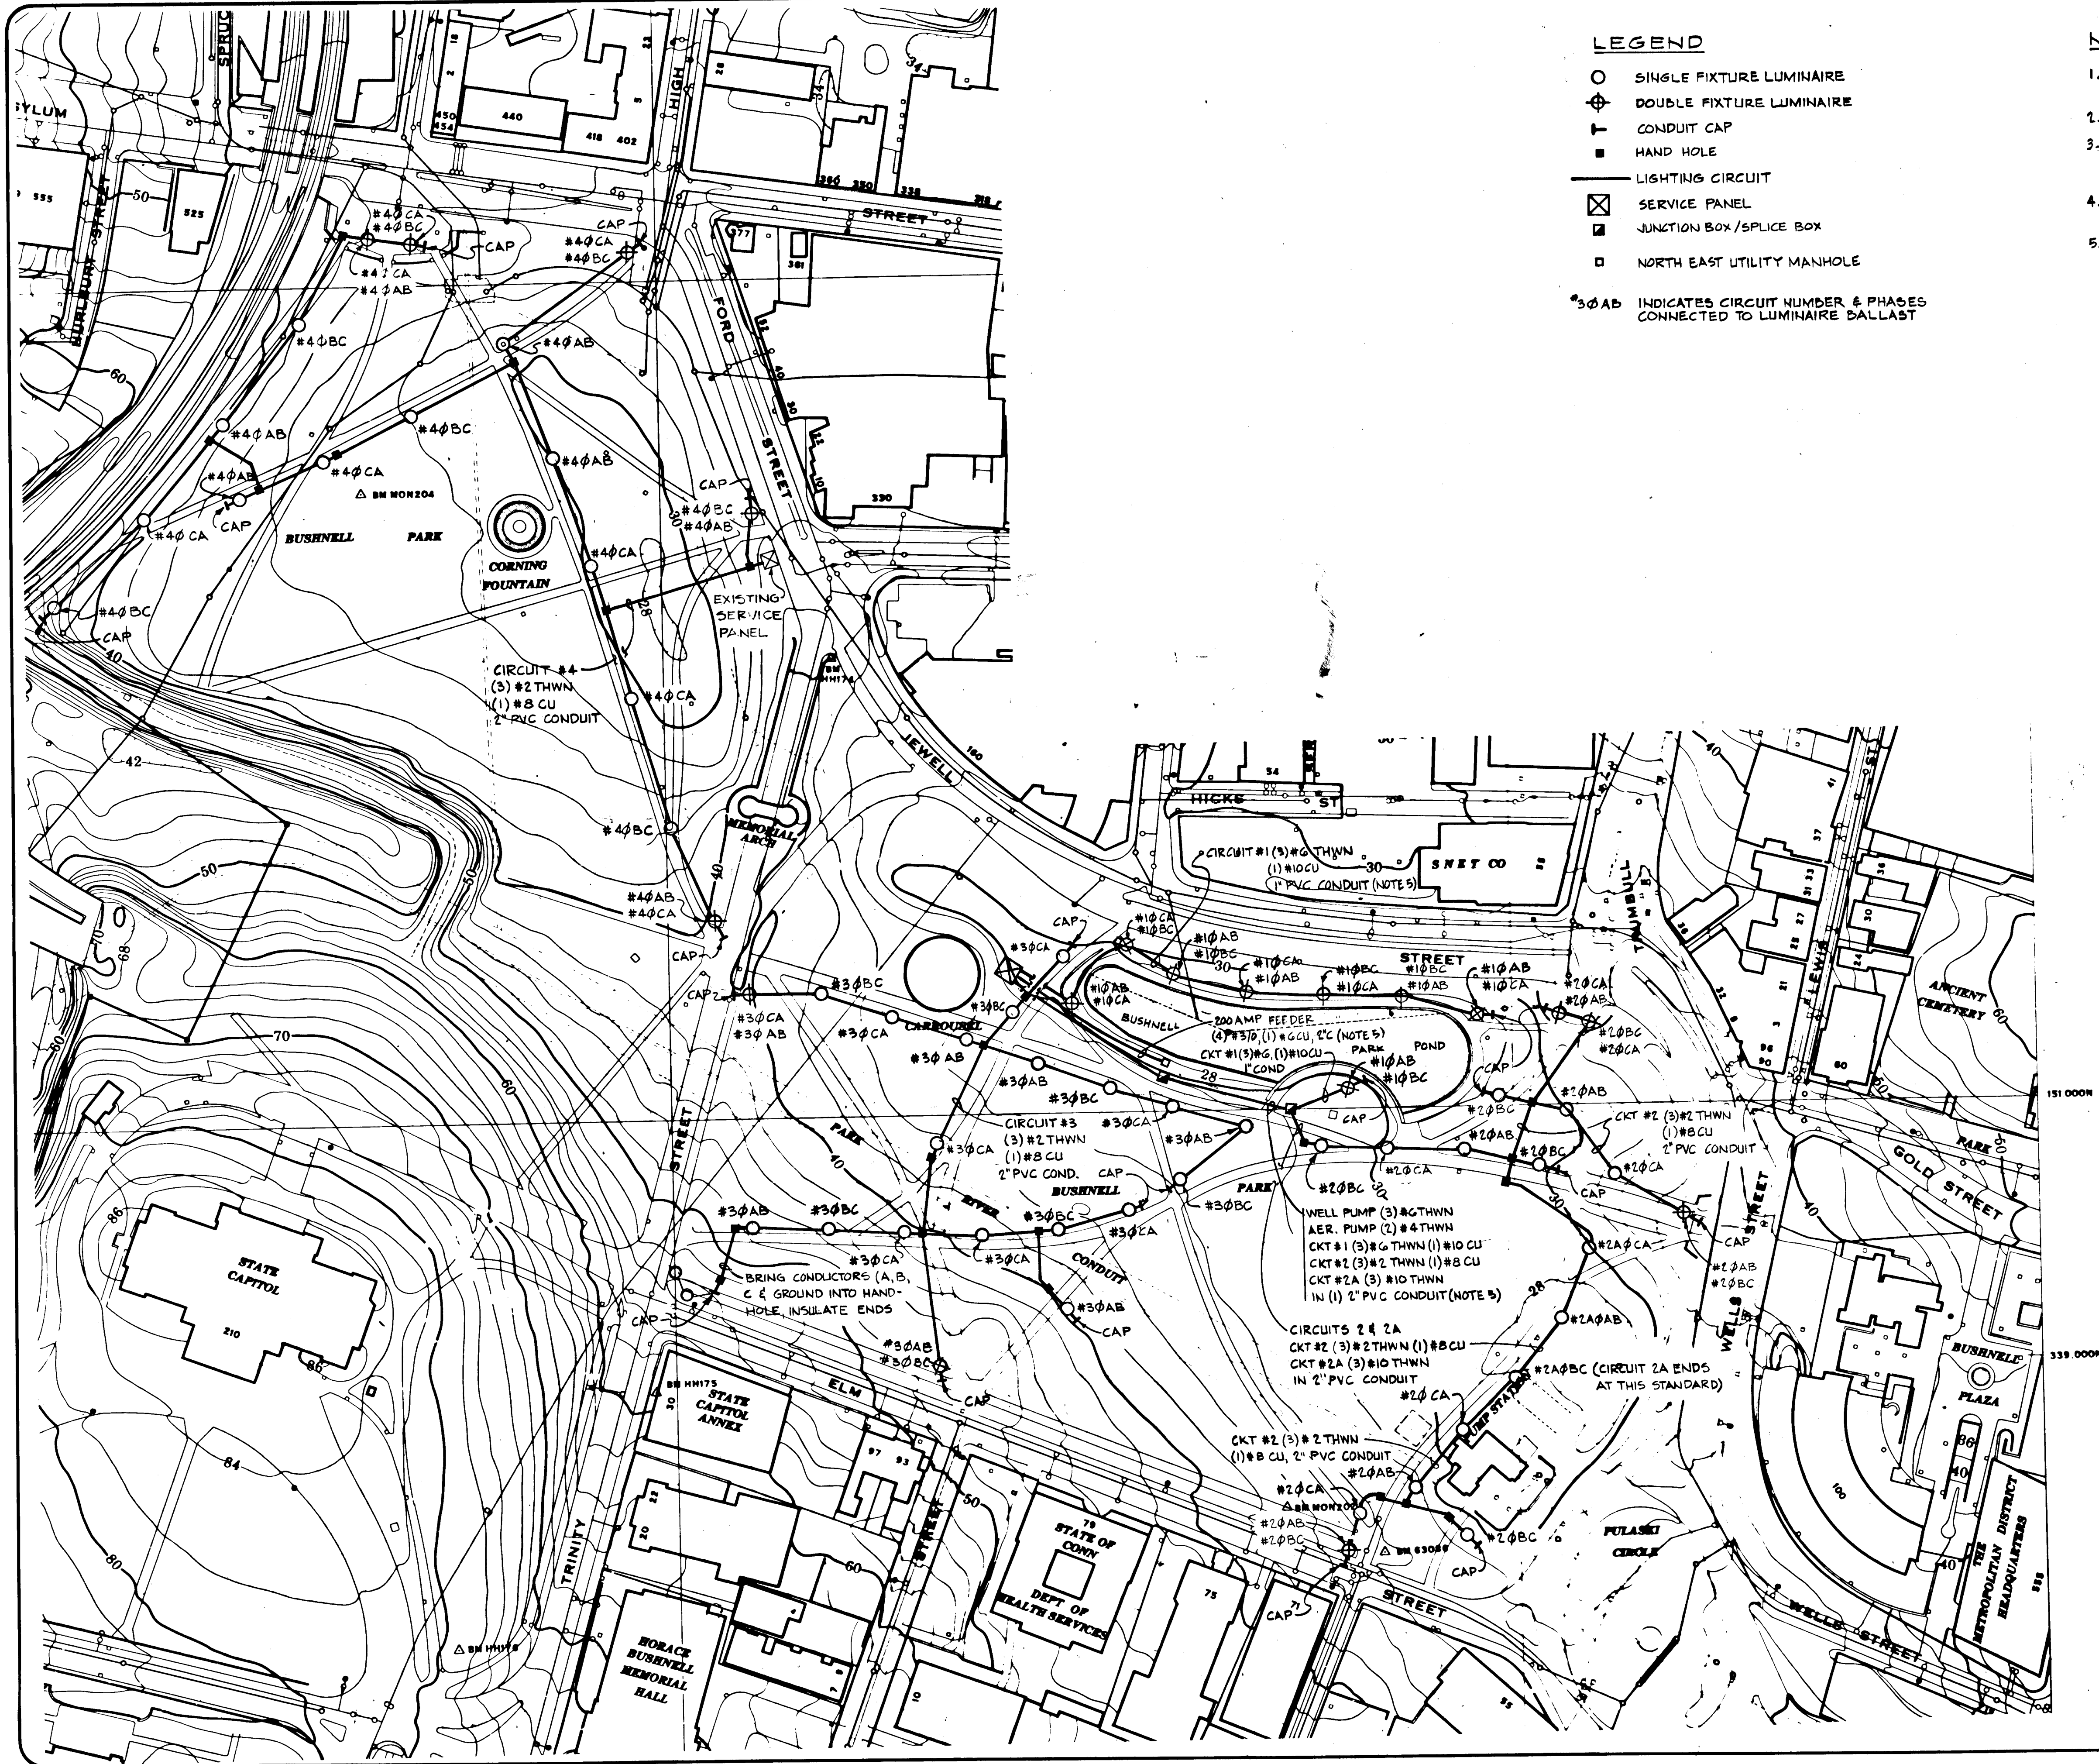

LEGEND

- SINGLE FIXTURE LUMINAIRE
 - ⊕ DOUBLE FIXTURE LUMINAIRE
 - ⊥ CONDUIT CAP
 - HAND HOLE
 - LIGHTING CIRCUIT
 - ⊠ SERVICE PANEL
 - ⊞ JUNCTION BOX / SPLICE BOX
 - NORTH EAST UTILITY MANHOLE
- *30AB INDICATES CIRCUIT NUMBER & PHASES CONNECTED TO LUMINAIRE BALLAST

NOTES:

1. ALL LIGHTING CIRCUITS TO BE 24" BELOW FINISHED GRADE IN PVC CONDUIT.
2. CONDUCTOR SIZES NOTED ON PLAN & SCHEMATIC.
3. ALL LIGHTING STANDARDS SHALL BE GROUNDED TO BOTH THEIR INDIVIDUAL GROUND RODS AND EQUIPMENT GROUND CONDUCTOR.
4. REFER TO SYSTEM SCHEMATIC AND ELECTRICAL DETAILS.
5. CONDUIT INSTALLED UNDER DIFFERENT CONTRACT.

CITY OF HARTFORD
DEPARTMENT OF PUBLIC WORKS
FACILITY SERVICE BUREAU

BUSHNELL PARK PATHWAY
LIGHTING
PROPOSED
SITE LIGHTING PLAN

Designed by: J.E.B.
Drawn by: R.E. Moski
Checked by: JAM
Approved by: EROK

Scale: 1" = 100'

Date: AUG 1, 1983

Dwg. No. 3 of 8

Dwg. No.

3

SUBMITTED [Signature]	APPROVED [Signature]	APPROVED [Signature]
DRAWN R. Moski	DAYBOOK NO. 010858	
CHECKED T. Mann	DATE 8/86/83	DRAWING NO. E-3
SCALE 1" = 100'		