



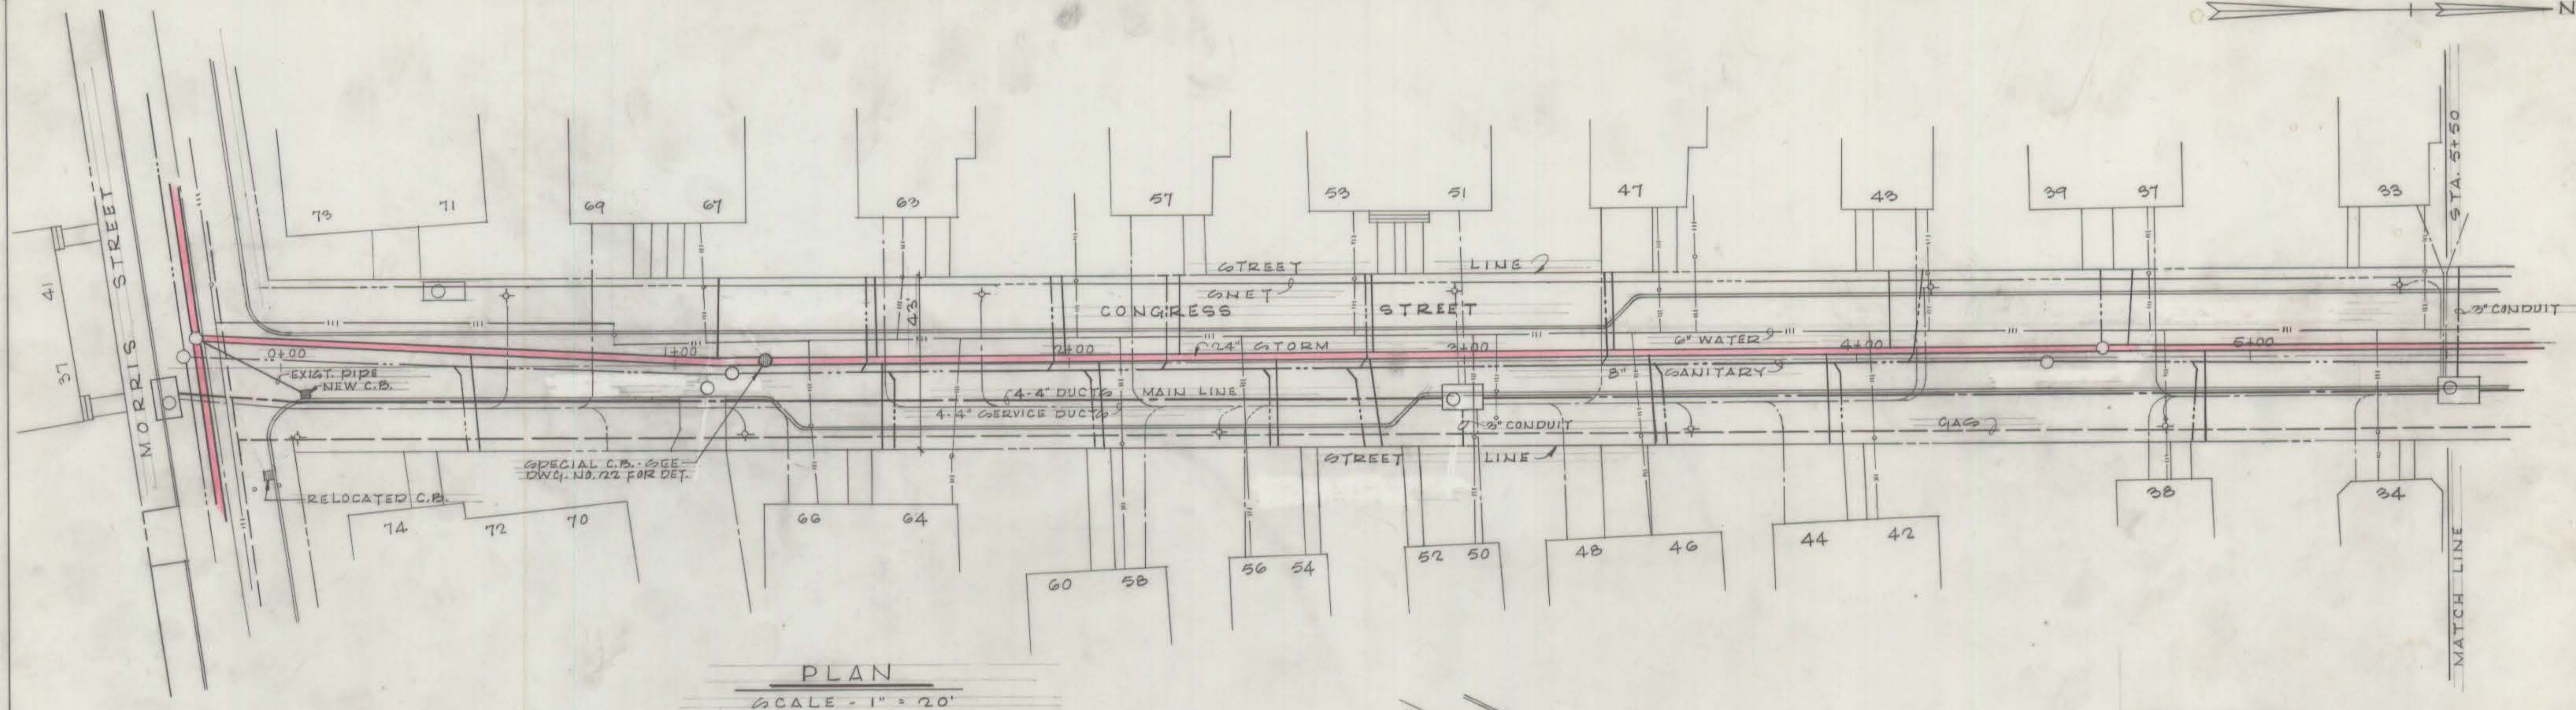

PLAN
SCALE - 1" = 20'

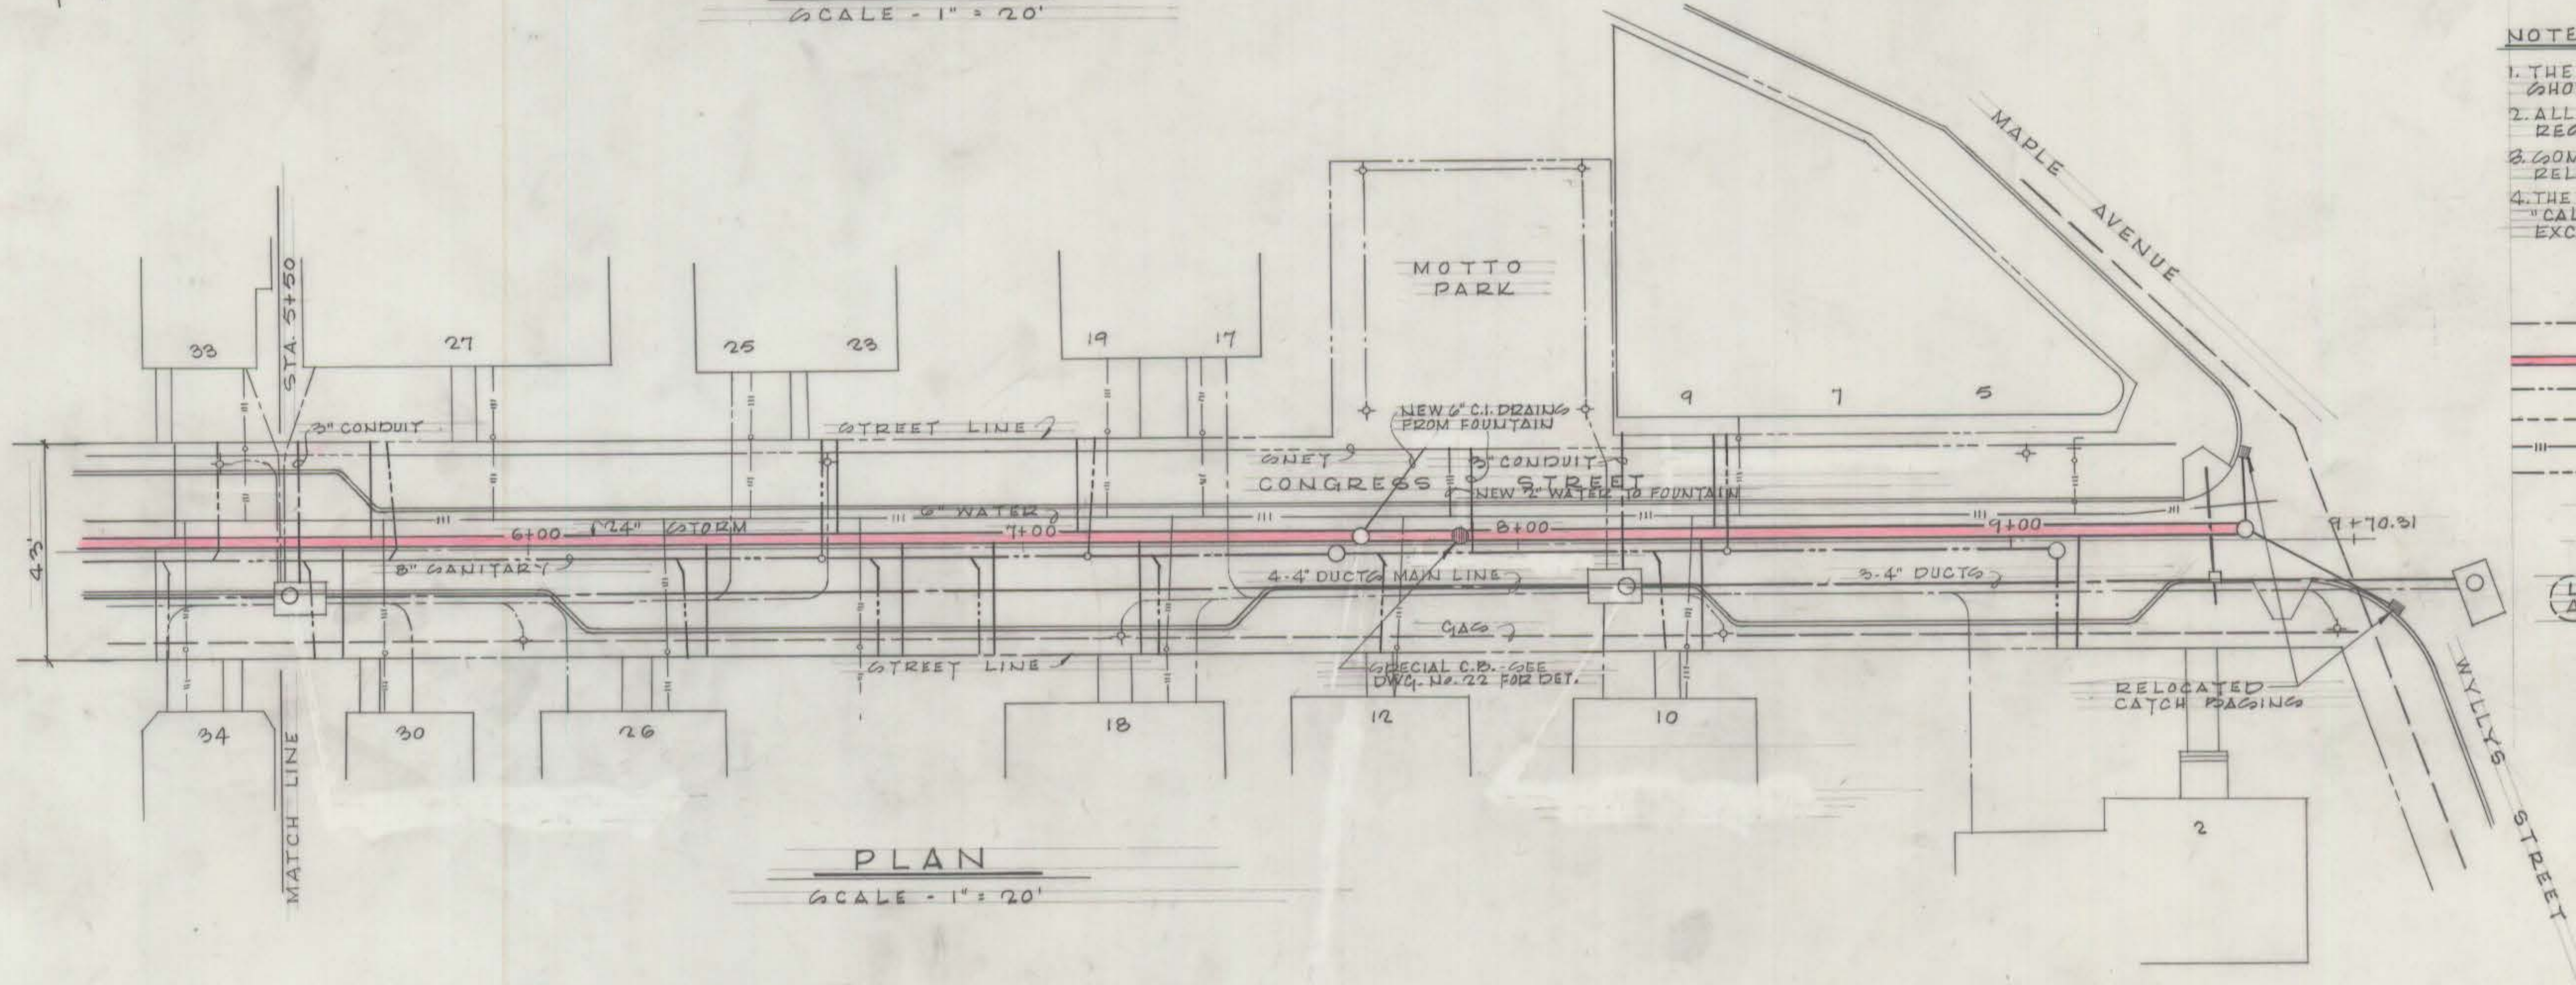

PLAN
SCALE - 1" = 20'

NOTE:

1. THE UTILITIES SHOWN ARE IN PLACE AND ARE SHOWN AS A REFERENCE TO THE CONTRACTOR
2. ALL MANHOLE FRAMES & COVERS ARE TO BE RESET TO NEW STREET GRADES.
3. SOME CATCH BASINS, MANHOLES ETC. ARE TO BE RELOCATED OR SHIFTED AS INDICATED ON PLANS.
4. THE CONTRACTOR IS STILL REQUIRED BY LAW TO CALL "CALL BEFORE YOU DIG" 48 HOURS PRIOR TO THE EXCAVATION (1-800-922-4455)

LEGEND

- ELECTRIC DUCTS
- STORM SEWER
- SANITARY SEWER
- GAS
- WATER
- TELEPHONE
- MANHOLE
- ⊕ LIGHT STANDARD

LOCATION & NO. OF STORM LATERALS FOR ALL SITE DRAINAGE BY OTHERS.

REVISED
3.28.80

NOTE: THE UTILITIES SHOWN ON THIS DRAWING ARE EXISTING. MAJOR UTILITY WORK IS NOT IN CONTRACT THIS DWG. TO BE USED FOR REFERENCE ONLY.

CITY OF HARTFORD, CONNECTICUT
DEPARTMENT OF PUBLIC WORKS
BUREAU OF ENGINEERING SERVICES
CHARTER OAK - SOUTH GREEN
URBAN RENEWAL PROJECT
HARTFORD, CONNECTICUT
UTILITY PLAN
CONGRESS STREET

SUBMITTED	RECOMMENDED	APPROVED
DIVISION ENGINEER	CHIEF OF ENG. SERV.	ASST. DIR. & CITY ENG.
DRAWN R.J.B.	SCALE	DAYBOOK NO. 010685-N
CHECKED M.G.	NOTED	DATE 7-27-79

SMITH EDWARDS ARCHITECTS

SEA Project No.
DATE:
REVISION: 3.28.80
DRAWN THUG:
331 WETHERSFIELD AVE.
HARTFORD, CT. 06114
TEL. (203) 522-7800

