


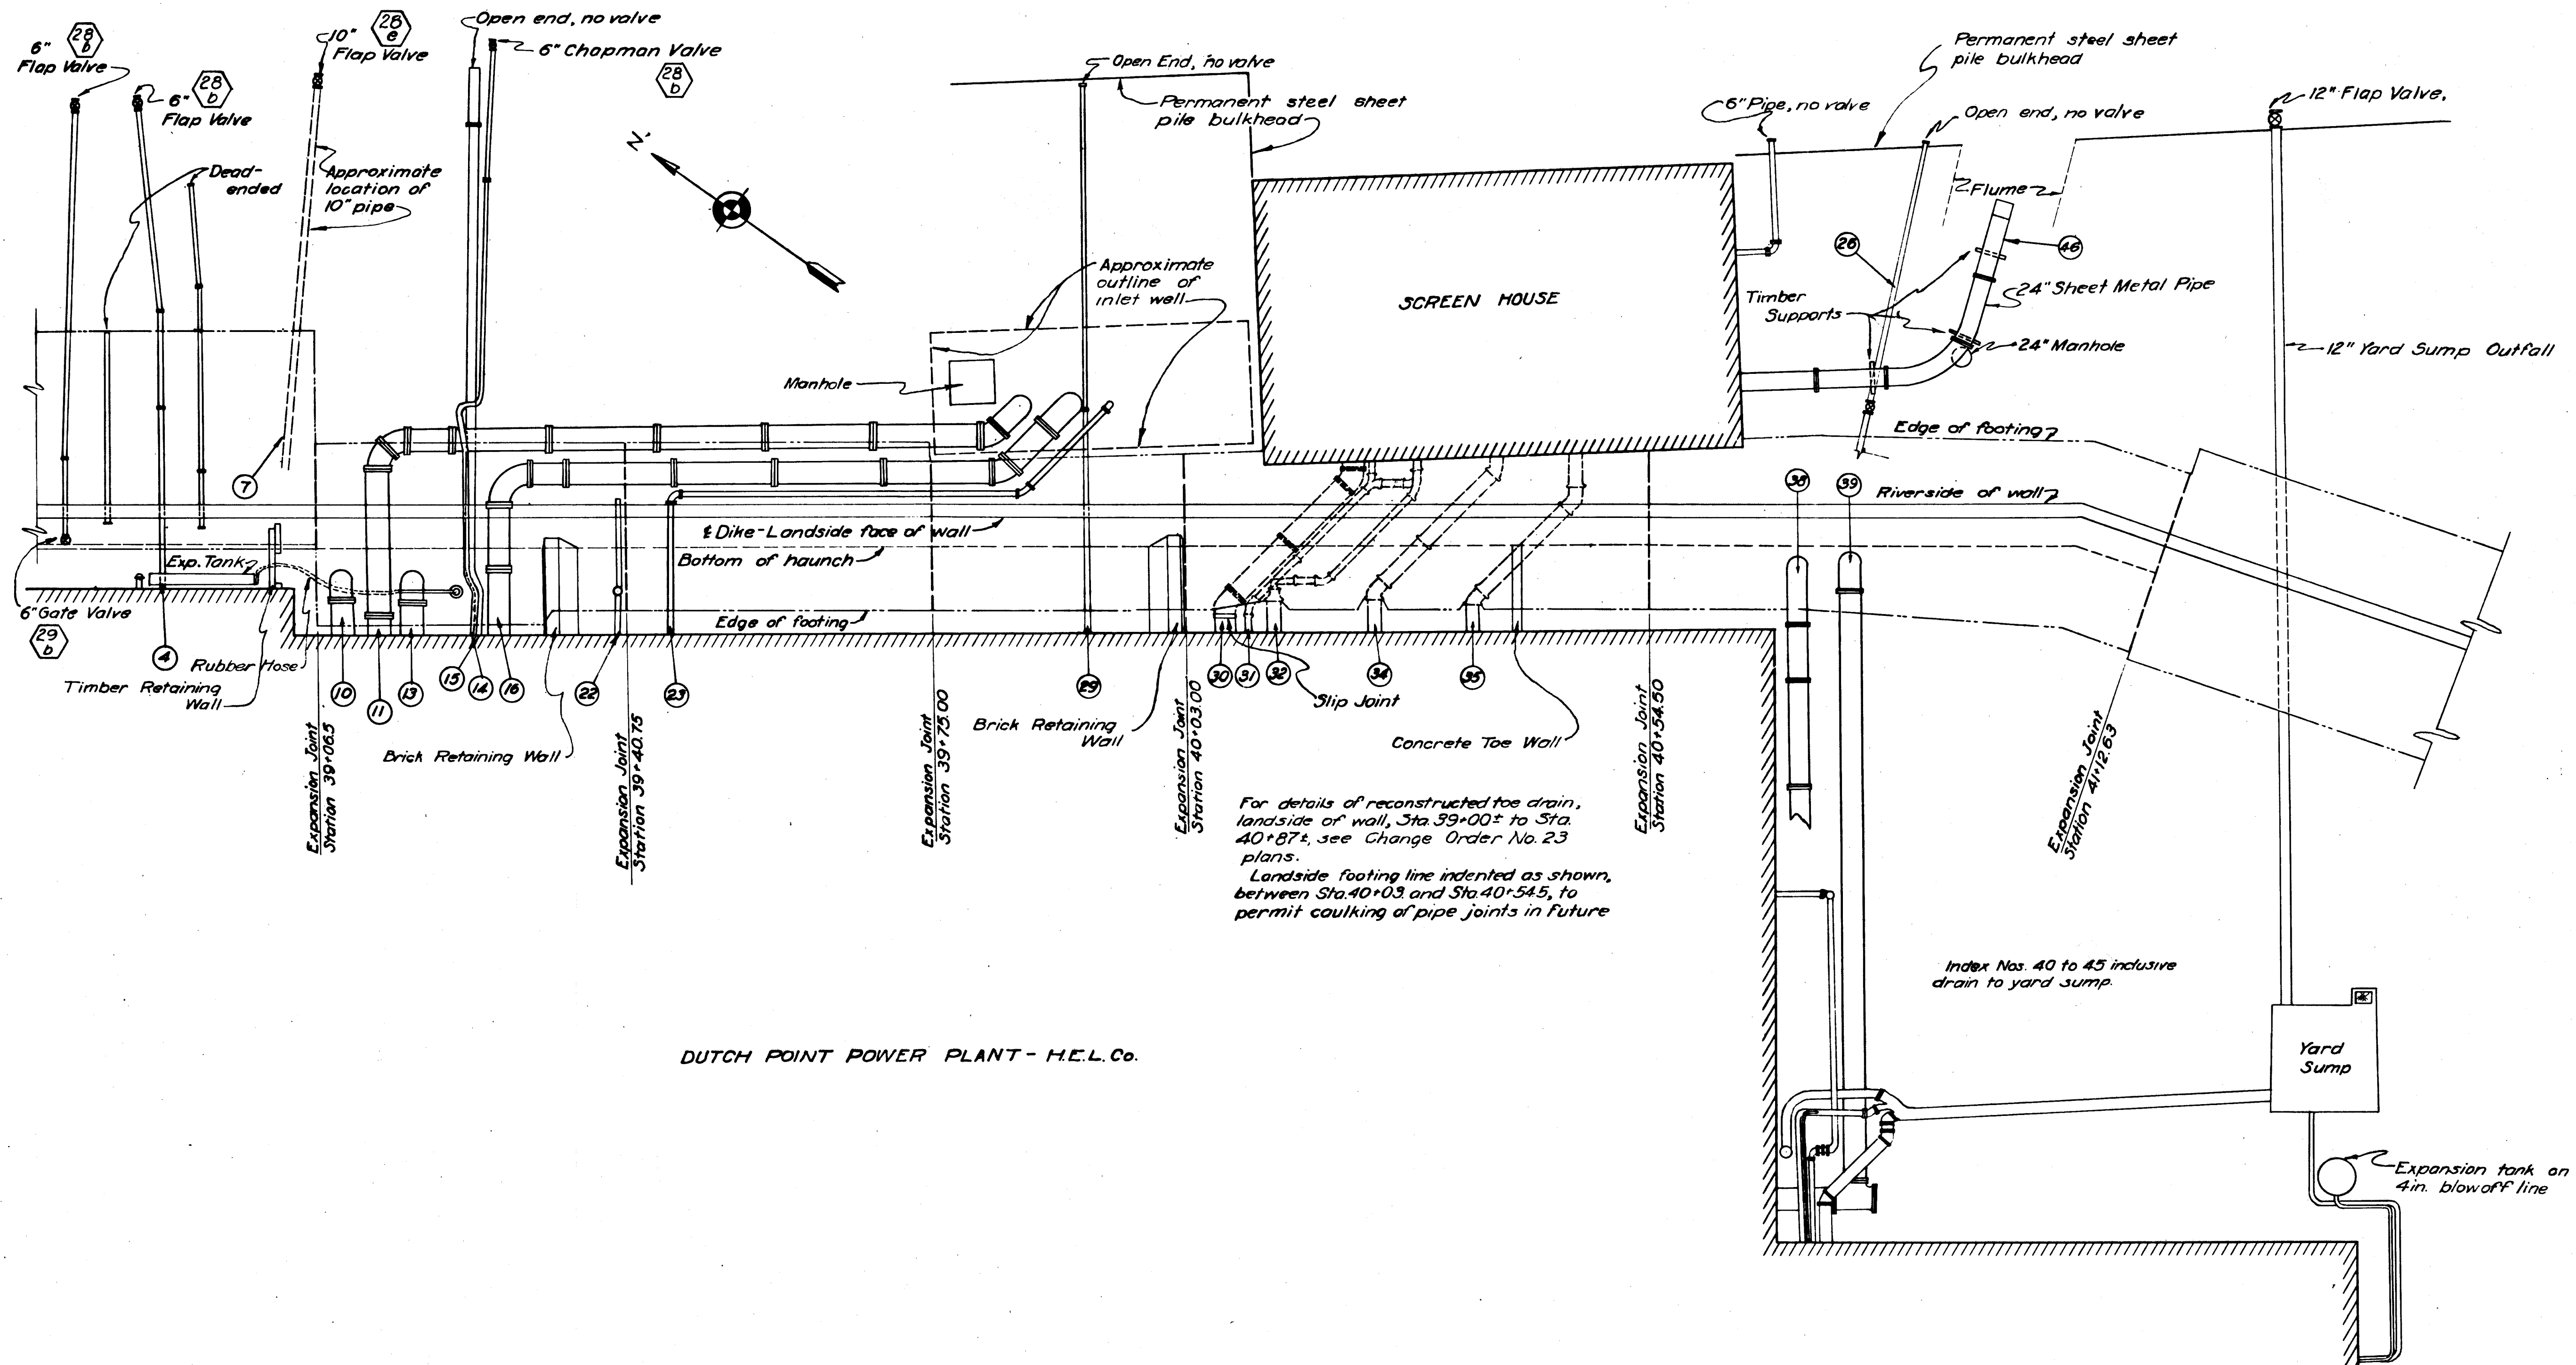

DUTCH POINT POWER PLANT - H.E.L. Co.

PLAN
Scale: 1"=10'

NOTES

Piping layout changed at the request of the Hartford Electric Light Co. All open end pipes shown are controlled by valves inside the station. For index and profile, see Sheet No. 42 B

KEY	DATE	REVISION	REV. BY	CK. BY	AP. BY
	12-31-45	As built revisions			

THIS SHEET ADDED TO SET

CONNECTICUT RIVER FLOOD CONTROL
HARTFORD DIKE
RIVERFRONT, MORGAN ST. TO STA. 97+05
DETAIL PLAN-DUTCH PT. STATION

CONNECTICUT RIVER	CONNECTICUT
IN 137 SHEETS	SCALE: 1"=10' FT. SHEET NO. 43A
U.S. ENGINEER OFFICE	PROVIDENCE, R.I. DATE: FEB. 1943
SUBMITTED: J.C. Dwyer	APPROVAL: J.B. Burns
SENIOR ENGINEER	PRINCIPAL ENGINEER
HEAD, DESIGN SECTION	CHIEF, ENGINEERING DIV.
PREPARED: J.B. Burns	DRAWN BY: J.B. Burns
RESIDENT ENG'R	CHECKED BY: E.R.C.
	FILE NO. CT-4-3146