


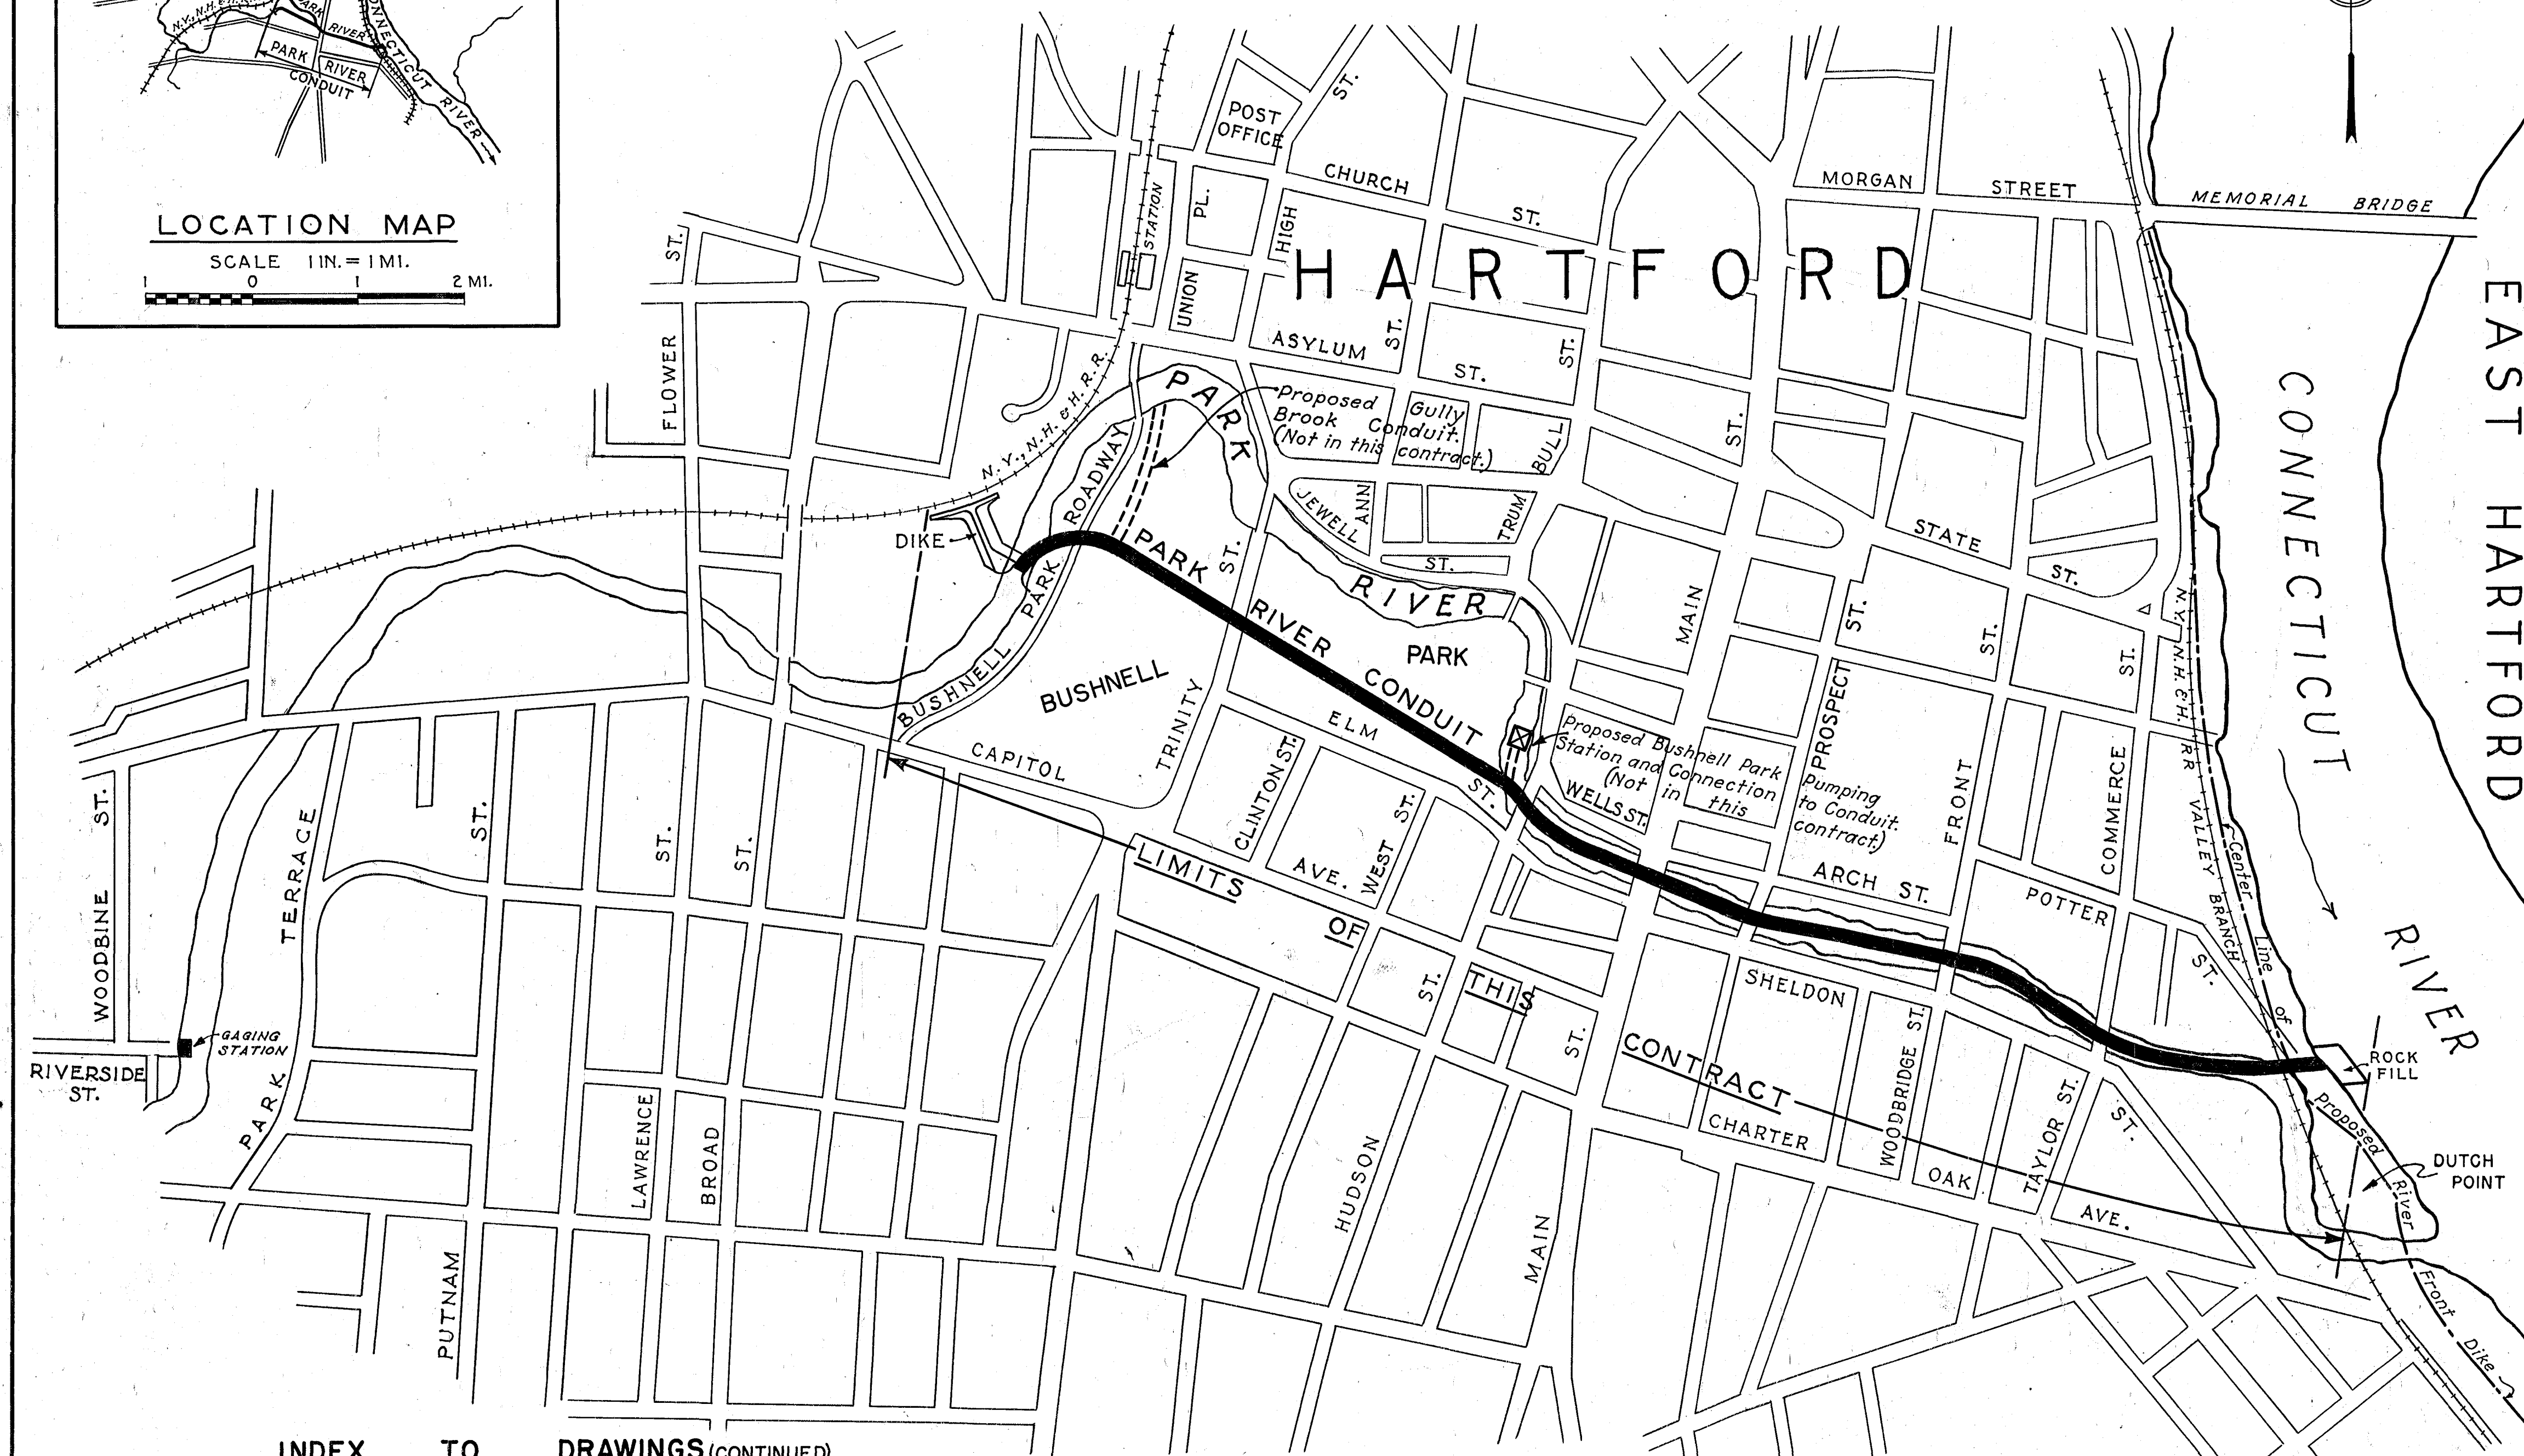

SHEET NO.	DESCRIPTION	FILE NO.
1	PROJECT LOCATION AND INDEX	CT-4-2606
2	HYDROGRAPH NO.1, CONNECTICUT RIVER	CT-3-1174
3	HYDROGRAPH NO.2, CONNECTICUT RIVER	CT-3-1175
4	HYDROGRAPH PARK RIVER	CT-3-1173
5	SUBSURFACE EXPLORATIONS NO. 1	CT-2-1286
6	SUBSURFACE EXPLORATIONS NO. 2	CT-2-1287
7	SUBSURFACE EXPLORATIONS NO. 3	CT-2-1288
8	SUBSURFACE EXPLORATIONS NO. 4	CT-2-1289
9	CONTRACTOR'S WORK AREAS	CT-4-2607
10	PLAN AND PROFILE NO. 1	CT-4-2608
11	PLAN AND PROFILE NO. 2	CT-4-2609
12	PLAN AND PROFILE NO. 3	CT-4-2610
13	PLAN AND PROFILE NO. 4	CT-4-2611
14	PLAN AND PROFILE NO. 5	CT-4-2612
15	PLAN AND PROFILE NO. 6	CT-4-2613
16	CONDUIT SECTIONS NO. 1	CT-4-2614
17	CONDUIT SECTIONS NO. 2	CT-4-2615
18	PILING NO. 1	CT-4-2616
19	PILING NO. 2	CT-4-2617
20	PARK RIVER INTERCEPTOR SIPHON DETAILS NO. 1	CT-4-2618
21	PARK RIVER INTERCEPTOR SIPHON DETAILS NO. 2	CT-4-2619
22	SIPHON INLET CHAMBER DETAILS	CT-4-2620
23	SIPHON INLET CHAMBER STEEL REINFORCEMENT	CT-4-2621
24	SIPHON OUTLET CHAMBER DETAILS	CT-4-2622
25	SIPHON OUTLET CHAMBER STEEL REINFORCEMENT	CT-4-2623
26	INLET STRUCTURE WALLS	CT-4-3040
27	INLET STRUCTURE WALL REINFORCEMENT NO. 1	CT-4-2625
28	INLET STRUCTURE WALL ELEVATIONS	CT-4-2626
29	MISCELLANEOUS INLET DETAILS	CT-4-2627
30	OUTLET STRUCTURE DETAILS NO. 1	CT-4-2628
31	OUTLET STRUCTURE DETAILS NO. 2	CT-4-2629
32	OUTLET STRUCTURE STEEL REINFORCEMENT NO. 1	CT-4-2630
33	OUTLET STRUCTURE STEEL REINFORCEMENT NO. 2	CT-4-2631
34	CONNECTICUT RIVER INTERCEPTOR AND HUDSON ST. SIPHONS	CT-4-2632
35	DRAIN CHAMBERS	CT-4-2633
36	DRAIN MANHOLES AND CATCHBASINS	CT-4-2634
37	SEWER CONNECTIONS NO. 1	CT-4-2635
38	SEWER CONNECTIONS NO. 2	CT-4-2636
39	MISCELLANEOUS DETAILS	CT-4-2637
40	TEMPORARY WATER LINE TO THE DUTCH POINT LIGHTING PLANT	CT-4-2706
19A	PILING NO. 3 (NOT IN CONTRACT)	CT-4-3045
41	GULLY BROOK CONNECTION AND TRANSITION	CT-4-3067
42	TILE STAFF GAGES	CT-4-3122
43	CONDUIT SECTIONS 1A	CT-4-3138
44	CONDUIT SECTIONS 2A	CT-4-3139
45	BUSHNELL PARK CONNECTIONS	CT-4-3141
46	TEMPORARY FLOOD PROTECTION AT PROSPECT ST.	CT-4-3142

INDEX TO DRAWINGS (CONTINUED)

<u>SHEET NO.</u>	<u>DESCRIPTION</u>	<u>FILE NO.</u>
47	TEMPORARY SHEET PILING BULKHEAD AT PROSPECT ST.- PLAN AND SECTION	CT - 4 - 3143
48	TEMPORARY SHEET PILING BULKHEAD AT PROSPECT ST.- DETAILS	CT - 4 - 3144

SCALE 1 IN. = 400 FT.

METCALF & EDDY
ENGINEERS
BOSTON, MASS.

RECORD
DRAWINGS

	12-31-45	As built.			
Ⓐ	11-17-43	<i>Sheets Nos. 10, 11, 12, 13, 34, 37 & 38 revised.</i>	B.S.	C.M.R.	J.H.
Ⓐ	3/13/43	<i>Sheets Nos. 47 and 48 added</i>	E.D.C.	J.S.	J.H.
Ⓐ	9/12/42	<i>Sheet No. 46 added</i>	E.D.C.	J.H.	J.H.
Ⓐ	4/22/42	<i>Sheet No. 42 added</i>	E.D.C.	J.H.	J.H.
Ⓐ	8/30/41	<i>Sheet No. 41 added</i>	E.P.C.	J.H.	J.H.
Ⓐ	7-10-41	<i>File No. changed</i>	F.T.C.	J.H.	J.H.
Ⓐ	10-7-40	<i>Sheet No. 40 added</i>	R.C.H.	J.H.	J.H.
KEY	DATE	REVISION (Indicated by Δ)		REV. BY	CK. BY

CONNECTICUT RIVER FLOOD CONTROL
PARK RIVER CONDUIT
HARTFORD, CONN.
PROJECT LOCATION AND INDEX

CONNECTICUT RIVER		CONNECTICUT	
100' 0"	SCALE 1 IN. = 400 FT.	1000'	SHEET NO. 1
U.S. ENGINEER OFFICE PROVIDENCE, R.I.		MAY 1940	
REVIEWED: <i>W. H. Hanna</i> LEADING ENGINEER F.C. DESIGN SECTION	APPROVAL RECOMMENDED: <i>W. H. Hanna</i> PRINCIPAL ENGINEER CHIEF F.C. ENGINEERING DIV.	APPROVED: <i>W. H. Hanna</i> DISTRICT ENGINEER DISTRICT NO. 1	
SUBMITTED: <i>Arthur C. How</i> METCALF & EDDY BOSTON, MASS.	(PARTNER)	FILE NO. CT-4-2606 DRAWN BY: E.S.B. CHECKED BY: E.S.B. TRACED BY: R.W.T.	

12-31-45 AS BUILT: