
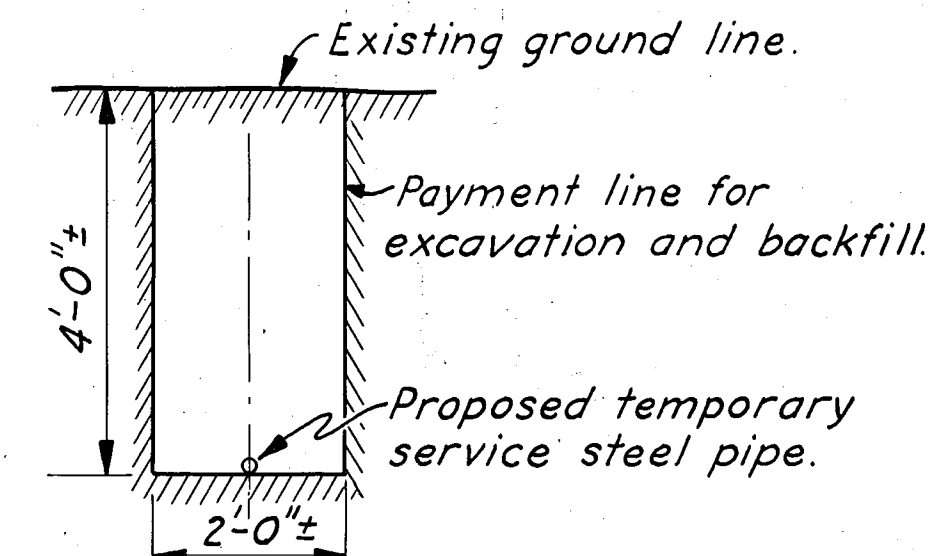


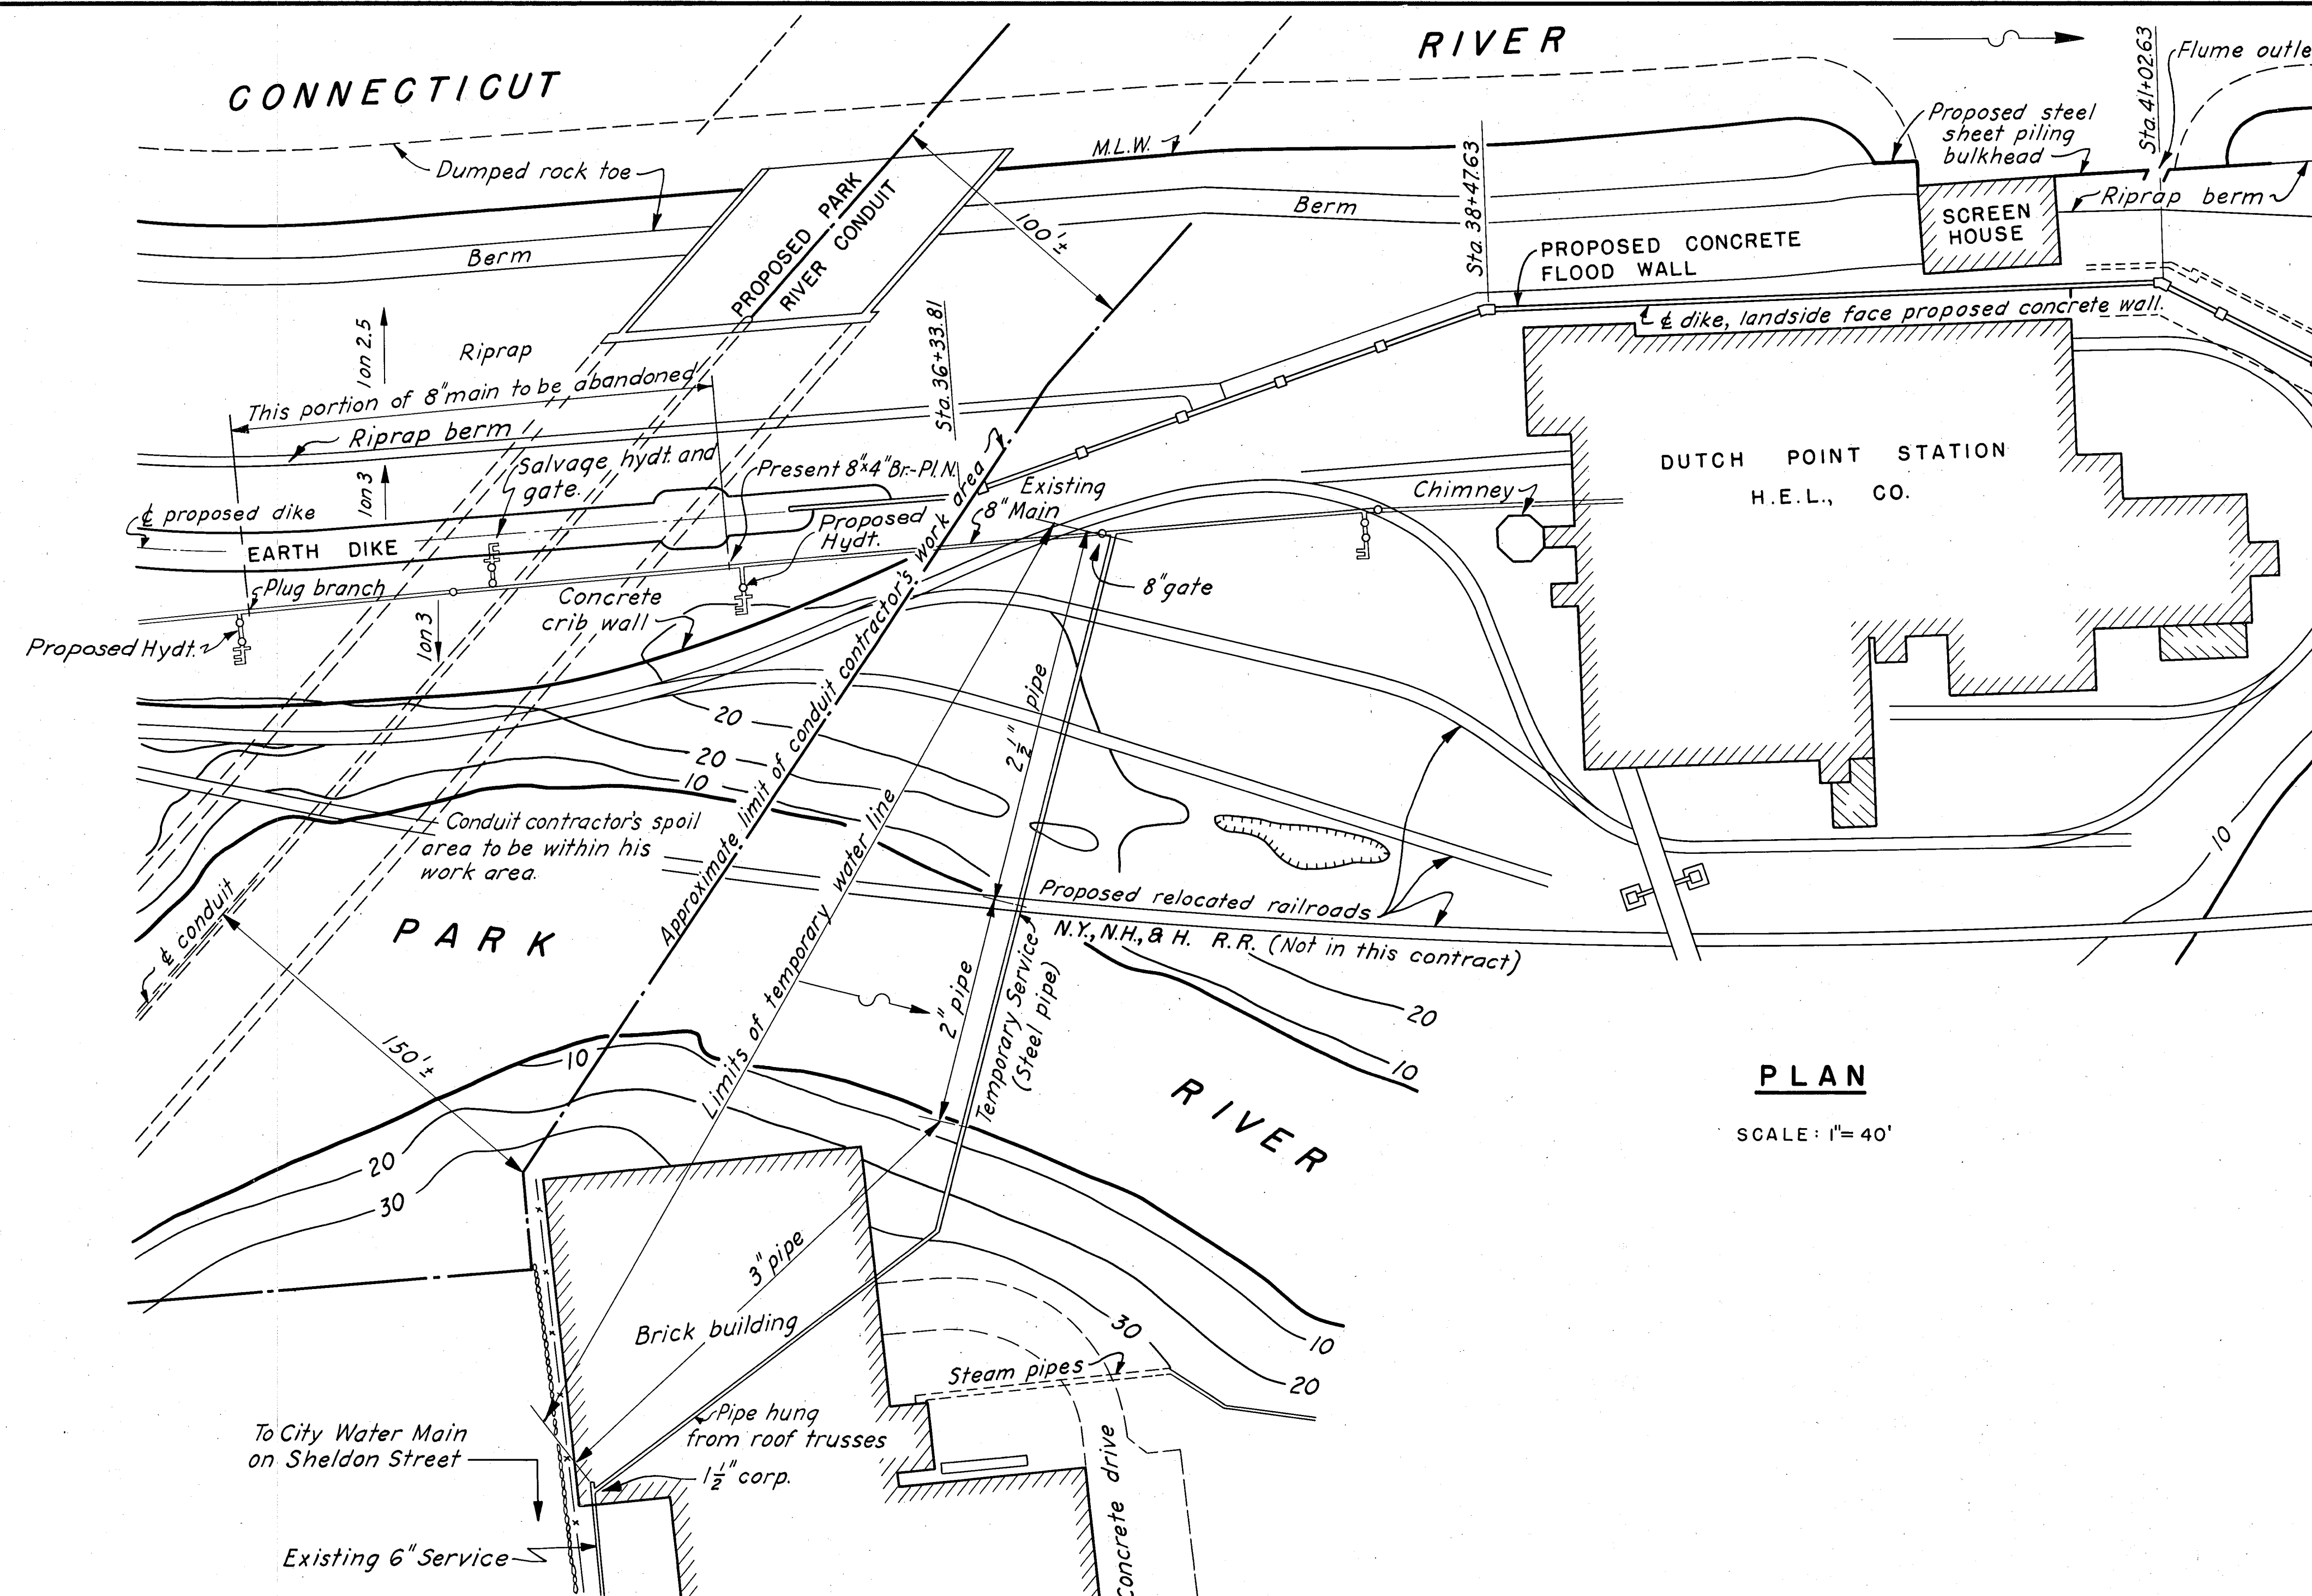


SCALE: 1" = 1'-0"

0 1' 2' 3' 4' 5'

NOTES

- Elevations refer to Mean Sea Level Datum.
- Payment for furnishing and installing temporary water line will be made under Item No. 32.
- Existing 8" main to be cut and plugged by others. Hydrants to be installed by others.

RECORD
DRAWINGS

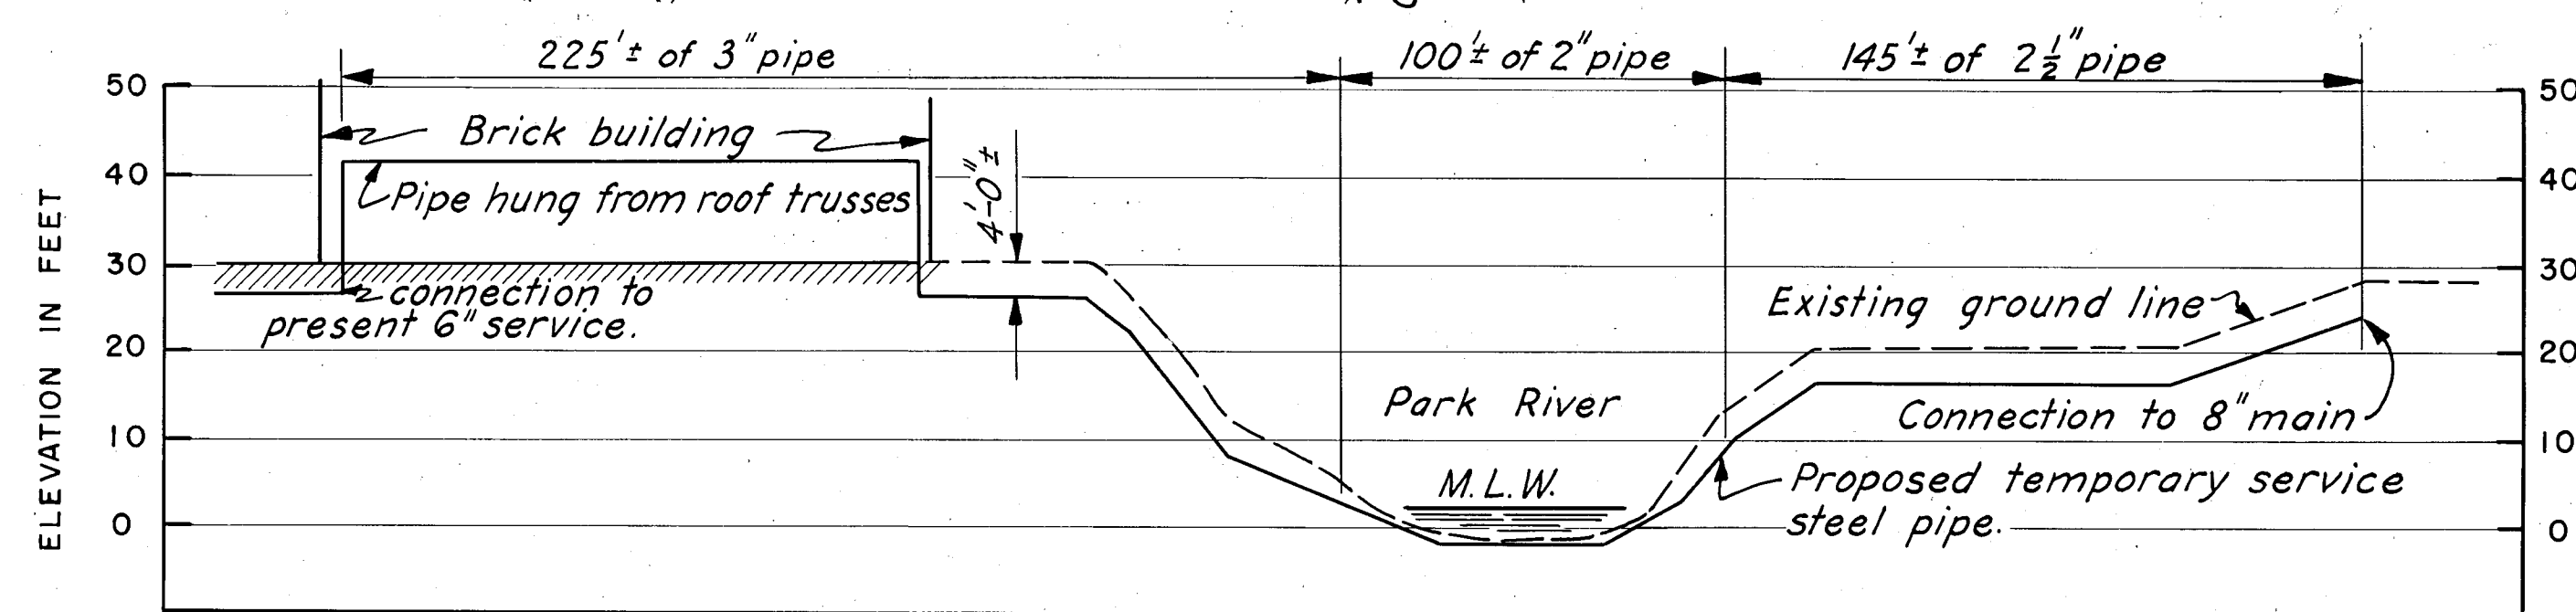

KEY	DATE	REVISION (Indicated by Δ)	REV. BY	CK. BY	AP. BY
	12-31-45	As built			

CONNECTICUT RIVER FLOOD CONTROL		
PARK RIVER CONDUIT		
HARTFORD, CONN.		
TEMPORARY WATER LINE TO THE DUTCH POINT LIGHTING PLANT		
CONNECTICUT RIVER	CONNECTICUT	
IN 48 SHEETS	SCALE: 1 IN. = 40 FT.	SHEET NO. 40
U.S. ENGINEER OFFICE, PROVIDENCE, R.I., OCT., 1940		
SUBMITTED:	APPROVAL RECOMMENDED:	APPROVED:
SENIOR ENGINEER	CHIEF, E.C. ENGINEERING DIV.	DISTRICT ENGINEER
DESIGNED:	DRAWN:	FILE NO. CT-4-2706
ASST. ENGINEER	C.M.A.	