

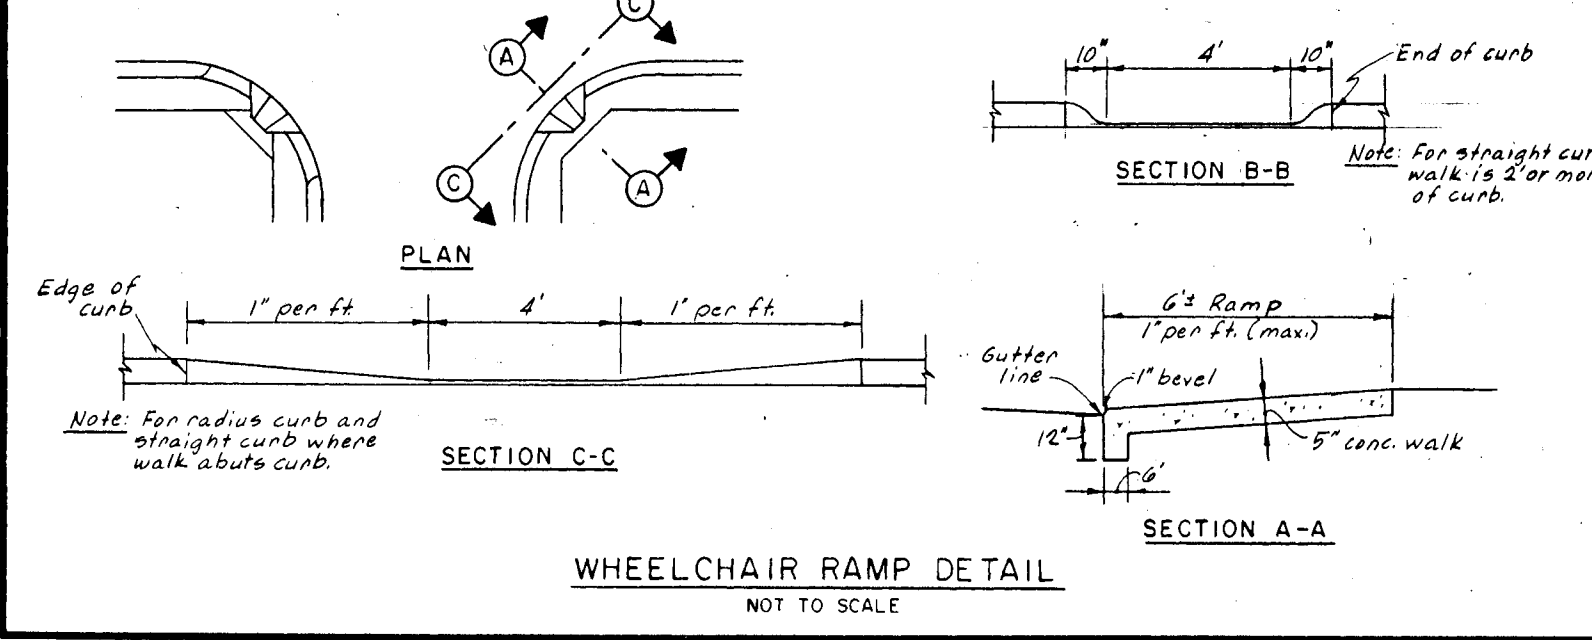
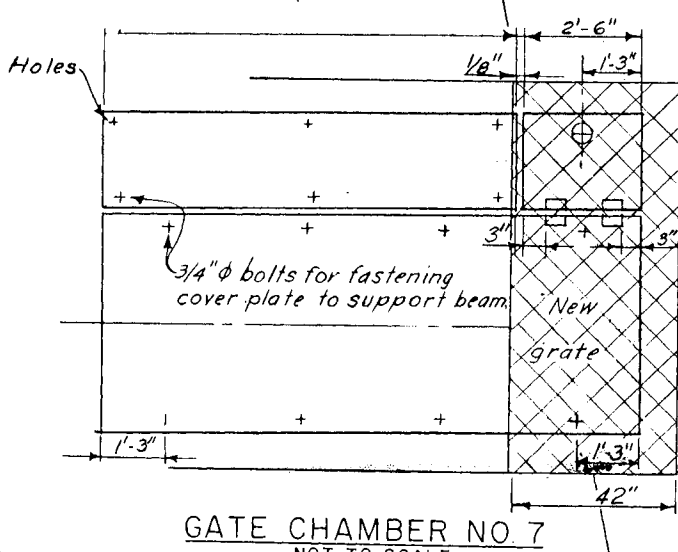
 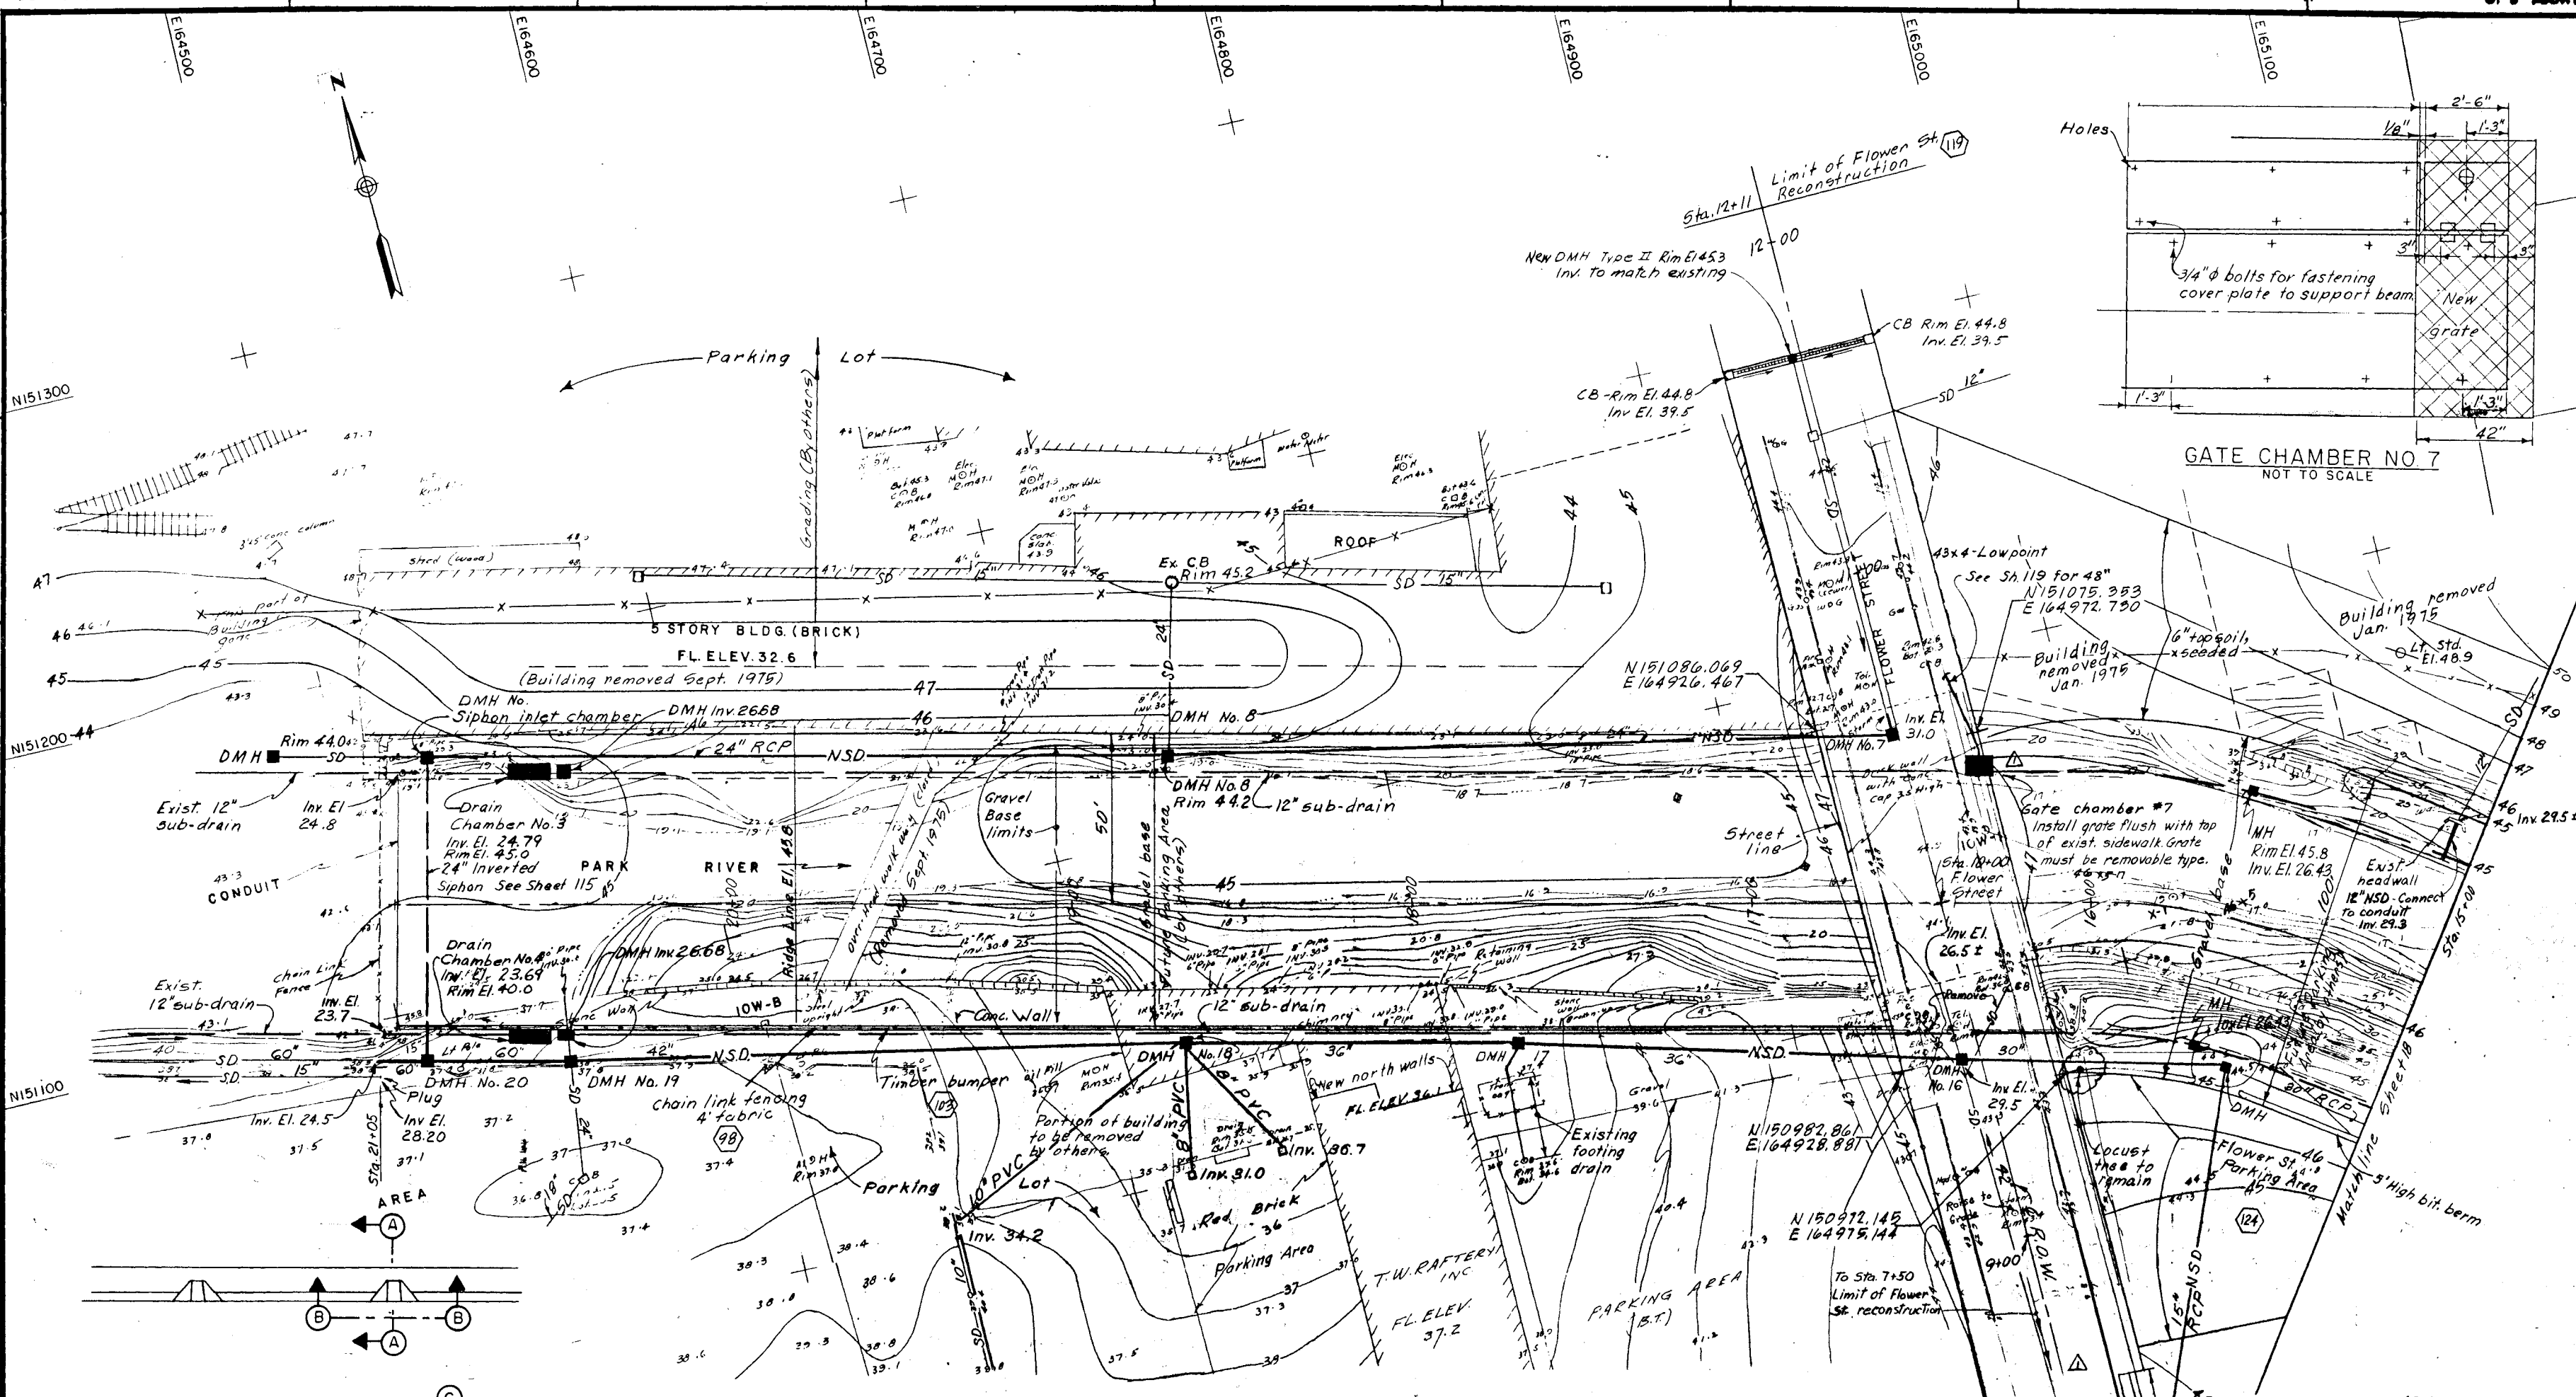


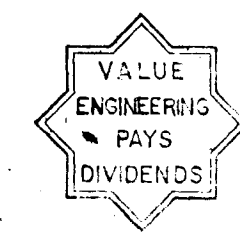

PLAN
SCALE: 1" = 20'

As Built Drawing
Contract No. DACW 33-76-C-0098

NOTES:
1. For details of wall and timber bumper see Sheet 21.



4-4-83 Final field corrections		
REVISION	DATE	DESCRIPTION
1	6 MAR 1976	Drainage layout revised (Am. No. 8)
DEPARTMENT OF THE ARMY NEW ENGLAND DIVISION CORPS OF ENGINEERS WALTHAM, MASS.		
WATER RESOURCES DEVELOPMENT PROJECT PARK RIVER LOCAL PROTECTION BOX CONDUIT AT SECTION 2		
GRADING PLAN NO. 2		
DES. BY R.T.C.	DR. BY W.F.	CL. BY R.T.C.
SUBMITTED	APPROVED	REVIEWED
CHIEF, PROJECT	CHIEF, PROJECT	CHIEF, PROJECT
APPROVED	APPROVED	APPROVED
DATE	DATE	DATE
MARCH 1976	MARCH 1976	MARCH 1976
SCALE: 1" = 20' SPEC. NO. DACW33-76-B-0040		
DRAWING NUMBER		
PAR-1		
SHEET 19		