
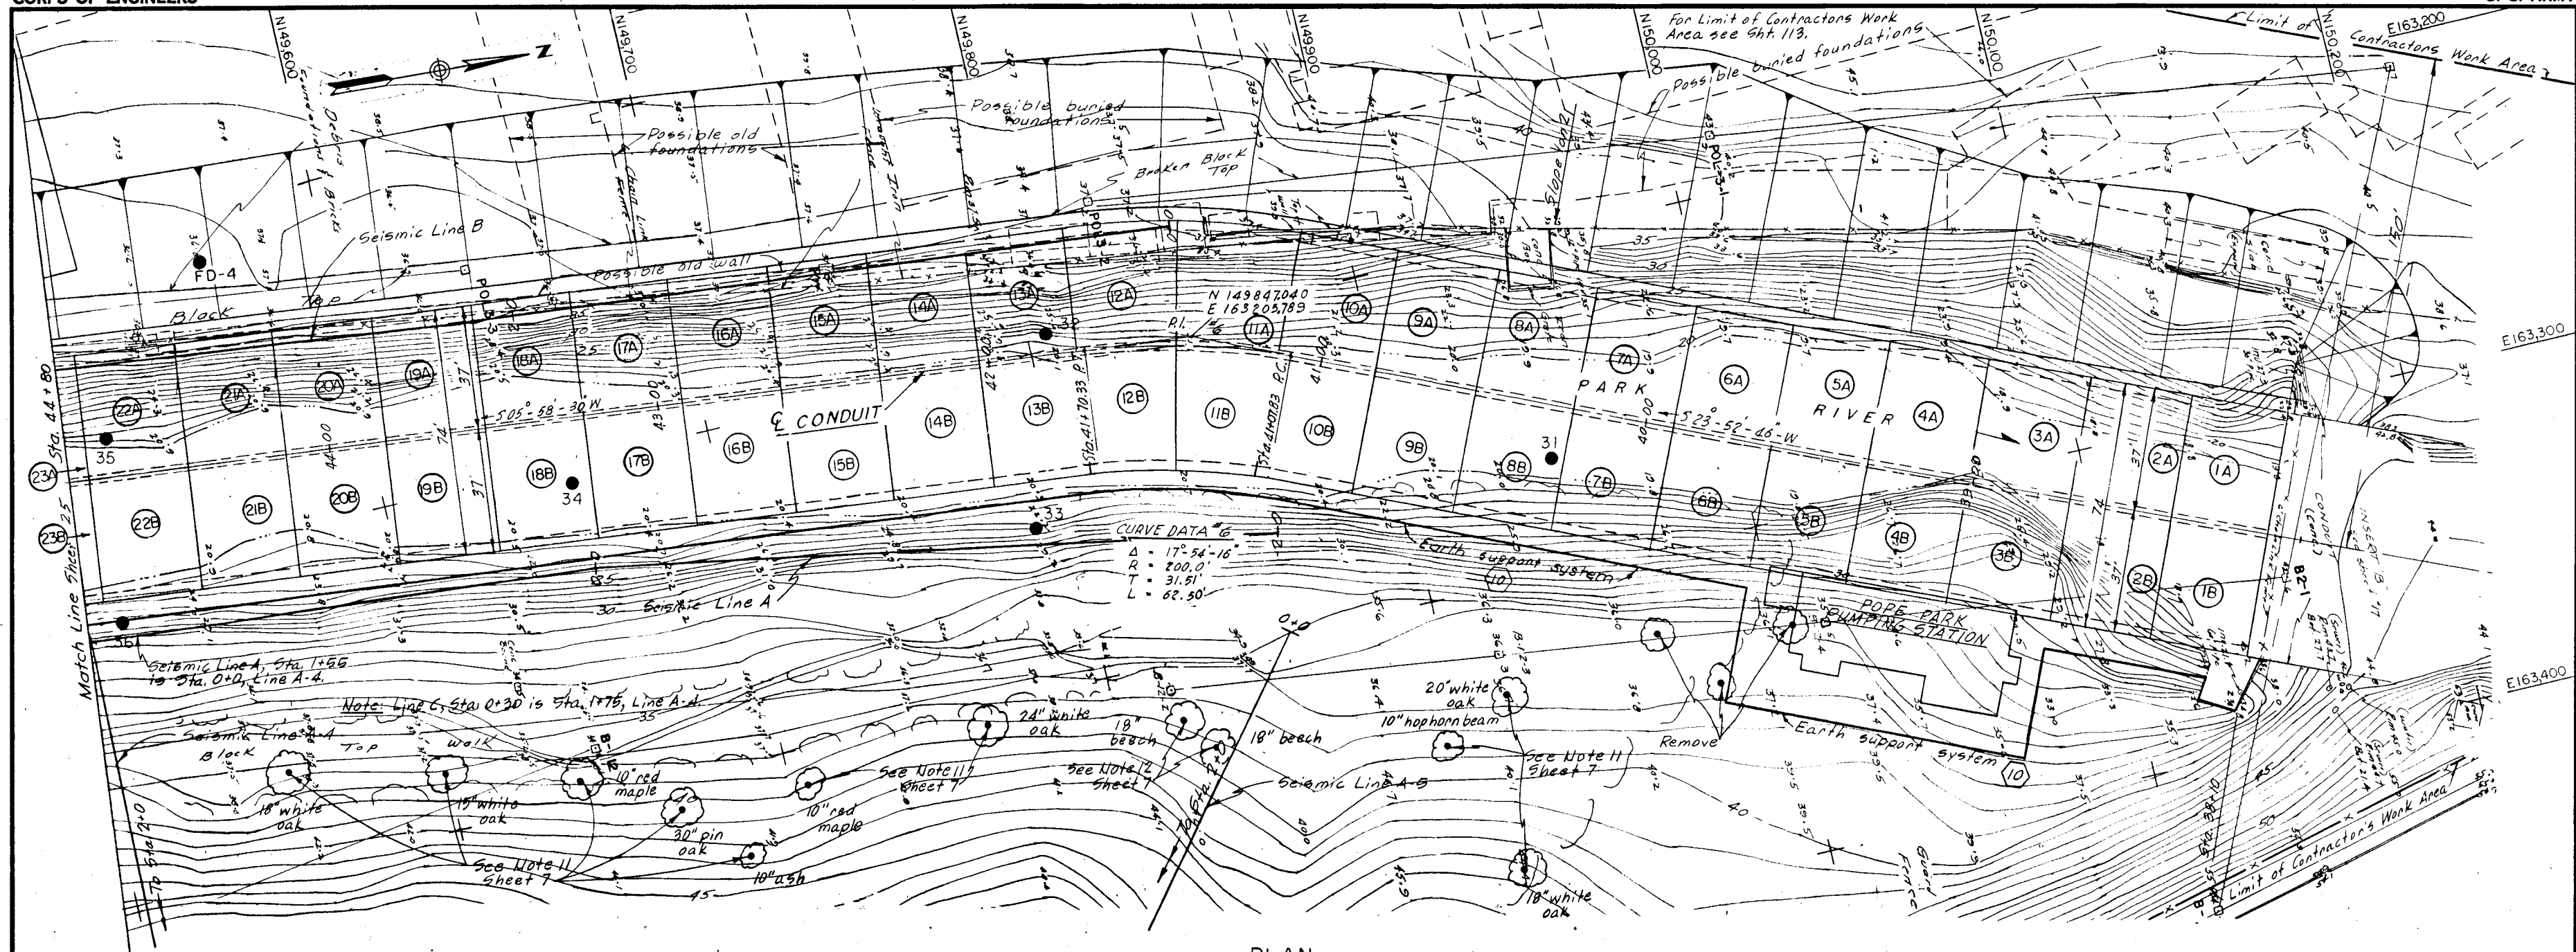


PLAN
SCALE: 1" = 20'

40 @ 30'-0" = 1200'-0"

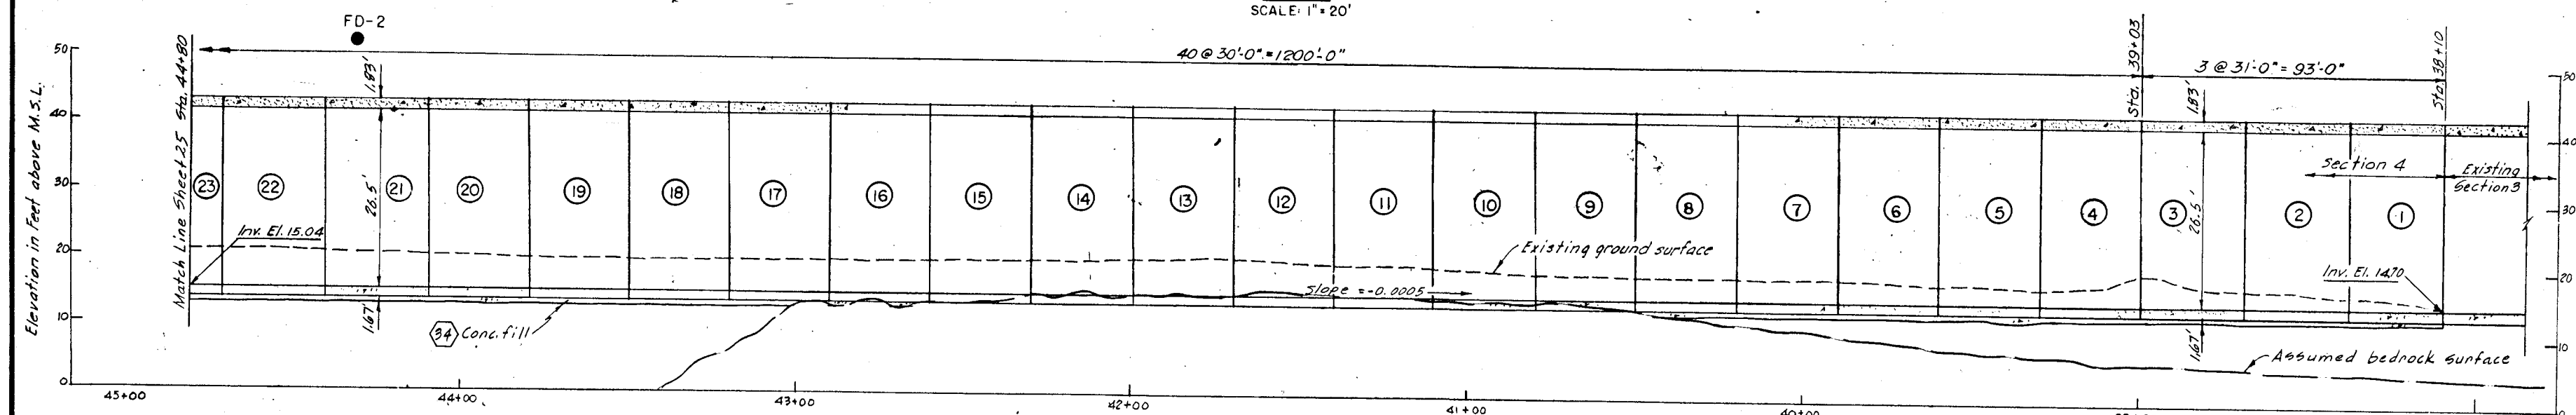

SECTIONAL PROFILE — SECTION 4


SCALE: HOR. 1" = 20'
VERT. 1" = 10'

NOTES:

1. For General Notes see Sheet 2.
2. For Typical Sections see Sheets 26 thru 31.
3. For Division of Water for Section 4 see Sheets 32 and 33.
4. For Typical Division of Water Section see Sheet 112.
5. For Grading Plan see Sheets 34 and 35.
6. For Structural details see Sheet 37.
7. For Joint and Miscellaneous details see Sheet 38.
8. For Limits of Contractor's Work Area see Sheets 113 and 114.
9. For Interpretation of Seismic Survey Lines A, B, & C see Division 2 of the Specifications.
10. For Record of Explorations see Division II of the Specifications.

As Built Drawing

Contract No. DACW 33-76-C-0098

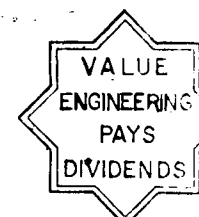

REVISION	DATE	DESCRIPTION	BY

DEPARTMENT OF THE ARMY
NEW ENGLAND DIVISION
CORPS OF ENGINEERS
WALTHAM, MASS.

WATER RESOURCES DEVELOPMENT PROJECT
PARK RIVER LOCAL PROTECTION
BOX CONDUIT AT SECTION 4
PLAN AND PROFILE NO. 1

DES. BY: J.B.M. R.T.C.
SUBMITTED: *[Signature]*
CHIEF, LAYOUT SECTION
APPROVAL/RECOMMENDATION: *[Signature]*
REVIEWED: *[Signature]*
APPROVED: *[Signature]*
CHIEF, PROJECT BRANCH

HARTFORD CONNECTICUT
DATE: MARCH 1976

SCALE: AS SHOWN SPEC. NO. DACW 33-76-B-0040
DRAWING NUMBER
PAR - I

SHEET 24