



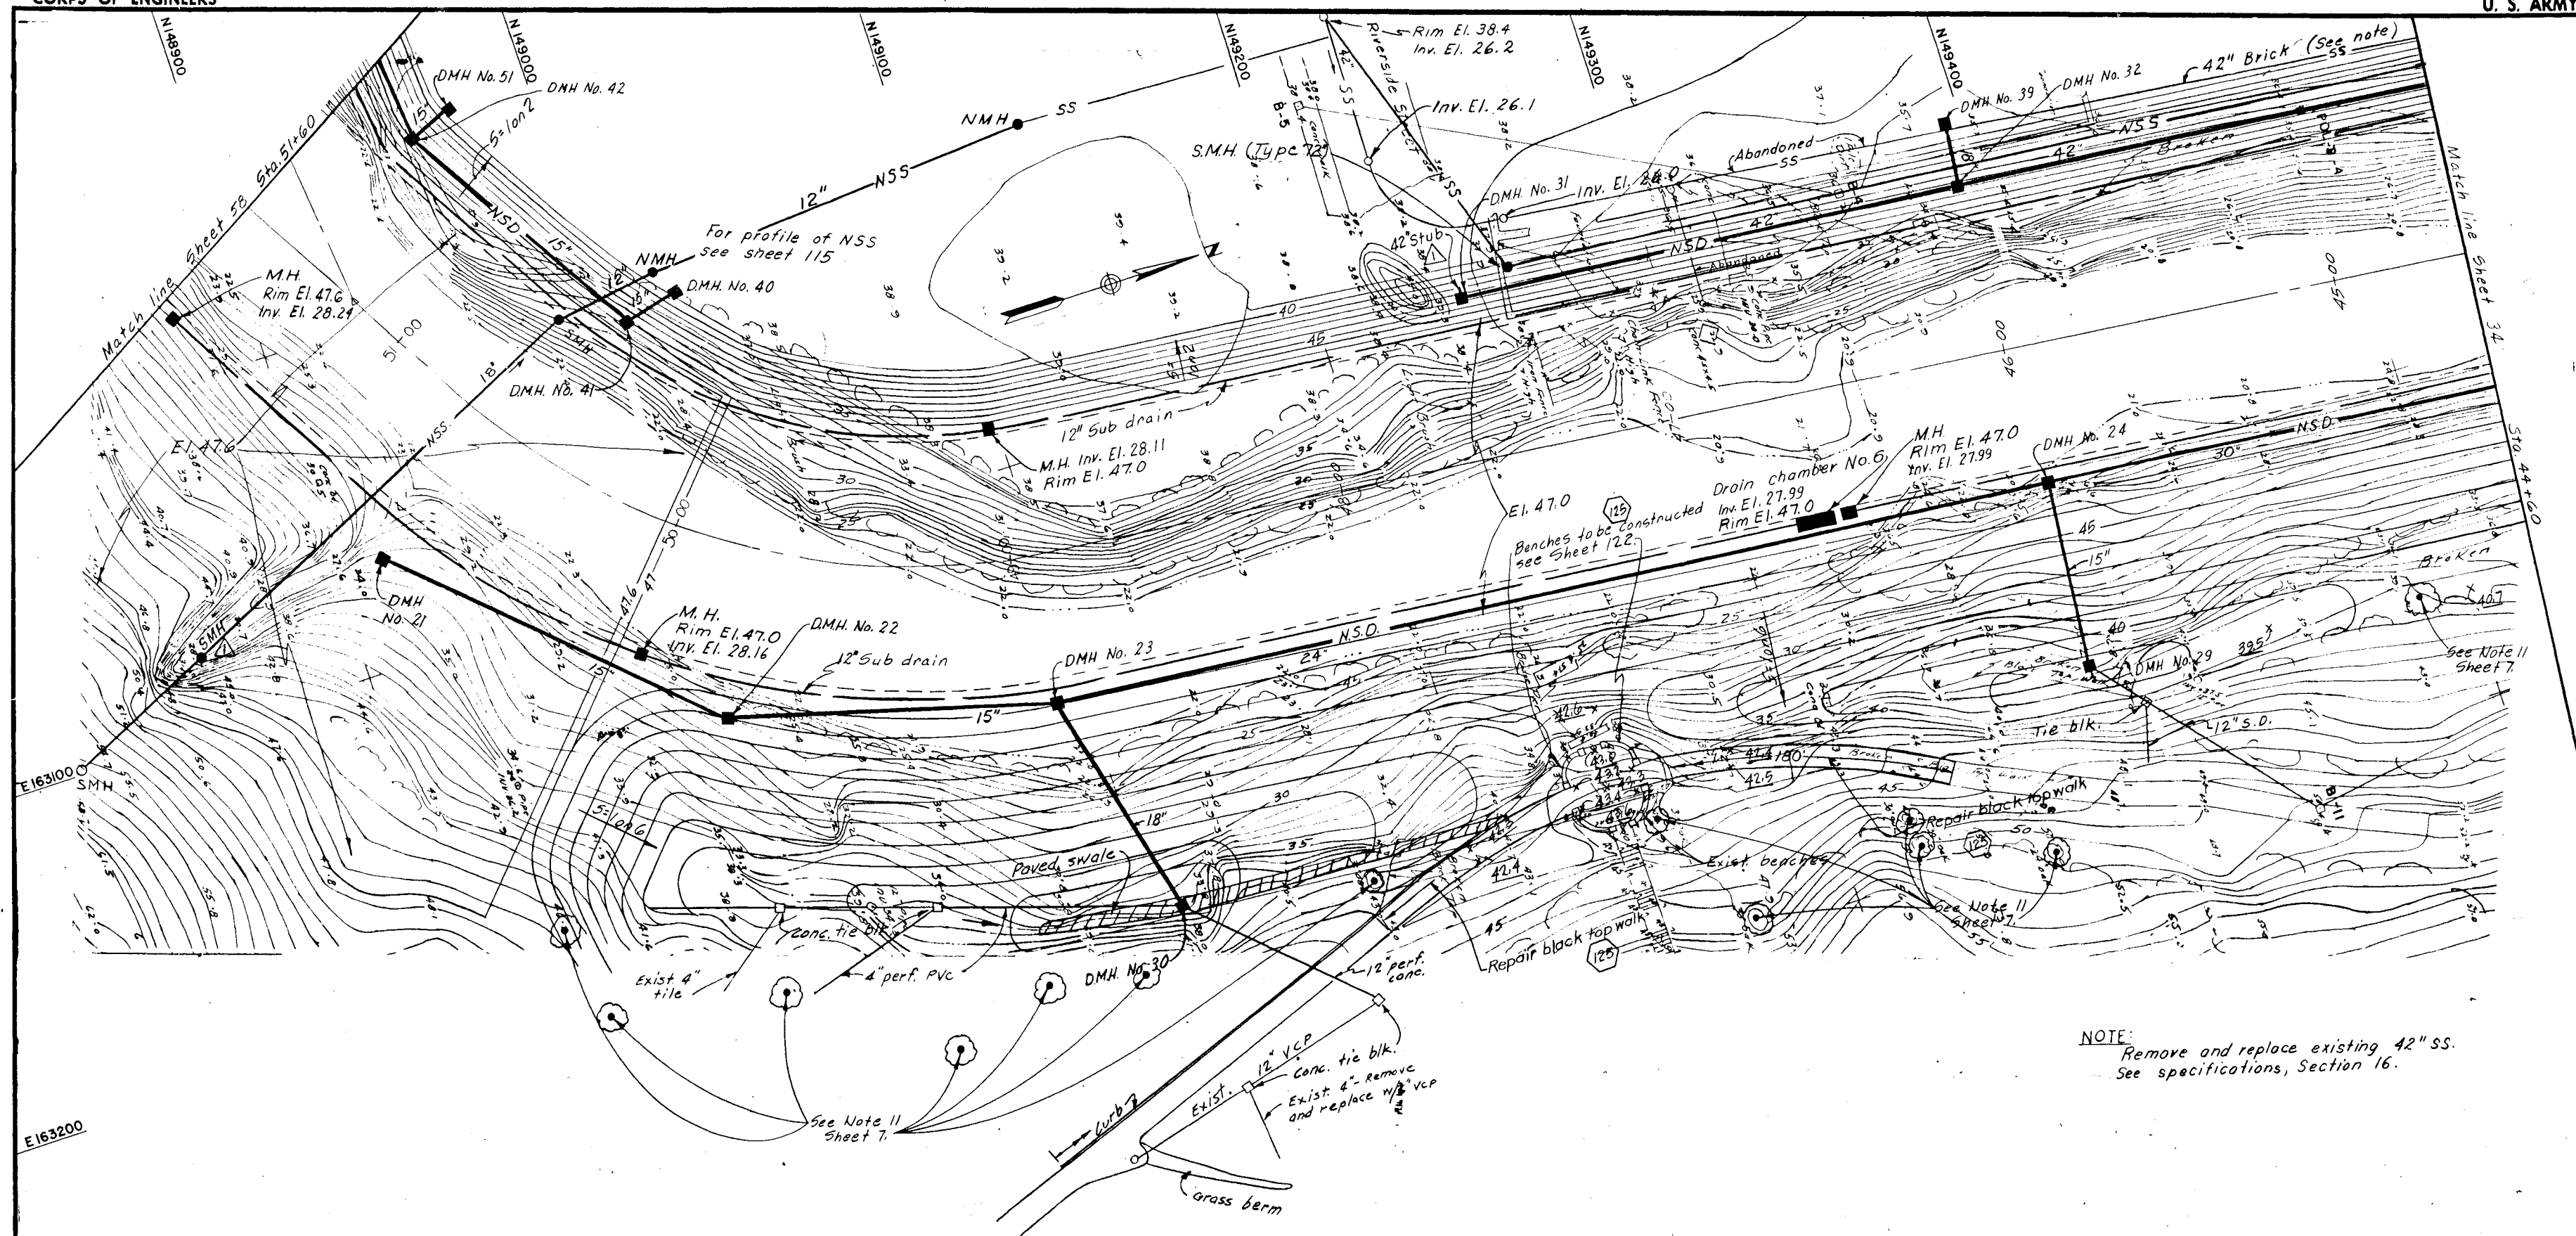

NOTE:
Remove and replace existing 42" SS.
See specifications, Section 16.

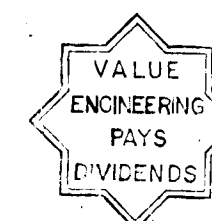

GRAPHIC SCALES
1" = 20' 0' 20' 40'

As Built Drawing

Contract No. DACW 33-76-C-0098

4-4-83 Final field corrections		5 APR 87 SMH and 42" stub added	
REVISION	DATE	DESCRIPTION	BY
DEPARTMENT OF THE ARMY NEW ENGLAND DIVISION CORPS OF ENGINEERS WALTHAM, MASS.			
WATER RESOURCES DEVELOPMENT PROJECT PARK RIVER LOCAL PROTECTION BOX CONDUIT AT SECTION 4 GRADING PLAN NO. 2			
DES. BY R. C. J. B. M. SUBMITTED CHIEF, LAYOUT SECTION APPROVE RECOMMENDOR CHIEF, CIVIL AND BRANCH REVIEWED PROJECT ENGINEER		HARTFORD APPROVED CHIEF, ENGINEERING DIVISION DATE MARCH 1976	
SCALE 1" = 20'		SPEC. NO. DACW33-76-B-0040 DRAWING NUMBER PAR - 1 SHEET 35	