
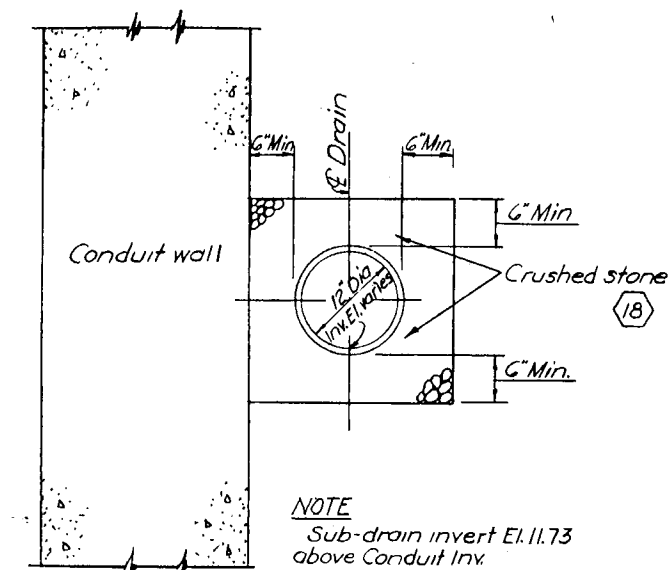
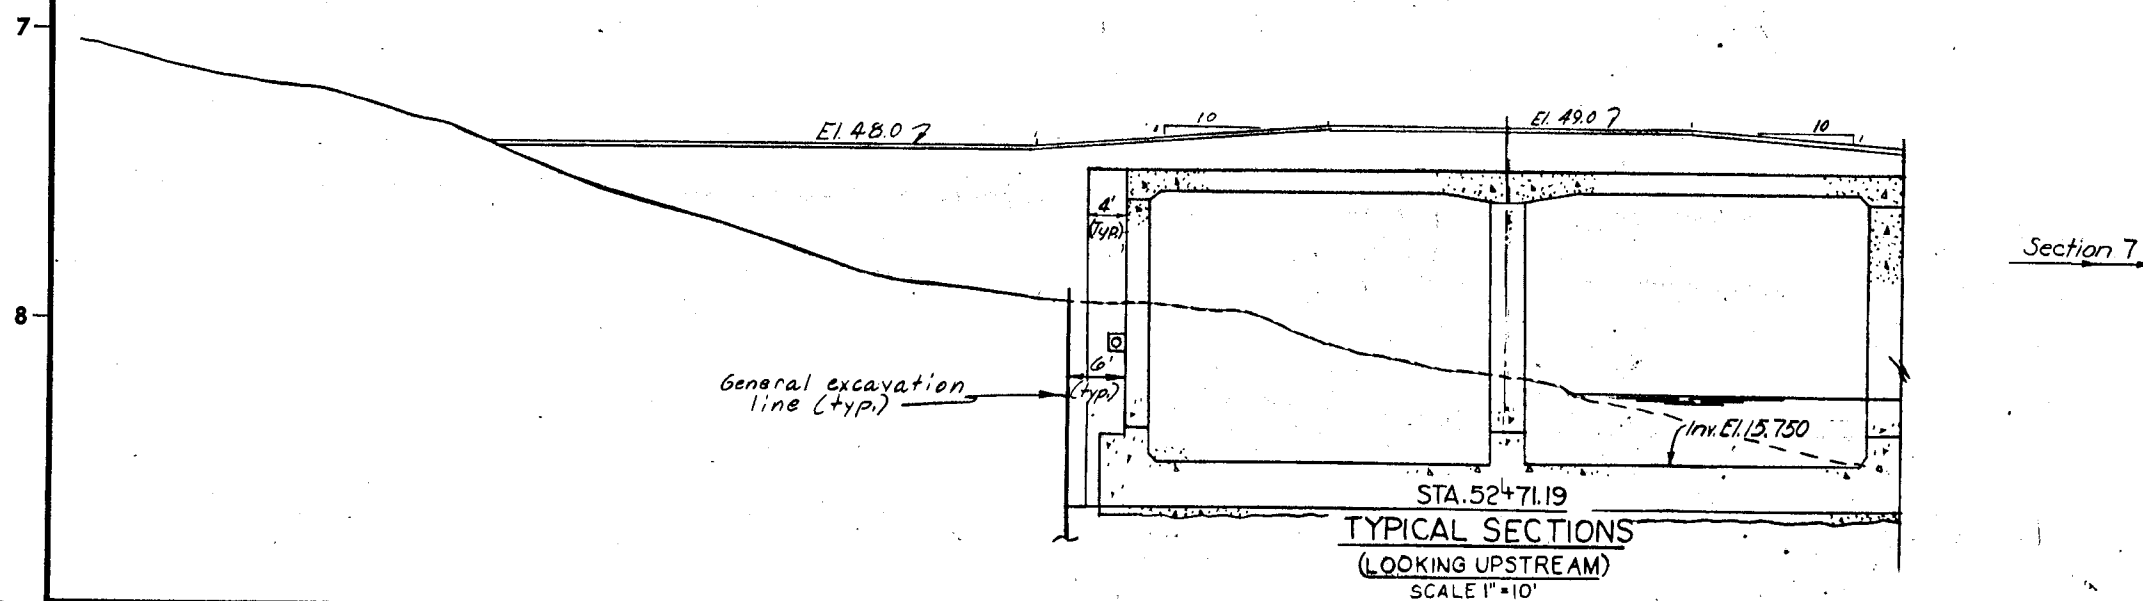
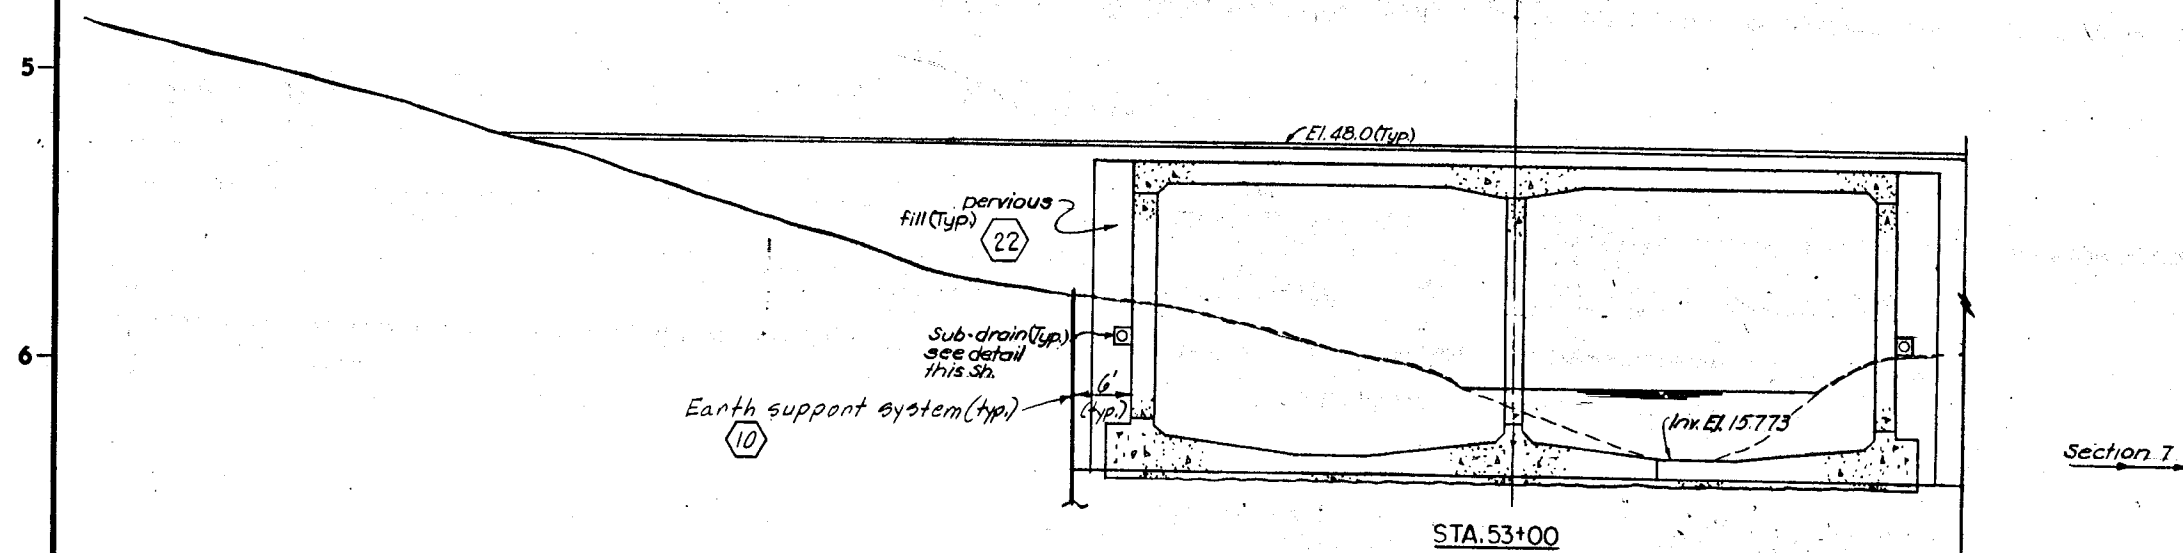
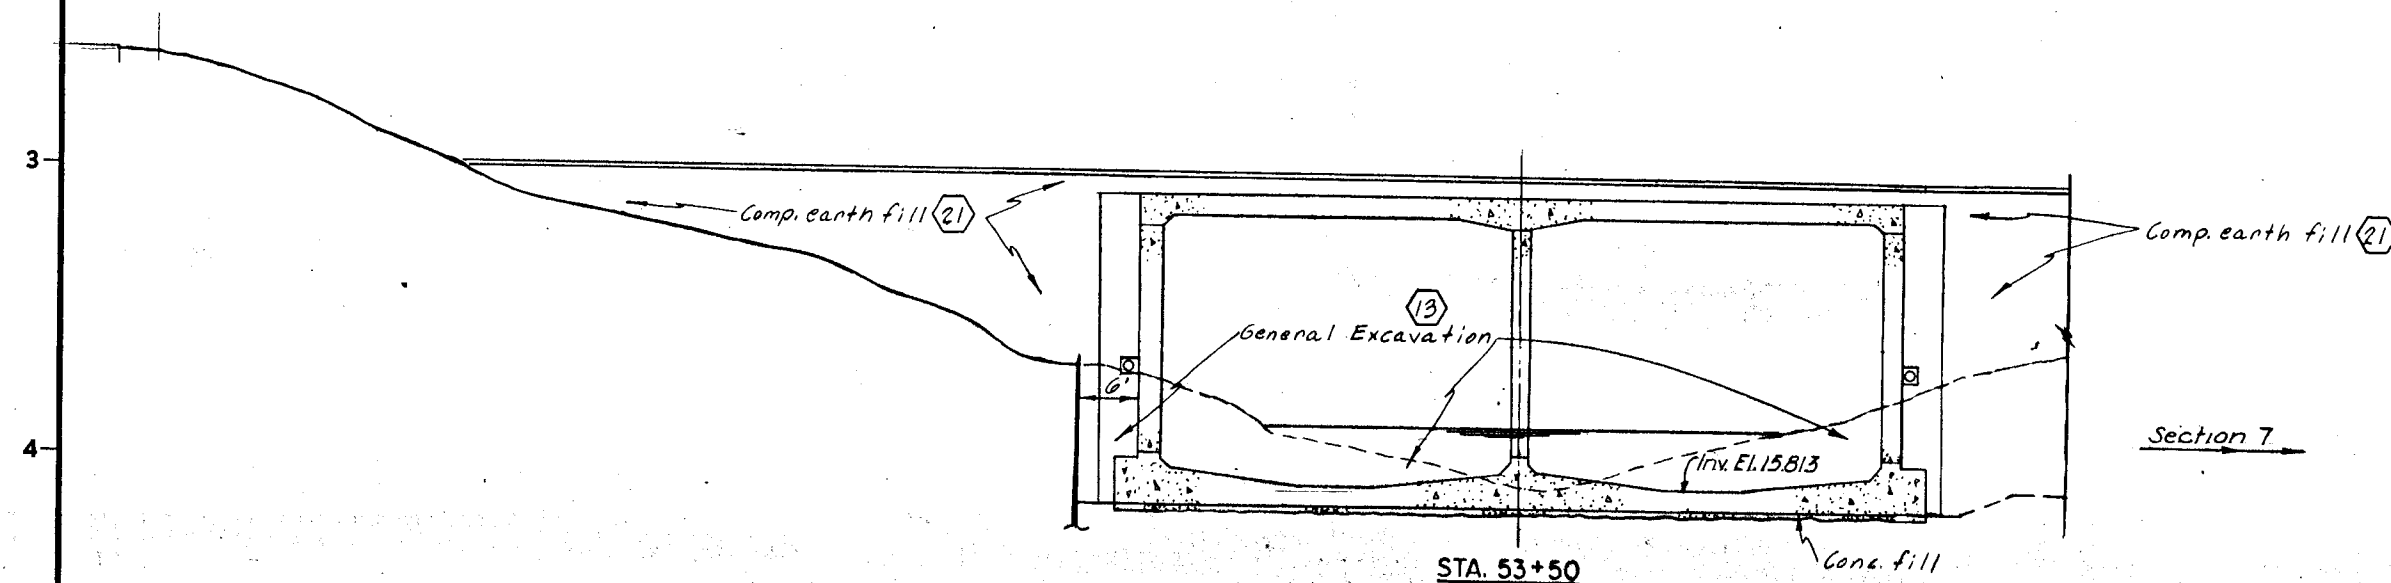


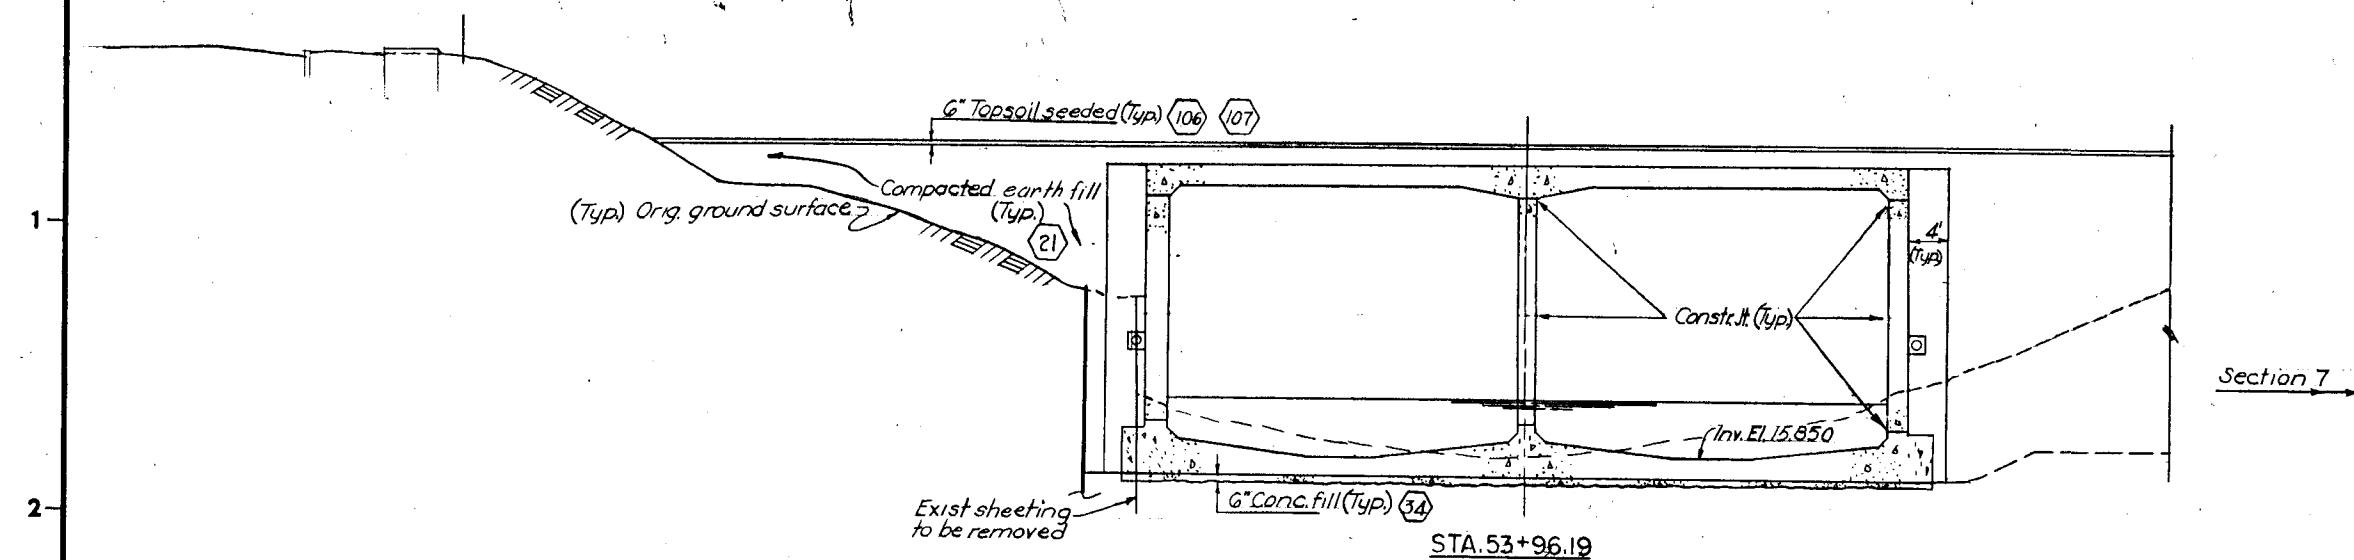

SUB-DRAIN DETAIL
SCALE 1"=10'

NOTES:

1. For general notes see Sh. 2.
2. For plan and profile of section 5 see Sh. 42.
3. For section 5 grading plan see Sh. 58.
4. For Limit of Contractor's Work Area see Sheet 113.
5. Delete horiz. constr. jt. at mid-wall height in conduit wall.


As Built Drawing

Contract No. DACW 33-76-C-0098

As Built Drawing

Contract No. DACW 33-76-C-0098

GRAPHIC SCALES
1"=10' 0' 10' 20'

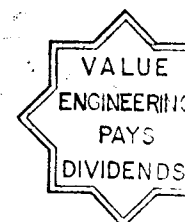

REVISION	DATE	DESCRIPTION	BY
4-4-83		Final Field Corrections	

DEPARTMENT OF THE ARMY
NEW ENGLAND DIVISION
CORPS OF ENGINEERS
WALTHAM, MASS.

WATER RESOURCES DEVELOPMENT PROJECT
PARK RIVER LOCAL PROTECTION
BOX CONDUIT AT SECTION 5
TYPICAL SECTIONS

HARTFORD CONNECTICUT
APPROVED: [Signature] DATE: MARCH 1976
CHIEF, ENGINEERING DIVISION

SCALE: As Shown SPEC. NO. DACW 33-76-B-0040
DRAWING NUMBER
PAR - I SHEET 43