



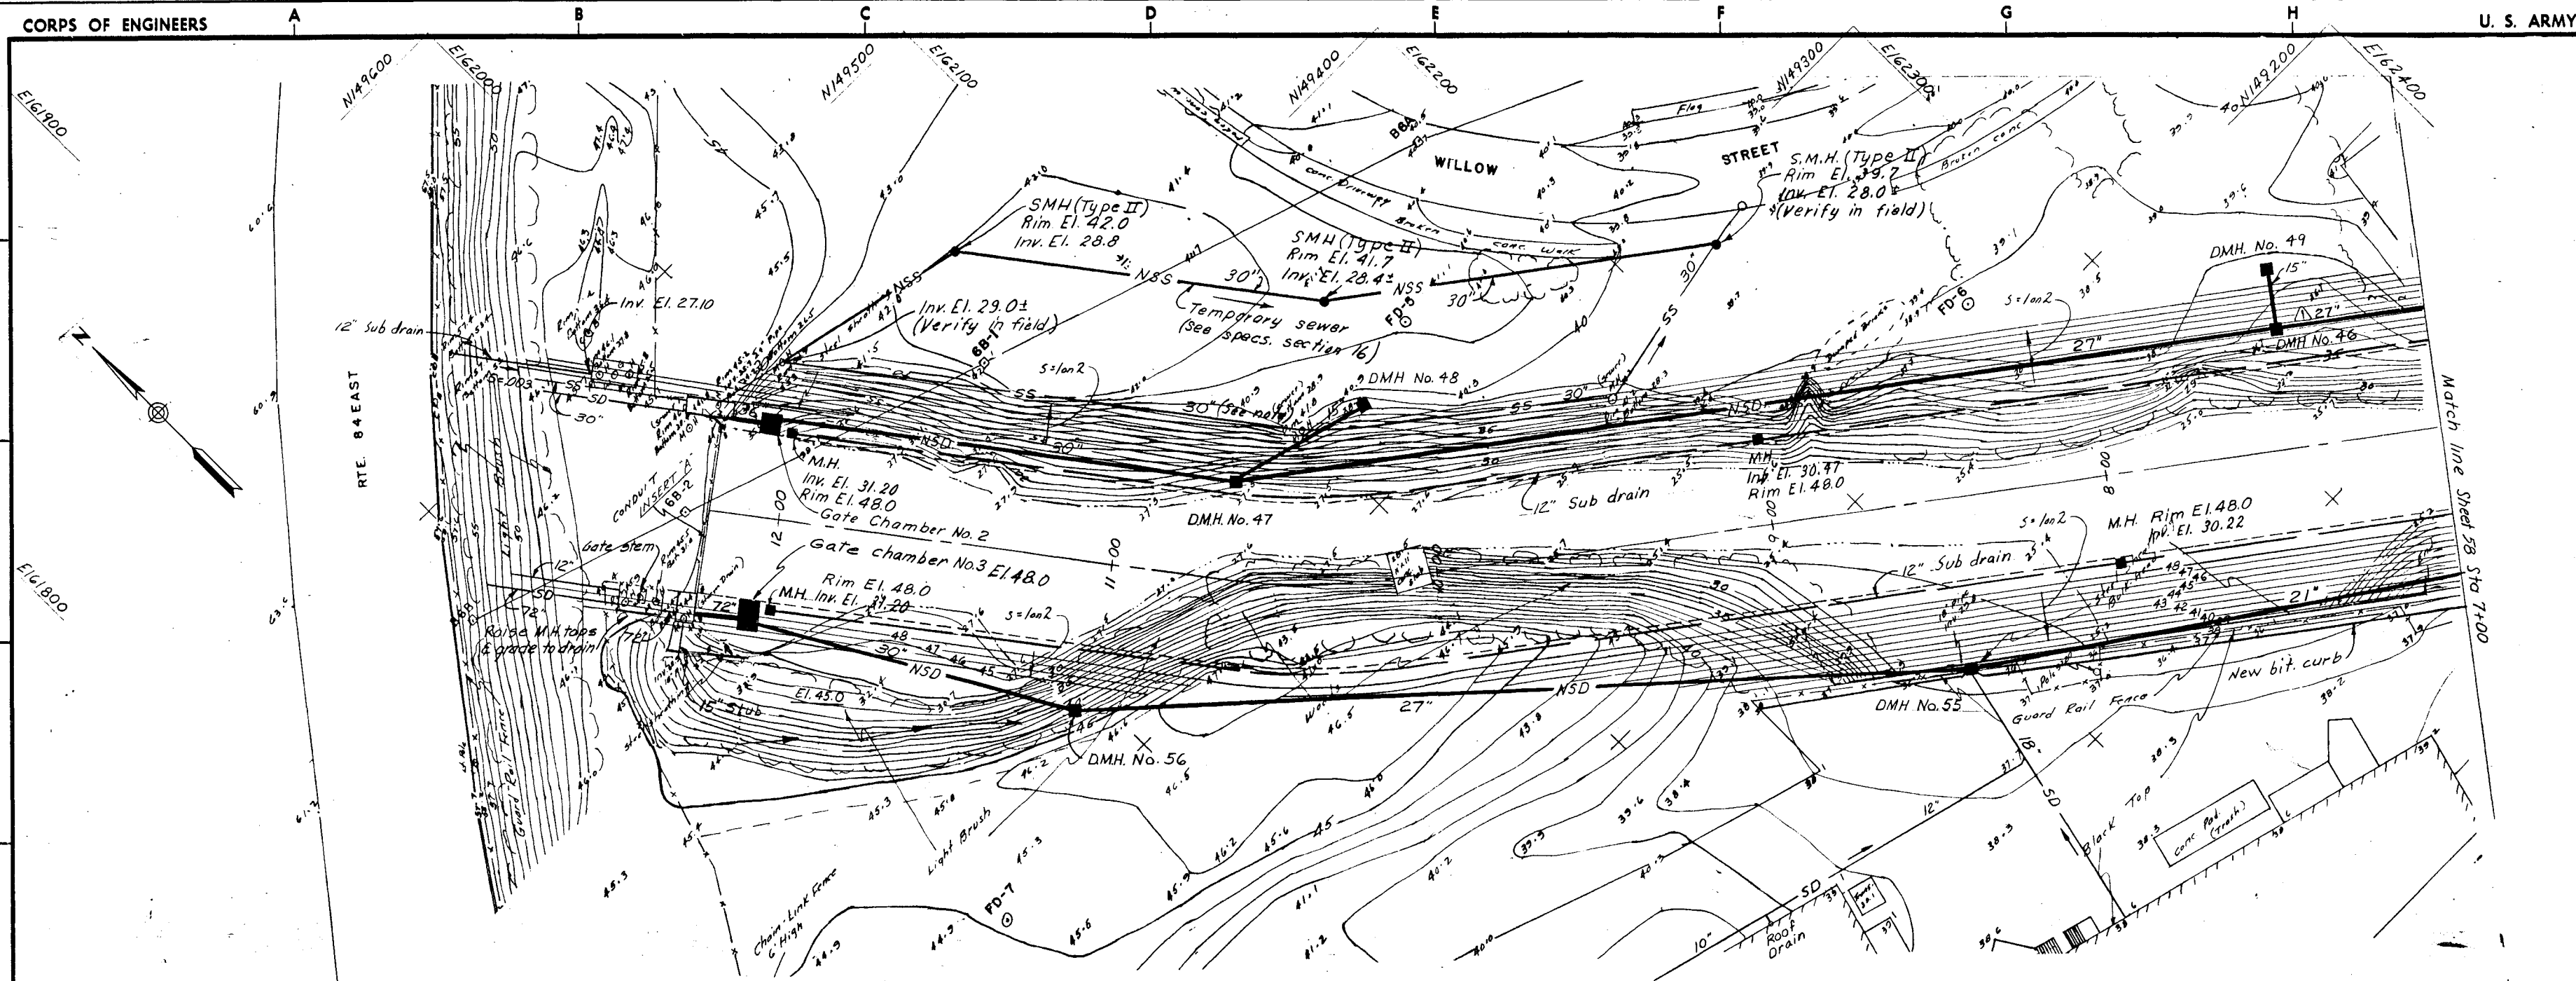

PLAN
SCALE 1" = 20'

NOTE:
Remove and replace existing 30" SS.
See specifications, Section 16.

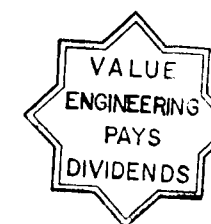

GRAPHIC SCALES

1" = 20' 0' 20' 40'

As Built Drawing

Contract No. DACW 33-76-C-0088

4-4-83 Final field corrections		
REVISION	DATE	DESCRIPTION
1	June 76	Storm drain size changed (Am. #4)
DEPARTMENT OF THE ARMY NEW ENGLAND DIVISION CORPS OF ENGINEERS WALTHAM, MASS.		
WATER RESOURCES DEVELOPMENT PROJECT PARK RIVER LOCAL PROTECTION BOX CONDUIT AT SECTION 7 GRADING PLAN NO. 2		
DES. BY R.C.	DR. BY J.B.M.	CK. BY R.T.C.
SUBMITTED CHIEF, LAYOUT SECTION		
APPROVAL RECOMMENDED CHIEF, TECH. ENG. BRANCH		
REVIEWED PROJECT ENGINEER		
APPROVED CHIEF, ENGINEERING DIVISION		
HARTFORD		CONNECTICUT
DATE		MARCH 1976
SCALE AS SHOWN SPEC. NO. DACW 33-76-B-0040		
DRAWING NUMBER PAR - I		
SHEET 59		