



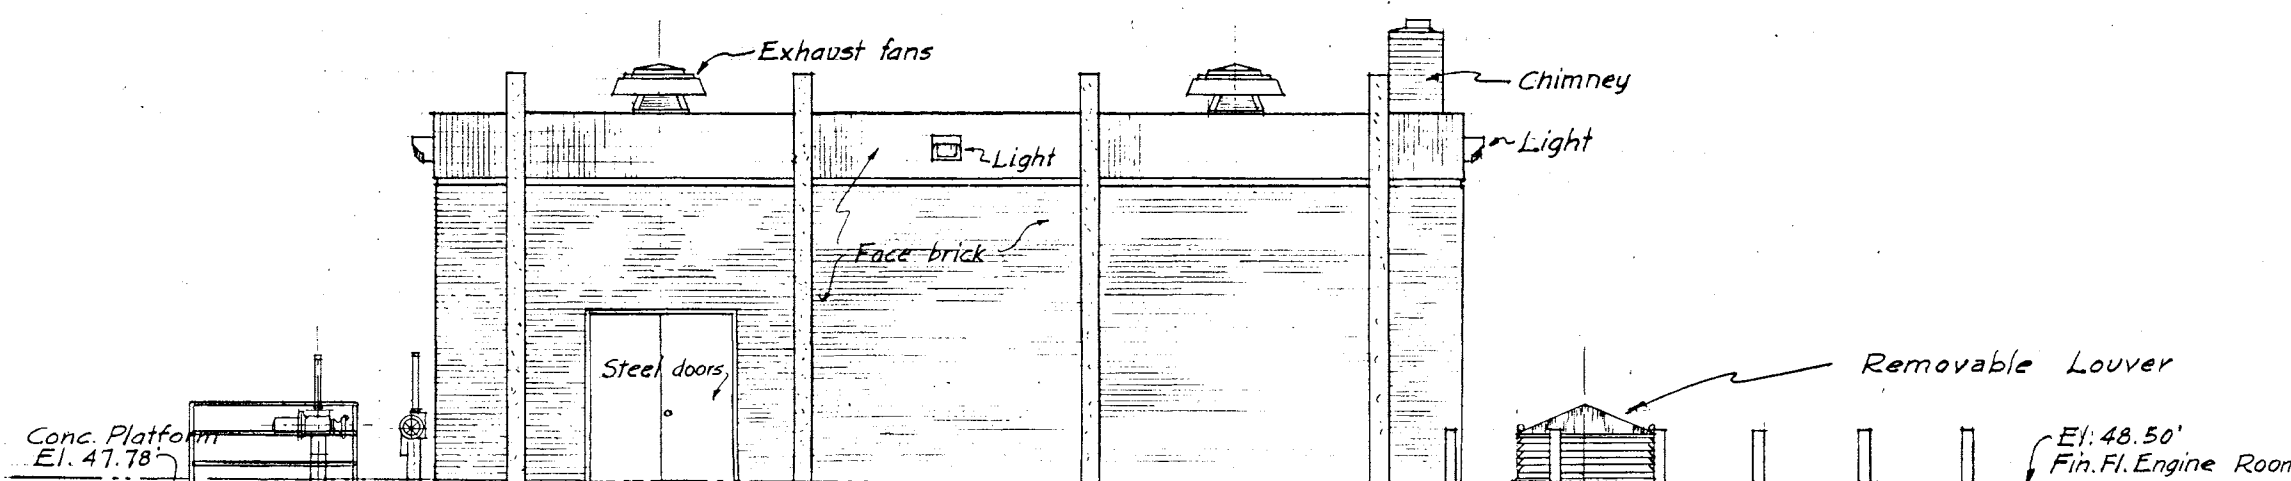


EAST ELEVATION

SCALE 1/4" = 1' - 0"

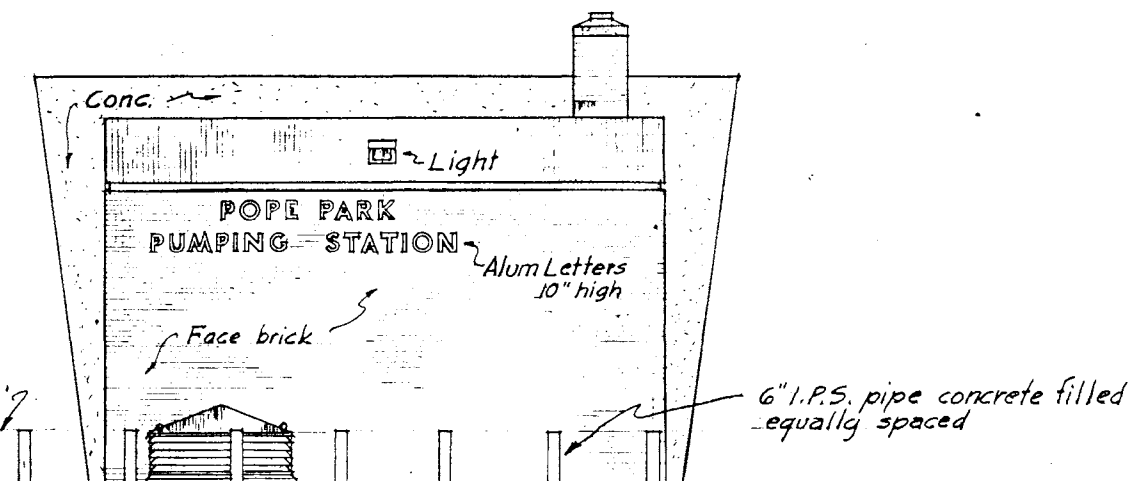


NORTH ELEVATION

SCALE 1/4" = 1' - 0"

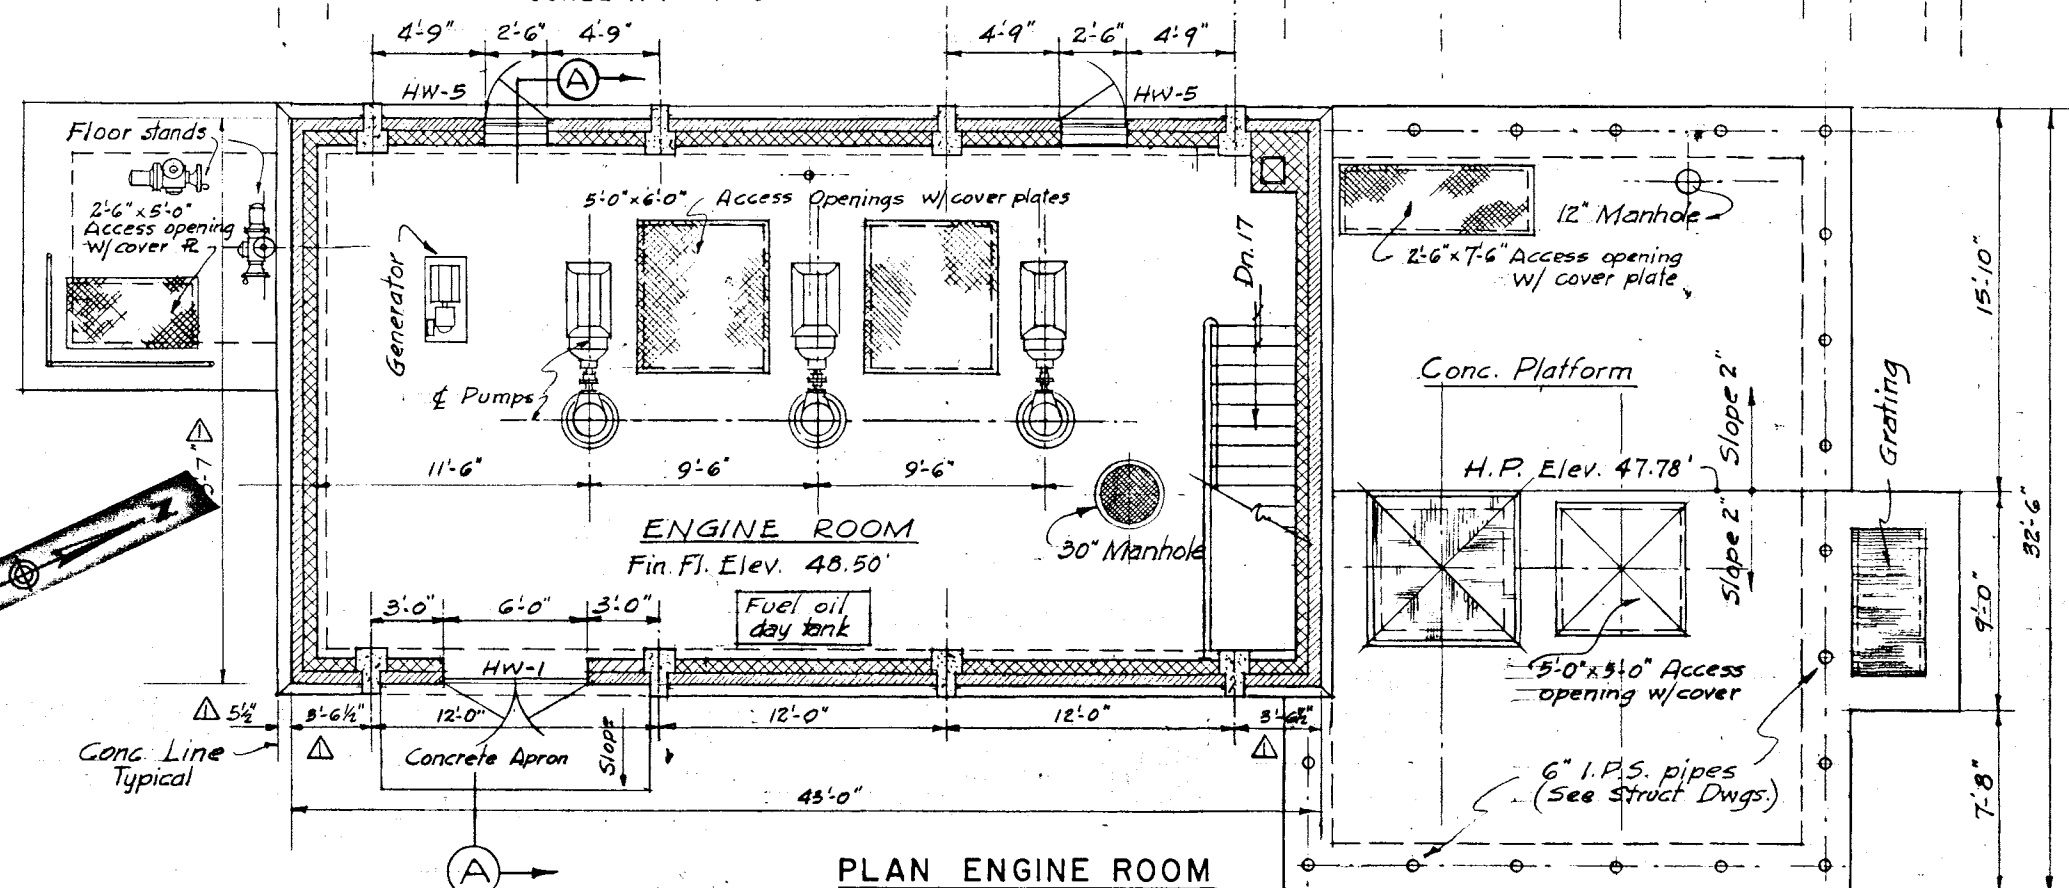


PLAN ENGINE ROOM

SCALE 1/4" = 1' - 0"

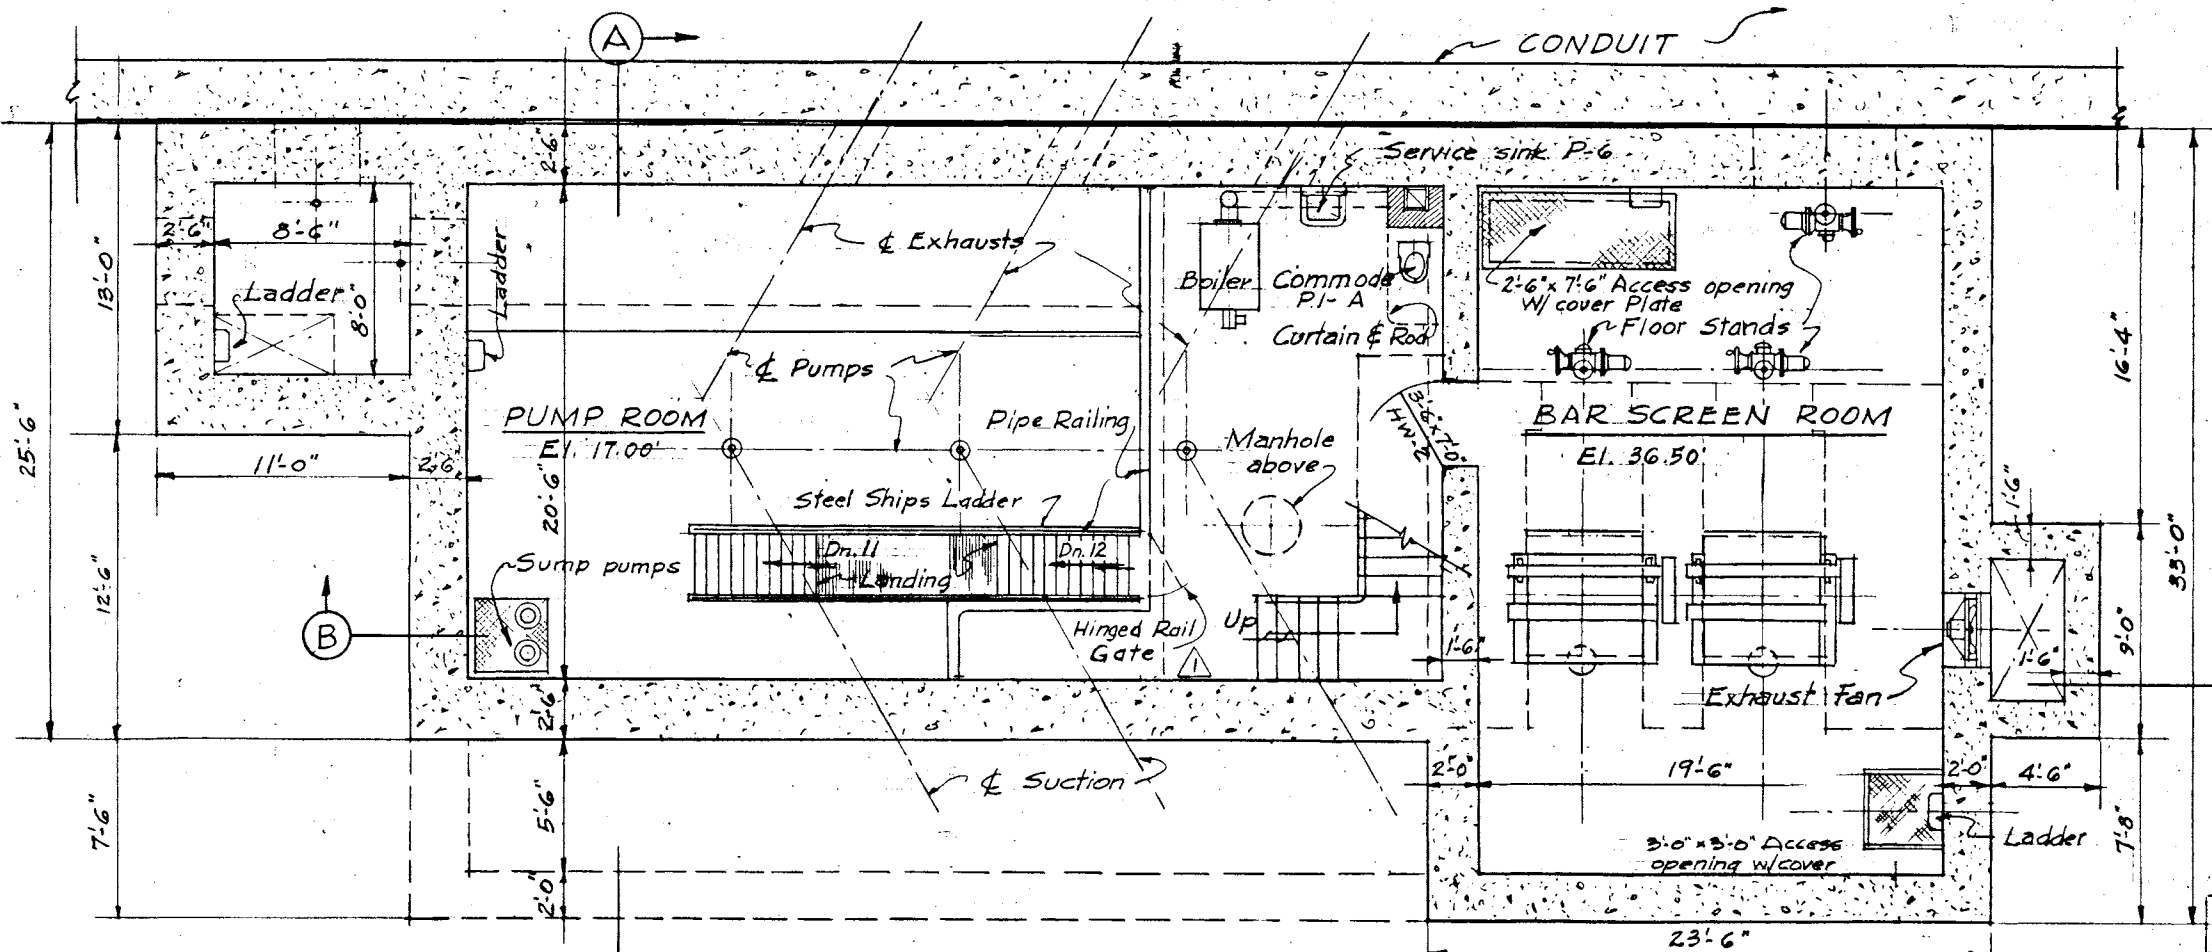

MEZZANINE FLOOR PLAN

SCALE 1/4" = 1' - 0"

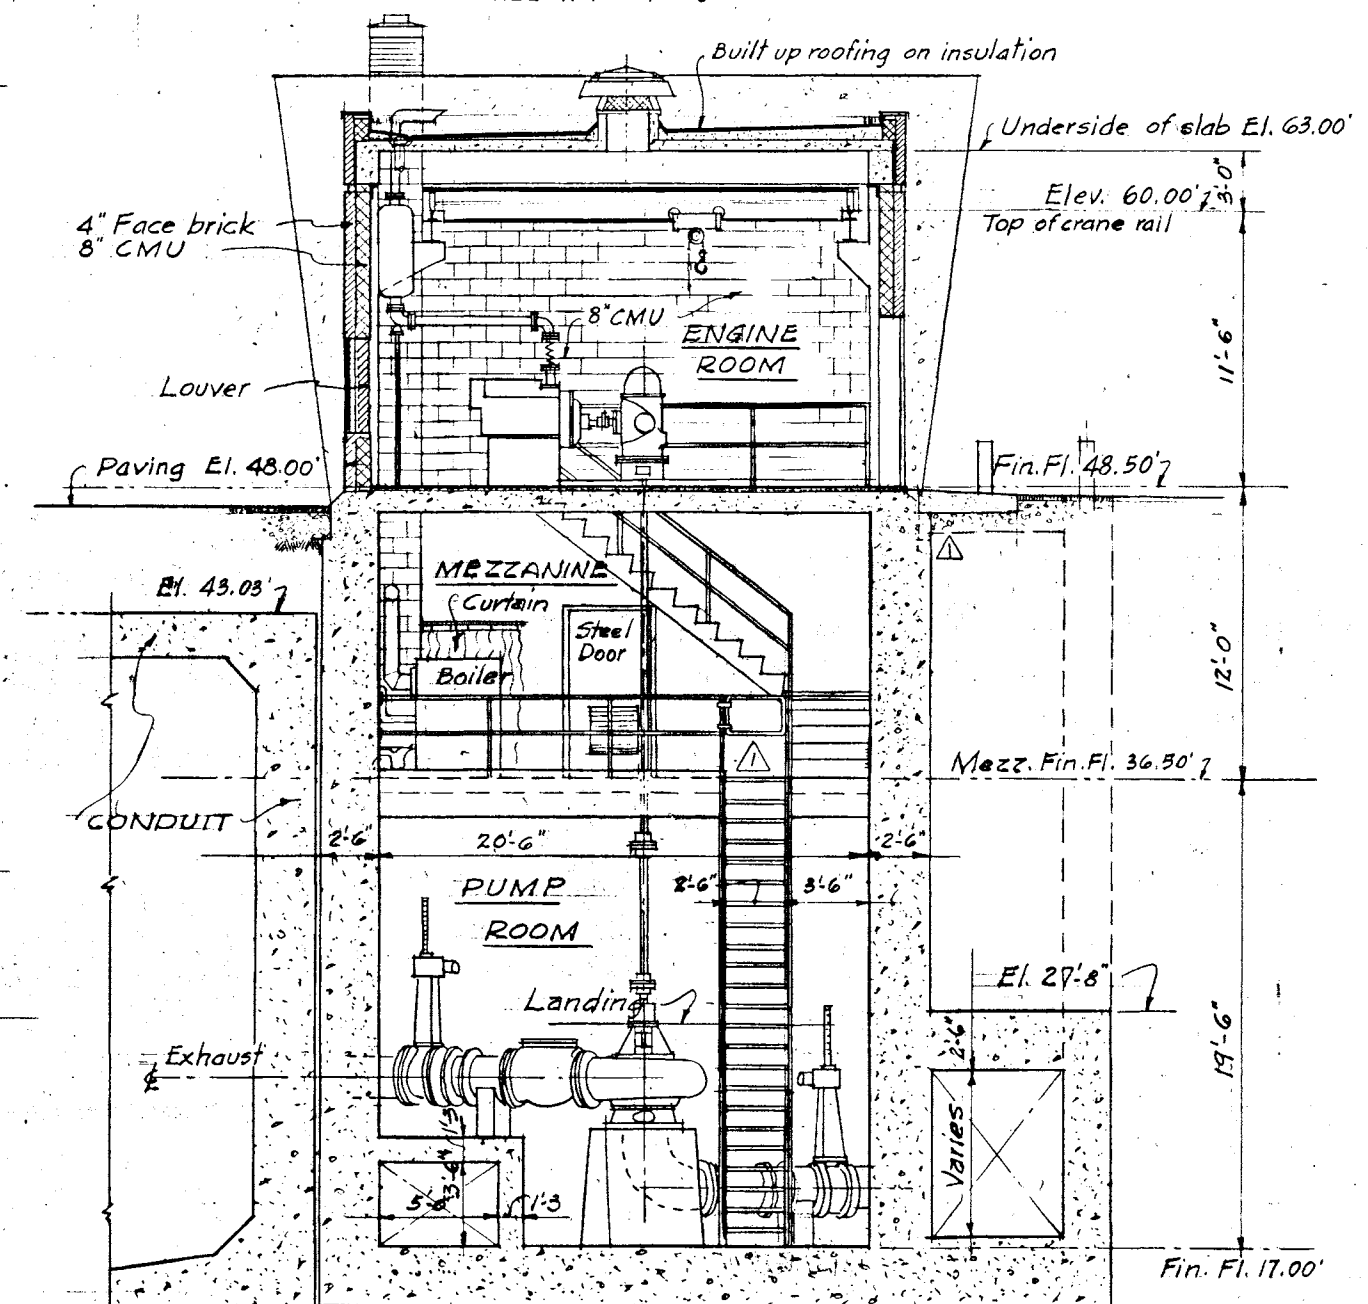

SECTION A-A

NOTES


- 1) For details of ships ladders, railings, access covers, ladders, grating, conc. stairs and manholes see Structural drawings.
- 2) "Colorcron" separate floor in Engine Room, Tile Red 28" thick. Integral "Colorcron" surface, same color, in Mezzanine & Bar Screen Room.



1/4" = 1' - 0"

As Built Drawing

Contract No. DACW 33-76-0-0098

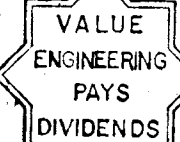

REVISION		DATE	REV. CHAIN TO HINGED RAIL GATE, & BRK. DM. COORD. PLATE DET. 1-1/2" DIA. 1/2"	BY
DEPARTMENT OF THE ARMY NEW ENGLAND DIVISION CORPS OF ENGINEERS WALTHAM, MASS.				
WATER RESOURCES DEVELOPMENT PROJECT PARK RIVER LOCAL PROTECTION POPE PARK PUMPING STATION ARCHITECTURAL PLANS, ELEVATIONS AND SECTION				
DES. BY C.E.	DR. BY C.E.	CHK. BY C.E.	DATE MARCH 1976	
APPROVED CHIEF, PROJECT BRANCH		APPROVED CHIEF, ENGINEERING DIVISION		
SCALE AS SHOWN		SPEC. NO. DACW 33-76-8-0040		
DRAWING NUMBER PAR - I		SHEET 64		