

1

2

3


4

5


6

7

8

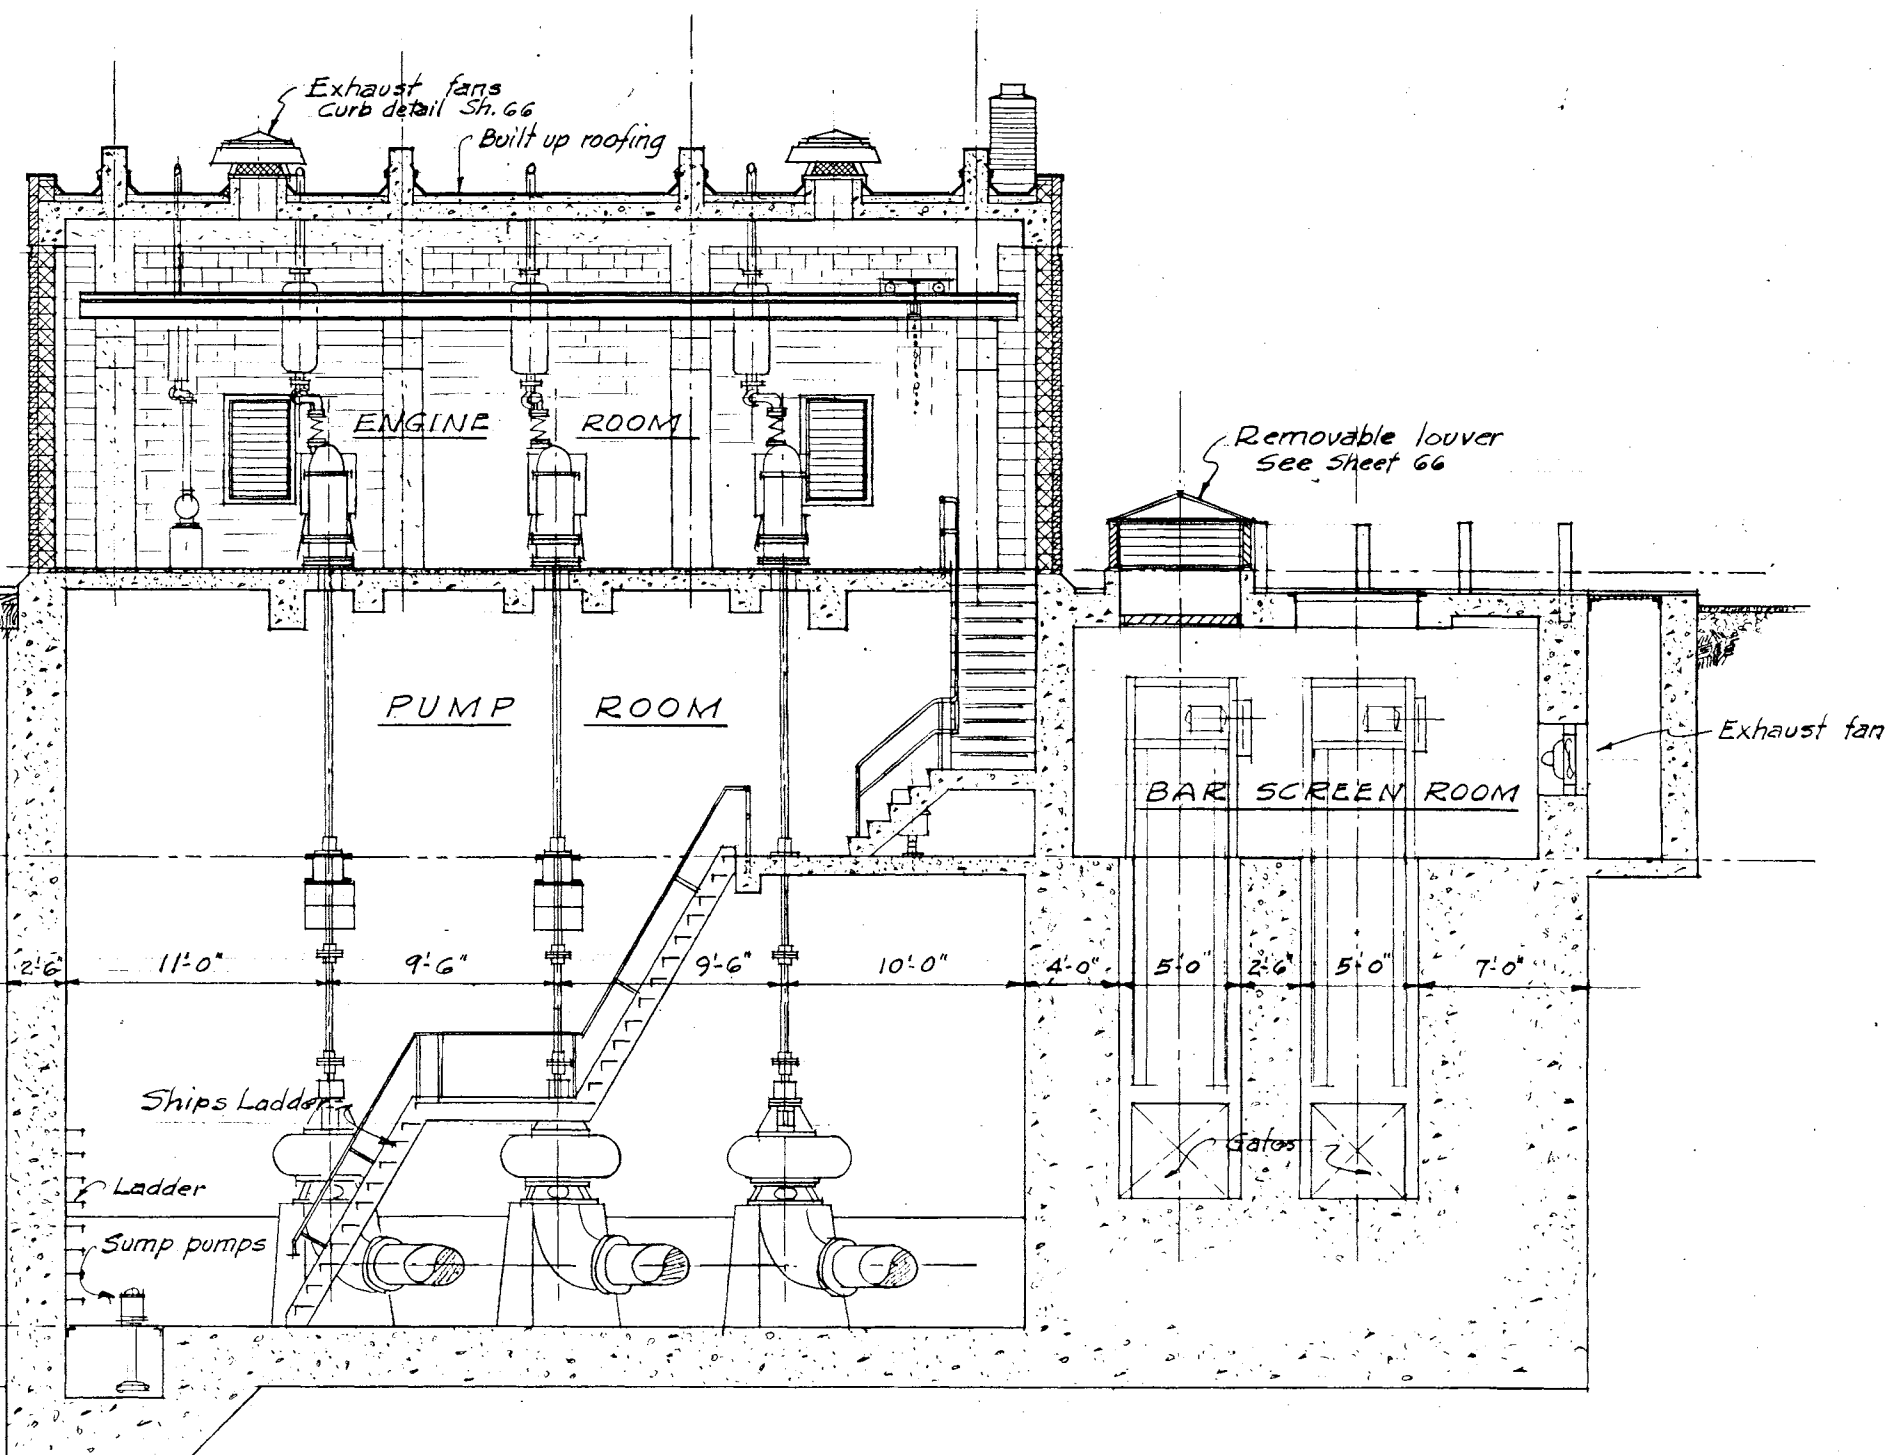



SECTION B-B
Scale 4" = 1'-0"

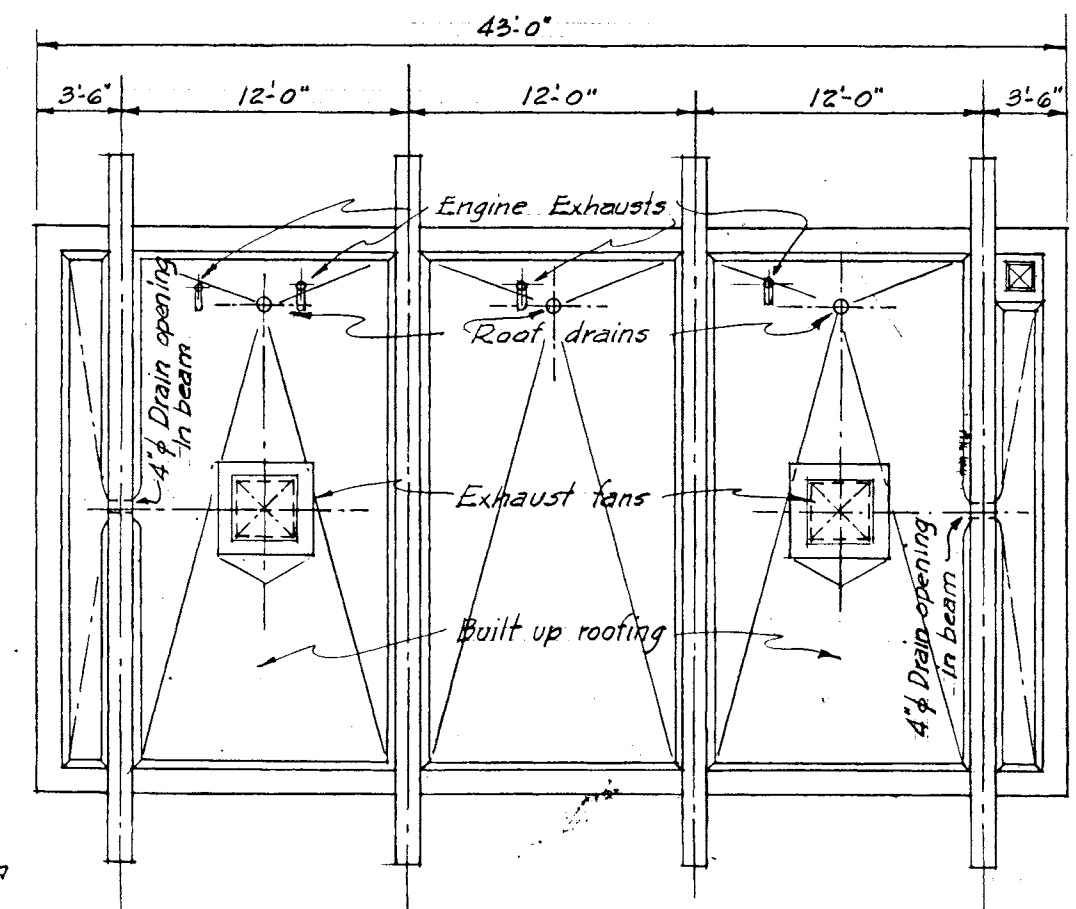

ROOF PLAN
Scale 4" = 1'-0"

NOTES

 1. For details of ships ladders, railings, access covers, gratings and manholes see structural sheets

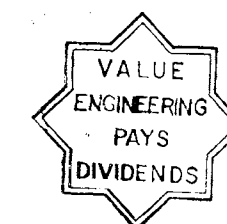

As Built Drawing

Contract No. DACW 33-76-C-0098

REVISION	DATE	DESCRIPTION	BY

DEPARTMENT OF THE ARMY
NEW ENGLAND DIVISION
CORPS OF ENGINEERS
WALTHAM, MASS.

DES. BY: [Signature] DR. BY: [Signature] CK. BY: [Signature]
C.E. C.E. C.E.

SUBMITTED: [Signature] [Date]
CHIEF, ARCH. SECTION
APPROVAL: [Signature] [Date]
CHIEF, TECH. ENG. BRANCH
REVIEWED: [Signature] [Date]
PROJECT ENGINEER

WATER RESOURCES DEVELOPMENT PROJECT
PARK RIVER LOCAL PROTECTION
POPE PARK PUMPING STATION
ARCHITECTURAL SECTIONS

HARTFORD CONNECTICUT

APPROVED: [Signature] DATE: MARCH 1976
CHIEF, ENGINEERING DIVISION

SCALE AS SHOWN SPEC. NO. DACW33-76-B-0040
DRAWING NUMBER
PAR - I

SHEET 65