



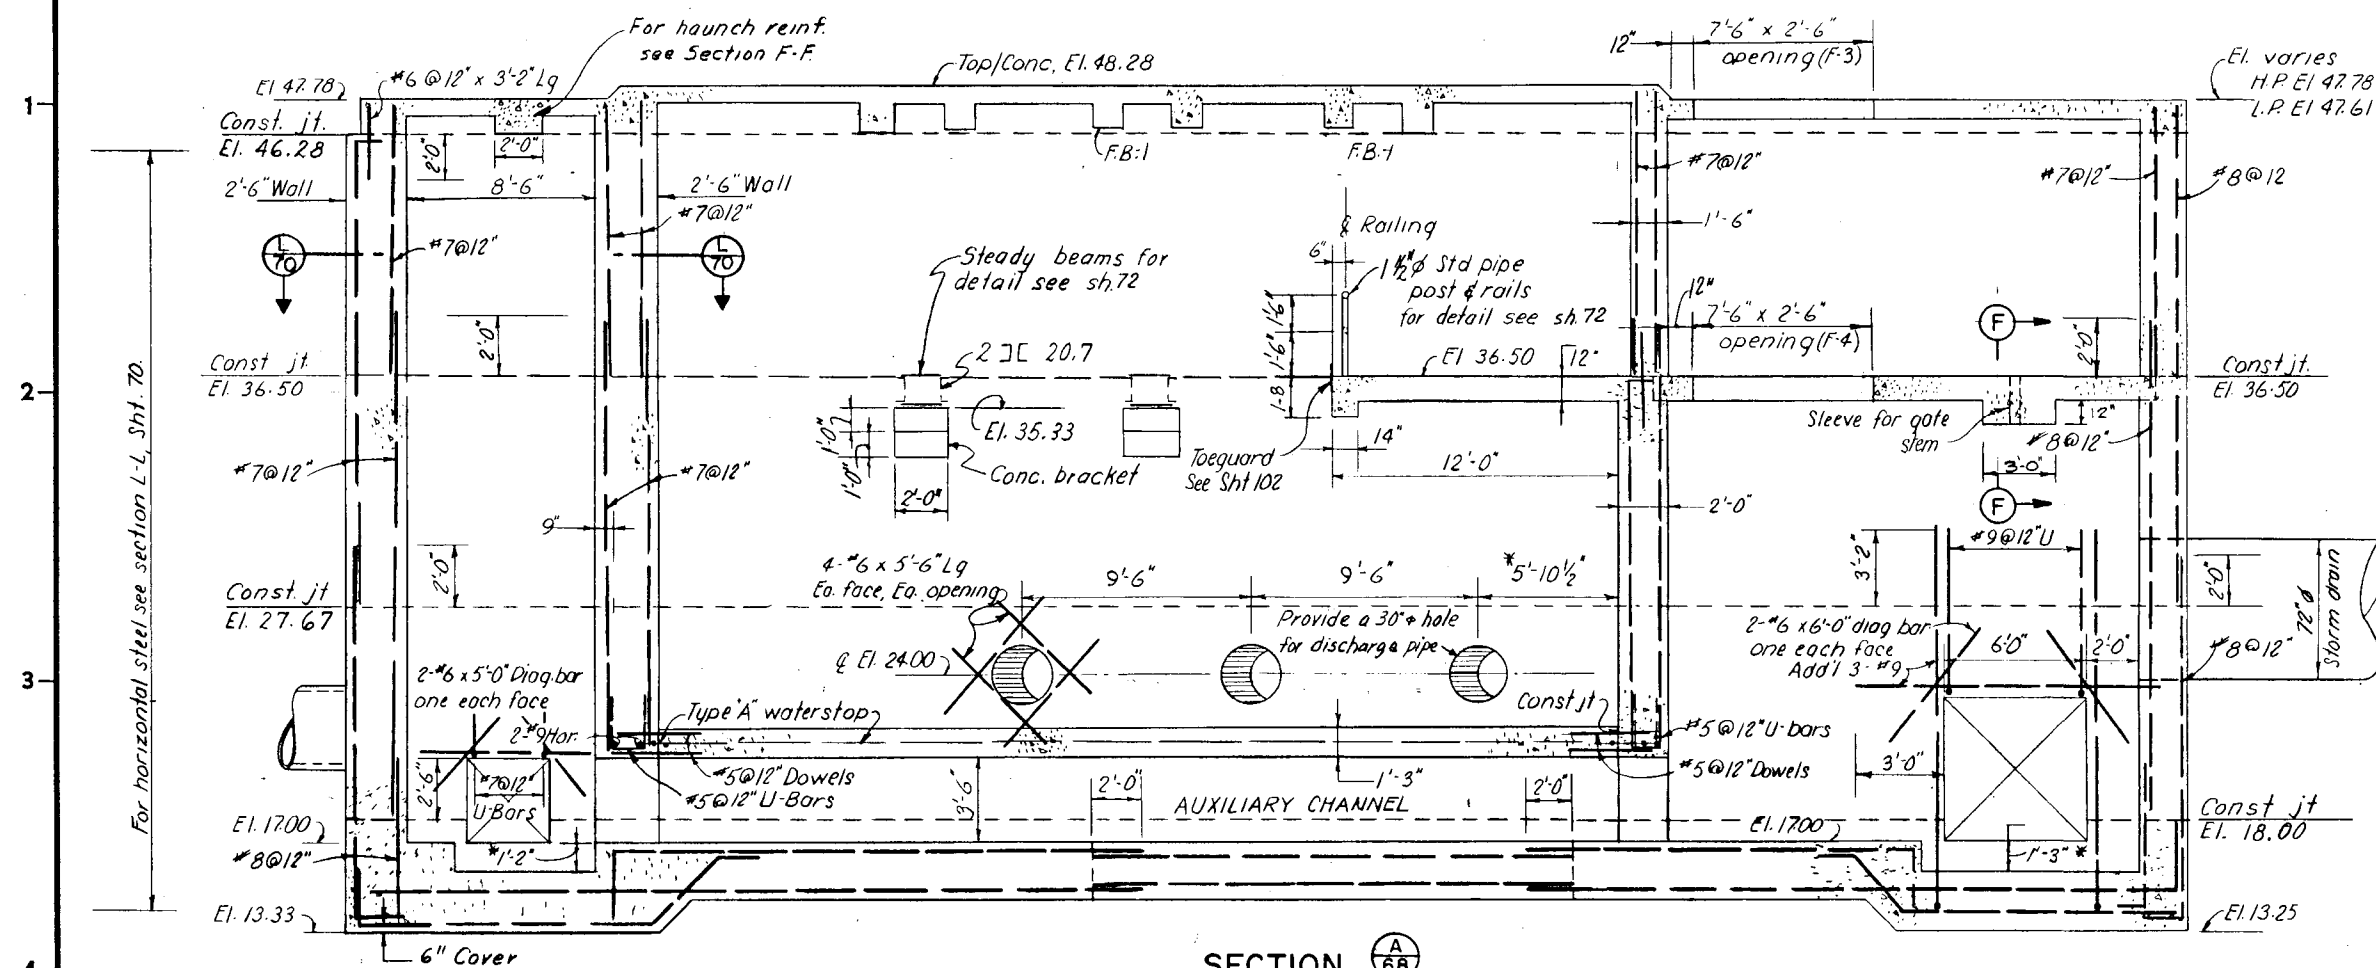

SECTION A-68


SCALE 1/4" = 1'-0"

- NOTES: 1. (*) Indicates dimensions to be verified in field.
2. Space between discharge pipe & pump station wall to be filled with a compressible material and sealed on the pump room side of wall.

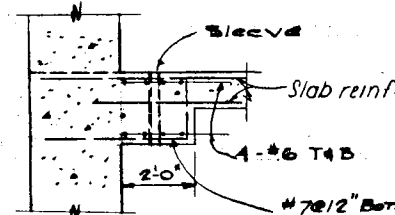

SECTION F-F

SCALE 3/8" = 1'-0"

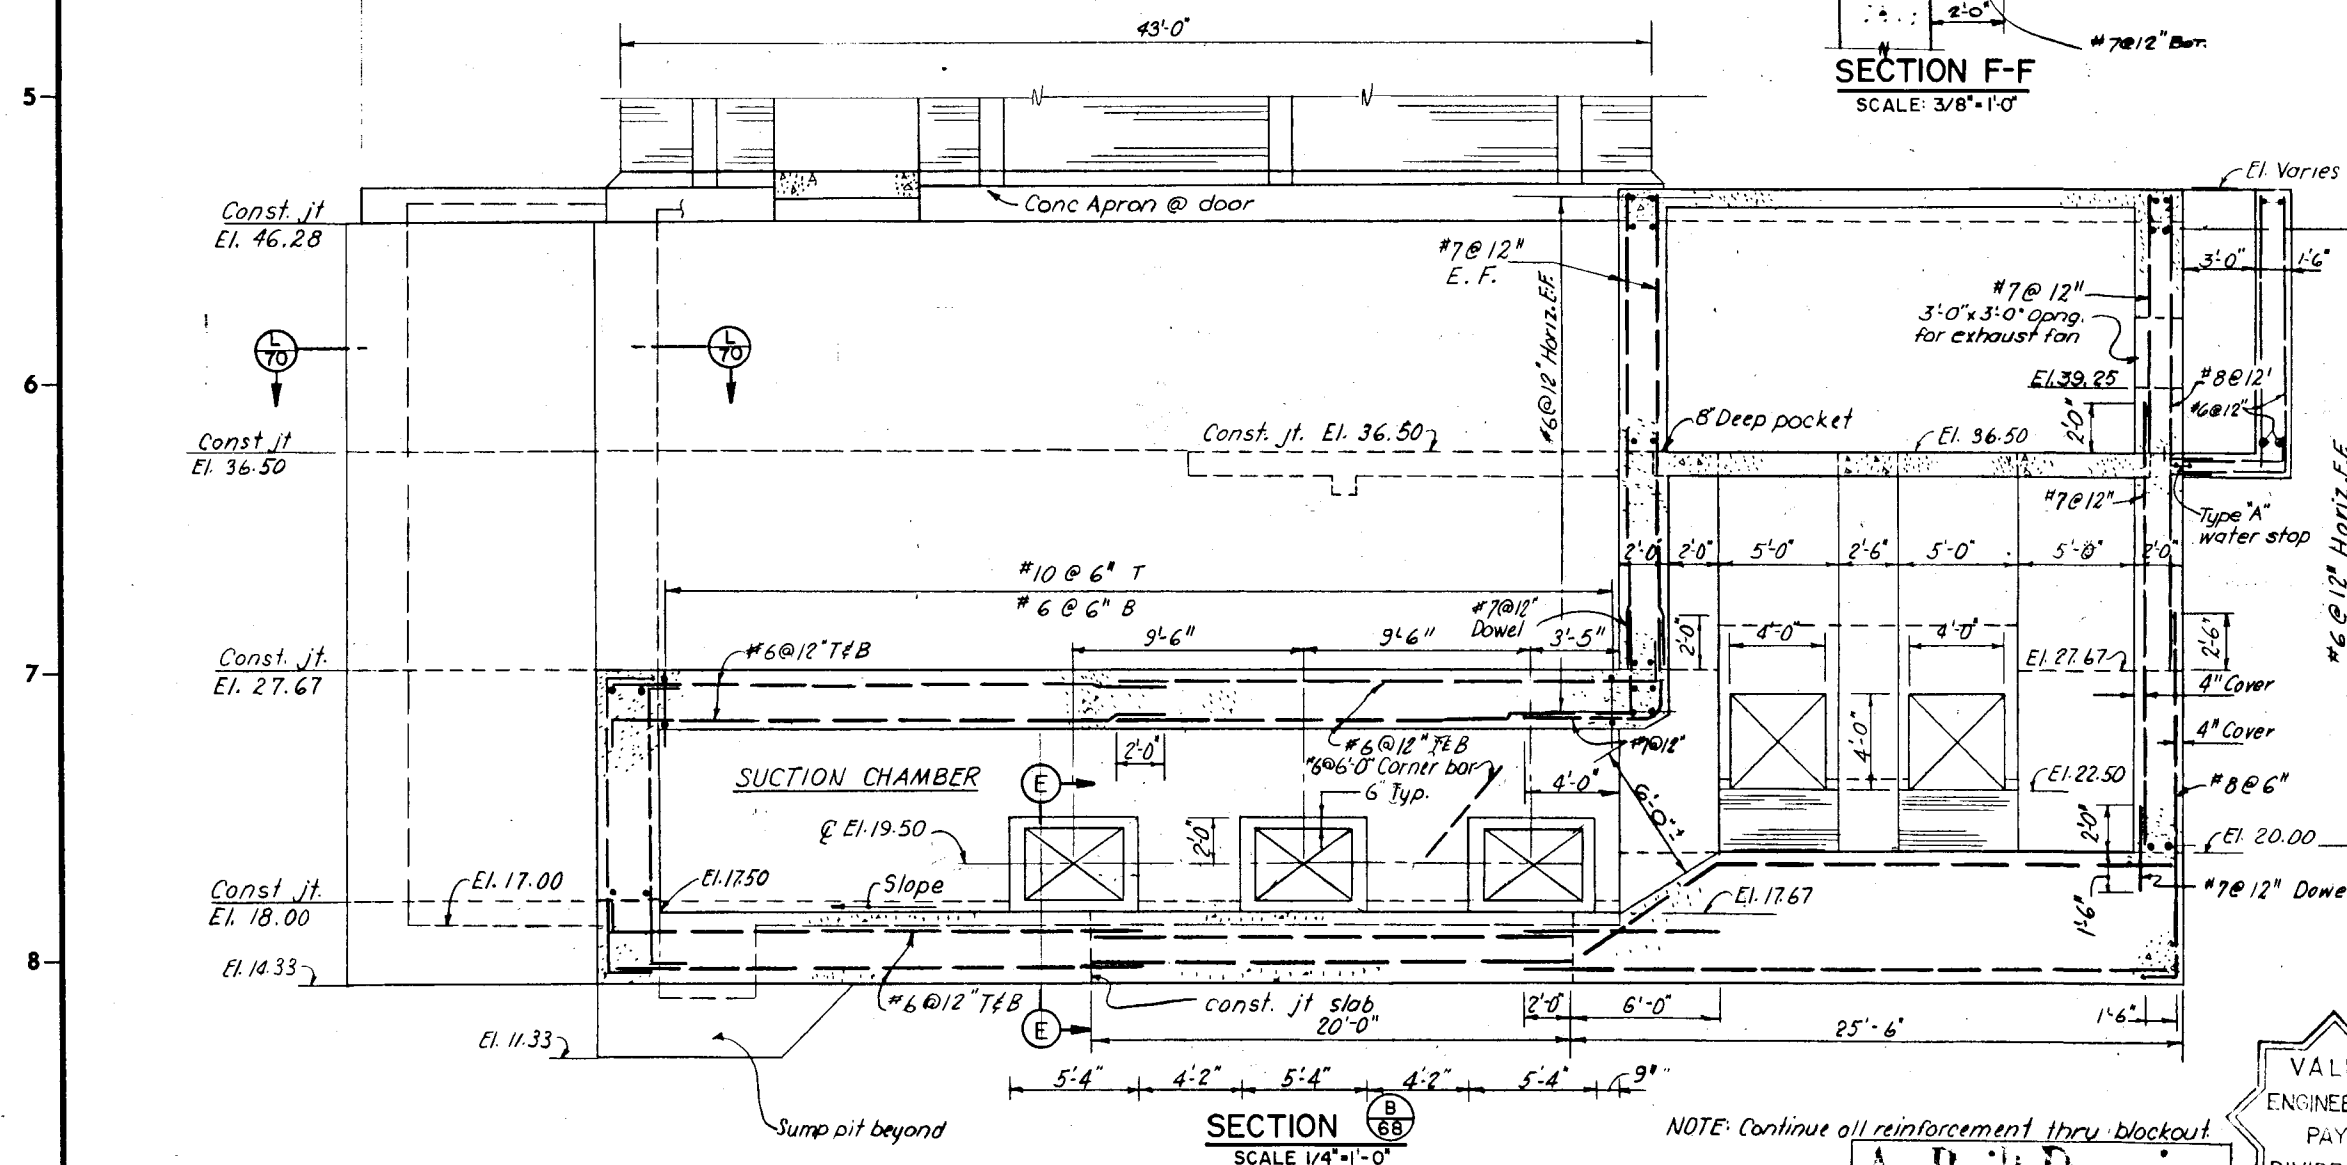


SECTION B-68

SCALE 1/4" = 1'-0"

NOTE: Continue all reinforcement thru blockout.


As Built Drawing

Contract No. DAWC 33-76C-0008

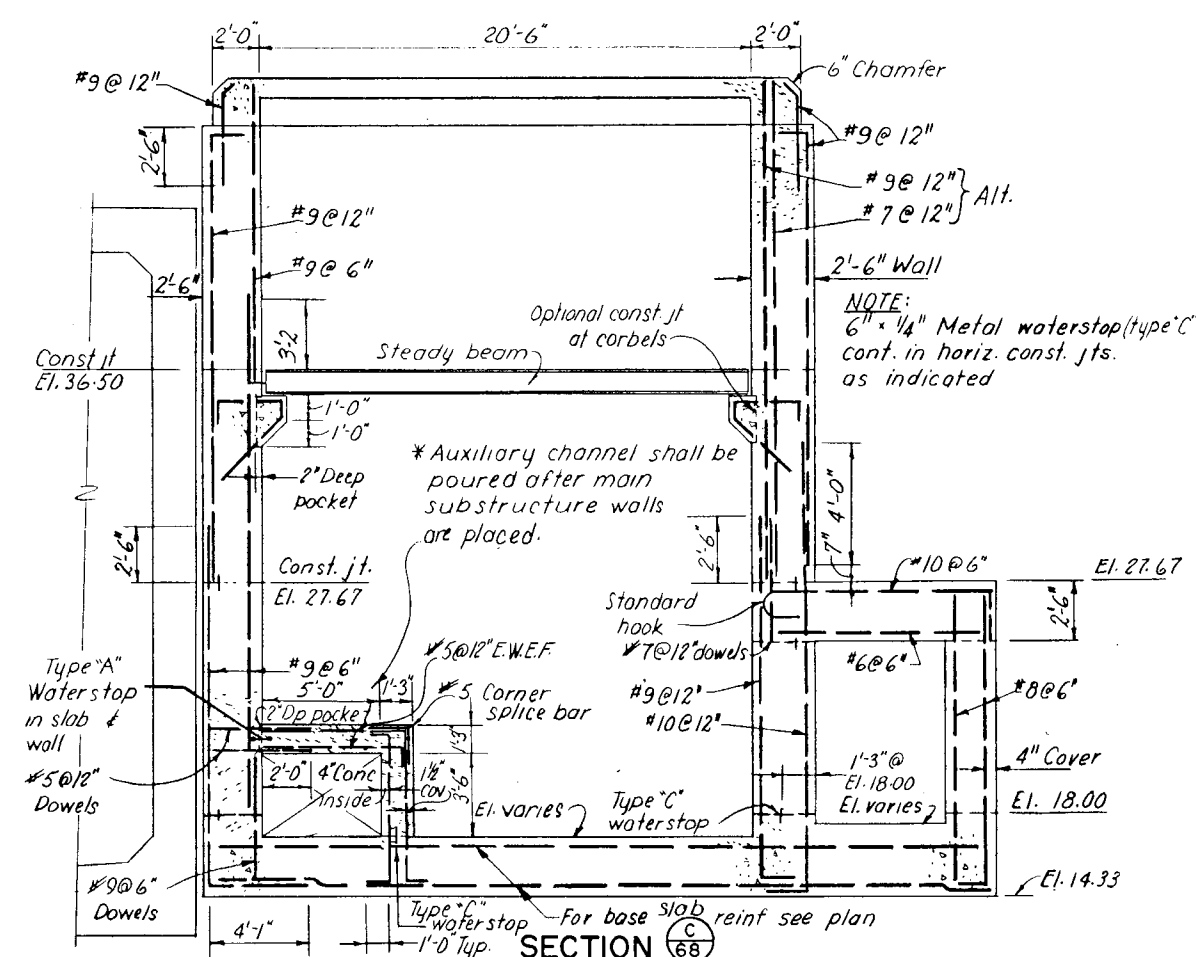


SECTION C-68

SCALE 1/4" = 1'-0"

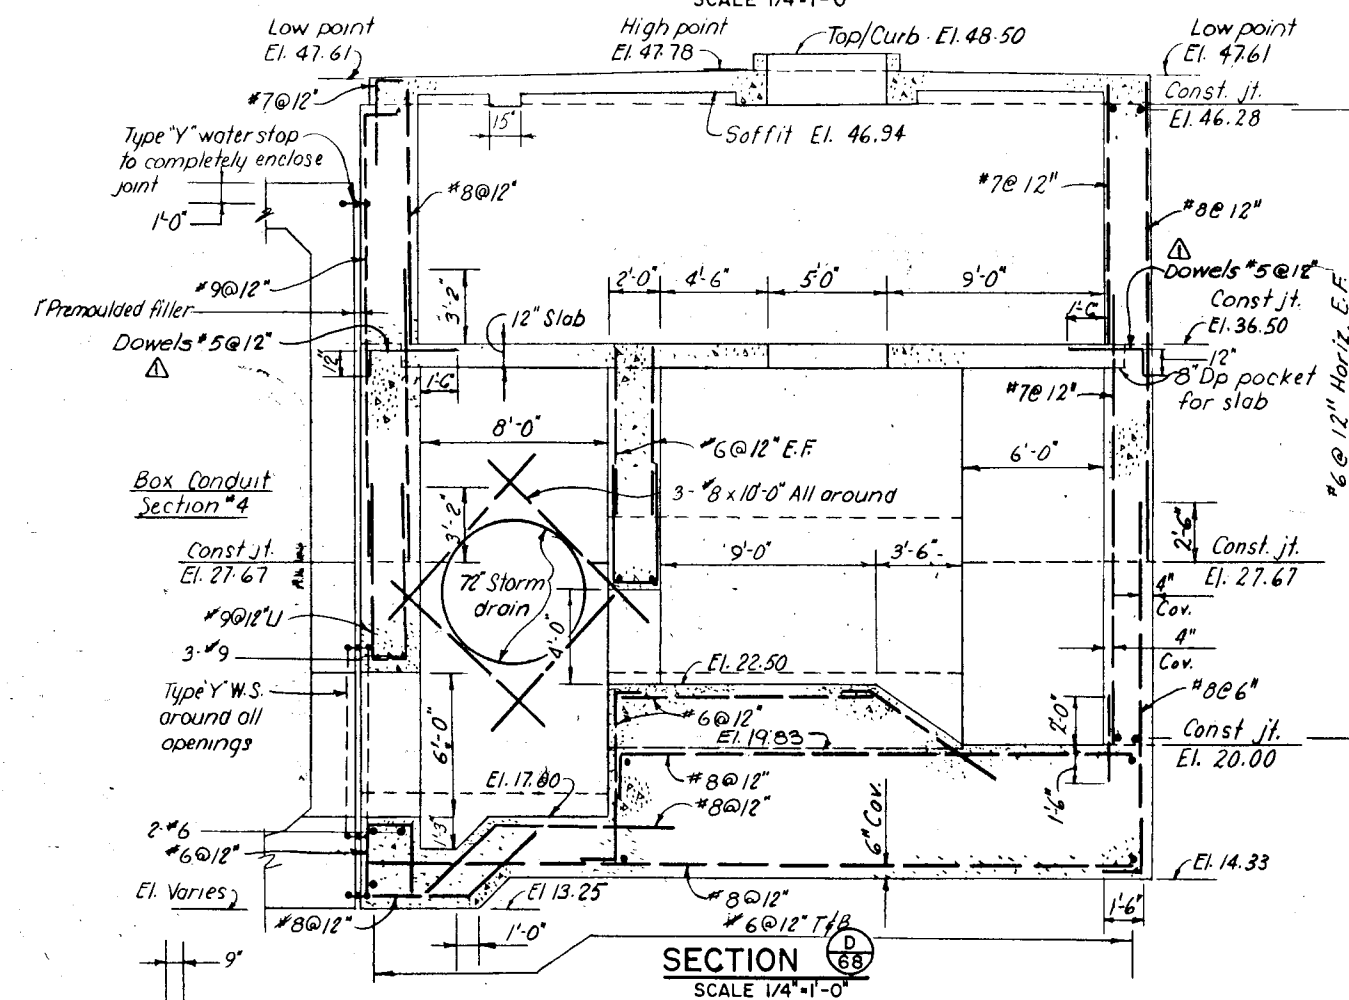

SECTION D-68

SCALE 1/4" = 1'-0"

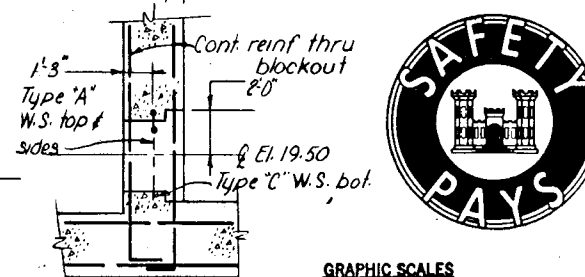

SECTION E-E

SCALE 1/4" = 1'-0"



REVISION				DATE		DESCRIPTION		BY	
1				June 76		Dowels added (Am. #4)		RFA/HRT	

DEPARTMENT OF THE ARMY
NEW ENGLAND DIVISION
CORPS OF ENGINEERS
WALTHAM, MASS.

WATER RESOURCES DEVELOPMENT PROJECT
PARK RIVER LOCAL PROTECTION
POPE PARK PUMPING STATION
REINFORCEMENT DETAILS NO. 3

HARTFORD CONNECTICUT

DATE MARCH 1976

SCALE AS SHOWN SPEC. NO. DACW33-76-B-0040
DRAWING NUMBER PAR-1

SHEET 69