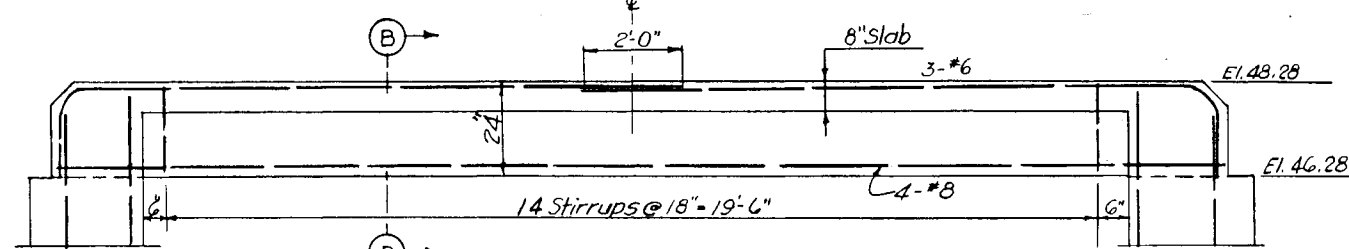
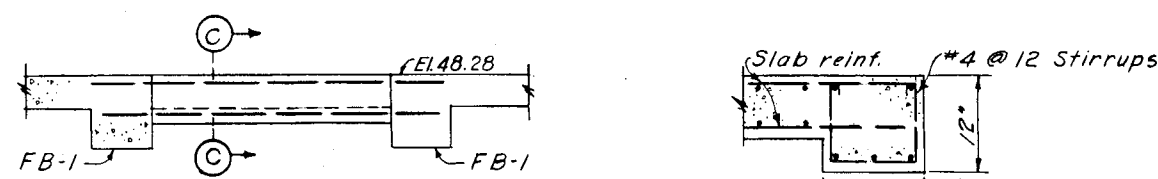
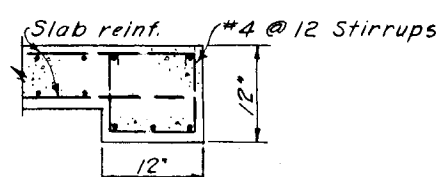
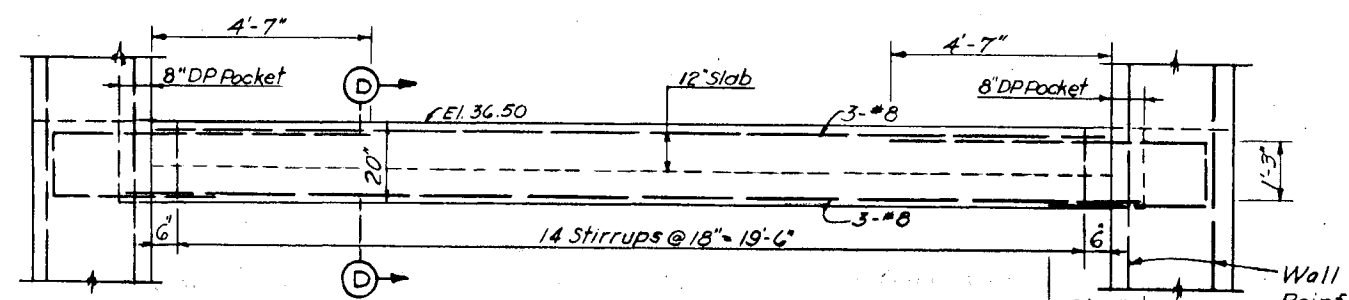
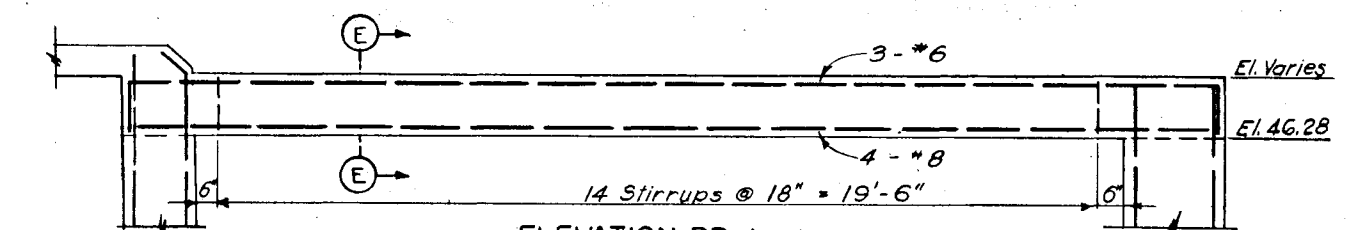
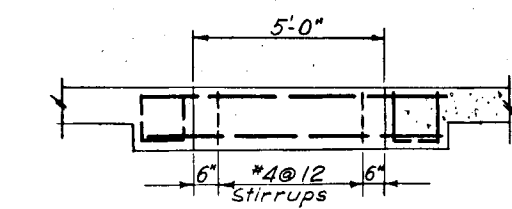
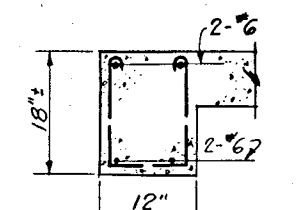
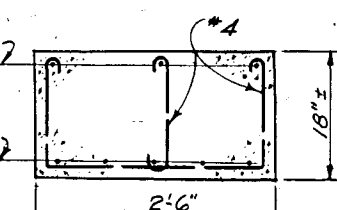
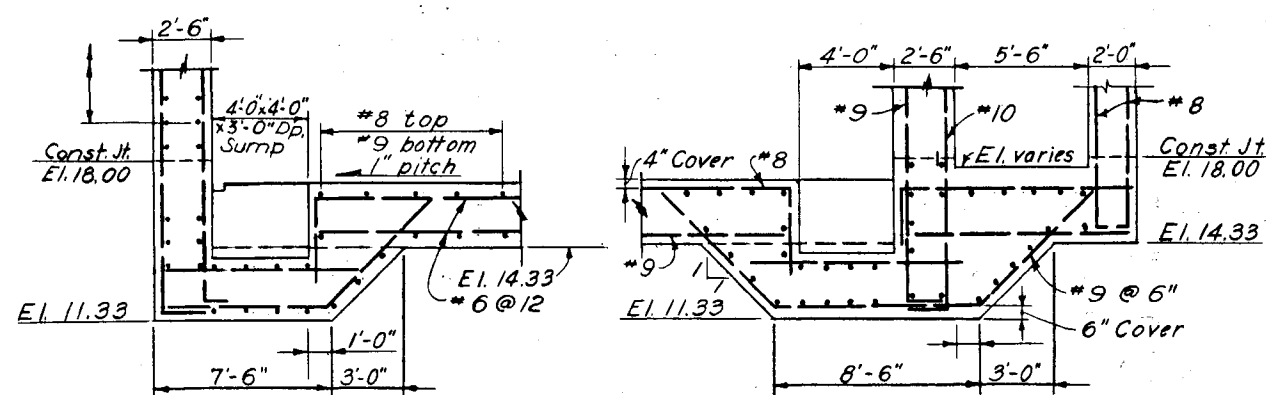
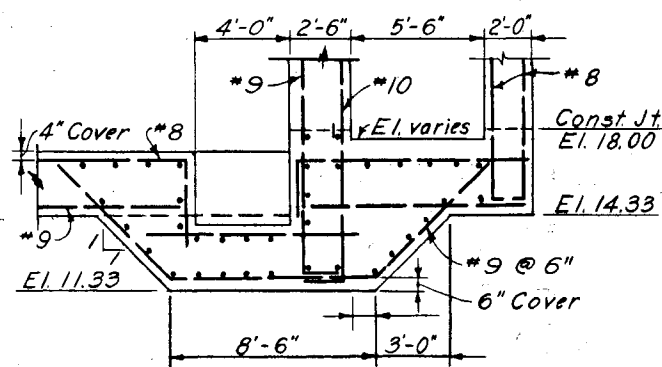
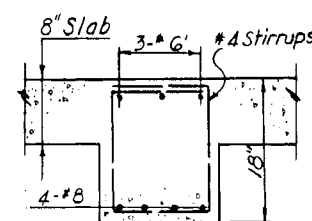
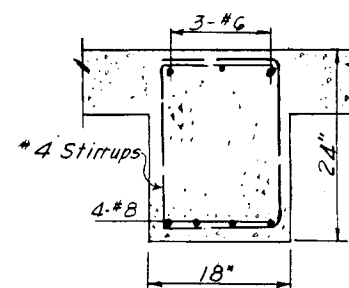
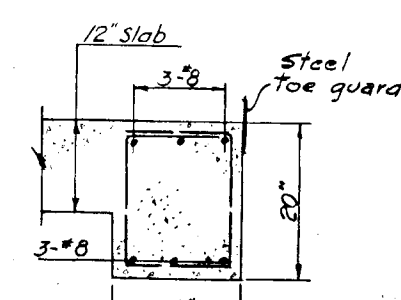
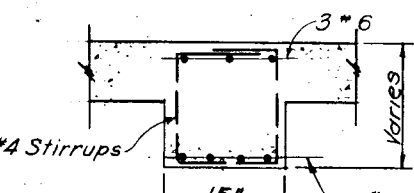
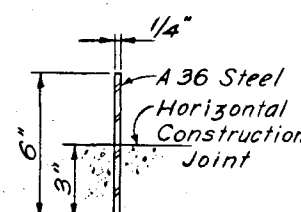
ELEVATION FB-1
SCALE 1/2" = 1'-0"ELEVATION FB-2
SCALE 1/2" = 1'-0"ELEVATION FB-3
SCALE 1/2" = 1'-0"SECTION C-C
SCALE 1" = 1'-0"ELEVATION MB-1
SCALE 1/2" = 1'-0"ELEVATION PB-1
SCALE 1/2" = 1'-0"ELEVATION PB-2 & PB-3
SCALE 1/2" = 1'-0"SECTION P B-2
SCALE 1" = 1'-0"SECTION P B-3
SCALE 1" = 1'-0"SECTION G
SCALE 1/4" = 1'-0"SECTION H
SCALE 1/4" = 1'-0"SECTION A-A
SCALE 1" = 1'-0"SECTION B-B
SCALE 1" = 1'-0"SECTION D-D
SCALE 1" = 1'-0"SECTION E-E
SCALE 1" = 1'-0"

DETAIL




WATERSTOP-TYPE "C"

NOTES:





1. Vertical construction joints in Pump Room walls below Elev. 36.50 shall have Type "A" Waterstop (cont.)
2. Splices between Type "A" and Type "C" are similar to Splice Details shown.
3. For details of type "A" waterstop see specifications.

As Built Drawing

Contract No. DACW 33-78-C-0098

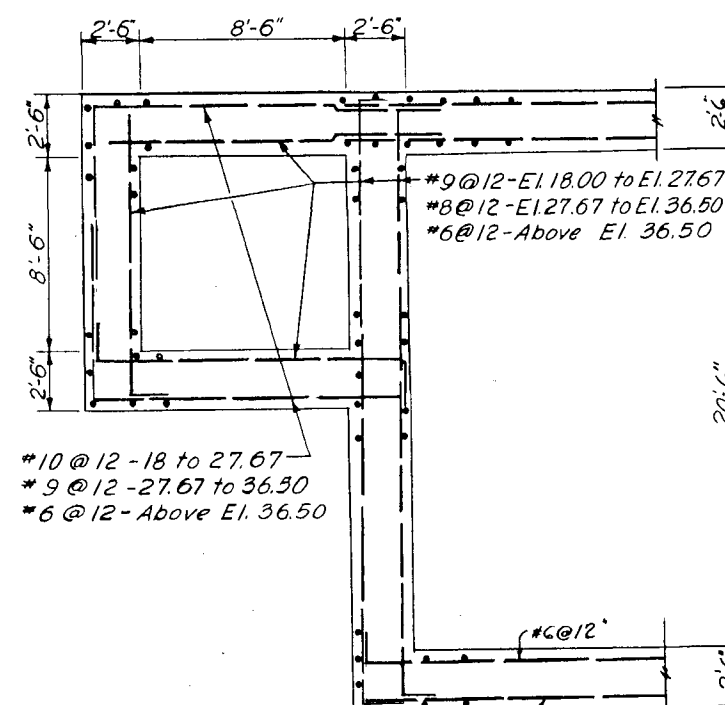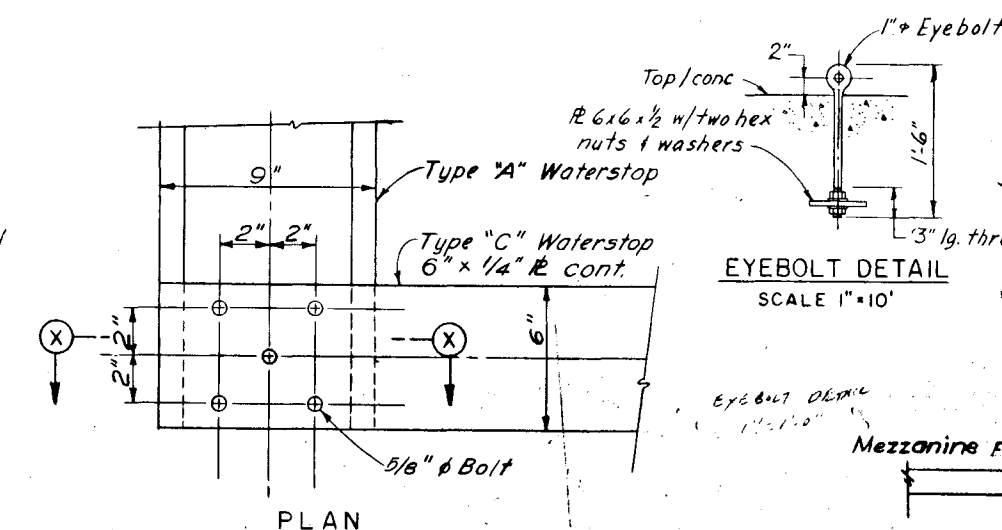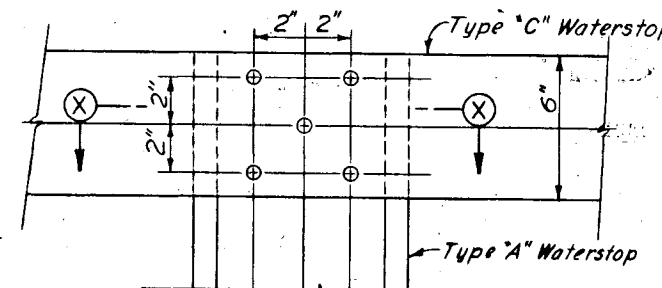SECTION L
PART PLAN WALL REINFORCEMENTSECTION X-X
WATERSTOP SPLICE-1
SCALE 3" = 1'-0"PLAN
WATERSTOP SPLICE-2
SCALE 3" = 1'-0"

GRAPHIC SCALES

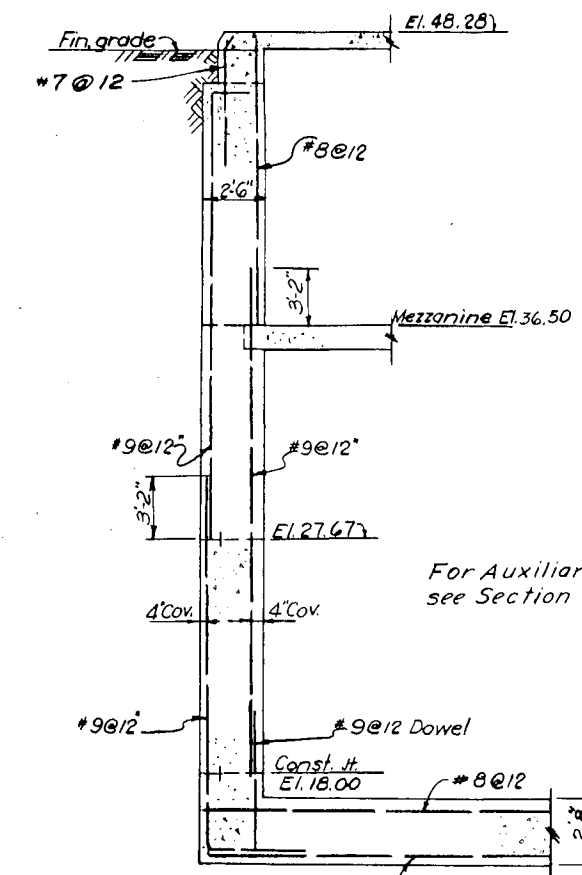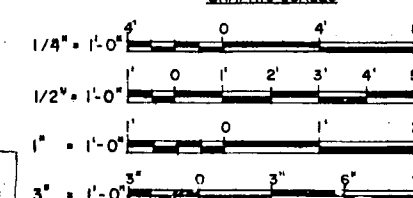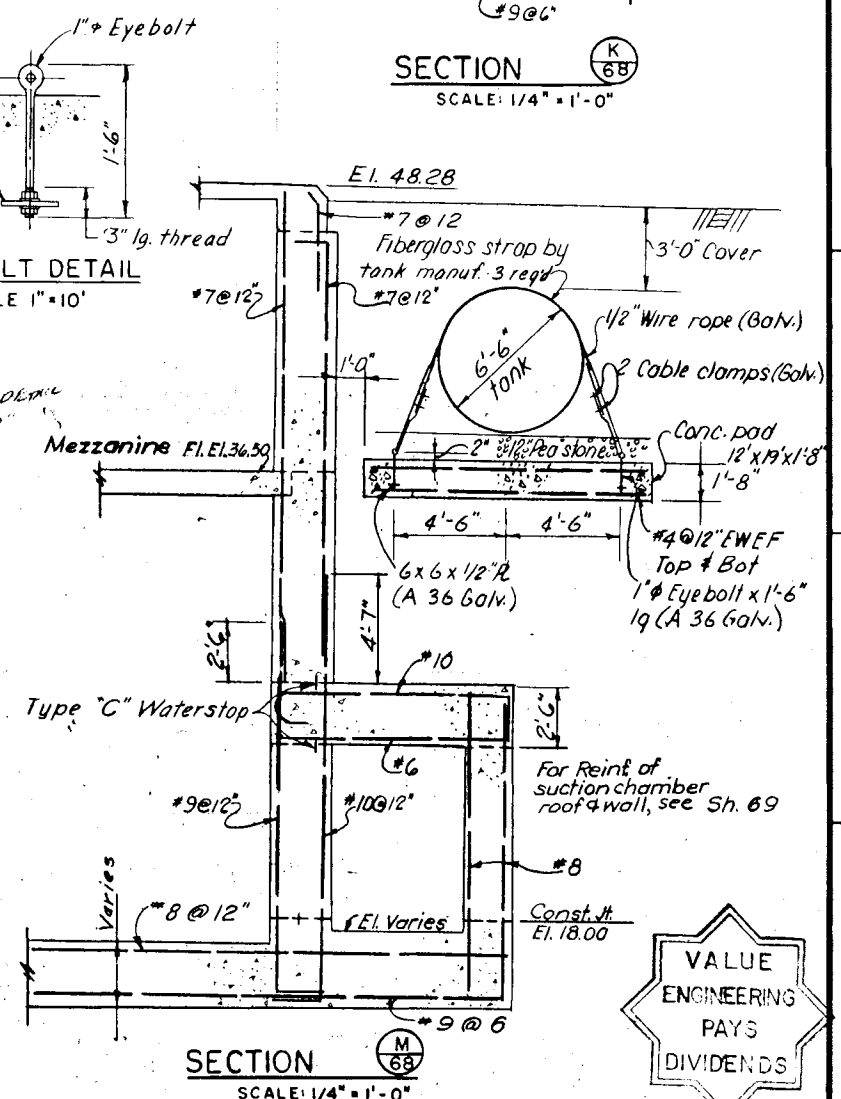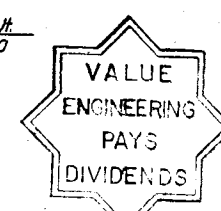SECTION K
SCALE 1/4" = 1'-0"SECTION M
SCALE 1/4" = 1'-0"

REVISION	DATE	DESCRIPTION	BY

DEPARTMENT OF THE ARMY NEW ENGLAND DIVISION CORPS OF ENGINEERS WALTHAM, MASS.			
WATER RESOURCES DEVELOPMENT PROJECT PARK RIVER LOCAL PROTECTION POPE PARK PUMPING STATION REINFORCEMENT DETAILS NO. 4			
DES. BY W.R.	DR. BY J.M.	CK. BY W.R.	DATE MARCH 1976
APPROVED HARTFORD			CONNECTICUT
SPEC. NO. DACW 33-78-B-0040			DRAWING NUMBER PAR-1
SHEET 70			