
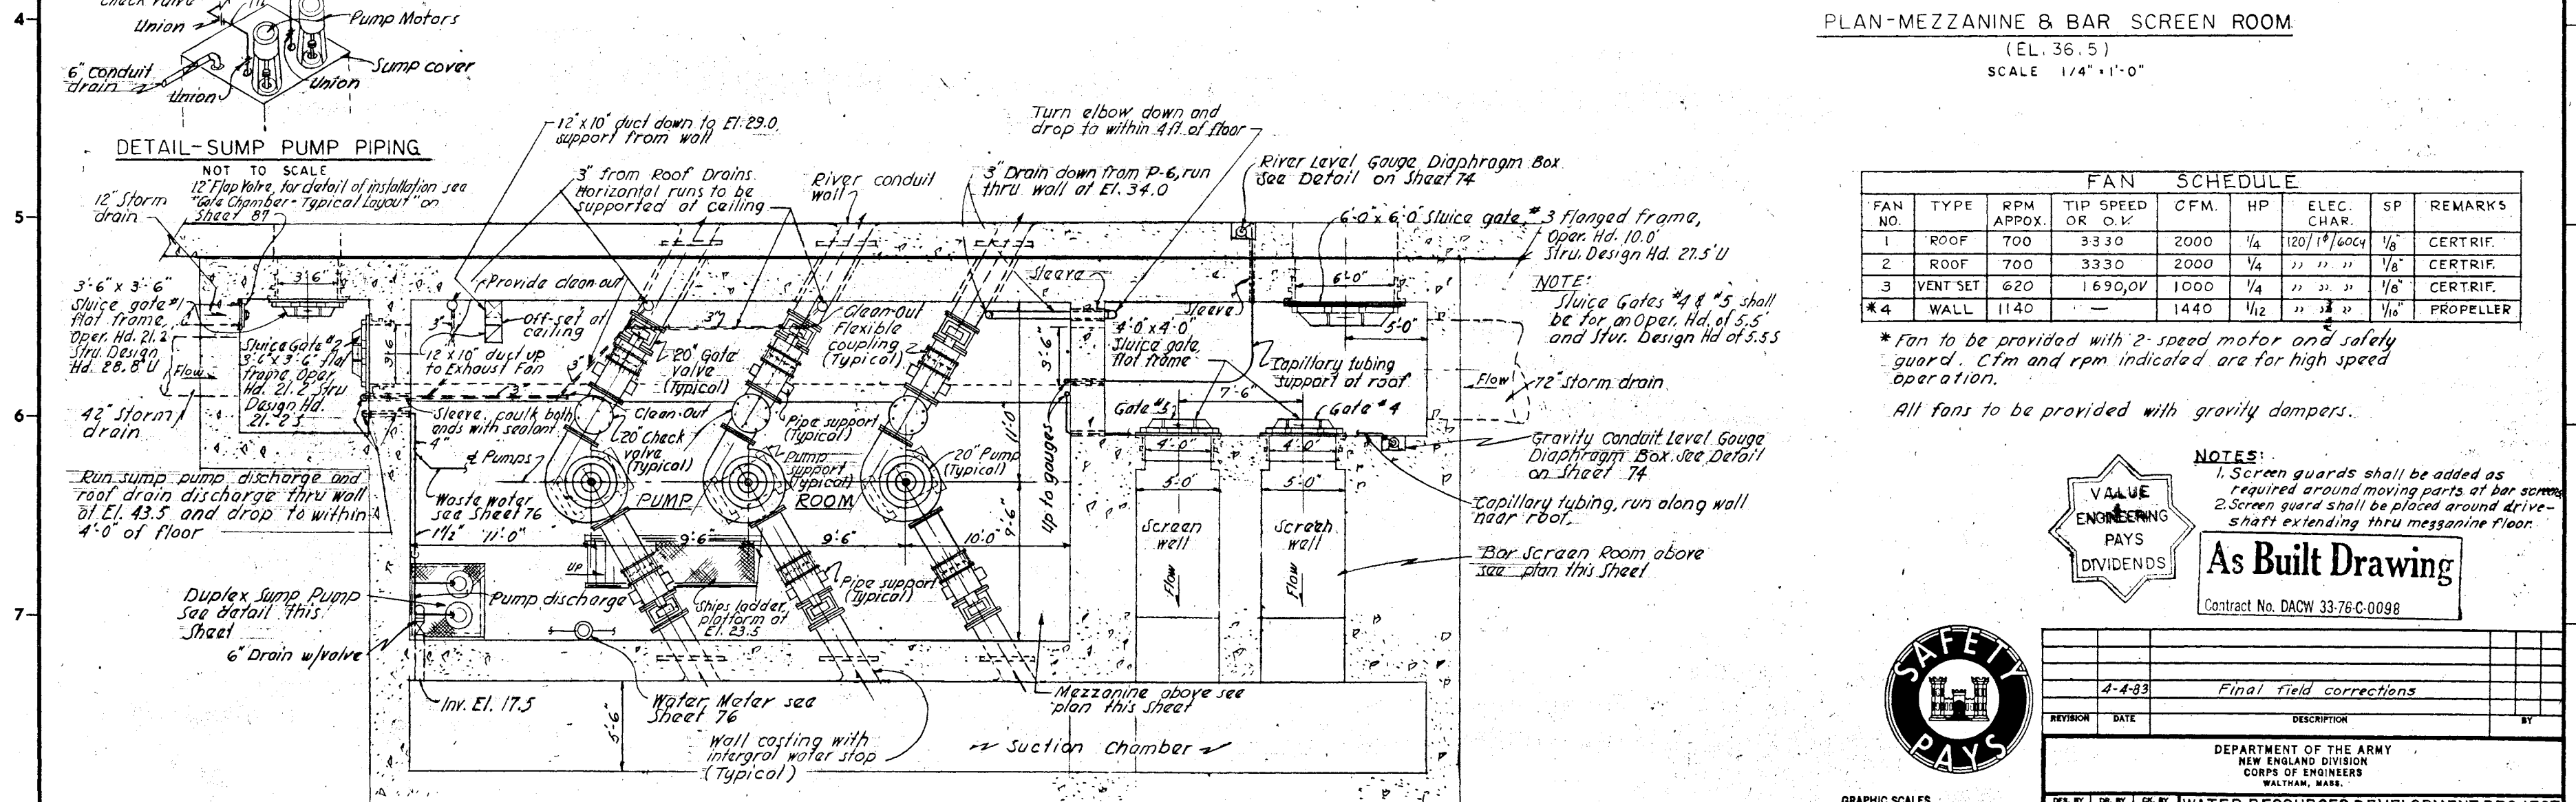


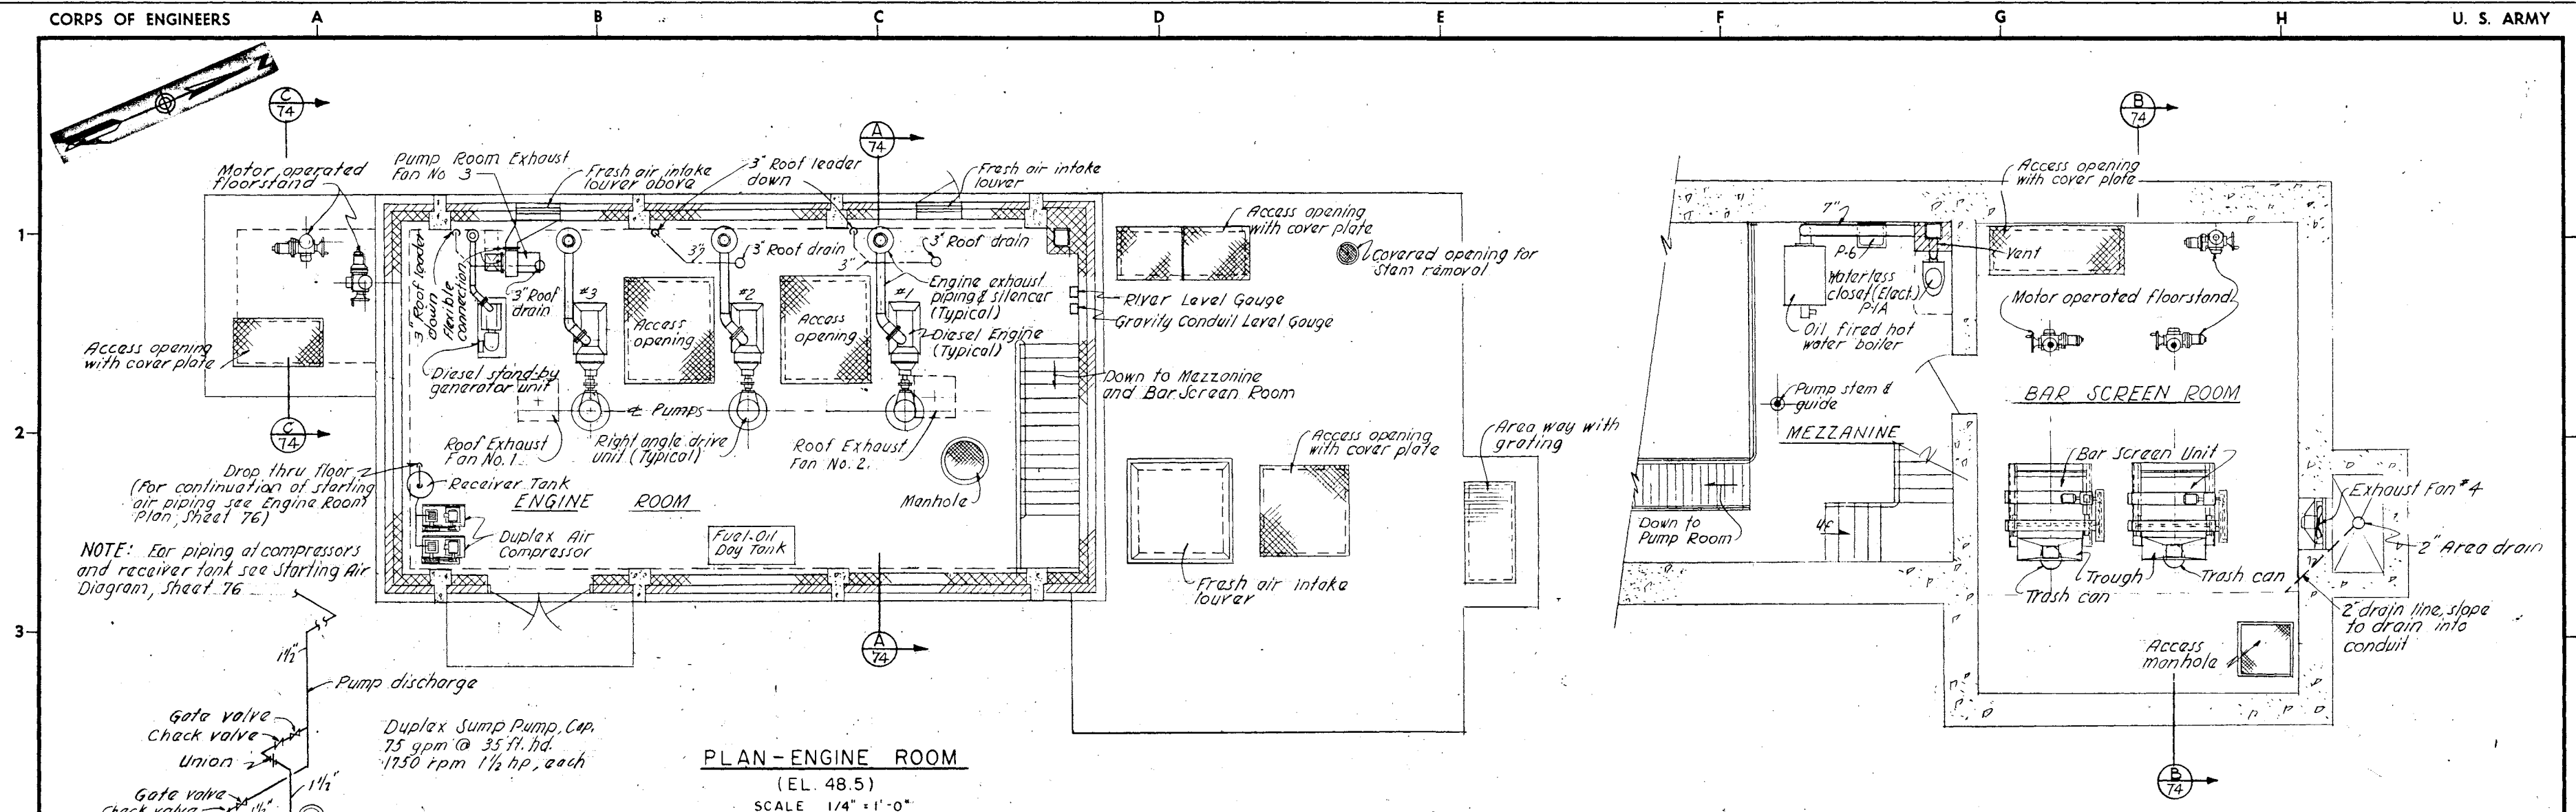

FAN SCHEDULE									
FAN NO.	TYPE	RPM APPROX.	TIP SPEED OR O.V.	CFM	HP	ELEC. CHAR.	SP	REMARKS	
1	ROOF	700	3330	2000	1/4	120/110/60C4	1/8	CERTIF.	
2	ROOF	700	3330	2000	1/4	" " "	1/8	CERTIF.	
3	VENT SET	620	1690, OV	1000	1/4	" " "	1/8	CERTIF.	
*4	WALL	1140	—	1440	1/2	" " "	1/16	PROPELLER	

* Fan to be provided with 2-speed motor and safety guard. Cfm and rpm indicated are for high speed operation.

All fans to be provided with gravity dampers.

- NOTES:**
1. Screen guards shall be added as required around moving parts at bar screen.
 2. Screen guard shall be placed around drive shaft extending thru mezzanine floor.

As Built Drawing

Contract No. DACW 33-76-C-0098



GRAPHIC SCALES

1/4" = 1'-0"

DES. BY J.T.S.	DR. BY J.P.V.	CHK. BY J.T.S.	DATE 4-4-83	DESCRIPTION Final field corrections
DEPARTMENT OF THE ARMY NEW ENGLAND DIVISION CORPS OF ENGINEERS WALTHAM, MASS.				
WATER RESOURCES DEVELOPMENT PROJECT PARK RIVER LOCAL PROTECTION POPE PARK PUMPING STATION MECHANICAL-PLAN				
HARTFORD			CONNECTICUT	
APPROVED			DATE MARCH 1978	
SCALE AS SHOWN SPEC. NO. DACW 33-76-B-1040 DRAWING NUMBER PAR-1				