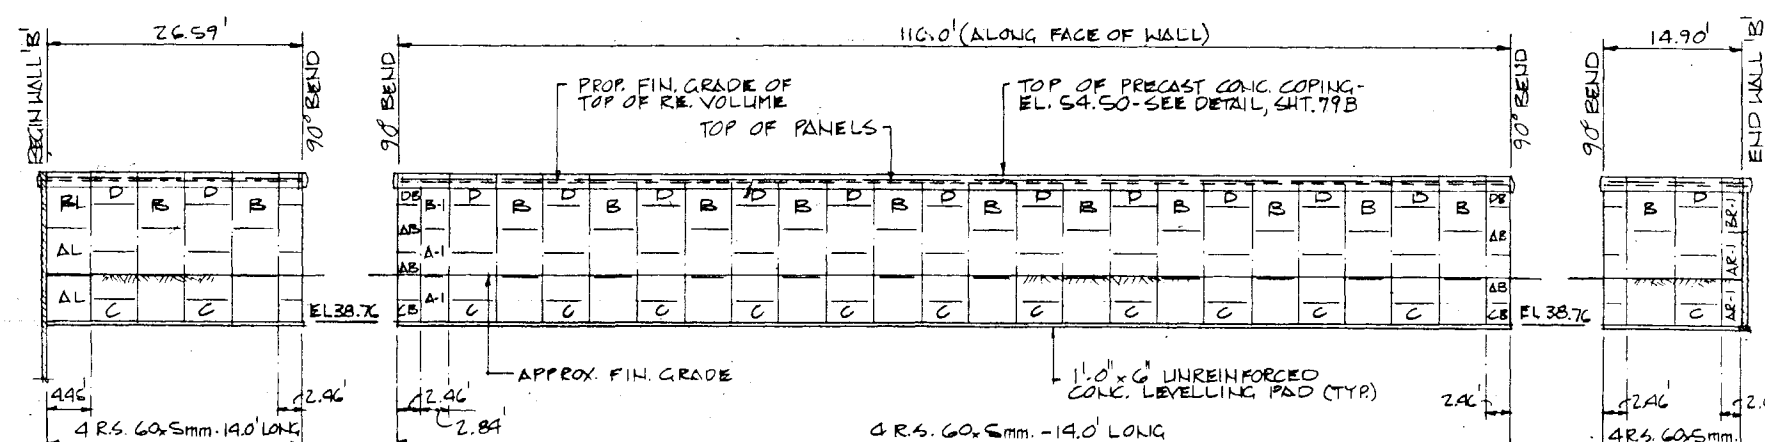
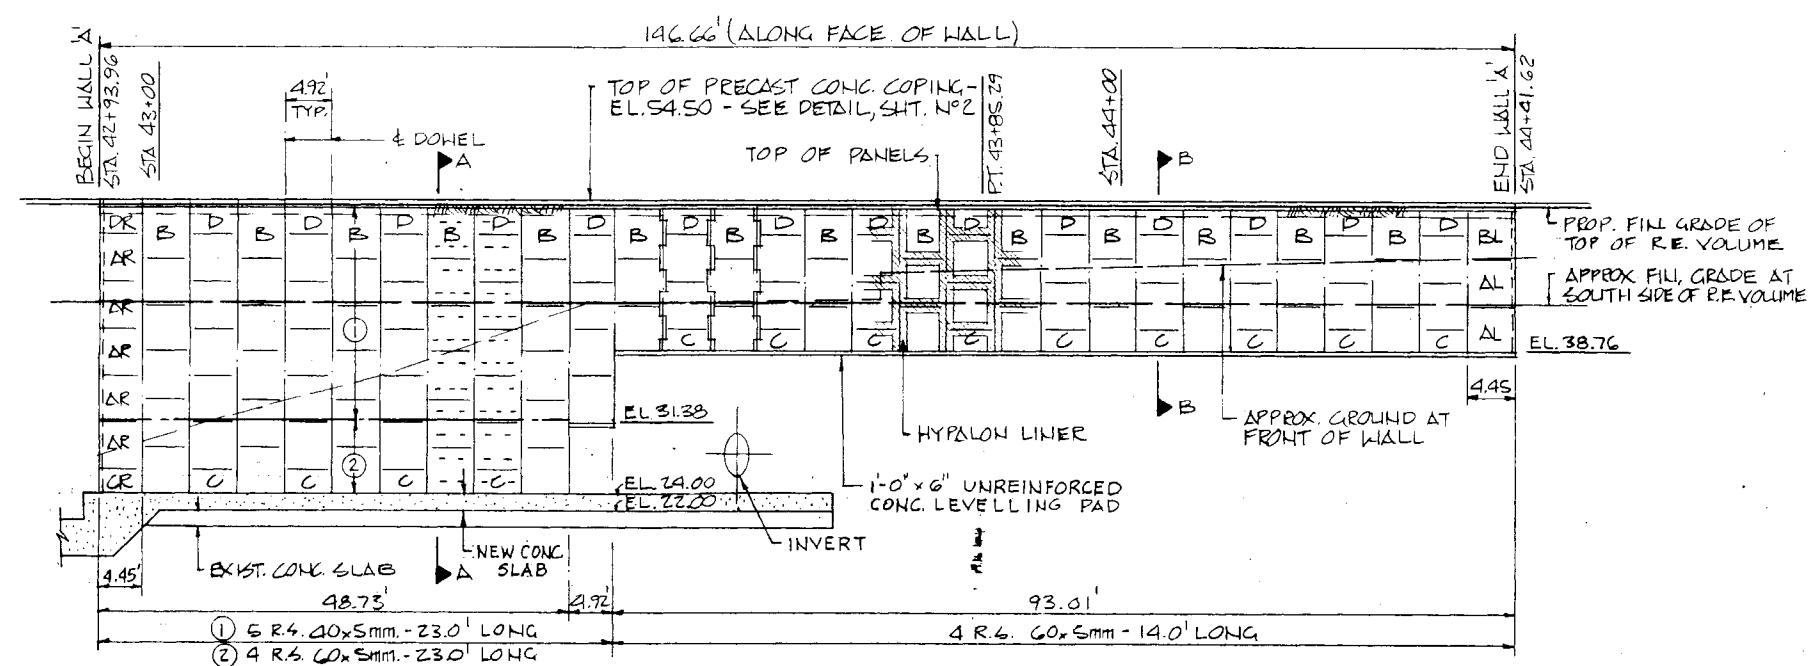
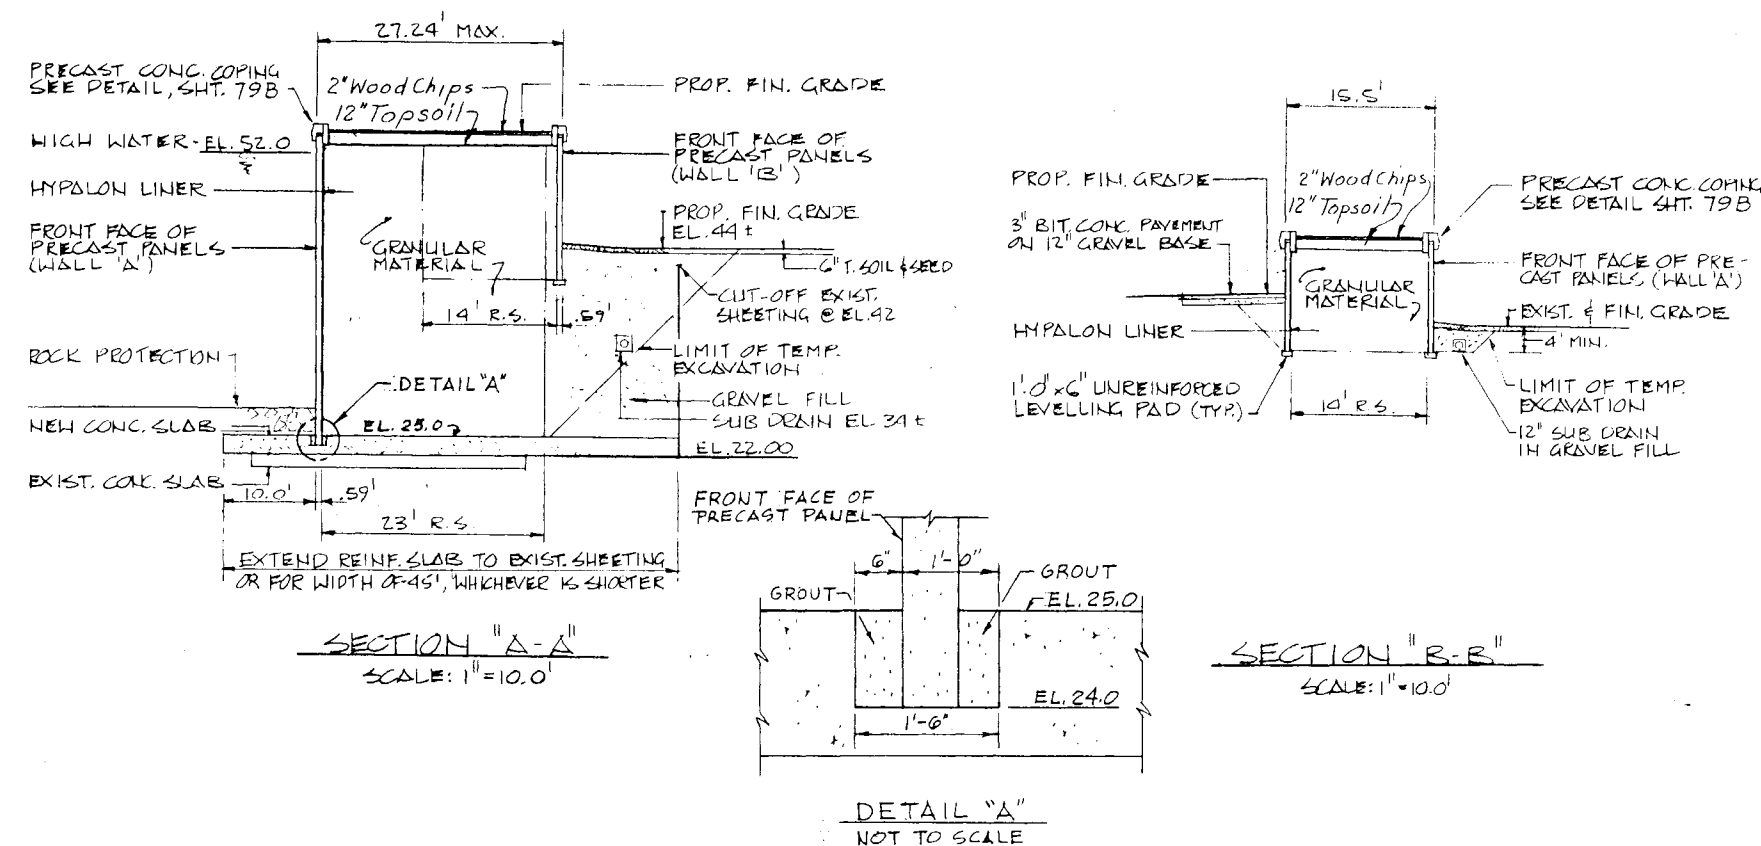
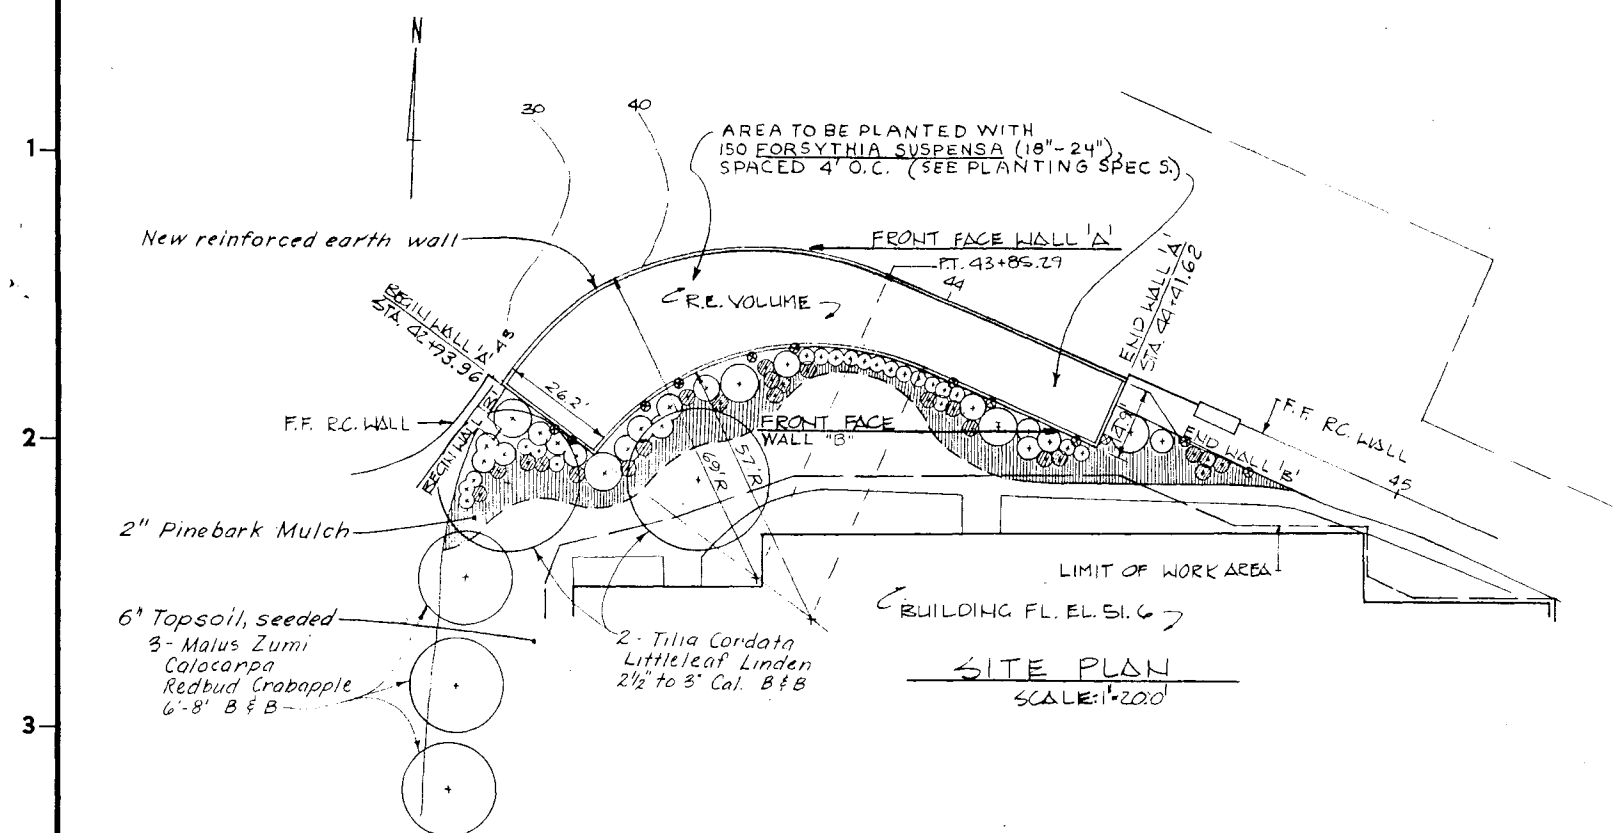


ELEVATIONS
SCALE: 1"=10.0'

REINFORCING STRIP SCHEDULE		
TYPE	LENGTH	QUANTITY
40x5mm	14.0'	23.0'
60x5mm	6.24	60

TOTAL PANEL SURFACE AREA: 5,293.6 SQ. FT.

PANEL SCHEDULE	
TYPE	QUANTITY
1	27.23
2	106.23
3	35.5
4	24.2
5	24.2
6	24.2
100	24.2

PLANTING LEGEND

- 3 MALUS ZUMI CALOCARPA
REDBUD CRABAPPLE 6'-8" B & B
- 2 TILIA CORDATA
LITTLELEAF LINDEN 2 1/2"-3" Cal. B & B
- 23 AZALEA KAEMPFERII "FEDORA"-3' O.C.
FEDORA AZALEA 15"-18" Cont.
- 21 BERBERIS THUNBERGI - 3' O.C.
JAPANESE BARBERRY 2'-3' B & B

- 5 RHODODENDRUM CATAWBIENSE ALBUM
WHITE CATAWBA RHODODENDRUM 2 1/2"-3' B & B
- 17 KALMIA LATIFOLIA - 5' O.C.
MOUNTAIN LAUREL 18"-24" B & B
- 250 HEDERA HELIX BALTICA - 2' O.C.
BALTIC IVY-2 YR. CONTAINER GROWN

- 12 PARTHENOISSUS TRICUSPIDATA VEITCHI
BOSTON IVY 6" POT

As Built Drawing

Contract No. DACW 33-76-C-0098

REVISION	DATE	DESCRIPTION	BY
4-83		Final field corrections	

DEPARTMENT OF THE ARMY
NEW ENGLAND DIVISION
CORPS OF ENGINEERS
WALTHAM, MASS.


WATER RESOURCES DEVELOPMENT PROJECT
PARK RIVER LOCAL PROTECTION

BOX CONDUIT AT SECTION 9
EAST FLOOD WALL DETAILS NO. 1

HARTFORD CONNECTICUT
APPROVED *John B. Fryer* DATE APRIL 1979
CHIEF, ENGINEERING DIVISION

SCALE AS SHOWN SPEC. NO. DACW 33-76-B-0040
DRAWING NUMBER
PAR-1

SHEET 79A
DATE: 3-22-79

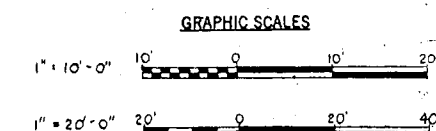

This drawing contains information proprietary to The Reinforced Earth Company, and is being furnished for the use of the U.S. Army, Corps of Engineers, only in connection with this project, and the information contained herein is not to be transmitted to any other organization unless specifically authorized in writing by The Reinforced Earth Company. The Reinforced Earth Company is exclusive licensee in the United States under patents issued to Henri Vidal, and the furnishing of this drawing does not constitute an express or implied license under the Vidal patents.