


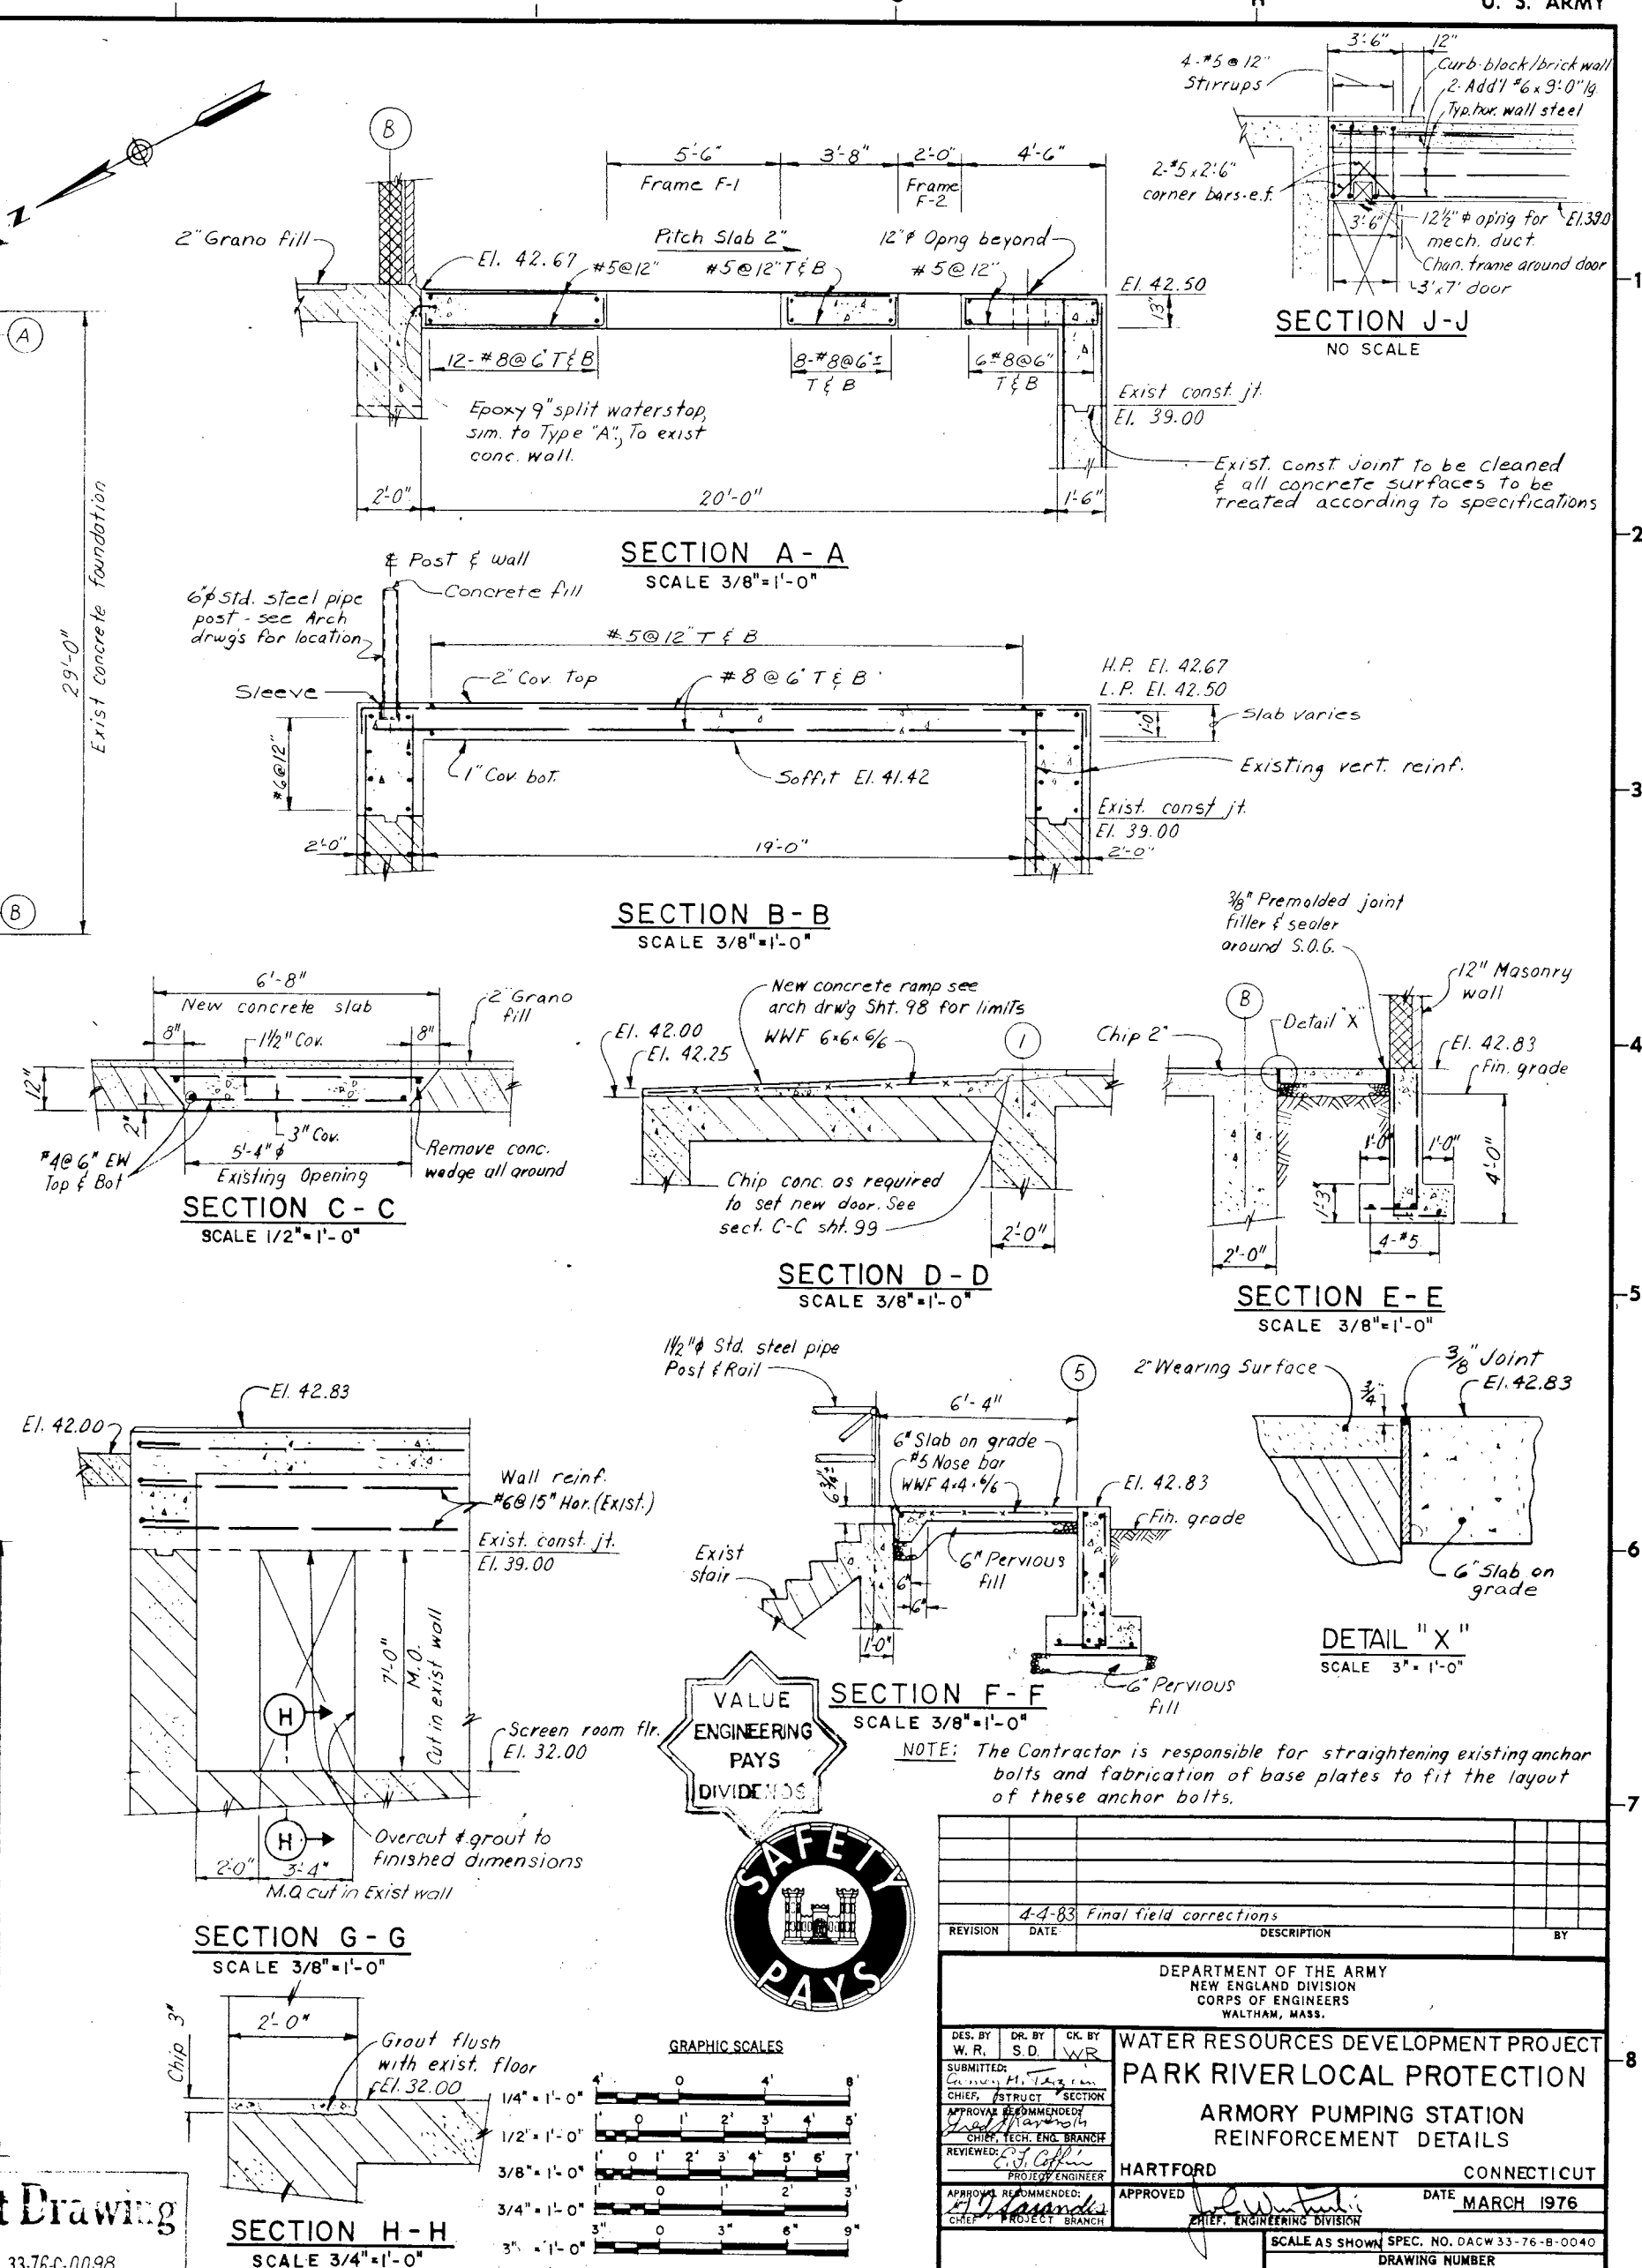

NOTE: The Contractor is responsible for straightening existing anchor bolts and fabrication of base plates to fit the layout of these anchor bolts.

[illegible]

DEPARTMENT OF THE ARMY
NEW ENGLAND DIVISION
CORPS OF ENGINEERS
WALTHAM, MASS.

WATER RESOURCES DEVELOPMENT PROJECT
PARK RIVER LOCAL PROTECTION

ARMORY PUMPING STATION
REINFORCEMENT DETAILS

HARTFORD CONNECTICUT
APPROVED *[Signature]* DATE MARCH 1976

CHIEF, ENGINEERING DIVISION

SCALE AS SHOWN SPEC. NO. DACW 33-76-B-0040

DRAWING NUMBER
PAR - 1

SHEET 101

SHEET 101
