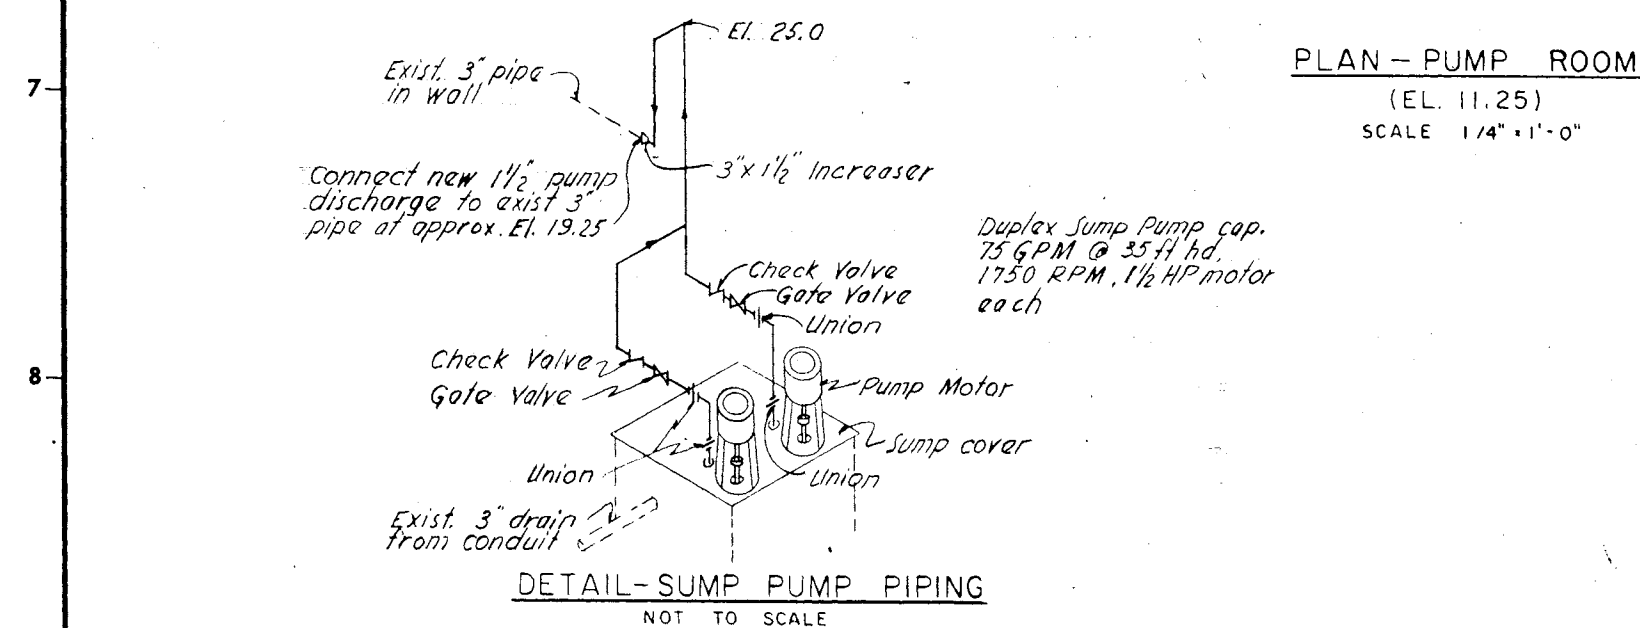
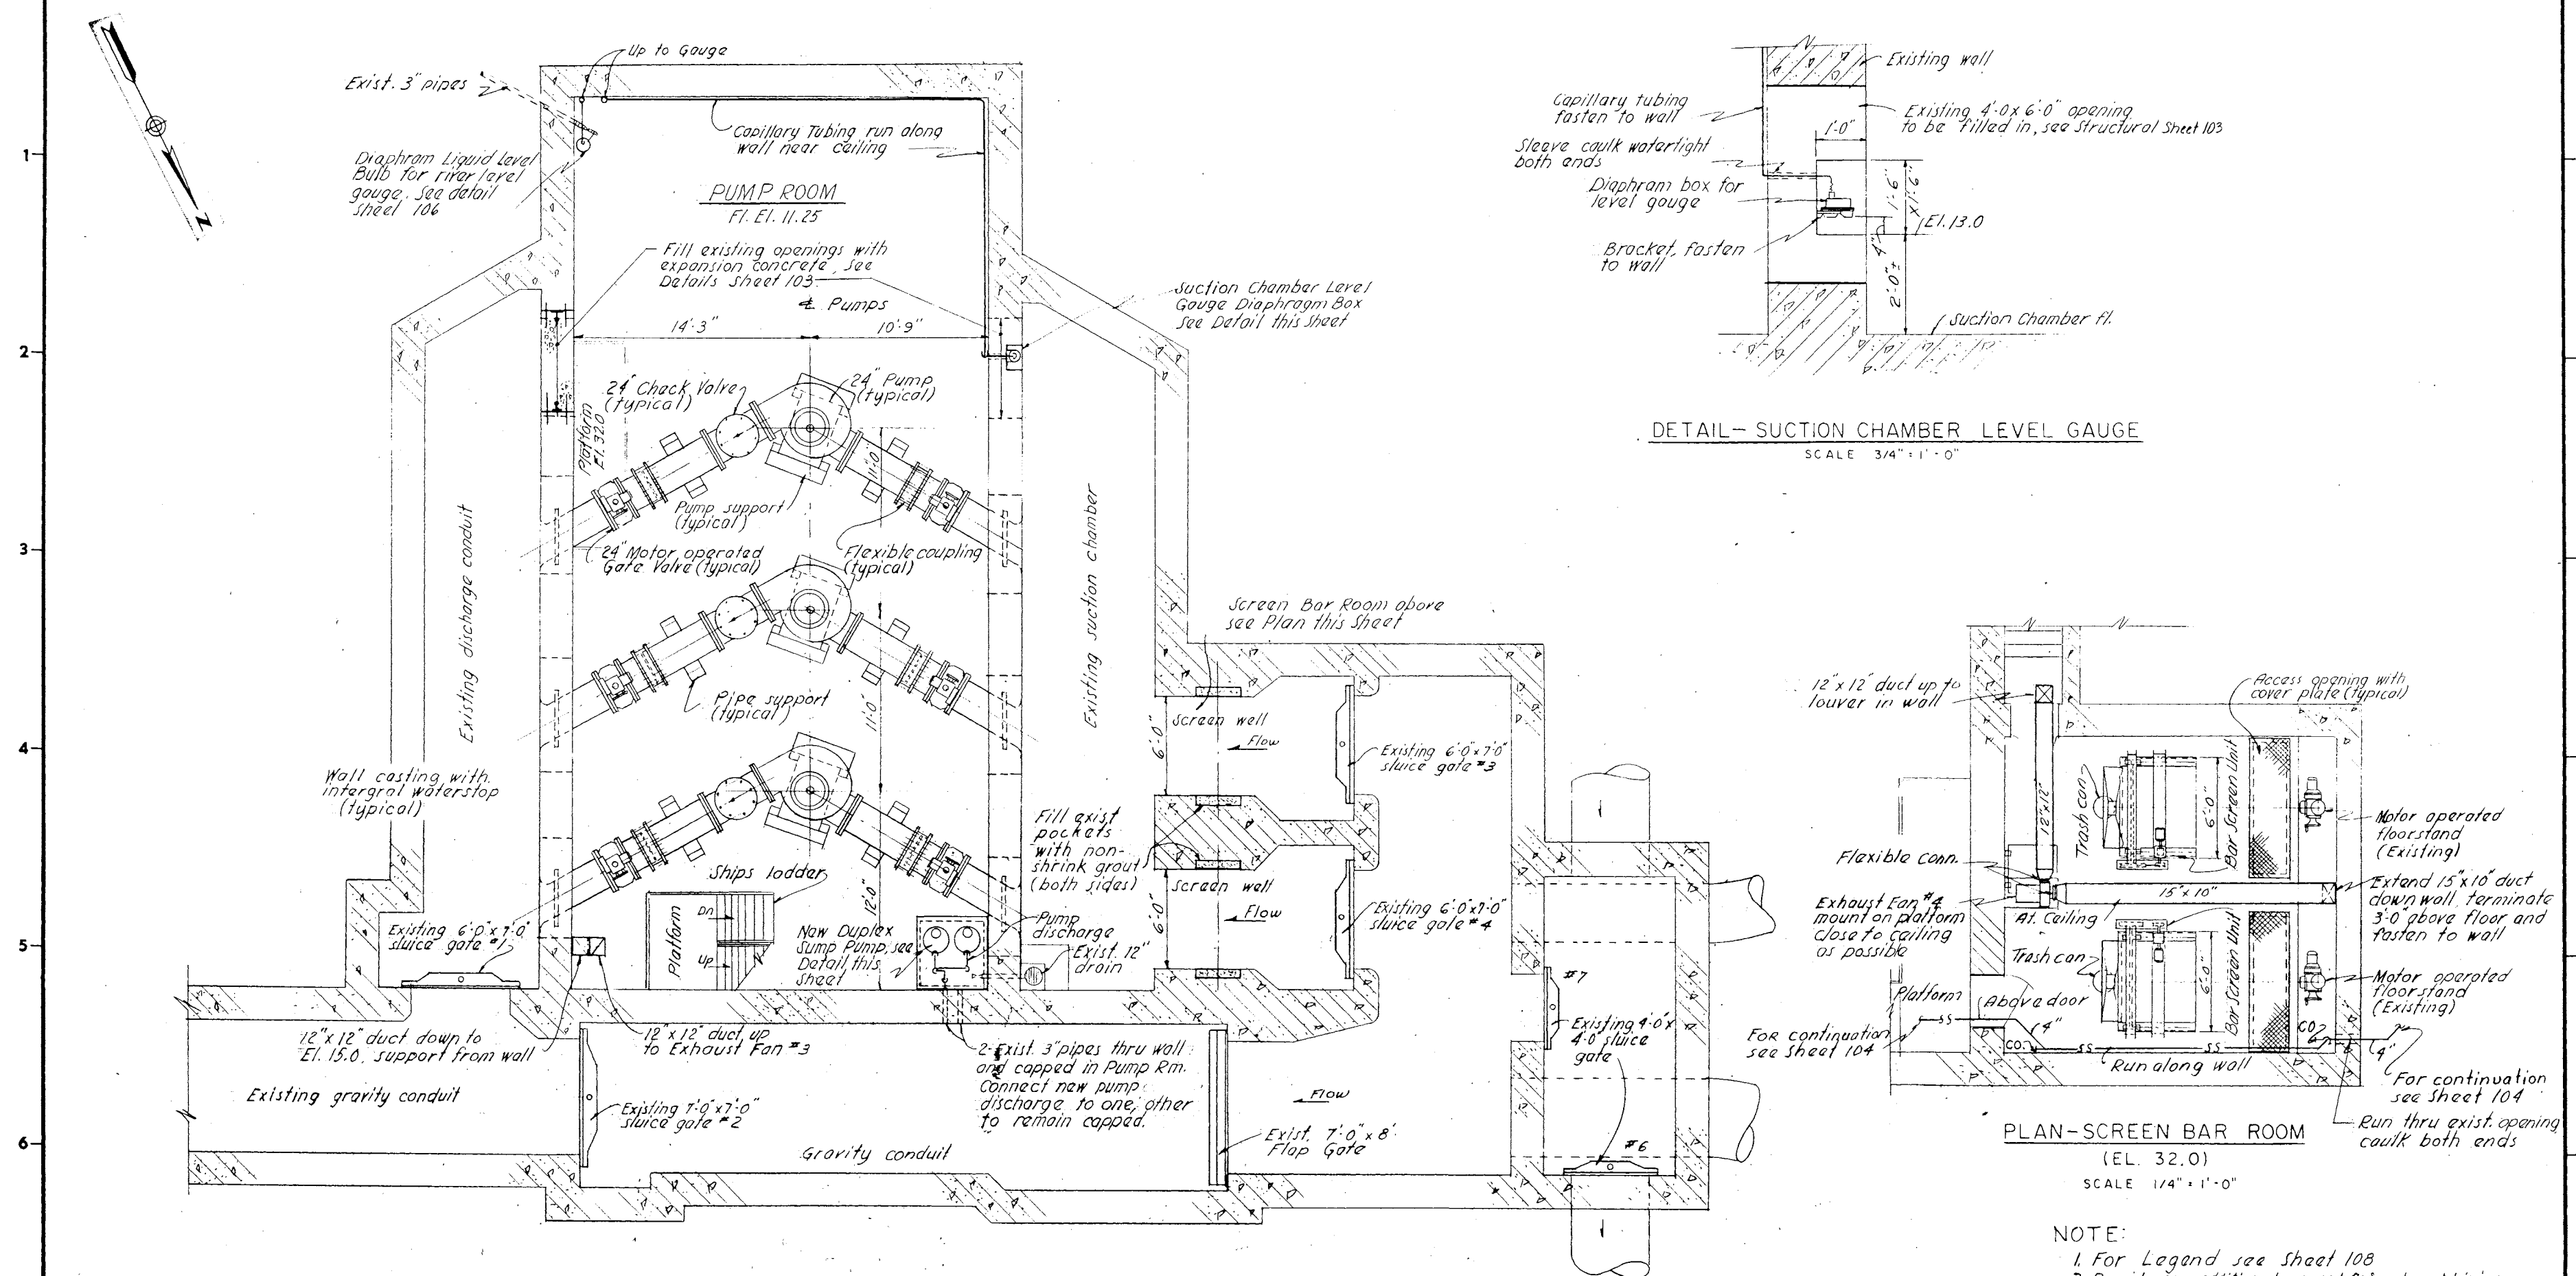


As Built Drawing

Contract No. DALW 33-78C-0098

4-4-83		Final field corrections	
REVISION	DATE	DESCRIPTION	BY
DEPARTMENT OF THE ARMY NEW ENGLAND DIVISION CORPS OF ENGINEERS WALTHAM, MASS.			
WATER RESOURCES DEVELOPMENT PROJECT PARK RIVER LOCAL PROTECTION ARMORY PUMPING STATION MECHANICAL PLANS NO. 2			
HARTFORD		CONNECTICUT	
APPROVED		DATE MARCH 1976	
CHIEF PROJECT BRANCH		CHIEF ENGINEERING DIVISION	
SCALE AS SHOWN		SPEC. NO. DACW 33-78-B-0040	
DRAWING NUMBER		PAR-1	
SHEET 103			