
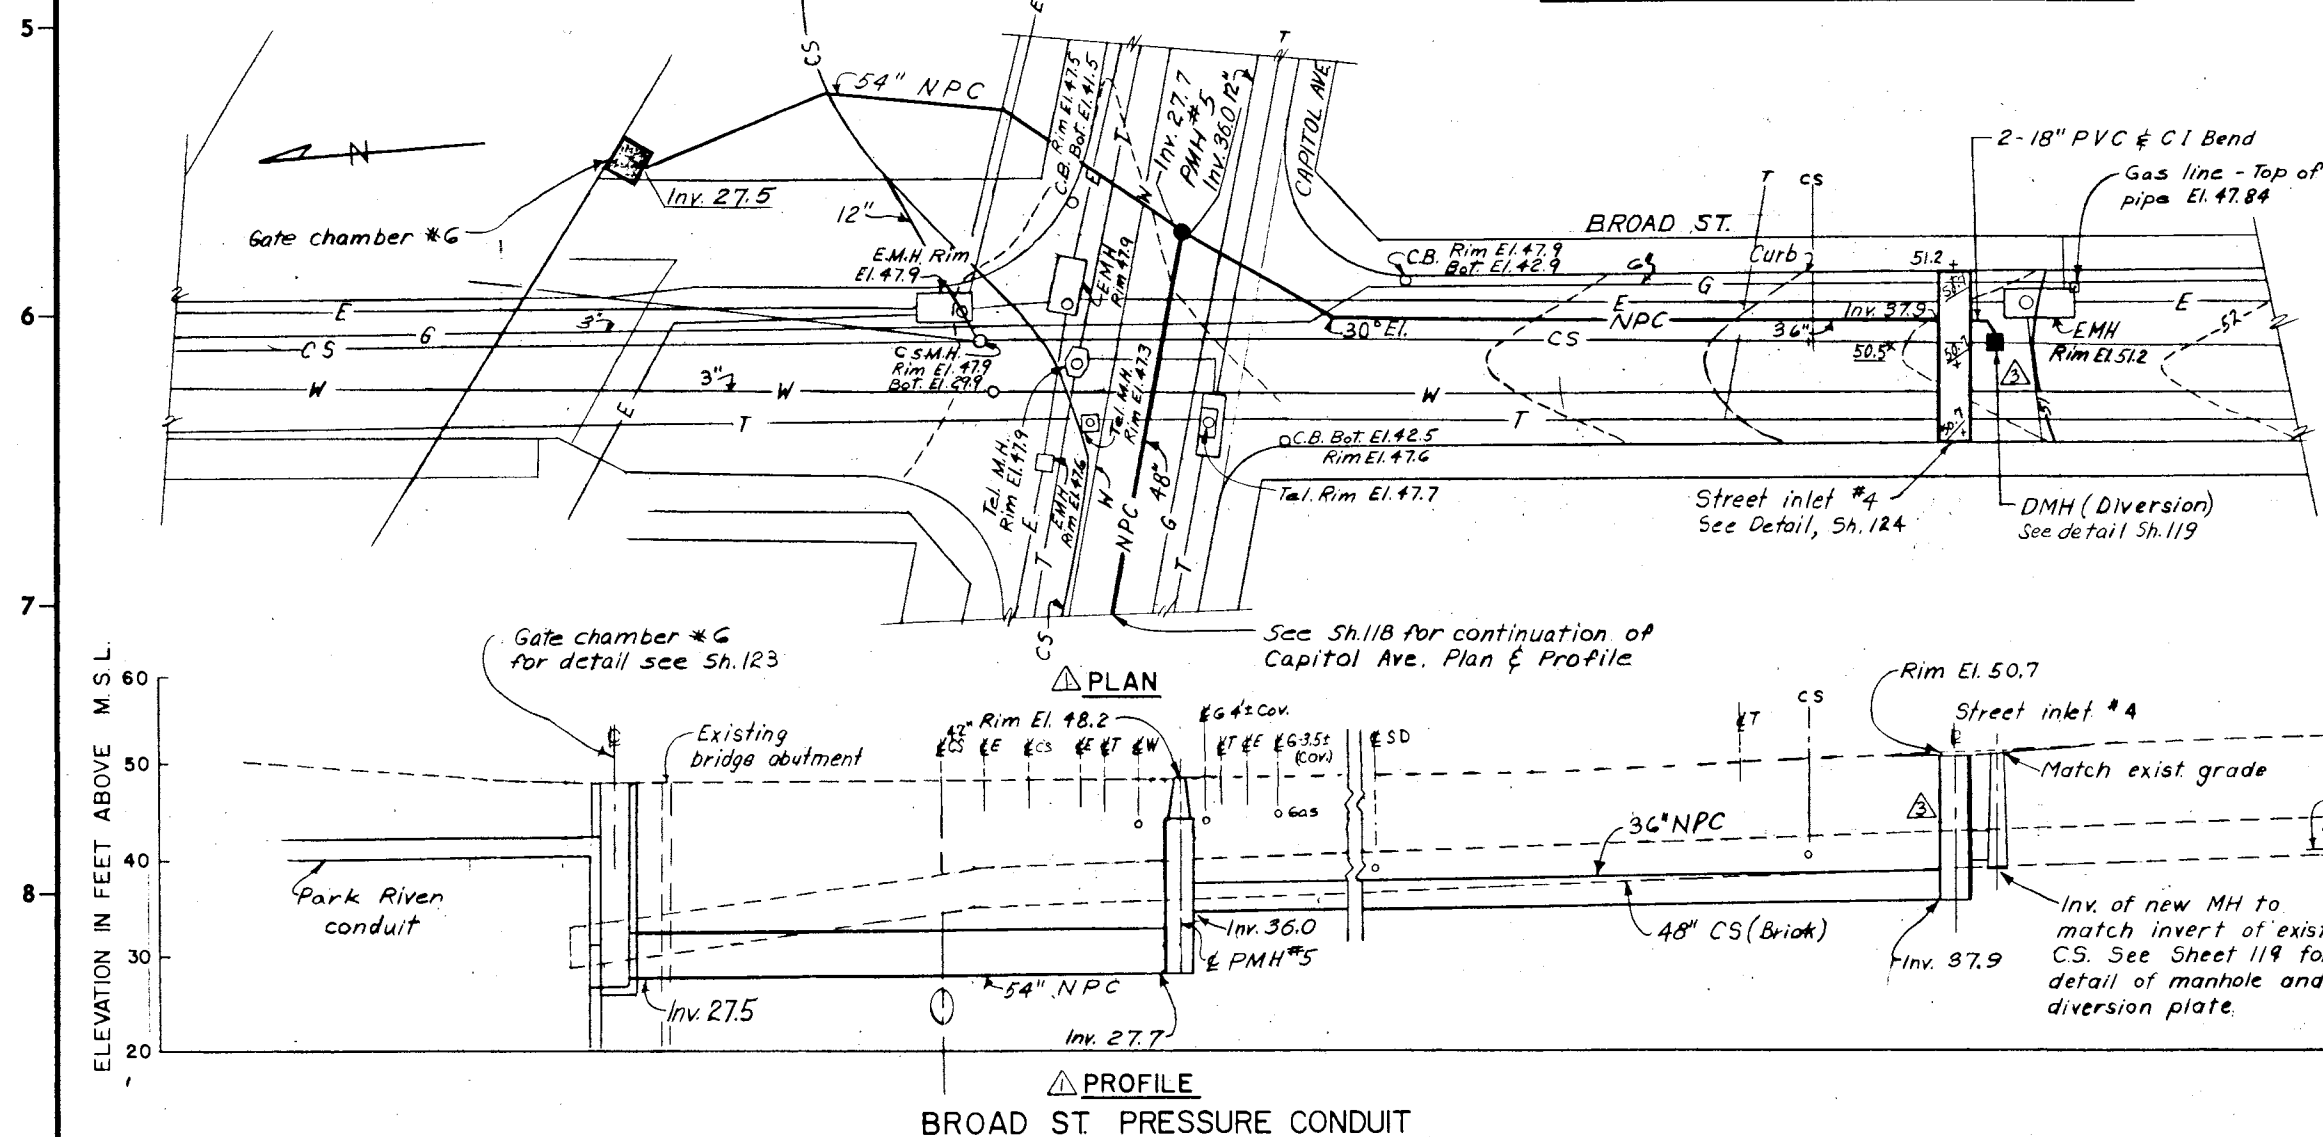
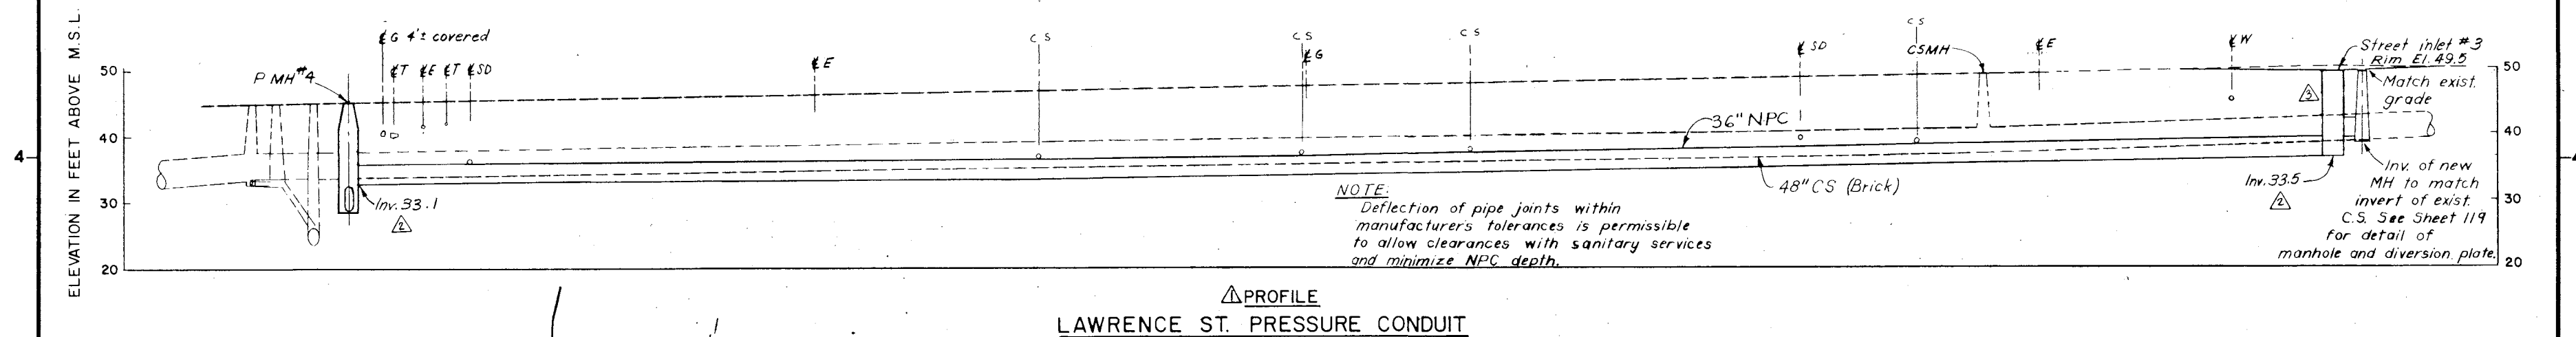
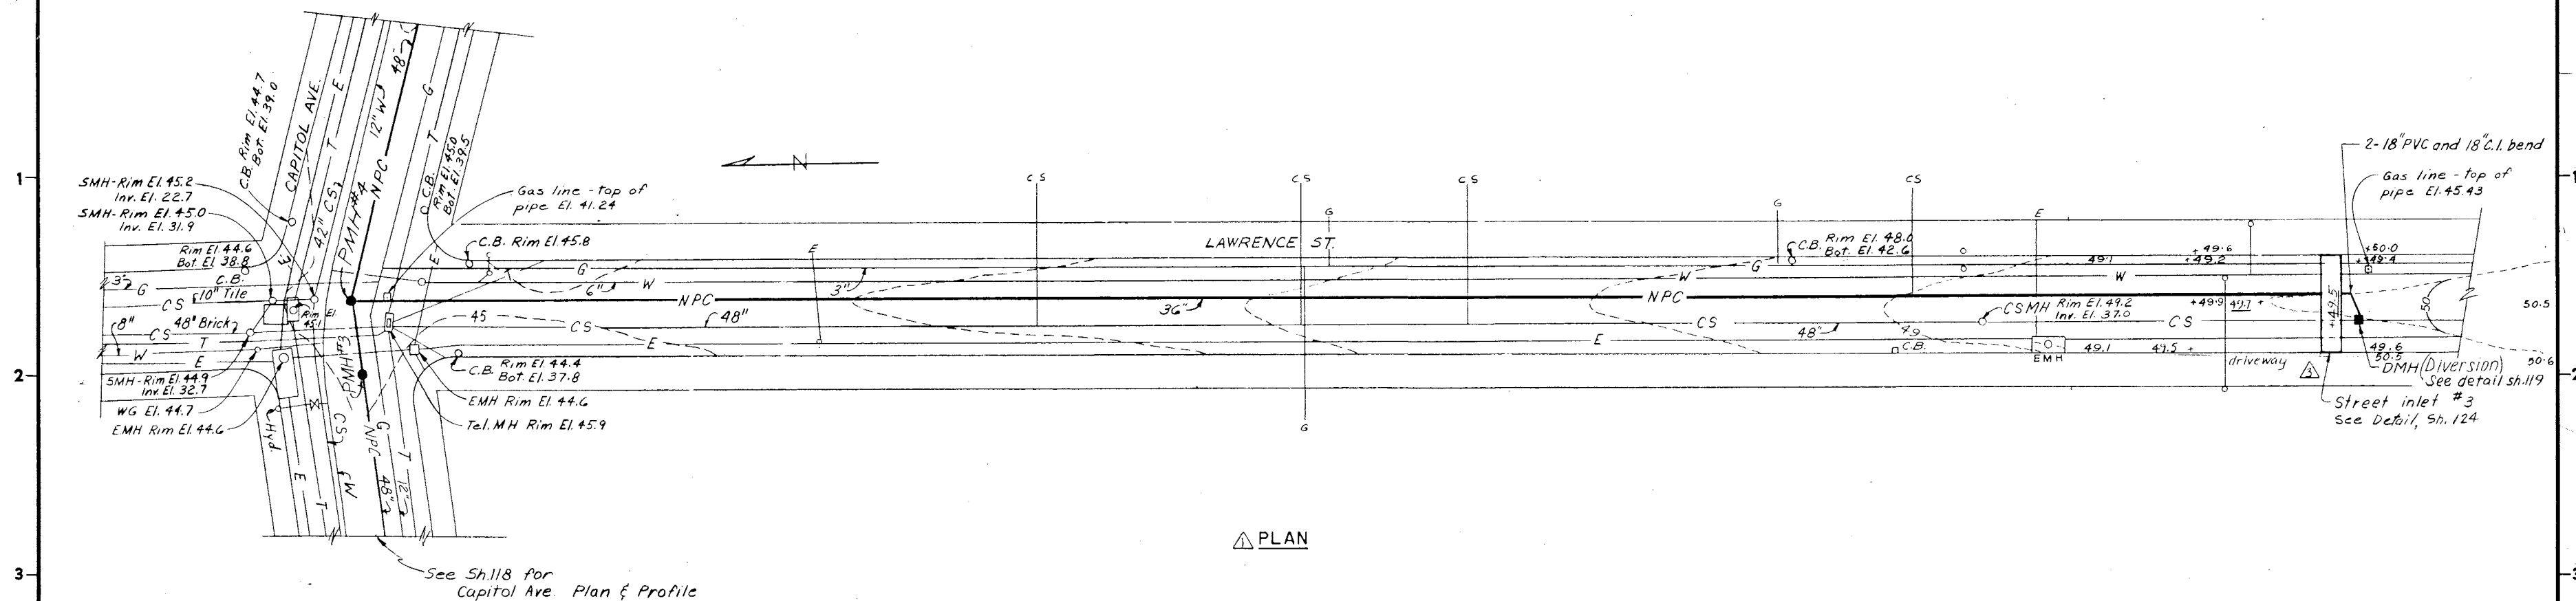


As Built Drawing

Contract No. DACW 33.76C 0098

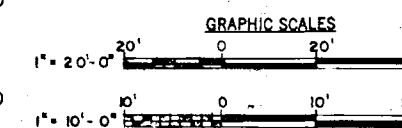

REVISION	DATE	DESCRIPTION	BY
4-4-83		Final field corrections	
25M, 71		Plan and Profile revised	BL/JH
300x78		Profile revised (Lawrence St)	BL/JH
5APR71		Plans and Profiles revised	BL/JH

DEPARTMENT OF THE ARMY
NEW ENGLAND DIVISION
CORPS OF ENGINEERS
WALTHAM, MASS.

WATER RESOURCES DEVELOPMENT PROJECT
PARK RIVER LOCAL PROTECTION

HIGH LEVEL DRAINAGE
PLAN AND PROFILE NO. 2

HARTFORD CONNECTICUT

APPROVED *[Signature]* DATE MARCH 1976

SCALE AS SHOWN SPEC. NO. DACW33-76-B-0040

DRAWING NUMBER
PAR - I

SHEET 117