



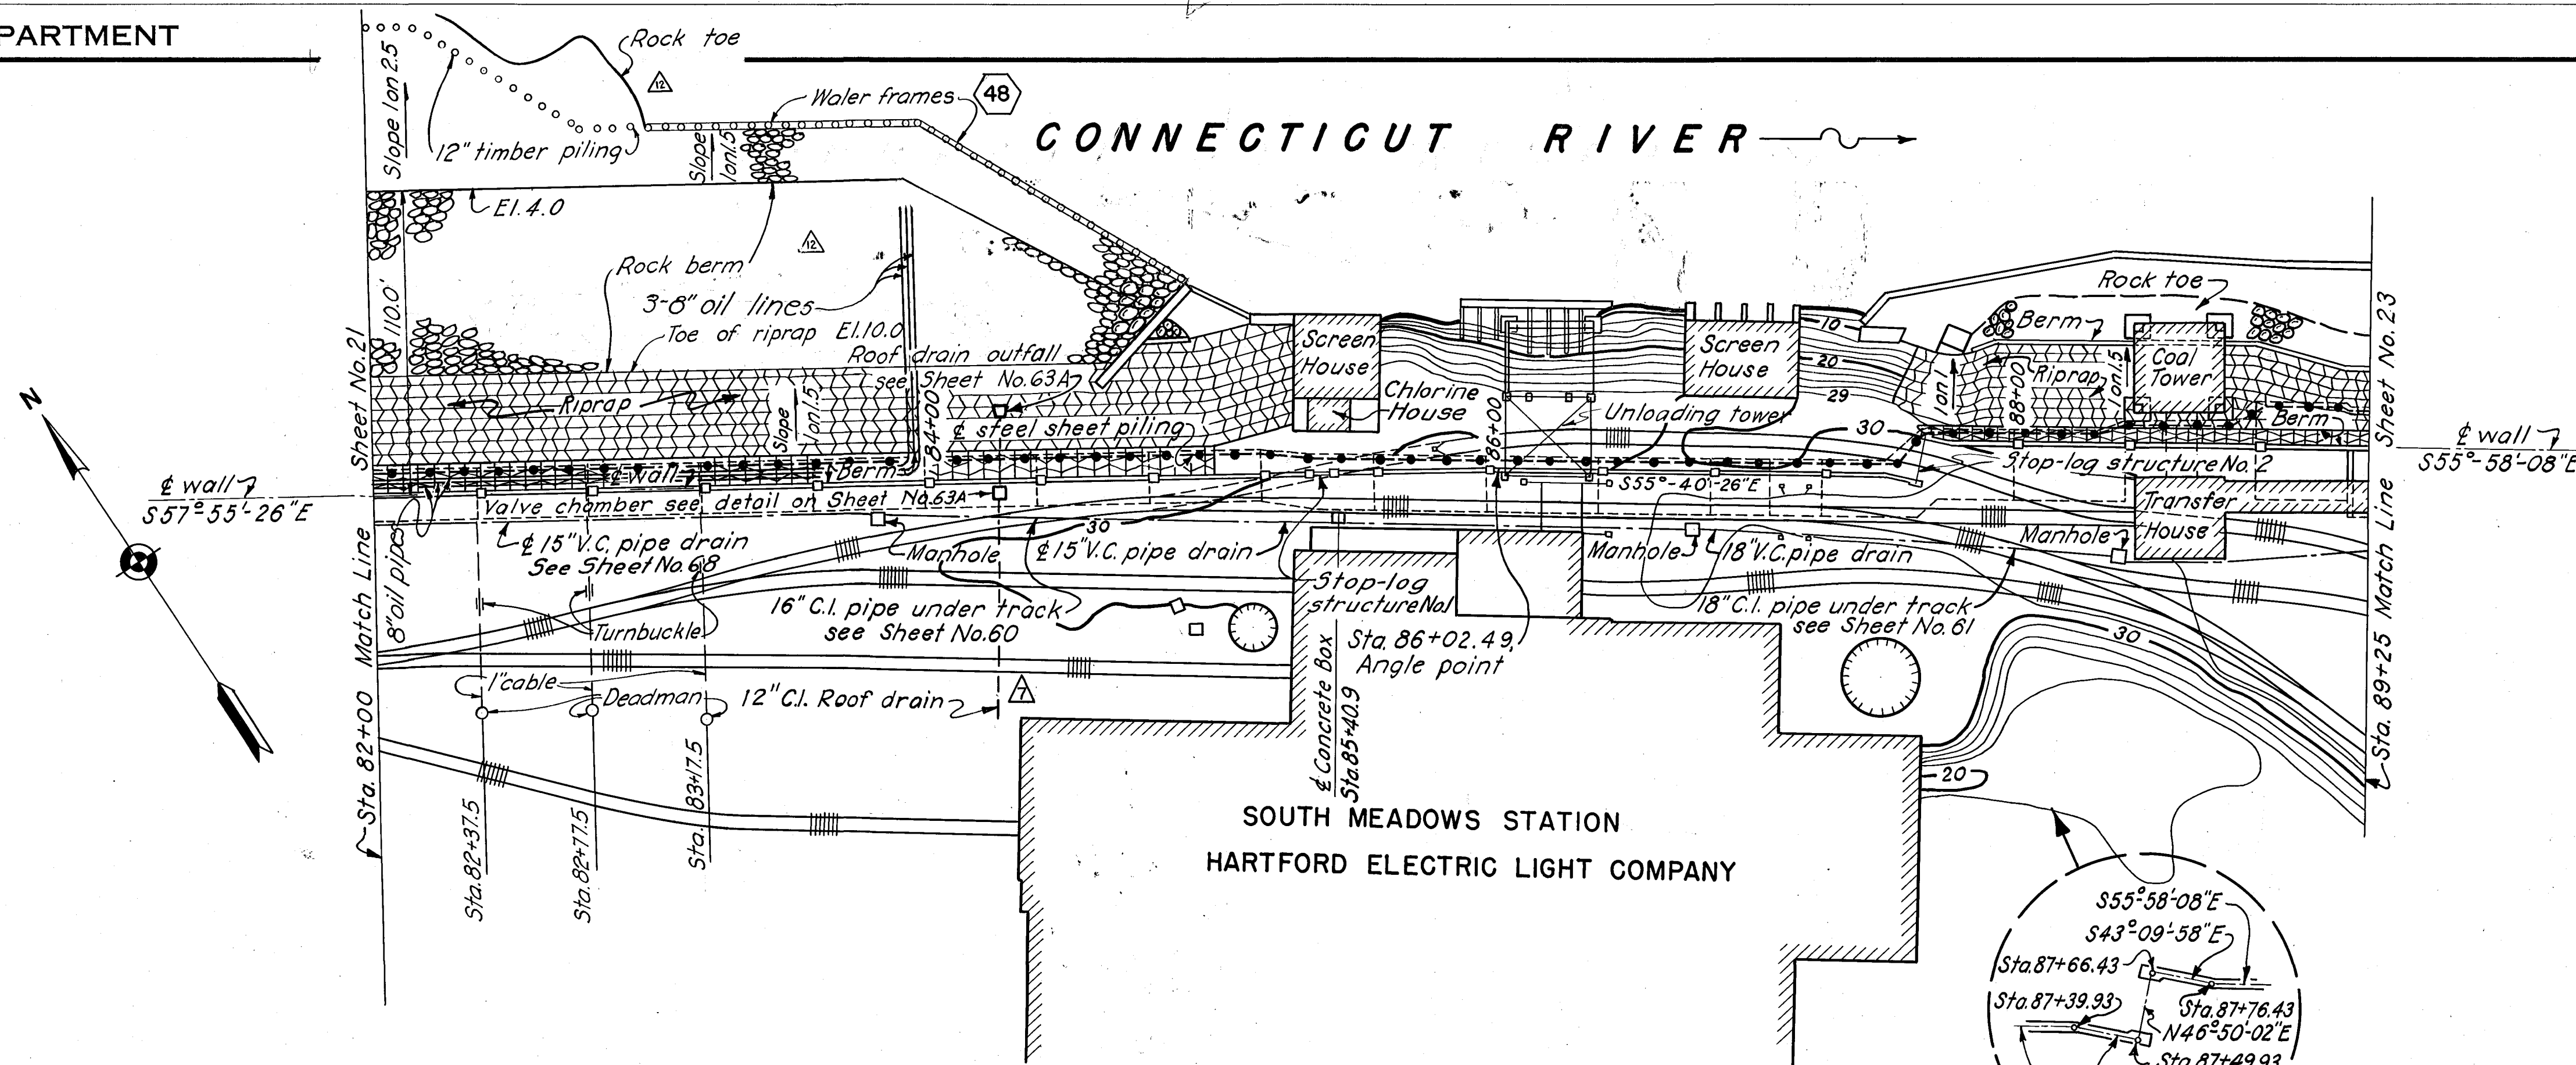

SOUTH MEADOWS STATION
HARTFORD ELECTRIC LIGHT COMPANY

PLAN
SCALE: 1" = 40'

Note: Payment for additional work on concrete wall, made necessary by delay resulting from slide, to be made under Item No. 51 - Cleaning reinforcing steel and Miscellaneous Extra Work on Concrete. Limits of work Sta. 80+37.50 to 83+77.50.


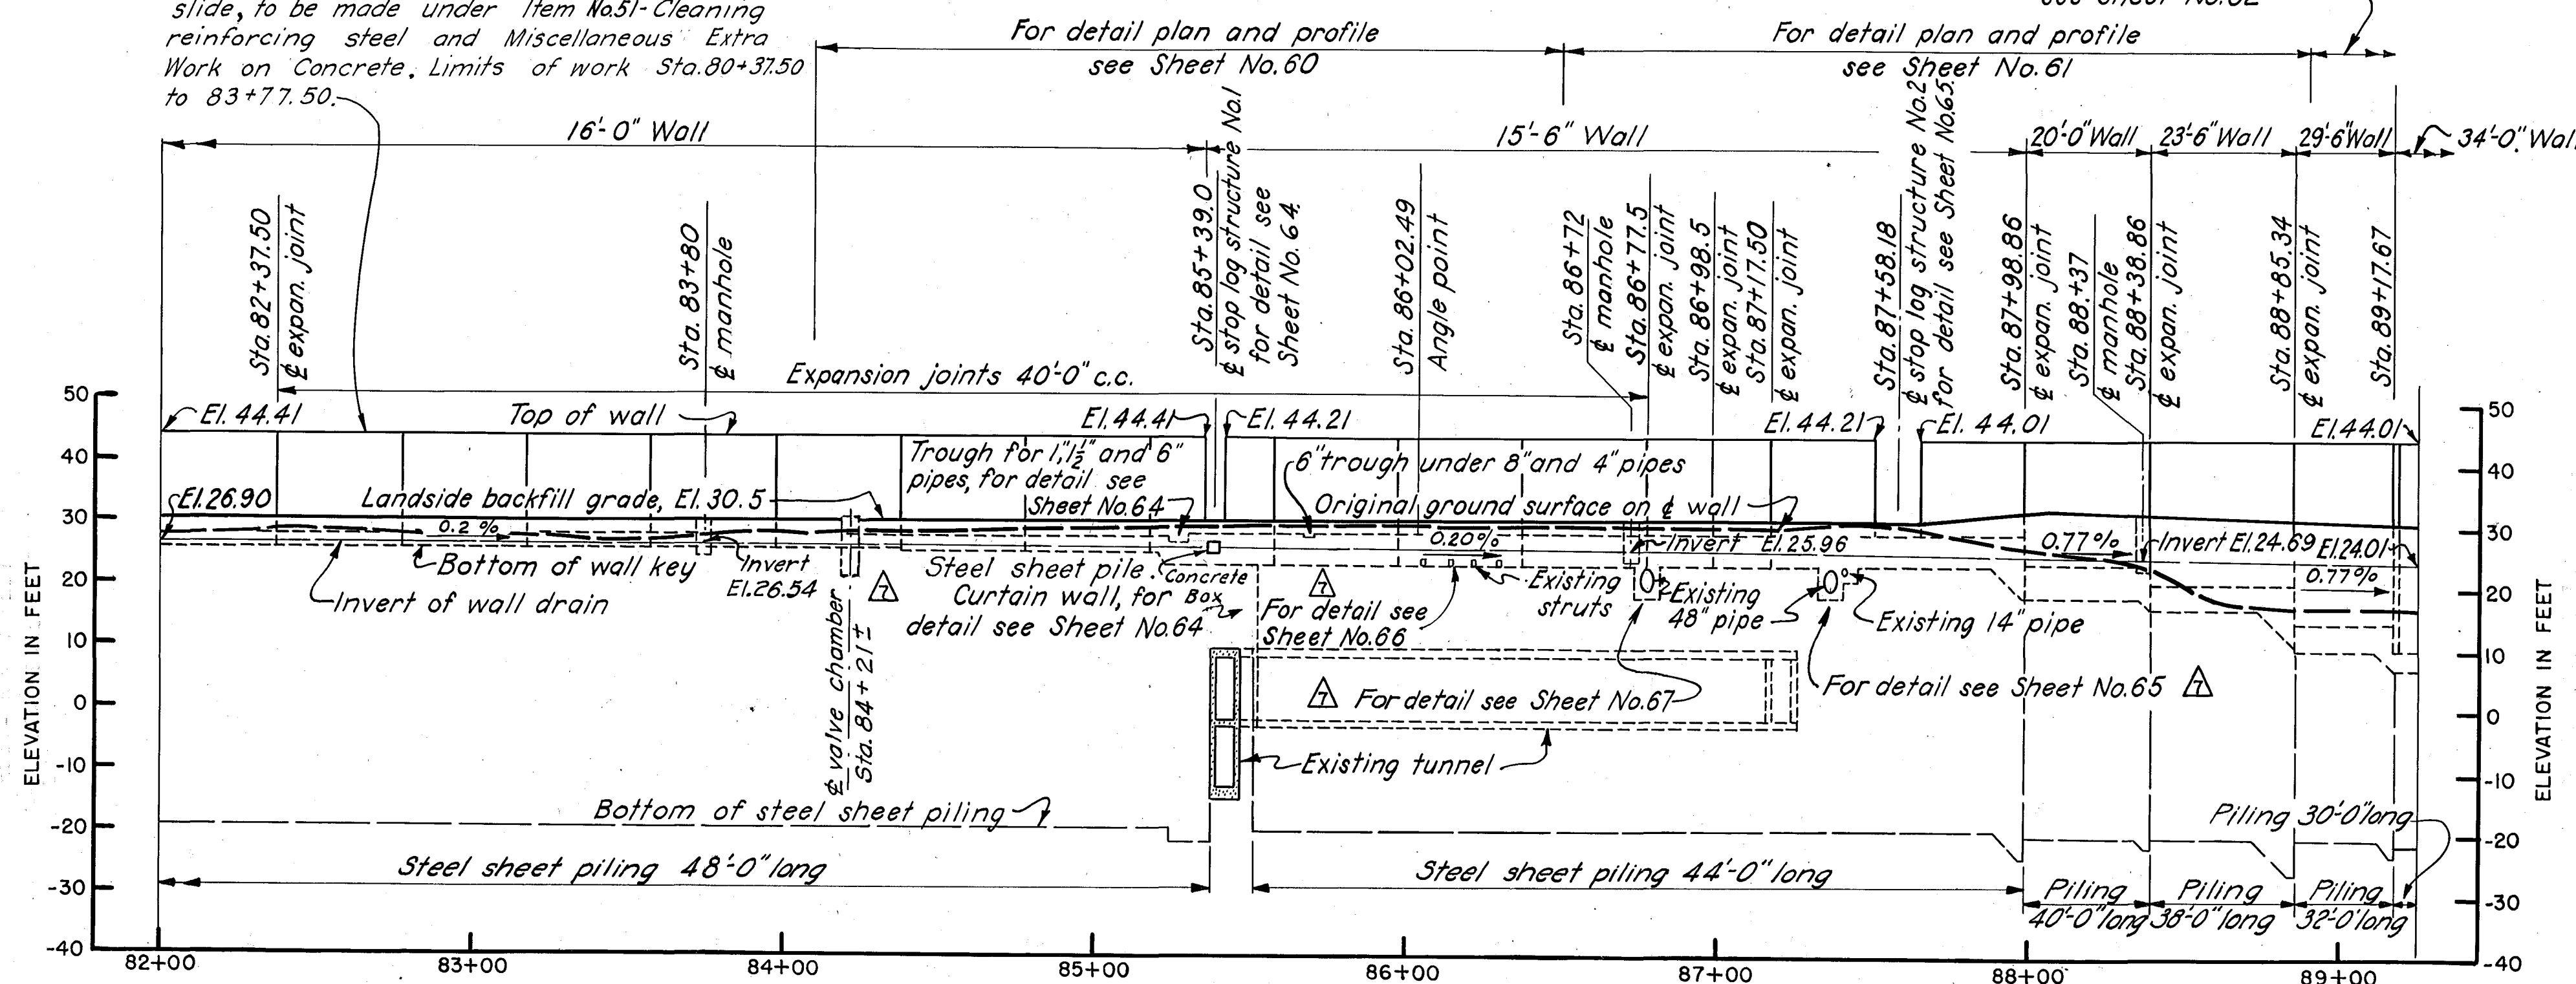


PROFILE
HOR. 1" = 40'
VERT. 1" = 20'

STATION COORDINATES		
STATION	NORTHINGS	EASTINGS
L Sta. 86+02.49	N-45795.10	E-74739.50
L Sta. 87+39.93	N-45717.60	E-74853.0
L Sta. 87+49.93	N-45710.31	E-74859.84
L Sta. 87+66.43	N-45721.60	E-74871.88
L Sta. 87+76.43	N-45714.30	E-74878.72

Stationing is to $\frac{1}{2}$ wall.

12" H beam @ 65' Outer edge of flange to be rolled slightly to avoid cutting of cable.

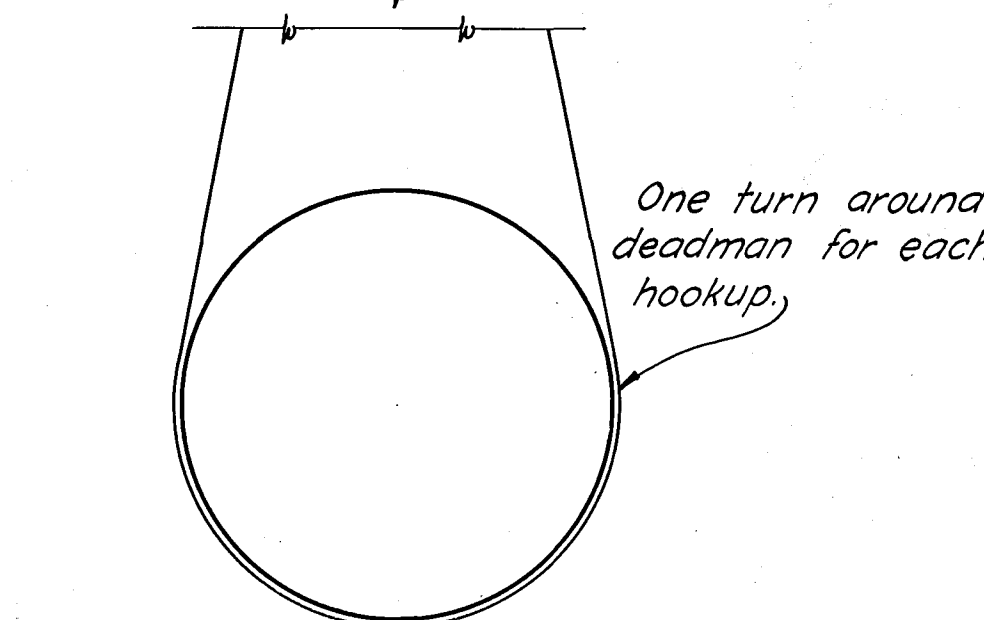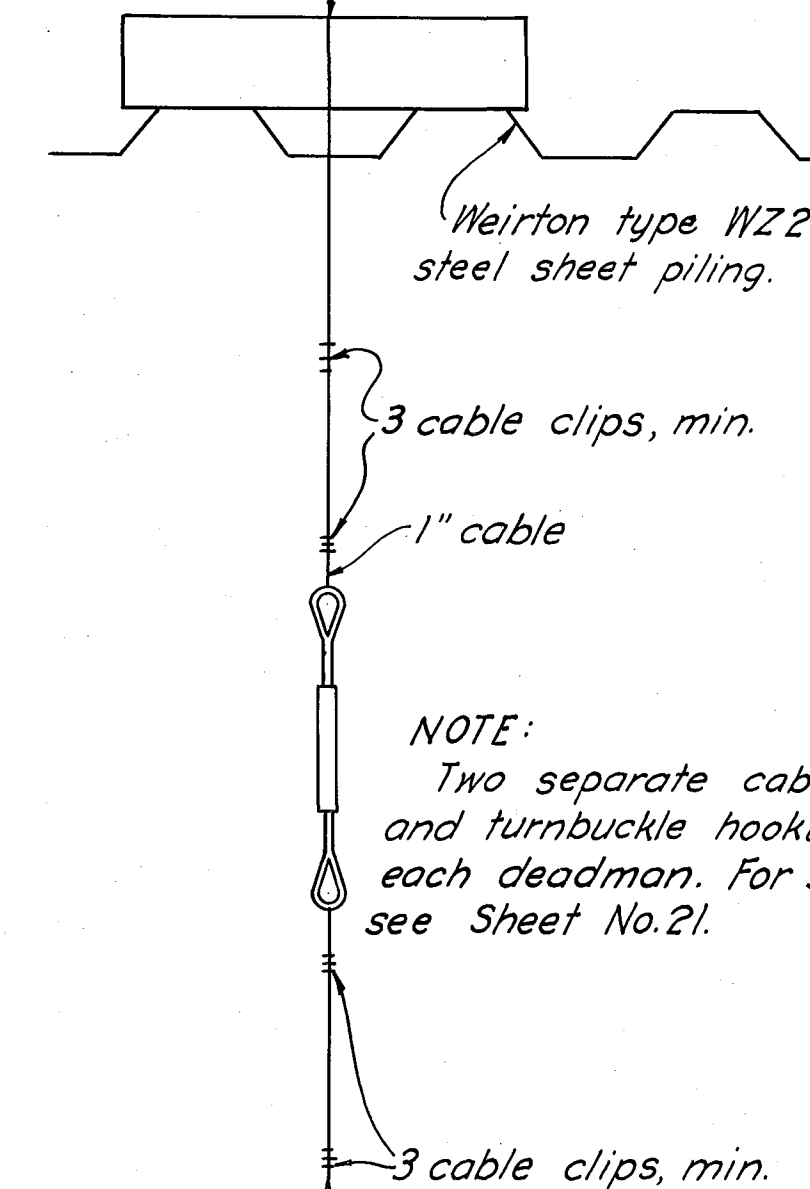

DETAIL OF CABLE HOOKUP

SCALE: 1" = 2'-0"

NOTE
For general notes applying to this sheet see Sheet No. 20.

CONNECTICUT RIVER FLOOD CONTROL			
HARTFORD DIKE			
RIVERFRONT, MORGAN ST. TO STA. 96+73			
PLAN AND PROFILE NO. 11			
CONNECTICUT RIVER		CONNECTICUT	
IN 135 SHEETS		SHEET NO. 22	
SCALE: 1 IN. = 40 FT.			
U.S. ENGINEER OFFICE, PROVIDENCE, R.I., MAY 1940			
SUBMITTED:	APPROVED:	RECOMMENDED:	APPROVED:
HEAD, DESIGN SECTION	PRINCIPAL ENGINEER	CHIEF, P.C. ENGINEERING DIV.	DISTRICT ENGINEER
DESIGNED:	DRAWN:	TRACED:	CHECKED:
ASSOC. ENGINEER	A.K.	H.A.V.	W.C.E.
FISCAL YEAR 1940			FILE NO. CT-4-2482